

INDEX TO DRAWINGS	
SHEET NO.	DESCRIPTION
1	TITLE SHEET
2	STANDARD PLANS SUMMARY
3	GENERAL NOTES
4	GENERAL NOTES AND LEGEND
5-7	WATER POLLUTION & EROSION CONTROL NOTES
8 - 20	TYPICAL SECTIONS
21 - 22	PAVEMENT DETAILS
23 - 32	GUARDRAIL DETAILS
33 - 57	ROADWAY PLAN
58 - 62	SUPERELEVATION DIAGRAMS
63 - 72	INTERSECTION PLAN
73 - 78	CURB RAMP ELEVATIONS
79 - 81	CURB RAMP DETAILS
82	WATER NOTES AND DETAILS
83	SIGNING AND STRIPING NOTES
84 - 97	SIGNING AND STRIPING PLAN
98 - 106	SIGN SCHEDULE
107 - 114	SIGN DETAILS
115 - 116	TRAFFIC CONTROL NOTES AND DETAILS
117 - 123	EROSION CONTROL PLAN
124	EROSION CONTROL DETAILS
125 - 160	CROSS SECTIONS
161 - 170	GEOTECHNICAL PLANS
171 - 173	STRUCTURAL PLANS
174 - 238	ELECTRICAL PLANS

STATE OF HAWAII

DEPARTMENT OF TRANSPORTATION

HIGHWAYS DIVISION

HONOLULU, HAWAII

PLANS FOR

PALI HIGHWAY RESURFACING




VINEYARD BLVD. TO WAOKANAKA ST.

FEDERAL-AID PROJECT NO. NH-061-1(036)

DISTRICT OF HONOLULU

ISLAND OF OAHU


FED. ROAD DIST. NO.	STATE	FED. AID PROJ. NO.	FISCAL YEAR	SHEET NO.	TOTAL SHEETS
HAWAII	HAW.	NH-061-1(036)	2020	1	238

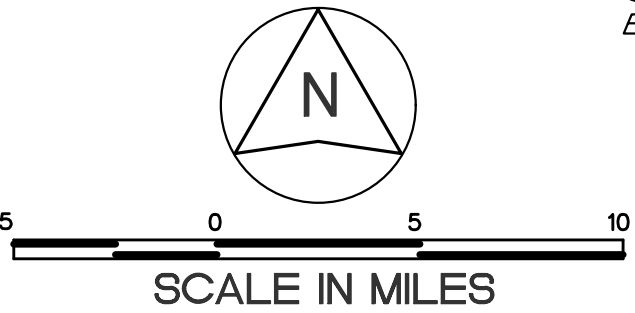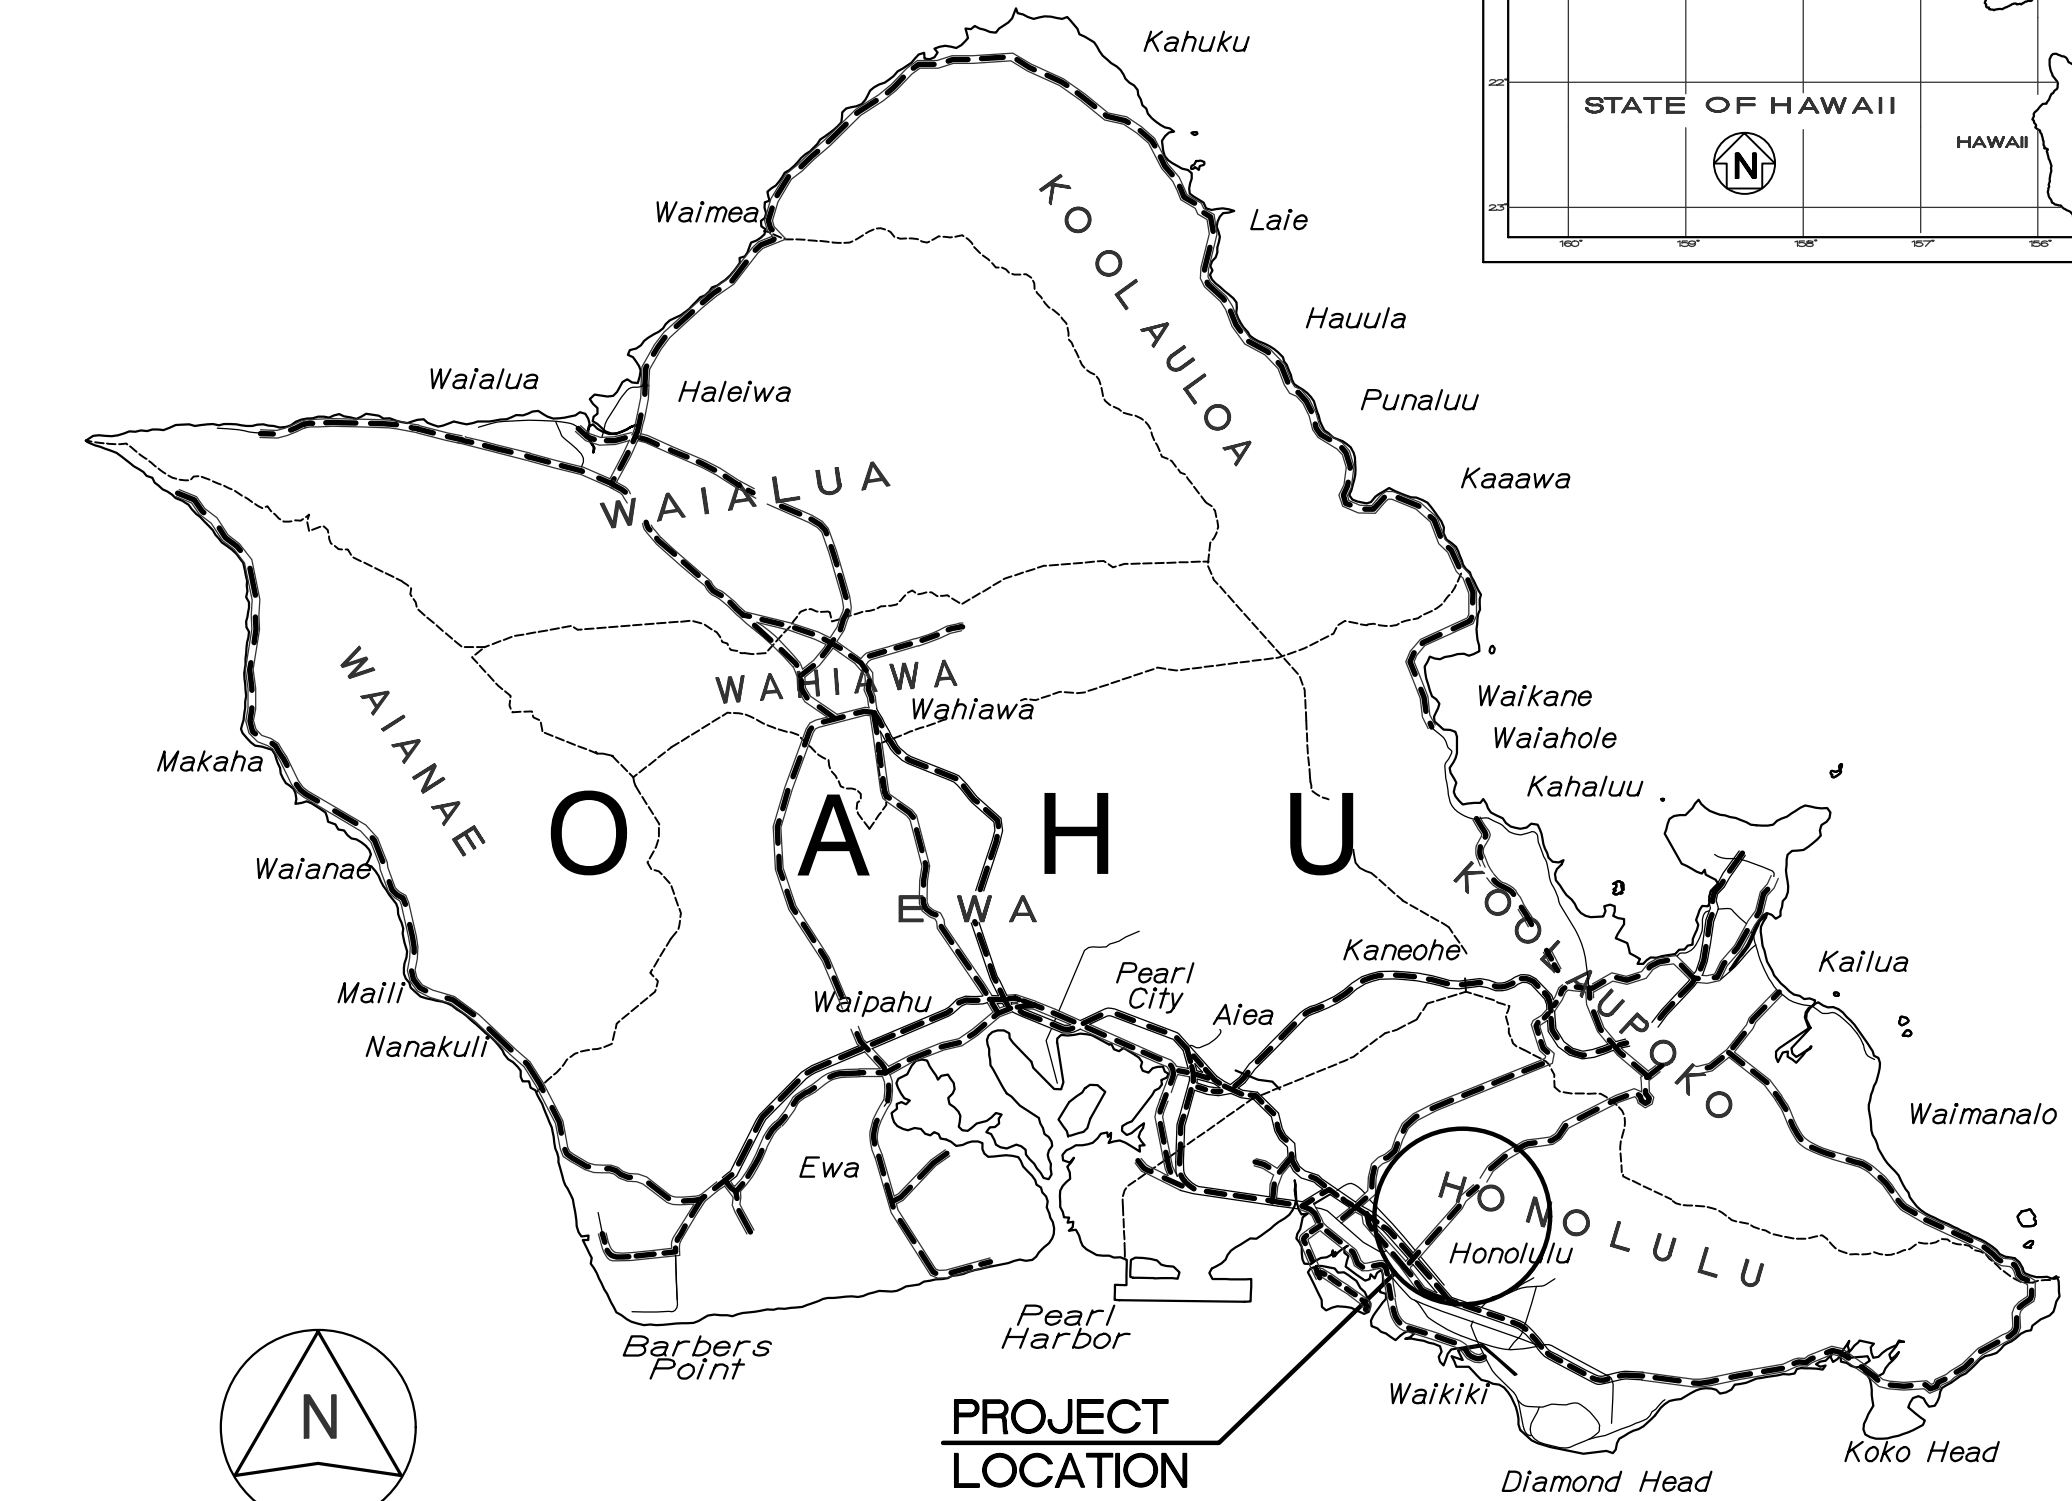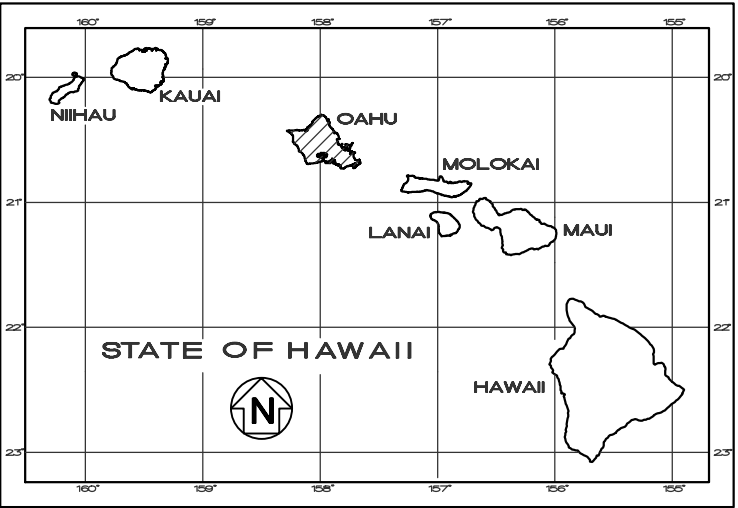



FEDERAL AID PROJECTS PREVIOUSLY CONSTRUCTED OR UNDER CONSTRUCTION

MILE POST -0.03 TO MILE POST 2.64, ROUTE 61

LIMITS OF PROJECT
VINEYARD BOULEVARD TO WAOKANAKA STREET

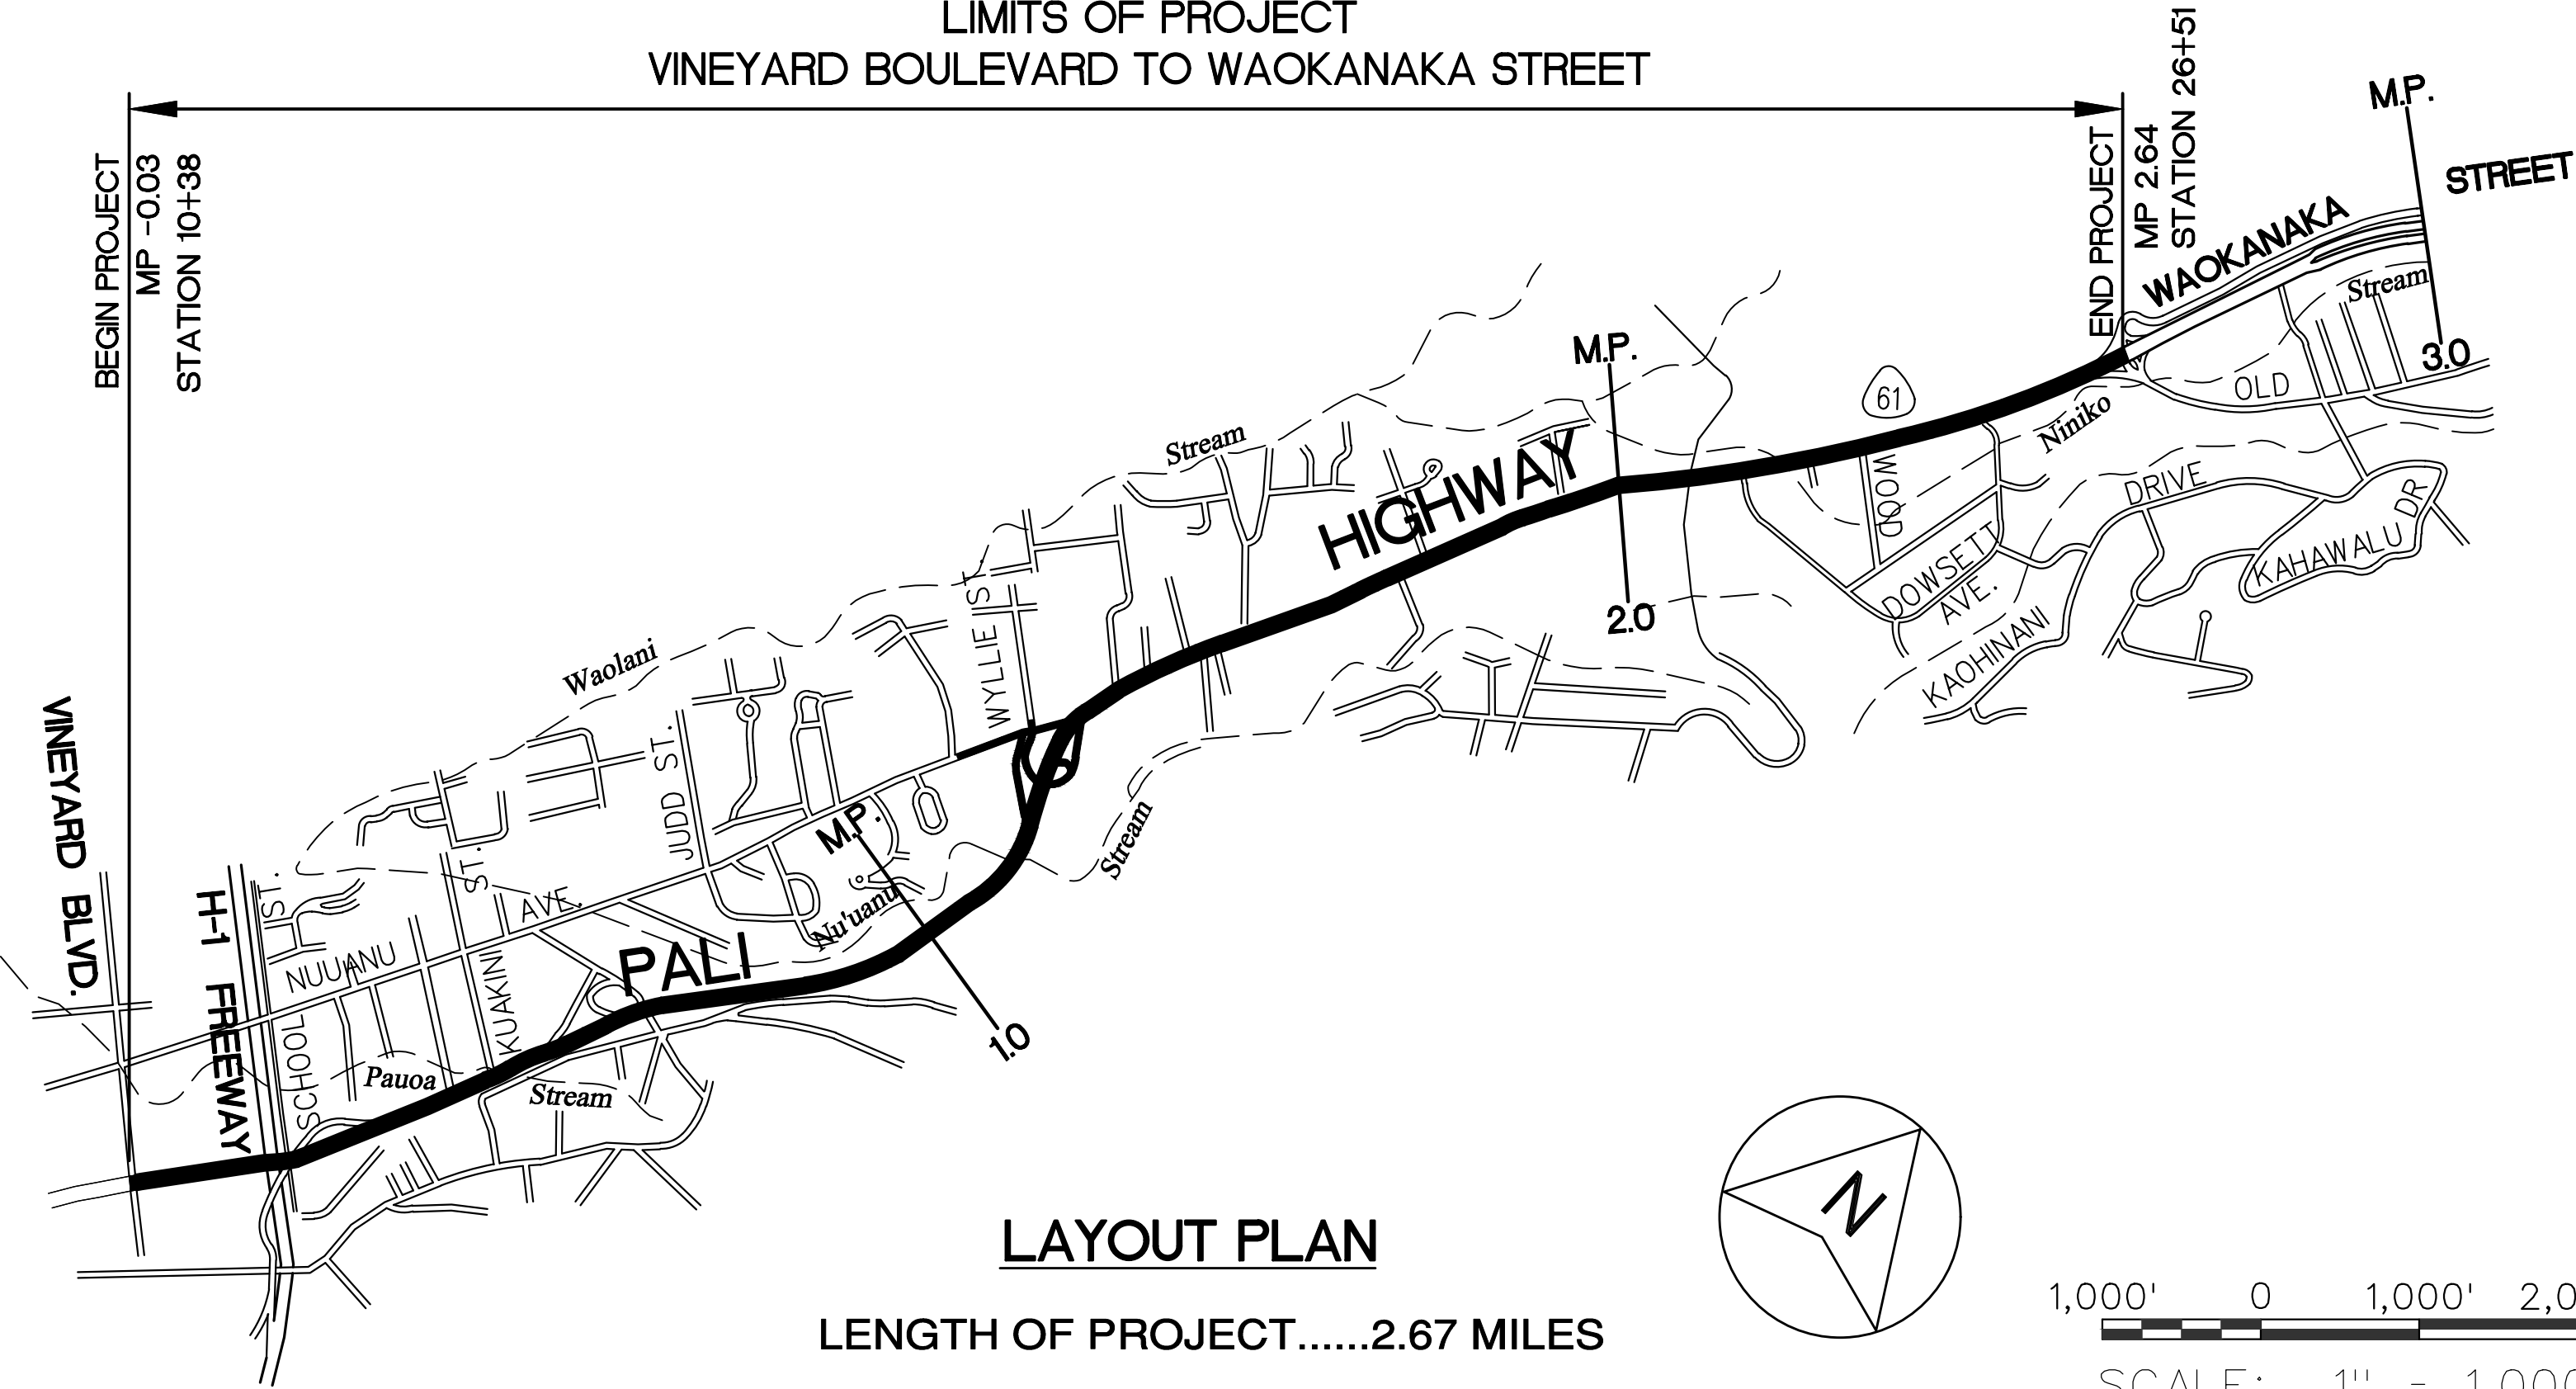

LAYOUT PLAN
LENGTH OF PROJECT.....2.67 MILES

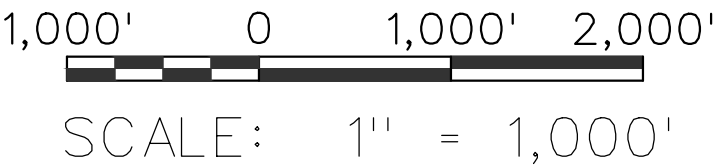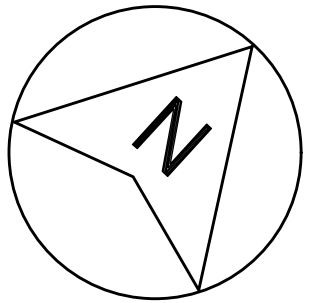

DESIGN DESIGNATION

ADT 2018	62,600
DESIGN ADT 2028	65,800
DHV	5,260
DESIGN D	60/40
T24	4.5
V	45/35 mph

DEPARTMENT OF TRANSPORTATION STATE OF HAWAII	
APPROVED:	Apr 14, 2020
DIR. OF TRANSPORTATION	DATE

DESIGNED BY
WESLEY R. SEGAWA & ASSOC.

MANAGED BY
HWY-DD

PHONE
692-7578

DATE
APRIL 2020