


FED ROAD DIST NO	STATE	FED AID PROJ NO	FISCAL YEAR	SHEET NO	TOTAL SHEETS
-	-	-	2019	-	-

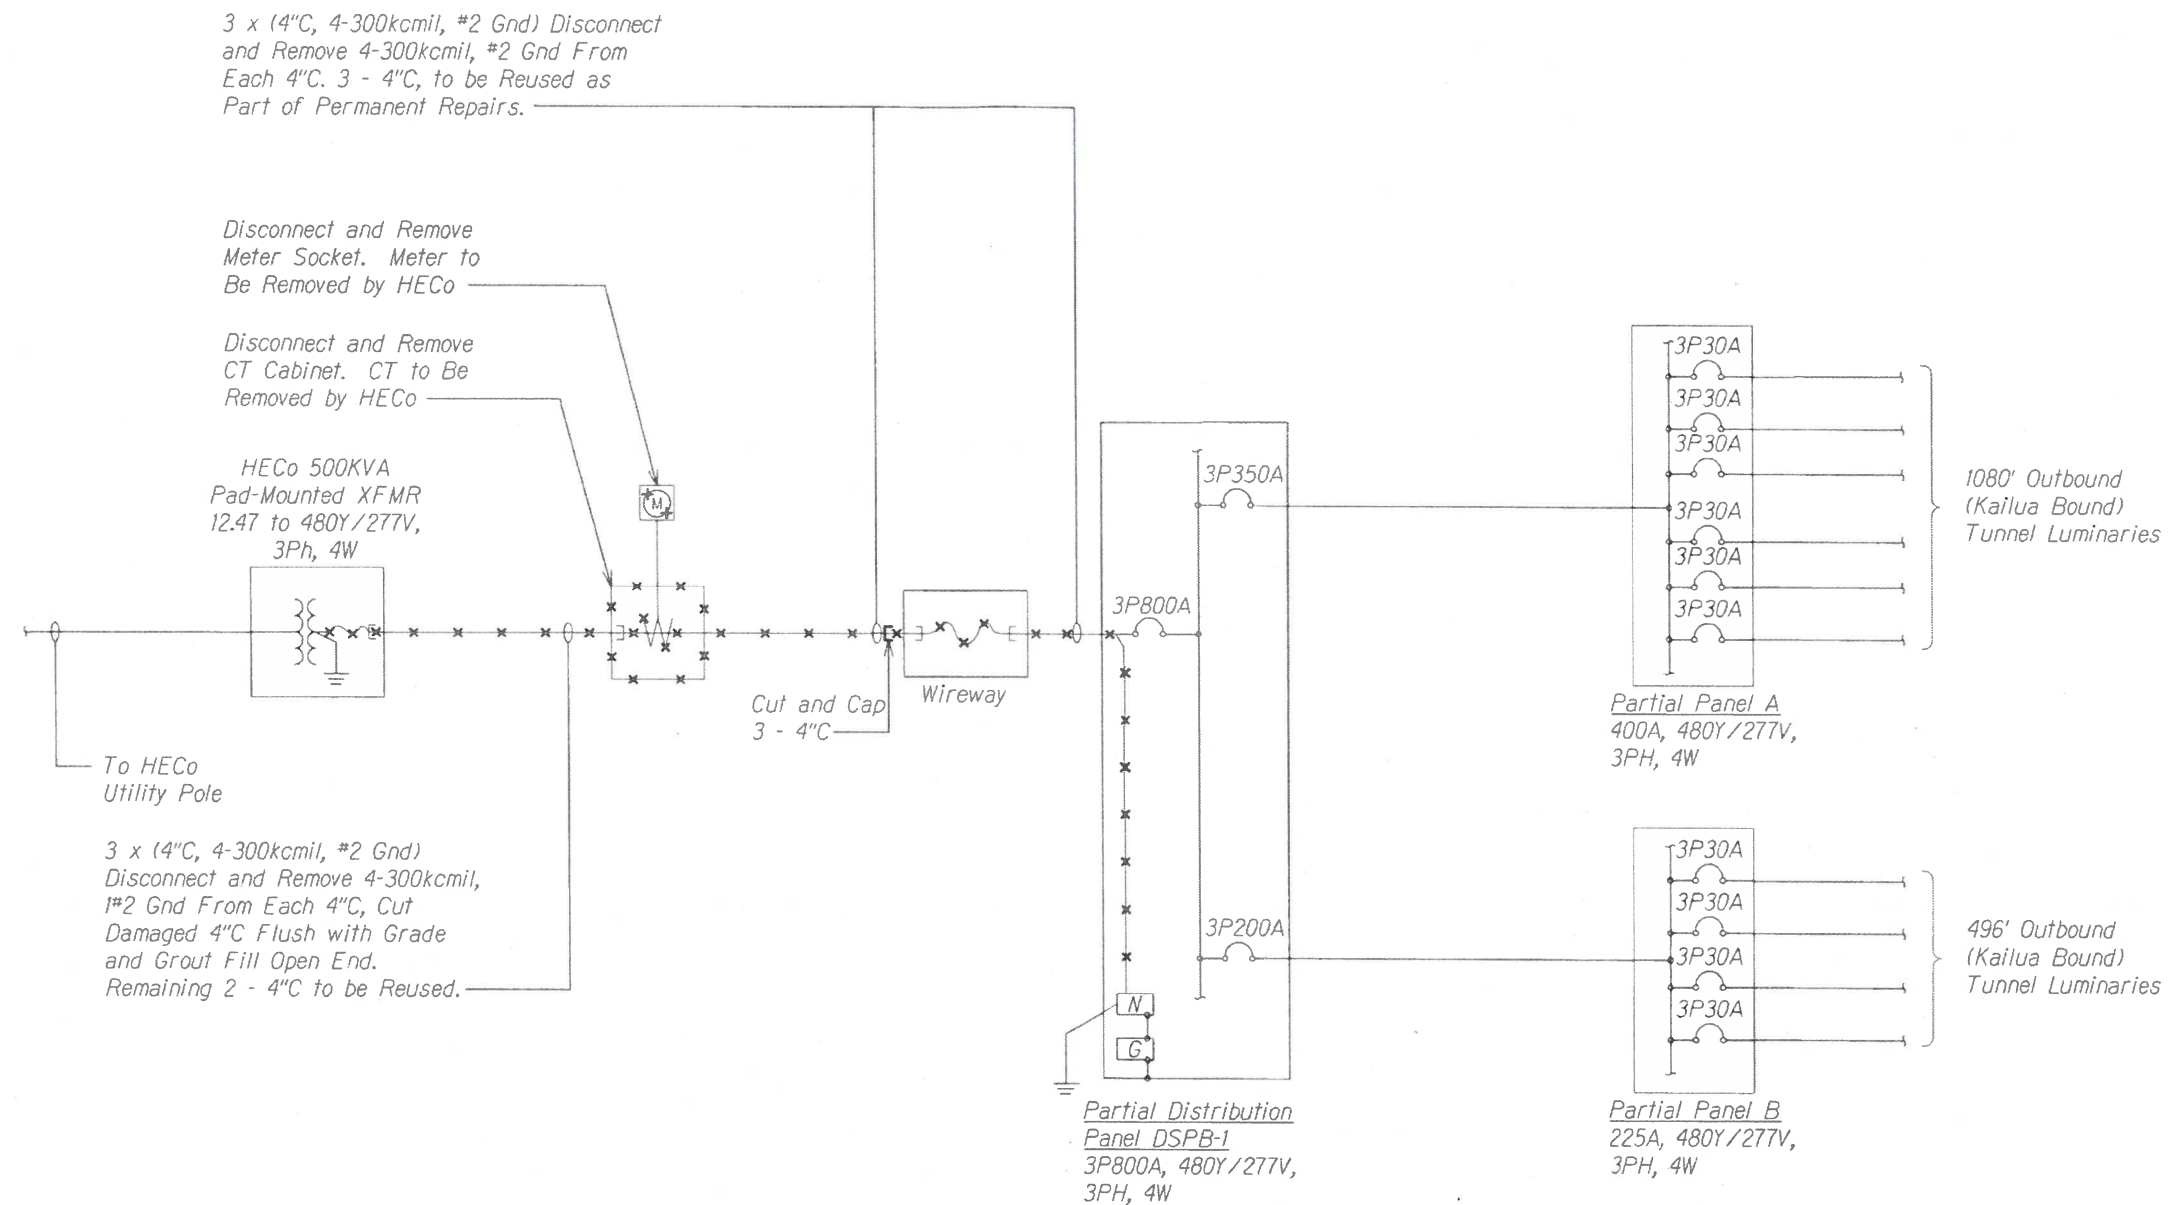

Partial One-line Diagram (Demolition Work)

Not to Scale

NOTES:

1. ——— Light Lines Denote Existing Condition
— X — X — "X" Denotes Removal Work

DESIGNED BY	DATE
DRAWN BY	
CHECKED BY	
NOTED BY	
REVISION	

RUSSELL K. MORI
LICENSED PROFESSIONAL ENGINEER
No. 31212
HAWAII, U.S.A.

STATE OF HAWAII
DEPARTMENT OF TRANSPORTATION
HIGHWAYS DIVISION

PARTIAL ONE LINE DIAGRAM

PALI HIGHWAY EMERGENCY REPAIRS


FAP NO. NH-HI-11(274)

Scale: As Noted Date: March 31, 2019

SHEET No. E4 OF SHEETS

"AS-BUILT"

FED ROAD DIST NO	STATE	FED AID PROJ NO	FISCAL YEAR	SHEET NO	TOTAL SHEETS
-	-	-	2019	-	-

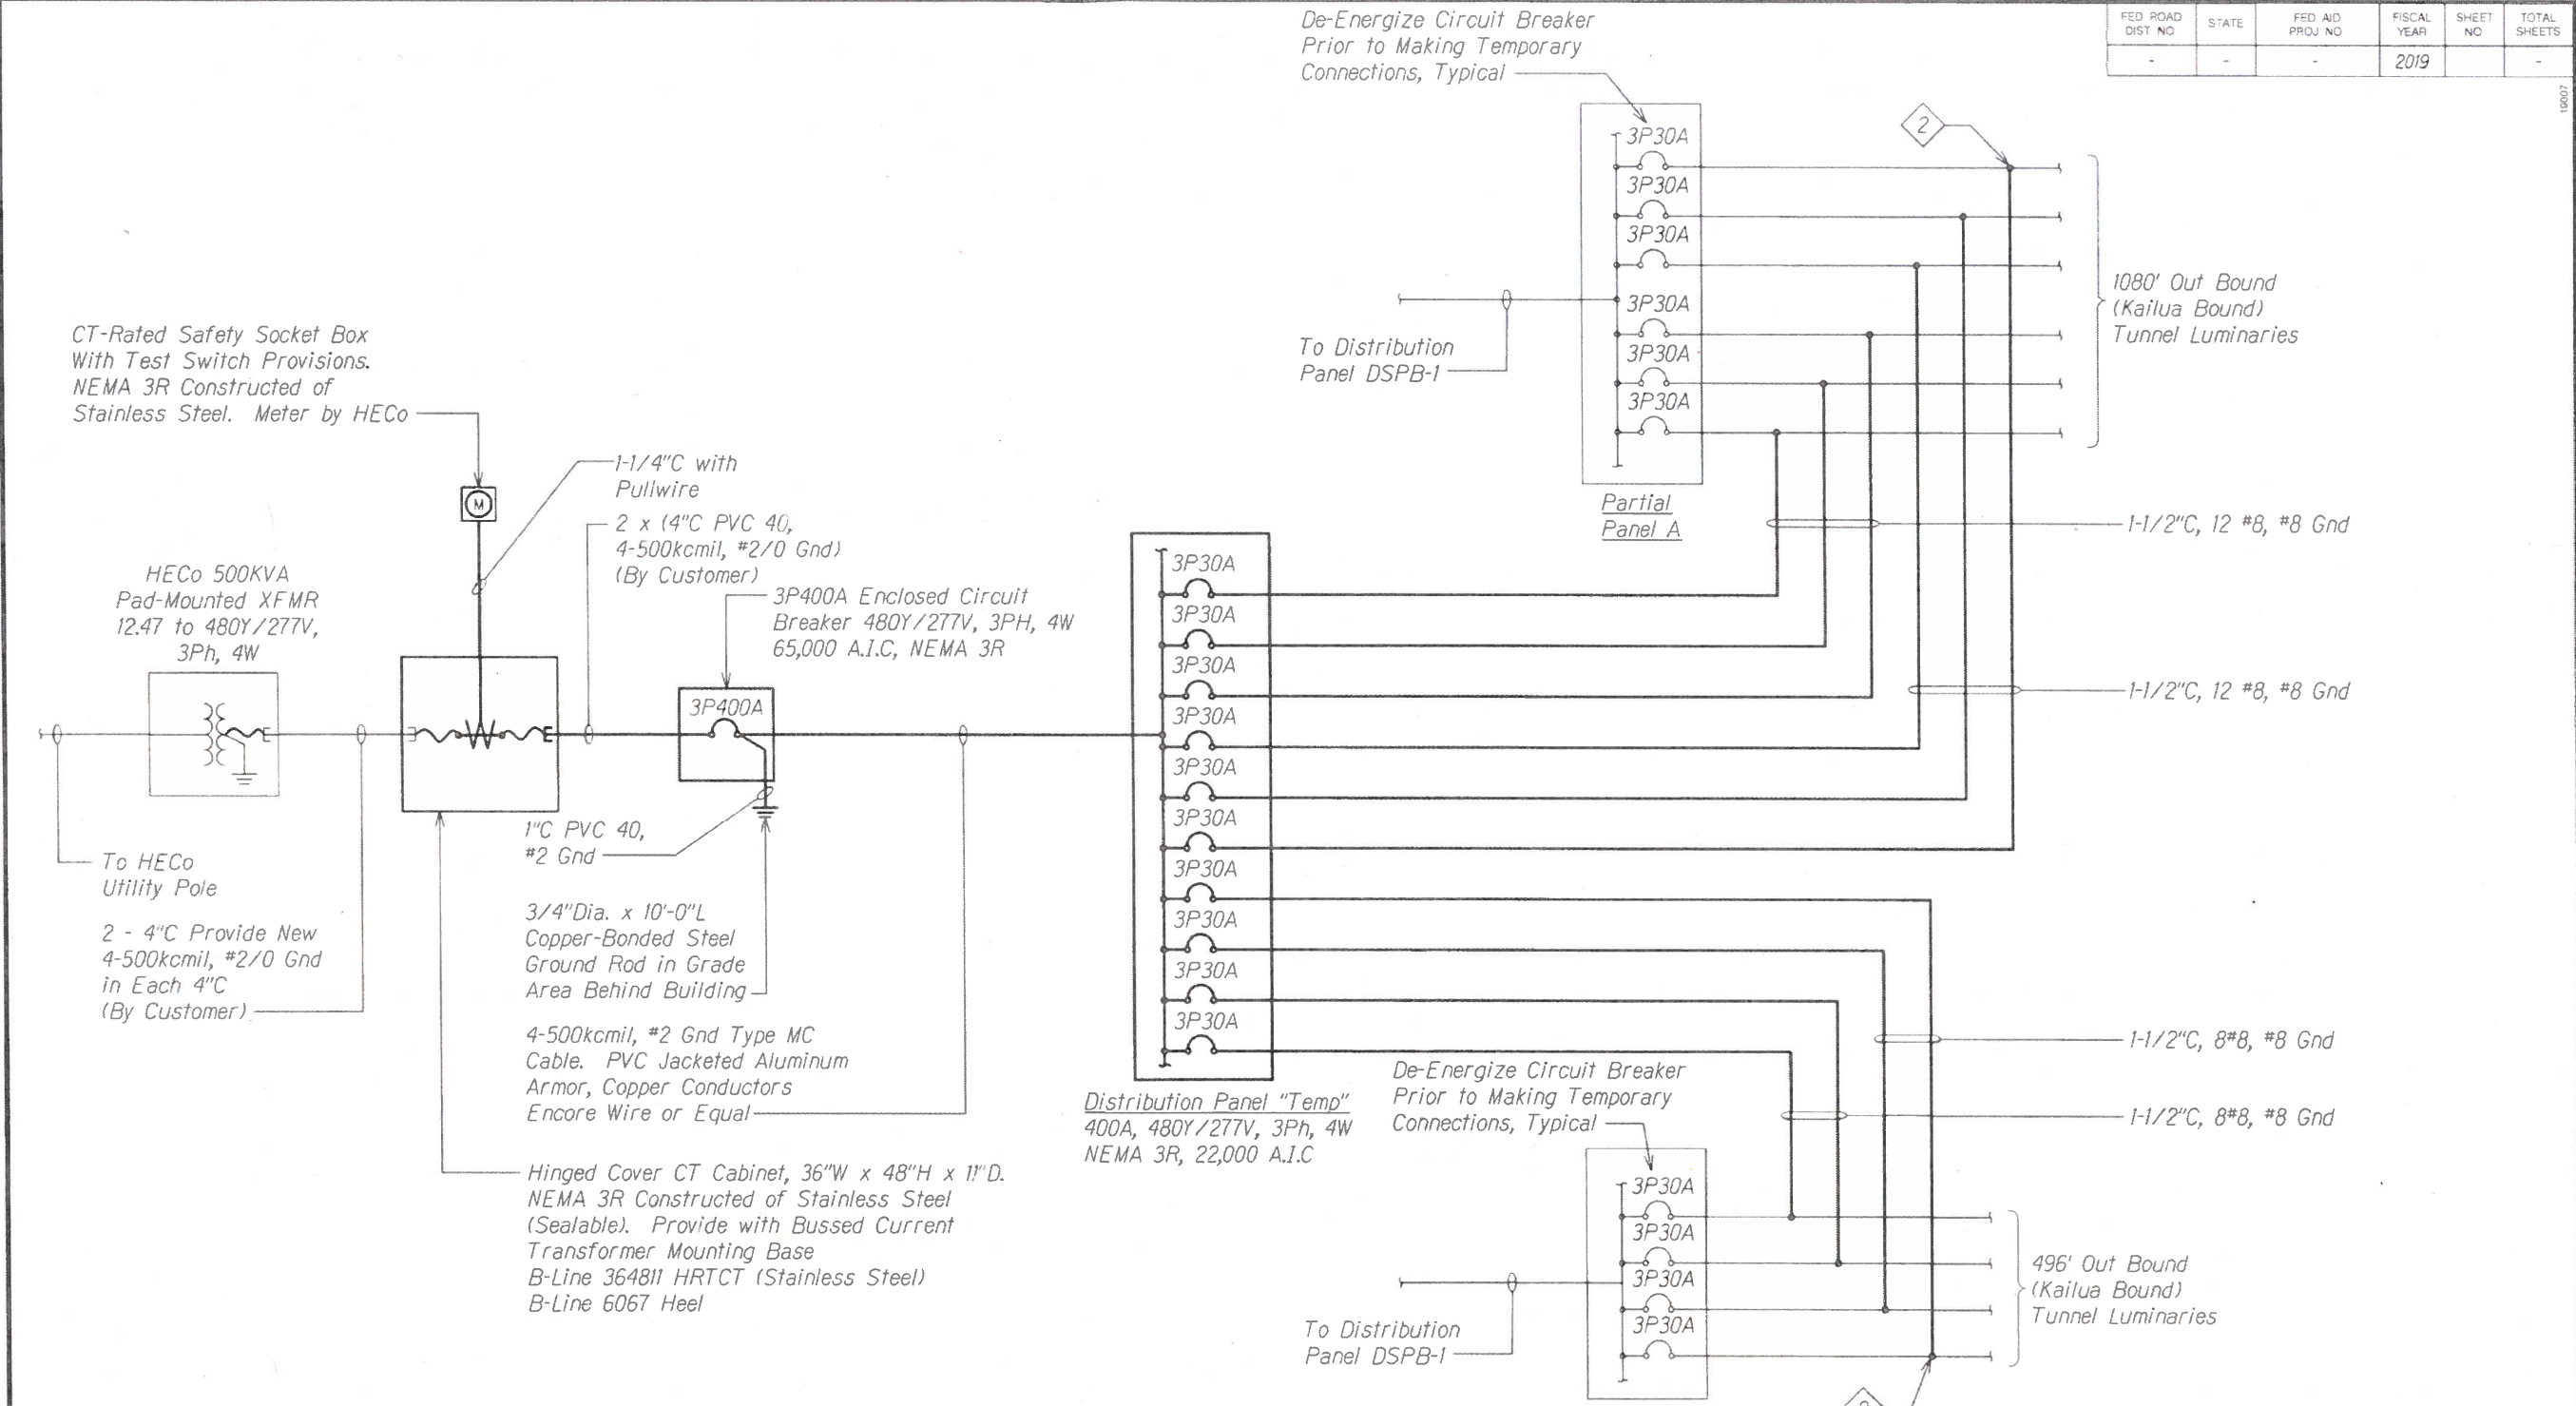

Partial One-line Diagram (Temporary Power)

Not to Scale

NOTES:

- Light Lines Denote Existing Condition
- Bold Lines Denote New Work
- Make Temporary Connection at Existing Pullbox at Outbound Entrance of Tunnel.

DATE	_____
SURVEY PLANNED BY	_____
DRAWN BY	_____
REVIEWED BY	_____
NOTED BY	_____
CHECKED BY	_____
ORIGINAL PLAN	_____
NOTE BOOK	_____
No.	_____

STATE OF HAWAII
DEPARTMENT OF TRANSPORTATION
HIGHWAYS DIVISION

PARTIAL ONE LINE DIAGRAM

PALI HIGHWAY EMERGENCY REPAIRS

FAP NO. NH-HI-1(274)

Scale: As Noted Date: March 31, 2019

SHEET No. E5 OF SHEETS

"AS-BUILT"