




INDEX OF DRAWINGS	
SHEET NO.	DESCRIPTION
1	TITLE SHEET
2	STANDARD PLAN SUMMARY
3-4	ROADWAY PLANS
5	ROCK SHED ROOFTOP GRADING
6-8	ROCK SHED DRAINAGE PLANS
9	SIGNING & STRIPING PLAN
10	EROSION CONTROL PLAN
11-19	CROSS SECTIONS
20-23	BORING LOGS
24-28	STRUCTURAL INDEX, GENERAL NOTES, SYMBOLS AND ABBREVIATIONS
29-34	STRUCTURAL LAYOUT PLAN, LONGITUDINAL SECTION, ELEVATION, FOUNDATION PLAN, ROOF FRAMING PLAN AND TOPPING PLAN
35-37	STRUCTURAL DEMOLITION PLANS
38-40	STRUCTURAL TYPICAL SECTIONS
41-45	DRILLED SHAFT DETAILS
46-48	COLUMN DETAILS
49-52	COLUMN CAP BEAM ELEVATION AND SECTIONS
53-63	RETAINING WALL ELEVATION, SECTIONS AND POST-TENSIONING ANCHOR DETAILS
64-65	ROOF SECTIONS
66	CONTAINMENT WALL AND 5'-6" HIGH WALL
67-69	PLANK SECTIONS AND DETAILS
70-74	UPTURN CURB ELEVATIONS AND SECTIONS
75-77	ROCK ANCHOR SECTIONS
78-80	MAKAI END POST PLAN AND ELEVATION, REINFORCEMENT LAYOUT PLANS AND SECTIONS
81-94	ELECTRICAL PLANS

STATE OF HAWAII
DEPARTMENT OF TRANSPORTATION
HIGHWAYS DIVISION
HONOLULU, HAWAII

PLANS FOR
PALI HIGHWAY
LANDSLIDE MITIGATION PROJECT
FEDERAL-AID PROJECT NO. ER-22(002)

DISTRICT OF HONOLULU & KOOLAUPOKO
ISLAND OF OAHU


FED. ROAD DIST. NO.	STATE	FEDERAL AID PROJ. NO.	FISCAL YEAR	SHEET NO.	TOTAL SHEETS
HAWAII	HAW.	ER-22(002)	2019	1	94

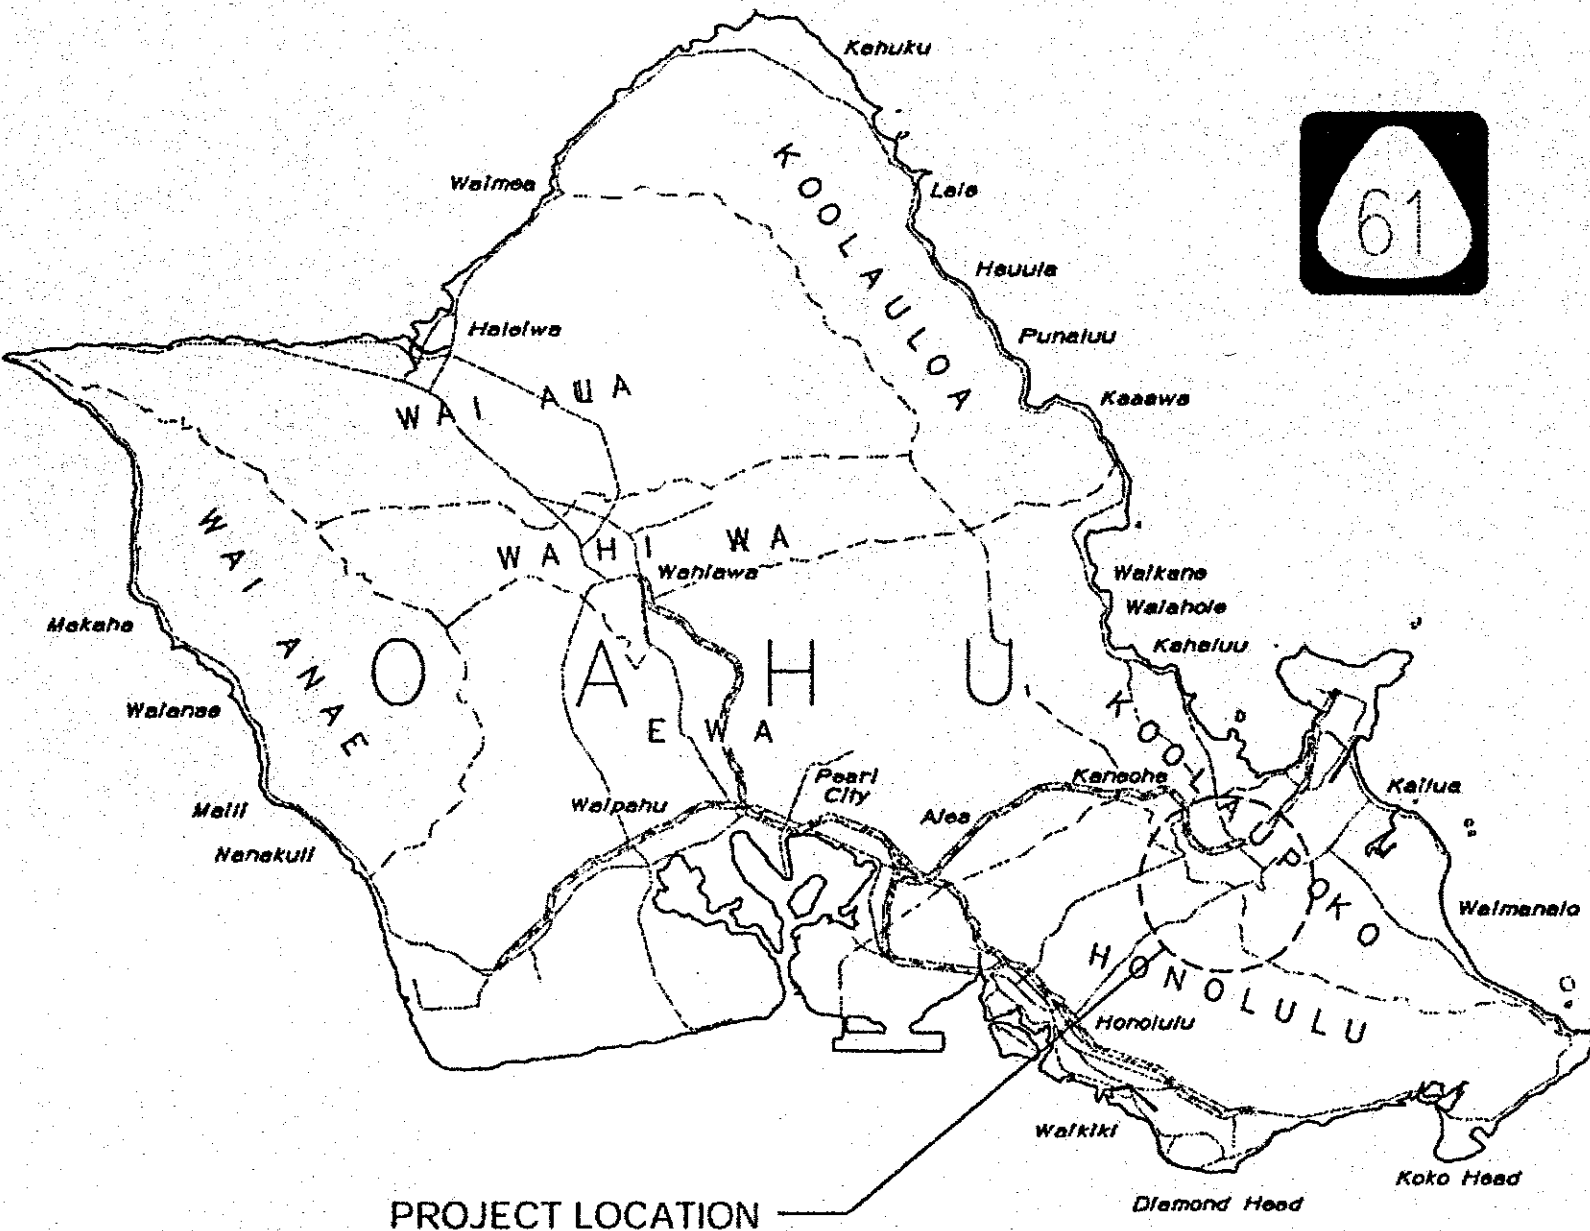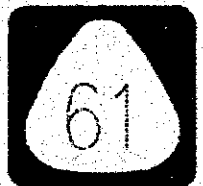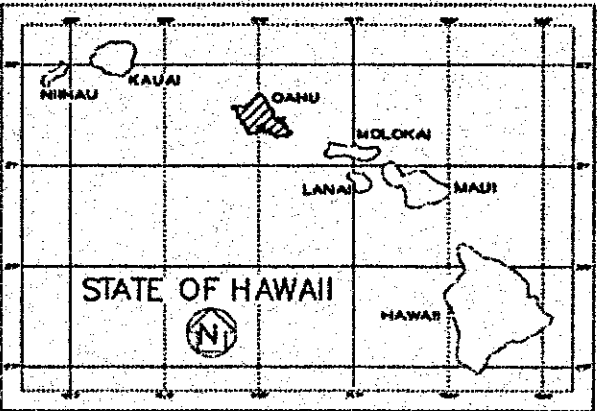

SCALE IN MILES
0 1 2 3 4 5

FEDERAL AID INTERSTATE PROJECTS PREVIOUSLY
CONSTRUCTED OR UNDER CONSTRUCTION

MILE POST 5.80 TO MILE POST 5.95

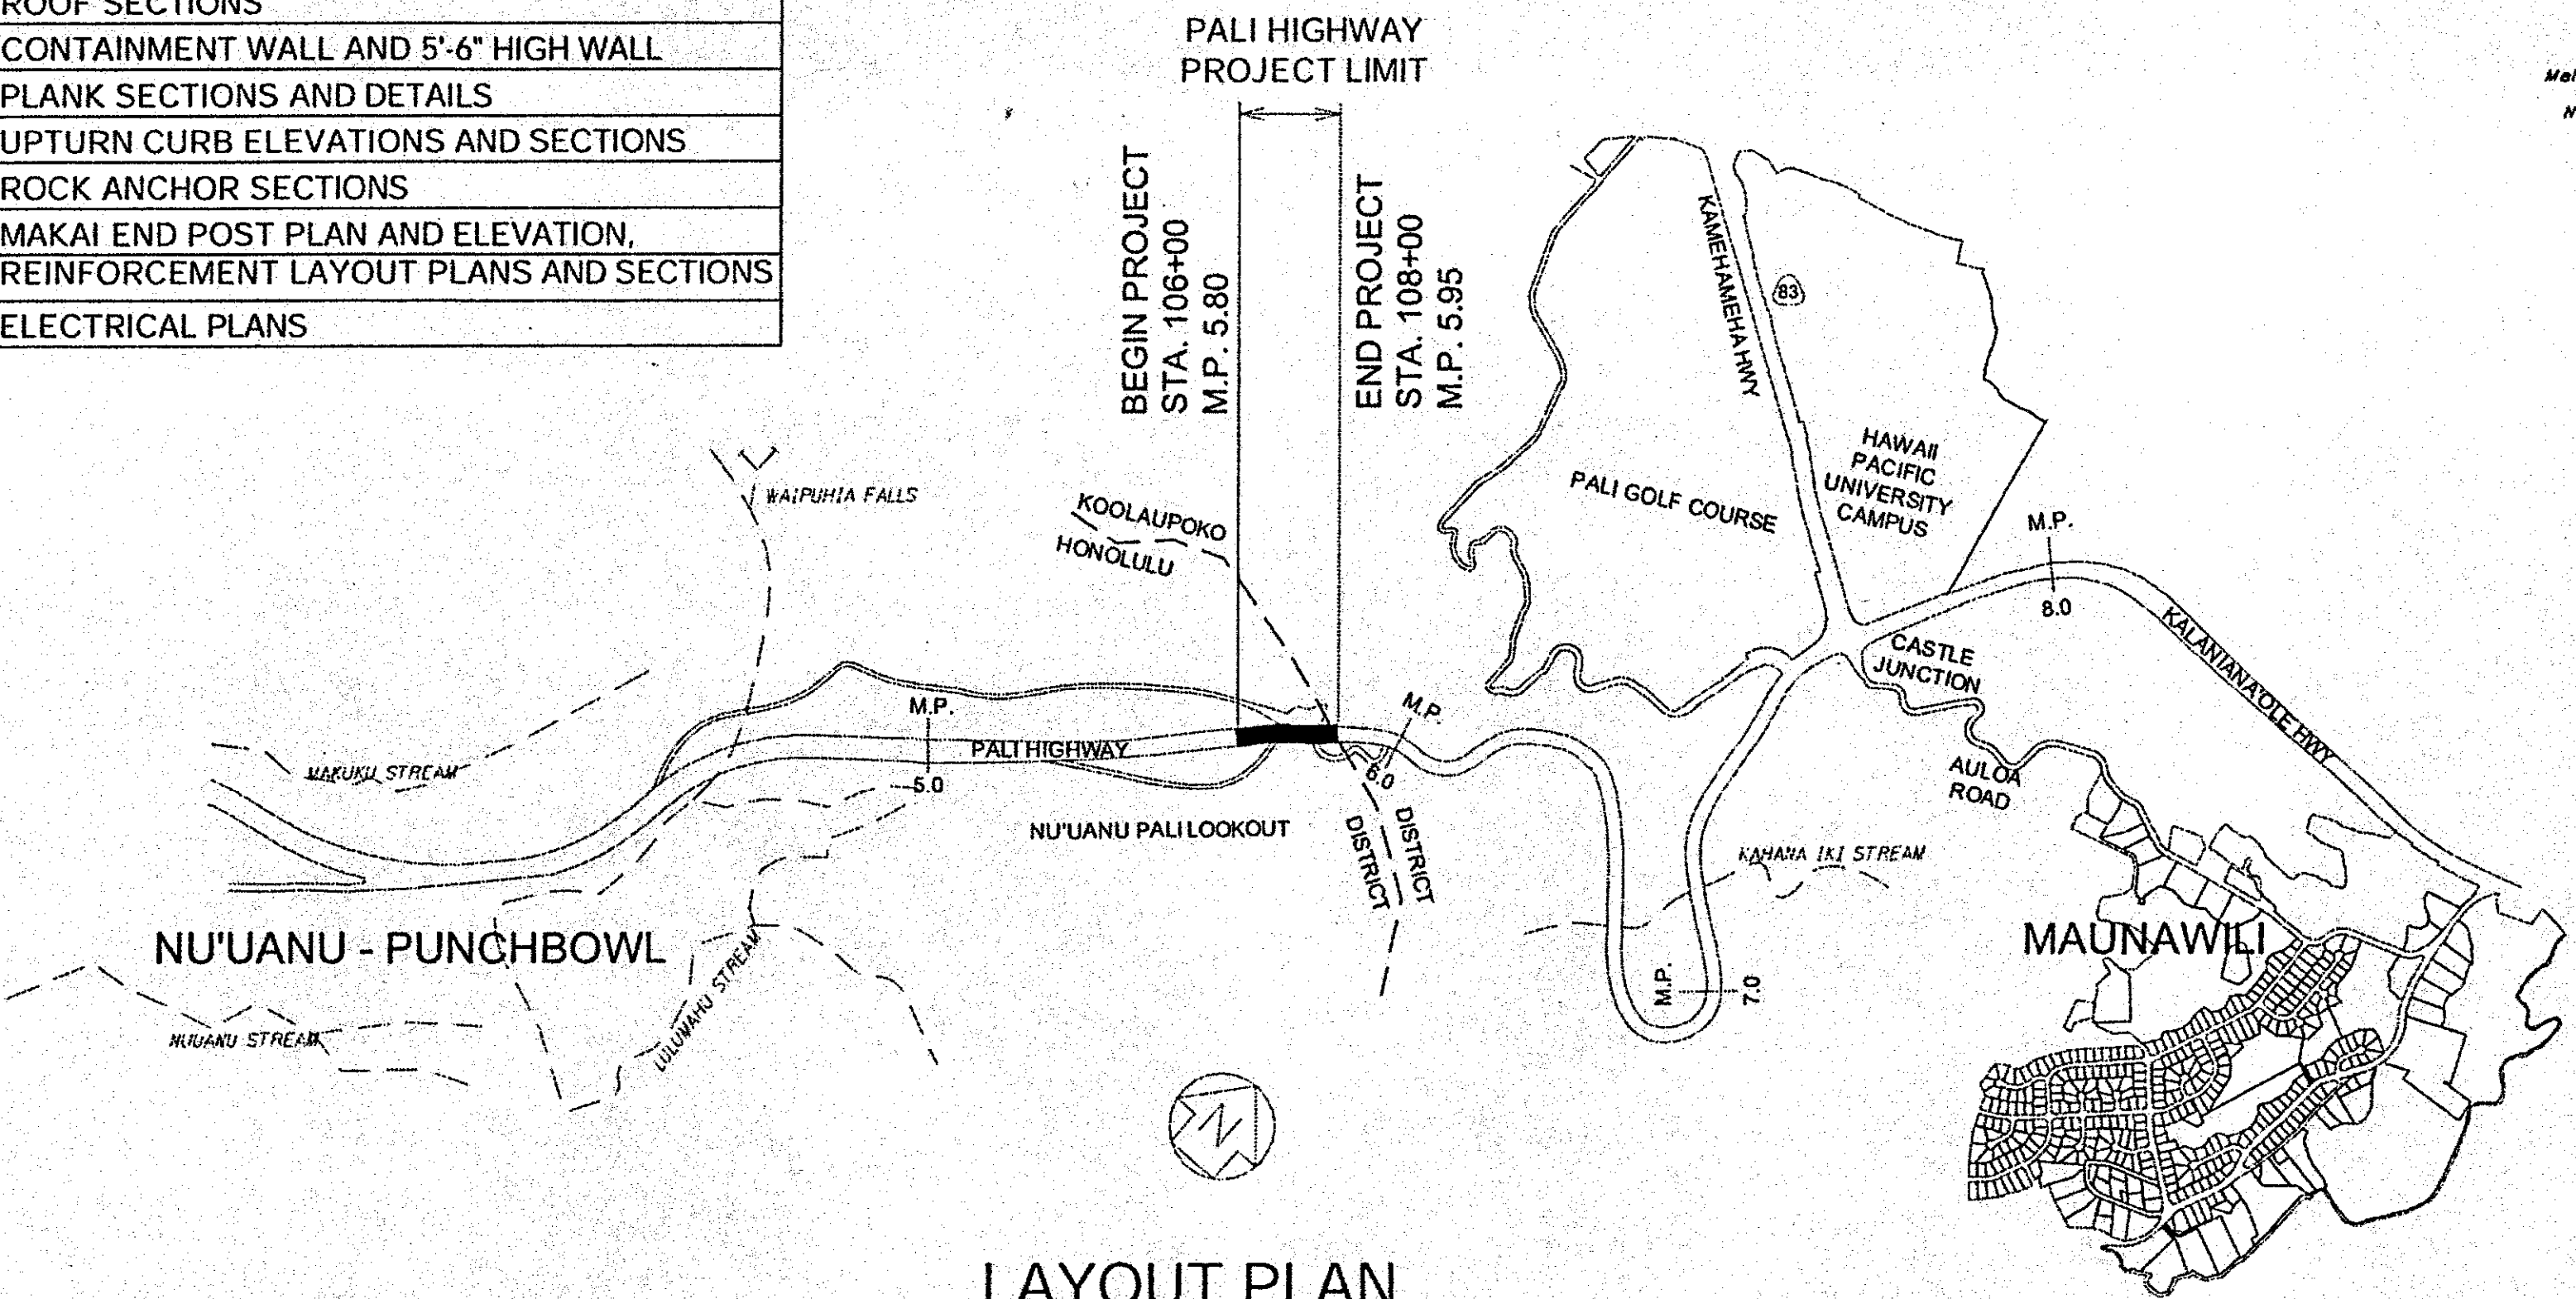

LAYOUT PLAN
NOT TO SCALE

DESIGNED BY	DATE
MANAGED BY	PHONE
WSP USA	
DESIGNED BY	DATE
MANAGED BY	PHONE
WSP USA	

DEPARTMENT OF TRANSPORTATION STATE OF HAWAII
APPROVED:
DIR. OF TRANSPORTATION DATE