
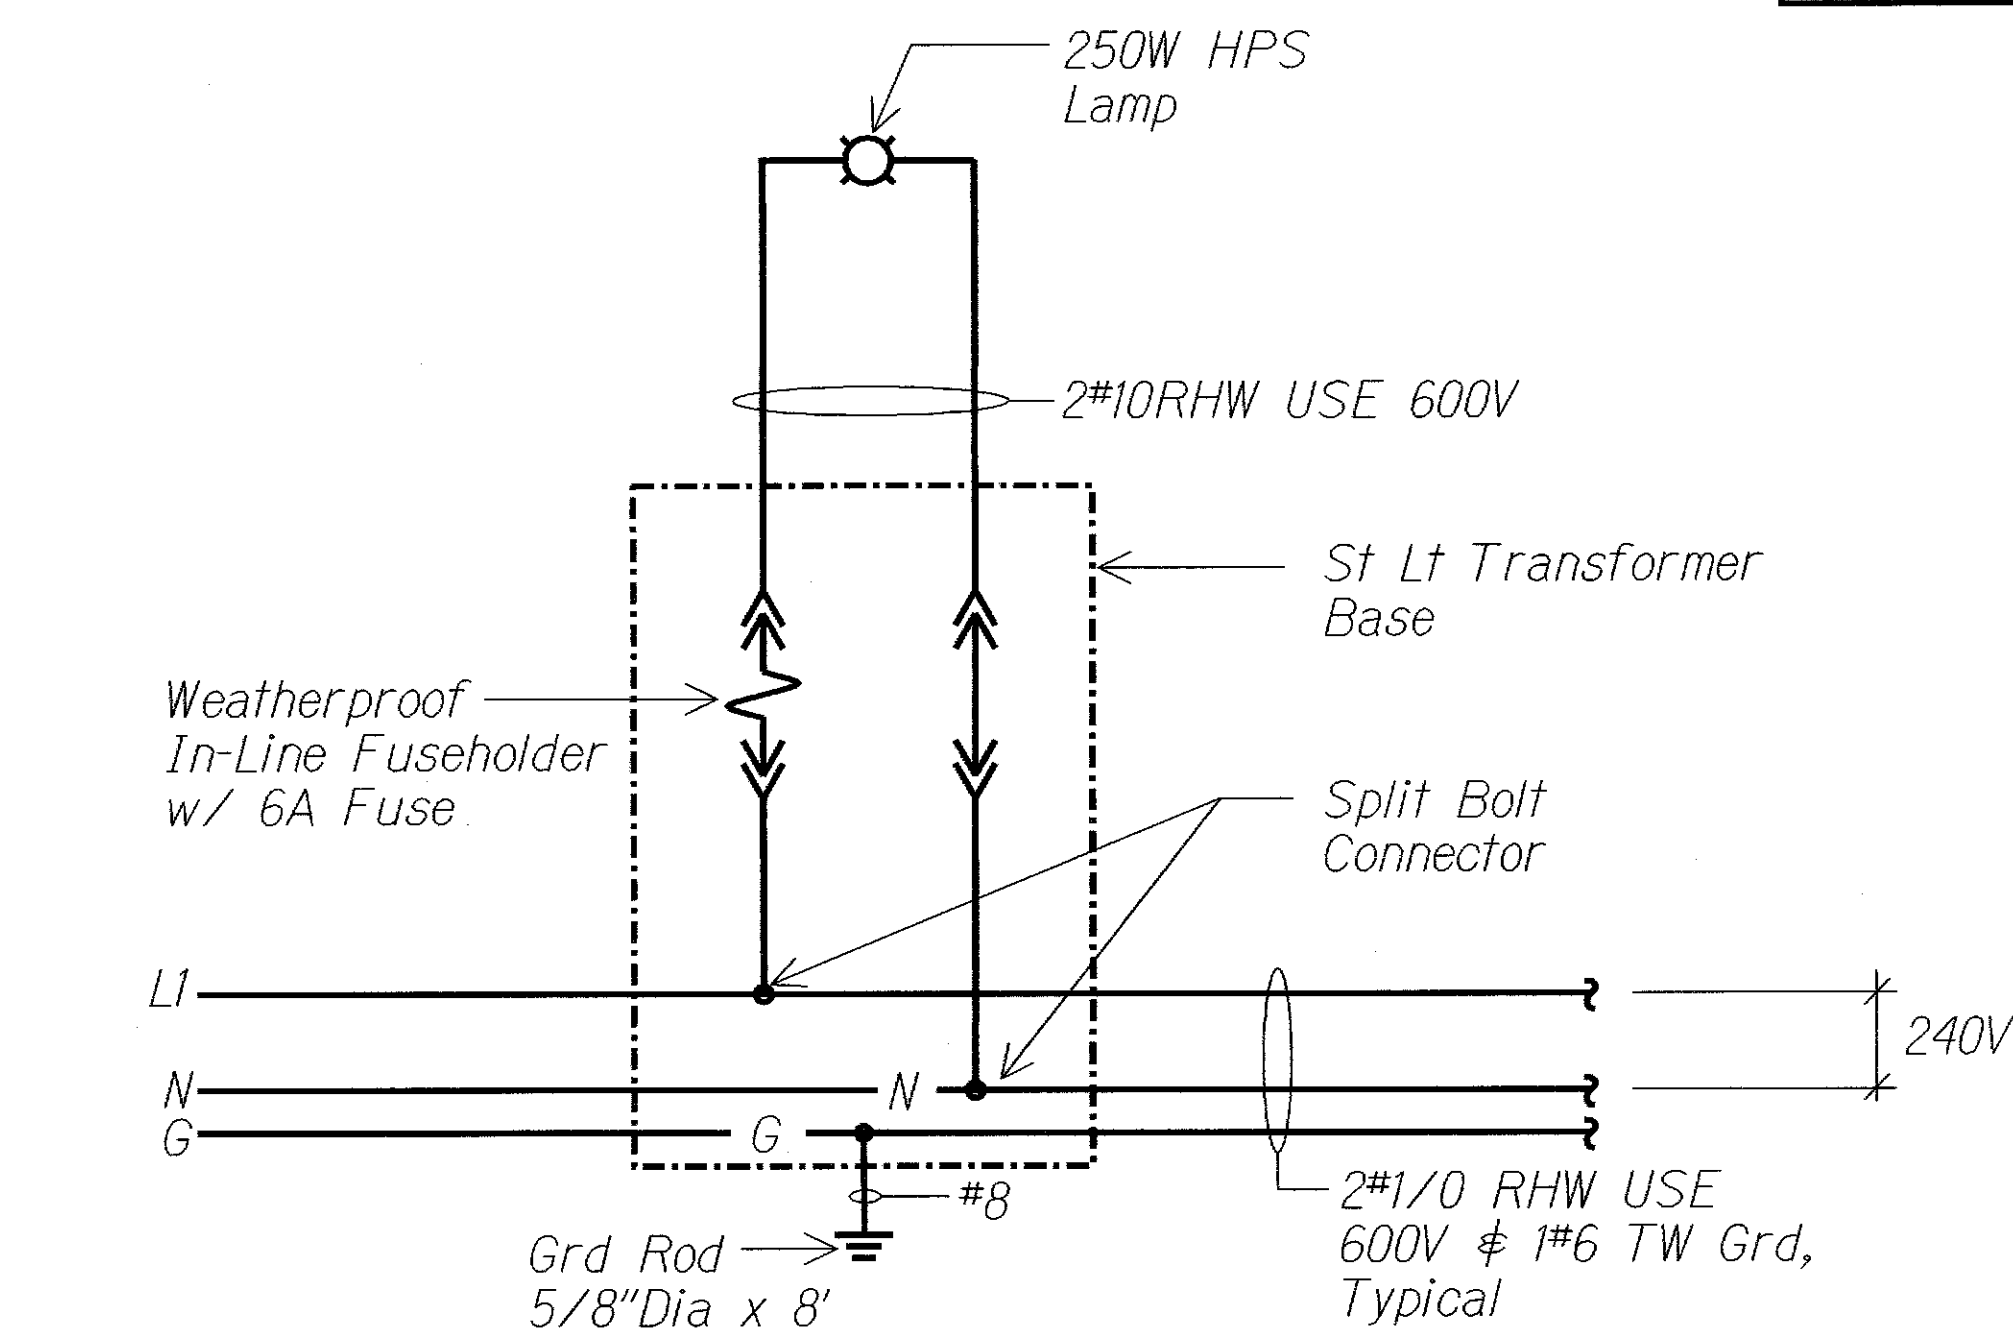


FED. ROAD DIST. NO.	STATE	PROJ. NO.	FISCAL YEAR	SHEET NO.	TOTAL SHEETS
HAWAII	HAW.	61C-01-04M	2004	43	91

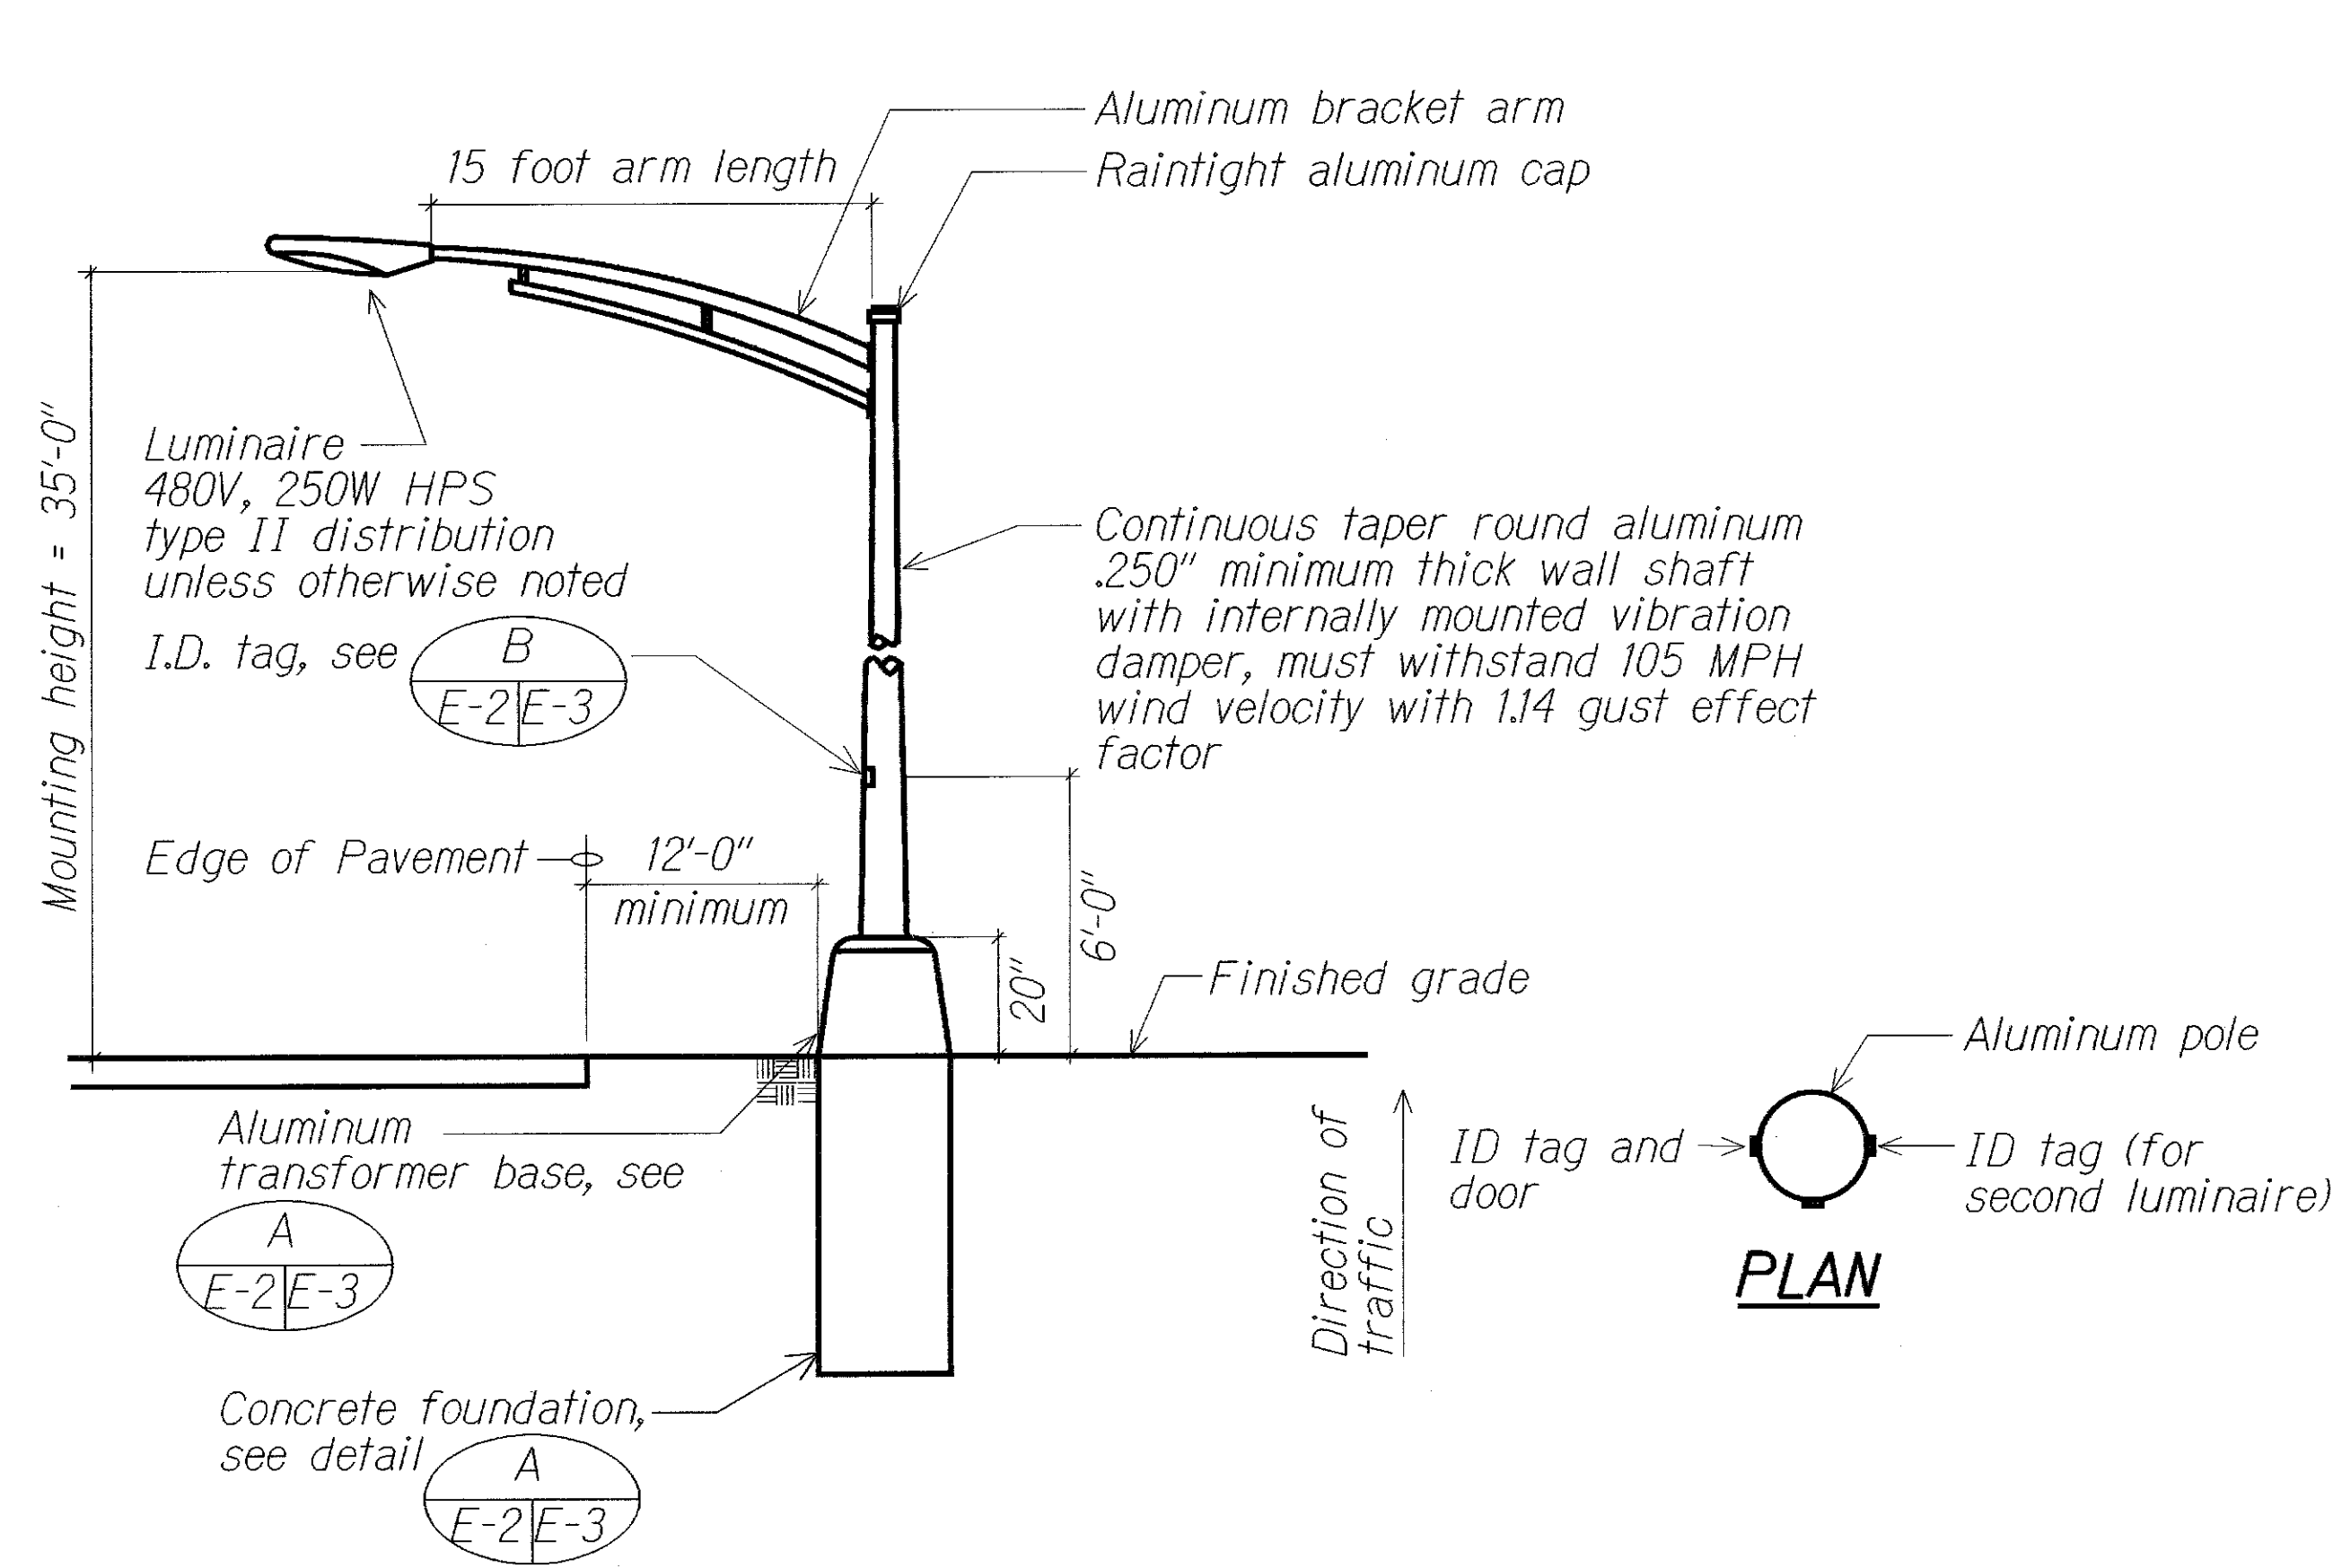


TYPICAL STREET LIGHT WIRING DIAGRAM

A TYPICAL LIGHT STANDARD INSTALLATION ON GRADE
E-1 E-2 Not to scale

Notes:

1. Aluminum pole must conform to the "2001 AASHTO Standard Specifications for structural supports for highway signs, luminaires and traffic signals.

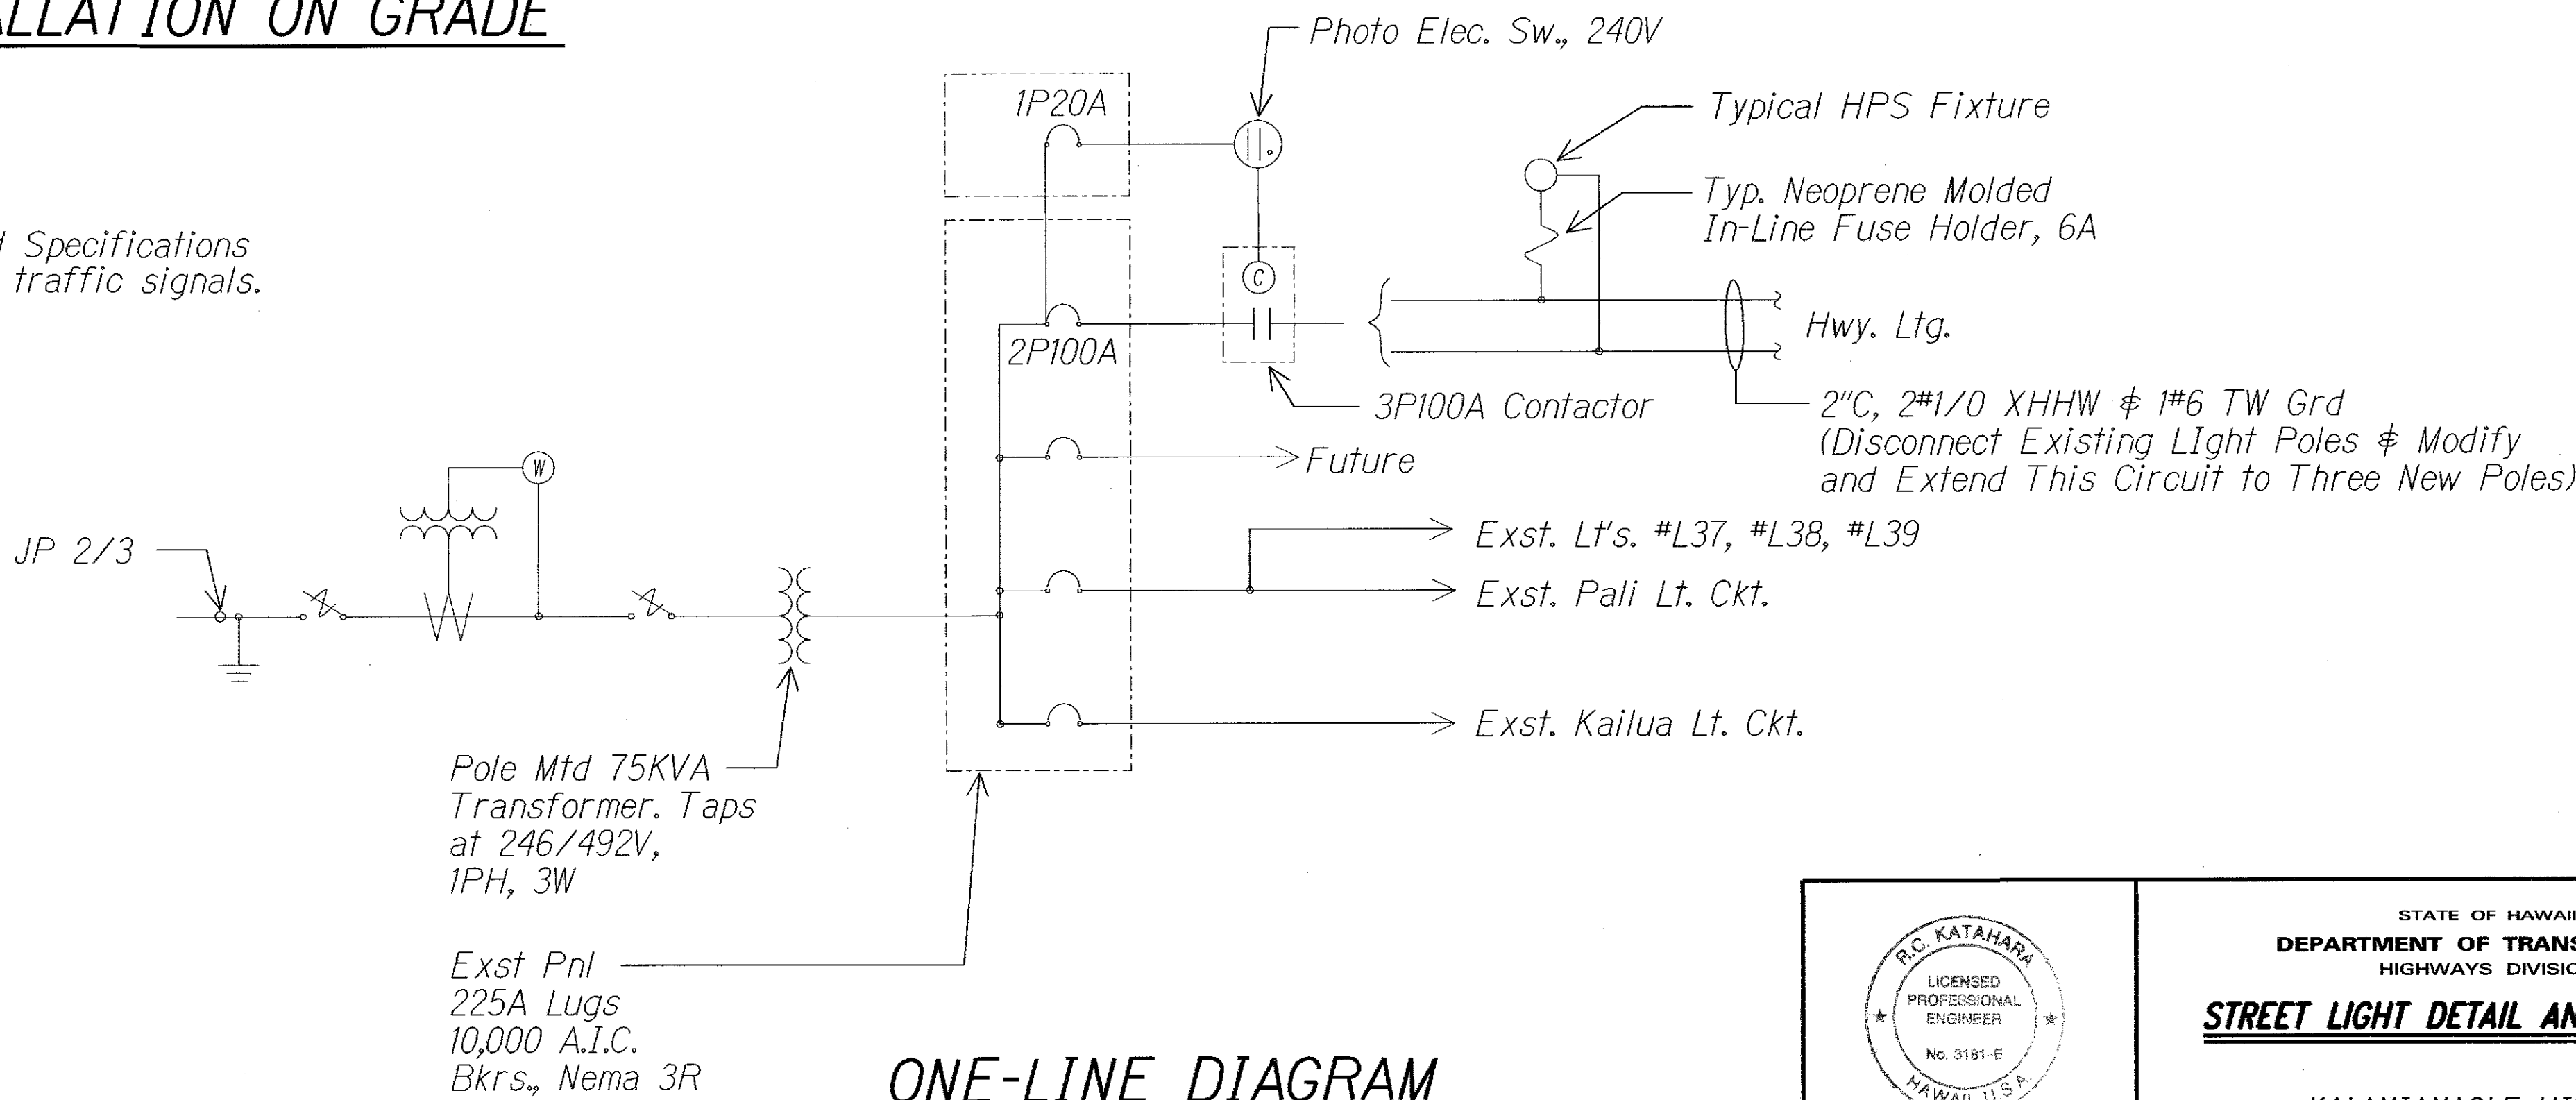

ONE-LINE DIAGRAM
Existing shown for information

STATE OF HAWAII
DEPARTMENT OF TRANSPORTATION
HIGHWAYS DIVISION

STREET LIGHT DETAIL AND DIAGRAMS

KALANIANA'OLE HIGHWAY
EMERGENCY LANDSLIDE REPAIRS AT CASTLE JUNCTION
PROJECT NO. 61C-01-04M

Scale: 1" = 10'-0"

DATE: 9/26/03

DATE: 9/26/03

DATE: 9/26/03

DATE: 9/26/03

DATE: 9/26/03

DATE: 9/26/03

ORIGINAL PLAN	DATE: 9/26/03
NOTES BOOK	DATE: 9/26/03
CHECKED BY	DATE: 9/26/03
DATE: 9/26/03	