
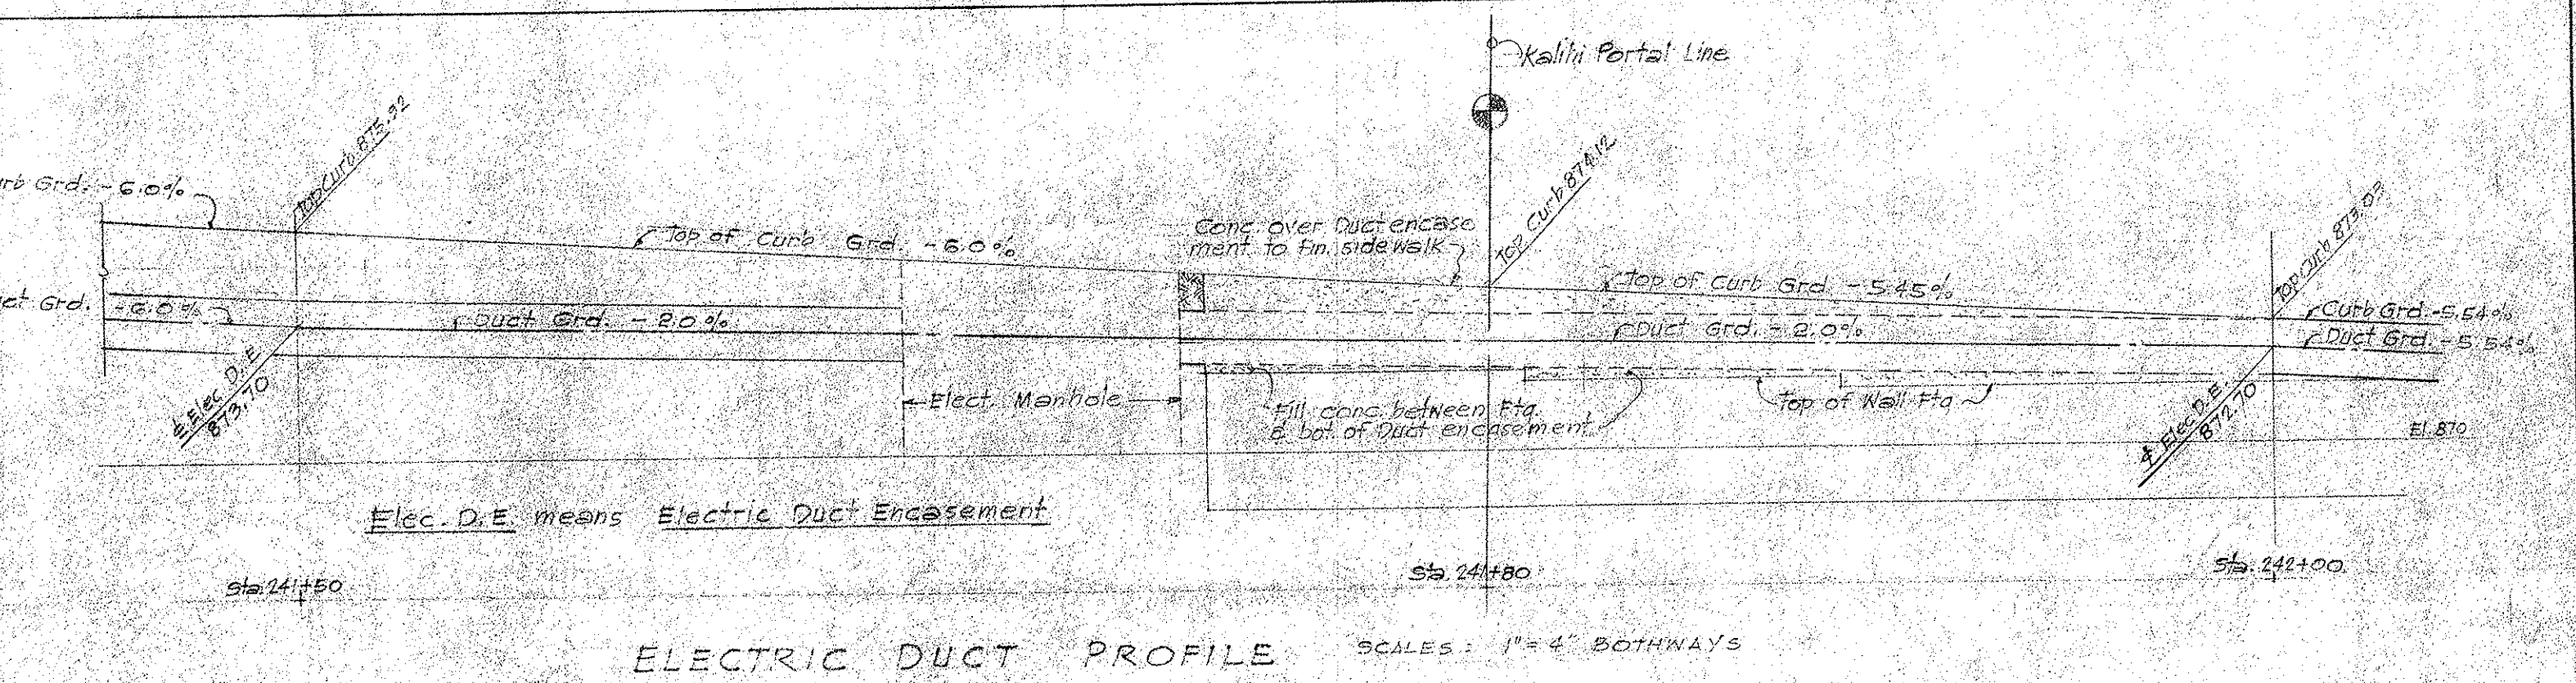
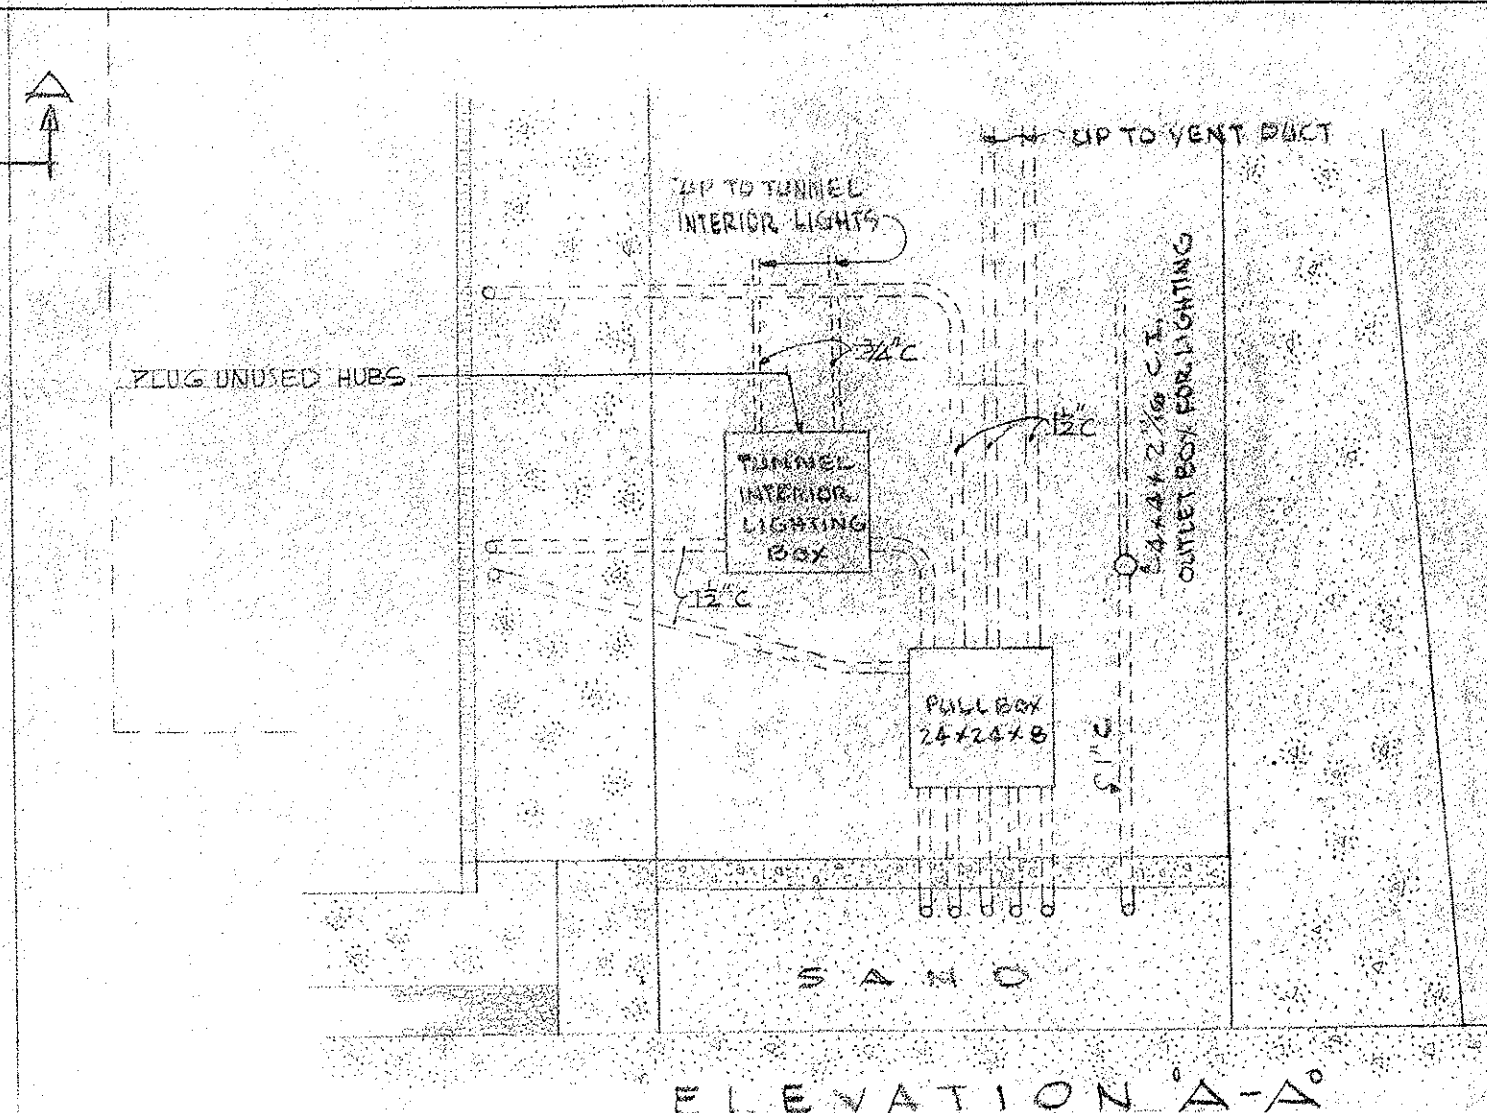


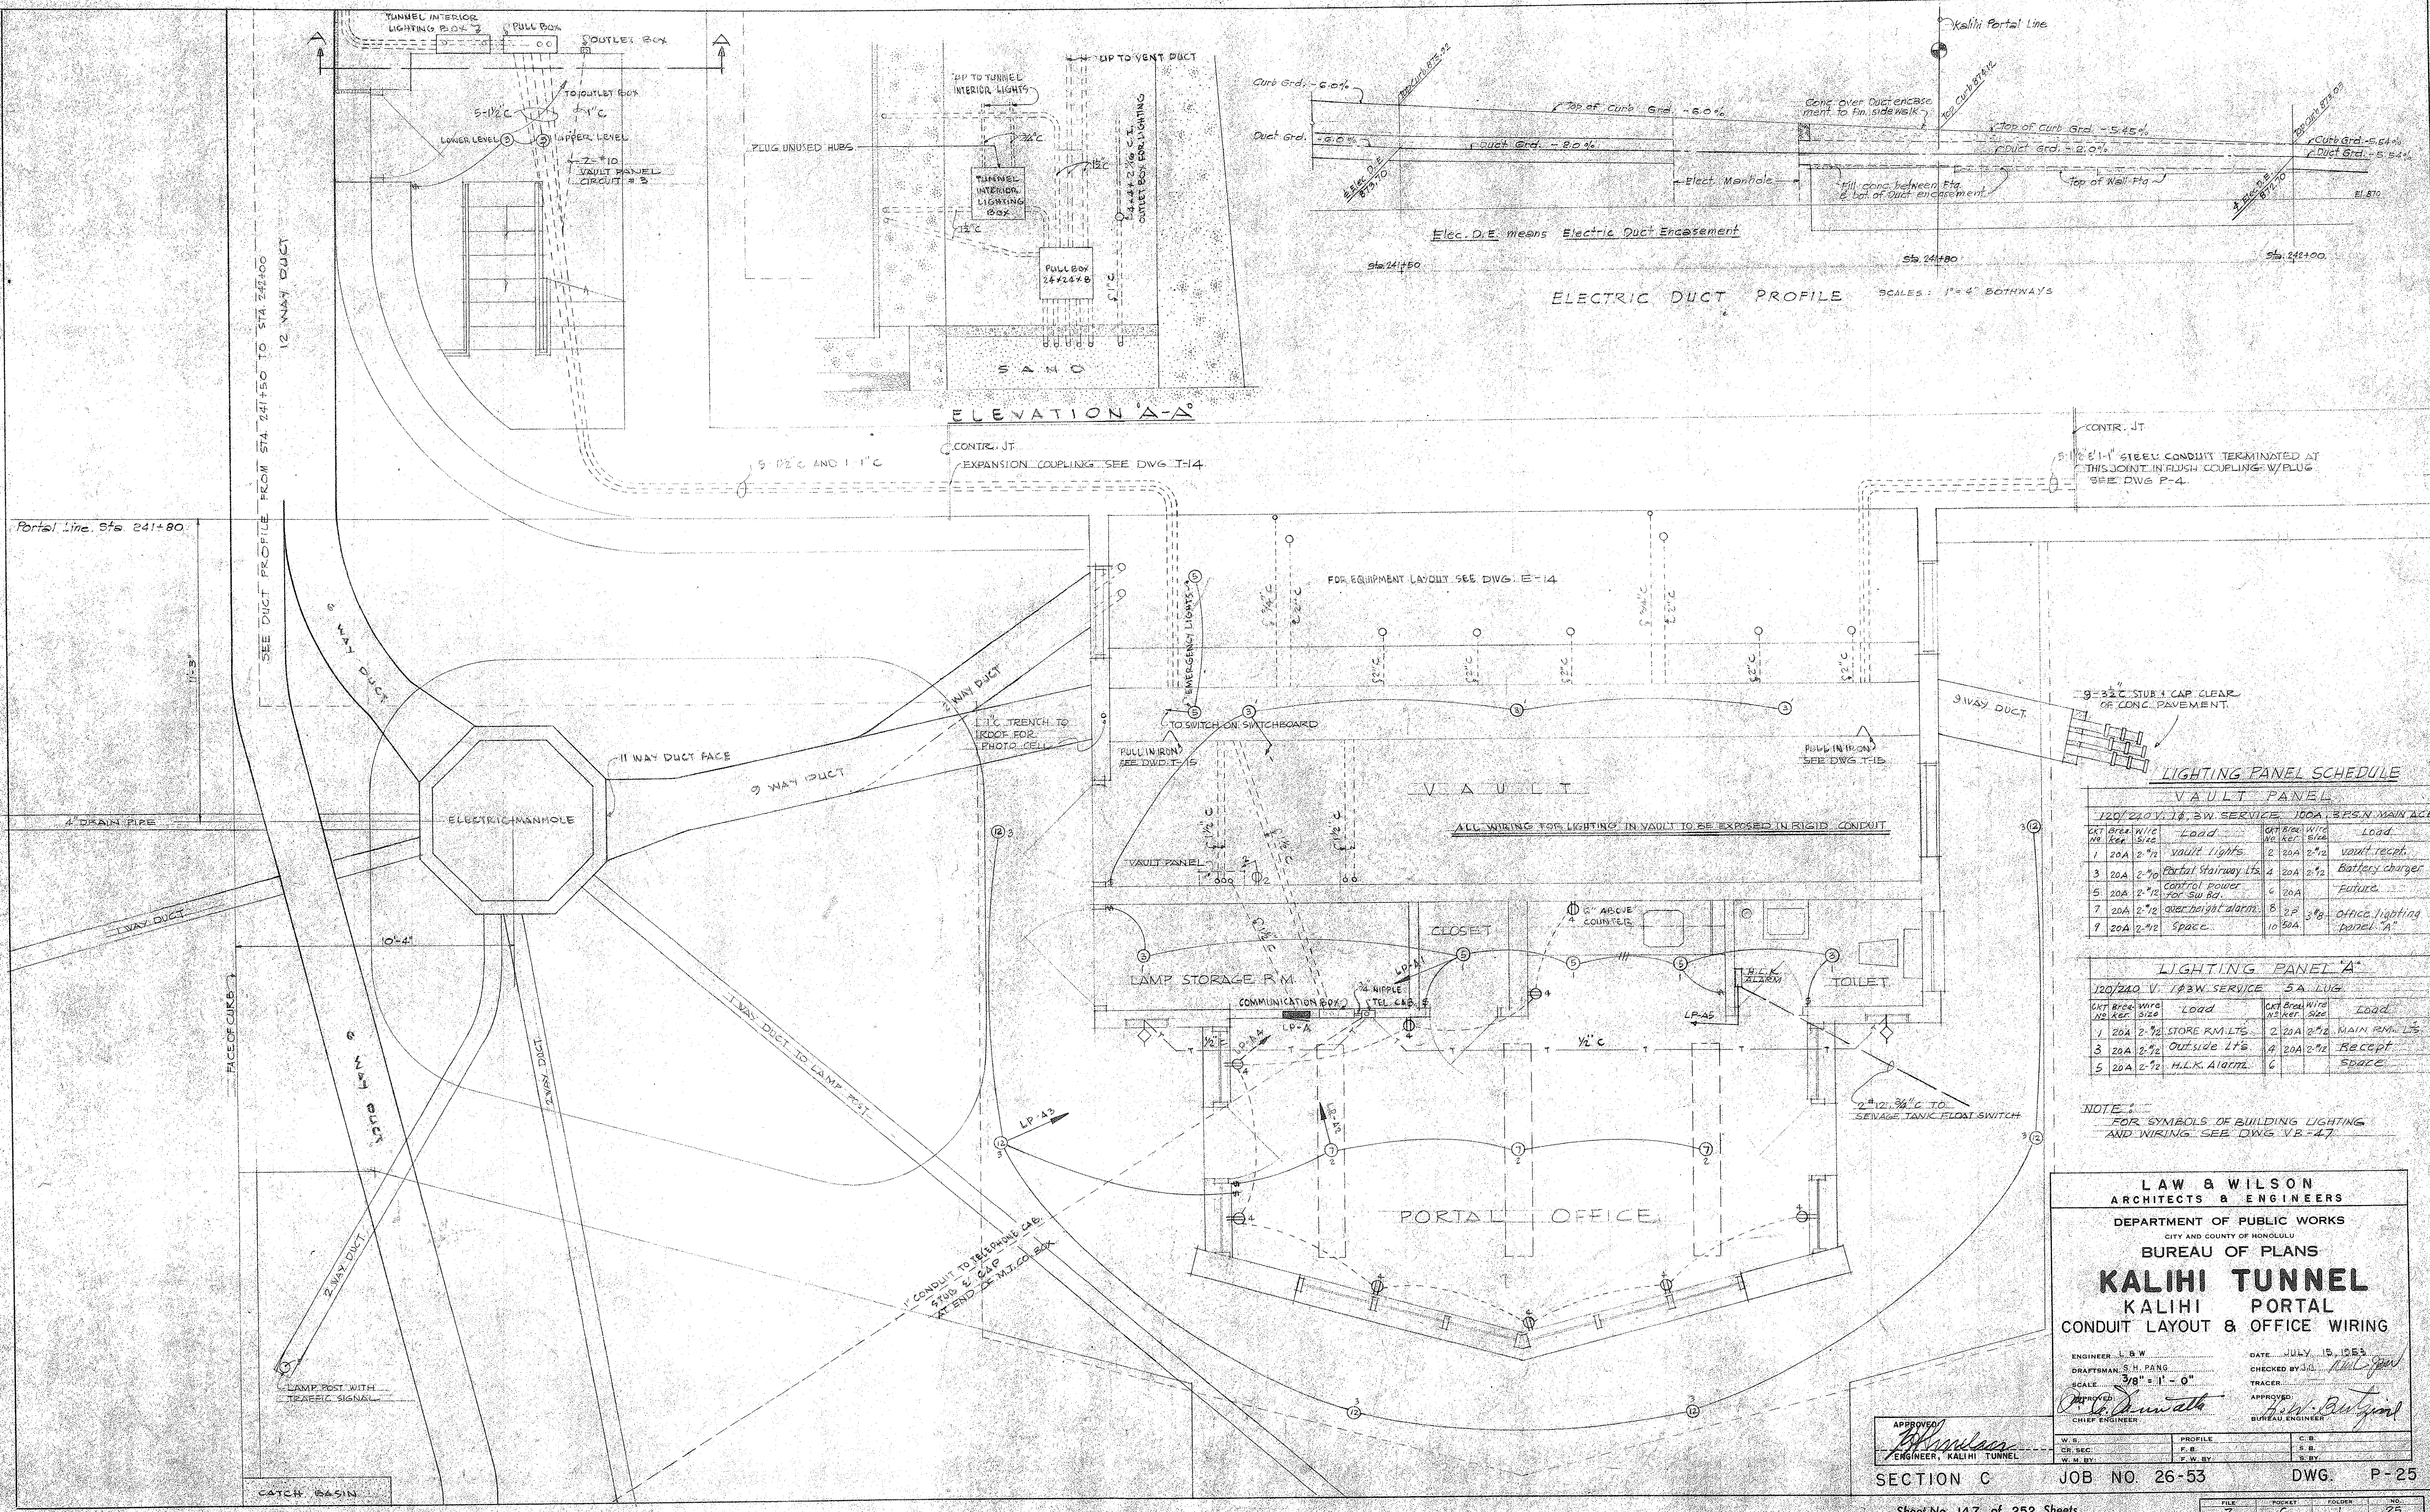

LIGHTING PANEL SCHEDULE

VAULT PANEL			
LT	Area	Wiring	Load
1	20A	2-1/2"	Vault Lights
2	20A	2-1/2"	Vault Recpt.
3	20A	2-1/2"	Partial Stairway Lts
4	20A	2-1/2"	Battery charger
5	20A	2-1/2"	Control Power for SW Bd.
6	20A	2-1/2"	Future
7	20A	2-1/2"	Overheight alarm
8	20A	2-1/2"	Office lighting panel "A"
9	20A	2-1/2"	Space

LIGHTING PANEL "A"			
LT	Area	Wiring	Load
1	20A	2-1/2"	STORE RM Lts
2	20A	2-1/2"	MAIN RM Lts
3	20A	2-1/2"	Outside Lts
4	20A	2-1/2"	Recept
5	20A	2-1/2"	Space

NOTE:
FOR SYMBOLS OF BUILDING LIGHTING AND WIRING SEE DWG. VB-47

LAW & WILSON
ARCHITECTS & ENGINEERS
CITY AND COUNTY OF HONOLULU
DEPARTMENT OF PUBLIC WORKS
BUREAU OF PLANS
KALIHI TUNNEL
KALIHI PORTAL
CONDUIT LAYOUT & OFFICE WIRING

ENGINEER: L.B.W.
DRAFTSMAN: S.H. PANG
SCALE: 3/8" = 1' - 0"
DATE: JULY 15, 1953
CHECKED BY: J.S. [Signature]
TRACER: [Signature]
APPROVED: [Signature] CHIEF ENGINEER
APPROVED: [Signature] BUREAU ENGINEER

W.S.	PROFILE	C.B.
CH. SEC.	P.B.	S.B.
W.M. BY	P.W. BY	S.W. BY

SECTION C JOB NO 26-53 DWG. P-25