


GROUND FL. CEILING PLAN (REAR OF BLDG.)

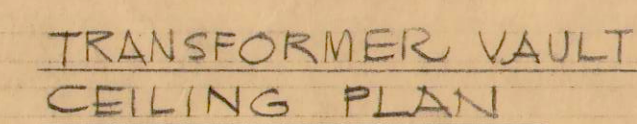


SECOND FL. CEILING PLAN


MEZZANINE CEILING PLAN

NOTES

ALL SWITCHES SHOWN SAT 4' ABOVE GROUND
FLOOR LEAVE OTHERS UNCHANGED
FOR GROUND FLOOR RECEPTACLES SEE DWG. NO. E-17
FOR EXTERIOR LIGHTS SEE DWG. NO. VB-6
FOR LOCATION OF LUMINAIRES WITH RESPECT
TO NEAREST STRUCTURAL MEMBER OR SUPPORT
SEE BUILDING CROSS SECTION, E-19, 20.
FOR ELECTRICAL LEGEND & ADDITIONAL
NOTES SEE DWG. NO. VB-47.

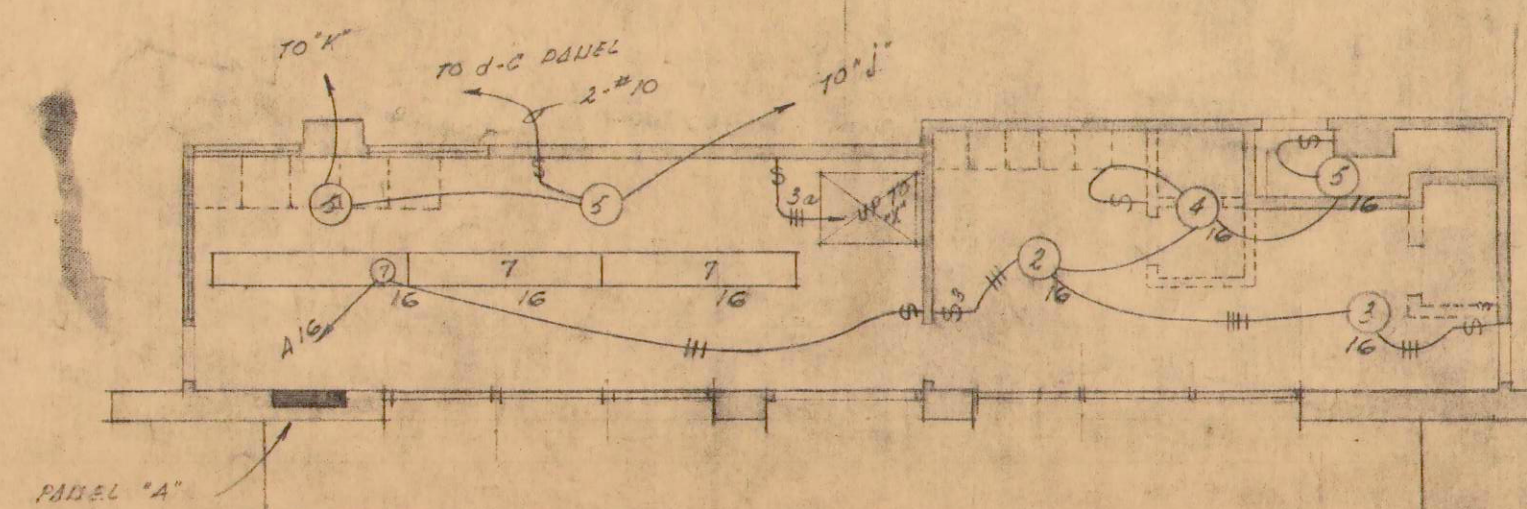

CONTROL ROOM & TOILET CEILING PLAN

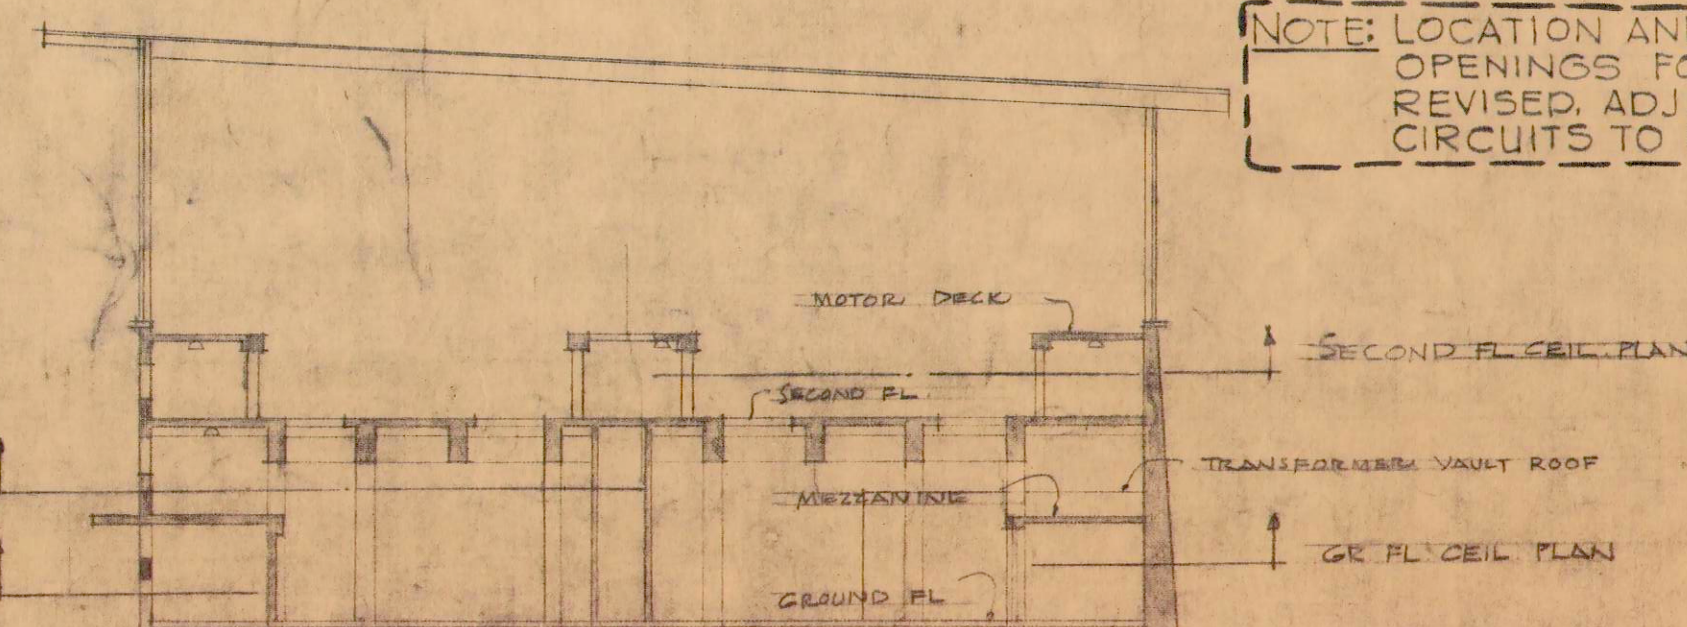

NOTE: LOCATION AND SIZES OF OPENINGS FOR VENT FANS REVISED. ADJUST ELECTRICAL CIRCUITS TO MEET REVISIONS

1	4-16-96	SEE NOTE	E.V.	10
REVISION	DATE	DESCRIPTION	MADE BY	CHK BY

LAW & WILSON
ARCHITECTS & ENGINEERS

DEPARTMENT OF PUBLIC WORKS
CITY AND COUNTY OF HONOLULU

BUREAU OF PLANS
KALIHI TUNNEL
VENTILATION BLDG.
ELECTRIC LIGHTING
REFLECTED CEILING PLANS

ENGINEER	1.8 W	DATE	24.12.15 12.23
DRAFTSMAN	M. H.	CHECKED BY	J. O. <i>[Signature]</i>
SCALE	AS NOTED	TRACER	
APPROVED	<i>[Signature]</i>	APPROVED	<i>[Signature]</i>
CHIEF ENGINEER		ENGINEER	

APPROVED:
H. Sanders
ENGINEER, KALIHI TUNNEL

SECTION C

JOB NO. 26-53

DWG. VB-46