

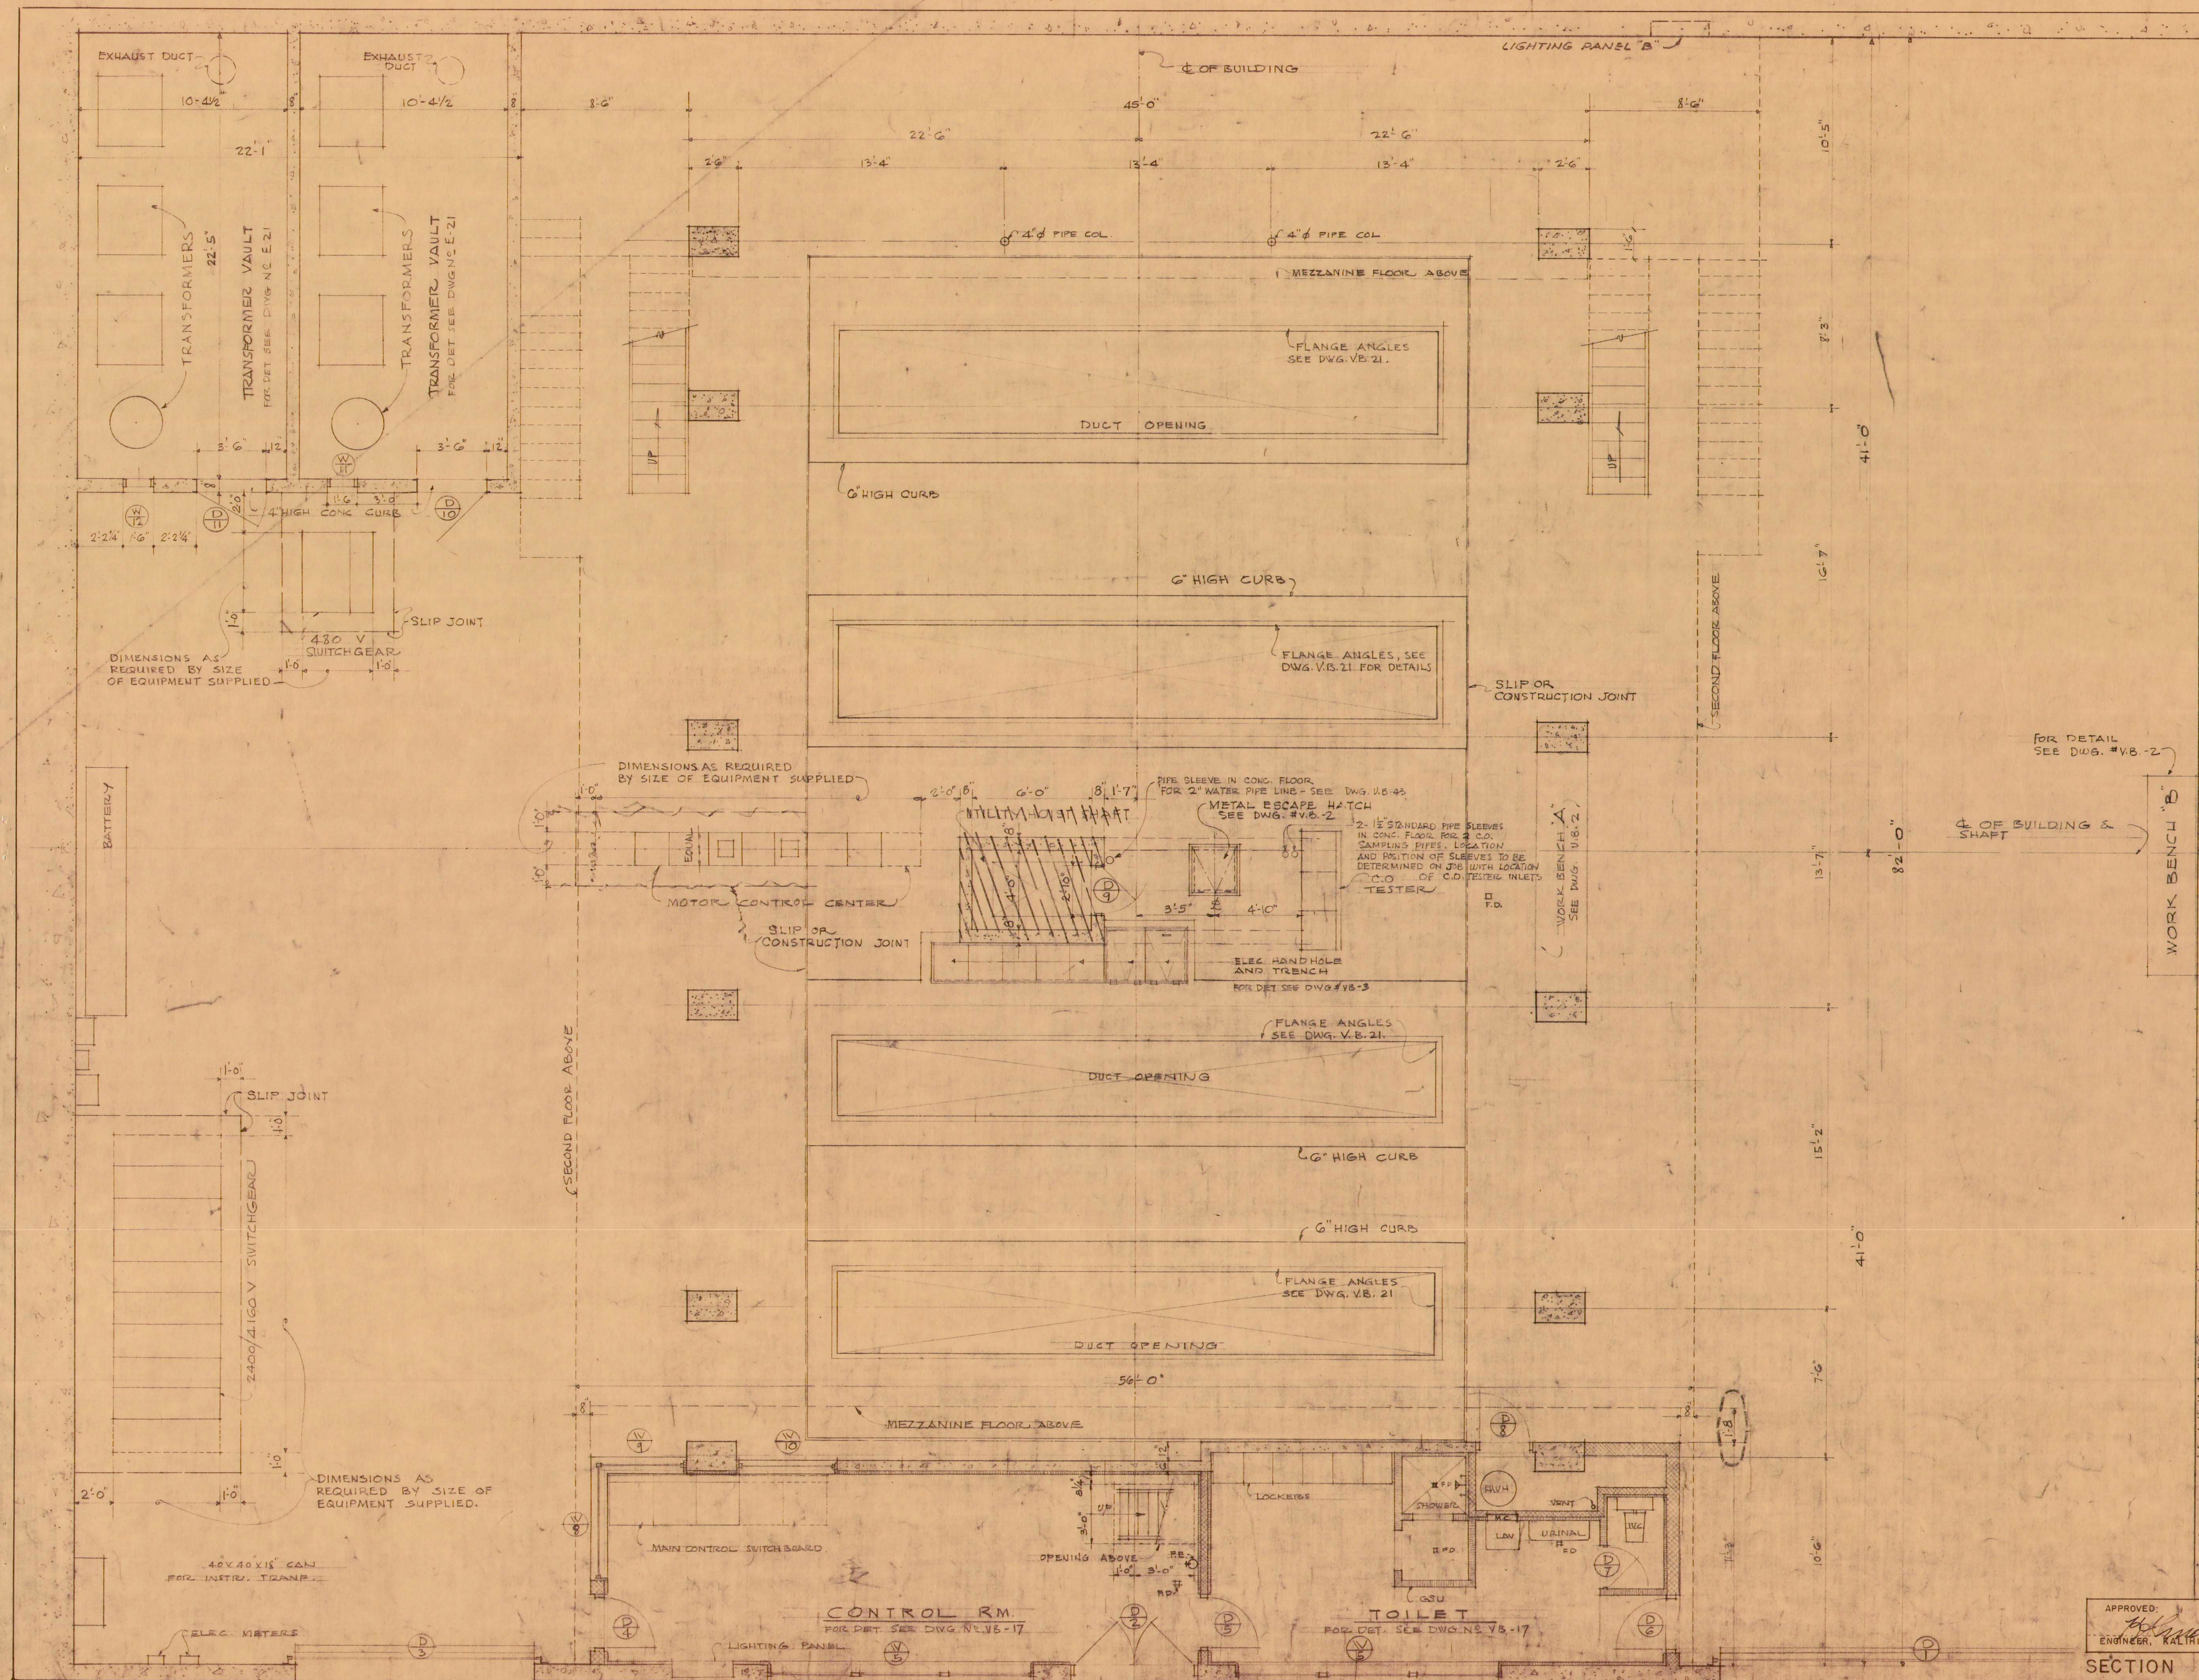


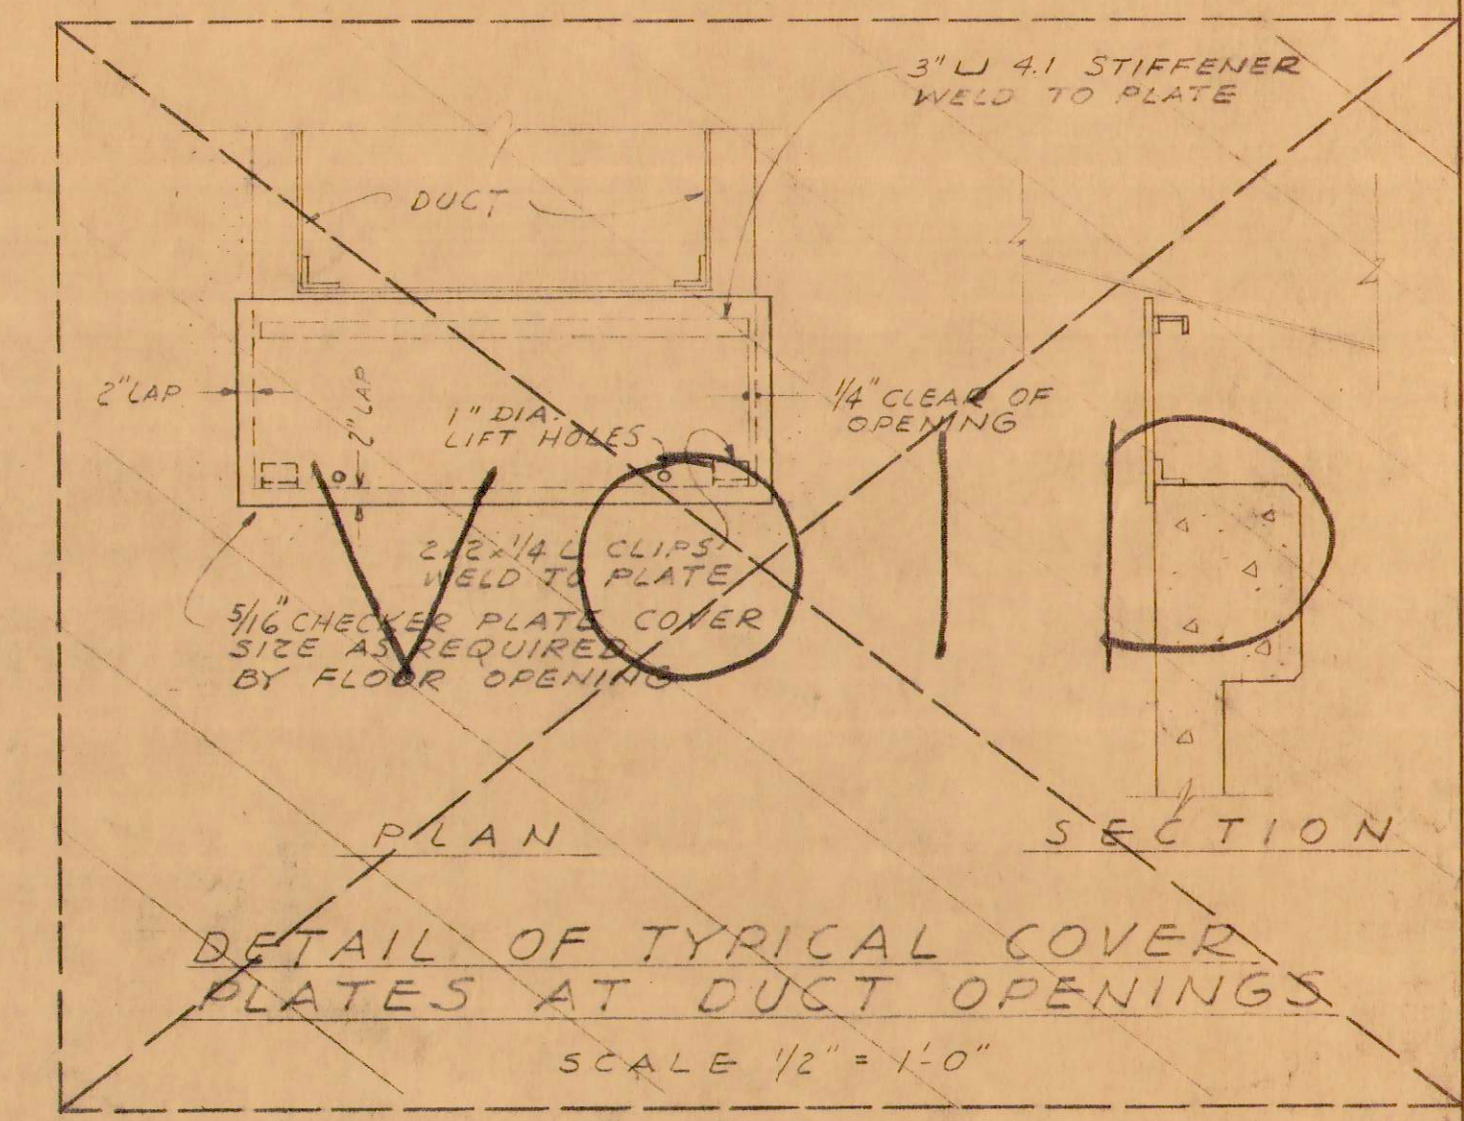

2	7-20-54	RELOCATED DUCT OPENINGS	H.M.	90
1	4-16-56	RELOCATED OPENINGS & EQUIPMENT	E.V.	10
REVISION	DATE	DESCRIPTION	MADE BY	CHECKED BY
LAW & WILSON ARCHITECTS & ENGINEERS DEPARTMENT OF PUBLIC WORKS CITY AND COUNTY OF HONOLULU BUREAU OF PLANS KALIHI TUNNEL VENTILATION BLDG. GROUND FLOOR PLAN				
ENGINEER	L. & W.	DATE	JULY 15, 1958	
DRAFTSMAN	P.K.	CHECKED BY	R.R. [Signature]	
SCALE	1/4" = 1'-0"	TRACER		
APPROVED	[Signature]	APPROVED	[Signature]	
CHIEF ENGINEER		BUREAU ENGINEER		
W.S.	CR. SEC.	PROFILE	C.B.	
W.M. BY.	F.W. BY.	S.B.	S.B.	
SECTION C JOB NO. 26-53 DWG. VB-10				

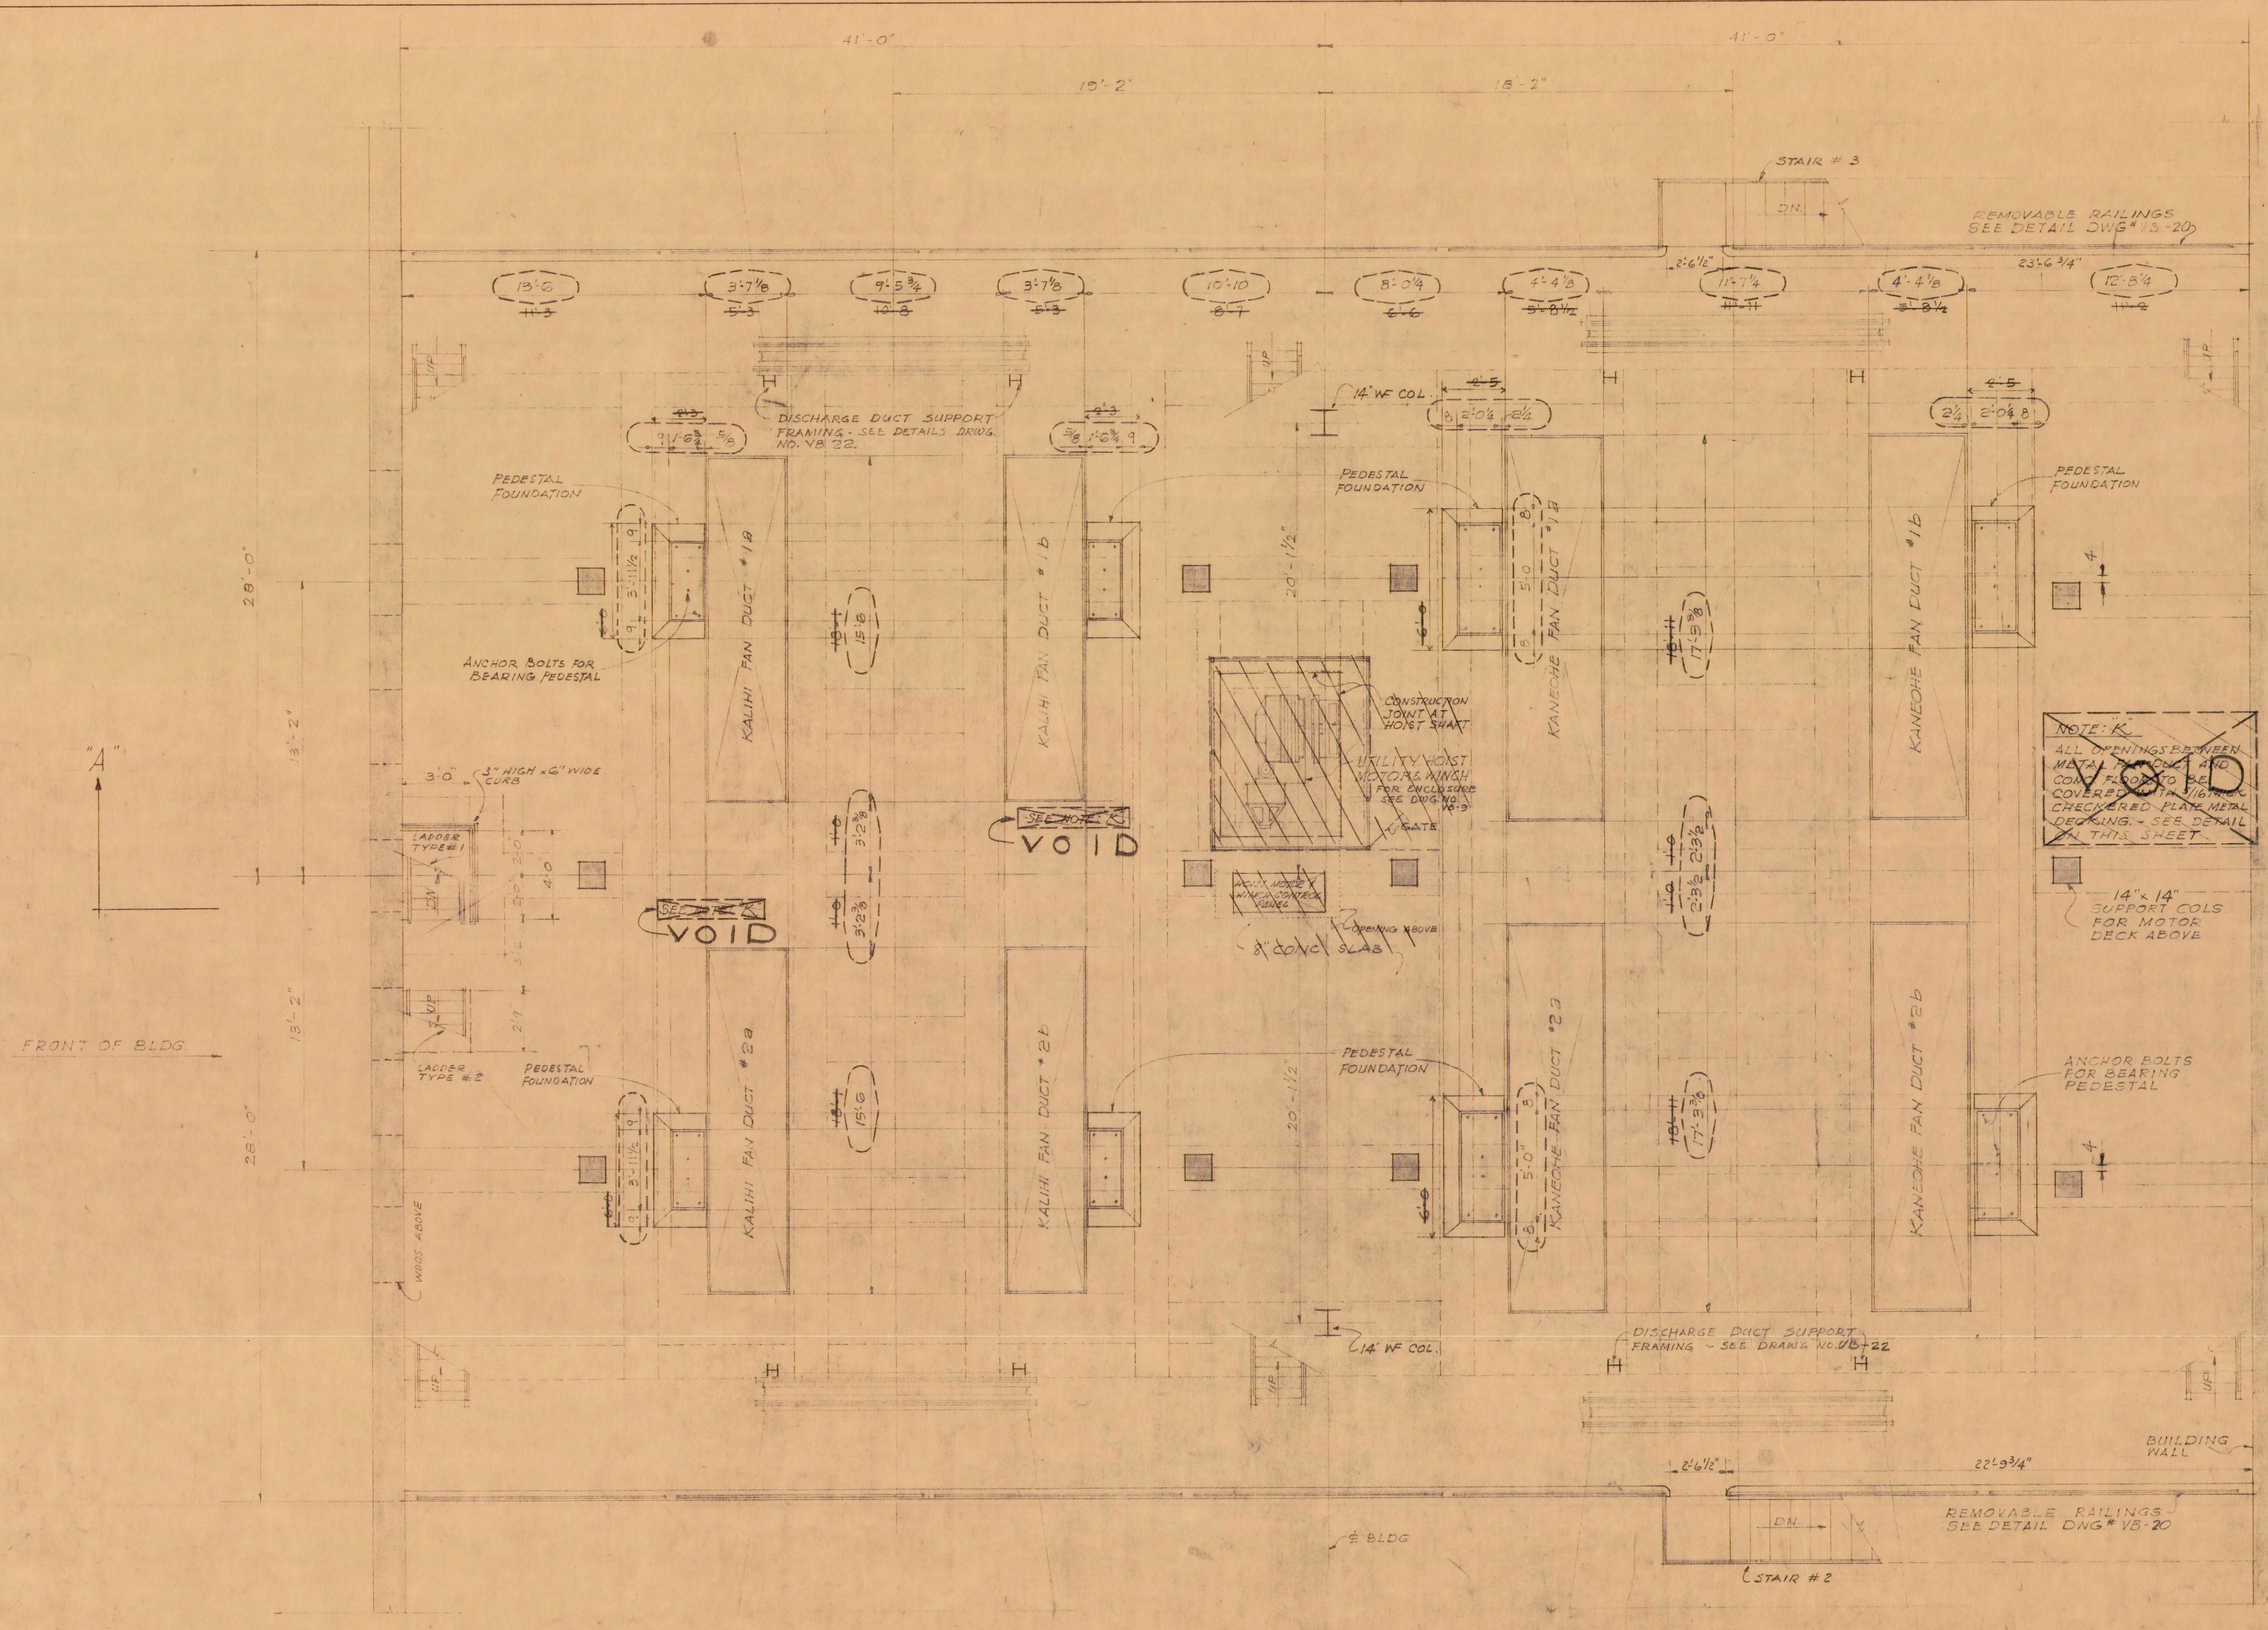

NOTE: K
ALL OPENINGS BETWEEN
METAL PARTS OF THE
CONCRETE FLOOR TO BE
COVERED WITH 1/8\"/>

SEE DWG # VB-8
FOR THIS SECTION

NOTES

PROVIDE AND INSTALL ALL NECESSARY ANCHOR BOLTS
AS REQUIRED TO ACCOMMODATE FAN BASE, MOTORS, SPEED
REDUCERS AND BEARING PEDESTAL. THE LOCATION, SIZE
AND TYPE TO BE AS RECOMMENDED BY THE MANUFACT-
URERS OF THE EQUIPMENT FURNISHED.

SECOND FLOOR PLAN
SCALE: 1/4" = 1'-0"

1	4-16-55	RELOCATED OPENINGS & EQUIPMENT	E.V.B.	100
REVISION	DATE	DESCRIPTION	MADE BY	CHK BY

LAW & WILSON
ARCHITECTS & ENGINEERS
DEPARTMENT OF PUBLIC WORKS
CITY AND COUNTY OF HONOLULU
BUREAU OF PLANS
KALIHI TUNNEL
VENTILATION BLDG.
2ND FLOOR PLAN

ENGINEER: L.W. DATE: JULY 15, 1955
DRAFTSMAN: P.K. CHECKED BY: R.B.
SCALE: 1/4" = 1'-0" TRACER:
APPROVED: *[Signature]* CHIEF ENGINEER
APPROVED: *[Signature]* BUREAU ENGINEER

W.S.	PROFILE	C.B.
CR. SEC.	F.S.	S.B.
W.M. BY:	F.W. BY:	S. BY: