
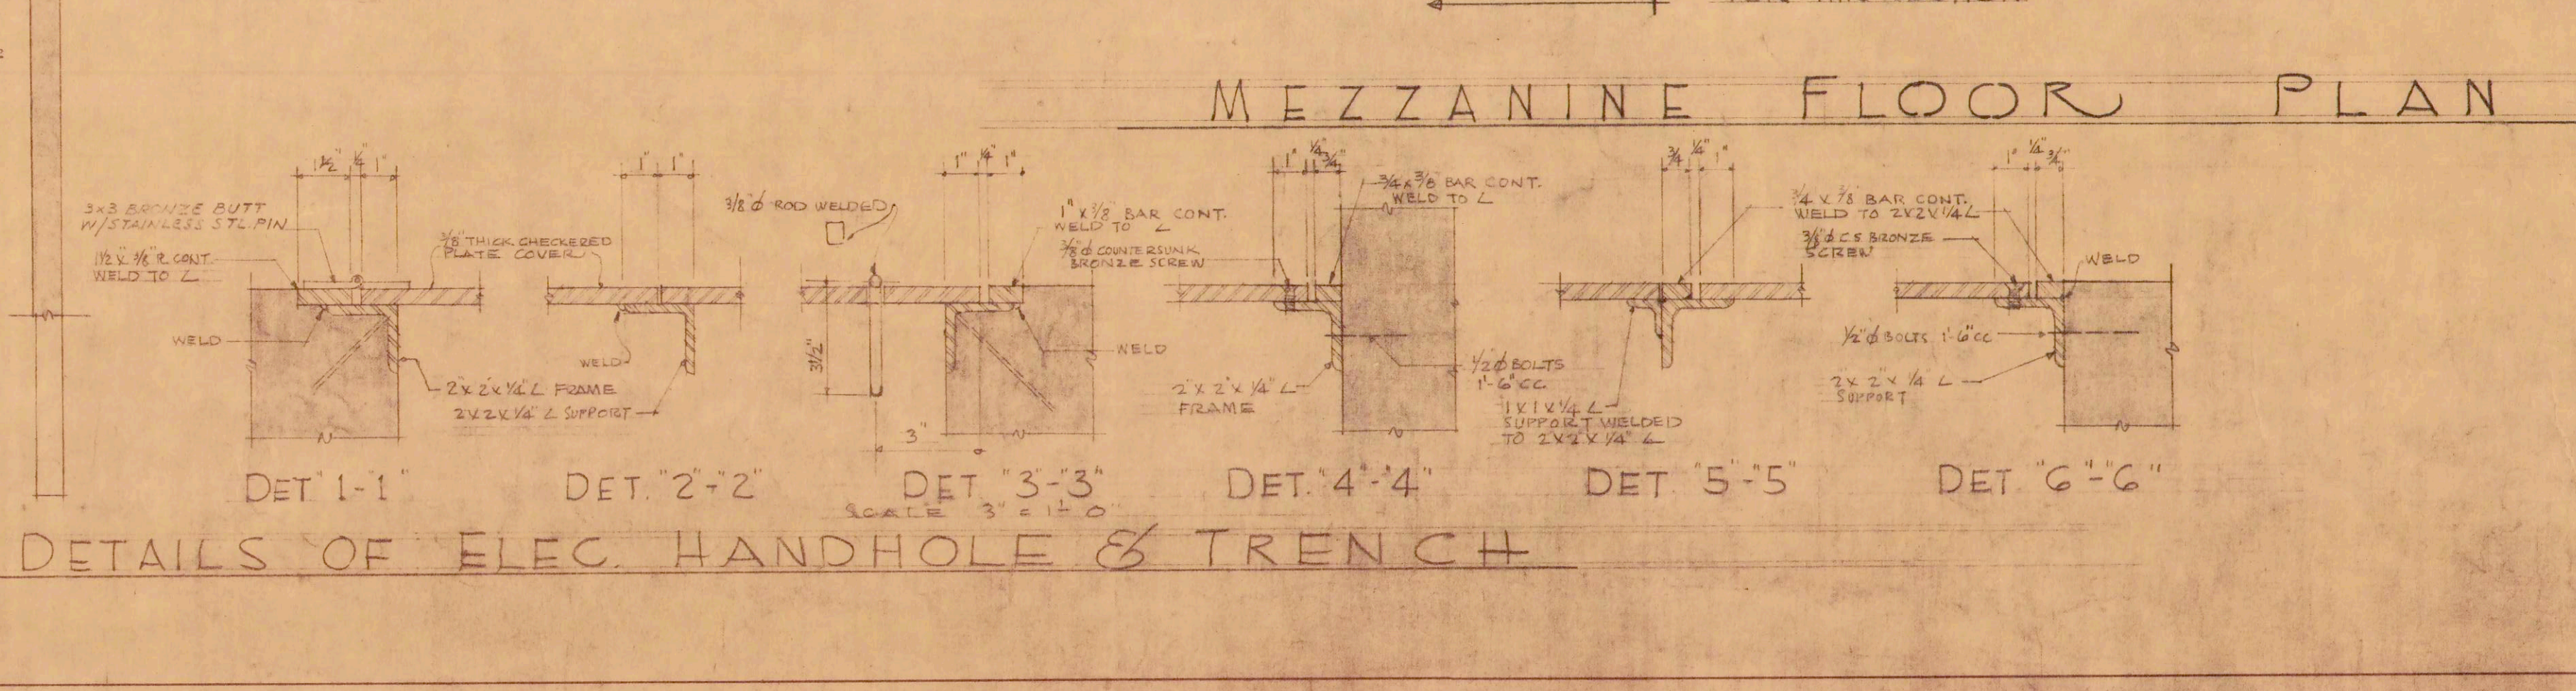
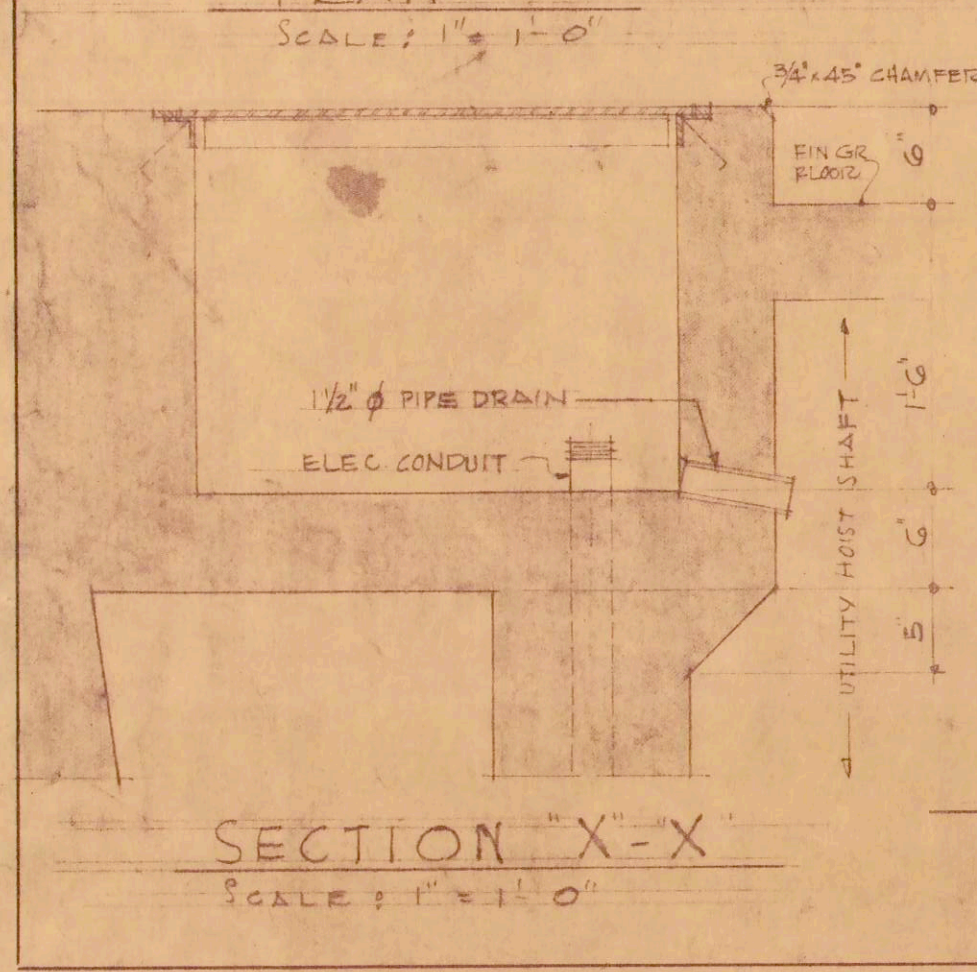
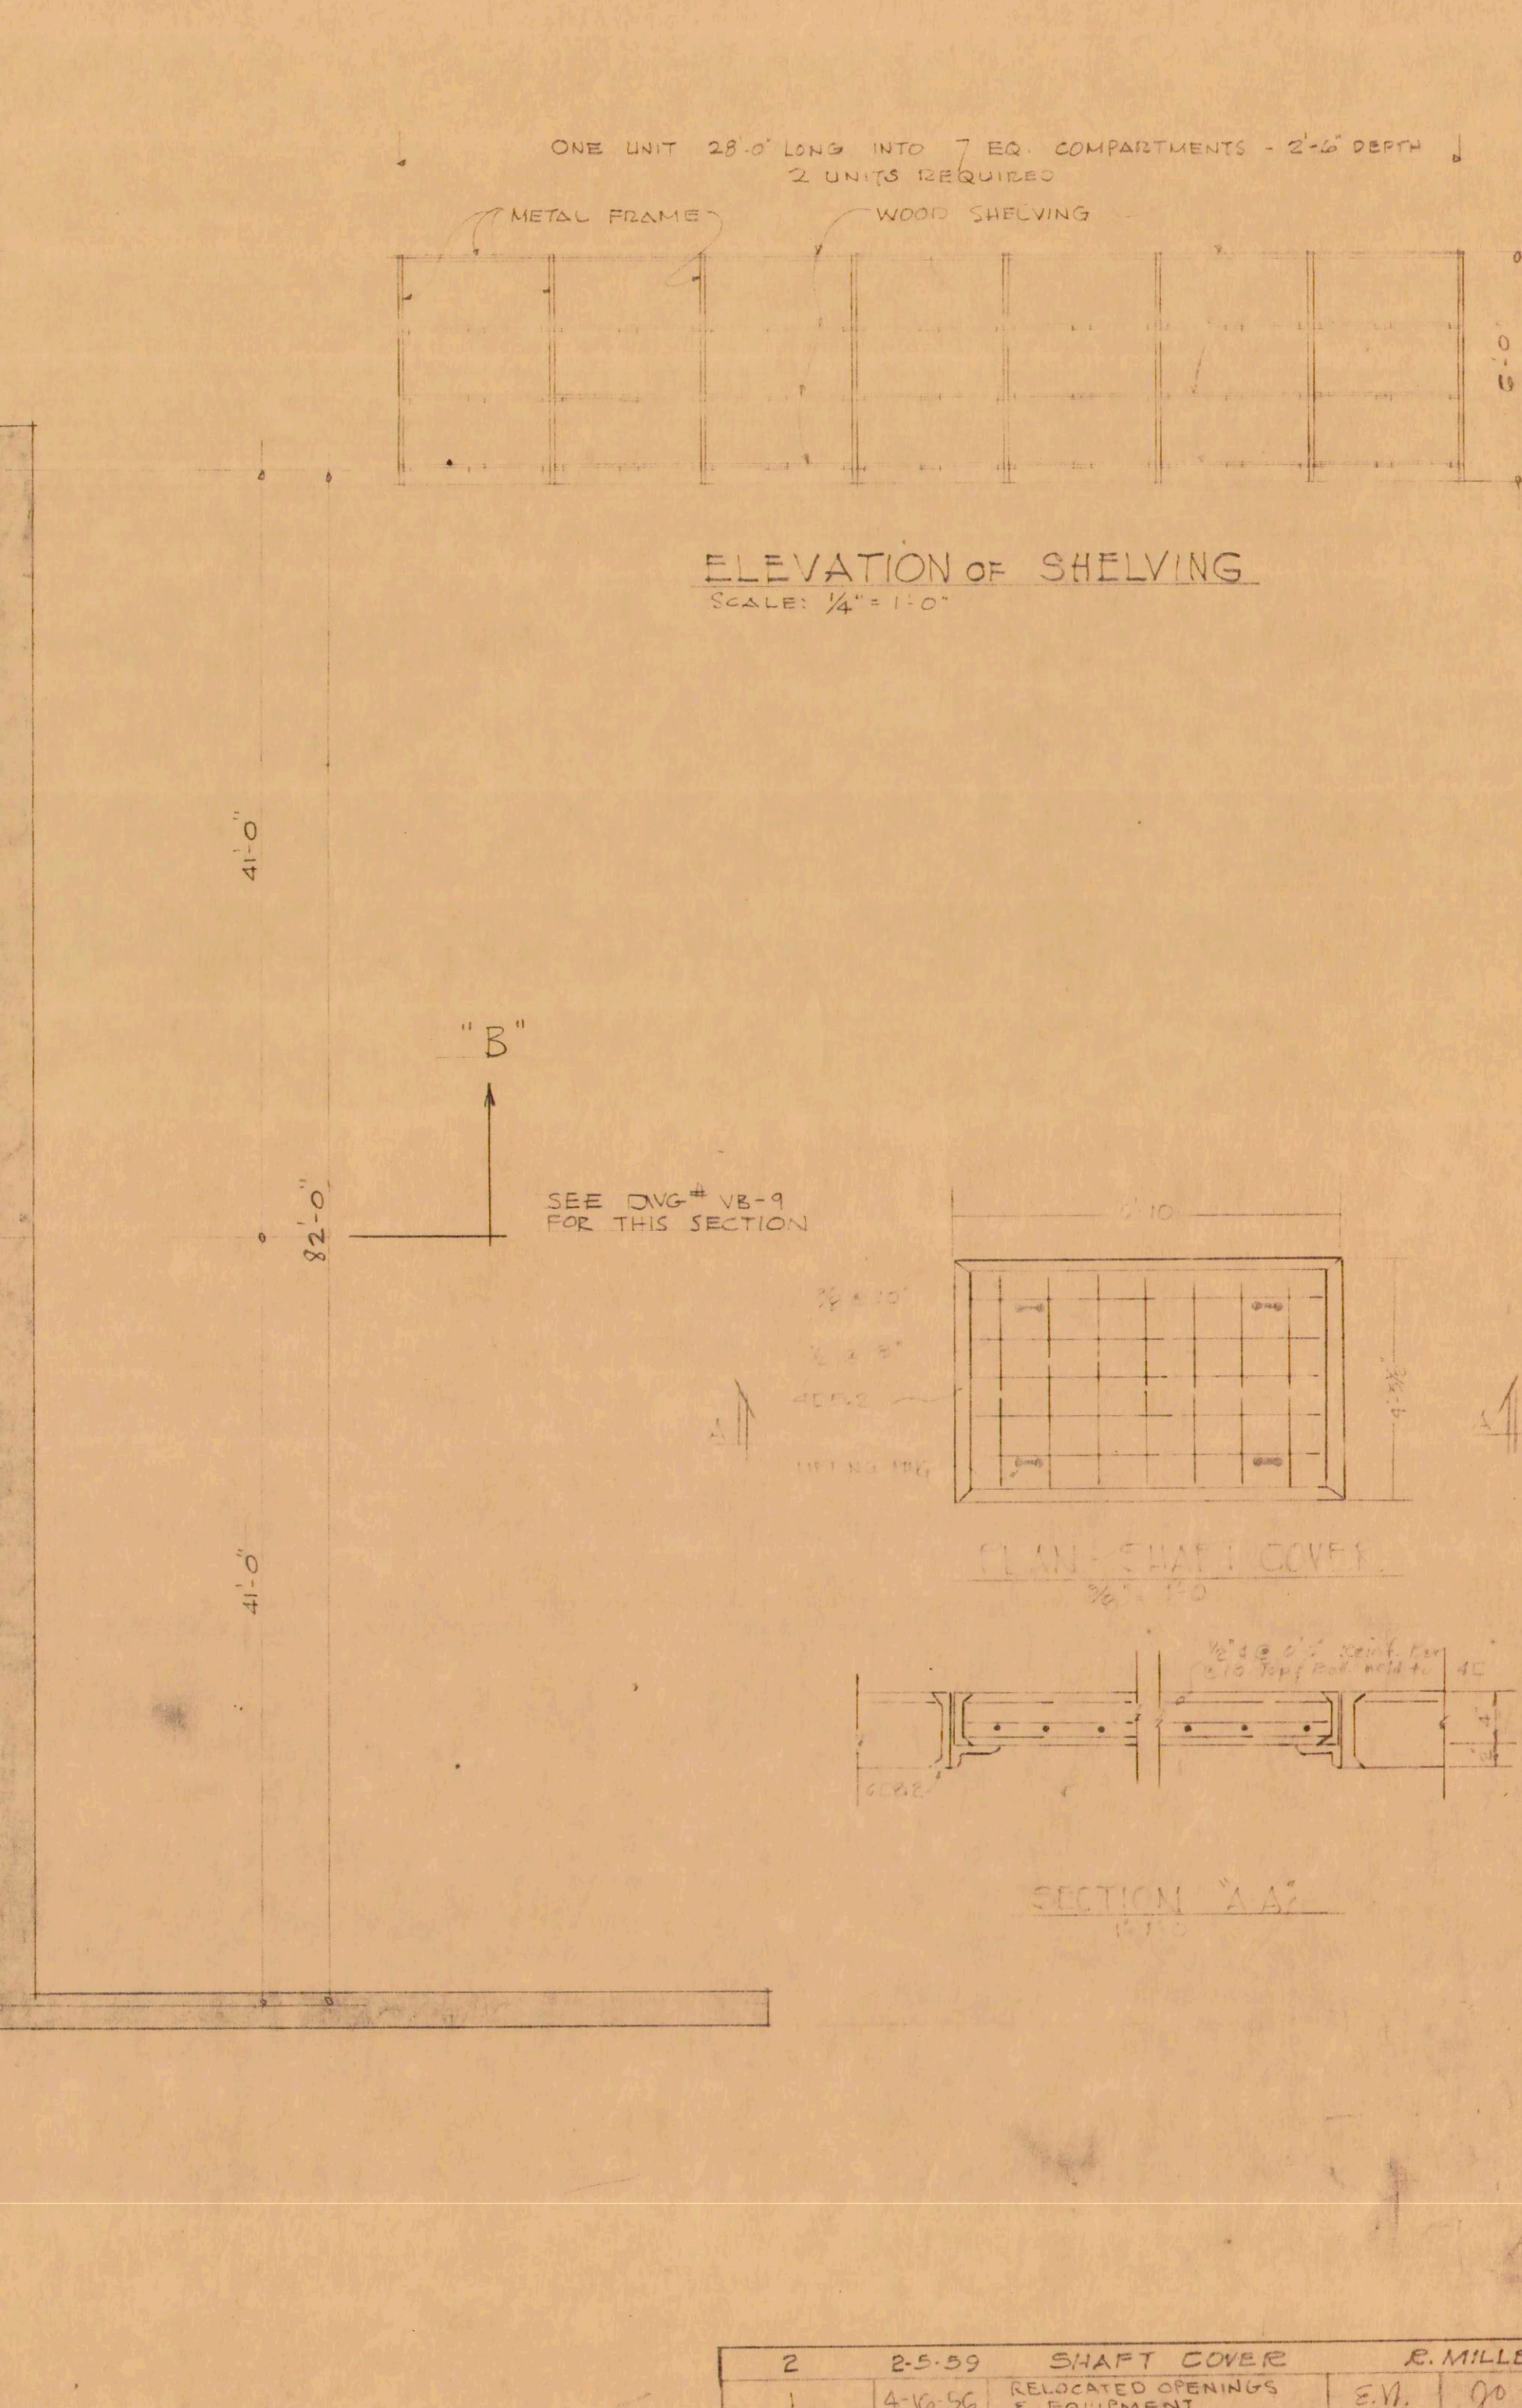
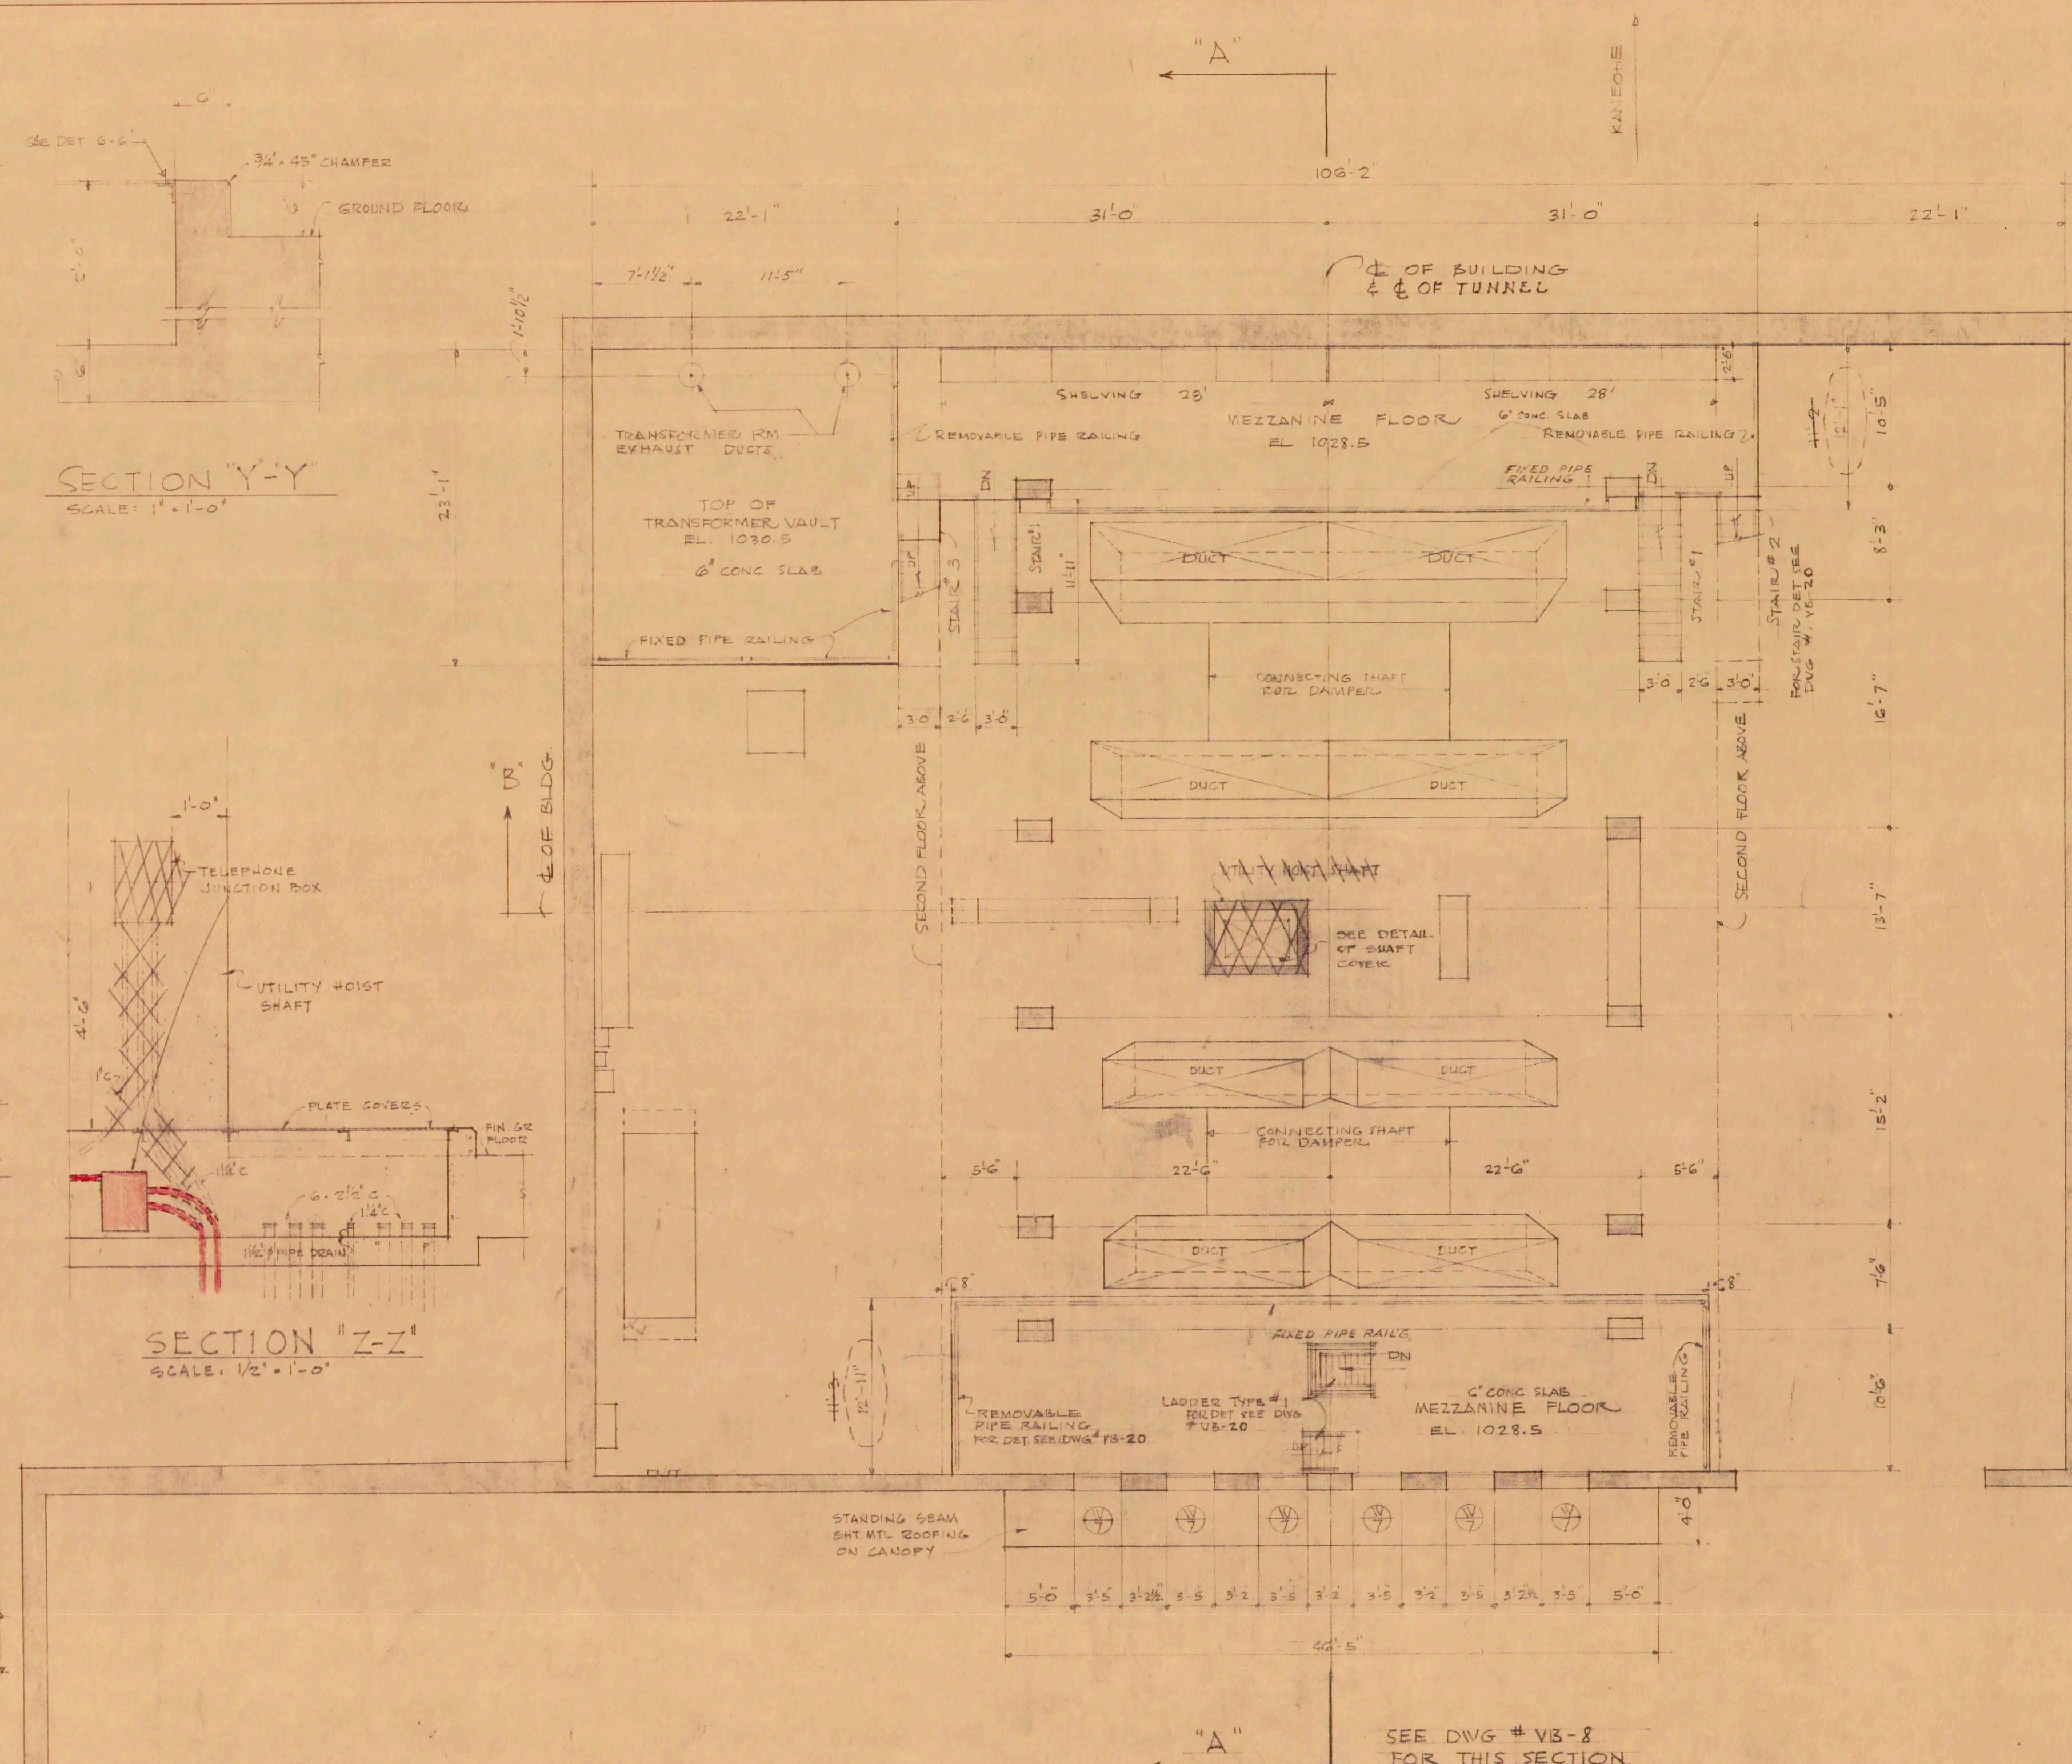


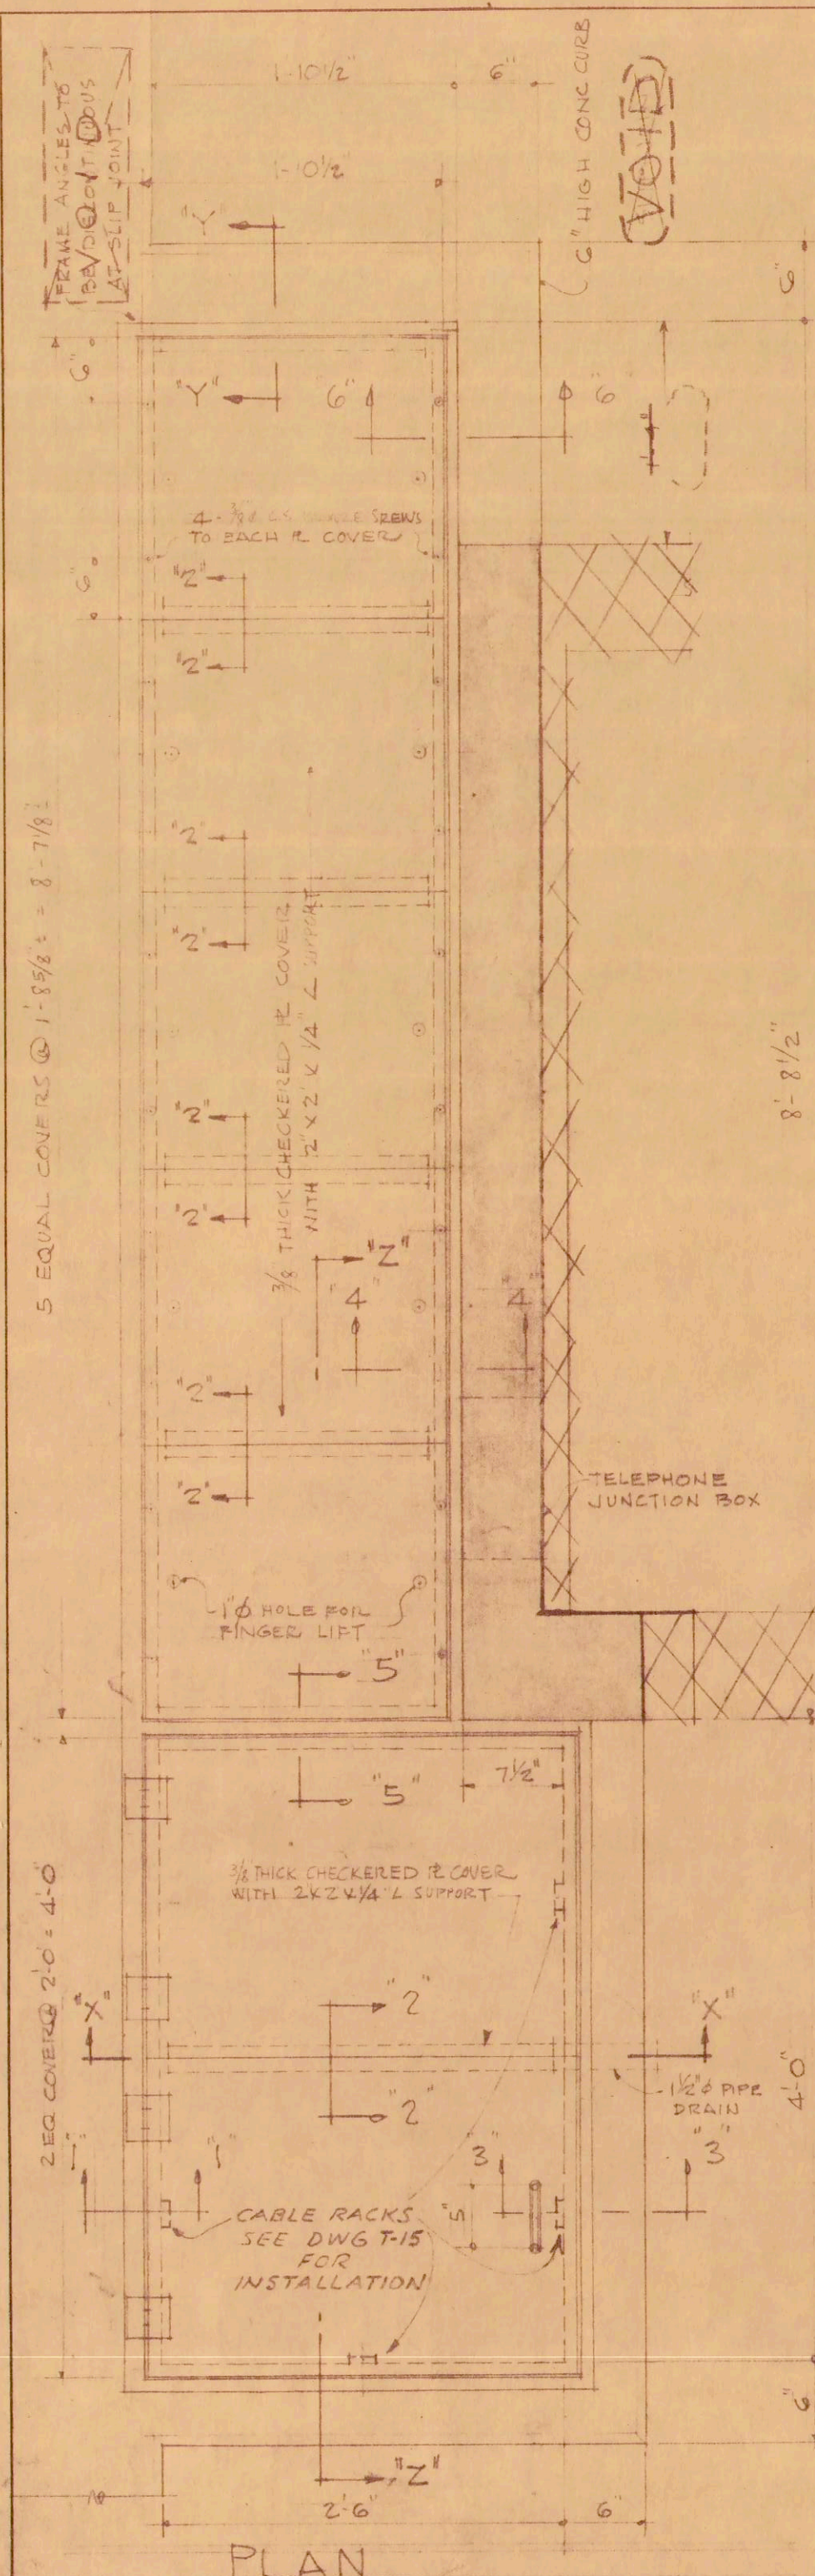

2	2-5-59	SHAFT COVER	R. MILLER
1	4-16-56	RELOCATED OPENINGS & EQUIPMENT	S.W. 90
REVISION	DATE	DESCRIPTION	MADE BY CHK. BY

LAW & WILSON
ARCHITECTS & ENGINEERS
DEPARTMENT OF PUBLIC WORKS
CITY AND COUNTY OF HONOLULU
BUREAU OF PLANS
KALIHI TUNNEL
VENTILATION BLDG.
MEZZANINE FLOOR PLAN

ENGINEER: L.A.W. DATE: JULY 18, 1959
DRAFTSMAN: P.K. CHECKED BY: [Signature]
SCALE: AS NOTED TRACER: [Signature]
APPROVED: [Signature] CHIEF ENGINEER
APPROVED: [Signature] BUREAU ENGINEER

W.B.	PROFILE	C.B.
C.R. SEC.	P.B.	S.B.
W.M. BY	P.W. BY	L.B.V.

SECTION C JOB NO. 26-53 DWG. VB-3