




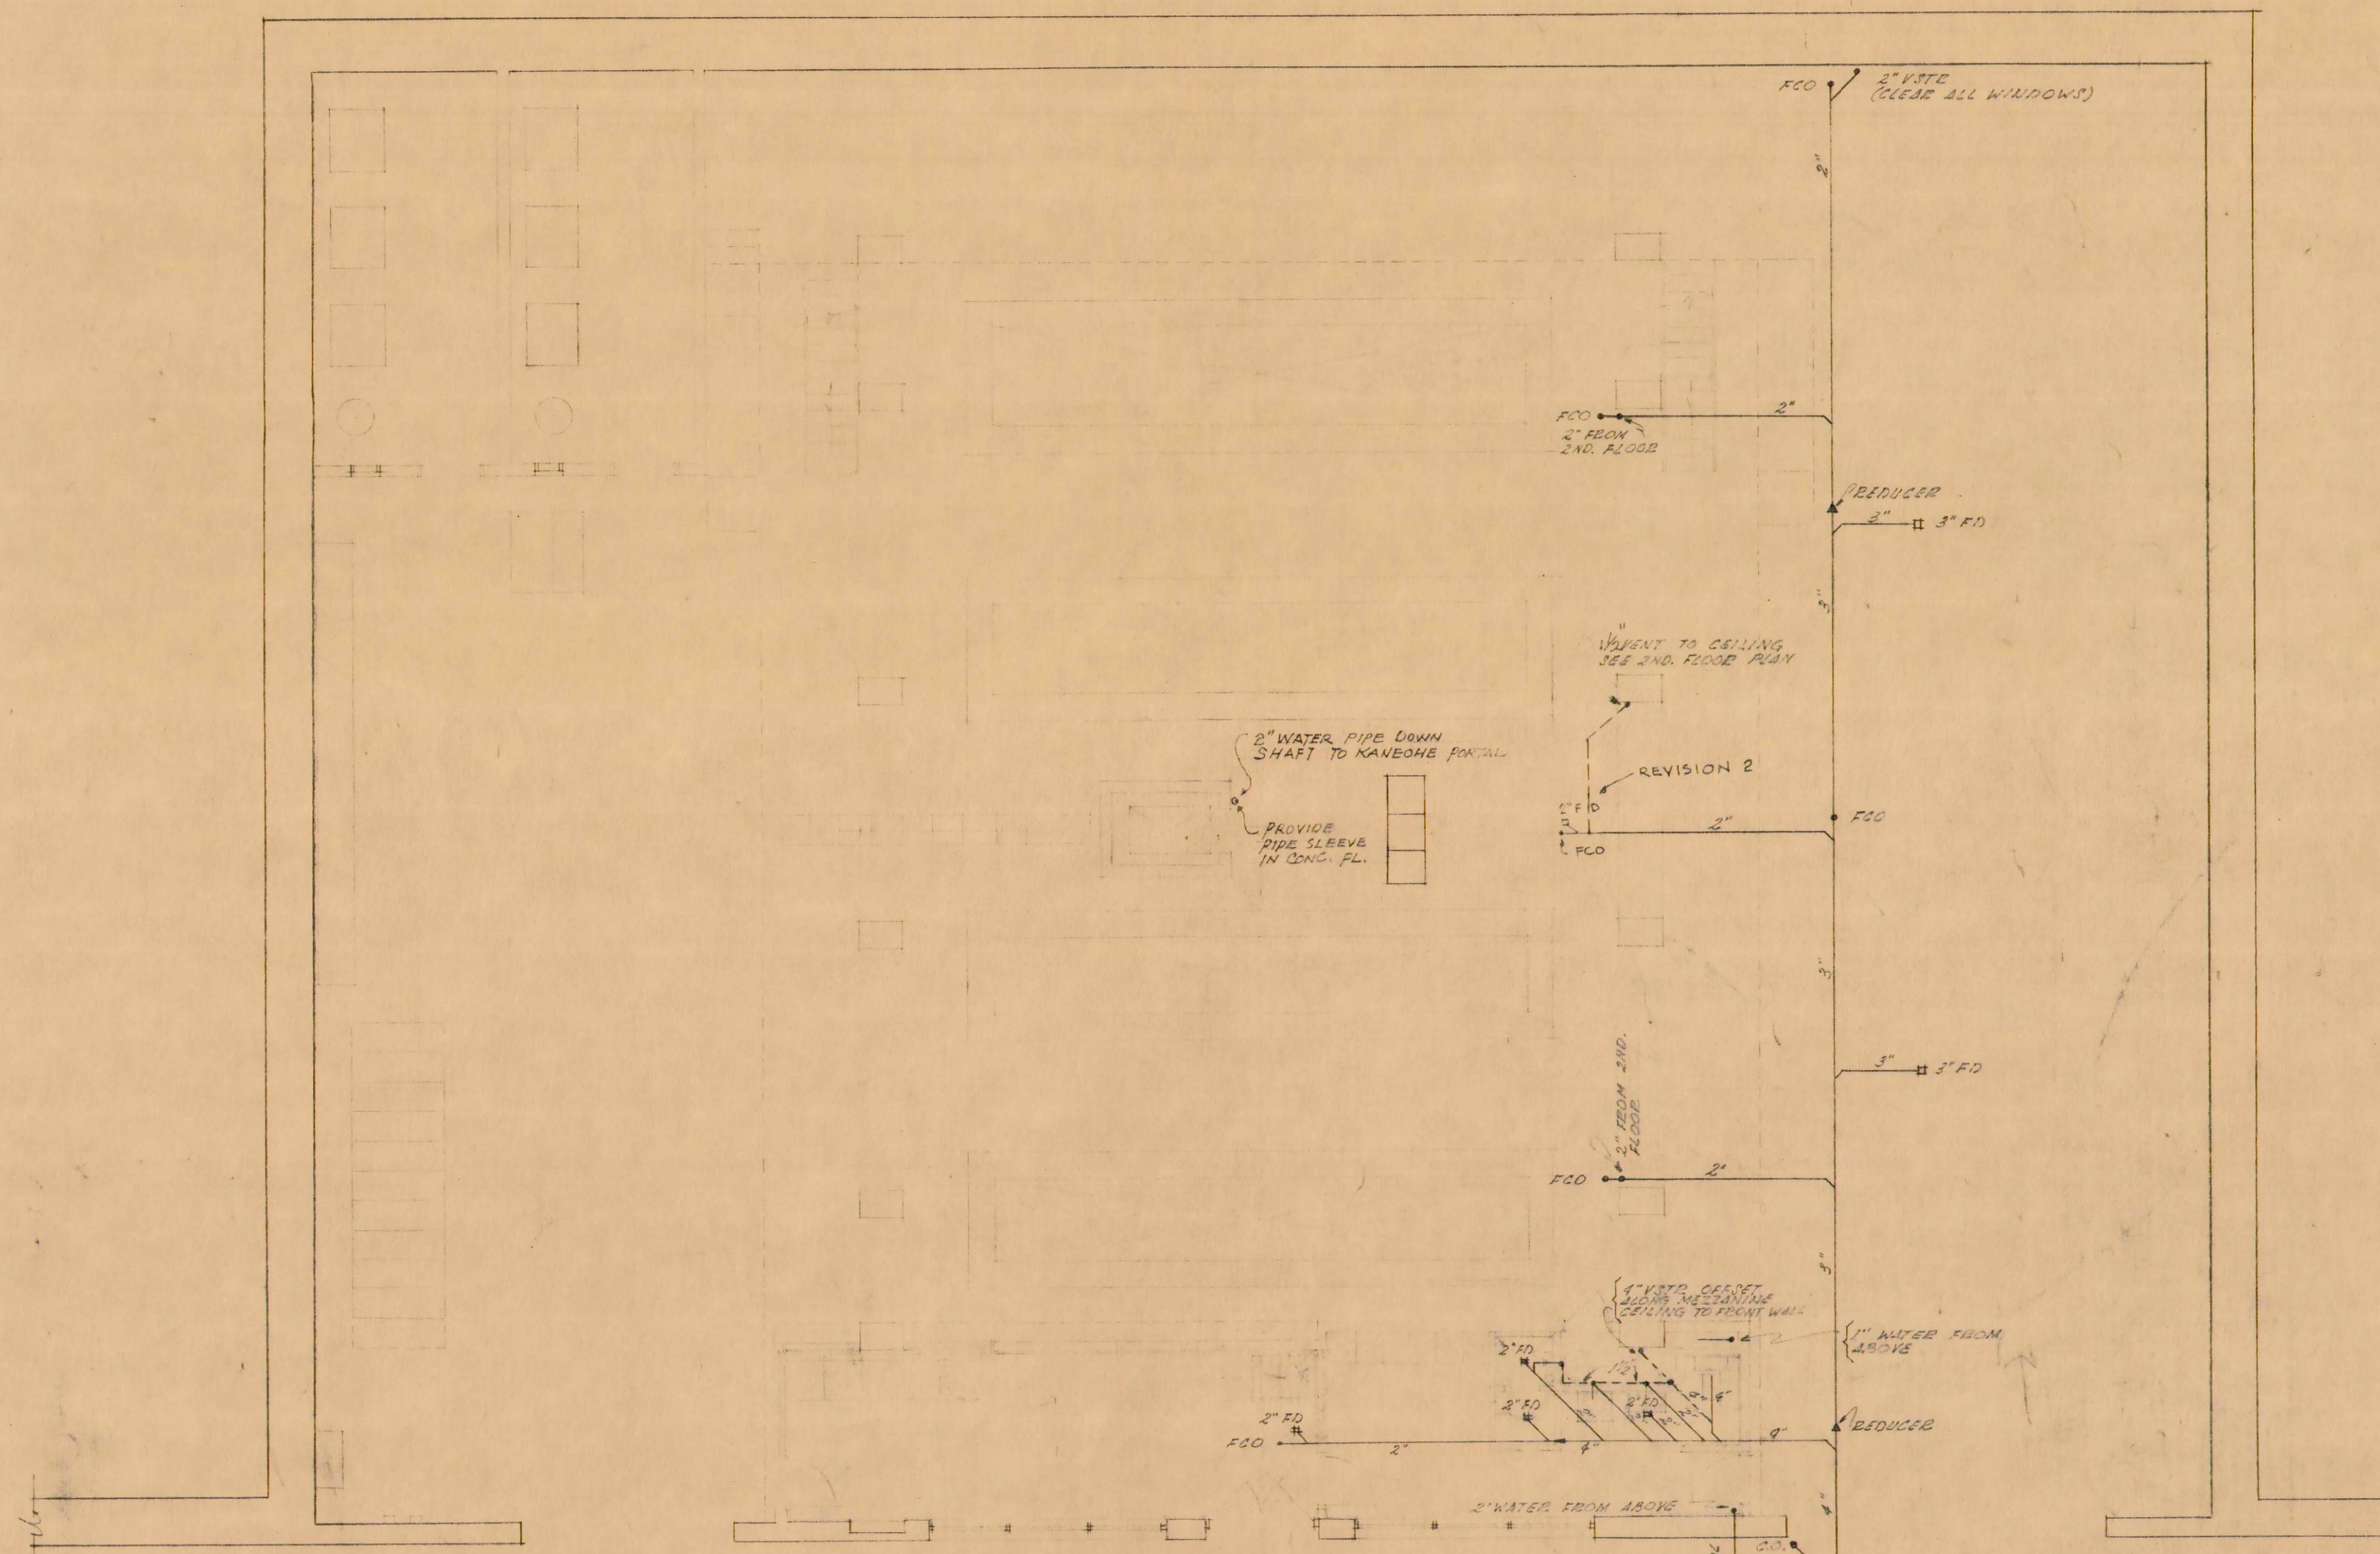

GROUND FLOOR PLAN
SCALE: 1/8" = 1'-0"

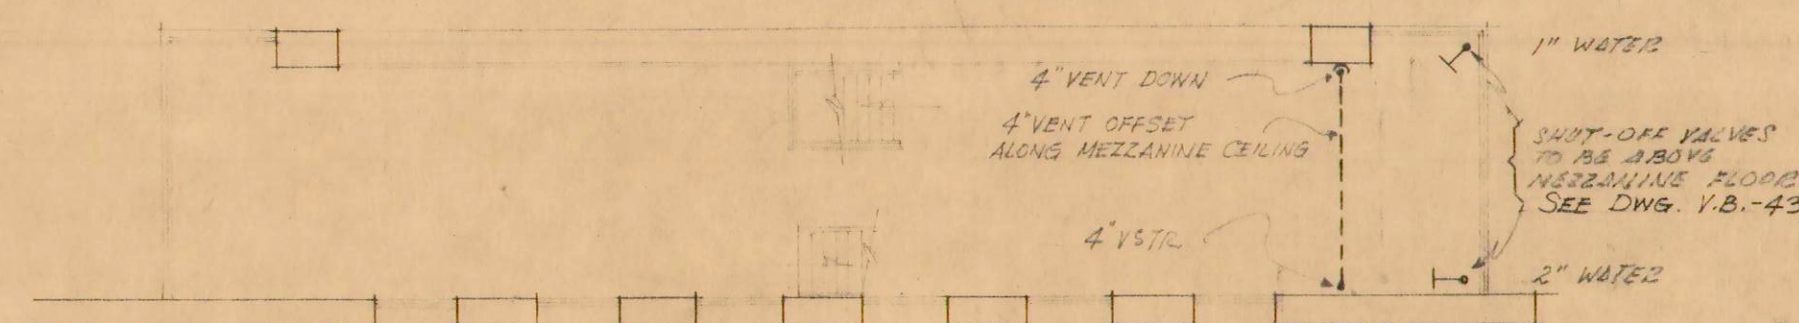


MEZZANINE FLOOR PLAN
SCALE: 1/8" = 1'-0"

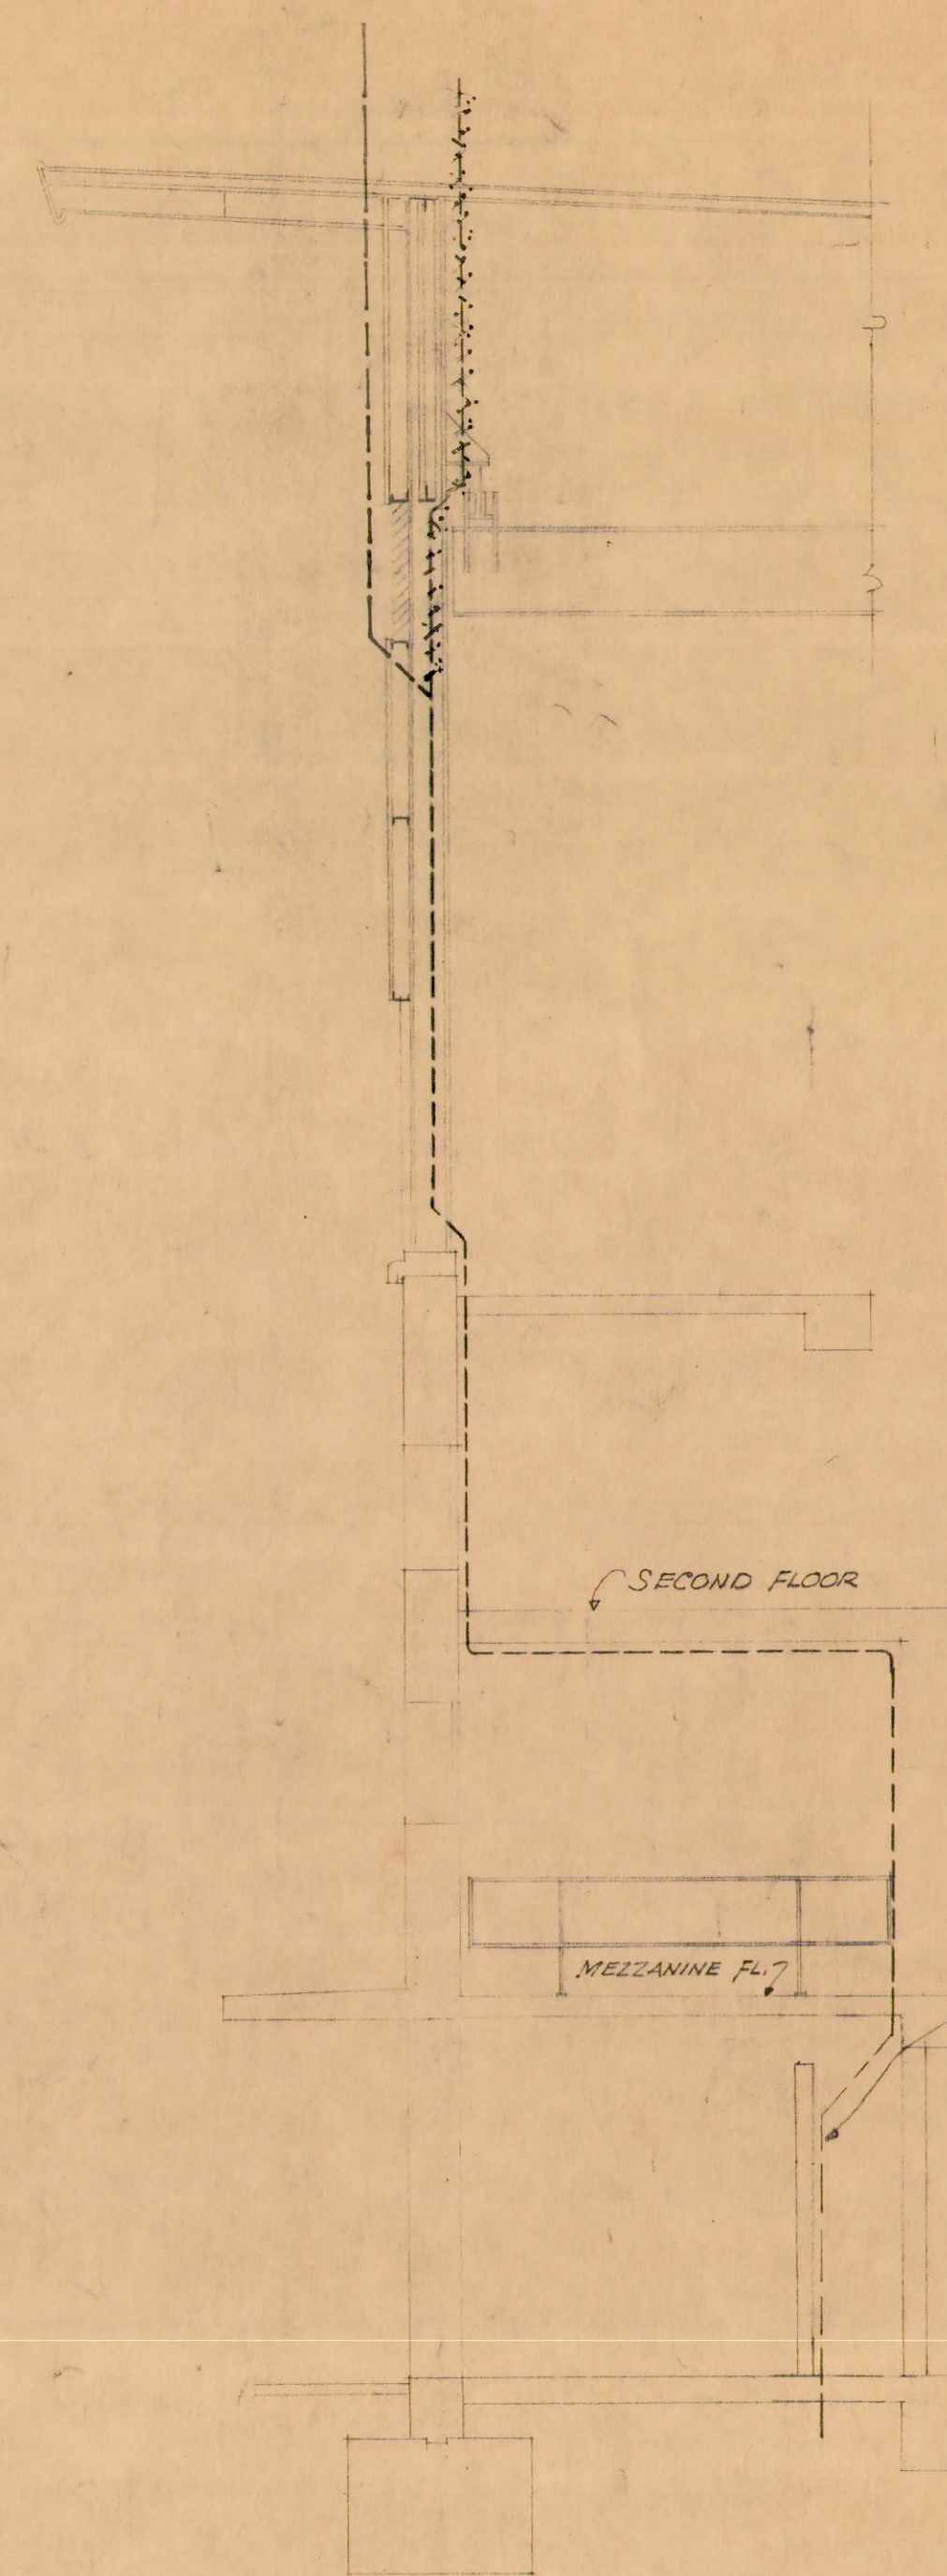


SECTION AT FRONT WALL

NOTE: LOCATION AND SIZES OF OPENINGS FOR VENT FANS REVISED. ADJUST PLUMBING CIRCUITS TO MEET REVISIONS.

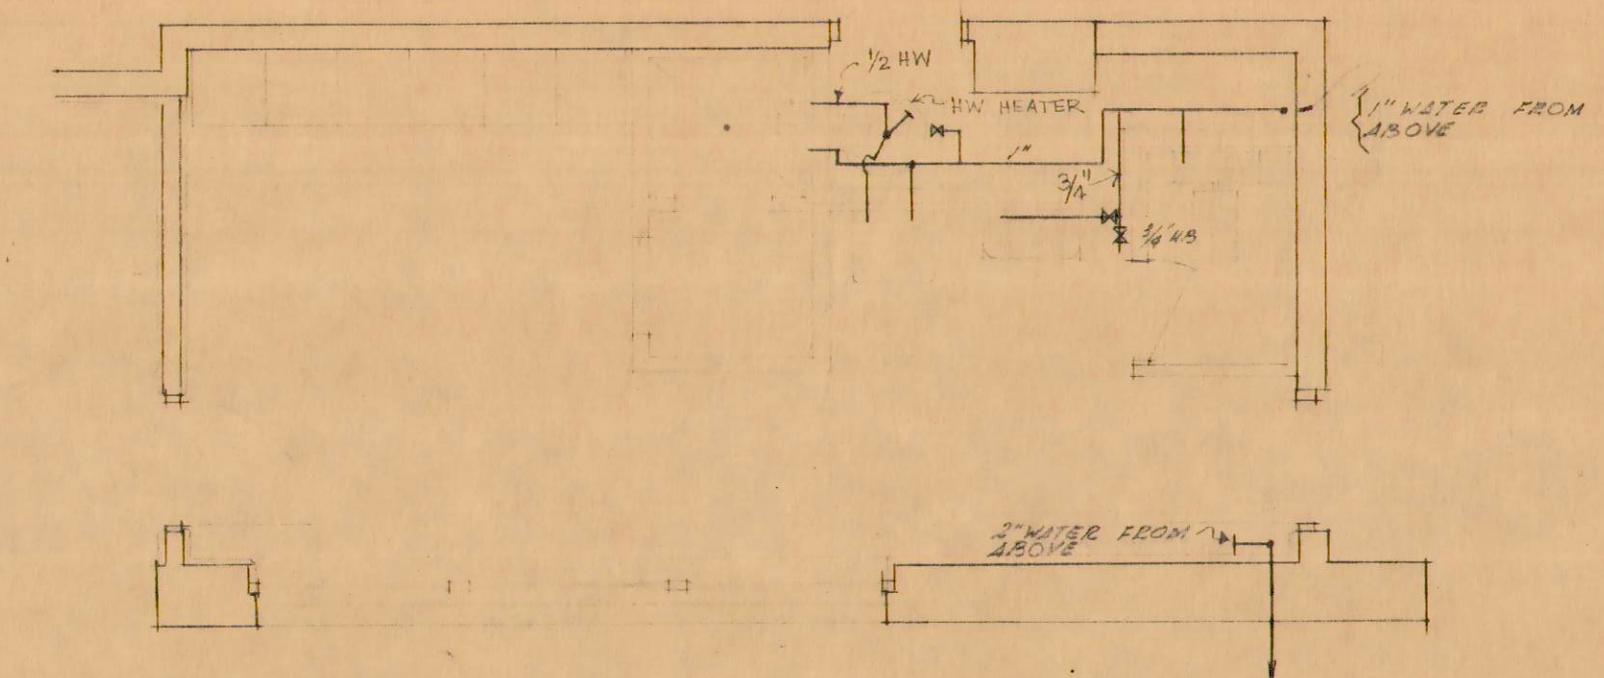

TOILET ROOM - WATER SUPPLY
SCALE: 1/4" = 1'-0"

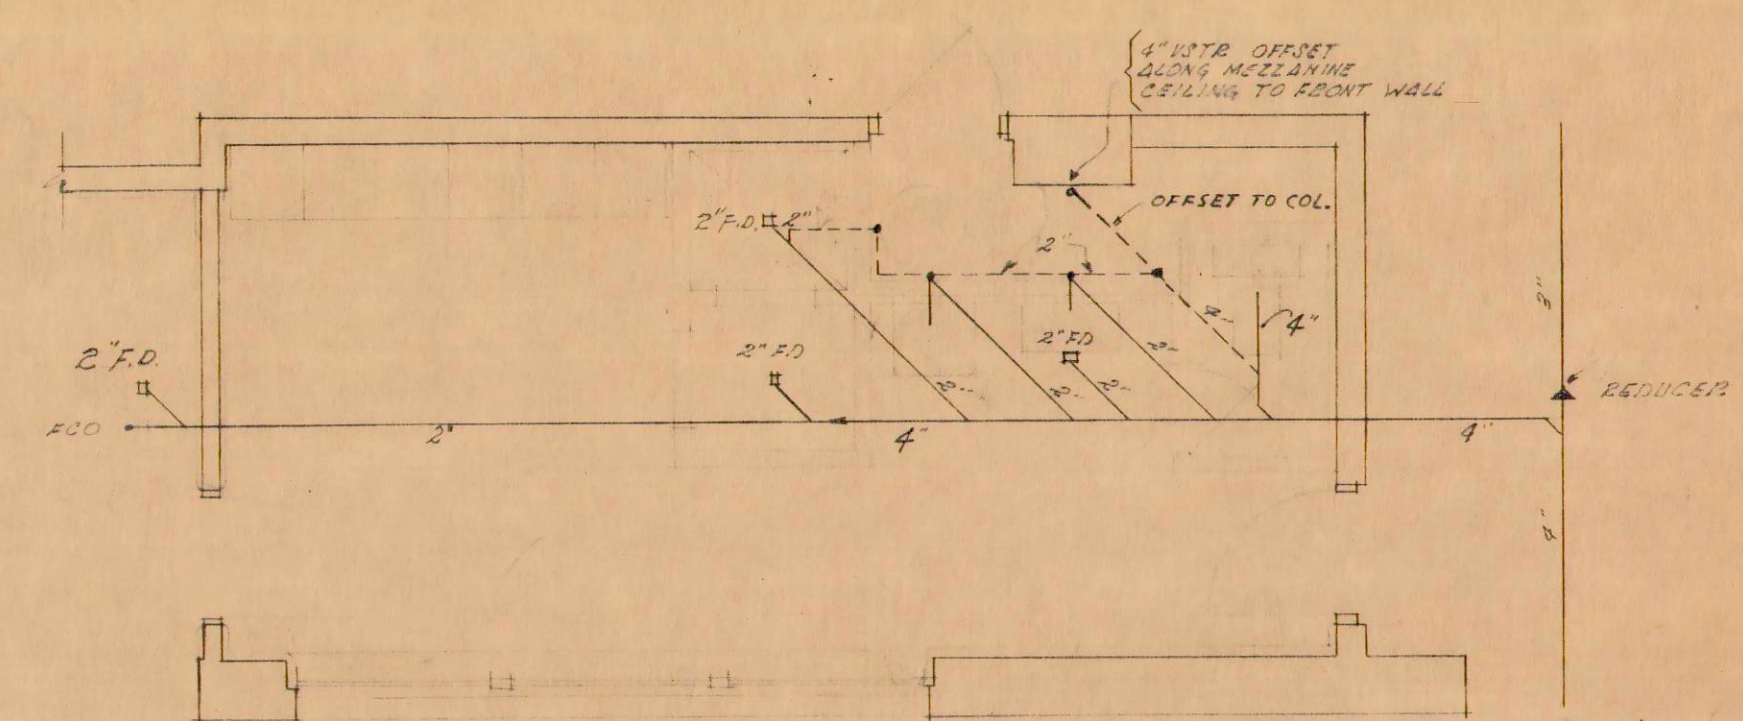

TOILET ROOM SANITARY SEWER
SCALE: 1/4" = 1'-0"

REVISION	DATE	DESCRIPTION	MADE BY	CHK BY
3	7-5-55	Relocate Vent	E. Miller	
2	7-20-56	RELOCATED 2" F.D.	H.M.	JO
1	4-16-56	SEE NOTE	E.V.	JO

LAW & WILSON
ARCHITECTS & ENGINEERS
DEPARTMENT OF PUBLIC WORKS
CITY AND COUNTY OF HONOLULU
BUREAU OF PLANS

KALIHI TUNNEL
VENTILATION BLDG. - PLUMBING
GROUND FLOOR PLAN & DETAILS

ENGINEER L.W. DATE JULY 18, 1955
DRAFTSMAN M.H. CHECKED BY E.V.
SCALE AS NOTED TRACER
APPROVED: *E. V. Miller* APPROVED: *H. B. Burtz*
CHIEF ENGINEER BUREAU ENGINEER

W.S.	PROFILE	C.B.
CR. SEC.	F.B.	S.B.
W.M.B.Y.	F.W.B.Y.	S.B.Y.

SECTION C JOB NO. 26-53 DWG. VB-42