


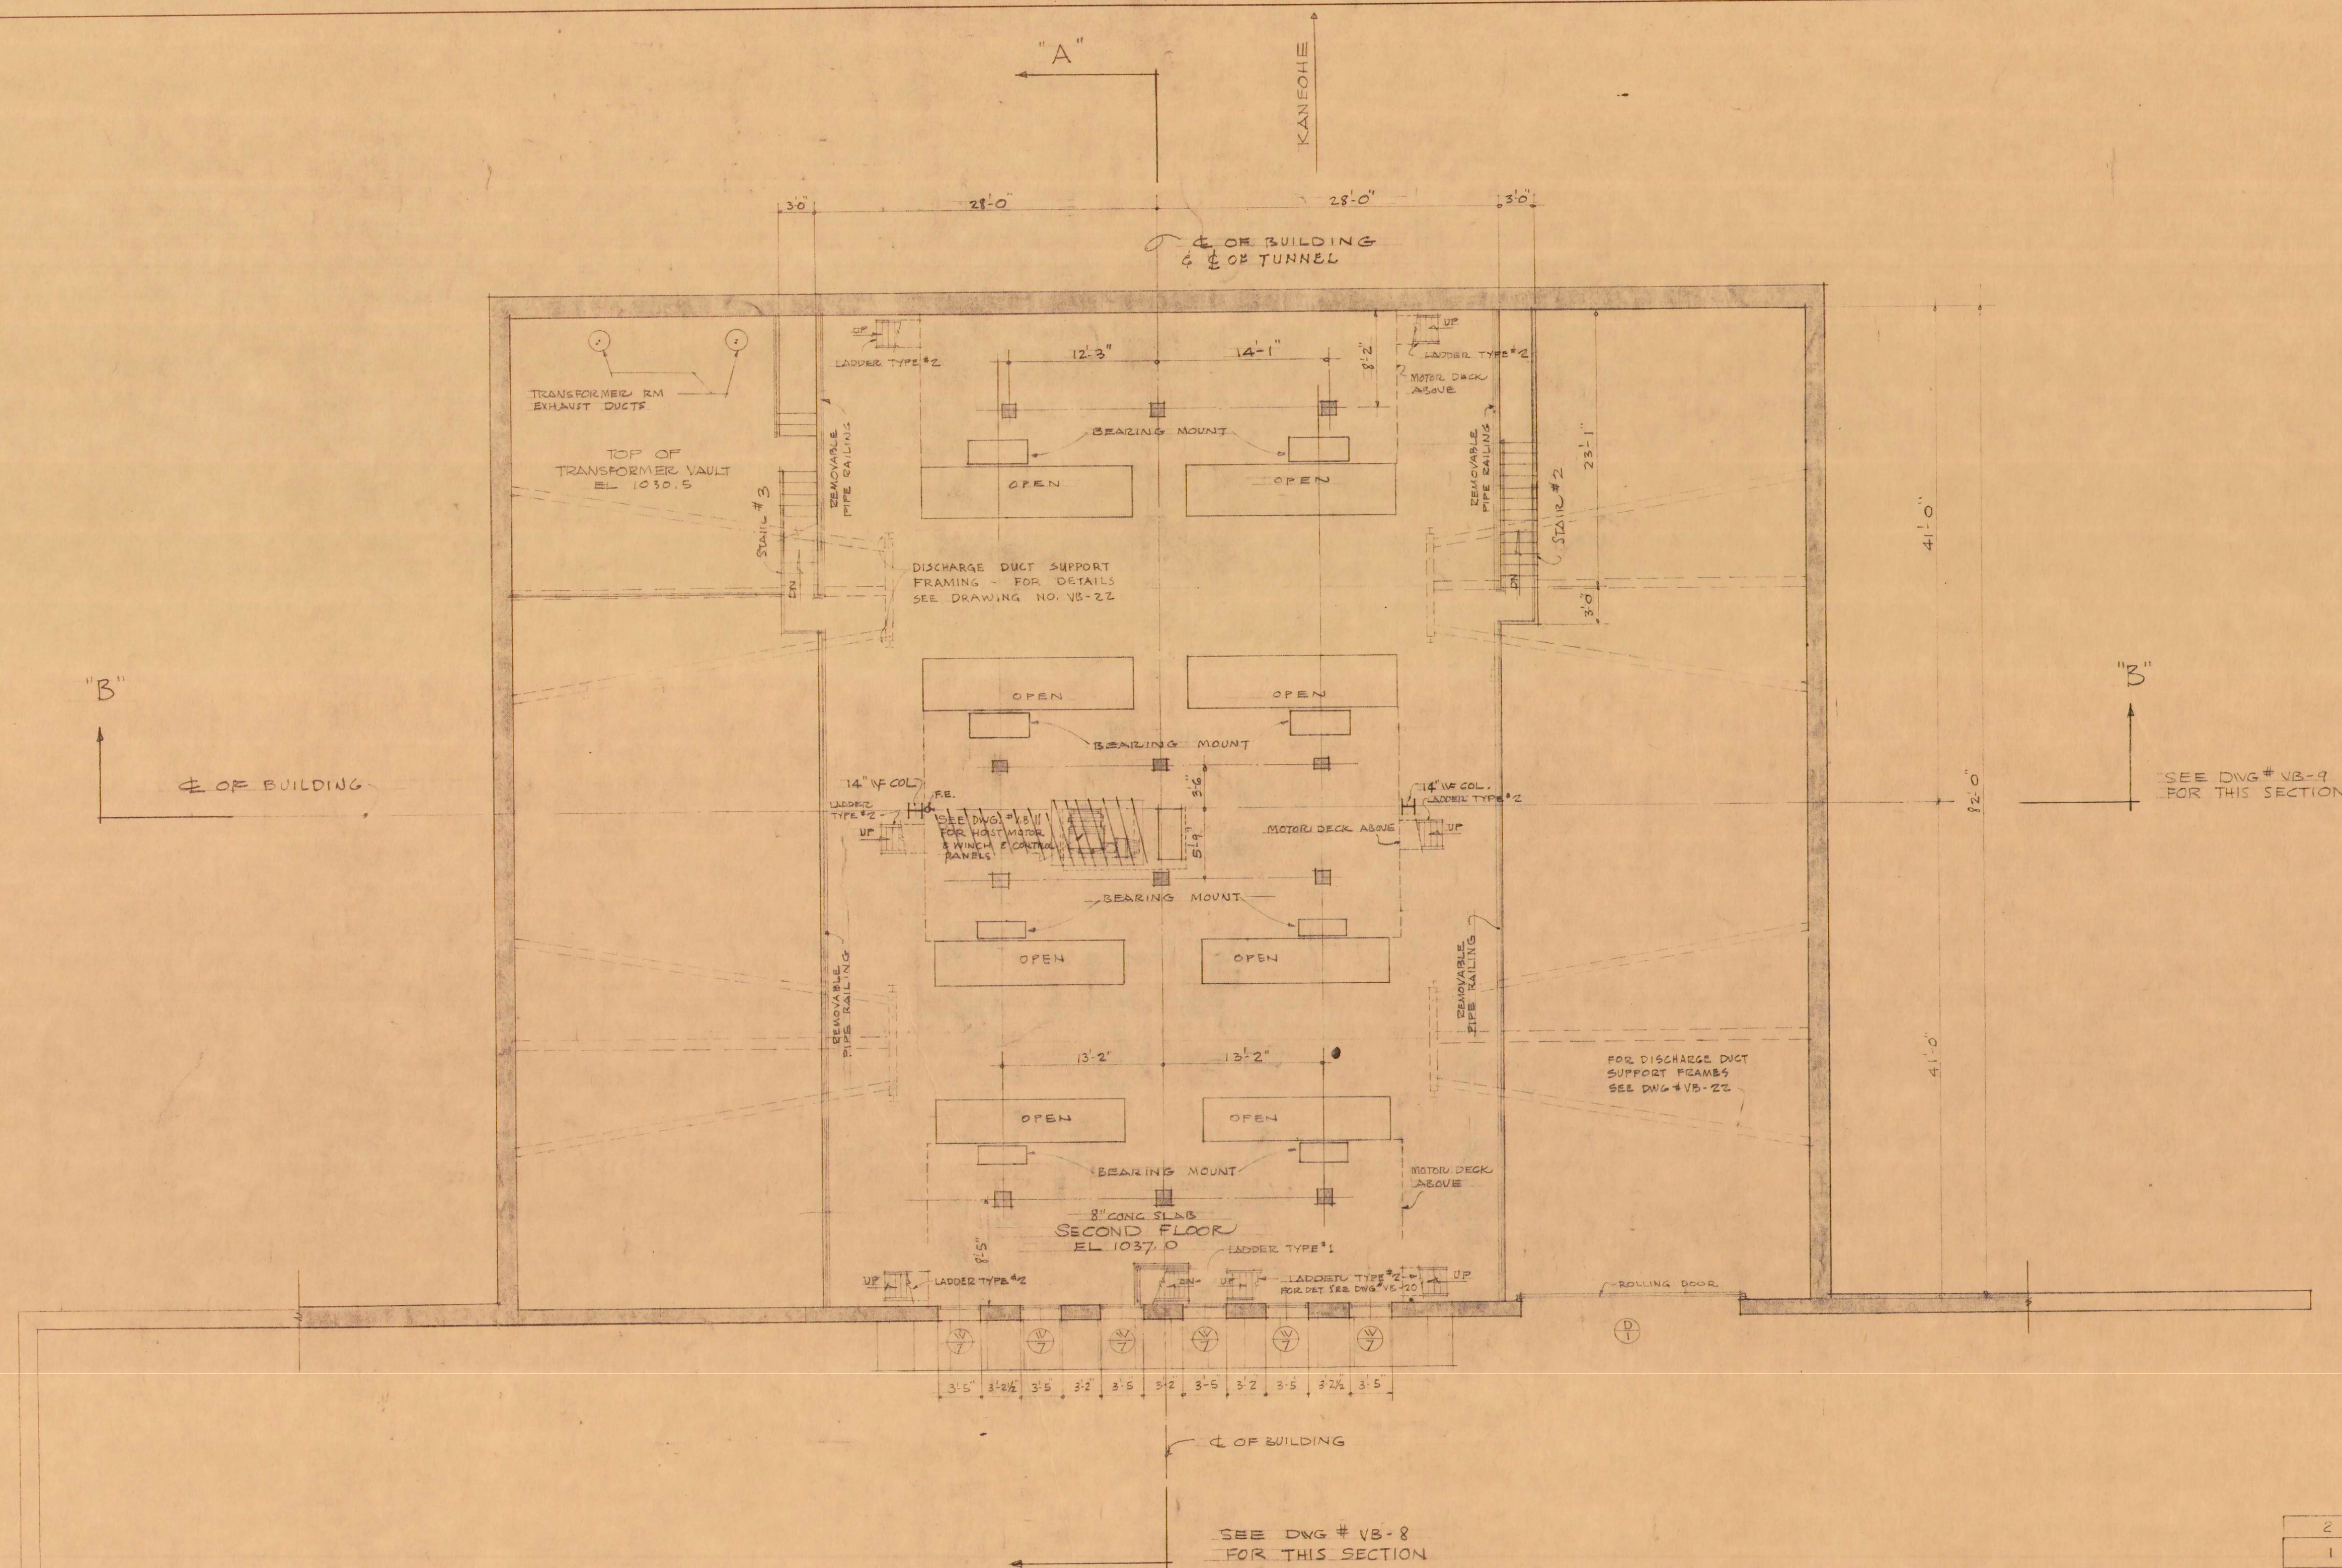

SECOND FLOOR PLAN

SCALE: $\frac{1}{8}'' = 1' - 0''$

NOTE: FOR DETAIL SEE DWG NO. VB-11

2	8-2-59	Delta Utility Hotel	W. Miller-	
1	4-16-58	RELOCATED OPENINGS & EQUIPMENT	E.M.	jo
REVISION	DATE	DESCRIPTION	MADE BY	CHK BY

LAW & WILSON
ARCHITECTS & ENGINEERS

DEPARTMENT OF PUBLIC WORKS
CITY AND COUNTY OF HONOLULU

BUREAU OF PLANS
KALIHI TUNNEL
VENTILATION BLDG.
SECOND FLOOR PLAN

ENGINEER: L.A.W. DATE: JULY 15, 1959
DRAFTSMAN: P.K. CHECKED BY: R.E. [Signature]
SCALE: $\frac{1}{8}'' = 1' - 0''$ TRACER:
APPROVED: [Signature] L. J. Jannetty, Jr. CHIEF ENGINEER
BUREAU ENGINEER

APPROVED: [Signature] R. E. [Signature]
ENGINEER, KALIHI TUNNEL

SECTION C

JOB NO. 26-53

DWG. VB-4