
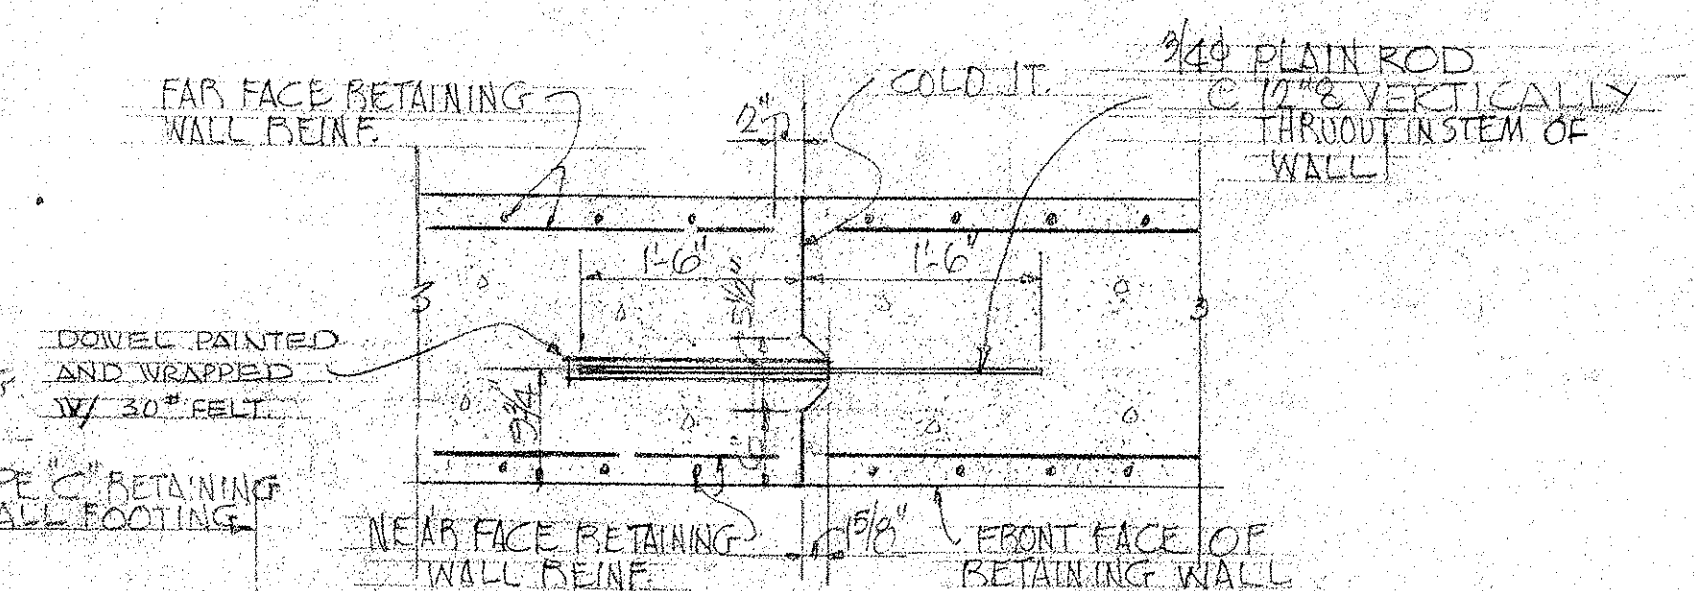
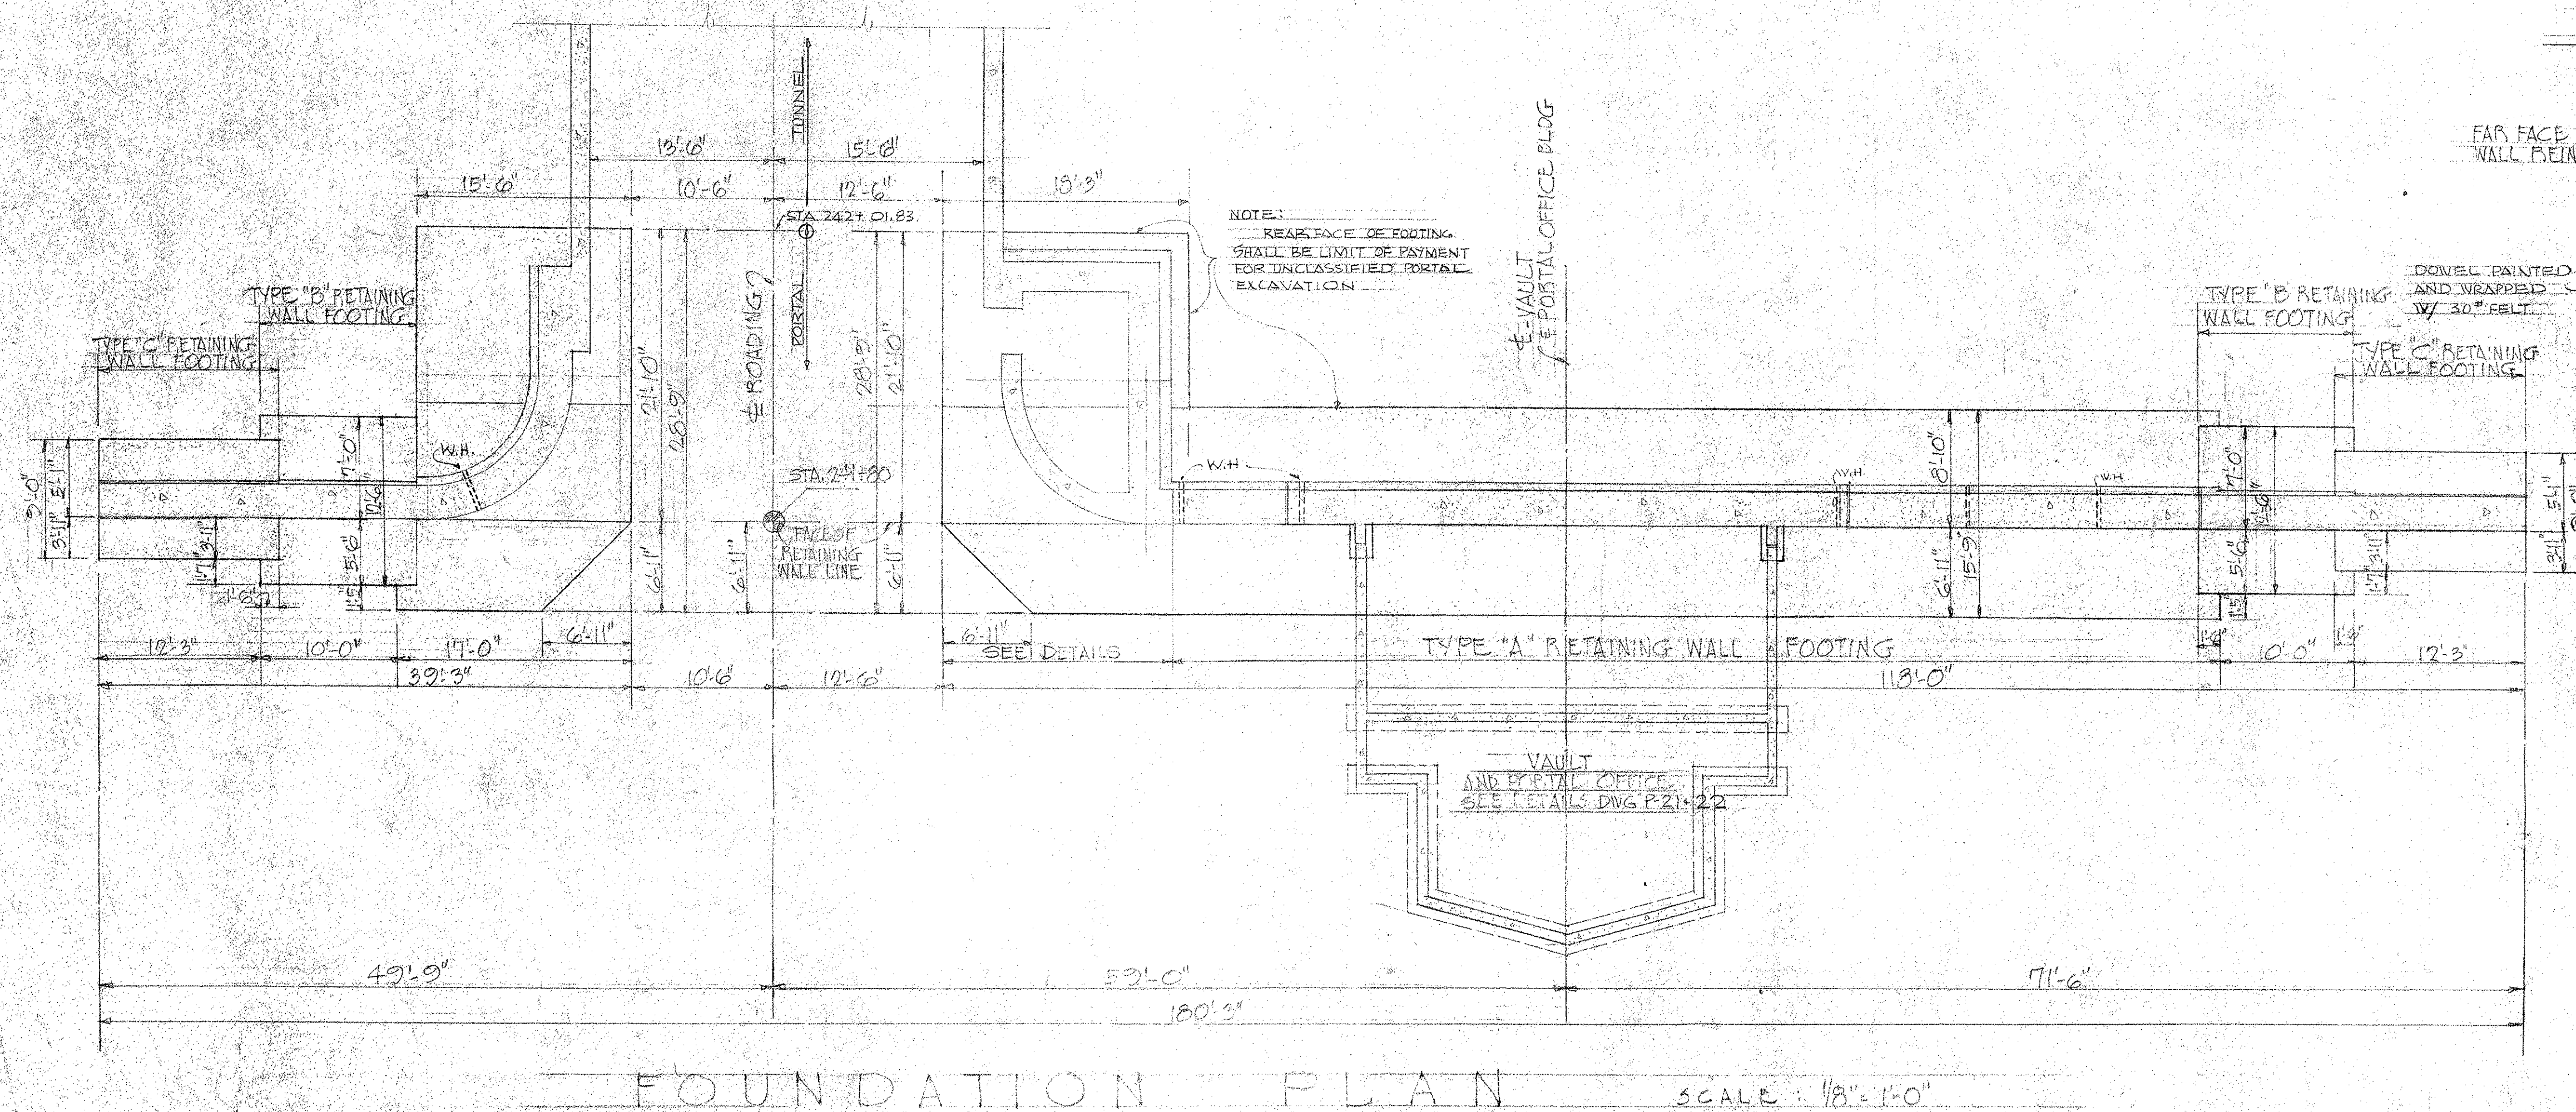
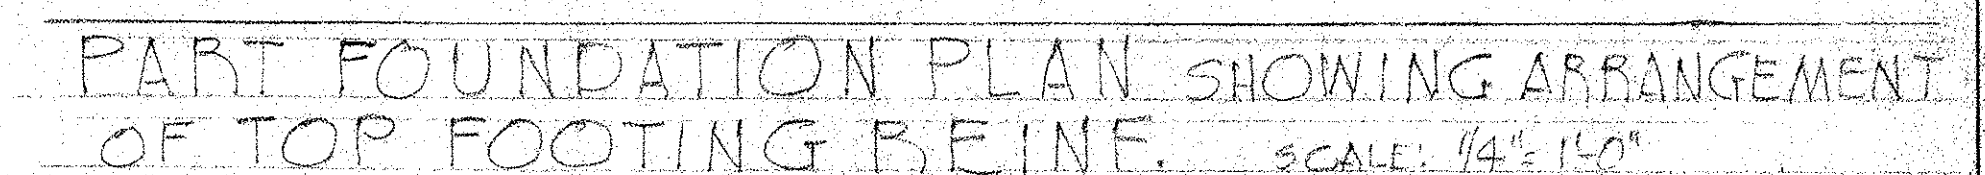


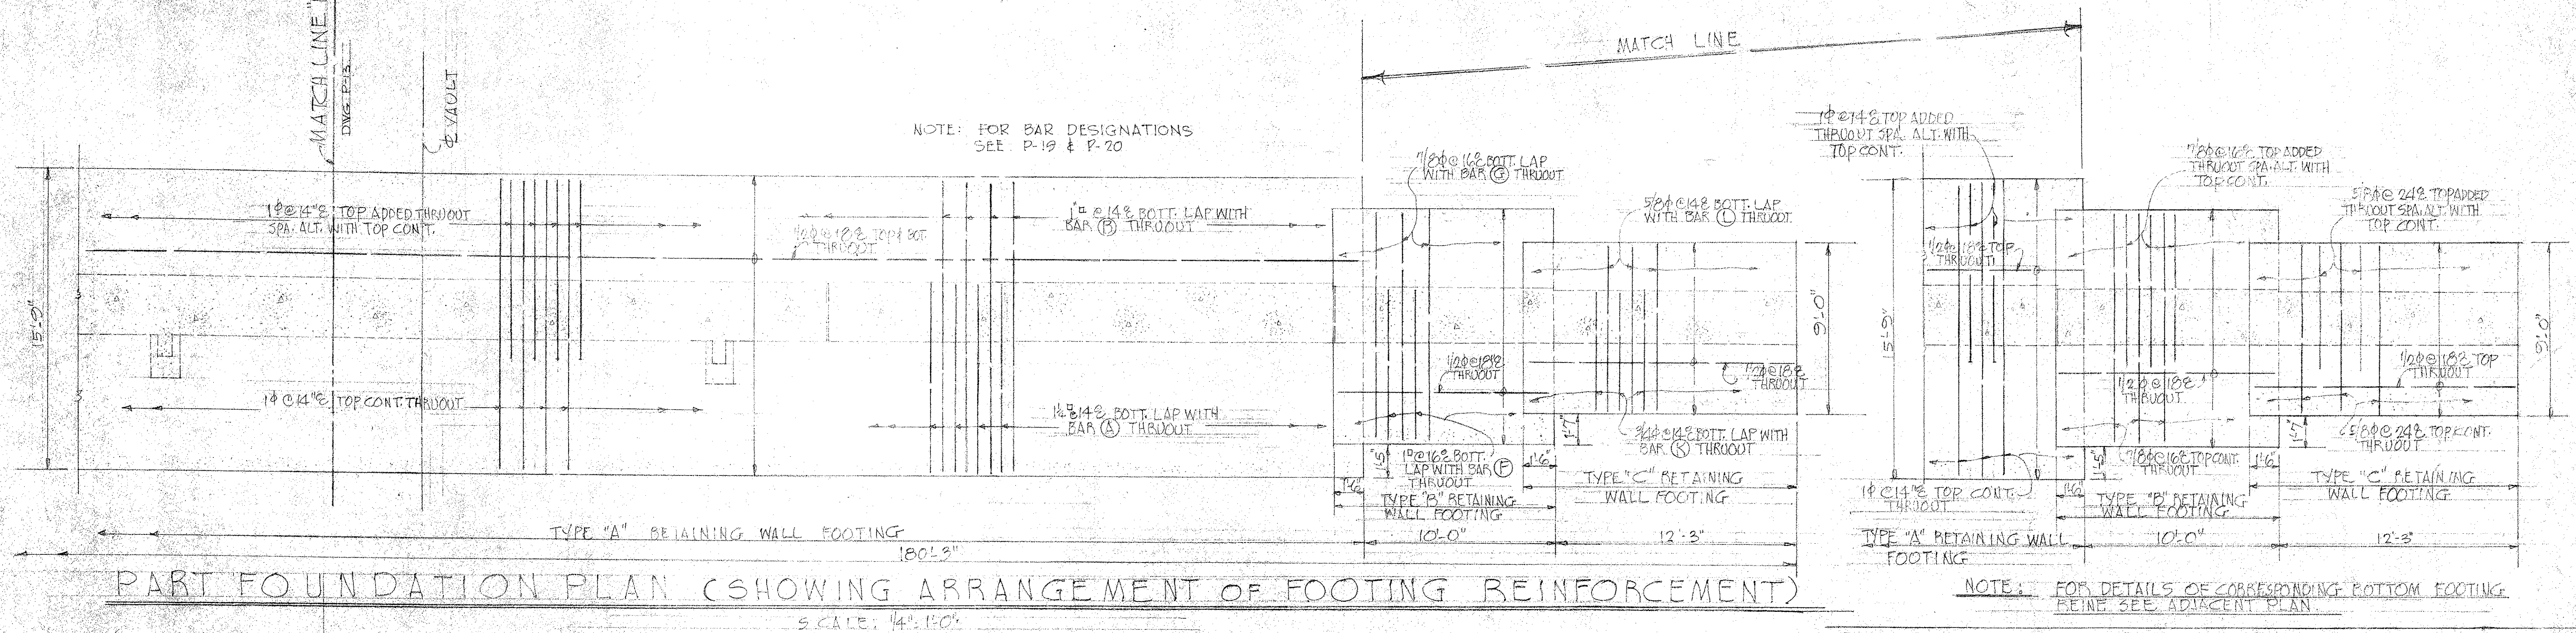

CONTRACTION JOINT

TYPICAL VERTICAL RETAINING WALL
JOINT DETAILS - SCALE: 3/4"=1'-0"

LAW & WILSON ARCHITECTS & ENGINEERS	
DEPARTMENT OF PUBLIC WORKS CITY AND COUNTY OF HONOLULU	
BUREAU OF PLANS	
KALIHI TUNNEL	
KALIHI PORTAL - STRUCTURAL FOUNDATION PLAN	
ENGINEER <u>L. B. W.</u> DRAFTSMAN <u>D. LO</u> SCALE <u>AS NOTED</u>	DATE <u>JULY 15, 1952</u> CHECKED BY <u>[Signature]</u> TRACER <u>J. L.</u>
APPROVED <u>[Signature]</u> CHIEF ENGINEER	APPROVED <u>[Signature]</u> BUREAU ENGINEER

APPROVED: 
ENGINEER, KALIHI TUNNEL

SECTION C

JOB NO. 26-53

DWG P-12

