


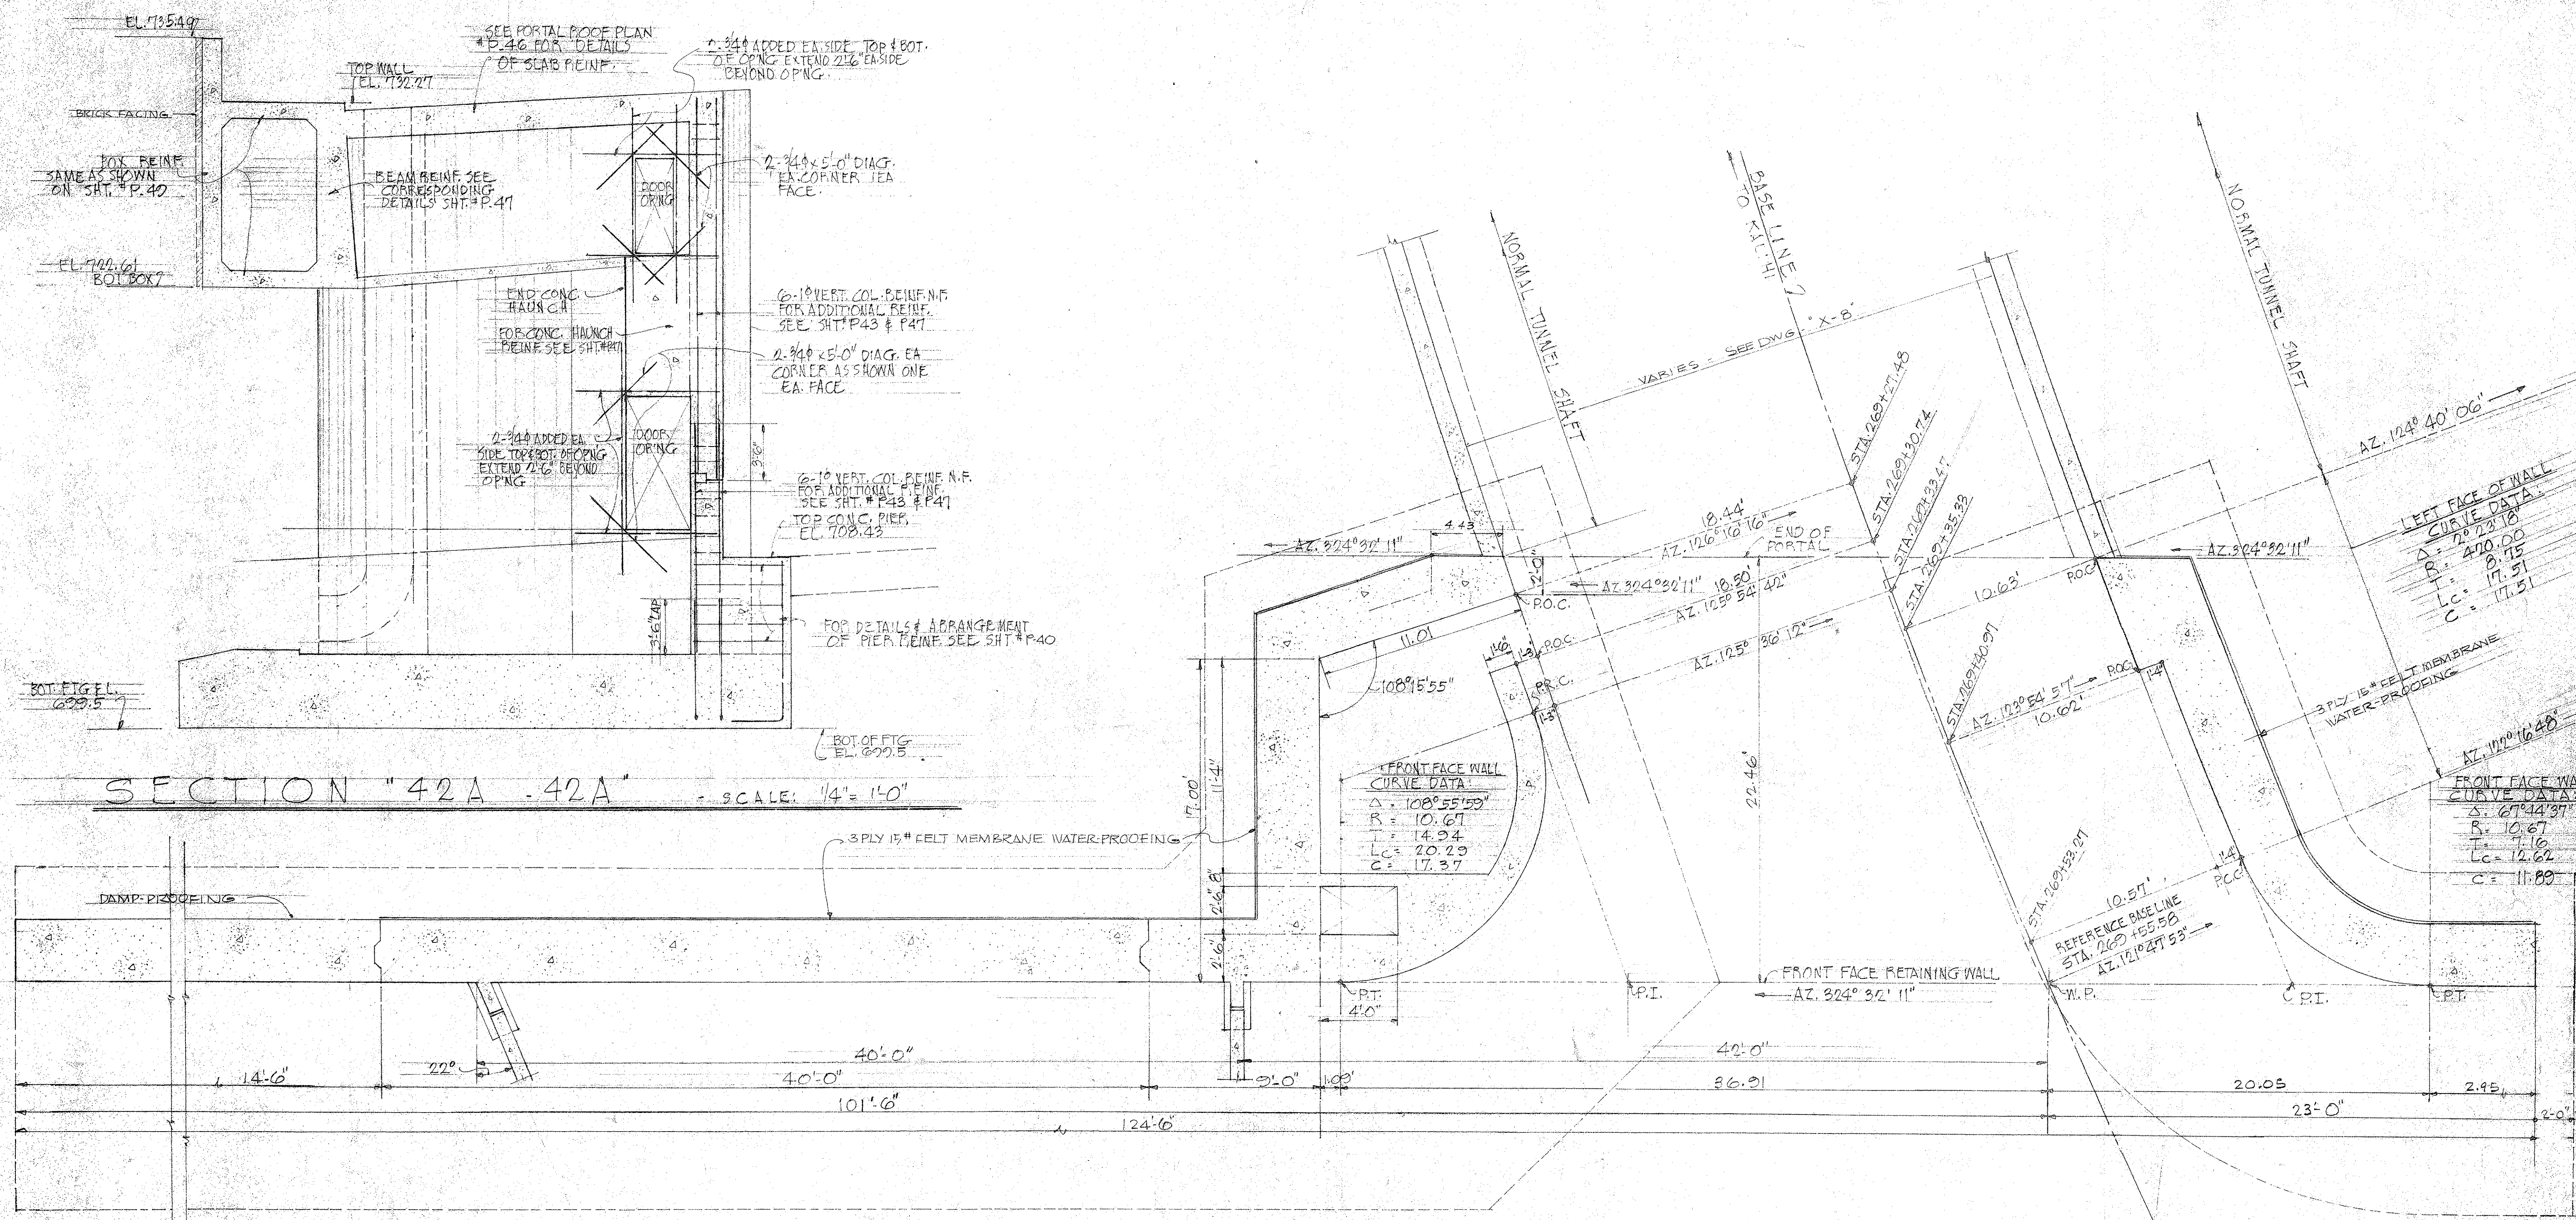

KANEOHE PORTAL WALL DATA PLAN (AT ROADWAY LEVEL)

SCALE: 1/4" = 1'-0"

LAW & WILSON
ARCHITECTS & ENGINEERS
DEPARTMENT OF PUBLIC WORKS
CITY AND COUNTY OF HONOLULU
BUREAU OF PLANS
KALIHU TUNNEL
KANEOHE PORTAL-STRUCTURAL
PLAN AT ROADWAY

ENGINEER: L. B. W. / D. L. DATE: JULY 15, 1953
DRAFTSMAN: J. Y. L. CHECKED BY: J. L. H. / J. P. B.
SCALE: 1/4" = 1'-0" TRACER:
APPROVED: *[Signature]* APPROVED: *[Signature]*
CHIEF ENGINEER BUREAU ENGINEER

APPROVED
[Signature]
ENGINEER, KALIHU TUNNEL

SECTION C JOB NO. 26-53 DWG. P-42