


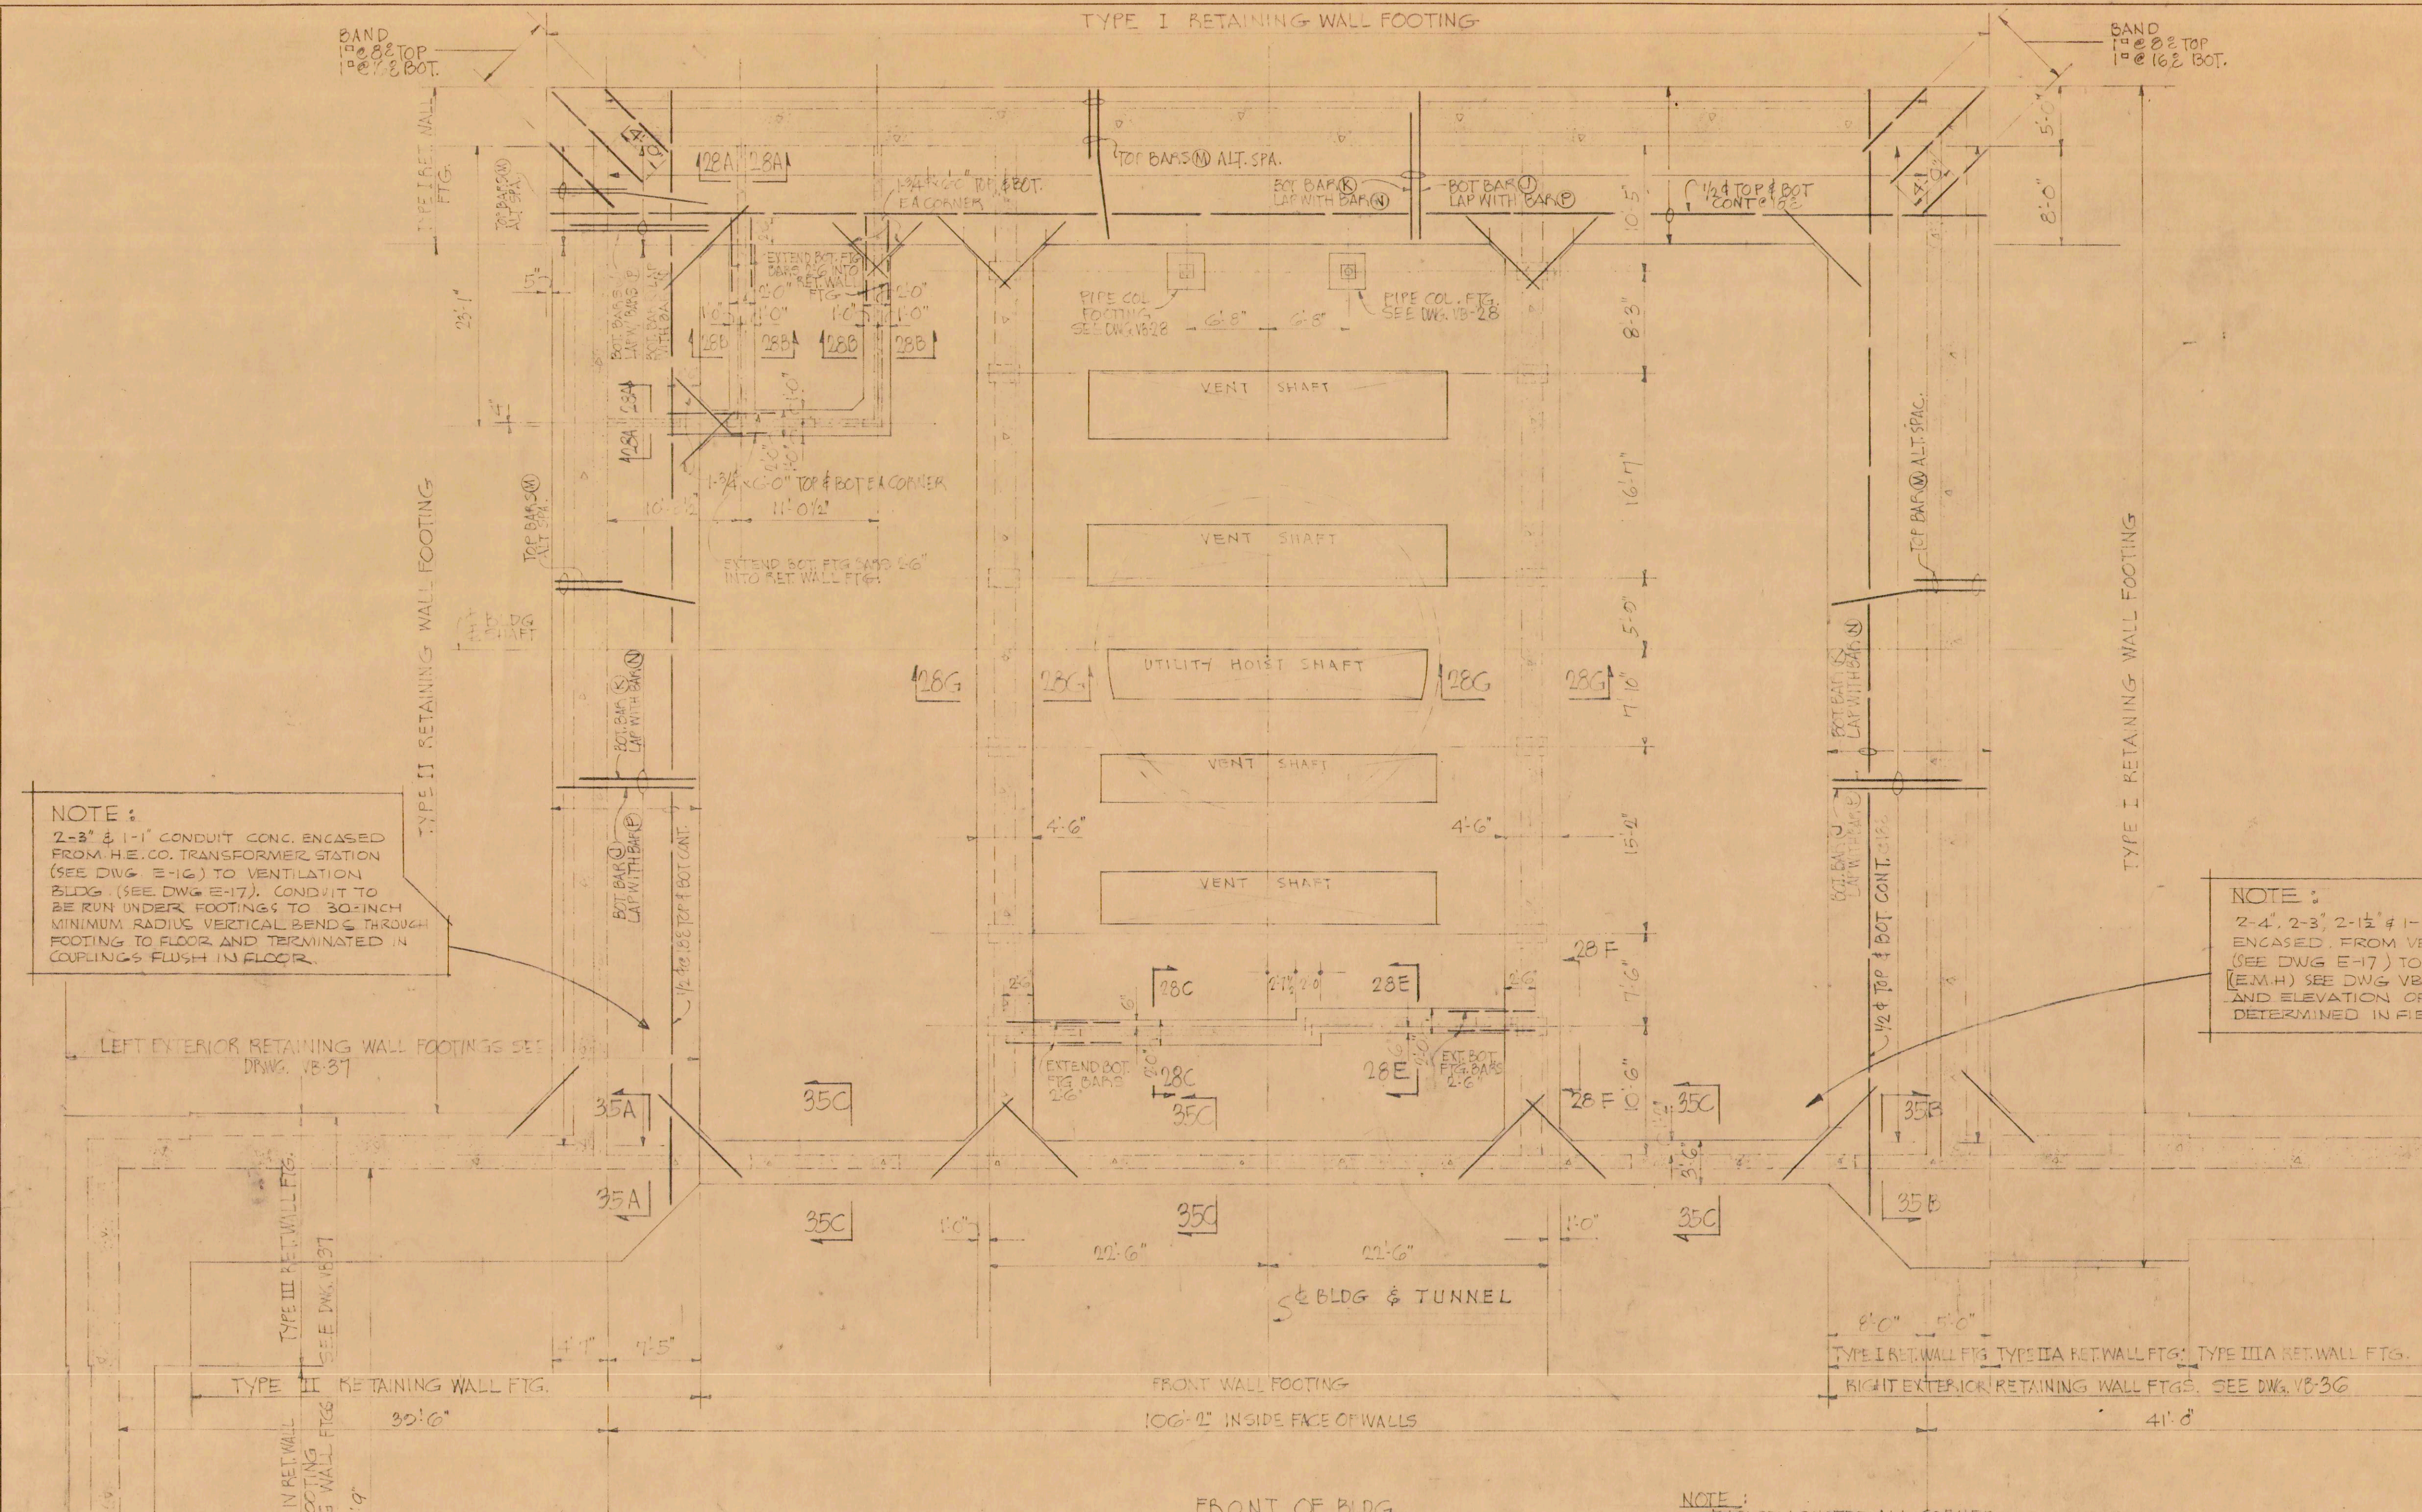

FOUNDATION PLAN SCALE: 1/8"=1'-0"

1	4-16-56	RELOCATED OPENINGS & EQUIPMENT	E.V.	90
REVISION	DATE	DESCRIPTION	MADE BY	CNR-07

LAW & WILSON
ARCHITECTS & ENGINEERS
DEPARTMENT OF PUBLIC WORKS
CITY AND COUNTY OF HONOLULU
BUREAU OF PLANS
KALIHI TUNNEL
VENTILATION BLDG.-STRUCTURAL
FOUNDATION PLAN

ENGINEER: L.A.W./D.L. DATE: JULY 12, 1956
DRAFTSMAN: F.C. CHECKED BY: D.L.
SCALE: 1/8"=1'-0" TRACER:
APPROVED: *[Signature]* SUPERVISOR:
CHIEF ENGINEER

W.S. PROFILE C.B.
CR. SEC. P.S.
W.M. BY. F.W. BY. S.B.Y.

SECTION C JOB NO. 26-53 DWG. VB-26