




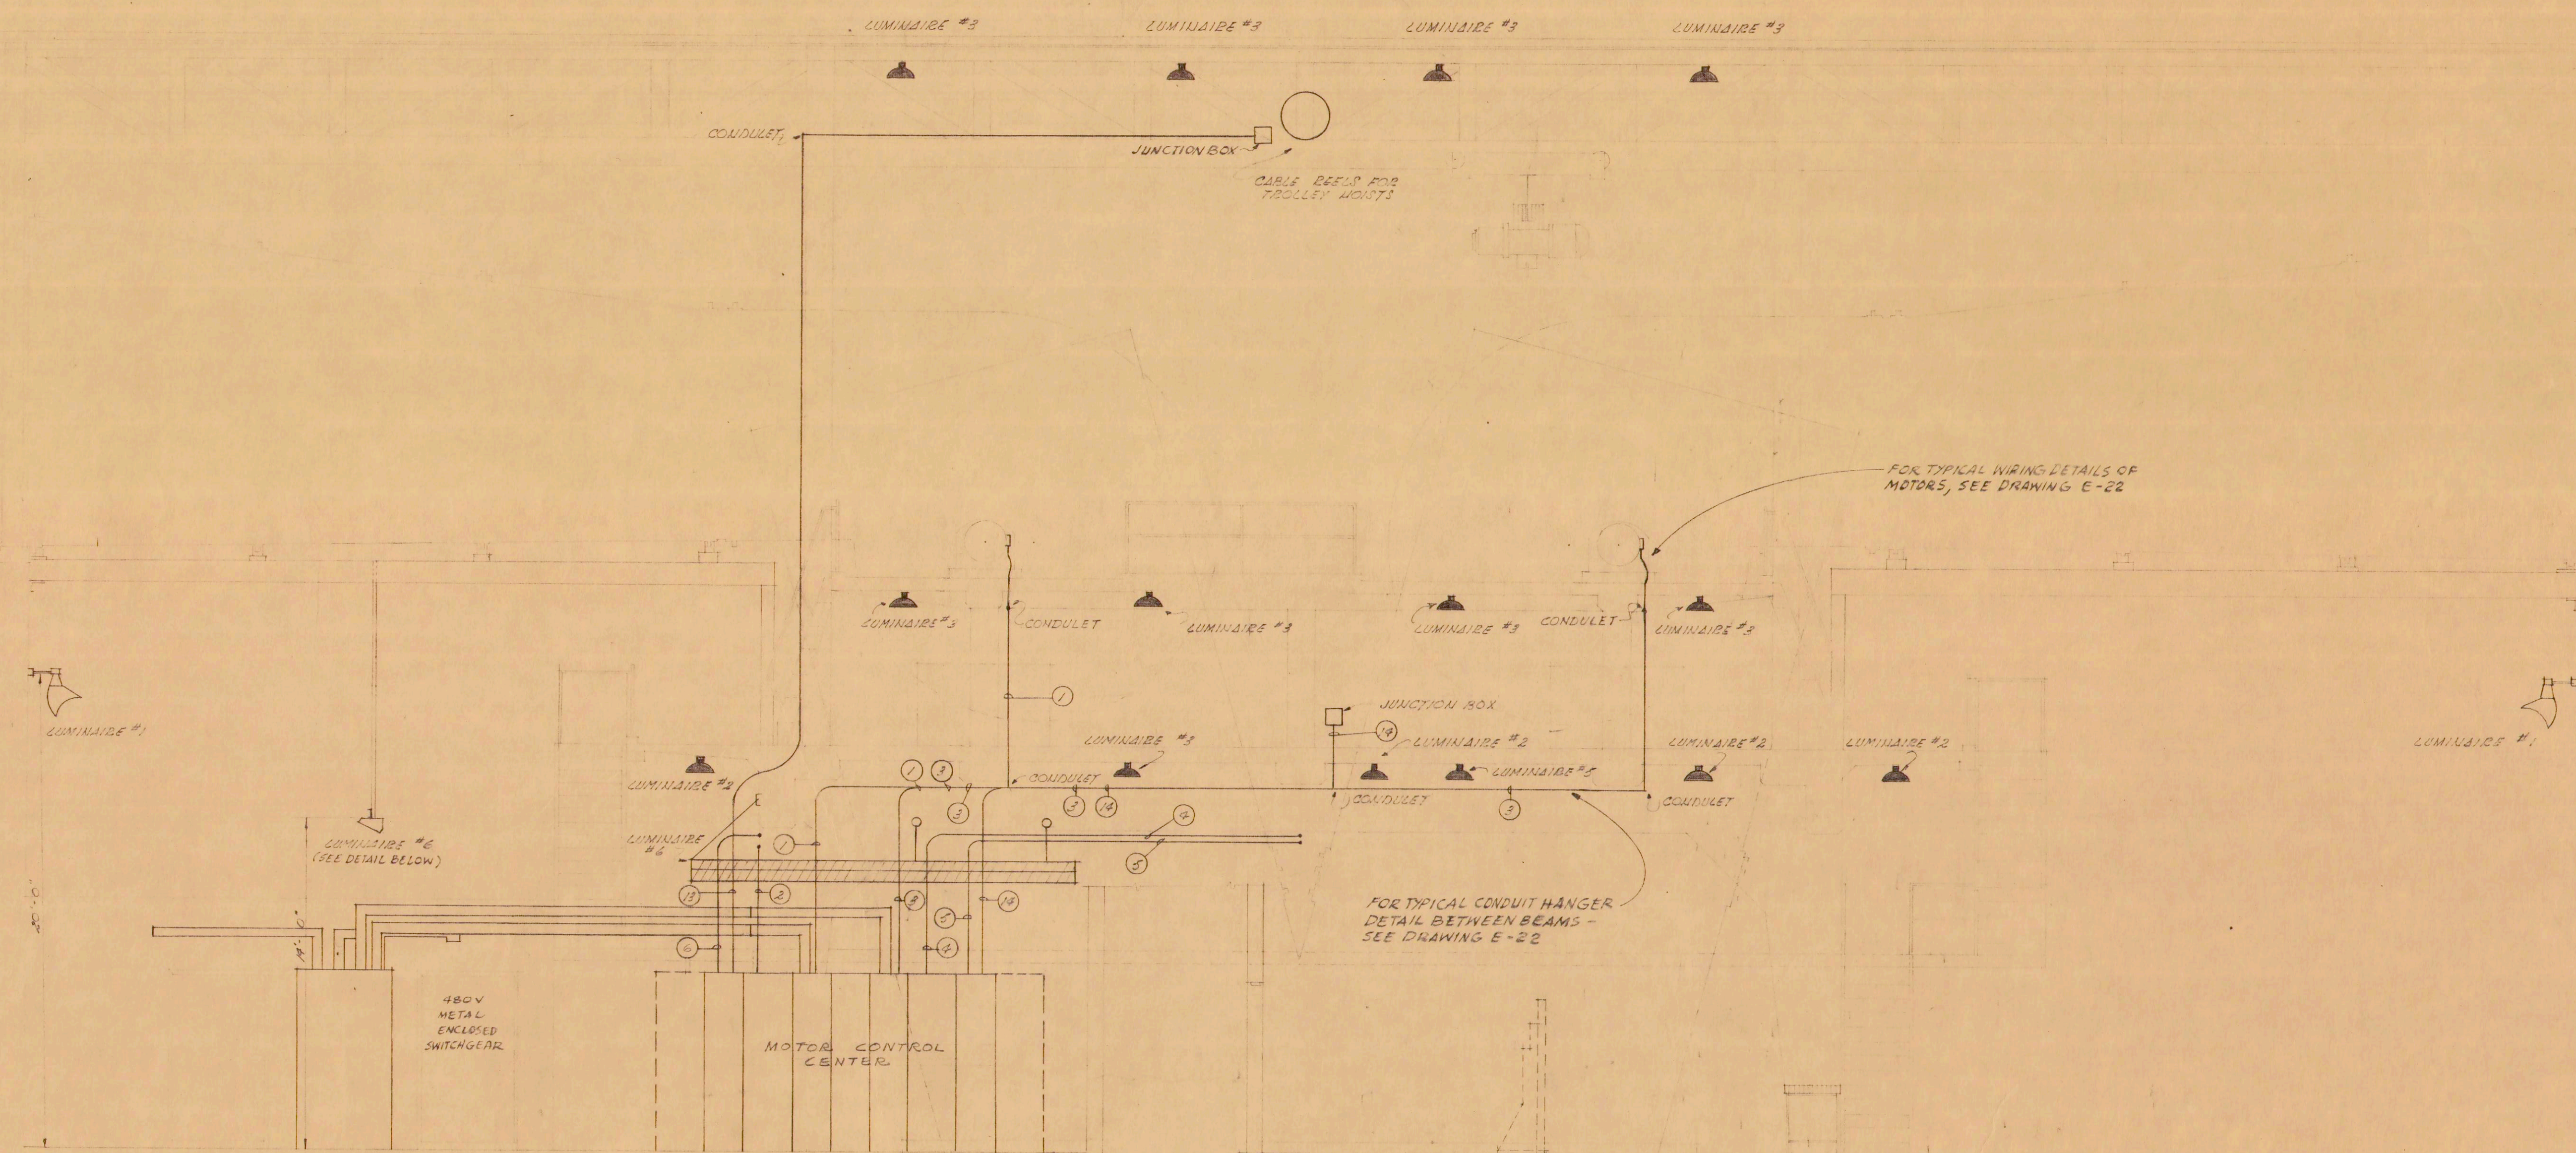

CONDUITS FOR KALIHI END MOTOR BRANCH CIRCUITS, NOT SHOWN ON THIS DRAWING.

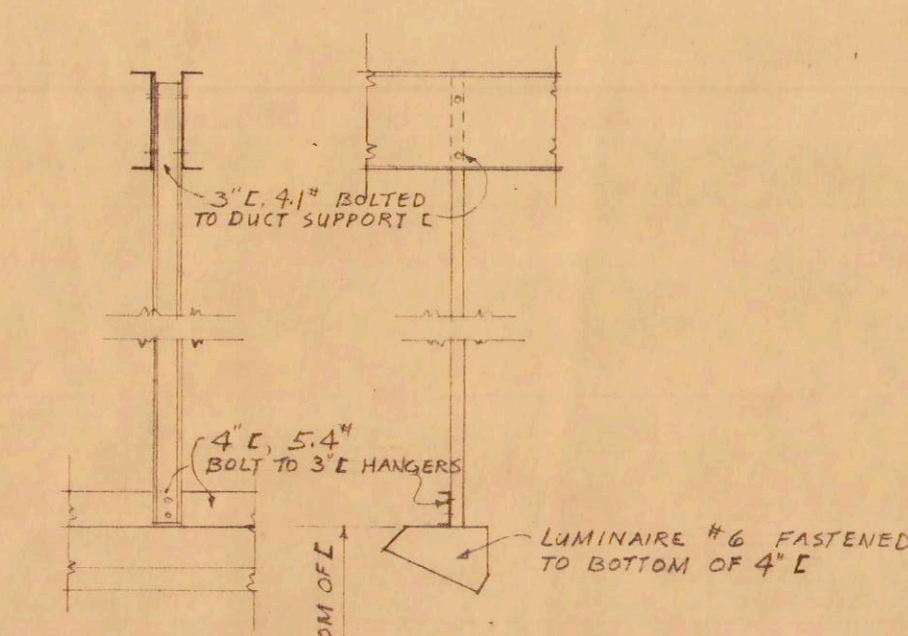

SIDE ELEVATION
SCALE: 1/2" = 1'-0"

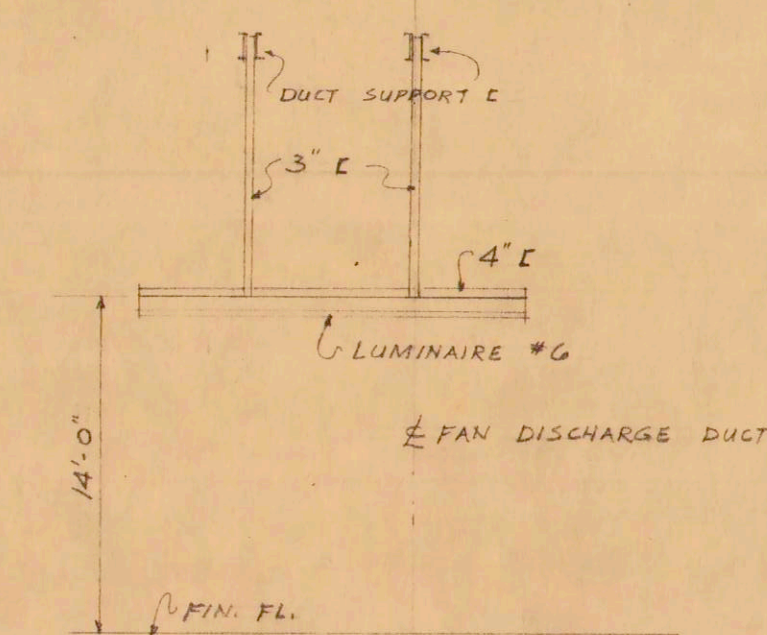

FRONT ELEVATION
SCALE: 1/8" = 1'-0"

END ELEVATION

SUPPORT FOR LUMINAIRE NO 6

NOTE: LOCATION AND SIZES OF OPENINGS FOR VENT FANS REVISED. ADJUST ELECTRICAL CIRCUITS TO MEET REVISIONS.

REVISION	DATE	DESCRIPTION	MADE BY	CHK BY
1	4-16-53	SEE NOTE	E.W.	90

LAW & WILSON
ARCHITECTS & ENGINEERS

DEPARTMENT OF PUBLIC WORKS
CITY AND COUNTY OF HONOLULU
BUREAU OF PLANS

KALIHI TUNNEL
ELECTRICAL-VENT. BLDG.
LUMINAIRE LOCATION & CONDUIT ROUTING
LONGITUDINAL SECTION

ENGINEER: L.W. DATE: JULY 15, 1953
DRAFTSMAN: M.H. CHECKED BY: J.S.
SCALE: 1/4" = 1'-0" TRACER: J.H.
APPROVED: [Signature] APPROVED: [Signature]
CHIEF ENGINEER BUREAU ENGINEER

APPROVED
[Signature]
ENGINEER, KALIHI TUNNEL

SECTION C JOB NO. 26-53 DWG. E-19

FILE	POCKET	FOLDER	NO.
7	6	3	23