




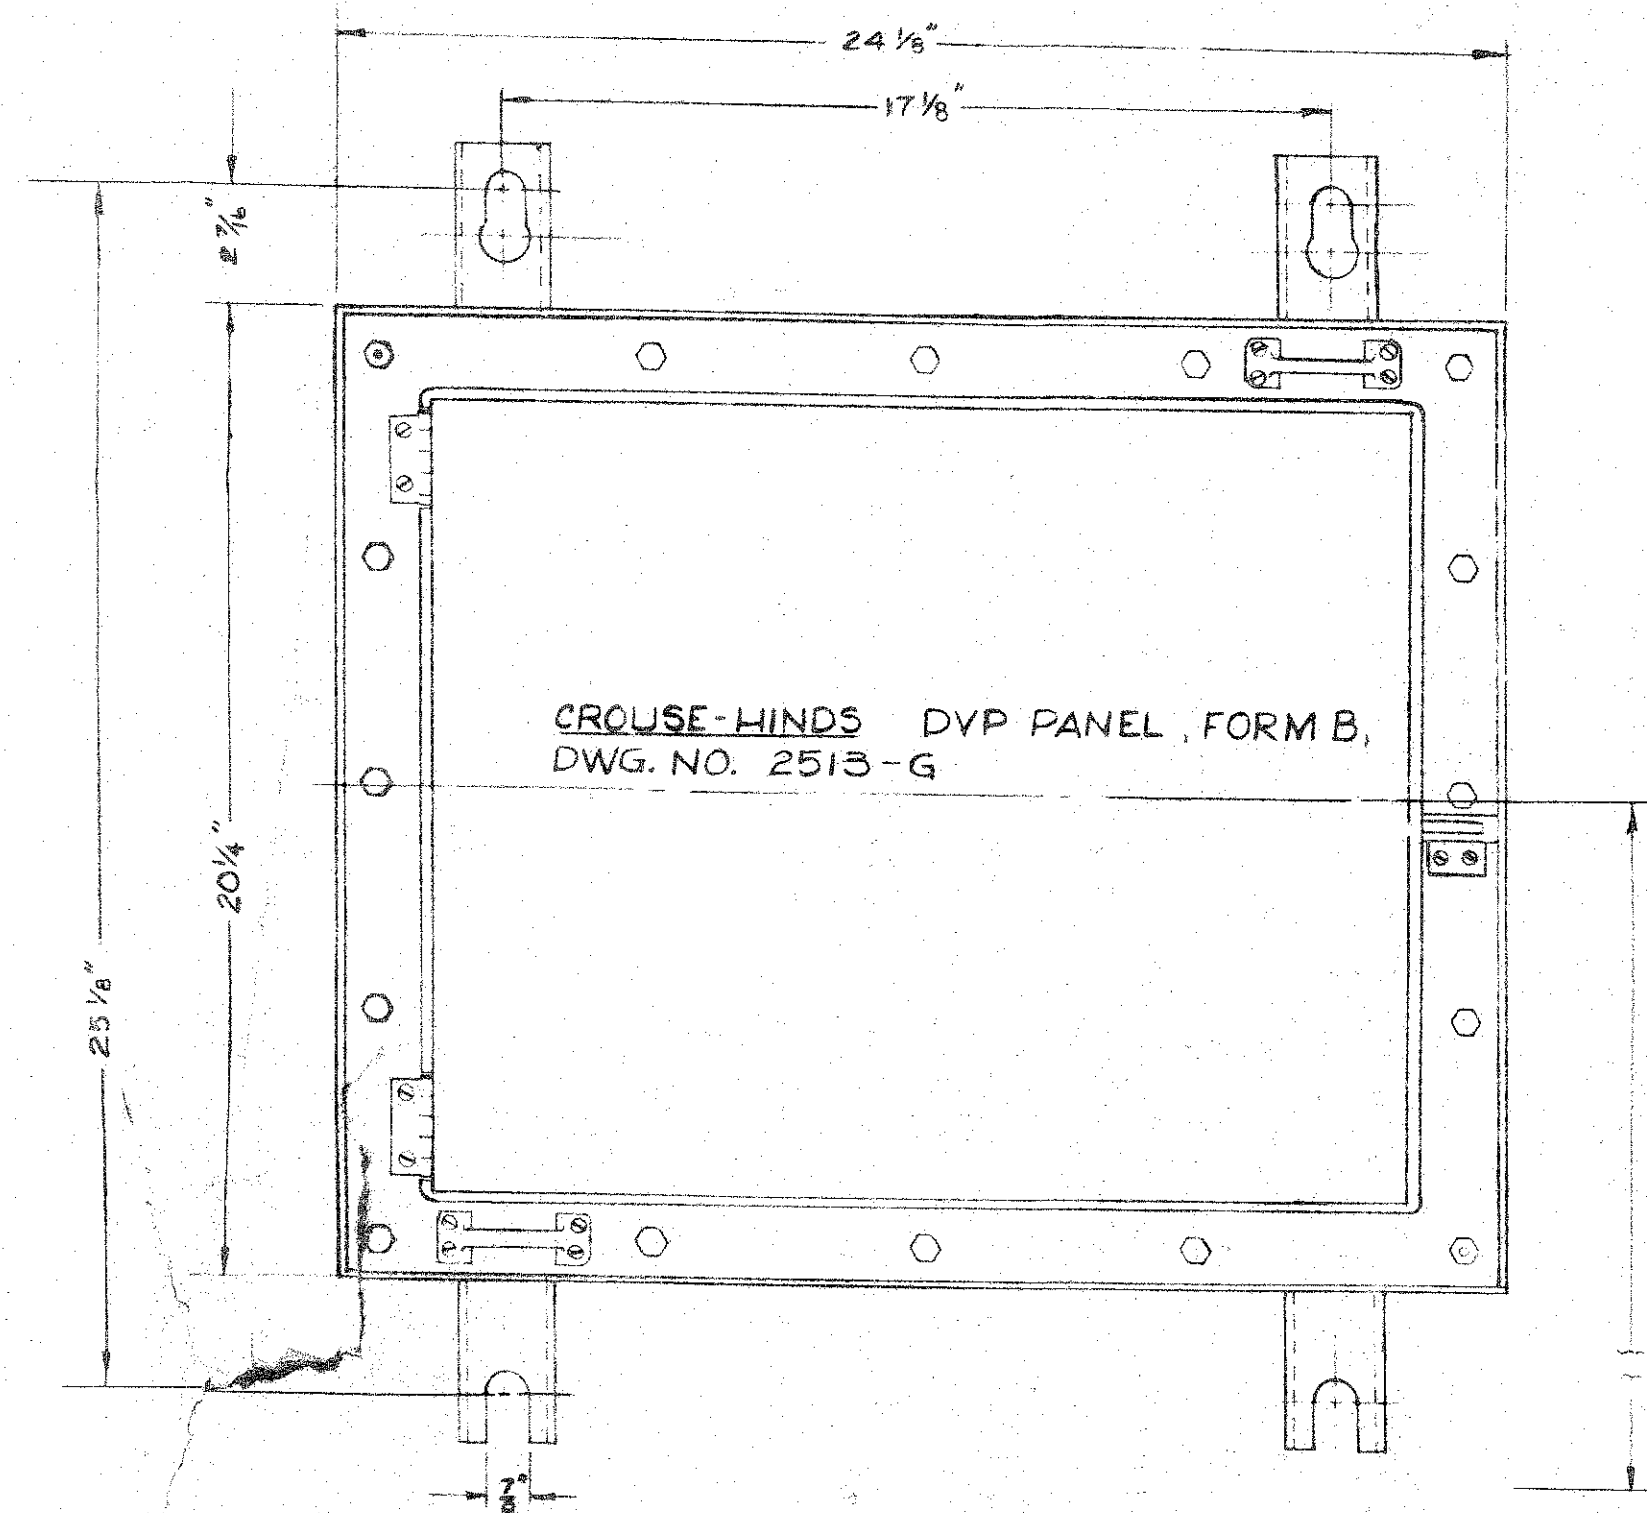


— FRONT ELEVATION OF LIGHTING PANEL —

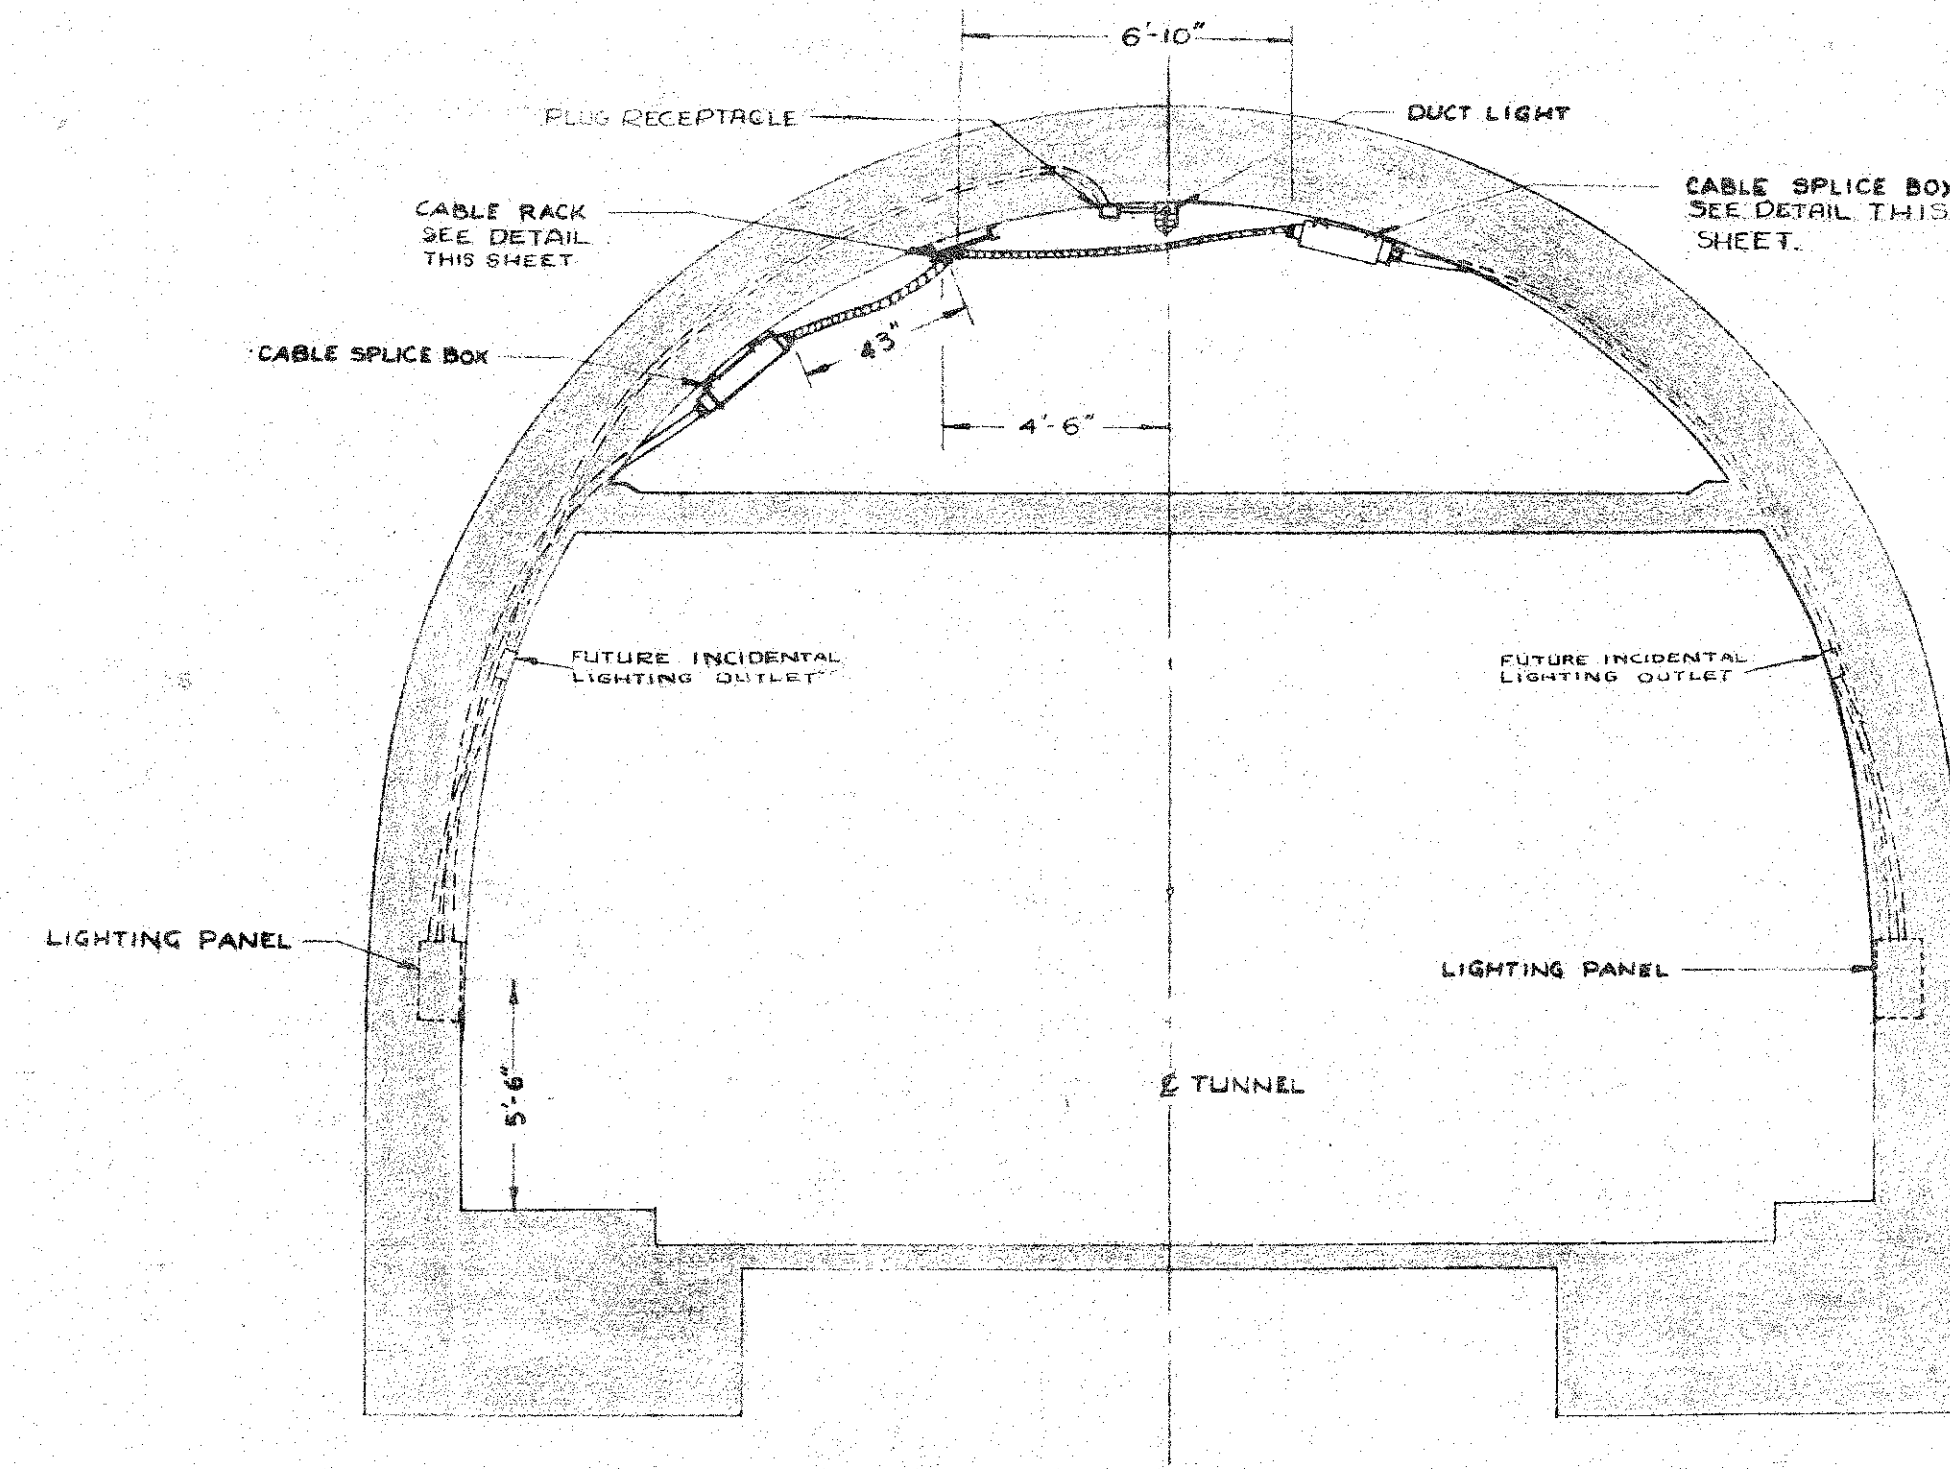


— TYPICAL ARRANGEMENT OF SPLICE BOXES,
CABLE RACK, CABLES & LIGHTING PANELS. —
SCALE 1/4" = 1'-0"
(TOWARD KANEOLHE)

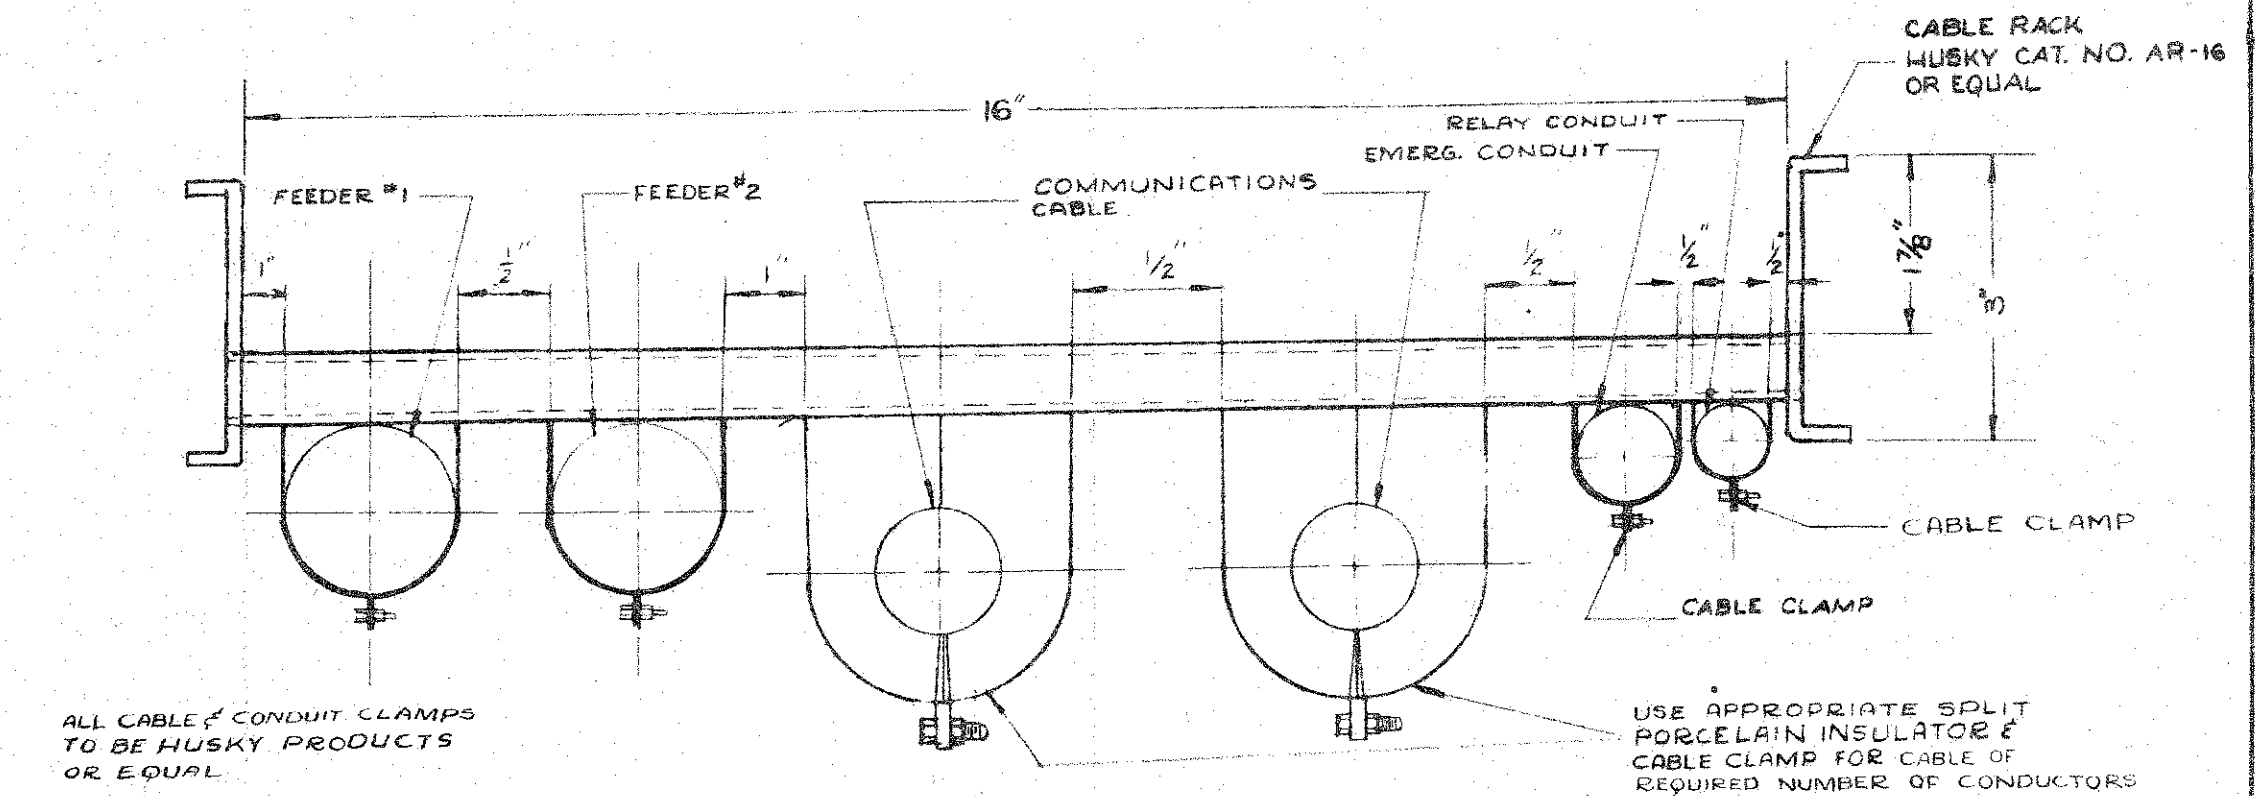


— TYPICAL SECTION THROUGH CABLE HANGER —
NO SCALE

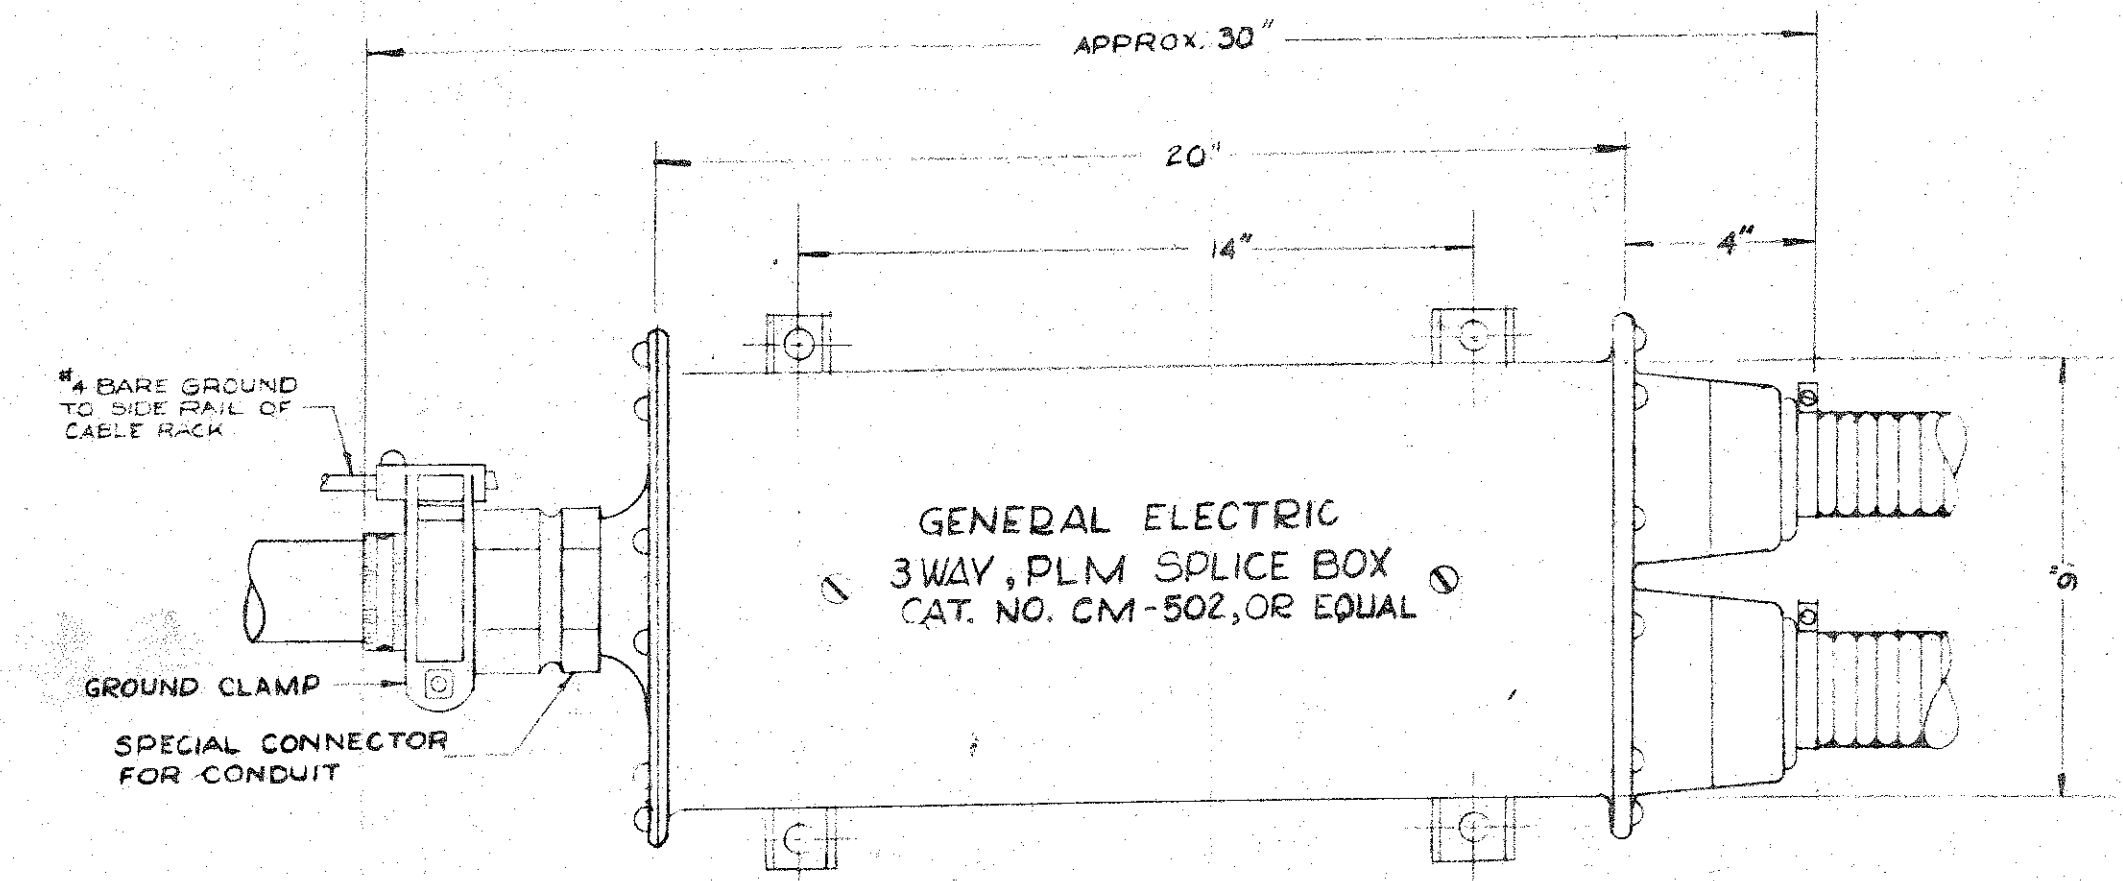


— PLAN CABLE SPLICE BOX —
SCALE 1/4" = 1'-0"

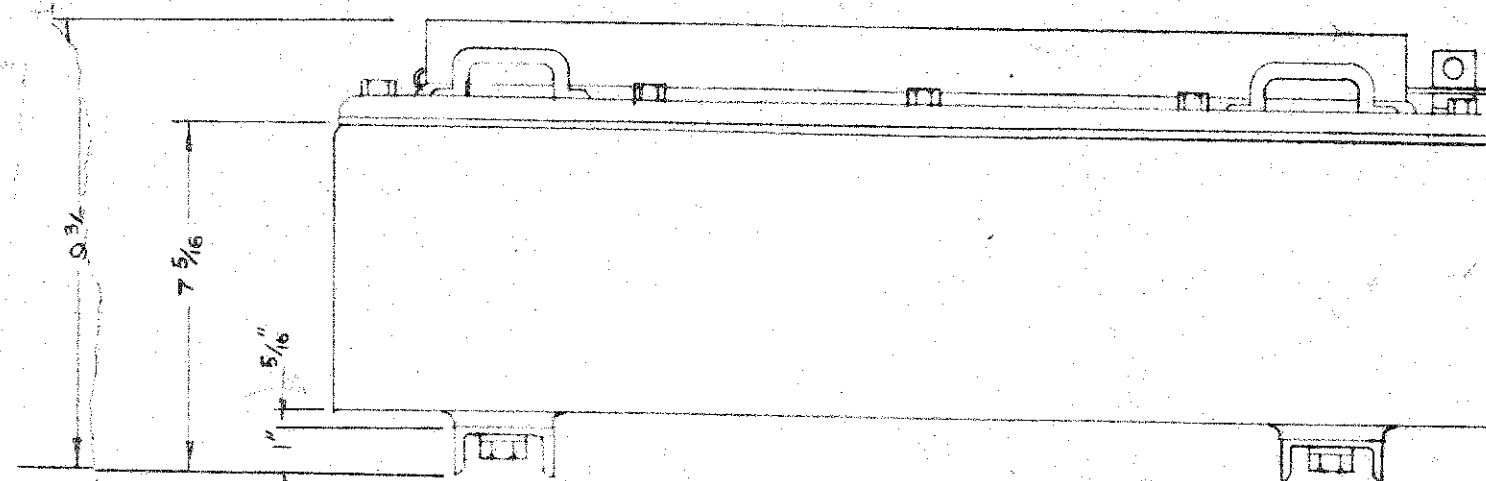

— SIDE ELEVATION OF LIGHTING PANEL —
SCALE 1/4" = 1'-0"

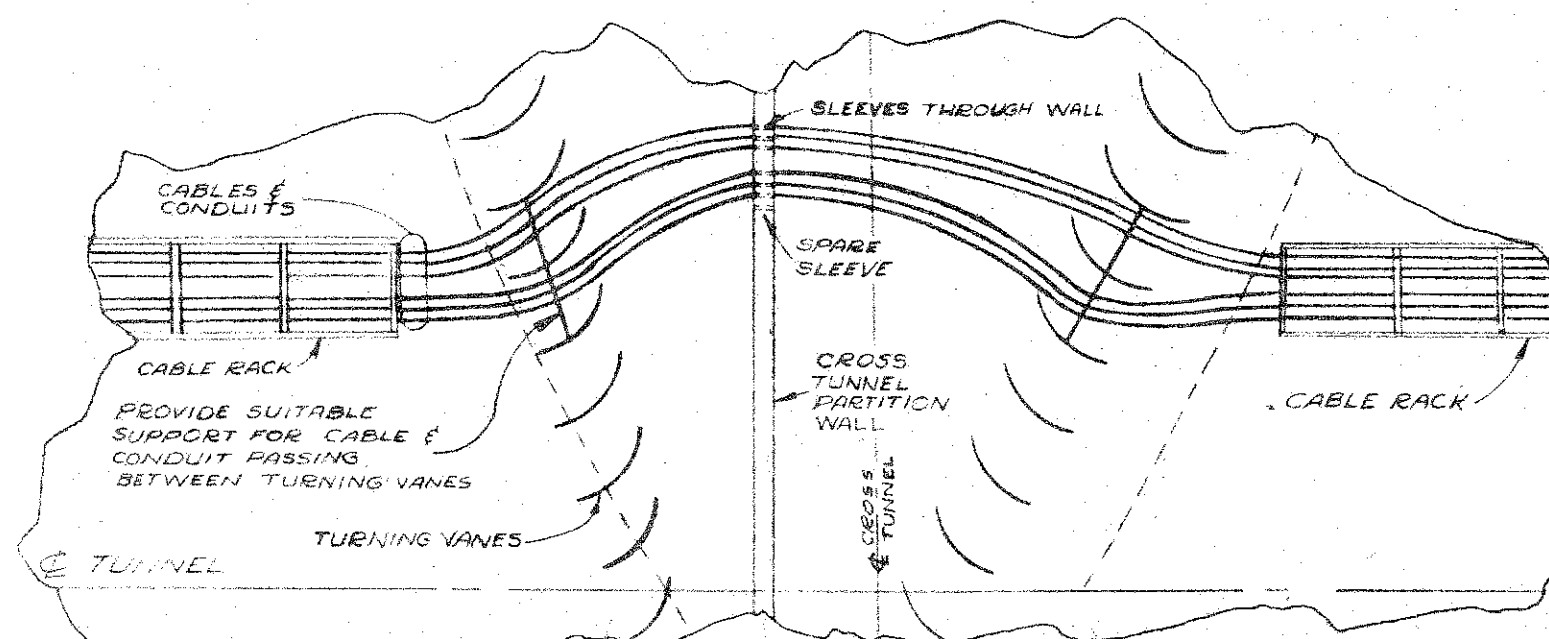

— PLAN OF CABLE RUN THROUGH
TURNING VANES —
SCALE 3/8" = 1'-0"

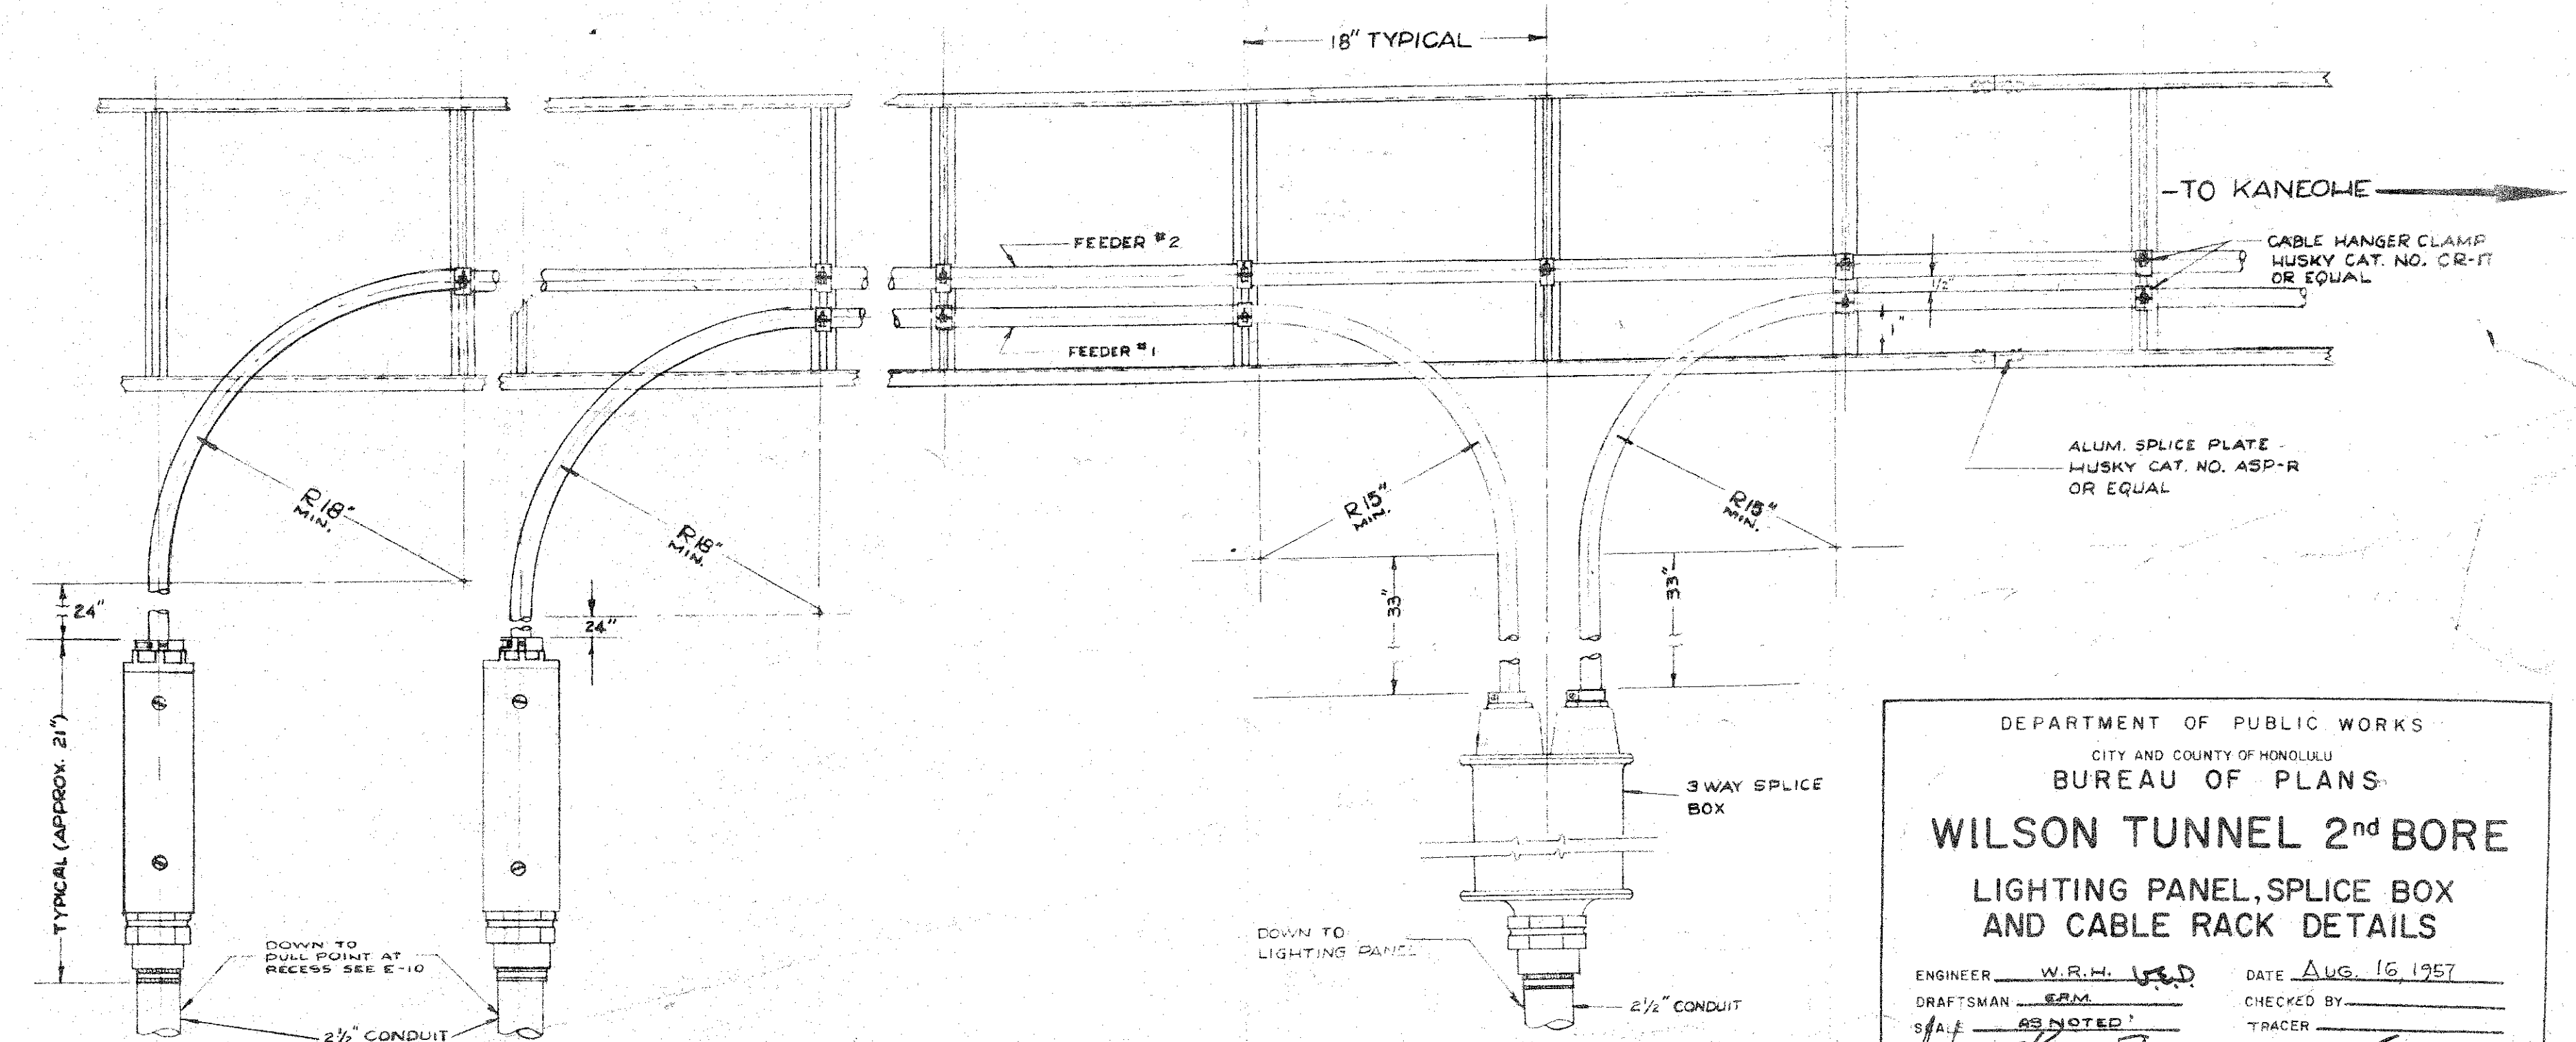

— TYPICAL ARRANGEMENT FOR
TAP TO LIGHTING PANEL —
SCALE 3/8" = 1'-0"

DEPARTMENT OF PUBLIC WORKS		
CITY AND COUNTY OF HONOLULU		
BUREAU OF PLANS		
WILSON TUNNEL 2 ND BORE		
LIGHTING PANEL, SPLICE BOX AND CABLE RACK DETAILS		
ENGINEER	W.R.H. <i>W.R.H.</i>	DATE
DRAFTSMAN	E.M.	CHECKED BY
SCALE	AS NOTED	TRACER
APPROVED	<i>W.R.H.</i>	APPROVED
CHIEF ENGINEER		BUREAU ENGINEER
W.B.	PROFILE	C.B.
CR SEC.	F.R.	S.B.
W.M.B.Y.	F.W.B.Y.	S.B.Y.
JOB NO. 13-57		DWG NO. E-11