

INDEX TO DRAWINGS		
SHEET NO.	DESCRIPTION	COMB. SHEET NO.
1	Title Sheet	2
2-3	Typical Sections	3-4
4-5	Plan & Profile	6-8
6-9	Detail Plan of Roadway	11-14
10-12	Highway Lighting Plan	15-17
13-14	Electrical Details	18-19
15-16	Traffic Signs Plan	20-21
17-25	Omitted	22-30
26-34	Standard Details	31-35, 37-40
35-45	Expressway Signs	42-52


STATE OF HAWAII
DEPARTMENT OF TRANSPORTATION
HIGHWAYS DIVISION
HONOLULU, HAWAII

"AS BUILT" PLANS FOR
PAVING TWO RAMPS OF
LIKELIKE HIGHWAY
BECKLEY STREET TO SCHOOL STREET
FEDERAL AID PROJECT NO. U-063-1(I)

DISTRICT OF HONOLULU
ISLAND OF OAHU

SCALE
PLAN 1 INCH = 50 FEET
PROFILE HOR. 1 INCH = 50 FEET
VER. 1 INCH = 5 FEET
CROSS SECTION HOR. 1 INCH = 10 FEET
VER. 1 INCH = 5 FEET

NOTE:
ALL CHANGES MADE DURING CONSTRUCTION
HAVE BEEN NOTED IN RED ON THESE TRACINGS
AND CHECKED BY:

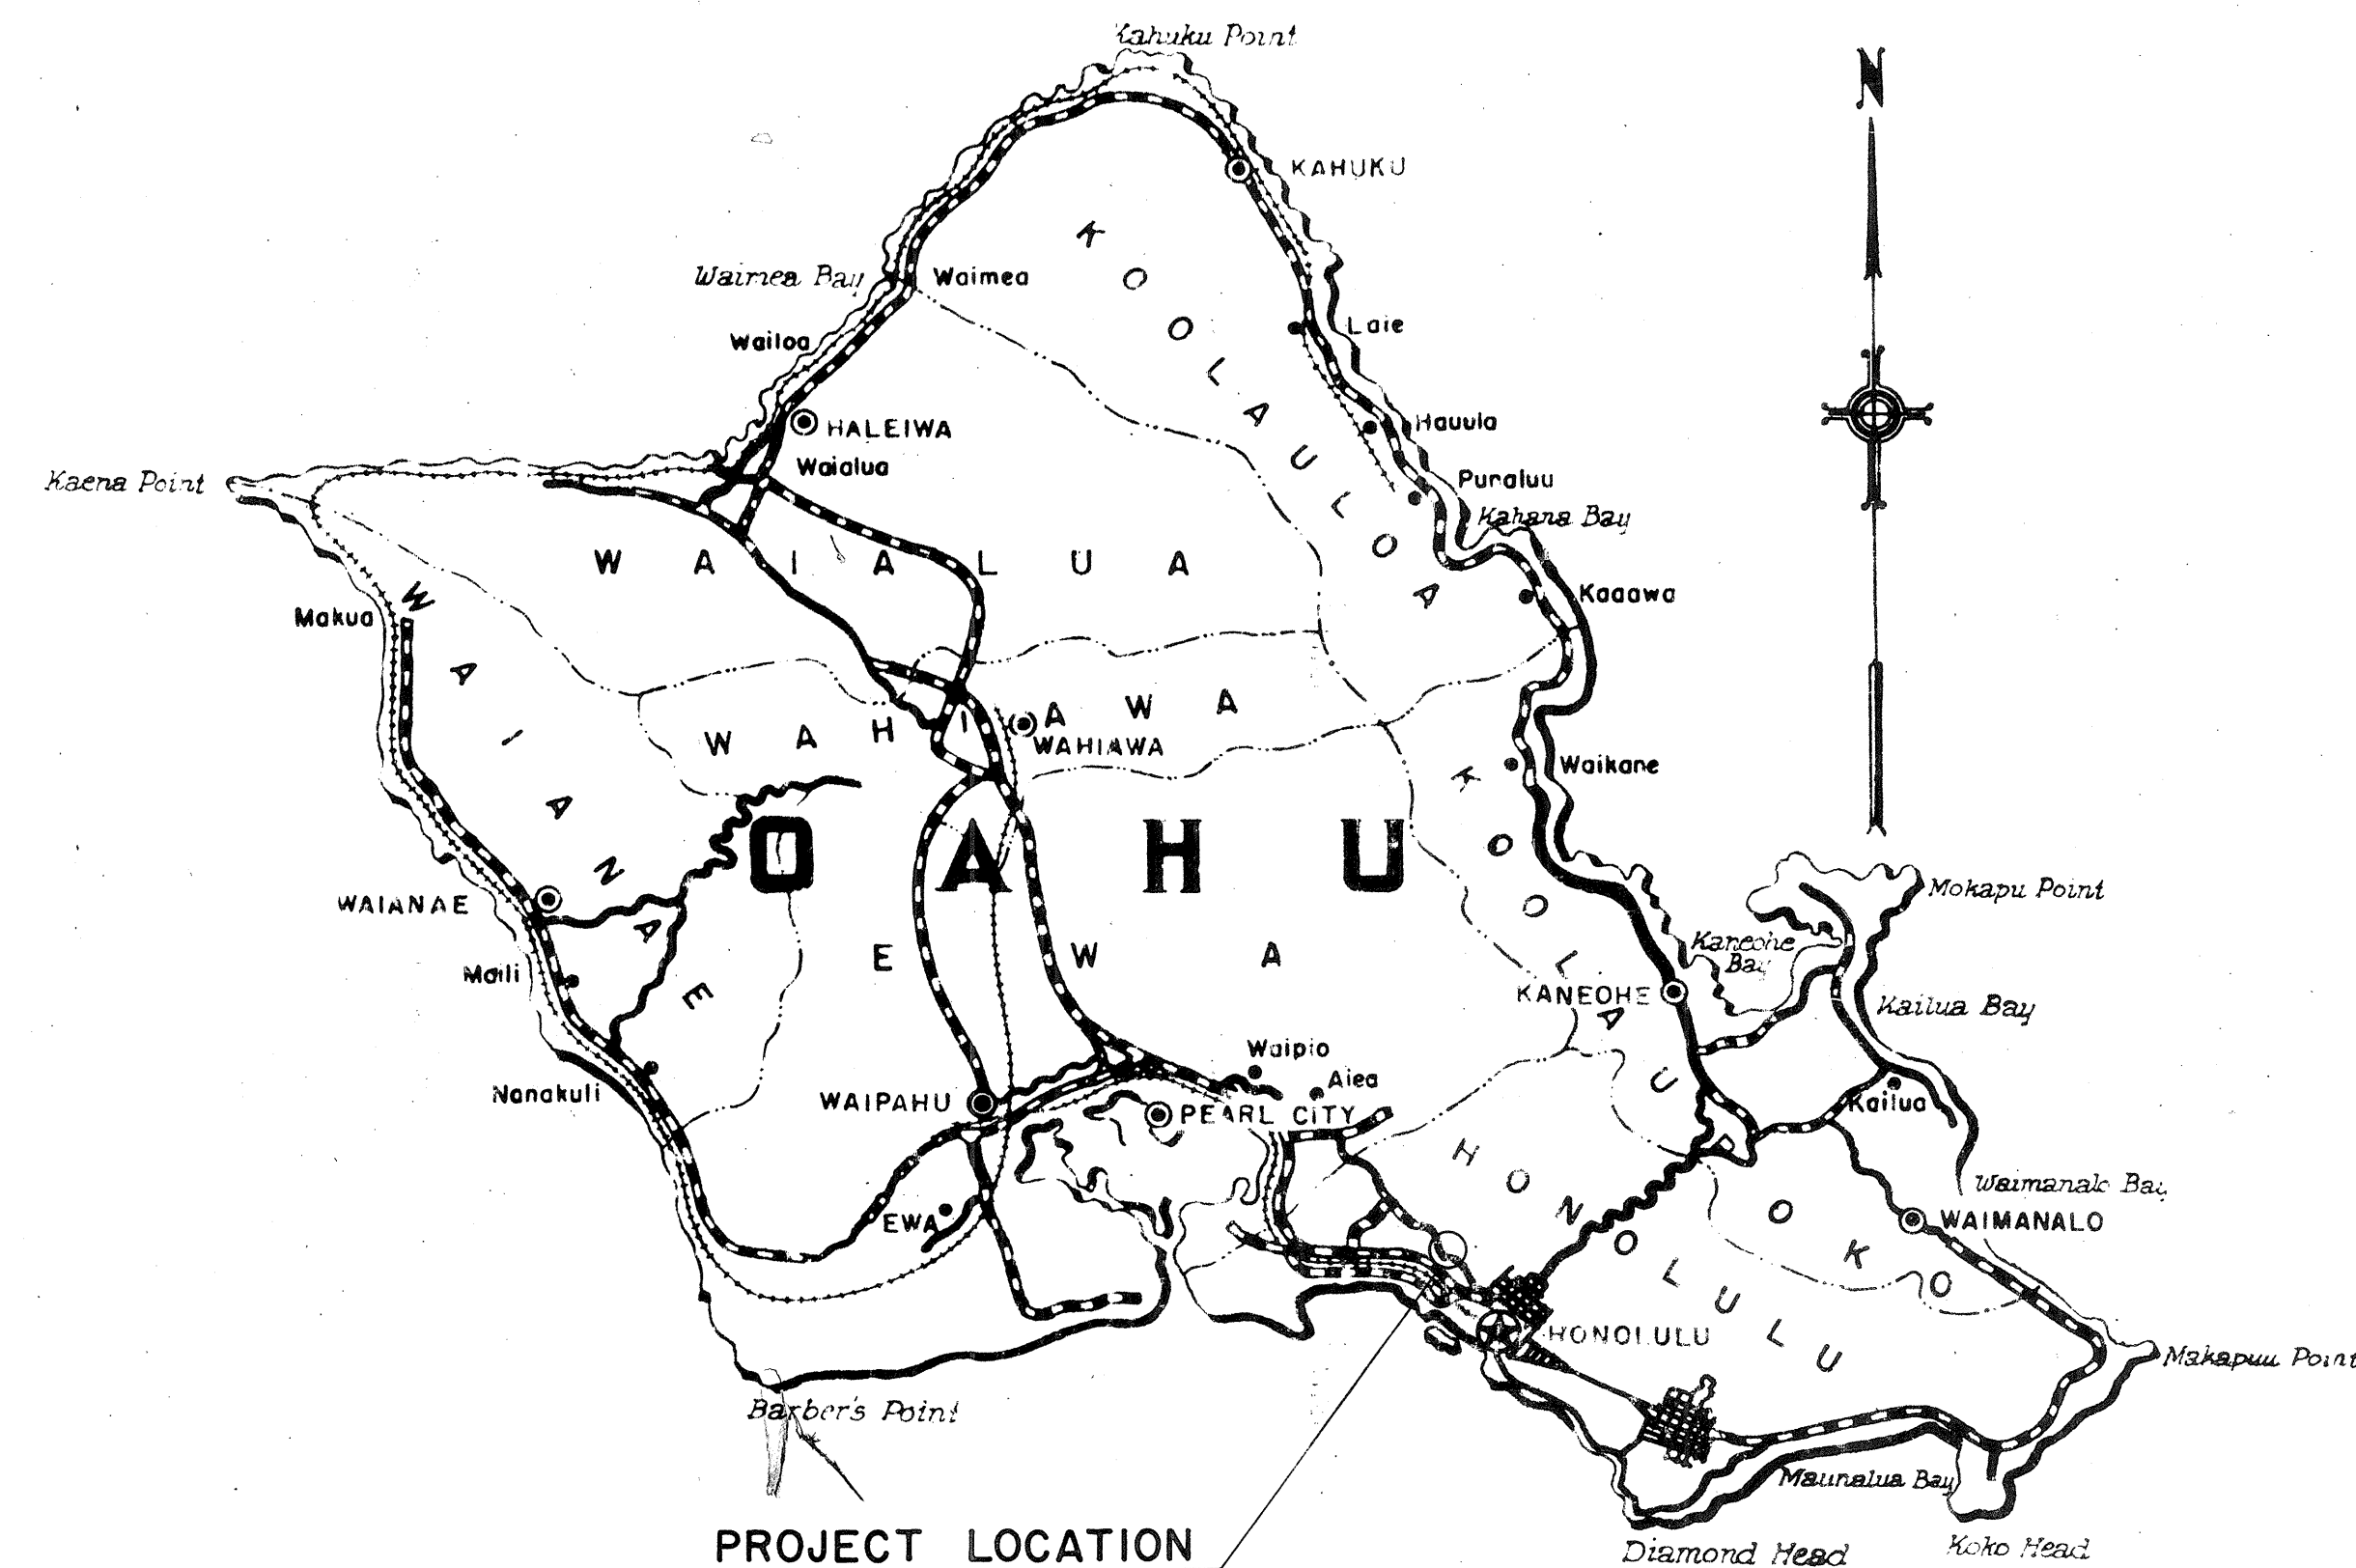

Federal Aid Projects Previously Constructed Or Under Construction

[Signature]
RESIDENT ENGINEER
3-17-66
DATE

BELT, COLLINS & ASSOCIATES, LTD.
Civil and Structural Engineers


• ASSOCIATES •

MOFFATT, NICHOL & TAYLOR - Structural Engineers
JAMES B. MANN - Surveyor
PAUL R. WEISSICH - Landscape Architect
WYNN NAKAMURA - Electrical Engineer

DESIGN CLASSIFICATION		RAMP K-1	RAMP K-2
ADT (1963)		0	0
ADT (1983)		6,200	6,300
DHV		11%	11%
D		70/30	70/30
T		2 %	2 %

APPROVED: DATE 27 Aug 63
[Signature]
DIRECTOR OF TRANSPORTATION

DEPARTMENT OF COMMERCE
BUREAU OF PUBLIC ROADS
APPROVED:
DIVISION ENGINEER DATE

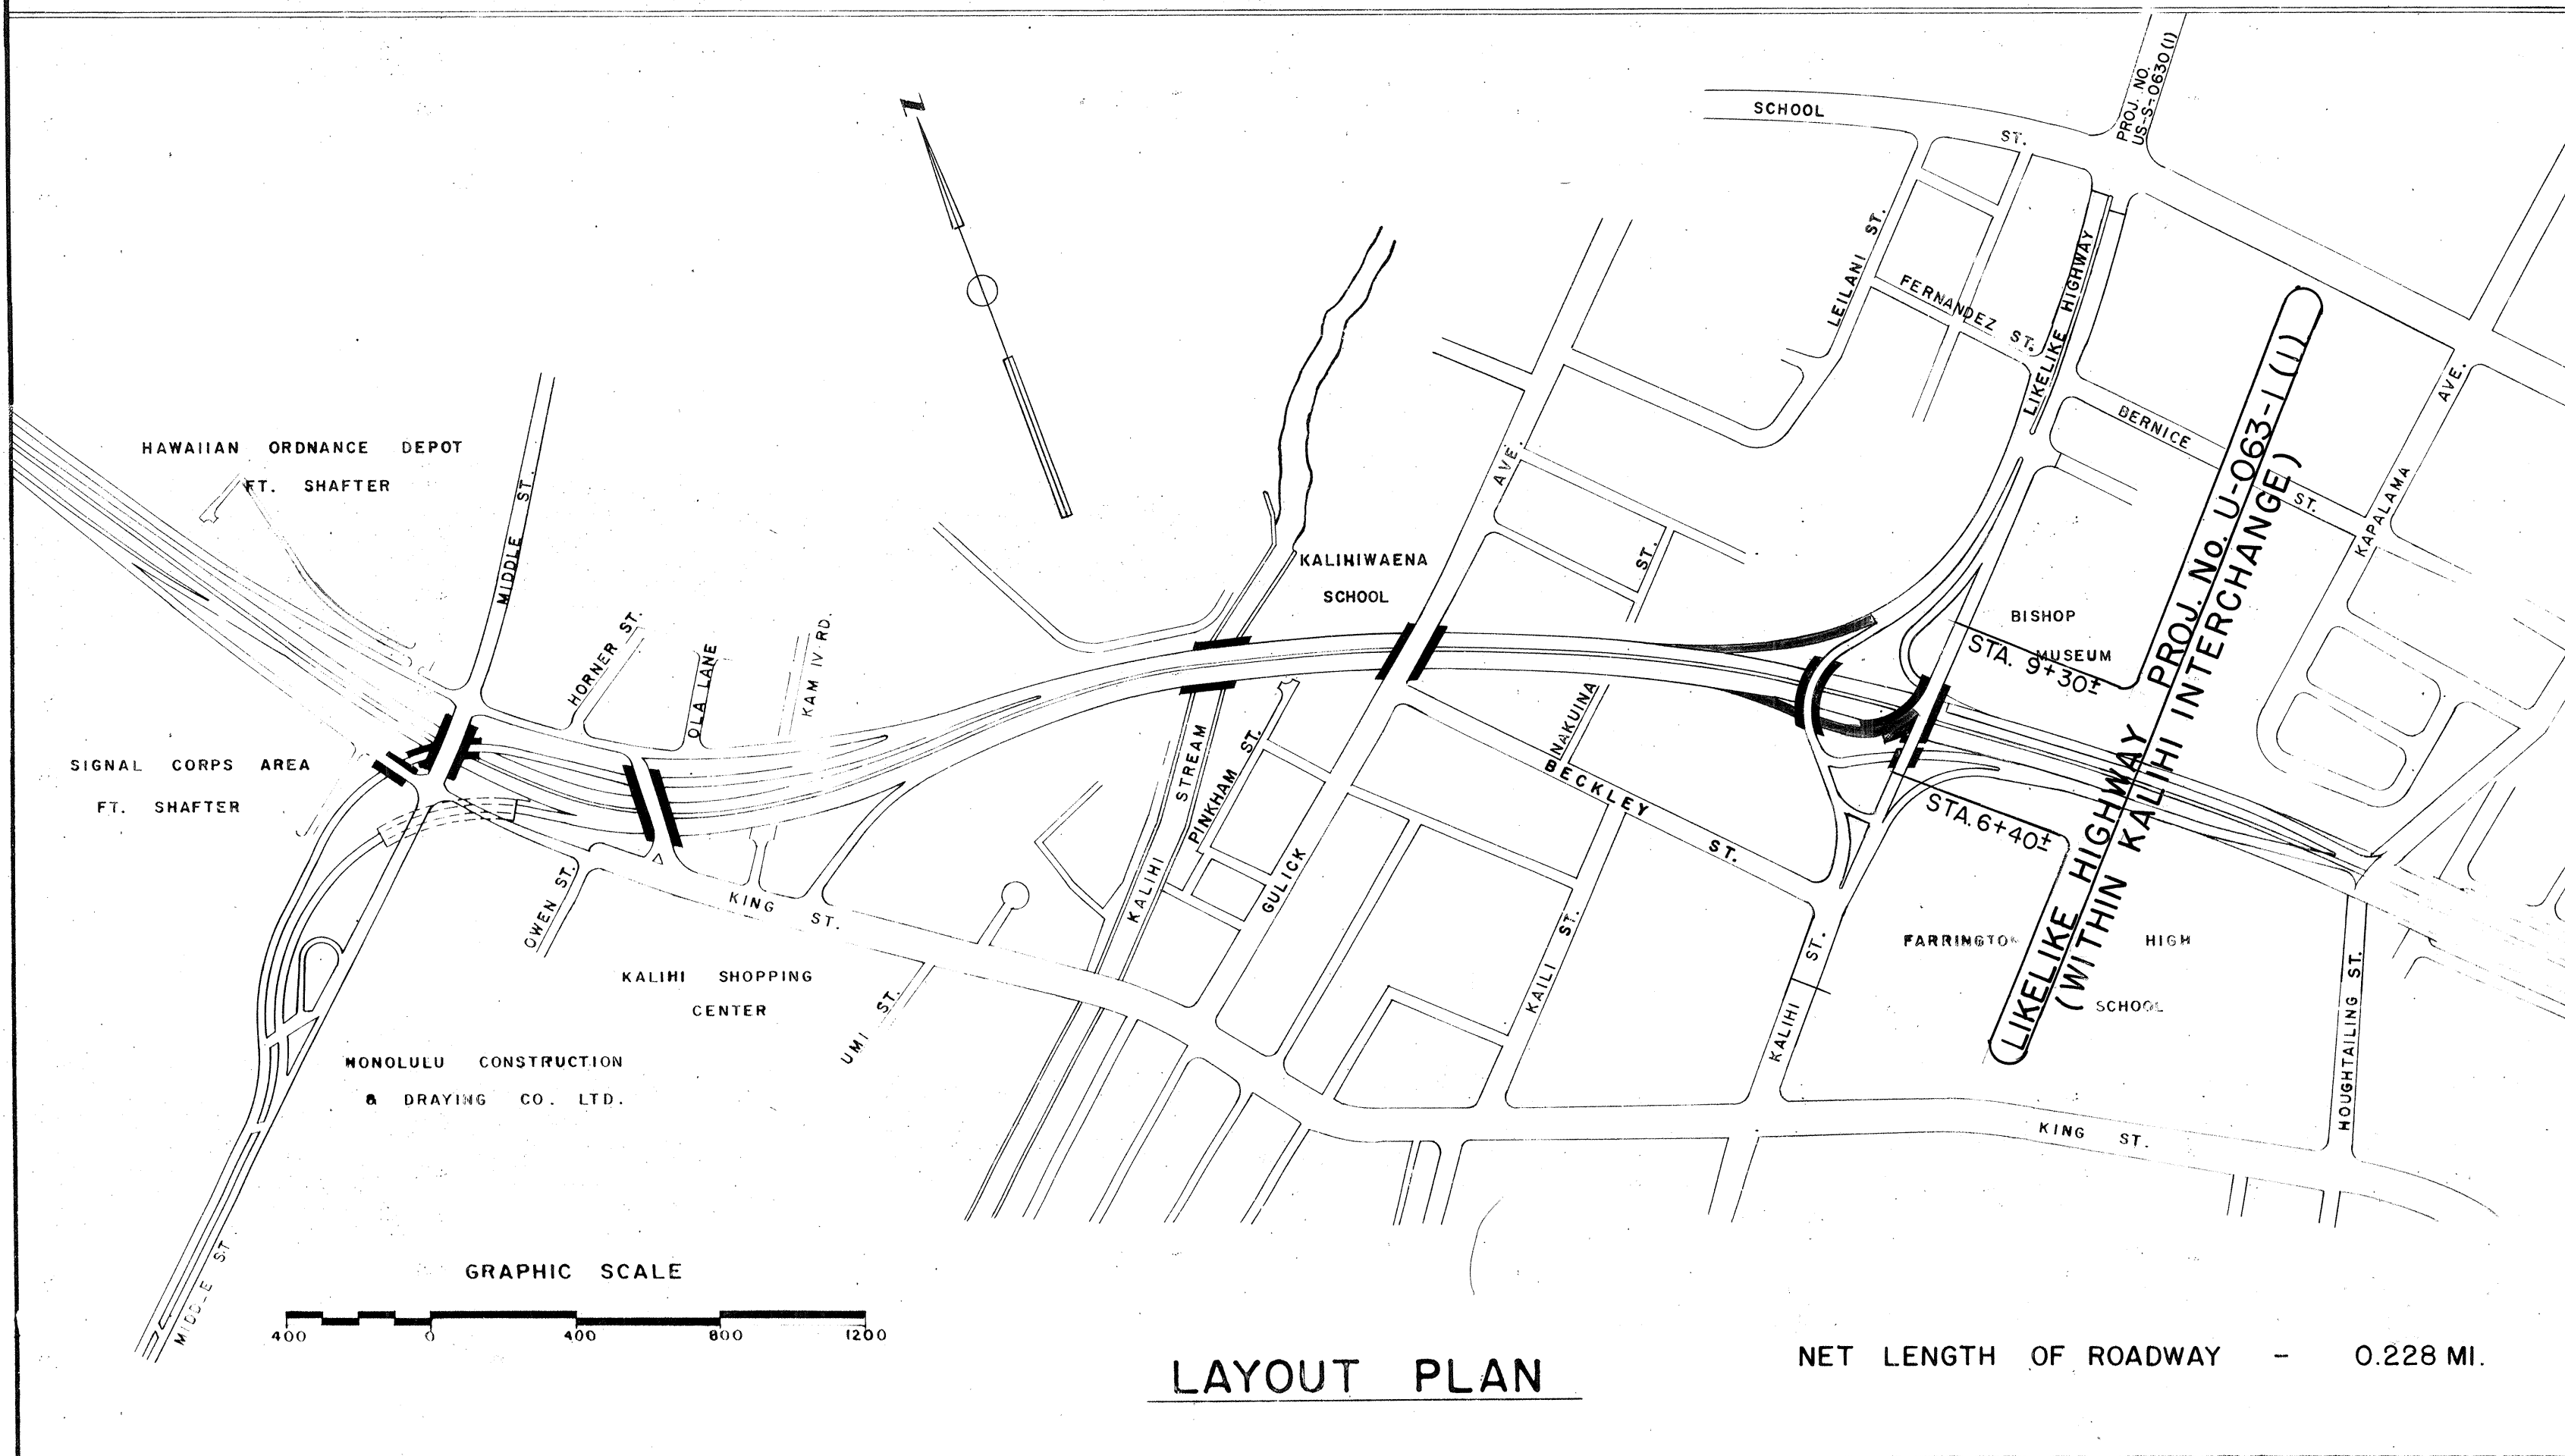

U-063-1(I) B 1