



FED. ROAD DIST. NO.	STATE	FED. AID PROJ. NO.	FISCAL YEAR	SHEET NO.	TOTAL SHEETS
HAWAII	HAW.	63A-03-68	1968	3	3

LEGEND


- Existing Duct To Remain
- /---/--- Existing Duct To Be Abandoned
- New 2" Duct - Direct Buried
- New 2" Duct - Encased
- Existing Pullbox
- ⊗ Relocated Pullbox
- New Pullbox - Type "C"
- Existing Light Standard
- ⊗ Relocated Light Standard

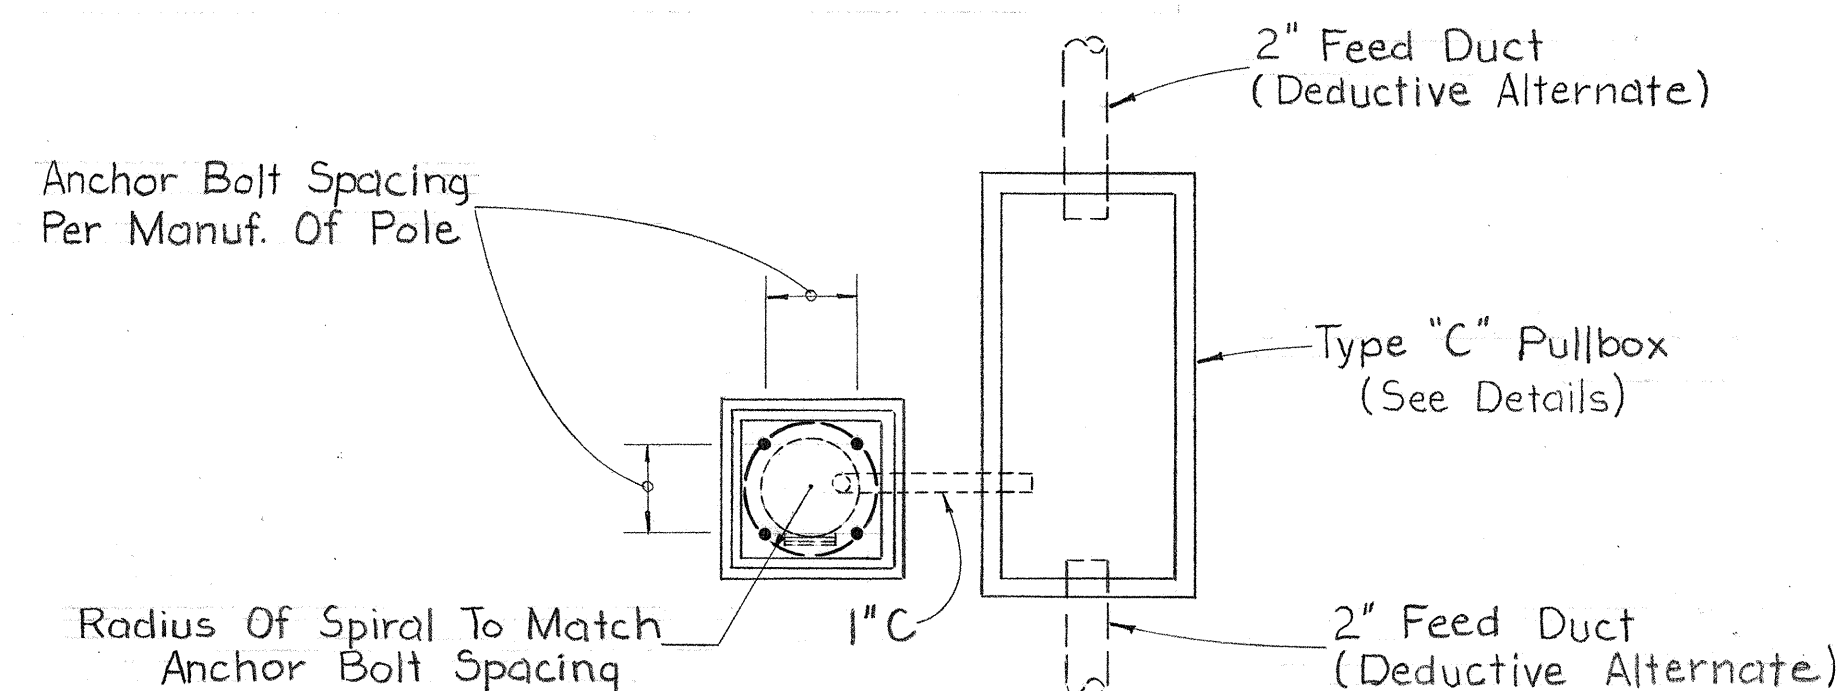


PLAN VIEW - LIGHT STANDARD FOUNDATION
NOT TO SCALE

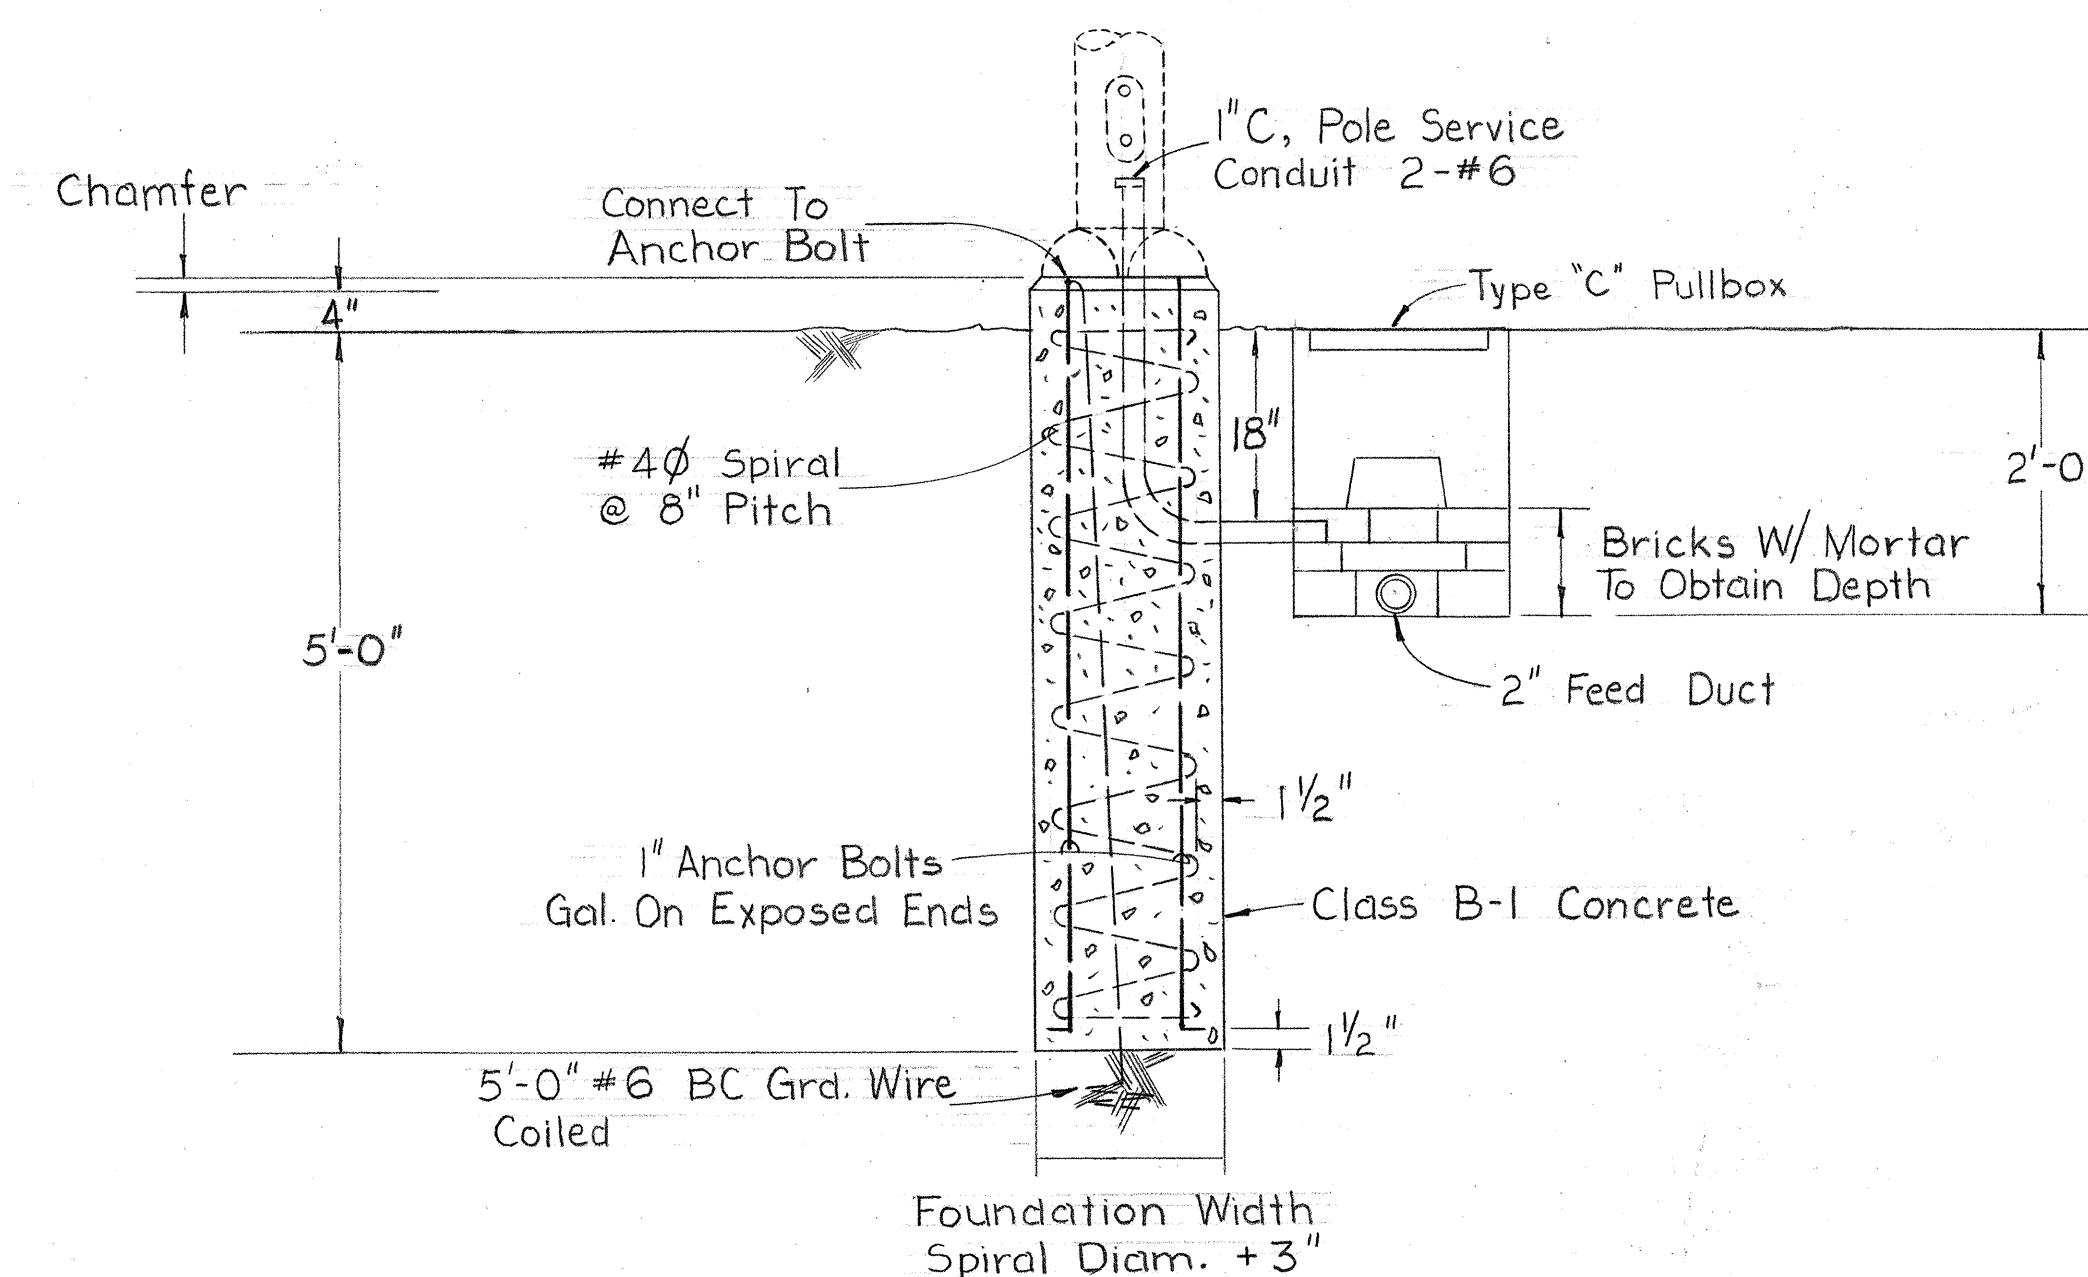


TYPICAL DETAIL - LIGHT STANDARD FOUNDATION
NOT TO SCALE

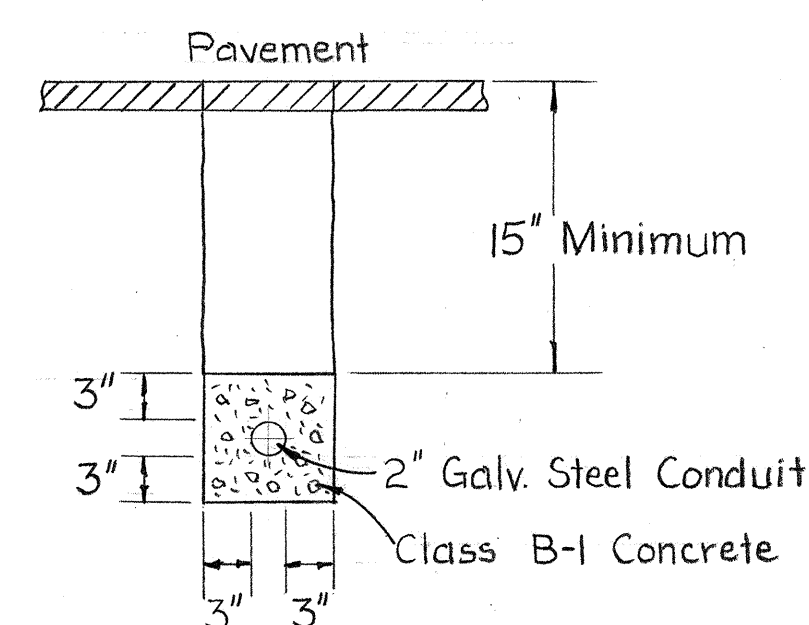

TYPICAL SECTION - ENCASED DUCT
NOT TO SCALE

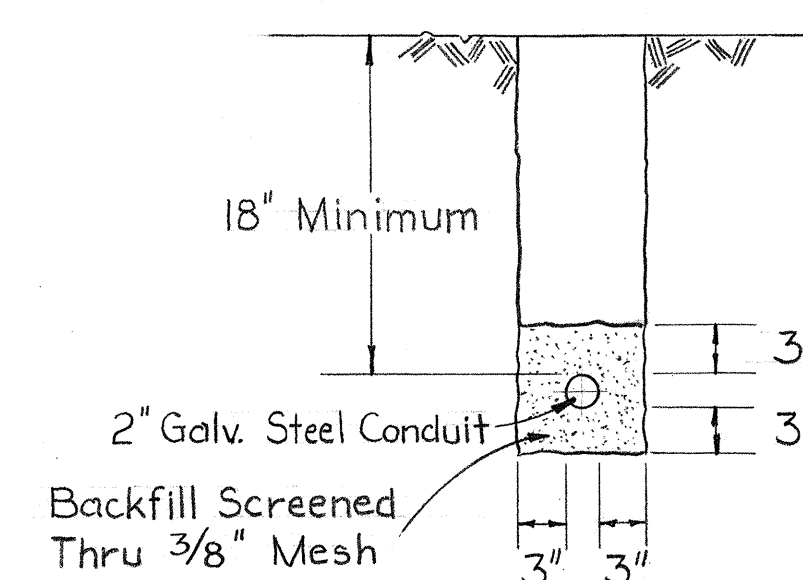

TYPICAL SECTION - DIRECT BURIED DUCT
NOT TO SCALE

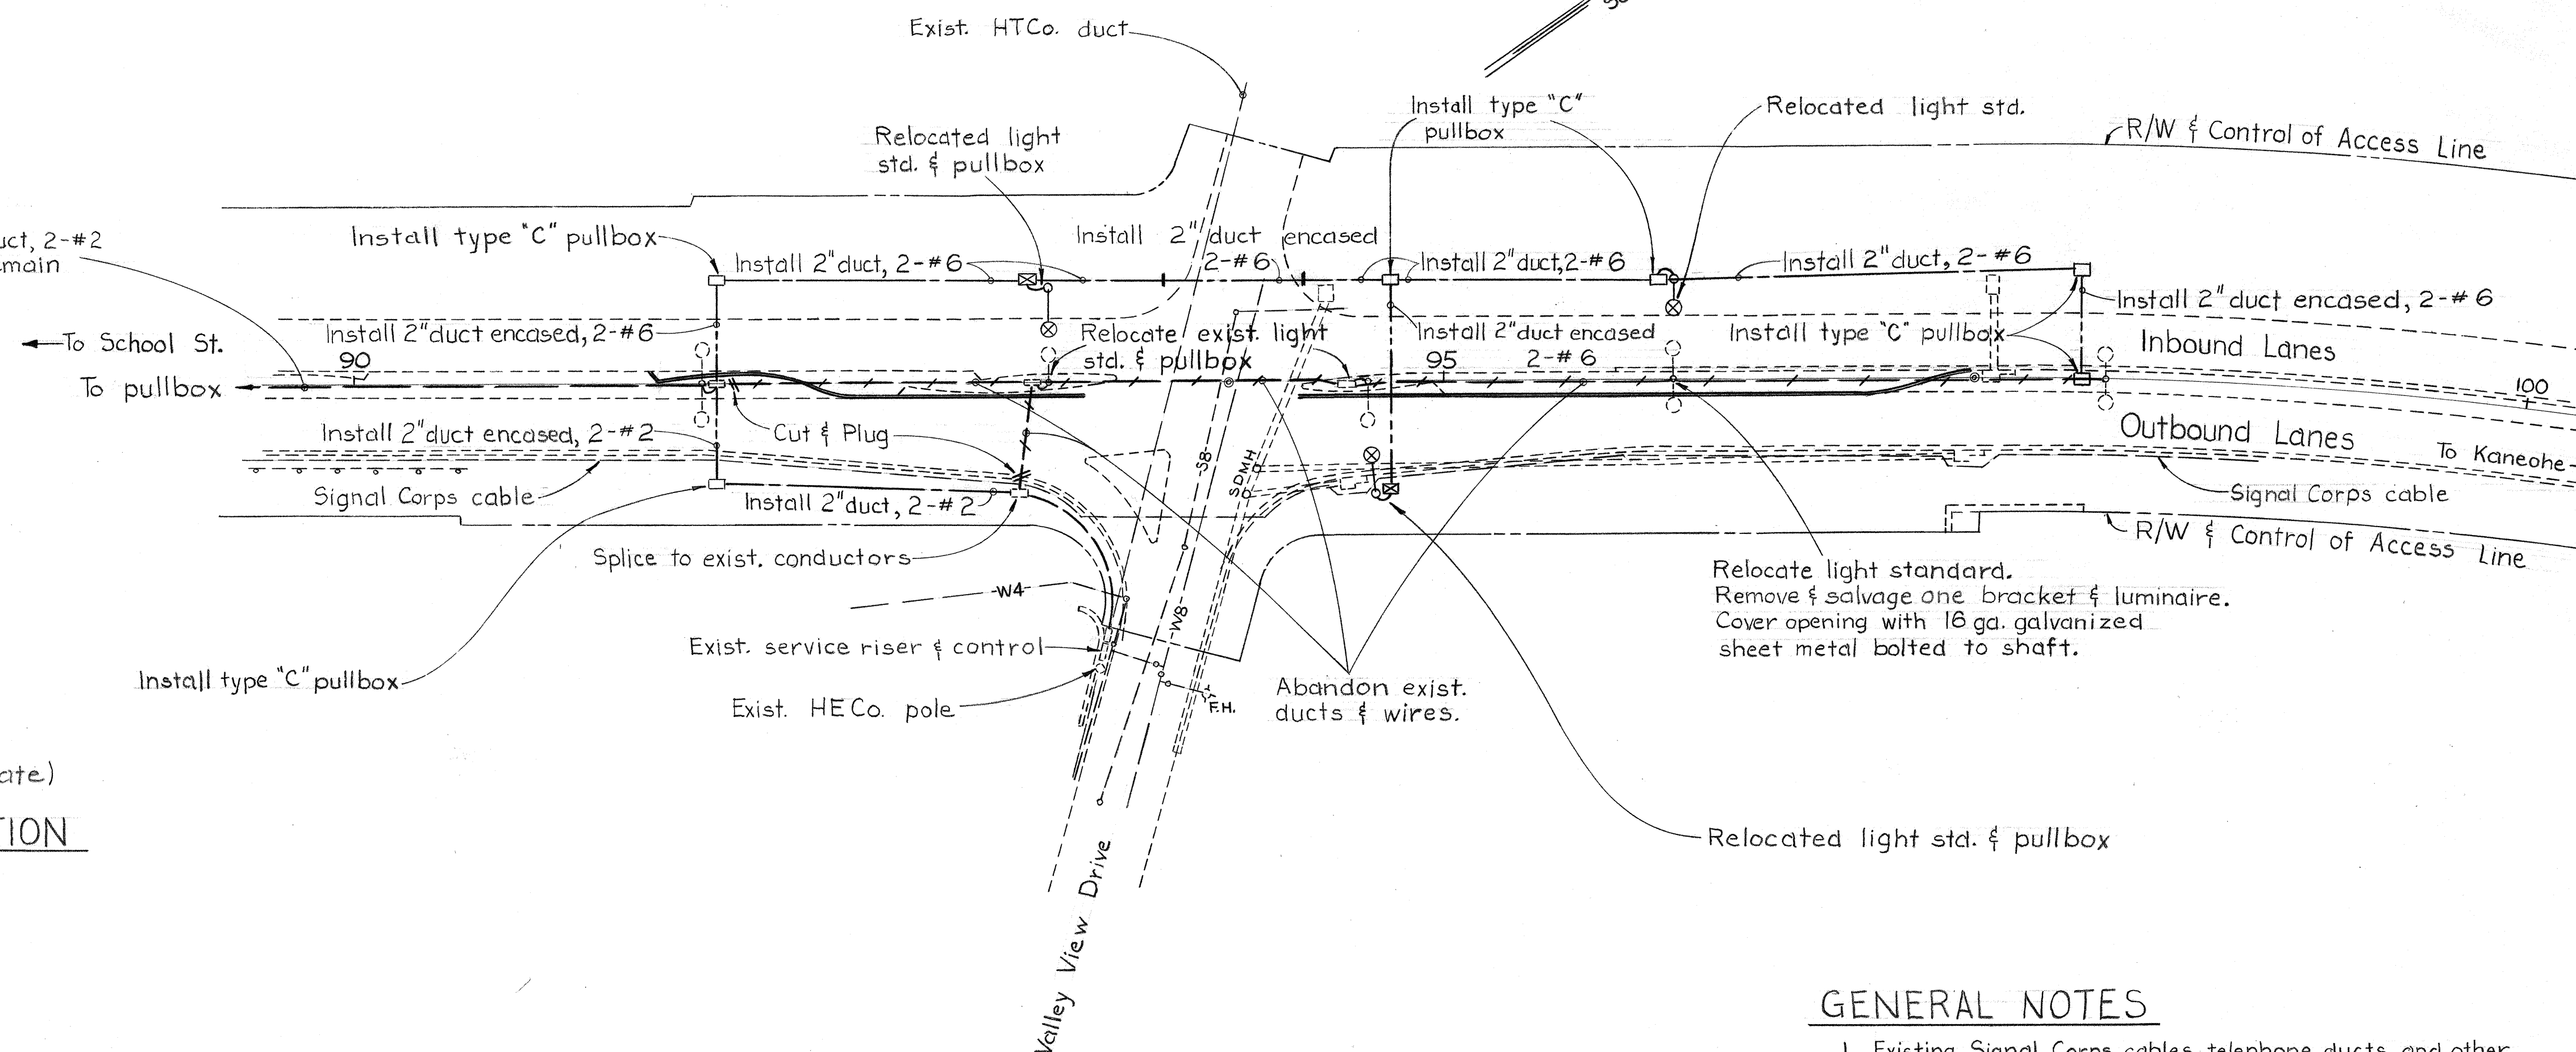

GENERAL NOTES

- Existing Signal Corps cables, telephone ducts, and other lines shown on the plan are approximate only. The Contractor shall verify their actual locations and shall use precaution when excavating in the vicinity of these facilities.
- The Contractor shall notify the Engineer at least 2 working days prior to doing any work on the existing lighting system.

STATE OF HAWAII
DEPARTMENT OF TRANSPORTATION
HIGHWAYS DIVISION

LIKELIKE HIGHWAY
VALLEY VIEW DRIVE
HIGHWAY LIGHTING PLAN
PROJECT NO. 63A-03-68

Scale As Noted July 1968

SHEET No. 1 OF 1 SHEETS

DATE	_____
DESIGNED BY	_____
CHECKED BY	_____
NOTED BY	_____
ORIGINAL PLAN	_____
NO.	_____