


FED. ROAD DIST. NO.	STATE	PROJ. NO.	FISCAL YEAR	SHEET NO.	TOTAL SHEETS
HAWAII	HAW.	63A-02-68	1968	CO325	31

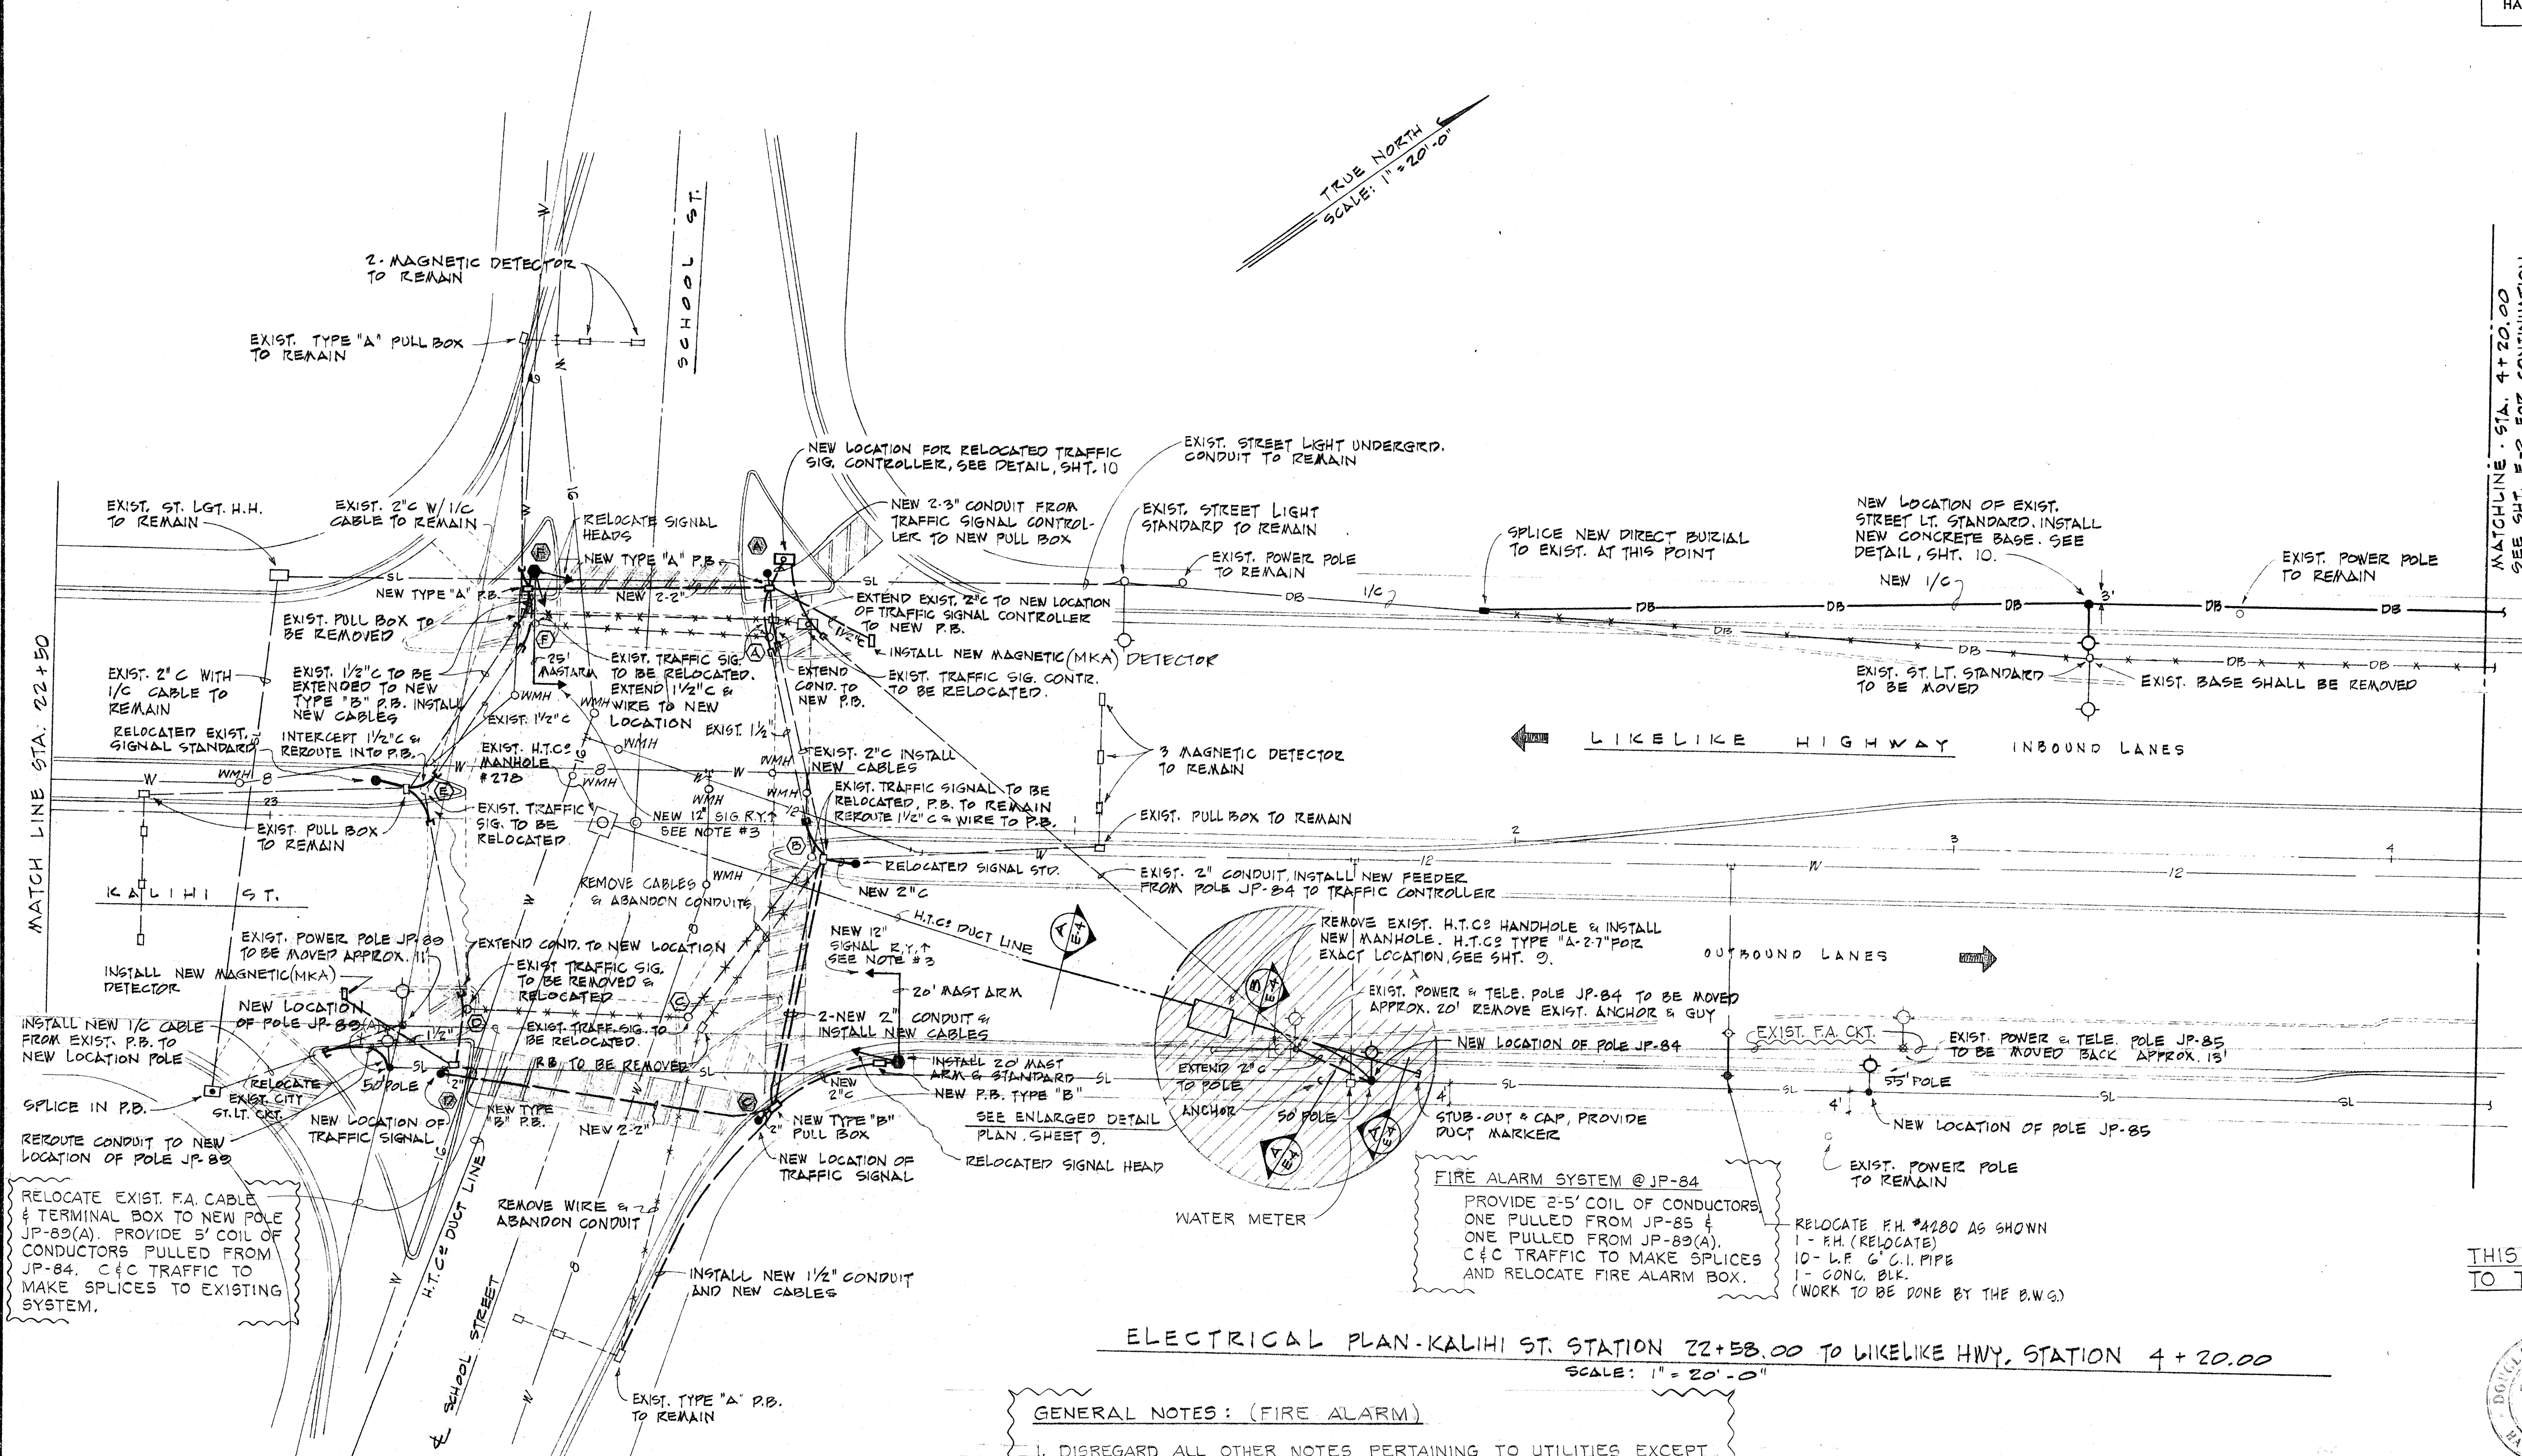


ELECTRICAL PLAN-KALIHI ST. STATION 22+58.00 TO LIKELIKE HWY. STATION 4+20.00
SCALE: 1" = 20'-0"

- GENERAL NOTES: (FIRE ALARM)
1. DISREGARD ALL OTHER NOTES PERTAINING TO UTILITIES EXCEPT THOSE FOR THE FIRE ALARM SYSTEM.
 2. THE CONTRACTOR WILL NOTIFY THE C & C, DEPT. OF TRAFFIC, THREE (3) DAYS PRIOR TO WORKING ON THE FIRE ALARM SYSTEM.

APPROVED
TRAFFIC ENGINEER, C. & C. OF HON. DATE

THIS SHEET IS A SUPPLEMENT TO THE CONTRACT PLANS.

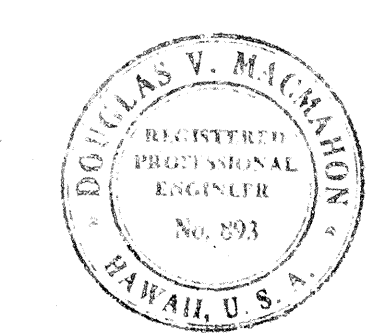

THIS WORK WAS PREPARED BY ME OR UNDER MY SUPERVISION.

STATE OF HAWAII
DEPARTMENT OF TRANSPORTATION
HIGHWAYS DIVISION
RELOCATION OF
FIRE ALARM SYSTEM
ADDITIONAL LANES ON LIKELIKE HIGHWAY
SCHOOL STREET TO KALIHI STREET
OAHU, HAWAII

PROJ. NO. 63A-02-68
SCALE: AS SHOWN Date: June 27, 1968

SHEET No. OF SHEETS

CO325

DATE	
SURVEY PLOTTED BY	
DRAWN BY	
DESIGNED BY	
NOTED BY	
CHECKED BY	
ORIGINAL PLAN	
NOTE BOOK	
NO.	

