
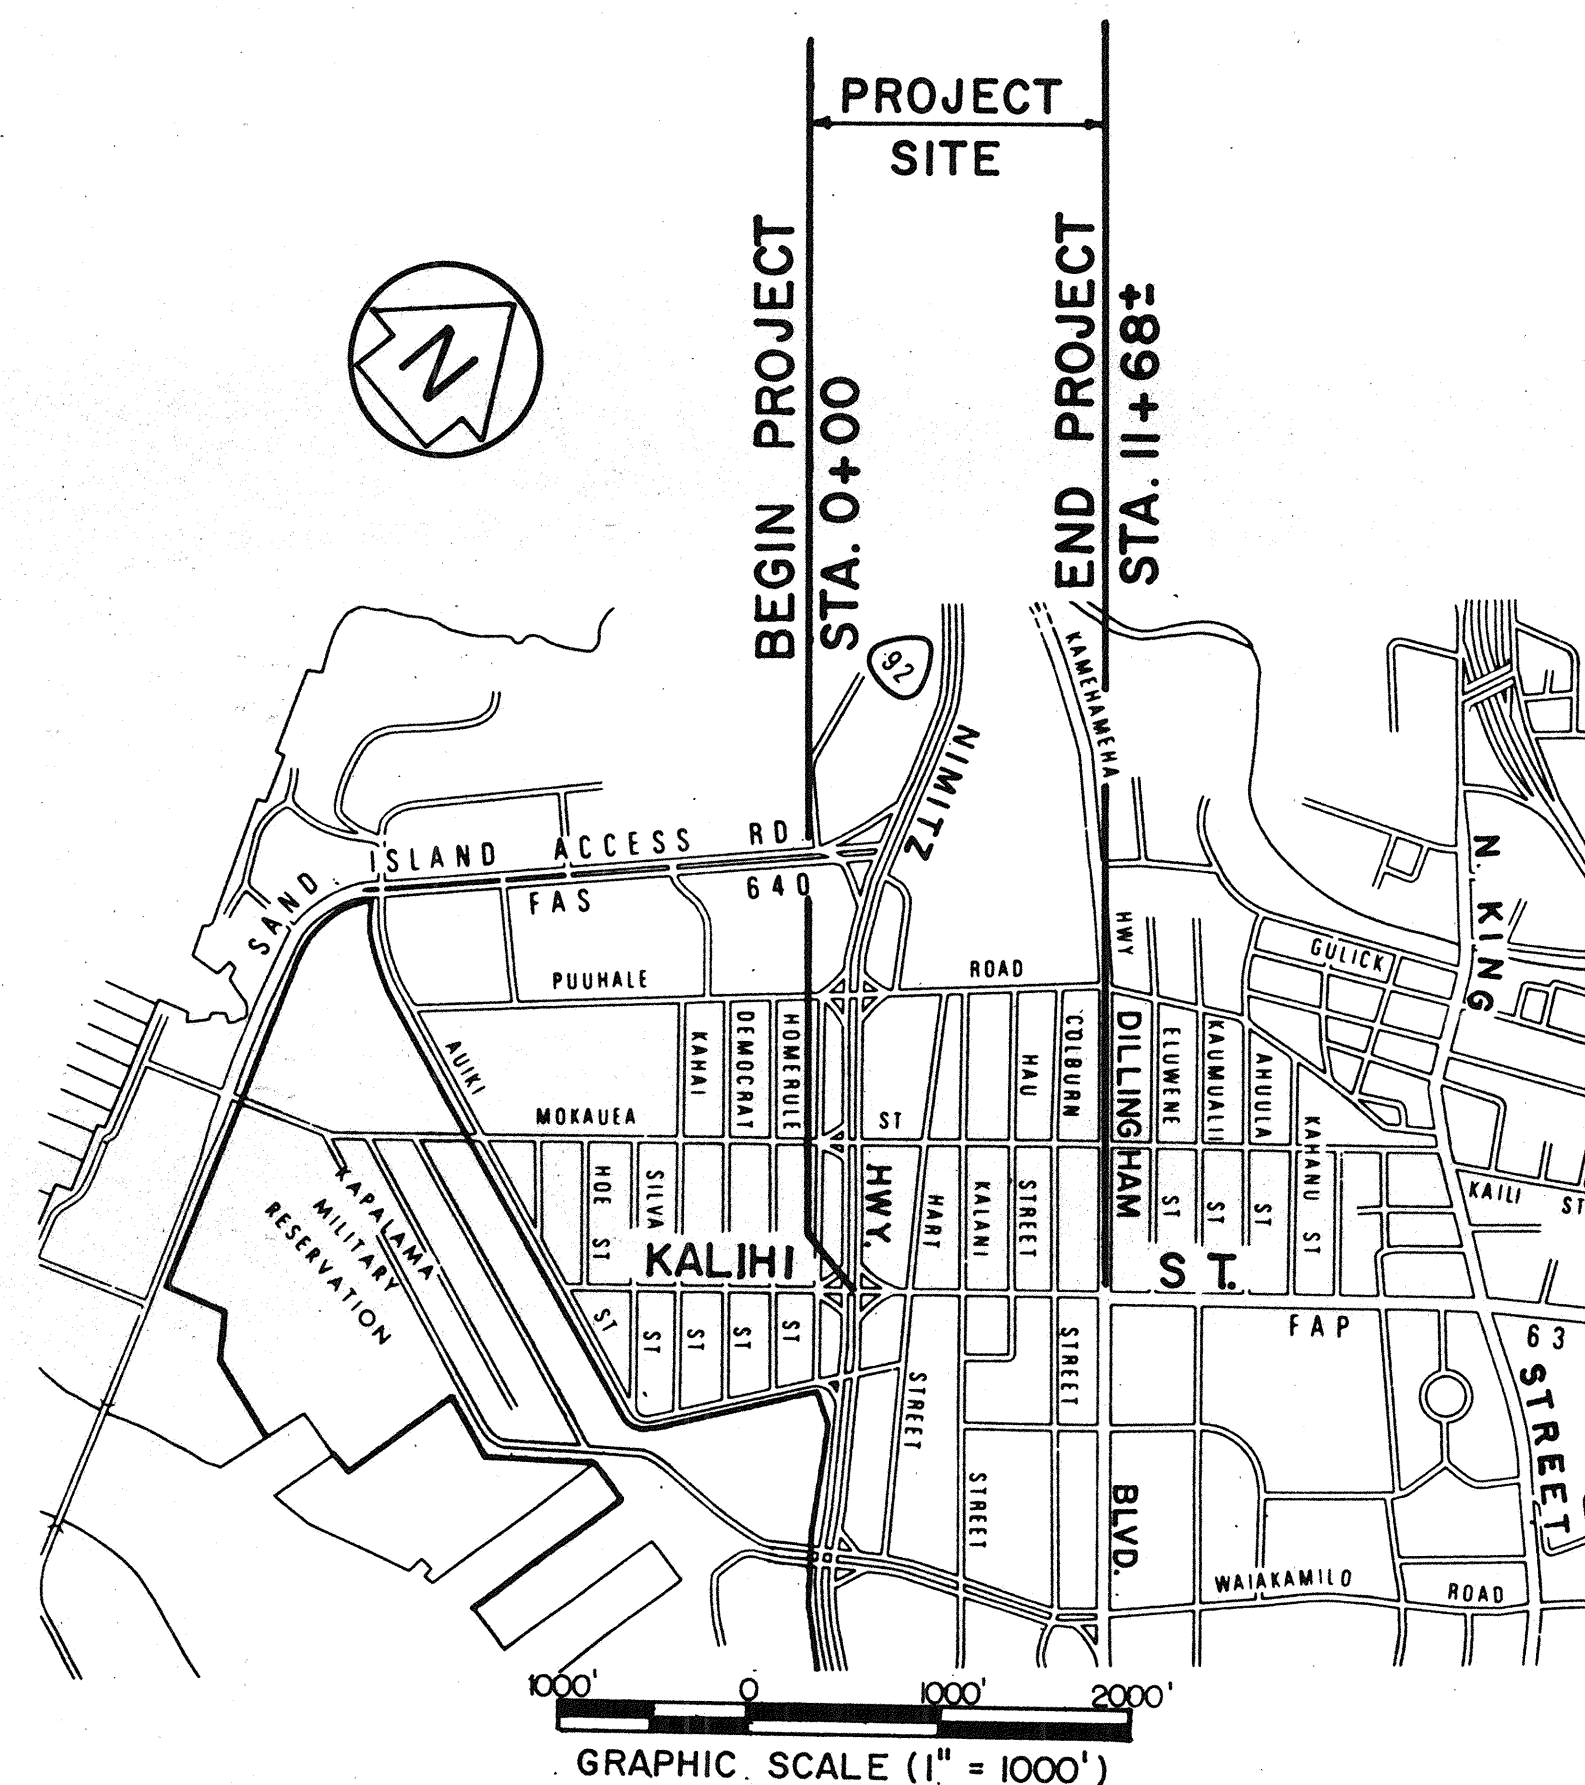
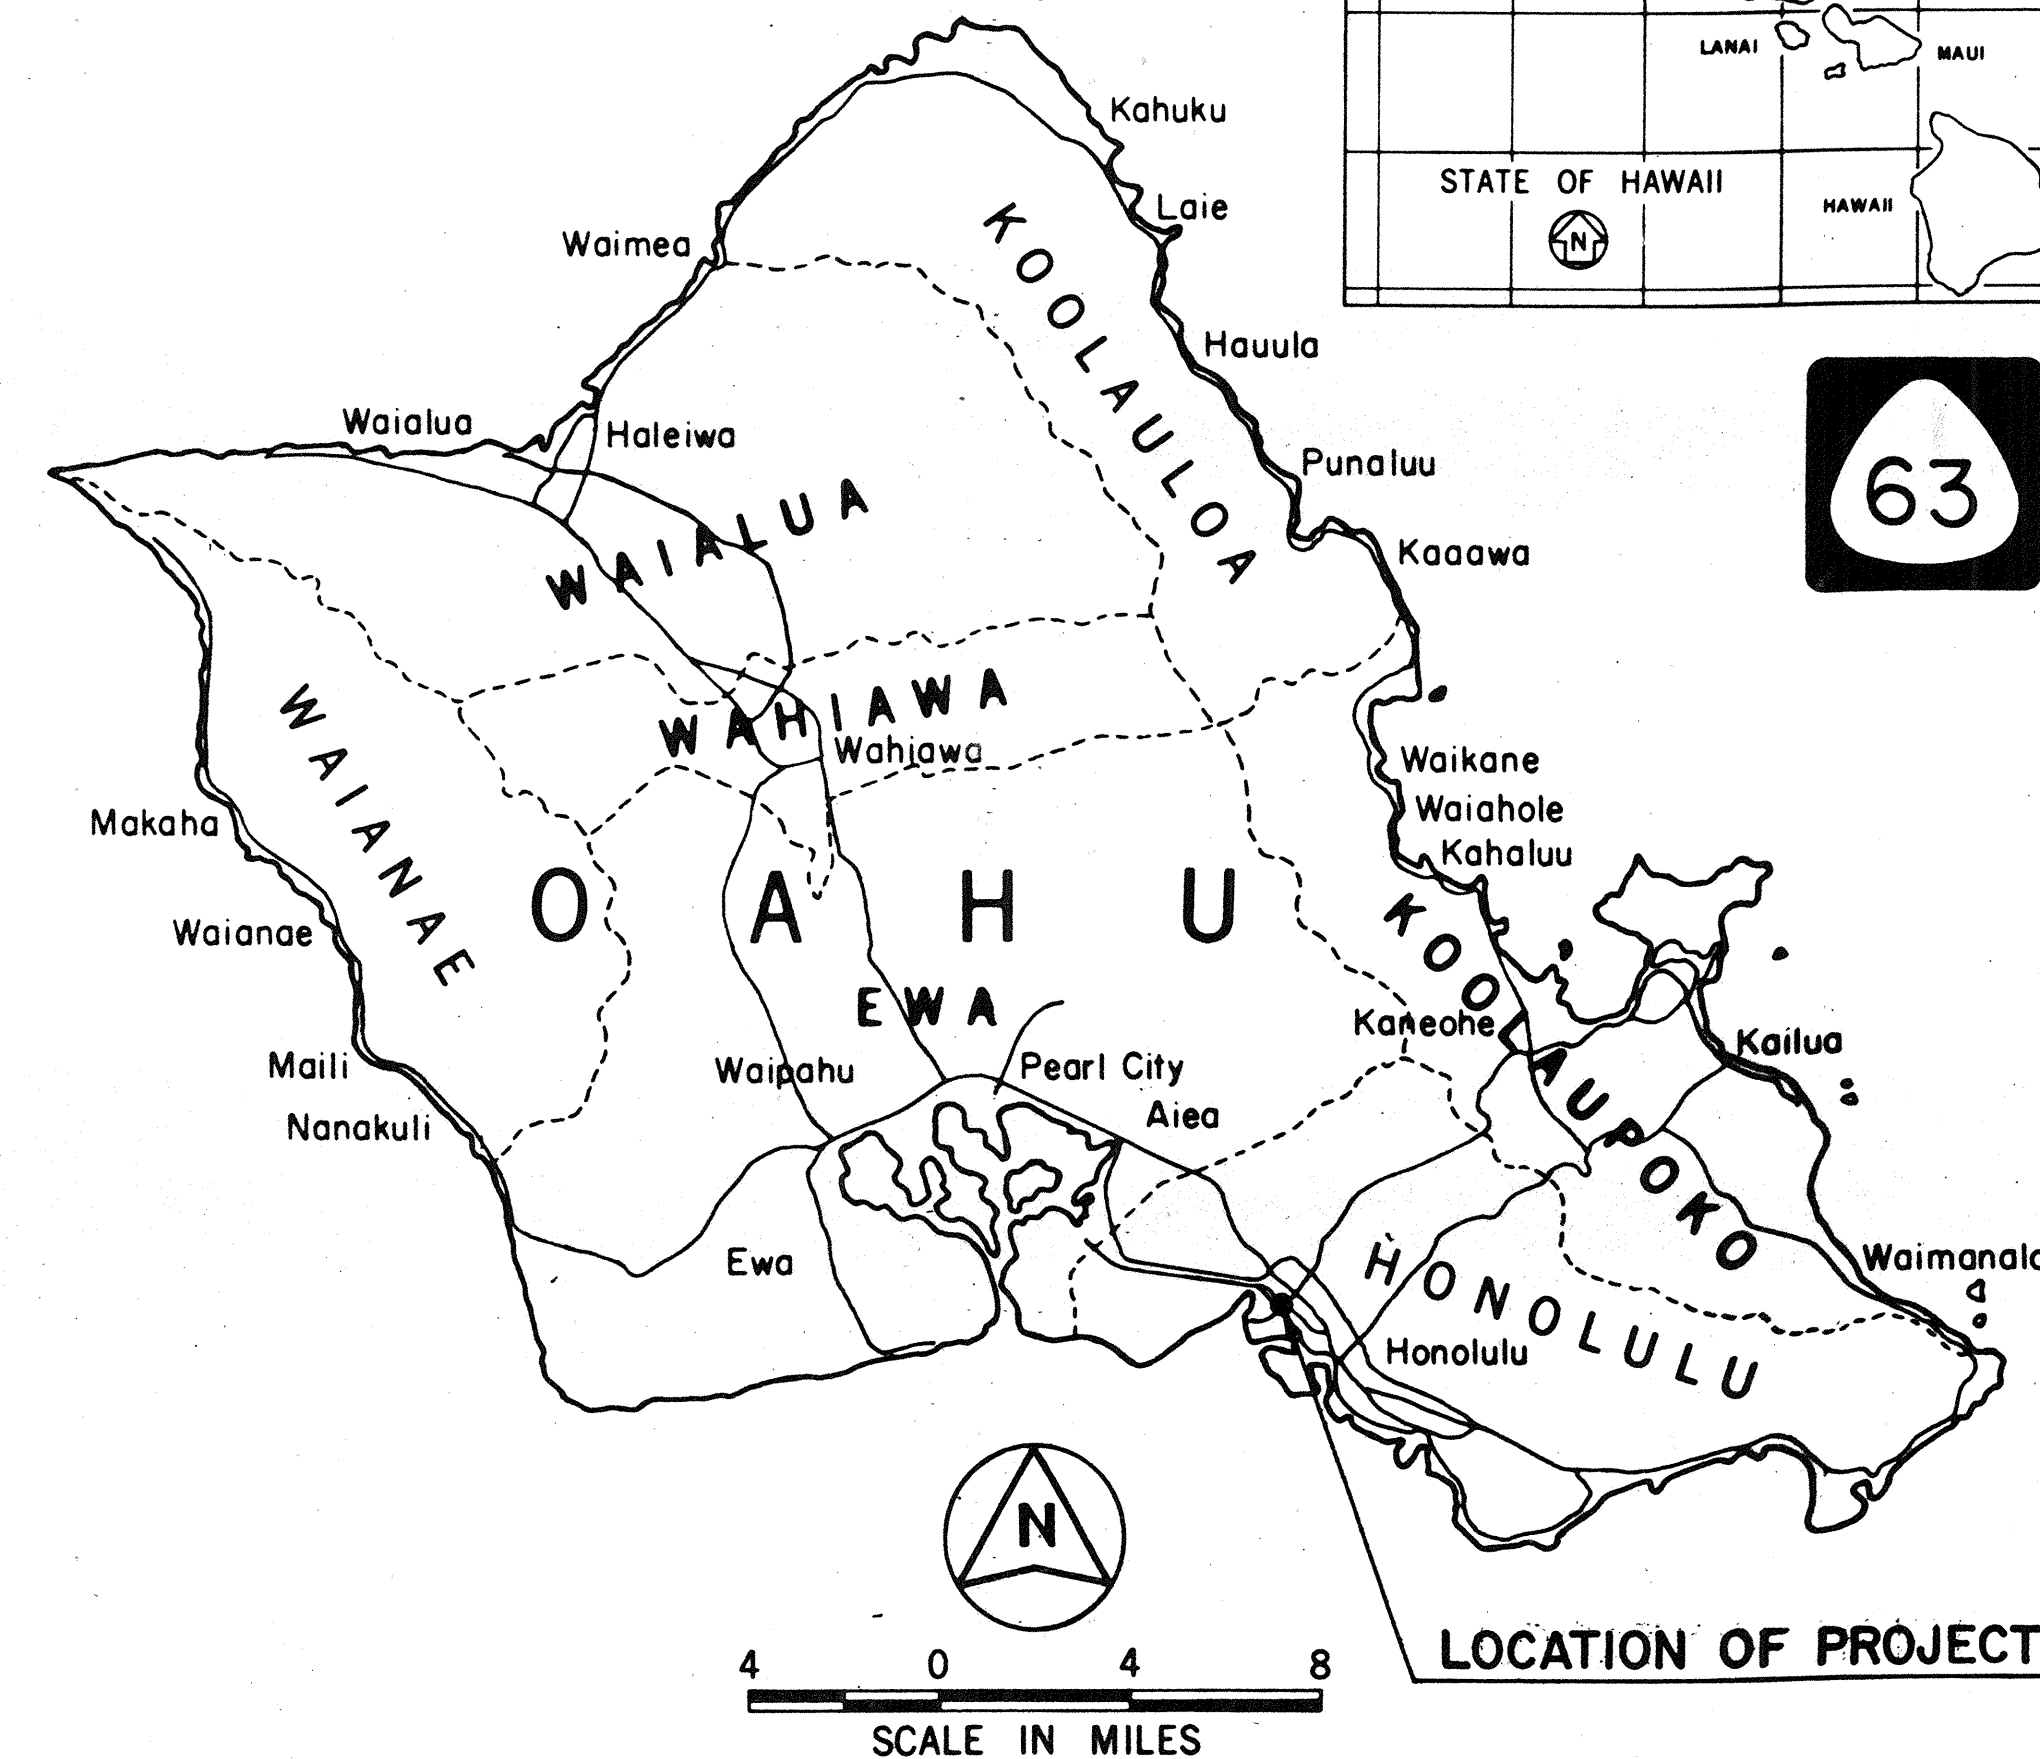


INDEX TO DRAWINGS	
SHEET NO.	DESCRIPTION
1	TITLE SHEET
2	STANDARD PLANS SUMMARY
3 - 4	NOTES, ABBREVIATIONS AND LEGEND
5 - 7	PLAN AND PROFILE
8	INTERSECTION PLANS
9	DRIVEWAY LAYOUT PLAN
10	MISC. DETAILS (TYP. ROAD SECT.)
11 - 12	DRAIN DETAILS
13	UTILITY PROFILES
14 - 15	TRAFFIC CONTROL PLANS AND NOTES, CONSTRUCTION SEQUENCING NOTES
16	SIGNING AND PAVEMENT MARKING PLAN
17 - 19	ELECTRICAL PLANS
20	ELECTRICAL NOTES AND DETAILS
21	TRAFFIC SIGNAL SYSTEM PLAN AT KALANI STREET
22	PULLBOX & COVER DETAILS
23	CROSS SECTIONS

STATE OF HAWAII
DEPARTMENT OF TRANSPORTATION
HIGHWAYS DIVISION
HONOLULU, HAWAII
"AS-BUILT"
PLANS FOR
KALIHI STREET IMPROVEMENTS
NIMITZ HIGHWAY TO DILLINGHAM BOULEVARD
PROJECT NO. 63A-02-89
DISTRICT OF HONOLULU
ISLAND OF OAHU

FED. ROAD DIST. NO.	STATE	PROJ. NO.	FISCAL YEAR	SHEET NO.	TOTAL SHEETS
HAWAII	HAW.	63A-02-89	1991	1	23

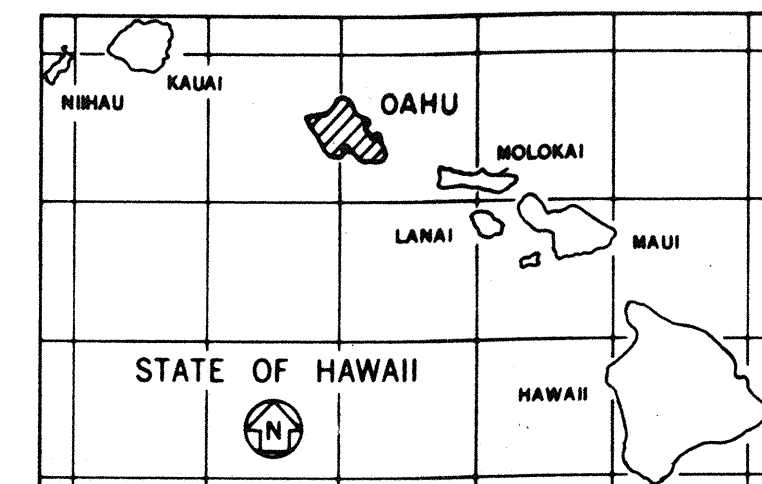

LENGTH OF PROJECT 0.228 MILES

LAYOUT PLAN

ALL CHANGES MADE DURING CONSTRUCTION HAVE BEEN NOTED IN RED ON THESE TRACINGS AND CHECKED BY

Sidney S. C. Lee 2/27/97
RESIDENT ENGINEER DATE

APPROVED: _____
DIRECTOR, DEPARTMENT OF TRANSPORTATION SERVICES DATE
CITY AND COUNTY OF HONOLULU
(FOR CONSTRUCTION WITHIN CITY R/W ONLY)

DEPARTMENT OF TRANSPORTATION
STATE OF HAWAII
APPROVED: Edward J. Smith 11/2/90
DIR. OF TRANSPORTATION DATE

DD-B-6-1