

C:\CAS\151\TILESHT 9/23/91


ORIGINAL PLAN	DATE
DRAWN BY	
CHECKED BY	
NOTES	
NO.	

DESIGN BY PAREN, INC. HERBERT TAO
DATE 9-23-91
PHONE 587-2124
P. S. & E. BY


INDEX TO DRAWINGS

SHEET NO.	DESCRIPTION
1	TITLE SHEET
2	STANDARD PLANS SUMMARY
3	DRAINAGE MAP
4 TO 6	NOTES
7	TYPICAL ROAD SECTIONS AND MISC. DETAILS
	PLAN AND PROFILE:
8	PO'OKELA STREET EXTENSION (0+42 TO 11+00)
9	PO'OKELA STREET EXTENSION (11+00 TO 22+69)
10	ROAD "A"
11	PO'OKELA STREET CUL-DE-SAC
12	KEAAHALA ROAD INTERIM WIDENING
13	GRADING PLAN "A"
14	GRADING PLAN "B"
15, 16	DRAINAGE SUMMARY
17	20'-0" X 10'-0" BOX CULVERT SECTIONS, DETAILS AND NOTES
18	BOX CULVERT AND CHANNEL PLAN AND SECTIONS
19	RC AND CRM CHANNEL WALL SECTION AND OTHER DETAILS
20	JOINT DETAILS
21	GRAVEL COMPACTION PILING PLAN
22	DRAINAGE PROFILES
23, 24	DRAINAGE DETAILS
25	WATER DETAILS
26	CROSS SECTION KEY MAP AND BORING LOCATIONS
27 TO 35	CROSS SECTIONS
36 TO 38	SIGNING AND STRIPING PLAN
39	SIGNING AND STRIPING DETAIL
40	STREET TREE PLAN
41	STREET TREE LIST, DETAILS AND NOTES
42	BORING LOGS
43	BORING AND PROBE LOGS
44 TO 49	ELECTRICAL PLANS

STATE OF HAWAII
DEPARTMENT OF TRANSPORTATION
HIGHWAYS DIVISION
HONOLULU, HAWAII
PLANS FOR
CONSTRUCTION OF
CASTLE HILLS ACCESS ROAD
PROJECT NO. HWY-0-05-91
DISTRICT OF KOOLAUPOKO
ISLAND OF OAHU

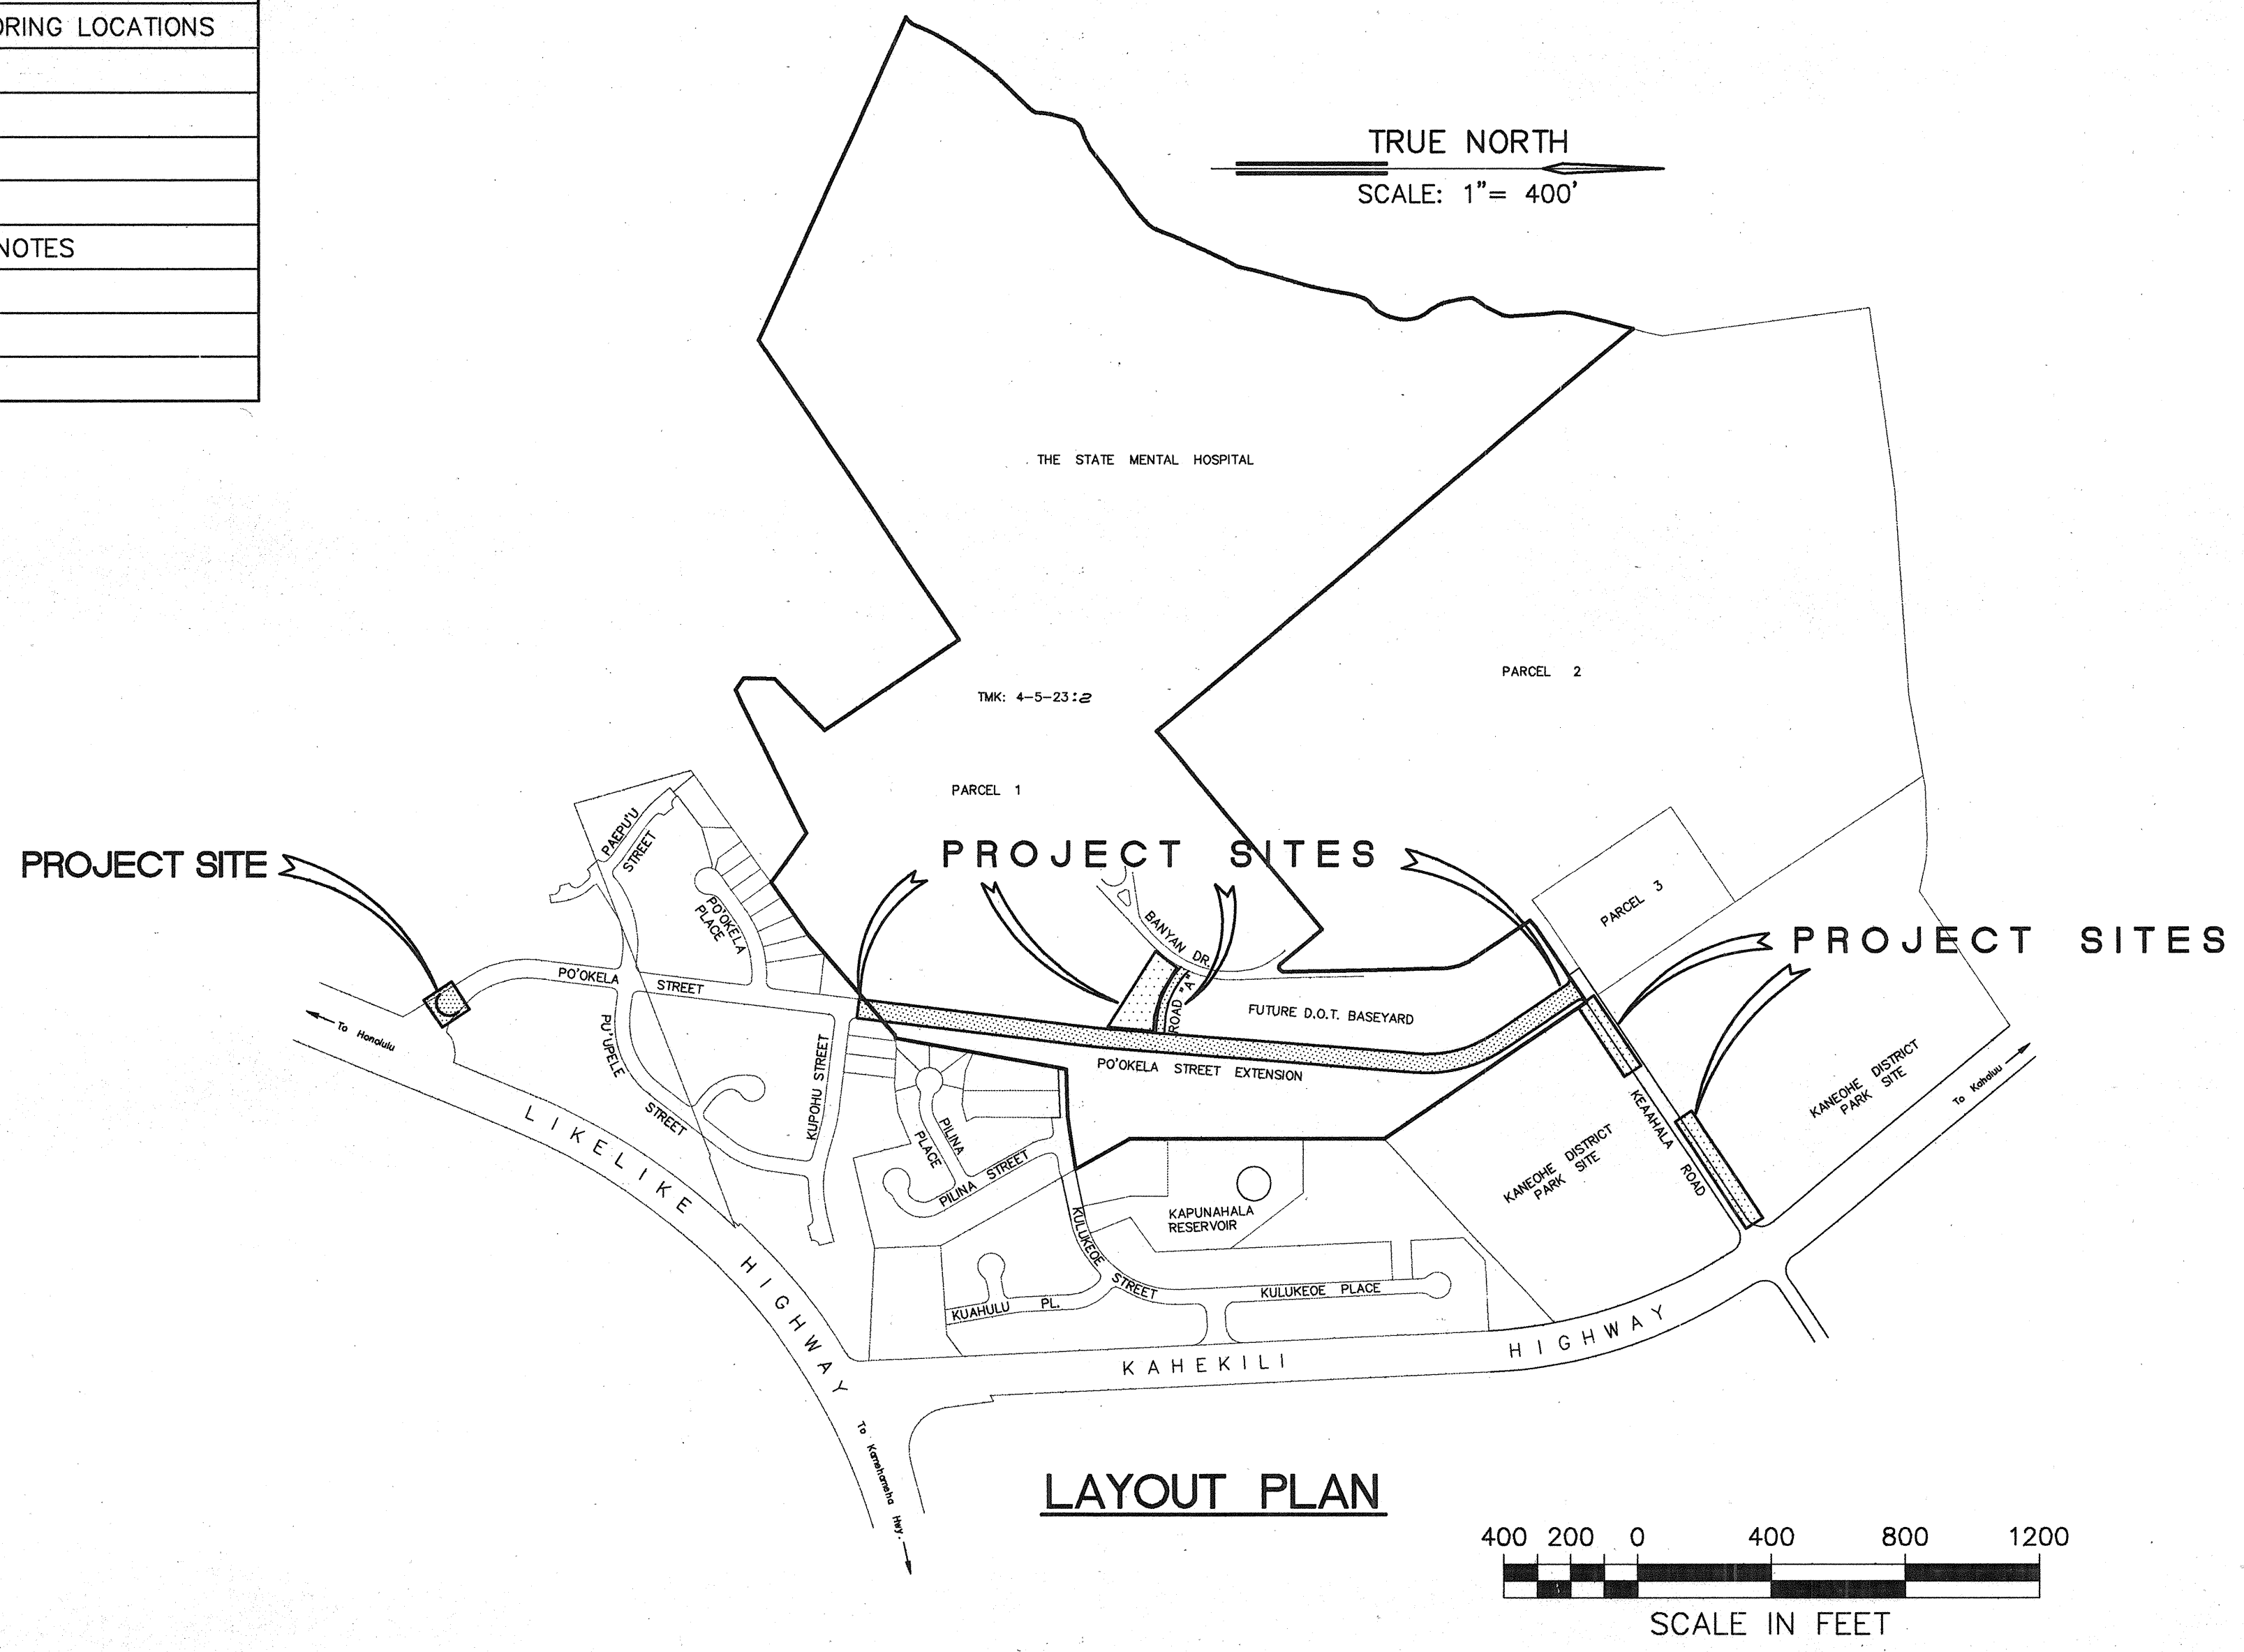

FED. ROAD DIS. NO.	STATE	PROJ. NO.	FISCAL YEAR	SHEET NO.	TOTAL SHEETS
HAWAII	HAW.	HWY-0-05-91	1992	1	49

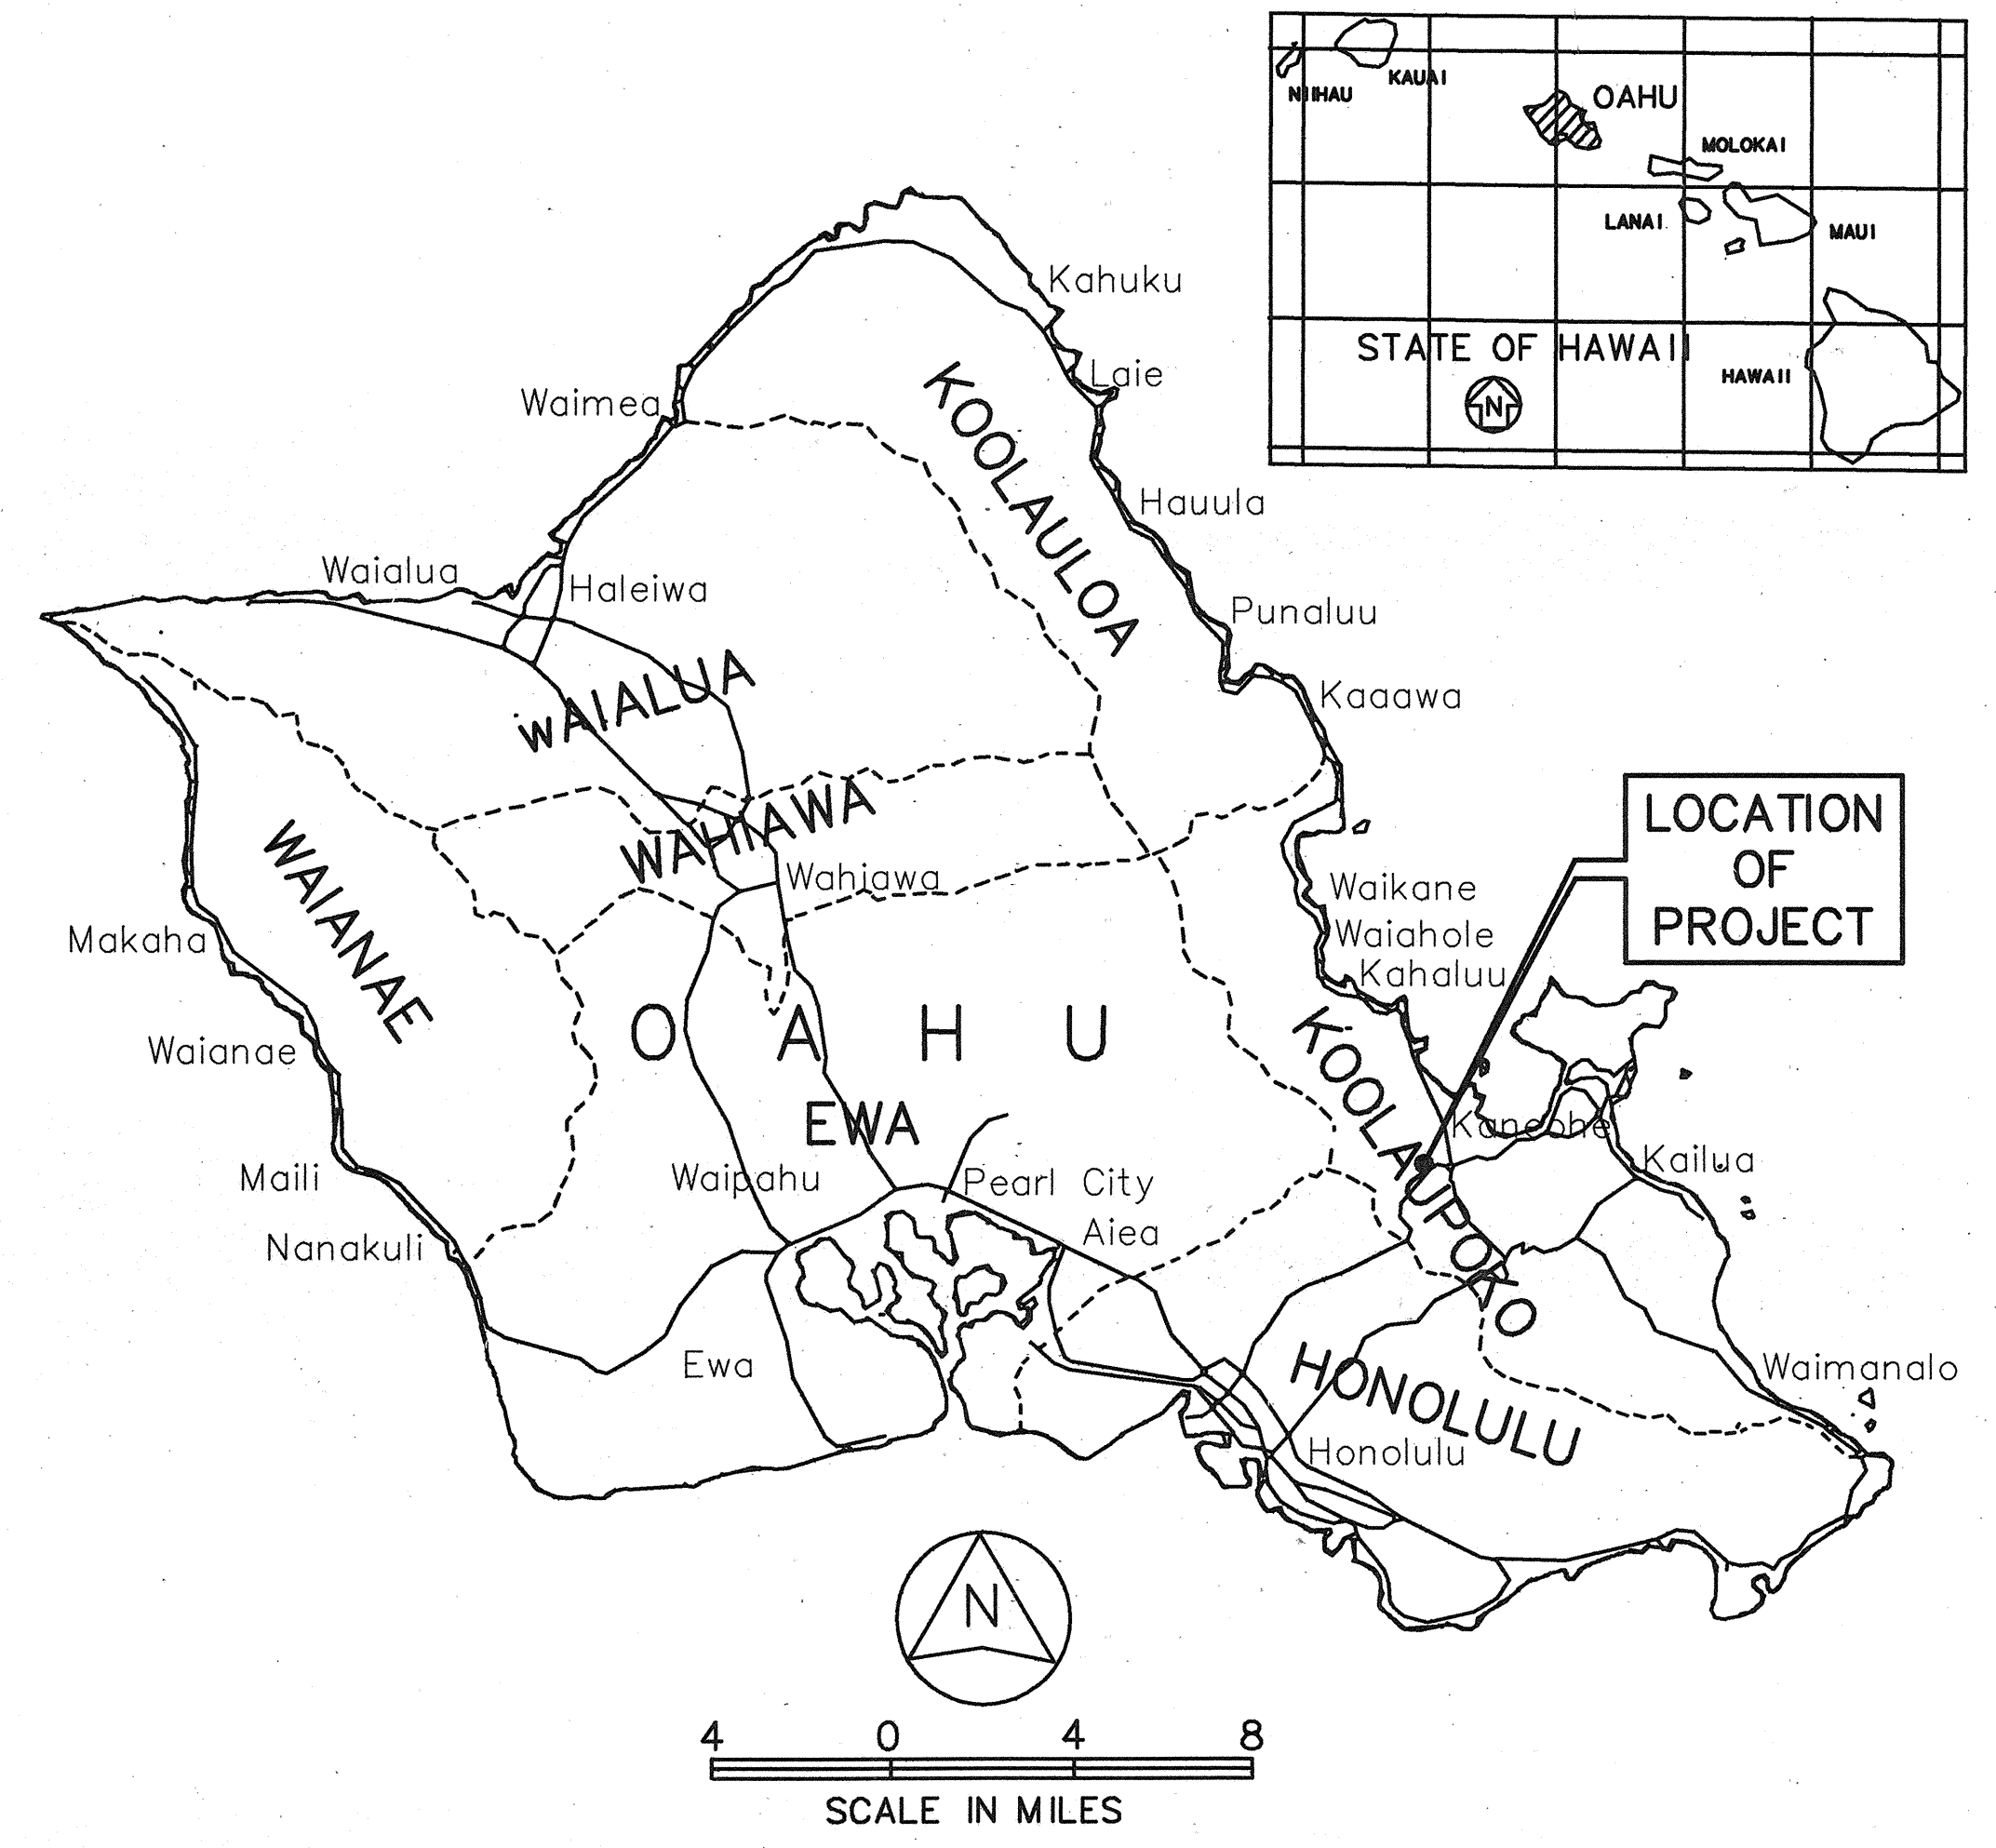

DEPARTMENT OF TRANSPORTATION
STATE OF HAWAII
APPROVED:
DIR. OF TRANSPORTATION
DATE 9/23/91