


FED. ROAD DIST. NO.	STATE	FED. AID PROJ. NO.	FISCAL YEAR	SHEET NO.	TOTAL SHEETS
HAWAII	HAW.	STP-063-1(22)	2003	57	69

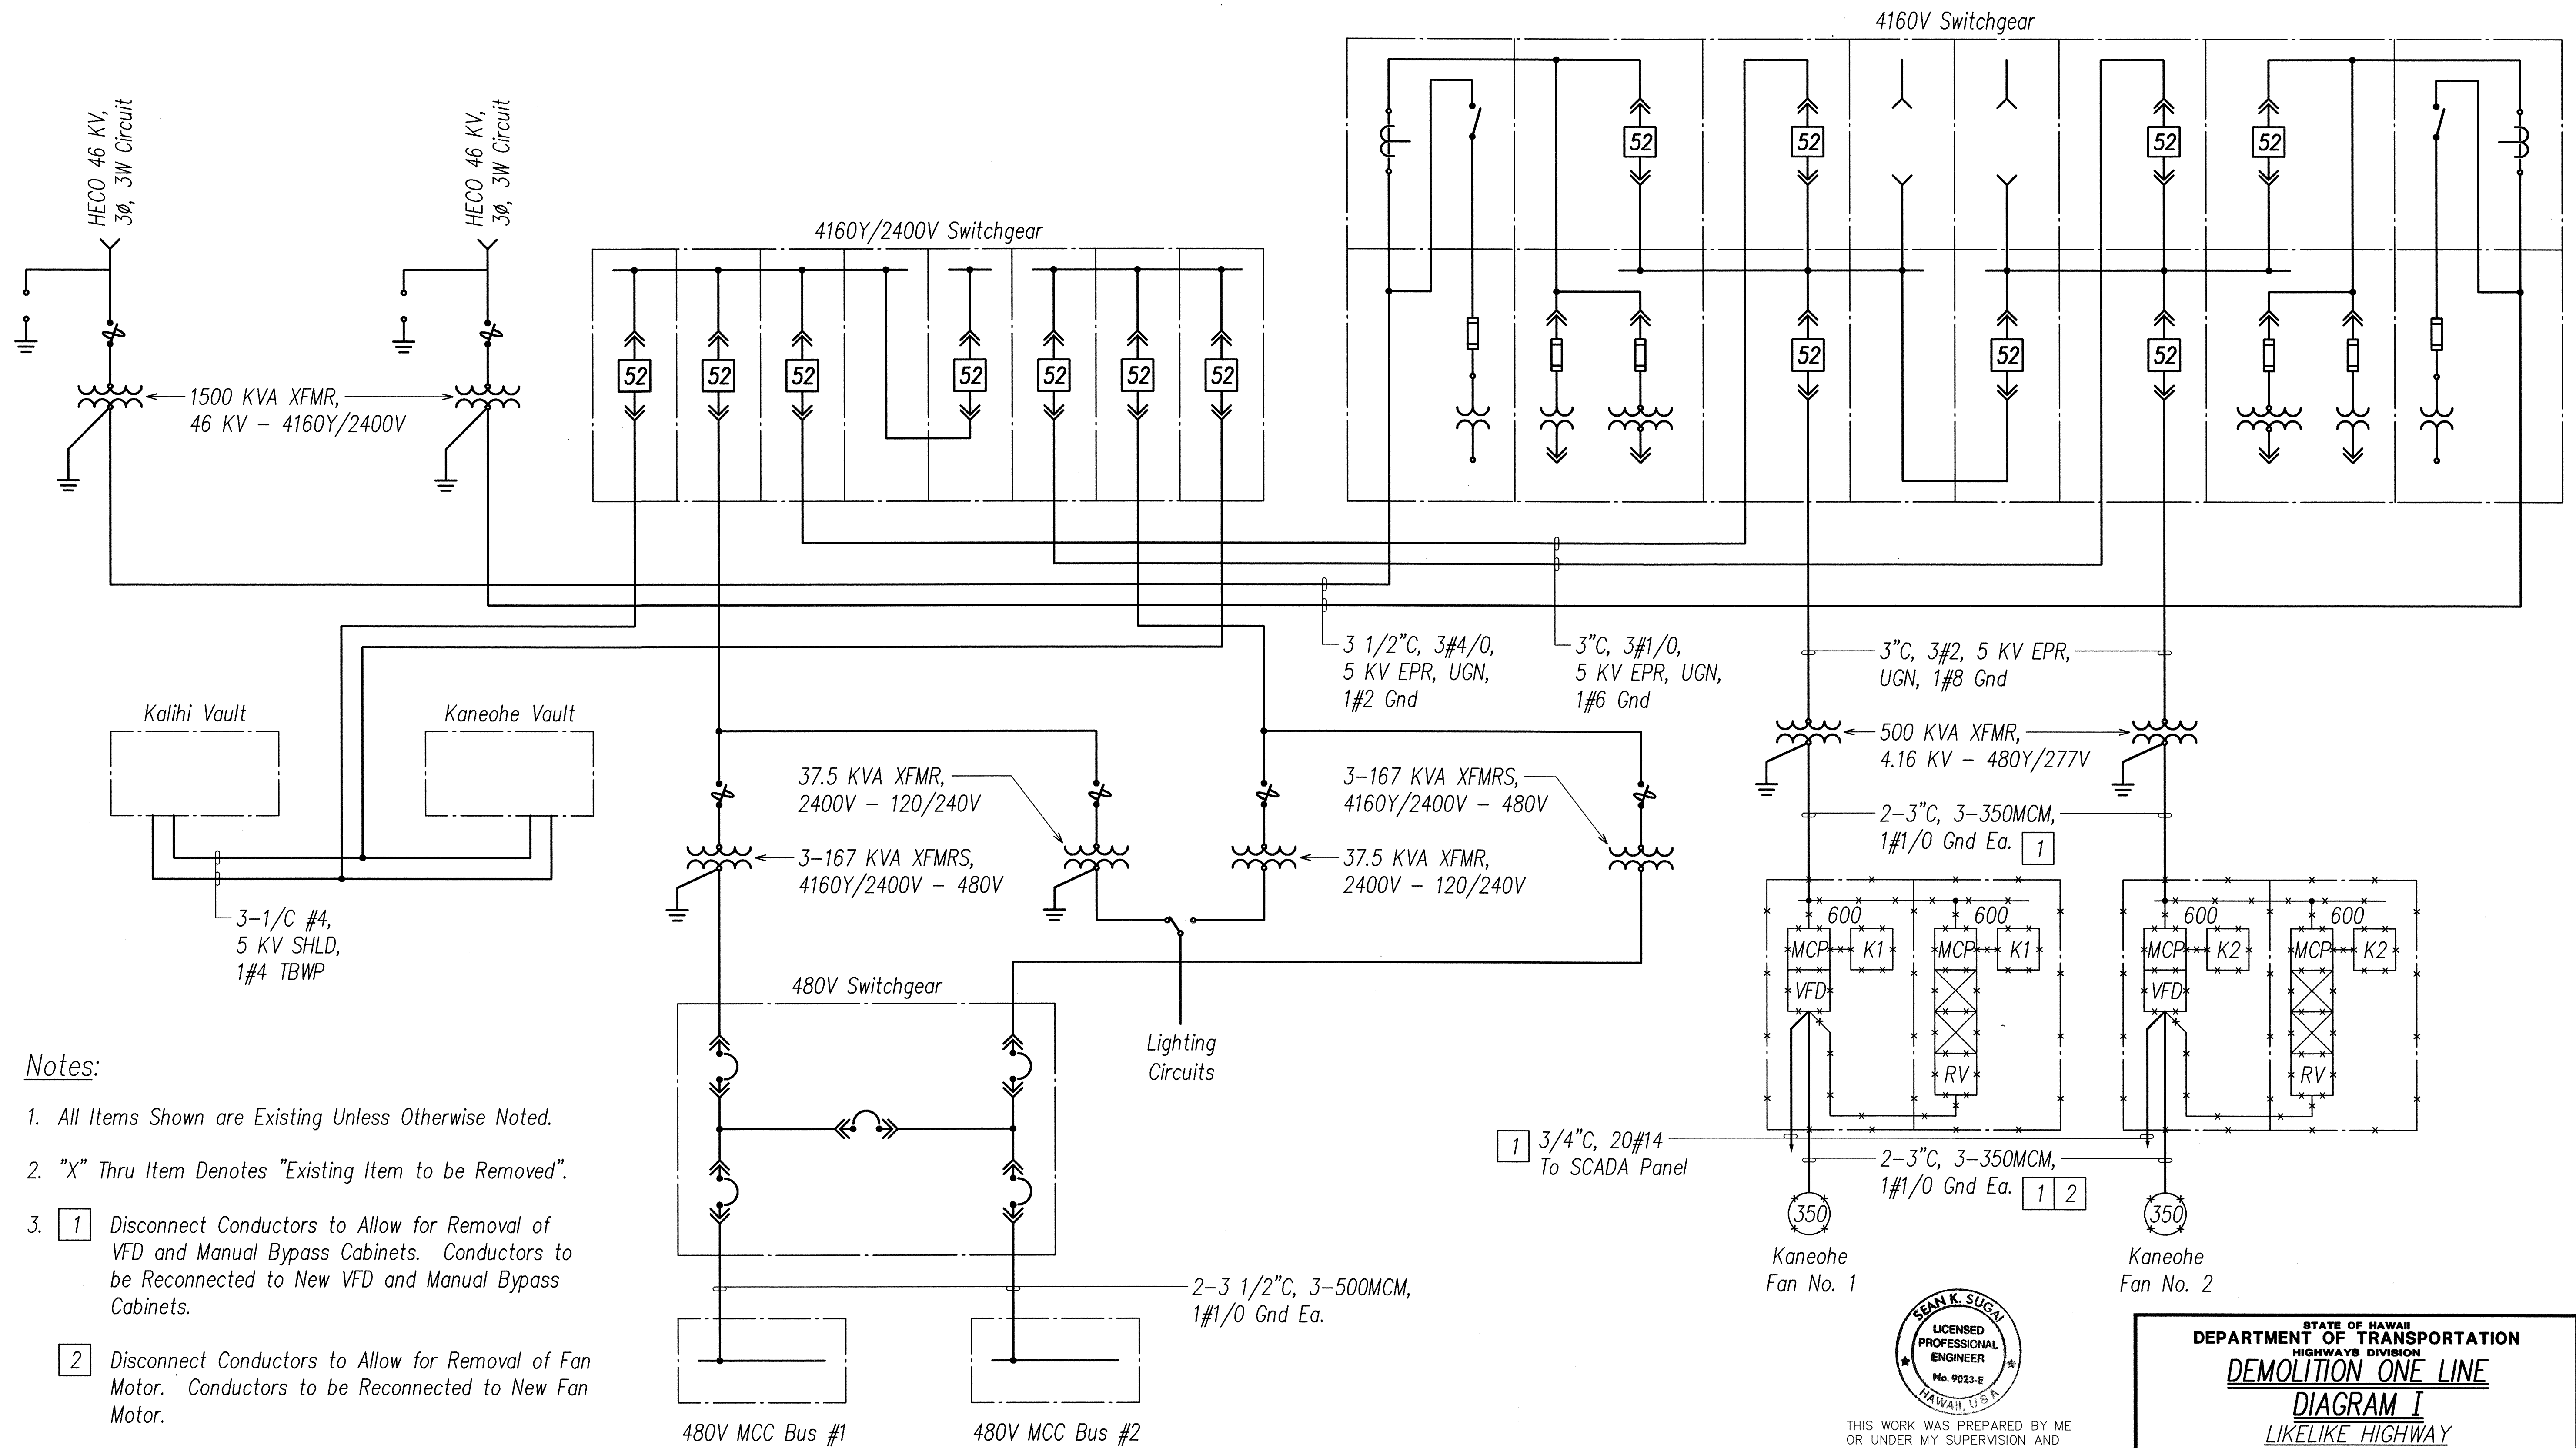

Notes:

1. All Items Shown are Existing Unless Otherwise Noted.
2. "X" Thru Item Denotes "Existing Item to be Removed".
3. 1 Disconnect Conductors to Allow for Removal of VFD and Manual Bypass Cabinets. Conductors to be Reconnected to New VFD and Manual Bypass Cabinets.
4. 2 Disconnect Conductors to Allow for Removal of Fan Motor. Conductors to be Reconnected to New Fan Motor.

DEMOLITION ONE LINE DIAGRAM I

DATE	_____
SURVEYED BY	_____
DRAWN BY	_____
DESIGNED BY	_____
CHECKED BY	_____
ORIGINAL PLAN	_____
NOTE BOOK	_____
No.	_____

LAST SAVE: 04/22/03 @ 15:03:14 BY: BO PLOT SC: 11-01-01
C:\WORK\PROJECTS\2003\2003-063\2003-063.dwg





THIS WORK WAS PREPARED BY ME
OR UNDER MY SUPERVISION AND
CONSTRUCTION OF THIS PROJECT
WILL BE UNDER MY OBSERVATION.

Signature: *Sean K. Sugai*
Date: April 30, 2004
Expiration Date of License: 4/30/05

STATE OF HAWAII
DEPARTMENT OF TRANSPORTATION
HIGHWAYS DIVISION
**DEMOLITION ONE LINE
DIAGRAM I**
LIKELIKE HIGHWAY
Wilson Tunnel Improvements
Leak and Crack Remediation
F. A. Project No. STP-063-1(22)
Scale: None Date: April 24, 2003
SHEET No. E-10 OF 17 SHEETS


FED. ROAD DIST. NO.	STATE	FED. AID PROJ. NO.	FISCAL YEAR	SHEET NO.	TOTAL SHEETS
HAWAII	HAW.	STP-063-1(22)	2003	58	69

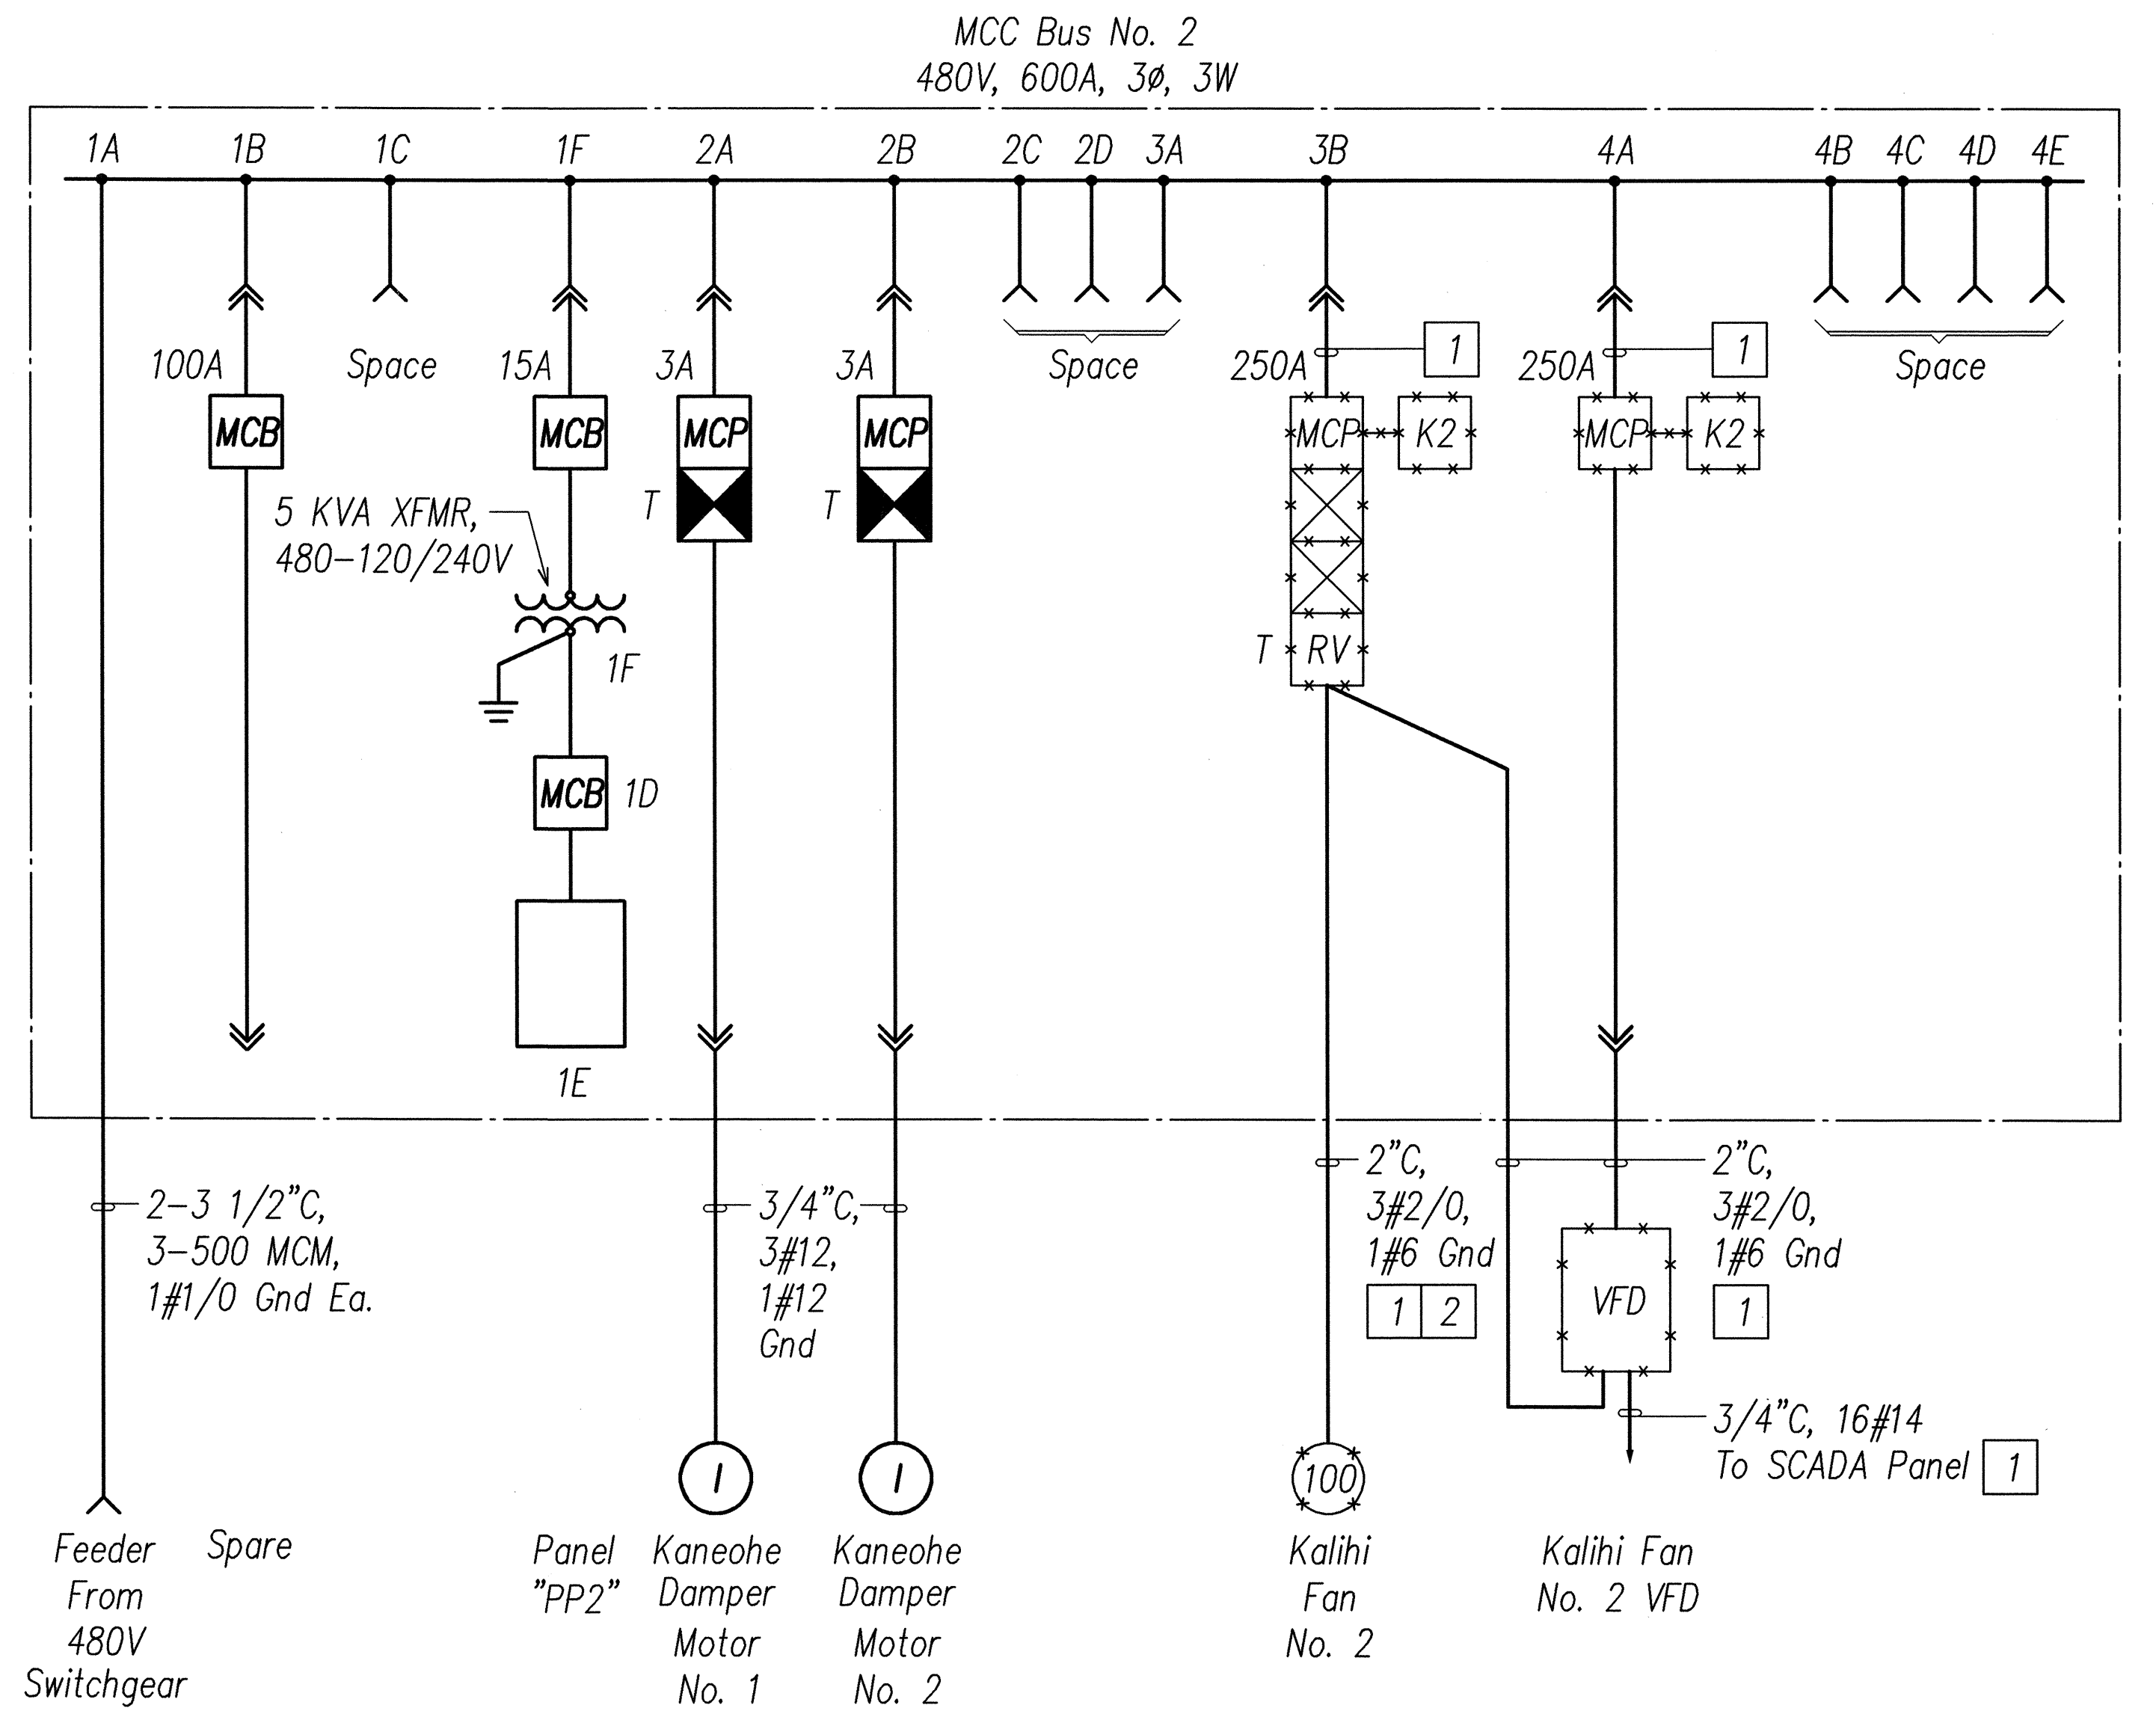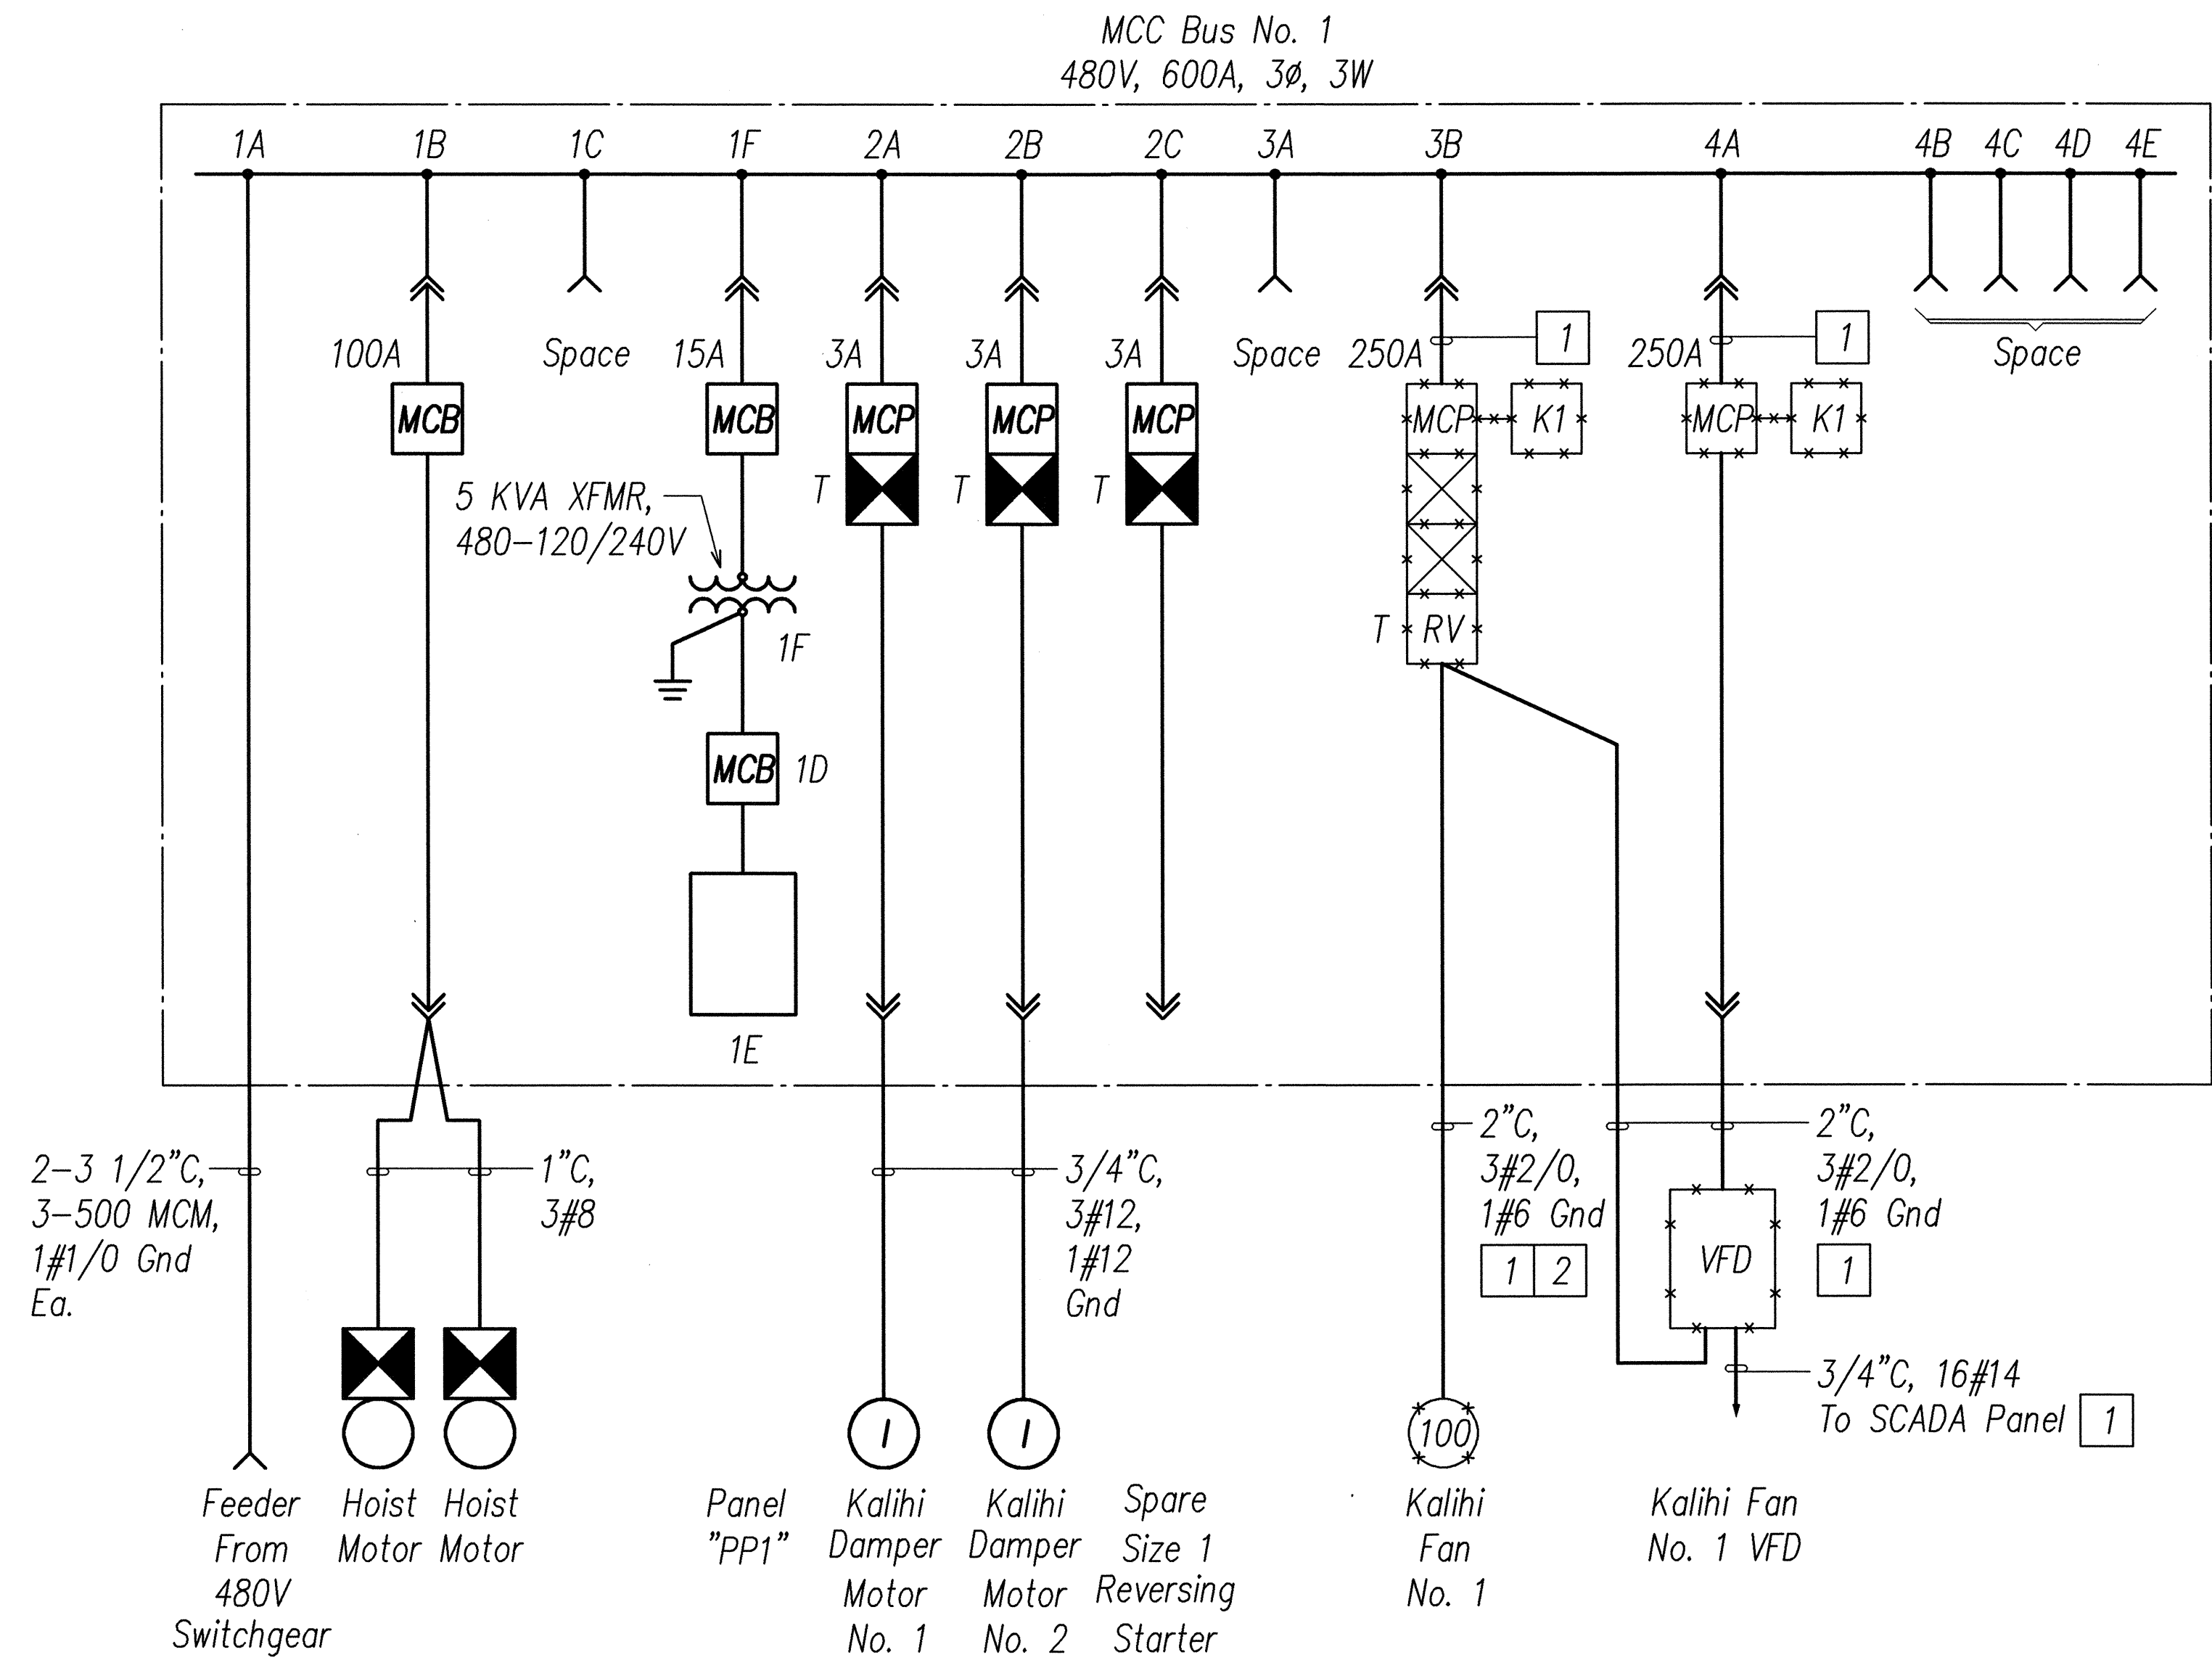

Notes:

1. All Items Shown are Existing Unless Otherwise Noted.
2. "X" Thru Item Denotes "Existing Item to be Removed".
3. 1 Disconnect Conductors to Allow for Removal of VFD & Manual Bypass Cabinets. Conductors to be Reconnected to New VFD & Manual Bypass Cabinets.
4. 2 Disconnect Conductors to Allow for Removal of Fan Motor. Conductors to be Reconnected to New Fan Motor.

DEMOLITION ONE LINE DIAGRAM II

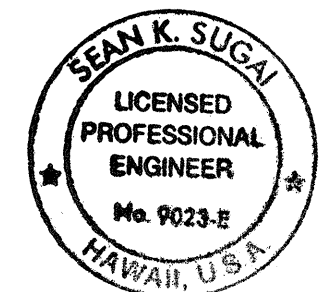

THIS WORK WAS PREPARED BY ME OR UNDER MY SUPERVISION AND CONSTRUCTION OF THIS PROJECT WILL BE UNDER MY OBSERVATION.

Signature: *Sean K. Sugan* April 30, 2004
4/22/04 EXPIRATION DATE OF THE LICENSE

STATE OF HAWAII
DEPARTMENT OF TRANSPORTATION
HIGHWAYS DIVISION
DEMOLITION ONE LINE
DIAGRAM II
LIKELIKE HIGHWAY
Wilson Tunnel Improvements
Leak and Crack Remediation
F. A. Project No. STP-063-1(22)
Scale: None Date: April 24, 2003
SHEET No. E-11 OF 17 SHEETS