

JOB NO. 46-OL-12

SAND ISLAND PARKWAY INCREMENT I

SAND ISLAND, OAHU, HAWAII

TAX MAP KEY 1-5-41

STATE OF HAWAII


DEPARTMENT OF LAND AND NATURAL RESOURCES
DIVISION OF WATER AND LAND DEVELOPMENT

ACT 195, SLH 1961, ITEM B-II-2, B-61-331-C
ACT 68, SLH 1971, ITEM 4-B-II, B-71-445-C & B-71-470-C

PLANS PREPARED BY:
R. M. TOWILL CORPORATION
PLANNERS, ENGINEERS, SURVEYORS, PHOTOGRAMMETRISTS

"AS BUILT" PLANS

DATE: FEBRUARY 1973

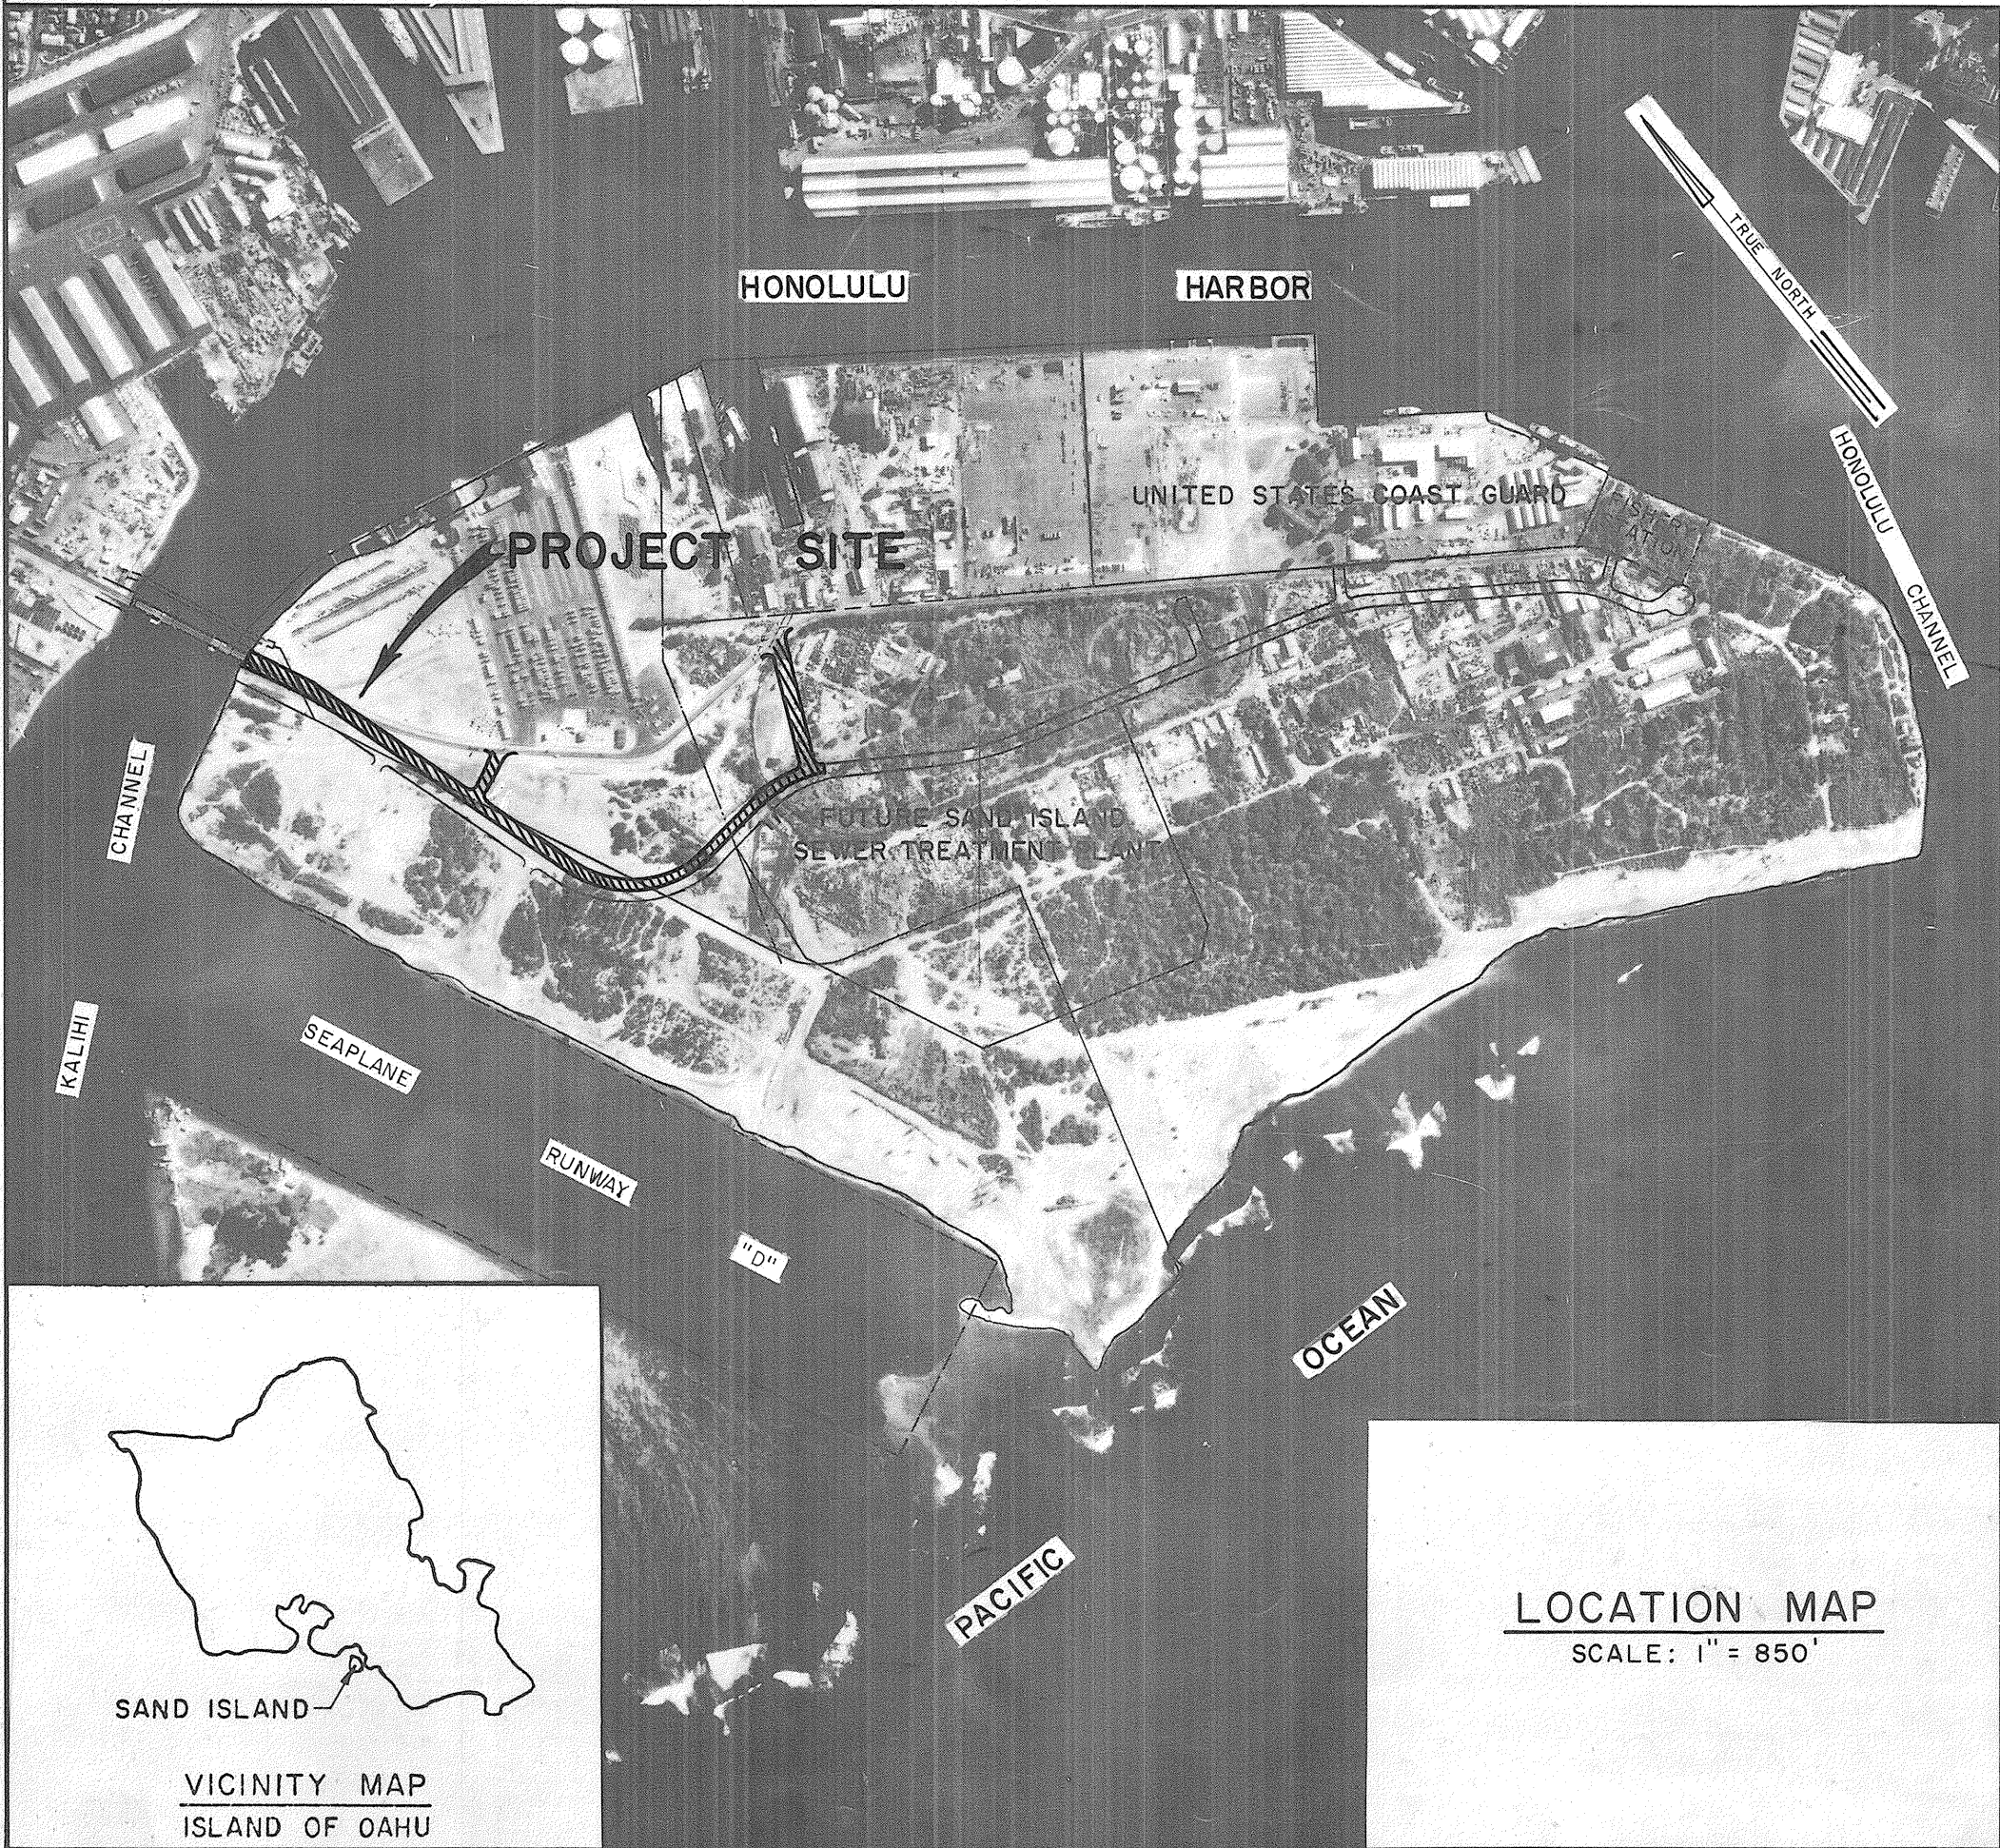

INDEX

DESCRIPTION	SHEET NO.
TITLE SHEET.....	1
GENERAL PLAN.....	C-2
RIGHT-OF-WAY MAP.....	C-3
TYPICAL SECTIONS.....	C-4
PLAN AND PROFILE	
STA. 13+19 TO STA. 26+00.....	C-5
STA. 26+00 TO STA. 38+24.39.....	C-6
STA. 38+24.39 TO STA. 44+82.88.....	C-7
ROAD "A".....	C-8
ROAD "B".....	C-9
INTERSECTION DETAILS.....	C-10 & C-11
SIGNING AND STRIPING PLANS.....	C-12 & C-13
DRAIN DETAILS.....	C-14 & C-15
STATE STANDARD DETAILS.....	C-16 TO C-34
CROSS SECTIONS.....	C-35 TO C-37
ELECTRICAL PLANS.....	E-1 TO E-4
LANDSCAPING PLANS.....	L-1 TO L-5

APPROVED:

<i>Christopher Cobb</i> CHAIRMAN AND MEMBER BOARD OF LAND AND NATURAL RESOURCES STATE OF HAWAII	2/10/75 DATE
<i>Robert H. Chuck</i> MANAGER - CHIEF ENGINEER DIVISION OF WATER AND LAND DEVELOPMENT, DEPARTMENT OF LAND AND NATURAL RESOURCES STATE OF HAWAII	2/10/75 DATE
<i>Shirley Smith</i> CHIEF ENVIRONMENTAL PROTECTION AND HEALTH SERVICE DIVISION STATE OF HAWAII	7/17/74 DATE
<i>E. Alvey Thayer</i> DIRECTOR, DEPARTMENT OF TRANSPORTATION STATE OF HAWAII	2/7/75 DATE
<i>Forrest Hayes</i> APPROVED FOR GRADING ONLY: DIRECTOR AND CHIEF ENGINEER, DEPARTMENT OF PUBLIC WORKS CITY AND COUNTY OF HONOLULU	10/17/74 DATE
<i>Russ Green</i> MANAGER AND CHIEF ENGINEER, BOARD OF WATER SUPPLY CITY AND COUNTY OF HONOLULU	11/8/74 DATE