


INDEX TO DRAWINGS	
SHEET NO.	DESCRIPTION
1	TITLE SHEET
2	STANDARD PLANS SUMMARY
3 - 5	CONSTRUCTION NOTES, ABBREVIATIONS, LEGEND
6 - 9	TYPICAL ROAD SECTIONS
10 - 14	PLAN & PROFILE
15	SUPERELEVATION DIAGRAM
16 - 23	DETAIL ROADWAY PLAN
24	EROSION CONTROL PLAN
25	NPDES GENERAL NOTES
26 - 28	MISCELLANEOUS DETAILS
29 - 34	UTILITY PLAN AND PROFILE, DETAILS
35 - 57	DRAINAGE SUMMARY, DRAINAGE PLAN AND PROFILE, GENERAL DRAINAGE MAP, DRAINAGE DETAILS, STRUCTURAL DETAILS
58 - 66	TRAFFIC CONTROL PLAN, CONSTRUCTION PHASING PLAN
67 - 71	PAVEMENT MARKING AND TRAFFIC SIGNING PLAN, DETAILS
72 - 74	CROSS SECTIONS
75 - 83	LANDSCAPING PLANS & DETAILS
84 - 95	ELECTRICAL PLANS & DETAILS

Plan Sht. Nos. C.O. 90S-1, C.O. 90S-2 and C.O. 95S-1 are supplementary sheets to this project. TOTAL SHEET COUNT after "AS-BUILT" postings 98 Sheets.

DESIGNED BY
 CALVIN KIM & ASSOC., INC.
 1050 QUEEN ST. STE 300
 P. S. & E. BY
 PRATT KINIMAKA
 587-2124
 PHONE
 587-2124
 DATE
 SEPT. 1993

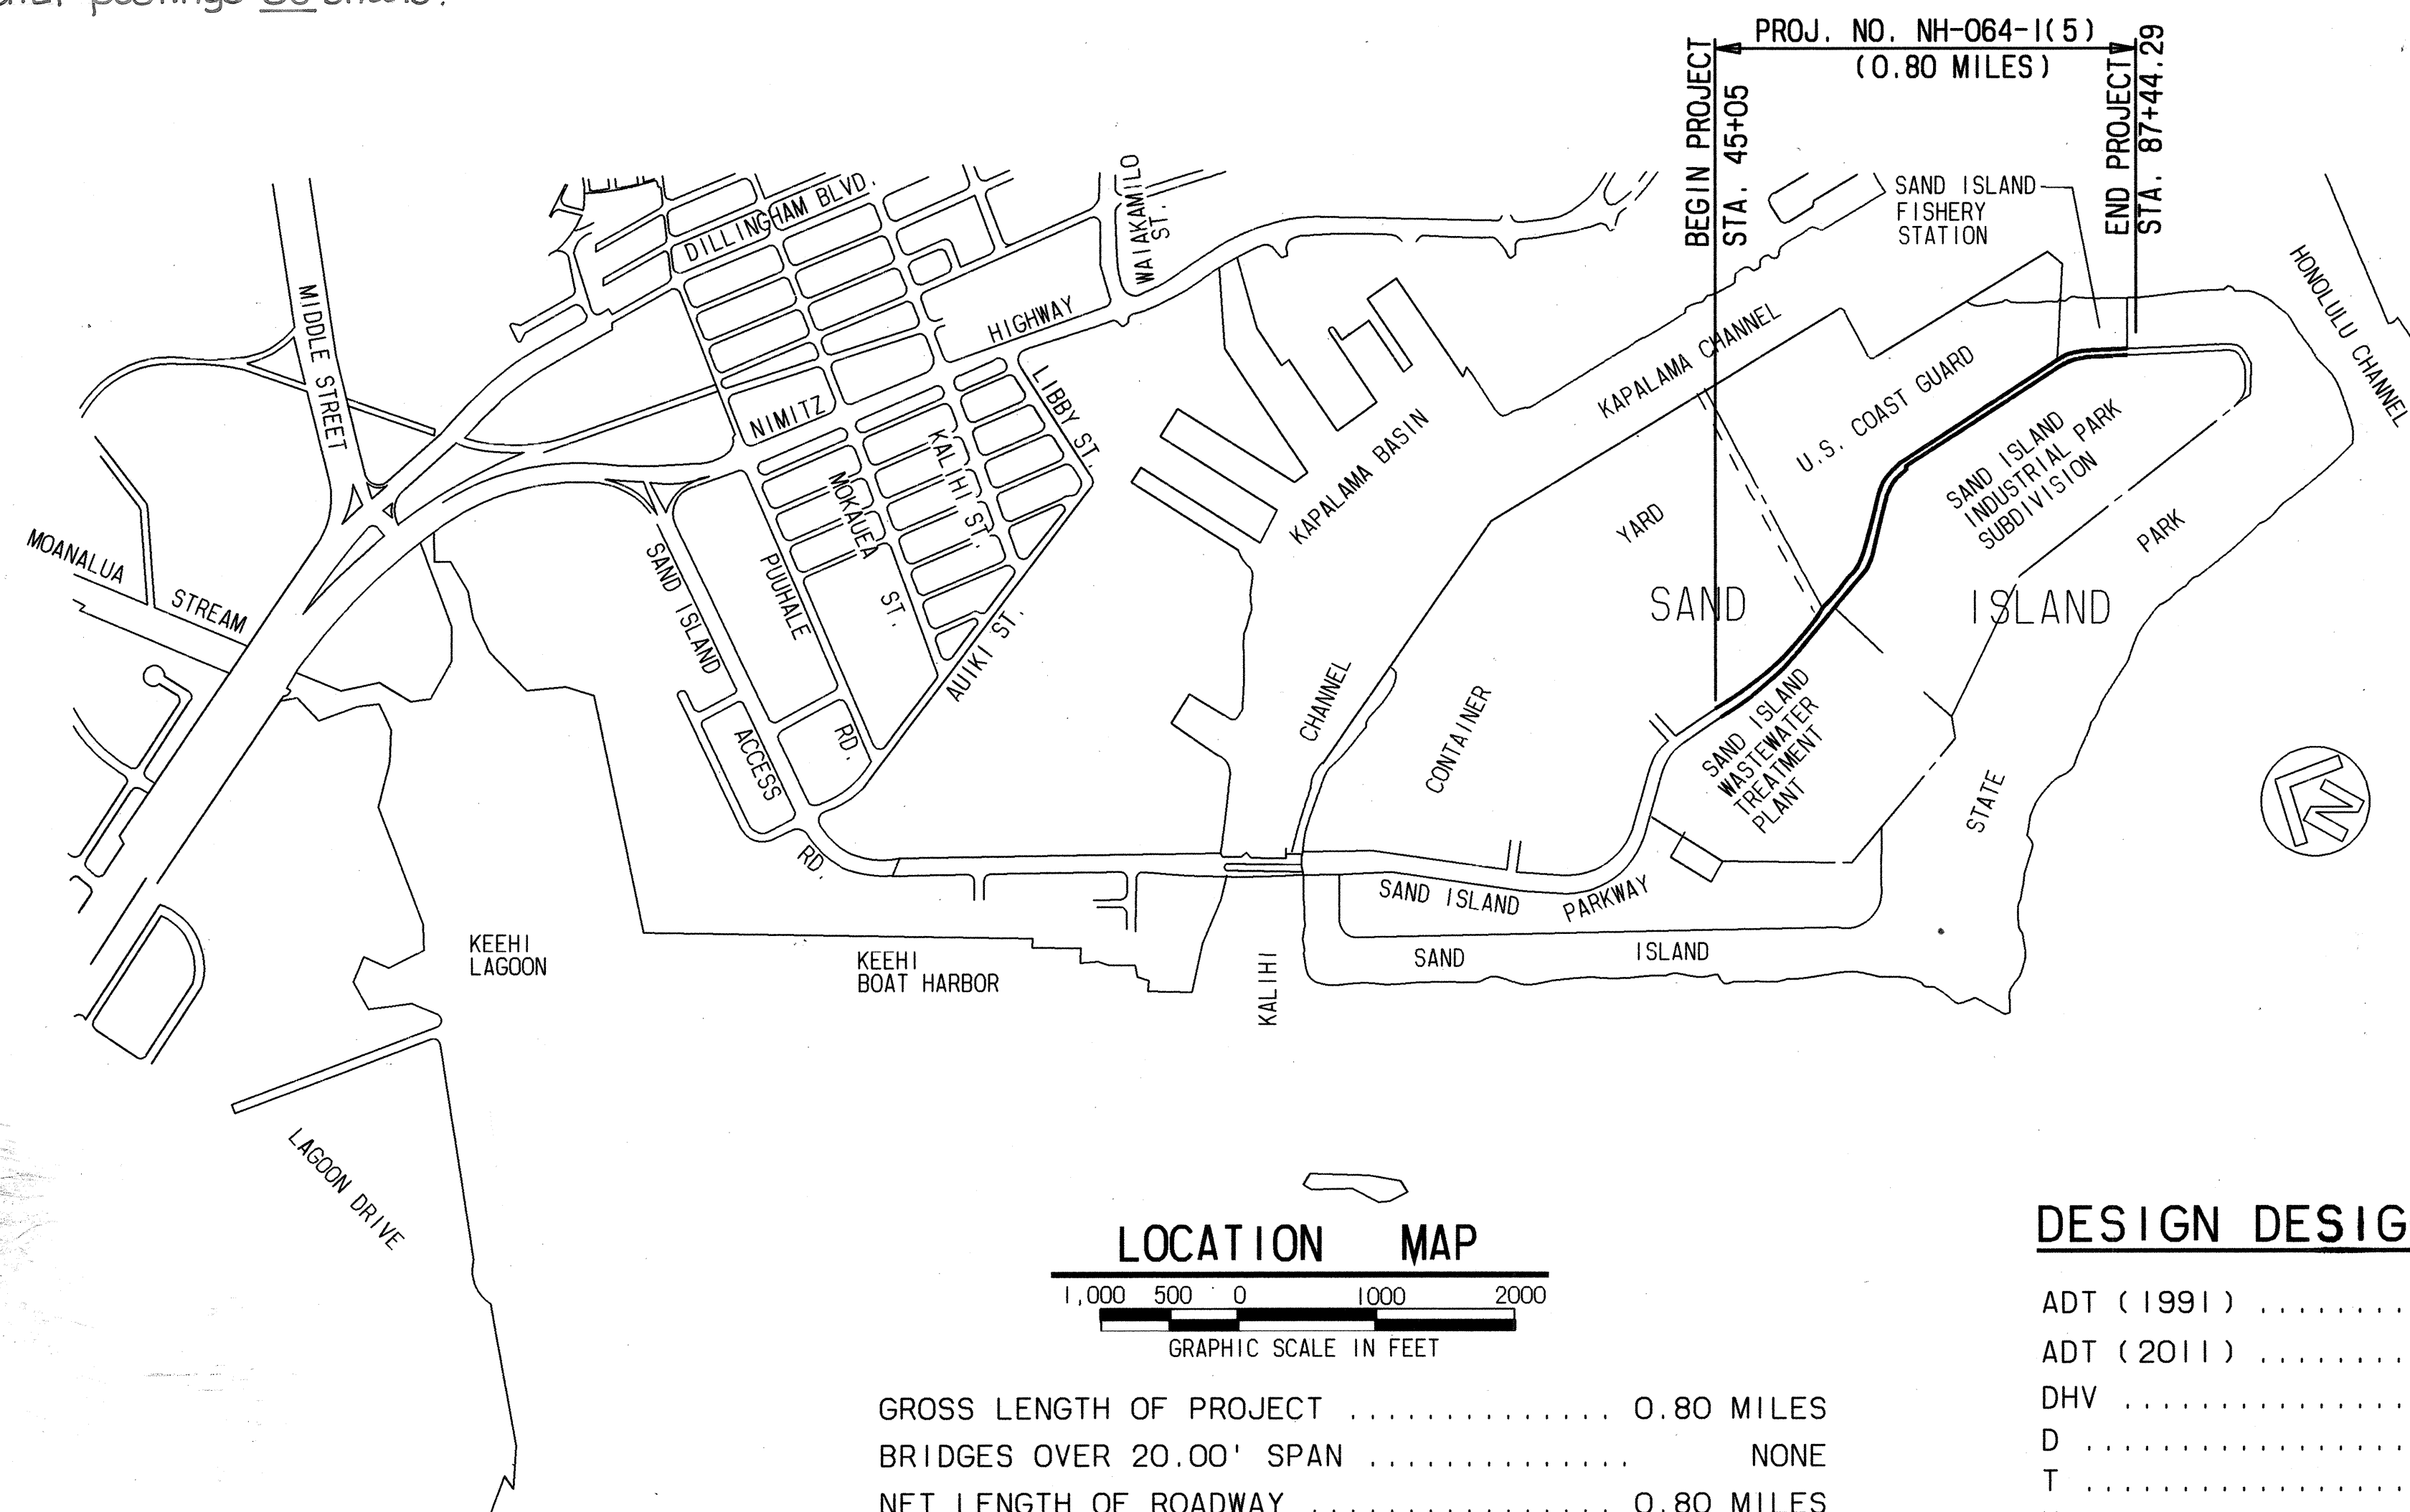

GROSS LENGTH OF PROJECT 0.80 MILES
 BRIDGES OVER 20.00' SPAN NONE
 NET LENGTH OF ROADWAY 0.80 MILES



DESIGN DESIGNATION	
ADT (1991)	7,800
ADT (2011)	13,180
DHV	1,780
D	30/25
T	9 %
V	30 MPH

DEPARTMENT OF TRANSPORTATION
 FEDERAL HIGHWAY ADMINISTRATION
 APPROVED:
Abraham Wong 2/15/94
 DIVISION ADMINISTRATOR DATE

DEPARTMENT OF TRANSPORTATION
 STATE OF HAWAII
 APPROVED:
T. Harano 2/15/94
 FOR DIR. OF TRANSPORTATION DATE

STATE OF HAWAII
 DEPARTMENT OF TRANSPORTATION
 HIGHWAYS DIVISION
 HONOLULU, HAWAII
 "AS-BUILT"
 SAND ISLAND PARKWAY
 TREATMENT PLANT TO PARK ENTRANCE
 FEDERAL AID PROJECT NO. NH-064-1(5)
 DISTRICT OF HONOLULU
 ISLAND OF OAHU

FED. ROAD DIST. NO.	STATE	FED. AID PROJ. NO.	FISCAL YEAR	SHEET NO.	TOTAL SHEETS
HAWAII	HAW.	NH-064-1(5)	1994	1	95

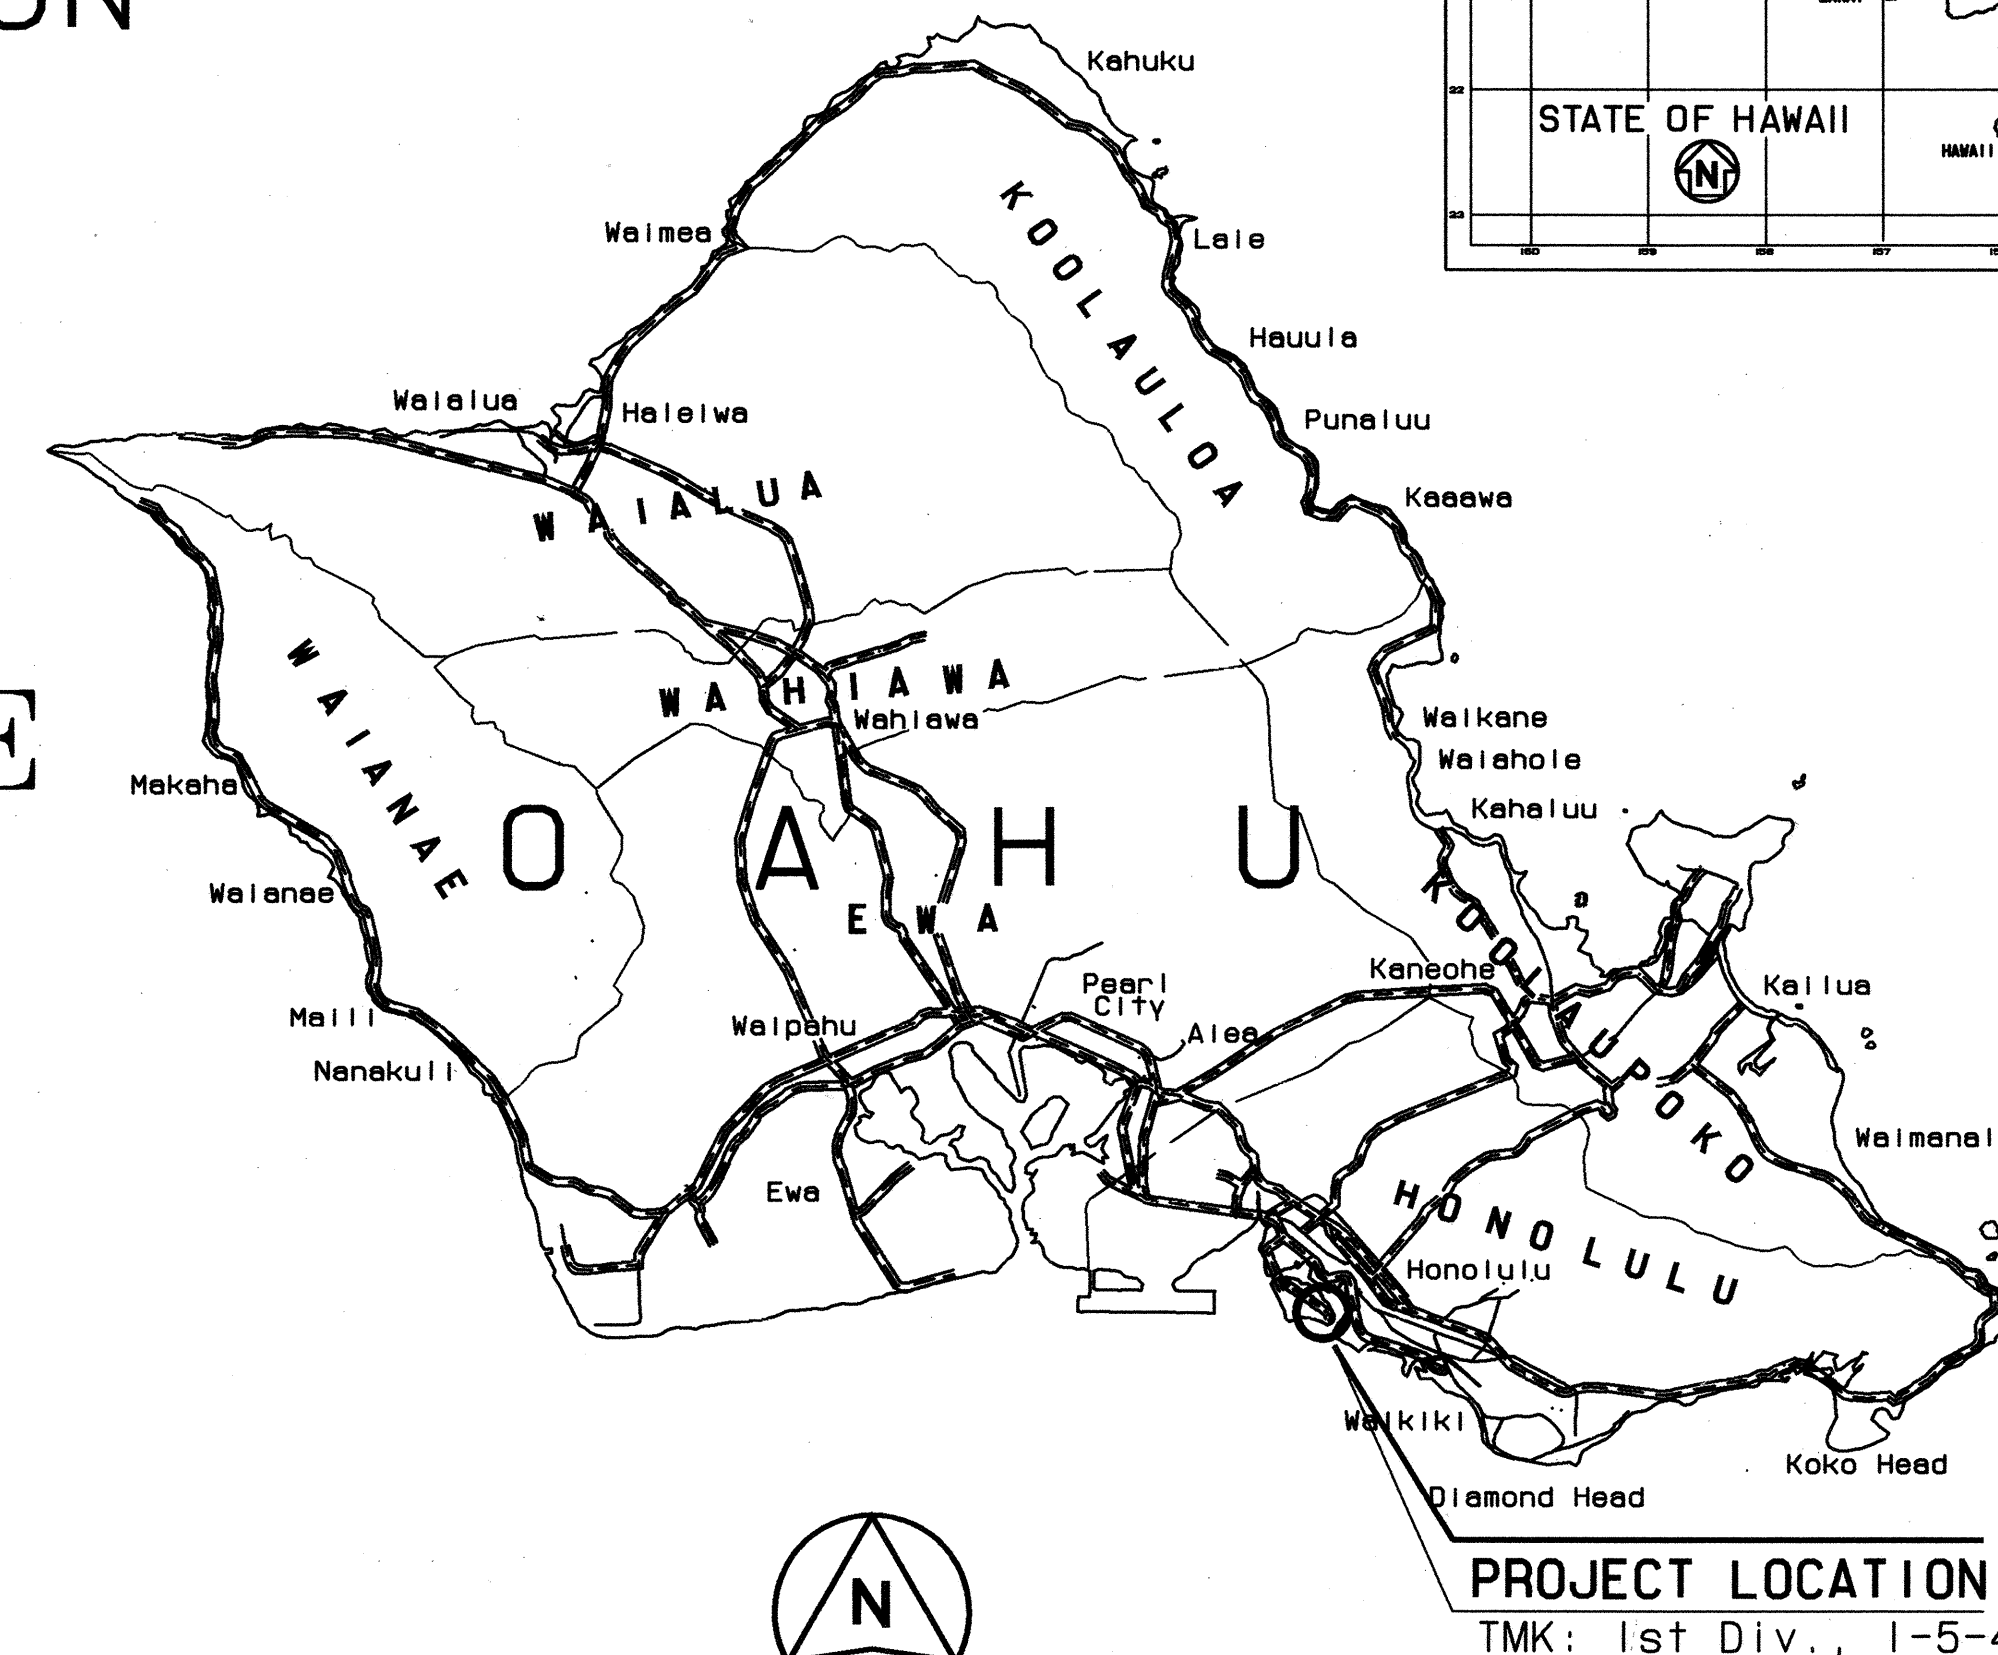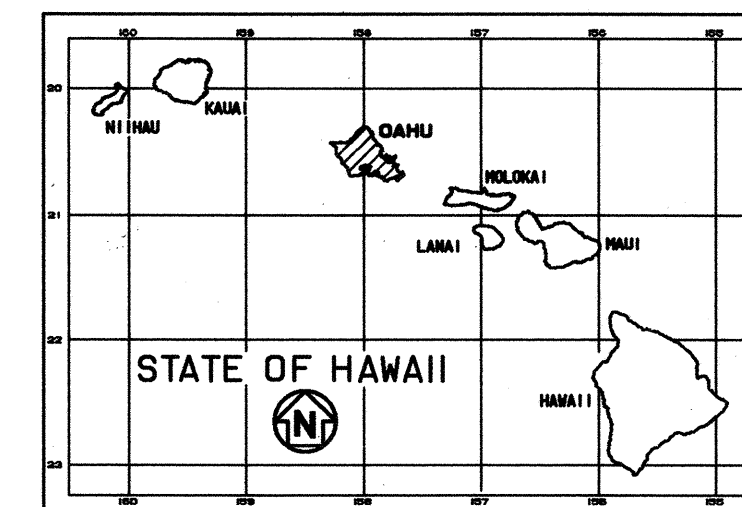

----- FEDERAL AID PROJECTS PREVIOUSLY CONSTRUCTED OR UNDER CONSTRUCTION
 MILE POST 0.0 TO MILE POST .88

CHANGES MADE DURING CONSTRUCTION HAVE BEEN INCORPORATED ON THESE PLANS EXCEPT CHANGES IN THE ORIGINAL THEORETICAL QUANTITIES. FOR ACTUAL QUANTITIES, REFER TO PROJECT LEDGER AND/OR COMPUTATION BOOK.
Sidney S. C. Chua 6/14/00
 RESIDENT ENGINEER DATE