

INDEX TO DRAWINGS	
SHEET NO.	DESCRIPTION
1	TITLE SHEET
2-5	TYPICAL SECTIONS
6-9	PLAN & PROFILE
10-14	DETAIL PLAN OF ROADWAY
15-16	CONSTRUCTION PHASING & DETOUR PLANS
17-35	MISCELLANEOUS & STANDARD ROADWAY DETAILS
36-70	DRAINAGE PLANS & DETAILS
71-83	TRAFFIC SIGNS, LANDSCAPING, & PAVEMENT MARKING PLANS & DETAILS
84-92	HIGHWAY LIGHTING PLANS & DETAILS
93-134	UTILITIES
93-104	SEWER PLANS & DETAILS
93,	ELECTRIC, TELEPHONE, WATER, &
105-134	GAS PLANS & DETAILS
135-153	CROSS SECTIONS
153	SPRINKLER SYSTEM

THESE SHEETS ADDED TO ORIGINAL CONTRACT PLANS.

25S-1, 46S-1, 49S-1, CO153S-1, CO153S-2, CO153S-3, CO153S-4, CO153S-5, CO153S-6.

STATE OF HAWAII

DEPARTMENT OF TRANSPORTATION

HIGHWAYS DIVISION

HONOLULU, HAWAII

"AS BUILT"

PLANS FOR

CONSTRUCTION OF

MOKAPU SADDLE ROAD

(KANEHOE BAY DRIVE TO KAILUA INTERCHANGE)

FEDERAL AID SECONDARY PROJECT NO. S-0630(10)


AND

FEDERAL AID SECONDARY PROJECT NO. S-0630(7)

DISTRICT OF KOOLAUPOKO

ISLAND OF OAHU

FED. ROAD DIST. NO.	STATE	FED. AID PROJ. NO.	FISCAL YEAR	SHEET NO.	TOTAL SHEETS
HAWAII	HAW.	S-0630(10) S-0630(7)	1970	1	153

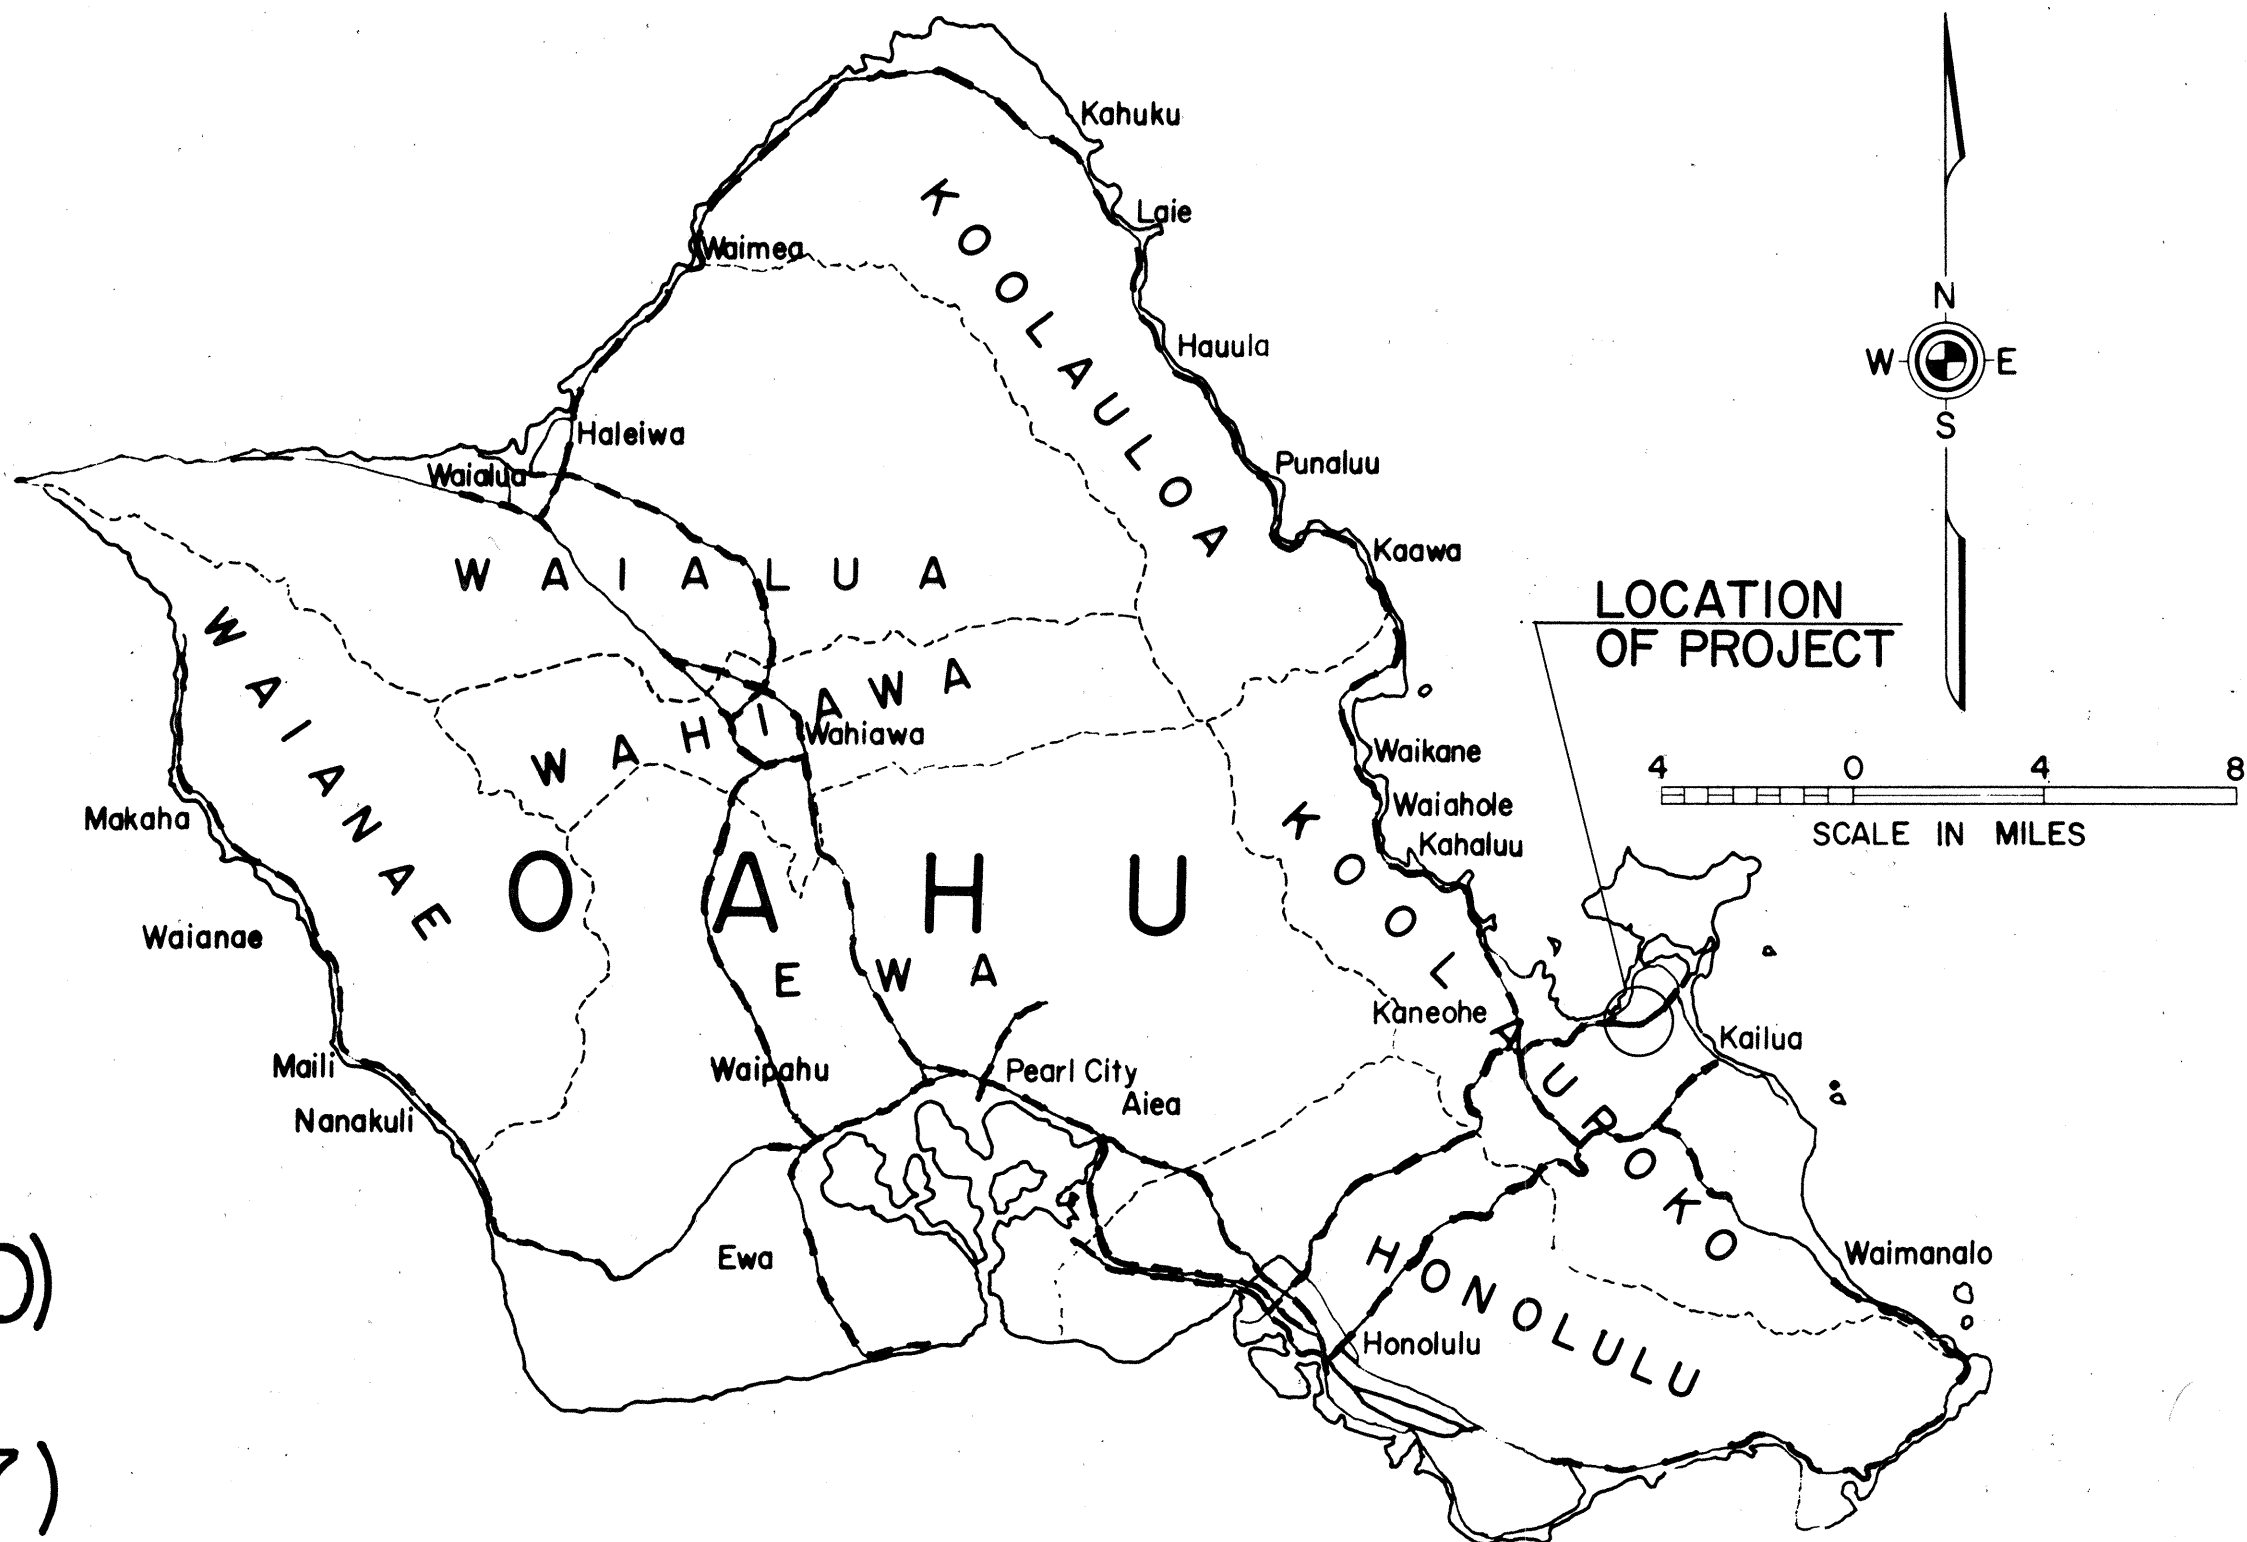

NOTE:

ALL CHANGES MADE DURING CONSTRUCTION HAVE BEEN INCORPORATED ON THESE PLANS IN RED EXCEPT CHANGES IN THE ORIGINAL THEORETICAL QUANTITIES. (FOR ACTUAL QUANTITIES, REFER TO PROJECT LEDGER AND/OR COMPUTATION BOOK.)

H. Hamada
RESIDENT ENGINEER

11/9/73
DATE

DESIGN CLASSIFICATION			
ADT 1966	8100	D	65/35
DESIGN ADT (1986)	9600	T	3%
DHV	1100	V	50 M.P.H.

DEPARTMENT OF TRANSPORTATION

BUREAU OF PUBLIC ROADS

APPROVED:

DIVISION ENGINEER

DATE

DEPARTMENT OF TRANSPORTATION

STATE OF HAWAII

APPROVED:

E. Alvey Wright

11/17/70

for DIR. OF TRANSPORTATION

DATE

