


FED. ROAD DIST. NO.	STATE	FED. AID PROJ. NO.	FISCAL YEAR	SHEET NO.	TOTAL SHEETS
HAWAII	HAW.	STP-065-1(9)	2003	35	114

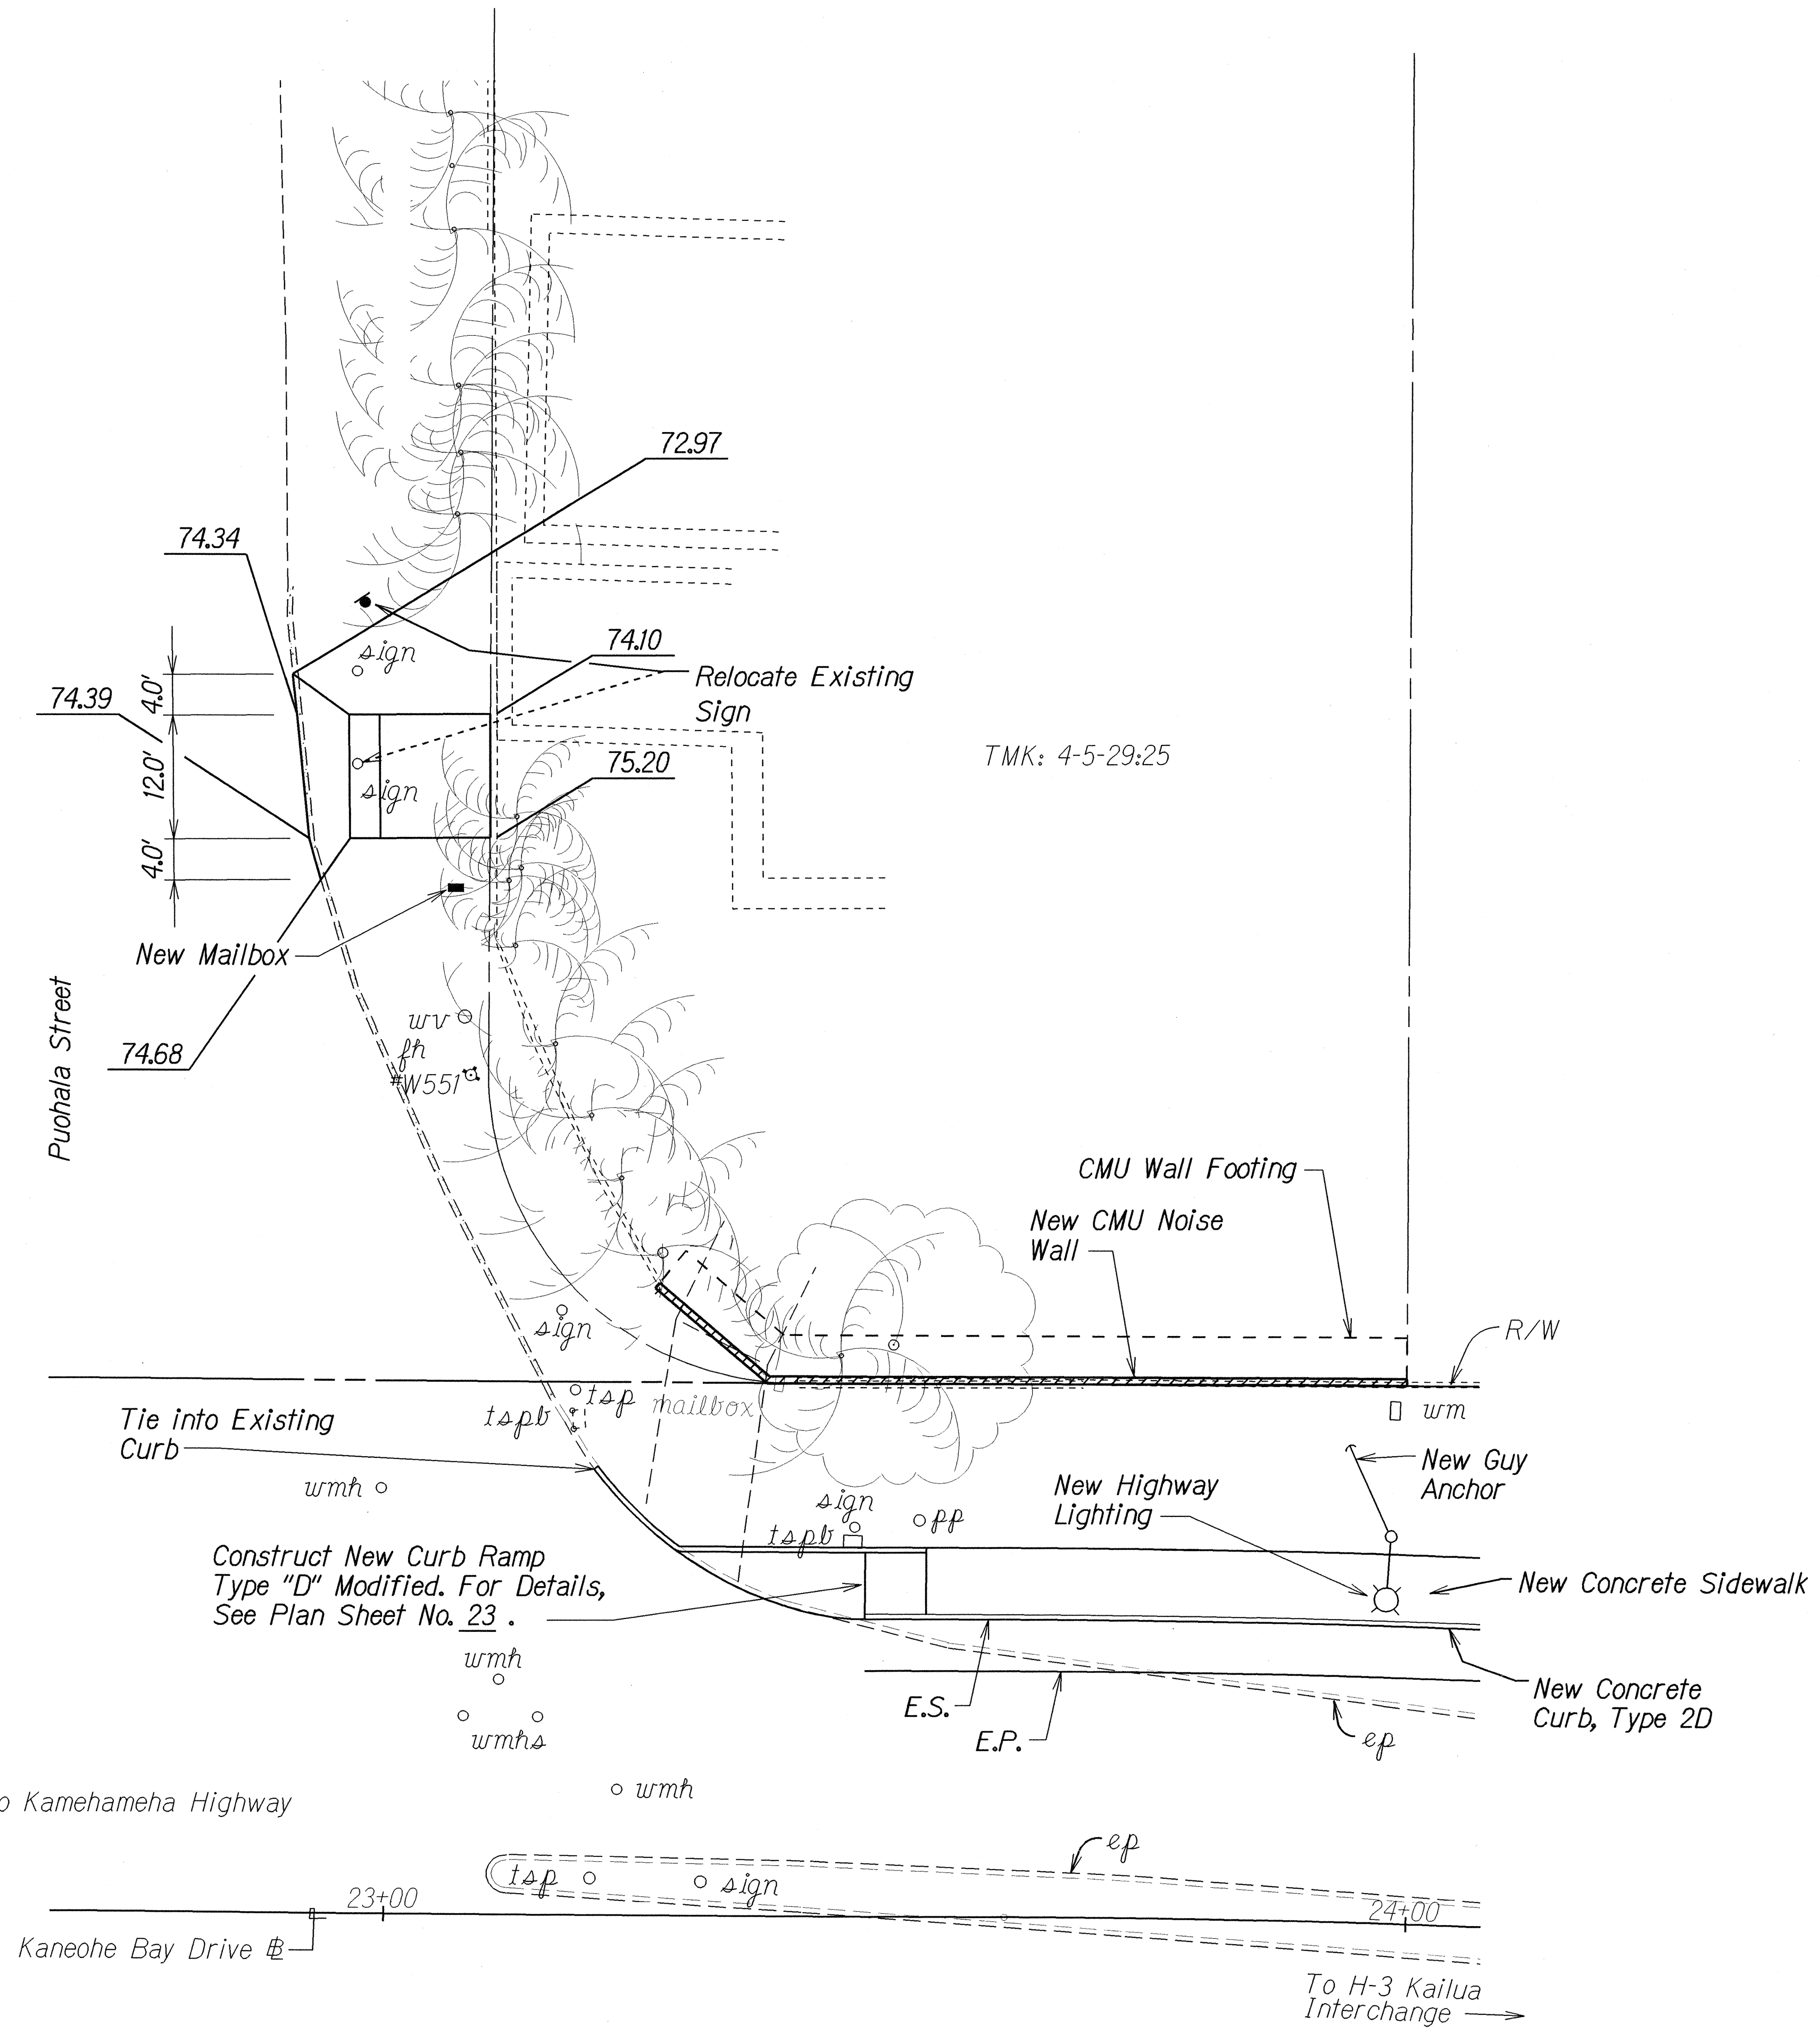

ORIGINAL PLAN	DATE
DESIGNED BY	12/20/00
CHECKED BY	
NOTED BY	
QUANTITIES BY	
DESIGNED BY	
TRACED BY	
DRAWN BY	
SURVEY PLOTTED BY	

STATE OF HAWAII
DEPARTMENT OF TRANSPORTATION
HIGHWAYS DIVISION


DETAIL ROADWAY PLAN

Kaneohe Bay Drive Improvements
Vicinity of Puohala Street to Kawa Bridge
Federal Aid Project No. STP-065-1(9)

Scale: 1"=10' Date: June, 2002

SHEET No. 1 OF 9 SHEETS

FED. ROAD DIST. NO.	STATE	FED. AID PROJ. NO.	FISCAL YEAR	SHEET NO.	TOTAL SHEETS
HAWAII	HAW.	STP-065-1(9)	2003	ADD. 36	114

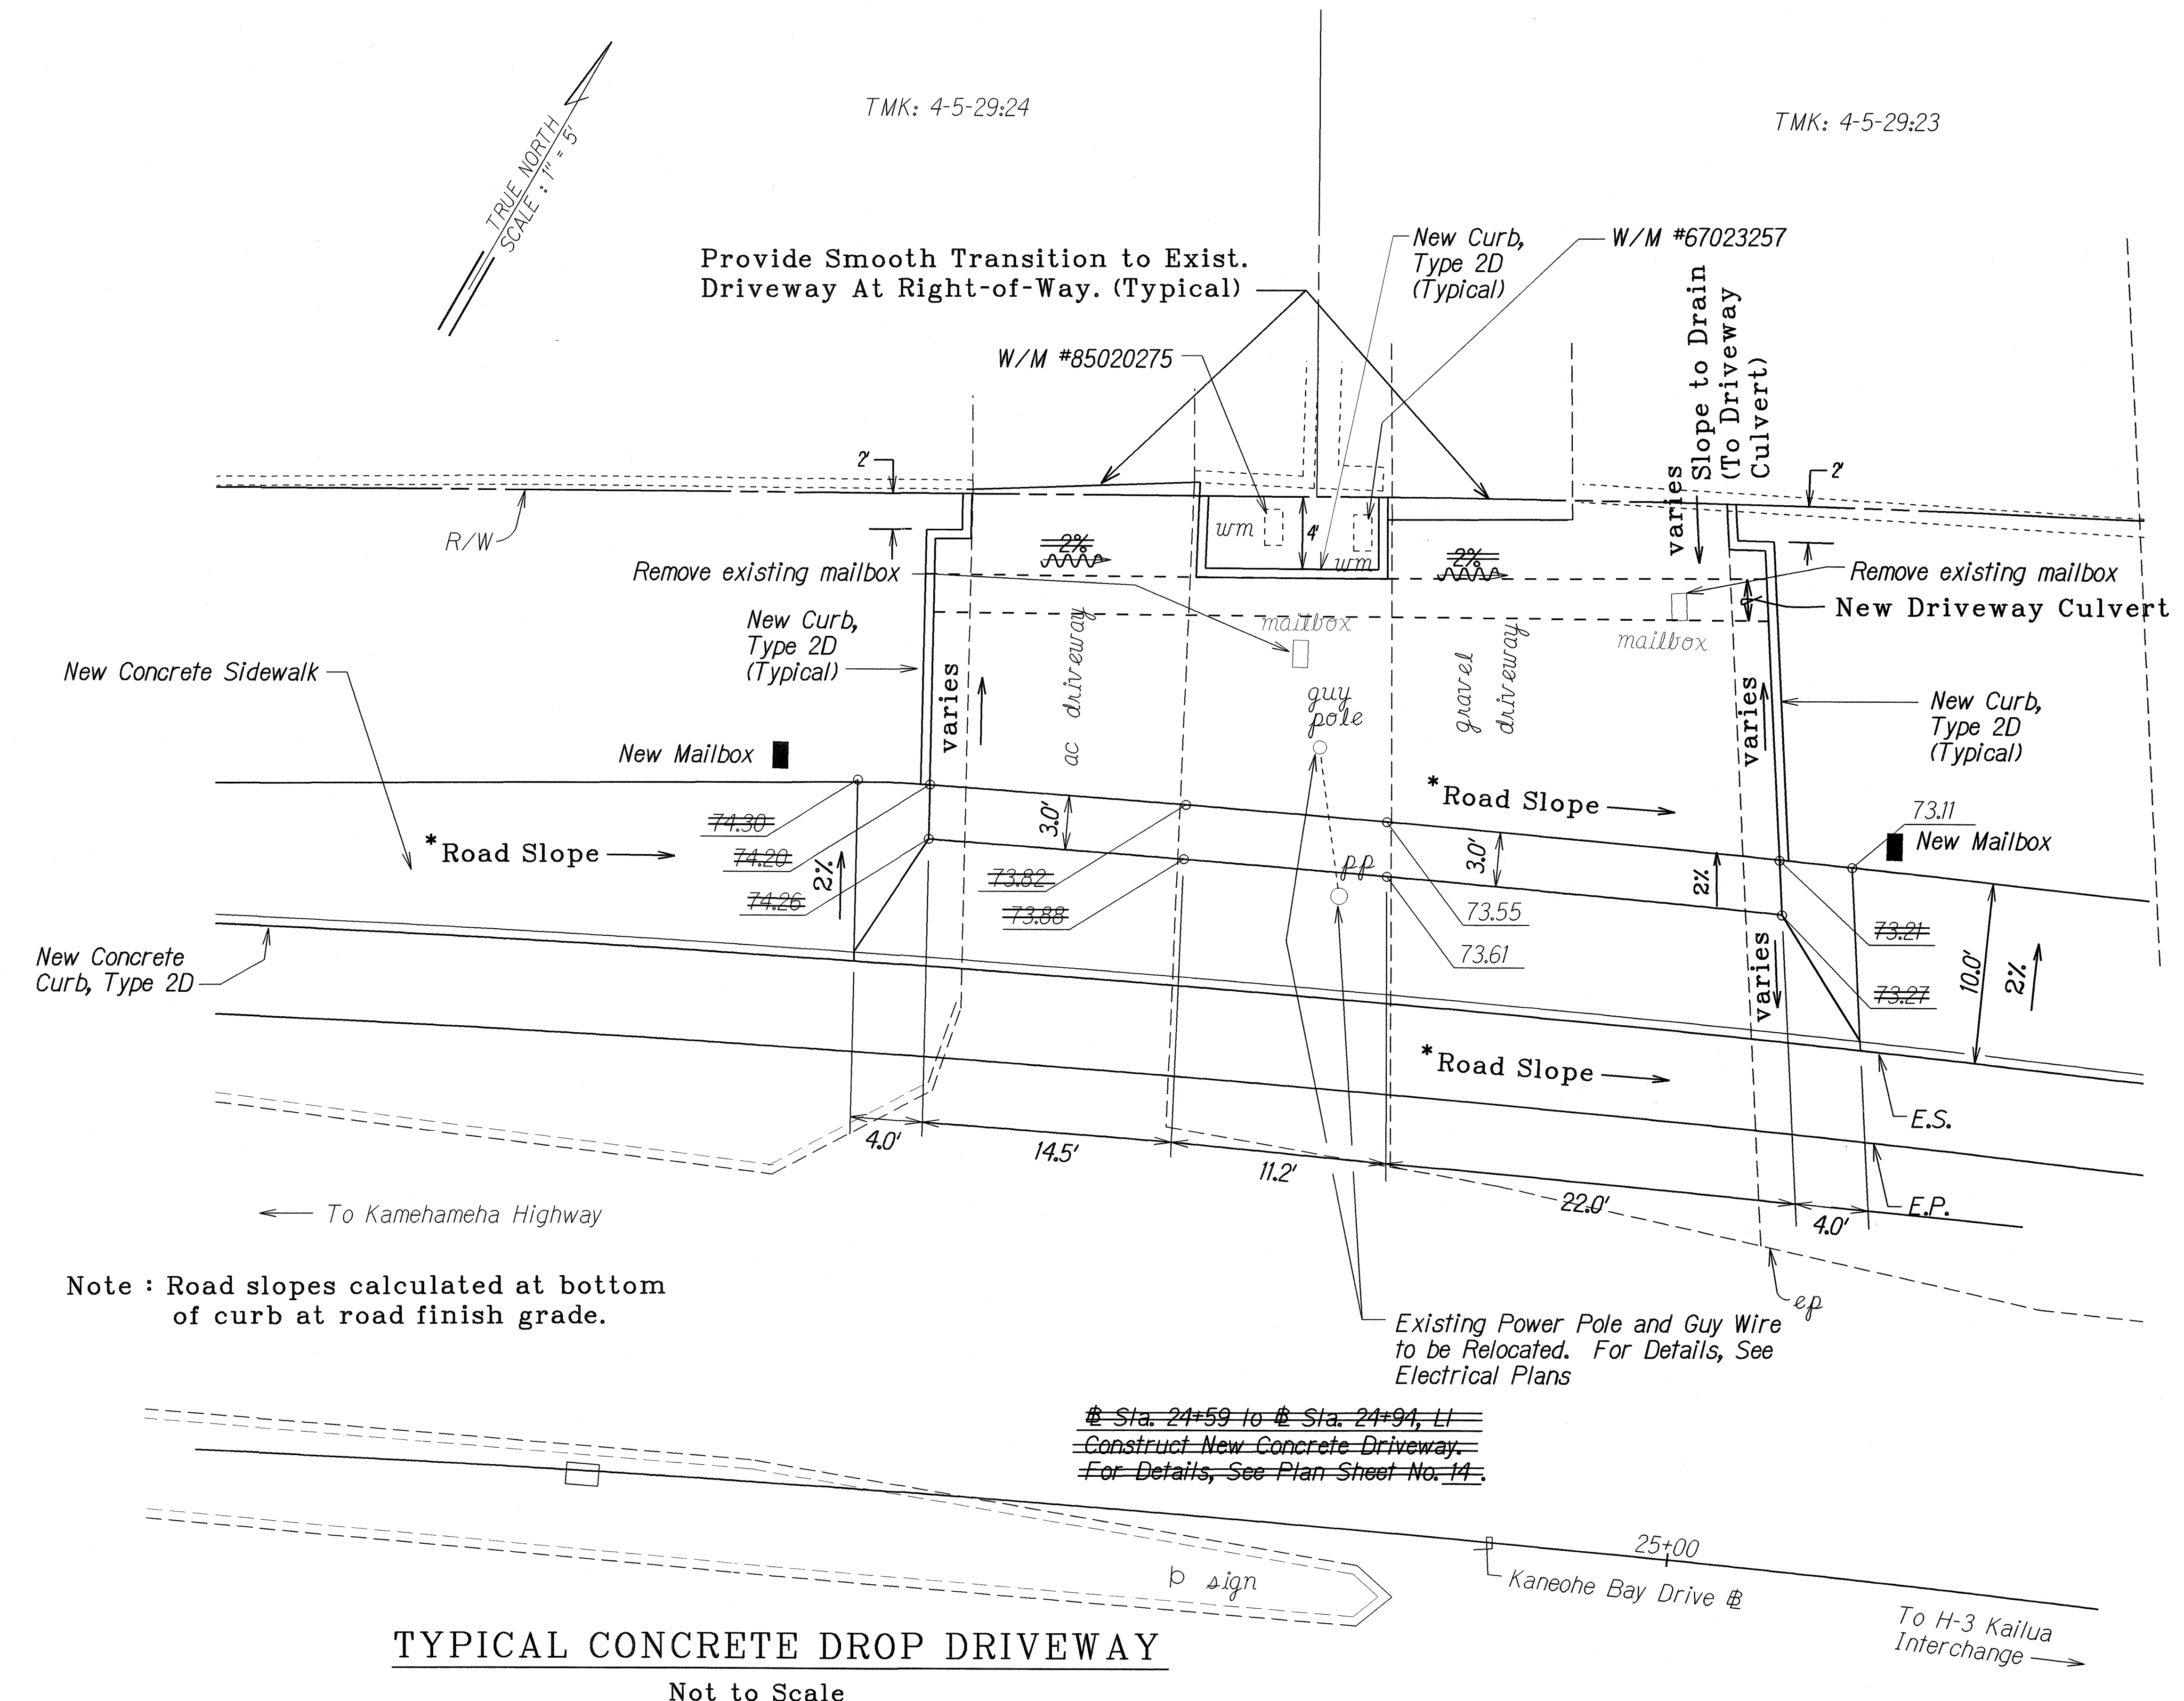

LEGEND FOR AS-BUILT POSTINGS	
	Squiggly line for as-built deletion
	Double line for as-built deletion
Roadway	Text for as-built posting

SURVEY PLOTTED BY	DATE
DESIGNED BY	2/27/02
QUANTITIES BY	
CHECKED BY	

2/3/03	Revised Driveway Per Adendum No. 1
--------	------------------------------------

DATE	REVISION
------	----------

STATE OF HAWAII
DEPARTMENT OF TRANSPORTATION
HIGHWAYS DIVISION

DETAIL ROADWAY PLAN

KANEOHE BAY DRIVE IMPROVEMENTS
Vicinity of Puohala Street to Kawa Bridge
Federal Aid Project No. STP-065-1(9)


Scale: 1"=5' Date: June, 2002

SHEET No. 2 OF 9 SHEETS

TYPICAL CONCRETE DROP DRIVEWAY
Not to Scale

"AS-BUILT"

FED. ROAD DIST. NO.	STATE	FED. AID PROJ. NO.	FISCAL YEAR	SHEET NO.	TOTAL SHEETS
HAWAII	HAW.	STP-065-1(9)	2003	37	114

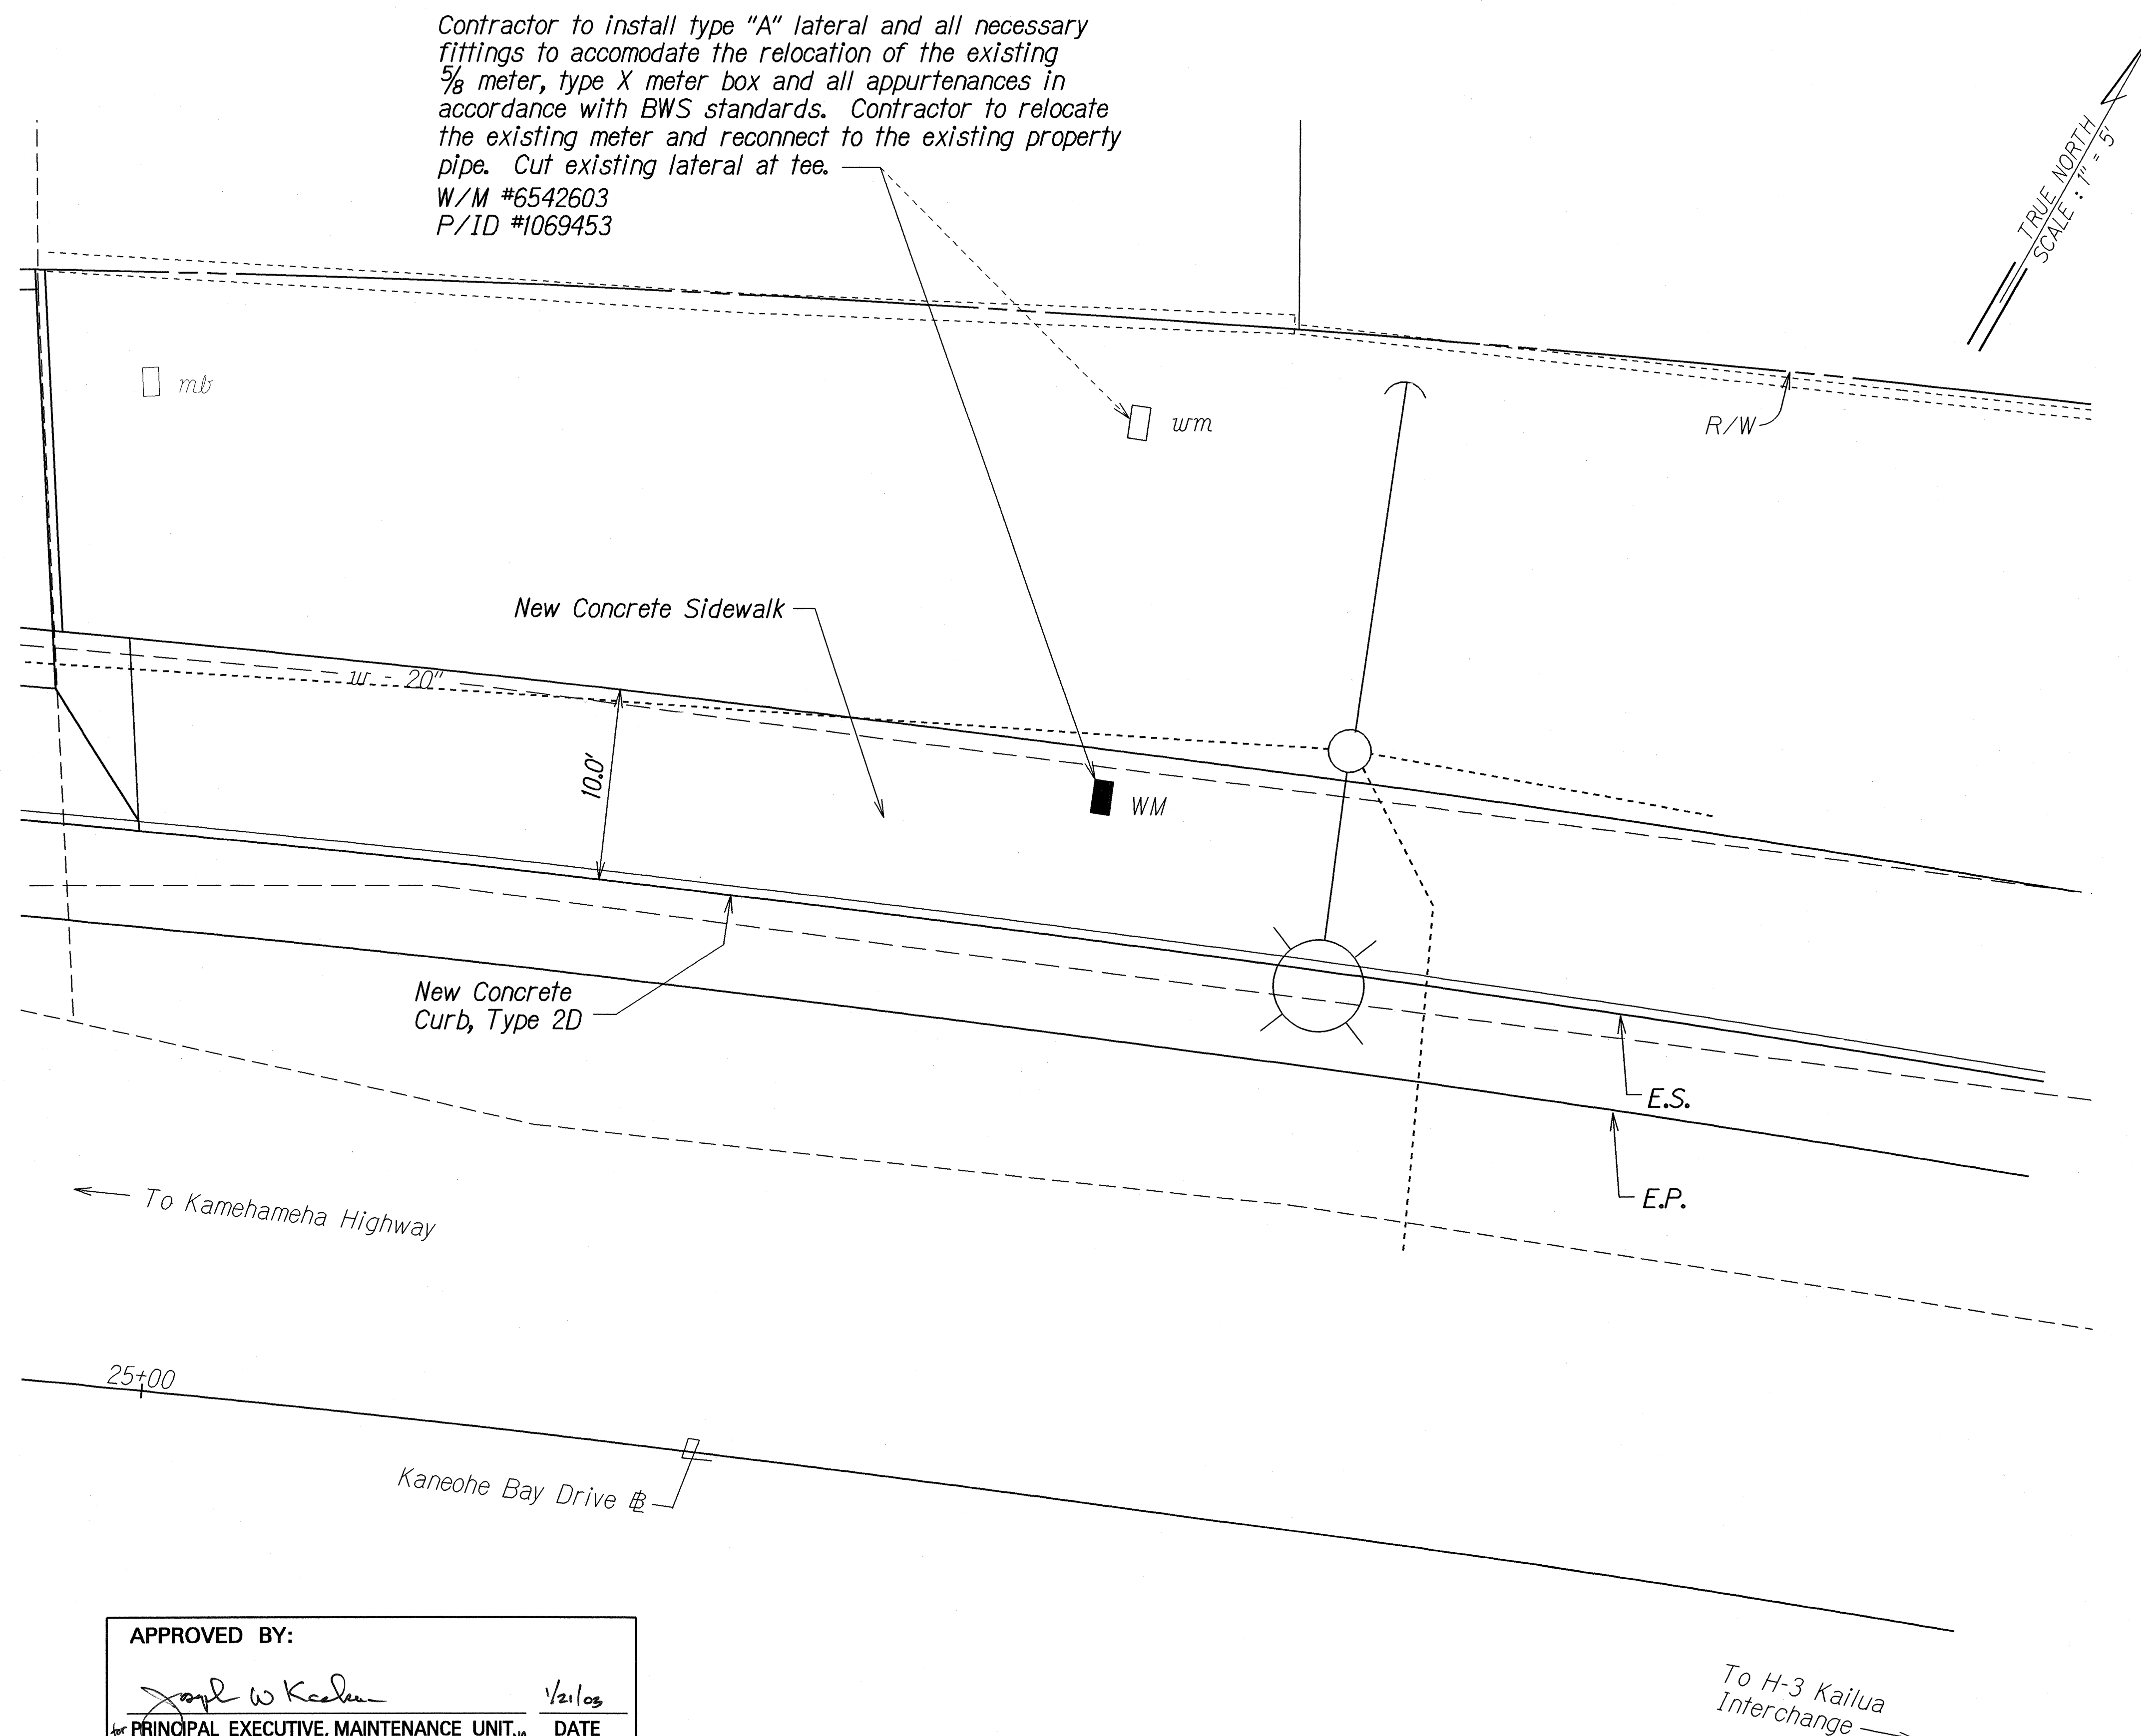

ORIGINAL PLAN	SURVEY PLOTTED BY	DATE
NOTE BOOK	DESIGNED BY	12/20/00
	QUANTITIES BY	
	CHECKED BY	

APPROVED BY:

[Signature] 1/21/03

PRINCIPAL EXECUTIVE, MAINTENANCE UNIT, DATE
BOARD OF WATER SUPPLY
CITY AND COUNTY OF HONOLULU


STATE OF HAWAII
DEPARTMENT OF TRANSPORTATION
HIGHWAYS DIVISION

DETAIL ROADWAY PLAN

KANEOHE BAY DRIVE IMPROVEMENTS
Vicinity of Puohala Street to Kawa Bridge
Federal Aid Project No. STP-065-1(9)

Scale: 1"=5' Date: June 2001

FED. ROAD DIST. NO.	STATE	FED. AID PROJ. NO.	FISCAL YEAR	SHEET NO.	TOTAL SHEETS
HAWAII	HAW.	STP-065-1(9)	2003	ADD. 38	114

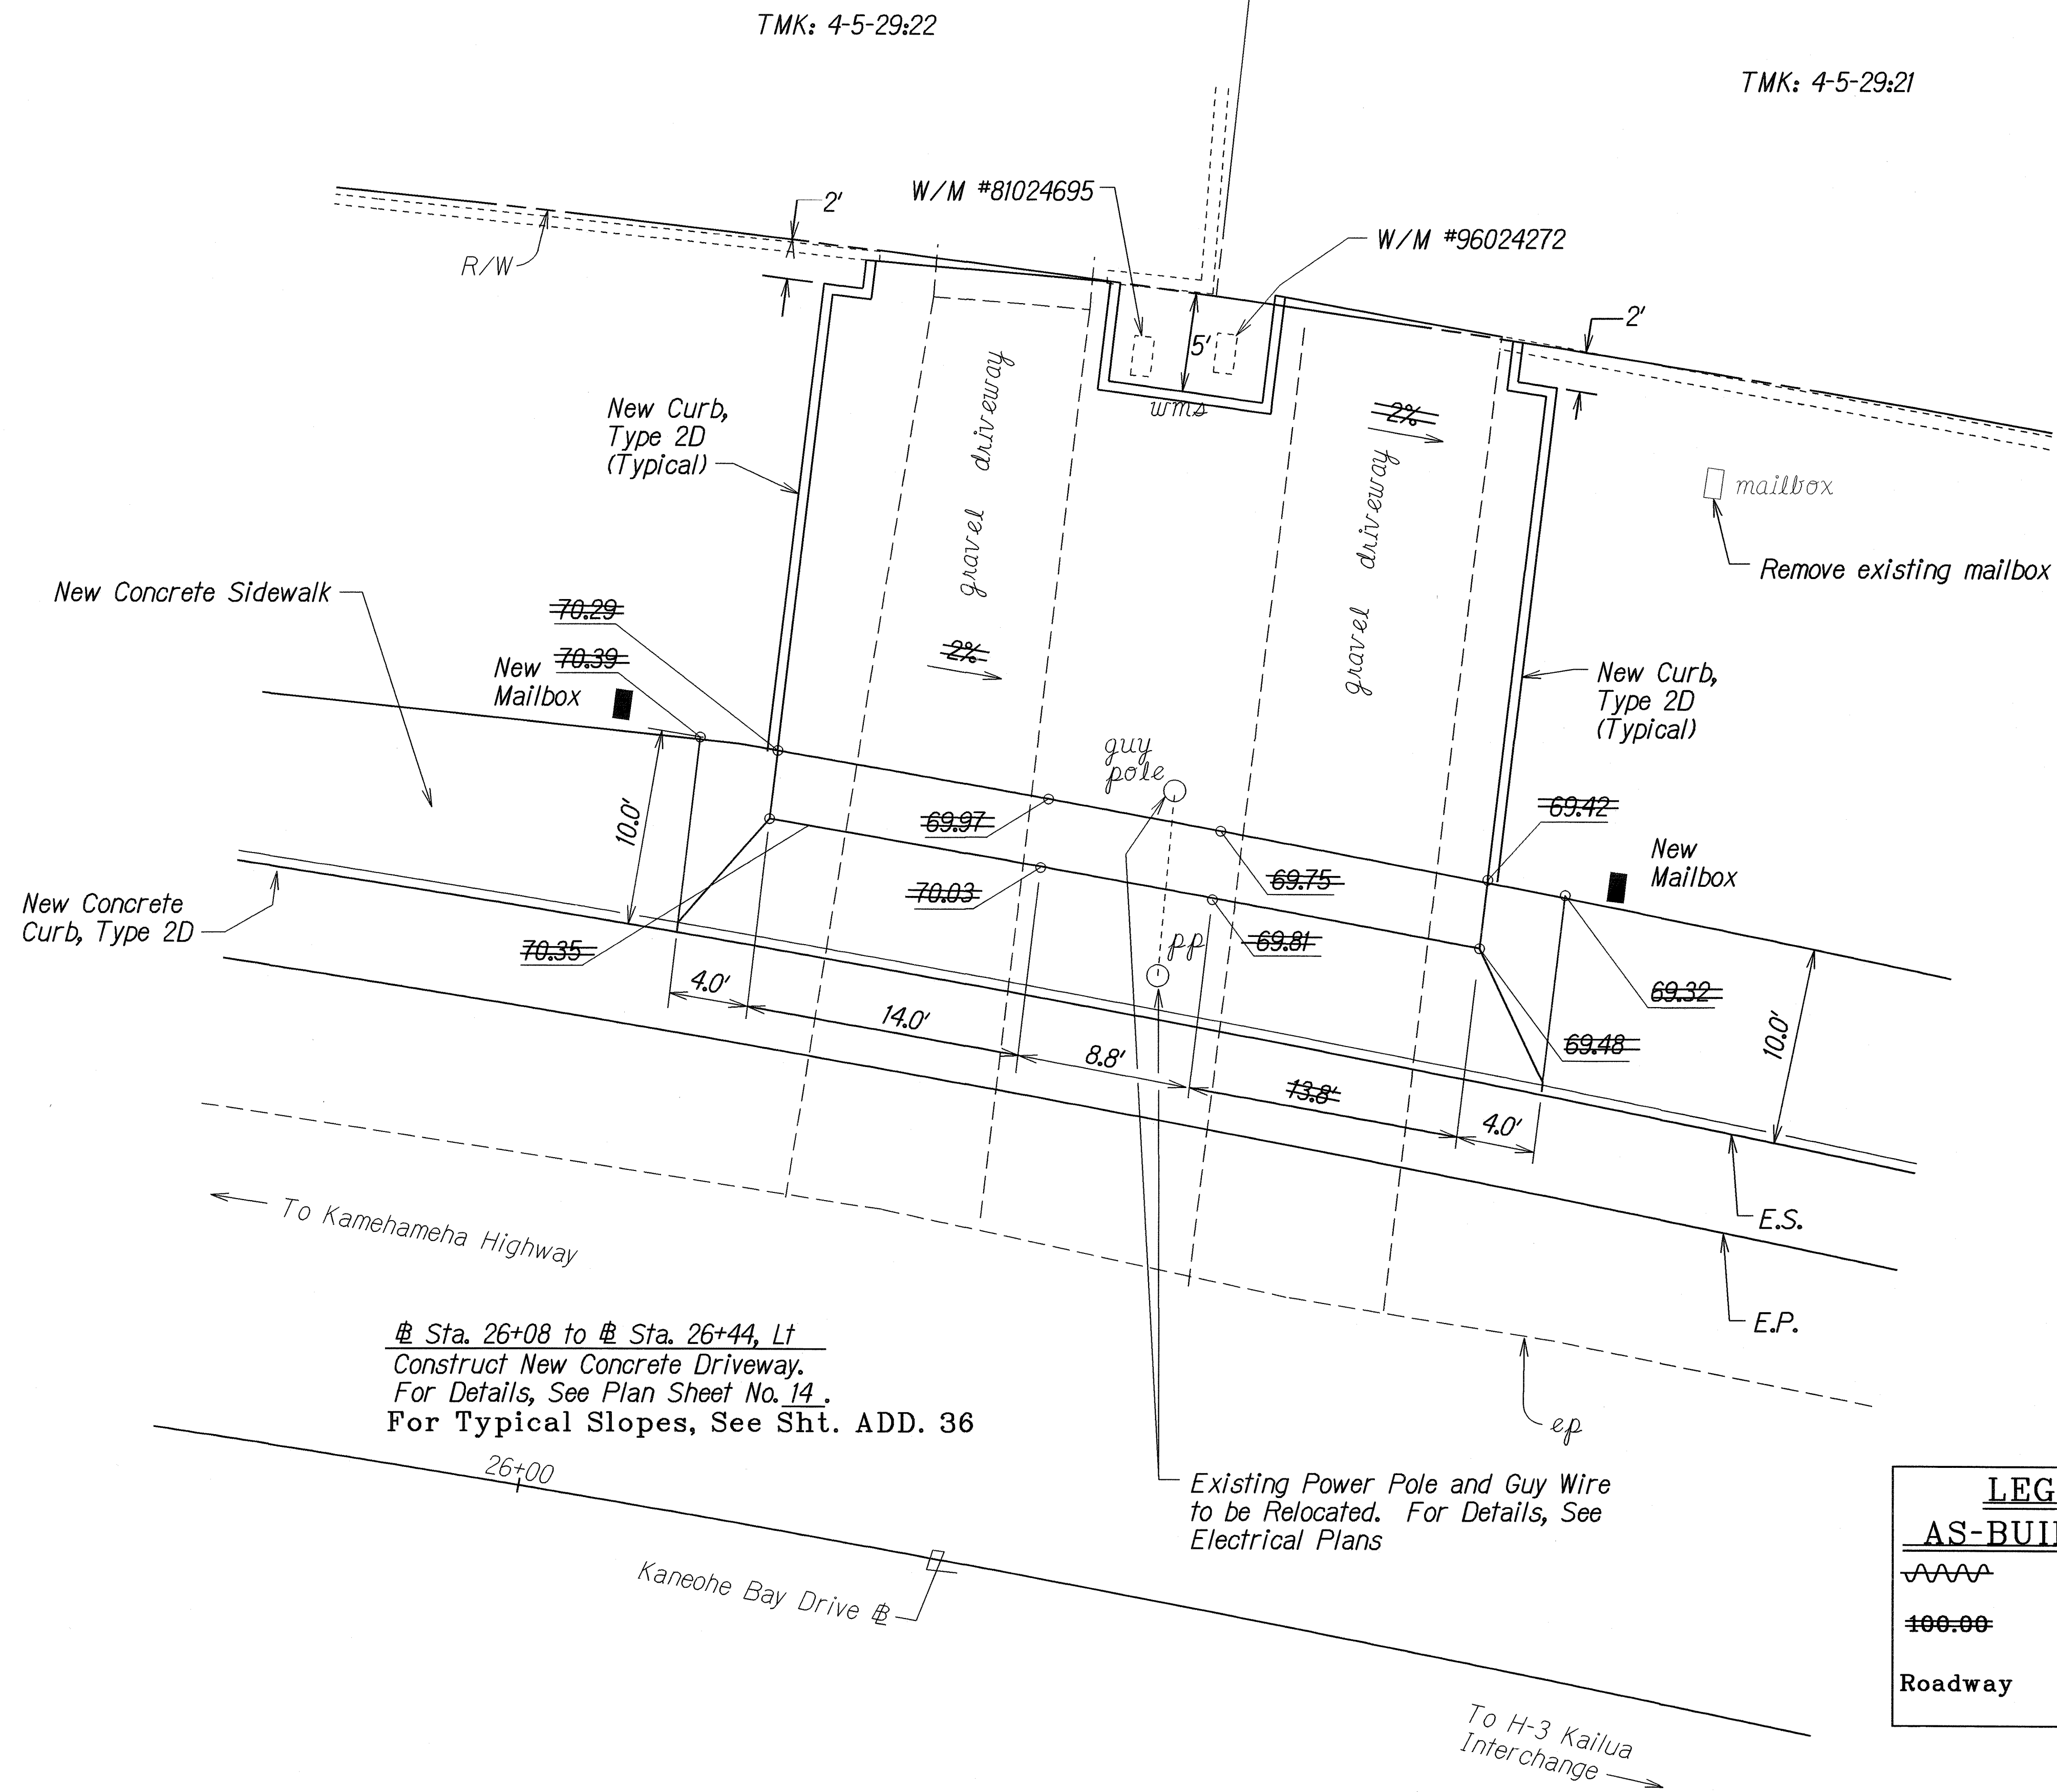

Sta. 26+08 to Sta. 26+44, Lt
Construct New Concrete Driveway.
For Details, See Plan Sheet No. 14.
For Typical Slopes, See Sht. ADD. 36

Existing Power Pole and Guy Wire
to be Relocated. For Details, See
Electrical Plans

LEGEND FOR AS-BUILT POSTINGS	
	Squiggly line for as-built deletion
	Double line for as-built deletion
	Text for as-built posting

2/3/03 Revised Driveway Per Addendum No. 1

DATE REVISION

STATE OF HAWAII
DEPARTMENT OF TRANSPORTATION
HIGHWAYS DIVISION

DETAIL ROADWAY PLAN

Kaneohe Bay Drive Improvements
Vicinity of Puohala Street to Kawa Bridge
Federal Aid Project No. STP-065-1(9)

Scale: 1"=5' Date: June, 2002


SURVEY PLOTTED BY	DATE
DRAWN BY	
DESIGNED BY	
QUANTITIES BY	
CHECKED BY	

asbuilt:ADD4:kanr04

"AS-BUILT"

ADD. 38

FED. ROAD DIST. NO.	STATE	FED. AID PROJ. NO.	FISCAL YEAR	SHEET NO.	TOTAL SHEETS
HAWAII	HAW.	STP-065-1(9)	2003	ADD. 39	114

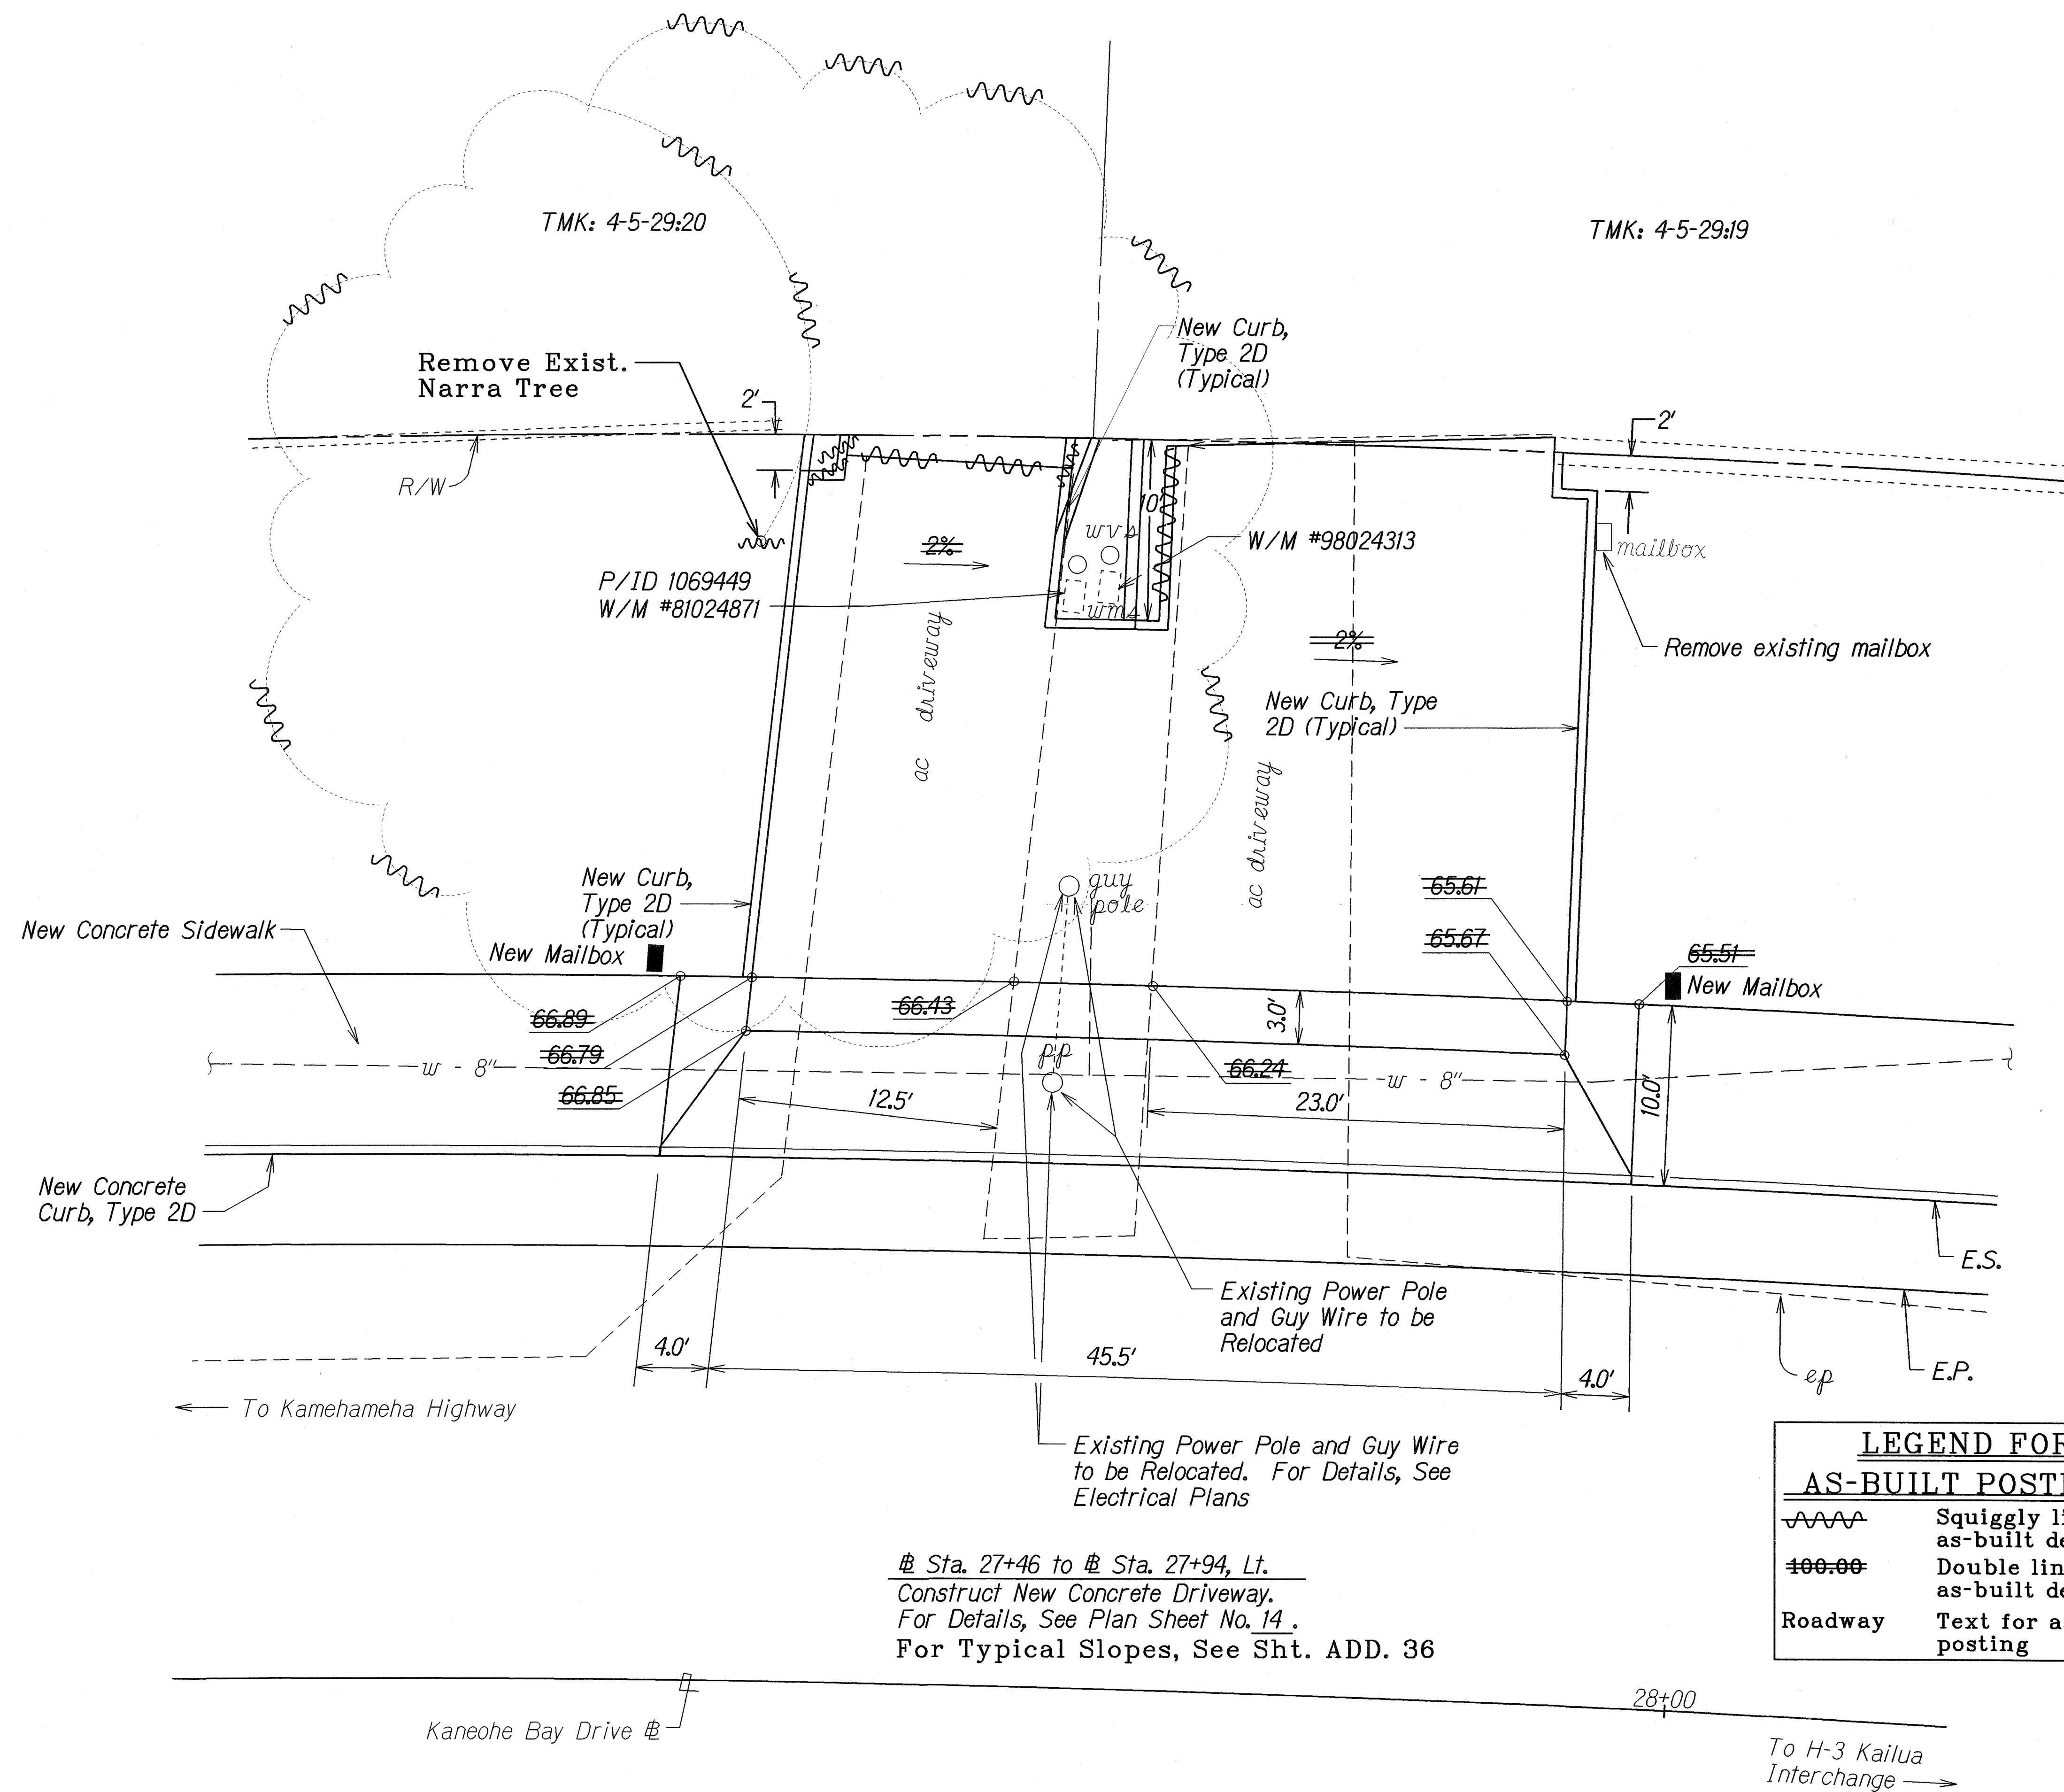

TRUE NORTH
SCALE: 1" = 5'

SURVEY PLOTTED BY	DATE
DESIGNED BY	
QUANTITIES BY	
CHECKED BY	

asbuilt.ADDA.kendrd05

LEGEND FOR AS-BUILT POSTINGS	
	Squiggly line for as-built deletion
	Double line for as-built deletion
Roadway	Text for as-built posting

2/3/03	Revised Driveway Per Addendum No. 1
--------	-------------------------------------

DATE	REVISION
------	----------

STATE OF HAWAII
DEPARTMENT OF TRANSPORTATION
HIGHWAYS DIVISION

DETAIL ROADWAY PLAN

Kaneohe Bay Drive Improvements
Vicinity of Puohala Street to Kawa Bridge
Federal Aid Project No. STP-065-1(9)

Scale: 1"=5' Date: June, 2002


SHEET No. 5 OF 9 SHEETS

Sta. 27+46 to # Sta. 27+94, Lt.
Construct New Concrete Driveway.
For Details, See Plan Sheet No. 14.
For Typical Slopes, See Sht. ADD. 36

"AS-BUILT"

ADD. 39

FED. ROAD DIST. NO.	STATE	FED. AID PROJ. NO.	FISCAL YEAR	SHEET NO.	TOTAL SHEETS
HAWAII	HAW.	STP-065-1(9)	2003	ADD. 40	114

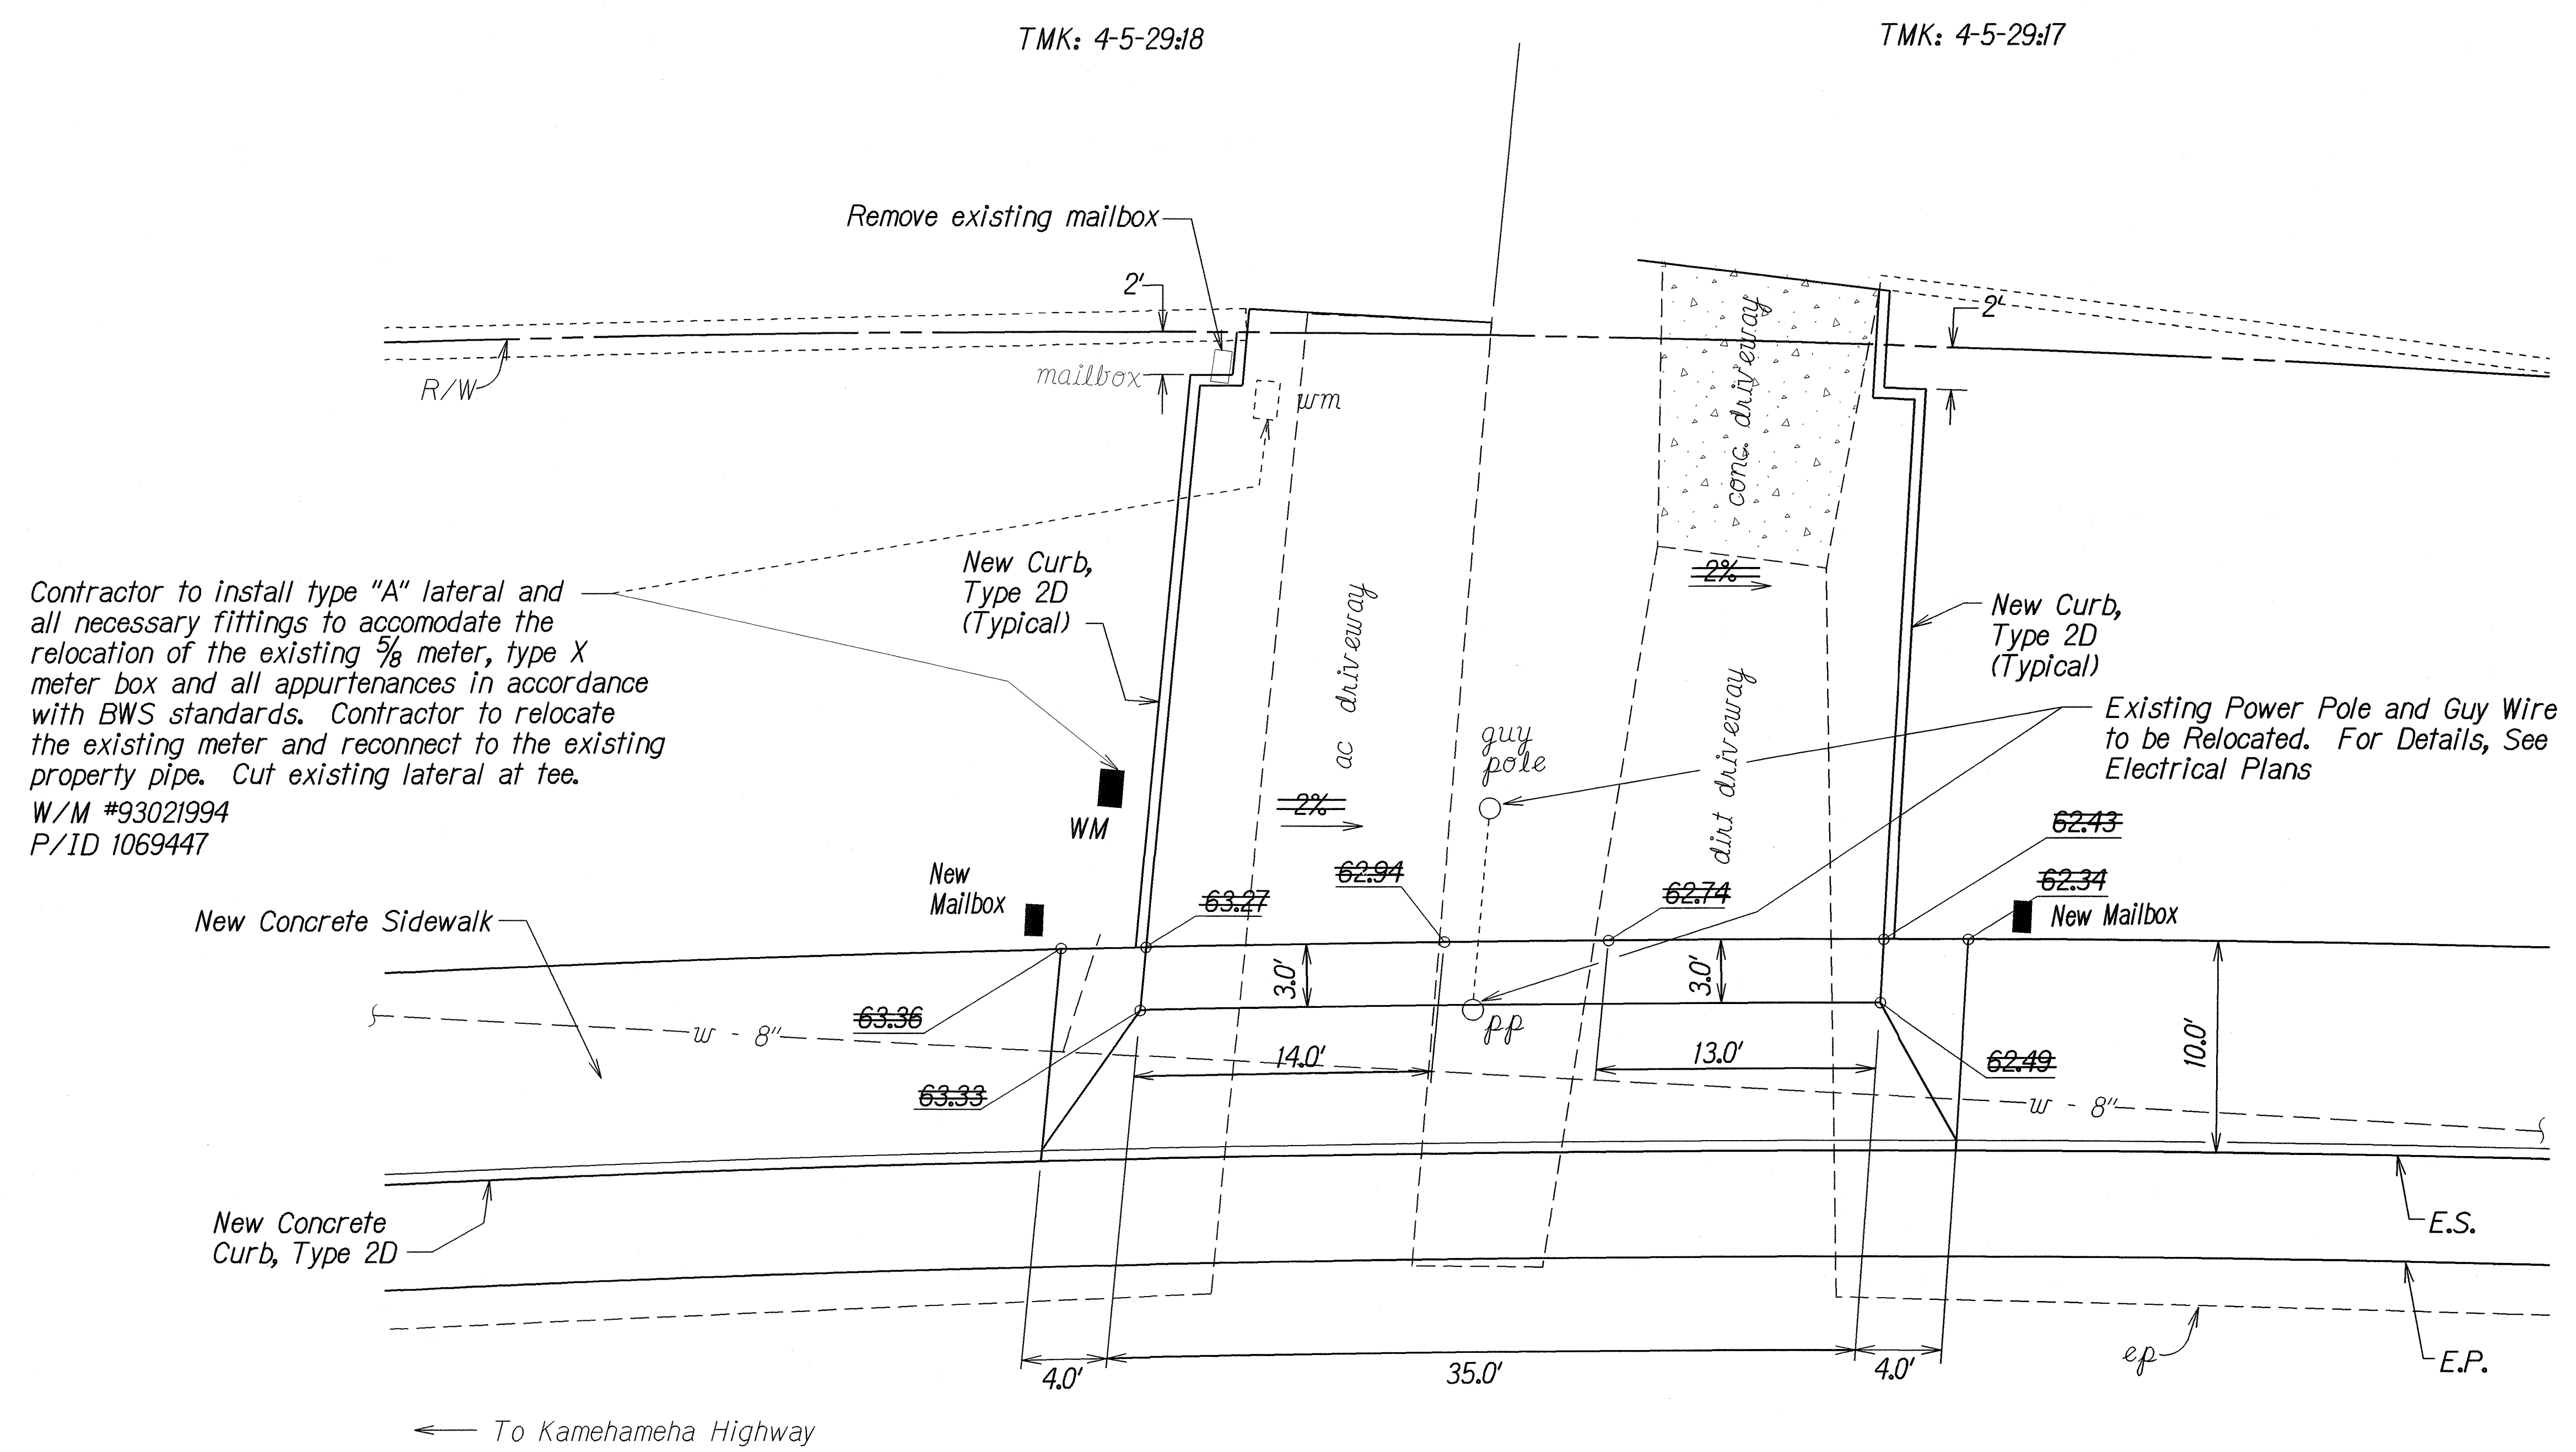

TRUE NORTH
SCALE: 1"=5'

APPROVED BY:
Wayne W. Keenan 1/21/03
PRINCIPAL EXECUTIVE MAINTENANCE UNIT
BOARD OF WATER SUPPLY
CITY AND COUNTY OF HONOLULU

± Sta. 28+91 to ± Sta. 29+27, Lt.
Construct New Concrete Driveway.
For Details, See Plan Sheet No. 14.
For Typical Slopes, See Sht. ADD.36

LEGEND FOR AS-BUILT POSTINGS

	Squiggly line for as-built deletion
	Double line for as-built deletion
Roadway	Text for as-built posting

To H-3 Kailua Interchange →

2/3/03 Revised Driveway Per Addendum No. 1

DATE REVISION


STATE OF HAWAII
DEPARTMENT OF TRANSPORTATION
HIGHWAYS DIVISION
DETAIL ROADWAY PLAN
KANEHOE BAY DRIVE IMPROVEMENTS
Vicinity of Puohala Street to Kawa Bridge
Federal Aid Project No. STP-065-1(9)
Scale: 1"=5' Date: June 2001
SHEET No. 6 OF 9 SHEETS

SURVEY PLOTTED BY	DATE
DRAWN BY	10/21/02
DESIGNED BY	
QUANTITIES BY	
CHECKED BY	


asbuilt.ADD40and06

FED. ROAD DIST. NO.	STATE	FED. AID PROJ. NO.	FISCAL YEAR	SHEET NO.	TOTAL SHEETS
HAWAII	HAW.	STP-065-1(9)	2003	42	114

Widen Nohea Place Driveway to Approx. 22' Wide. (See Profile Below for Pavement Structure)

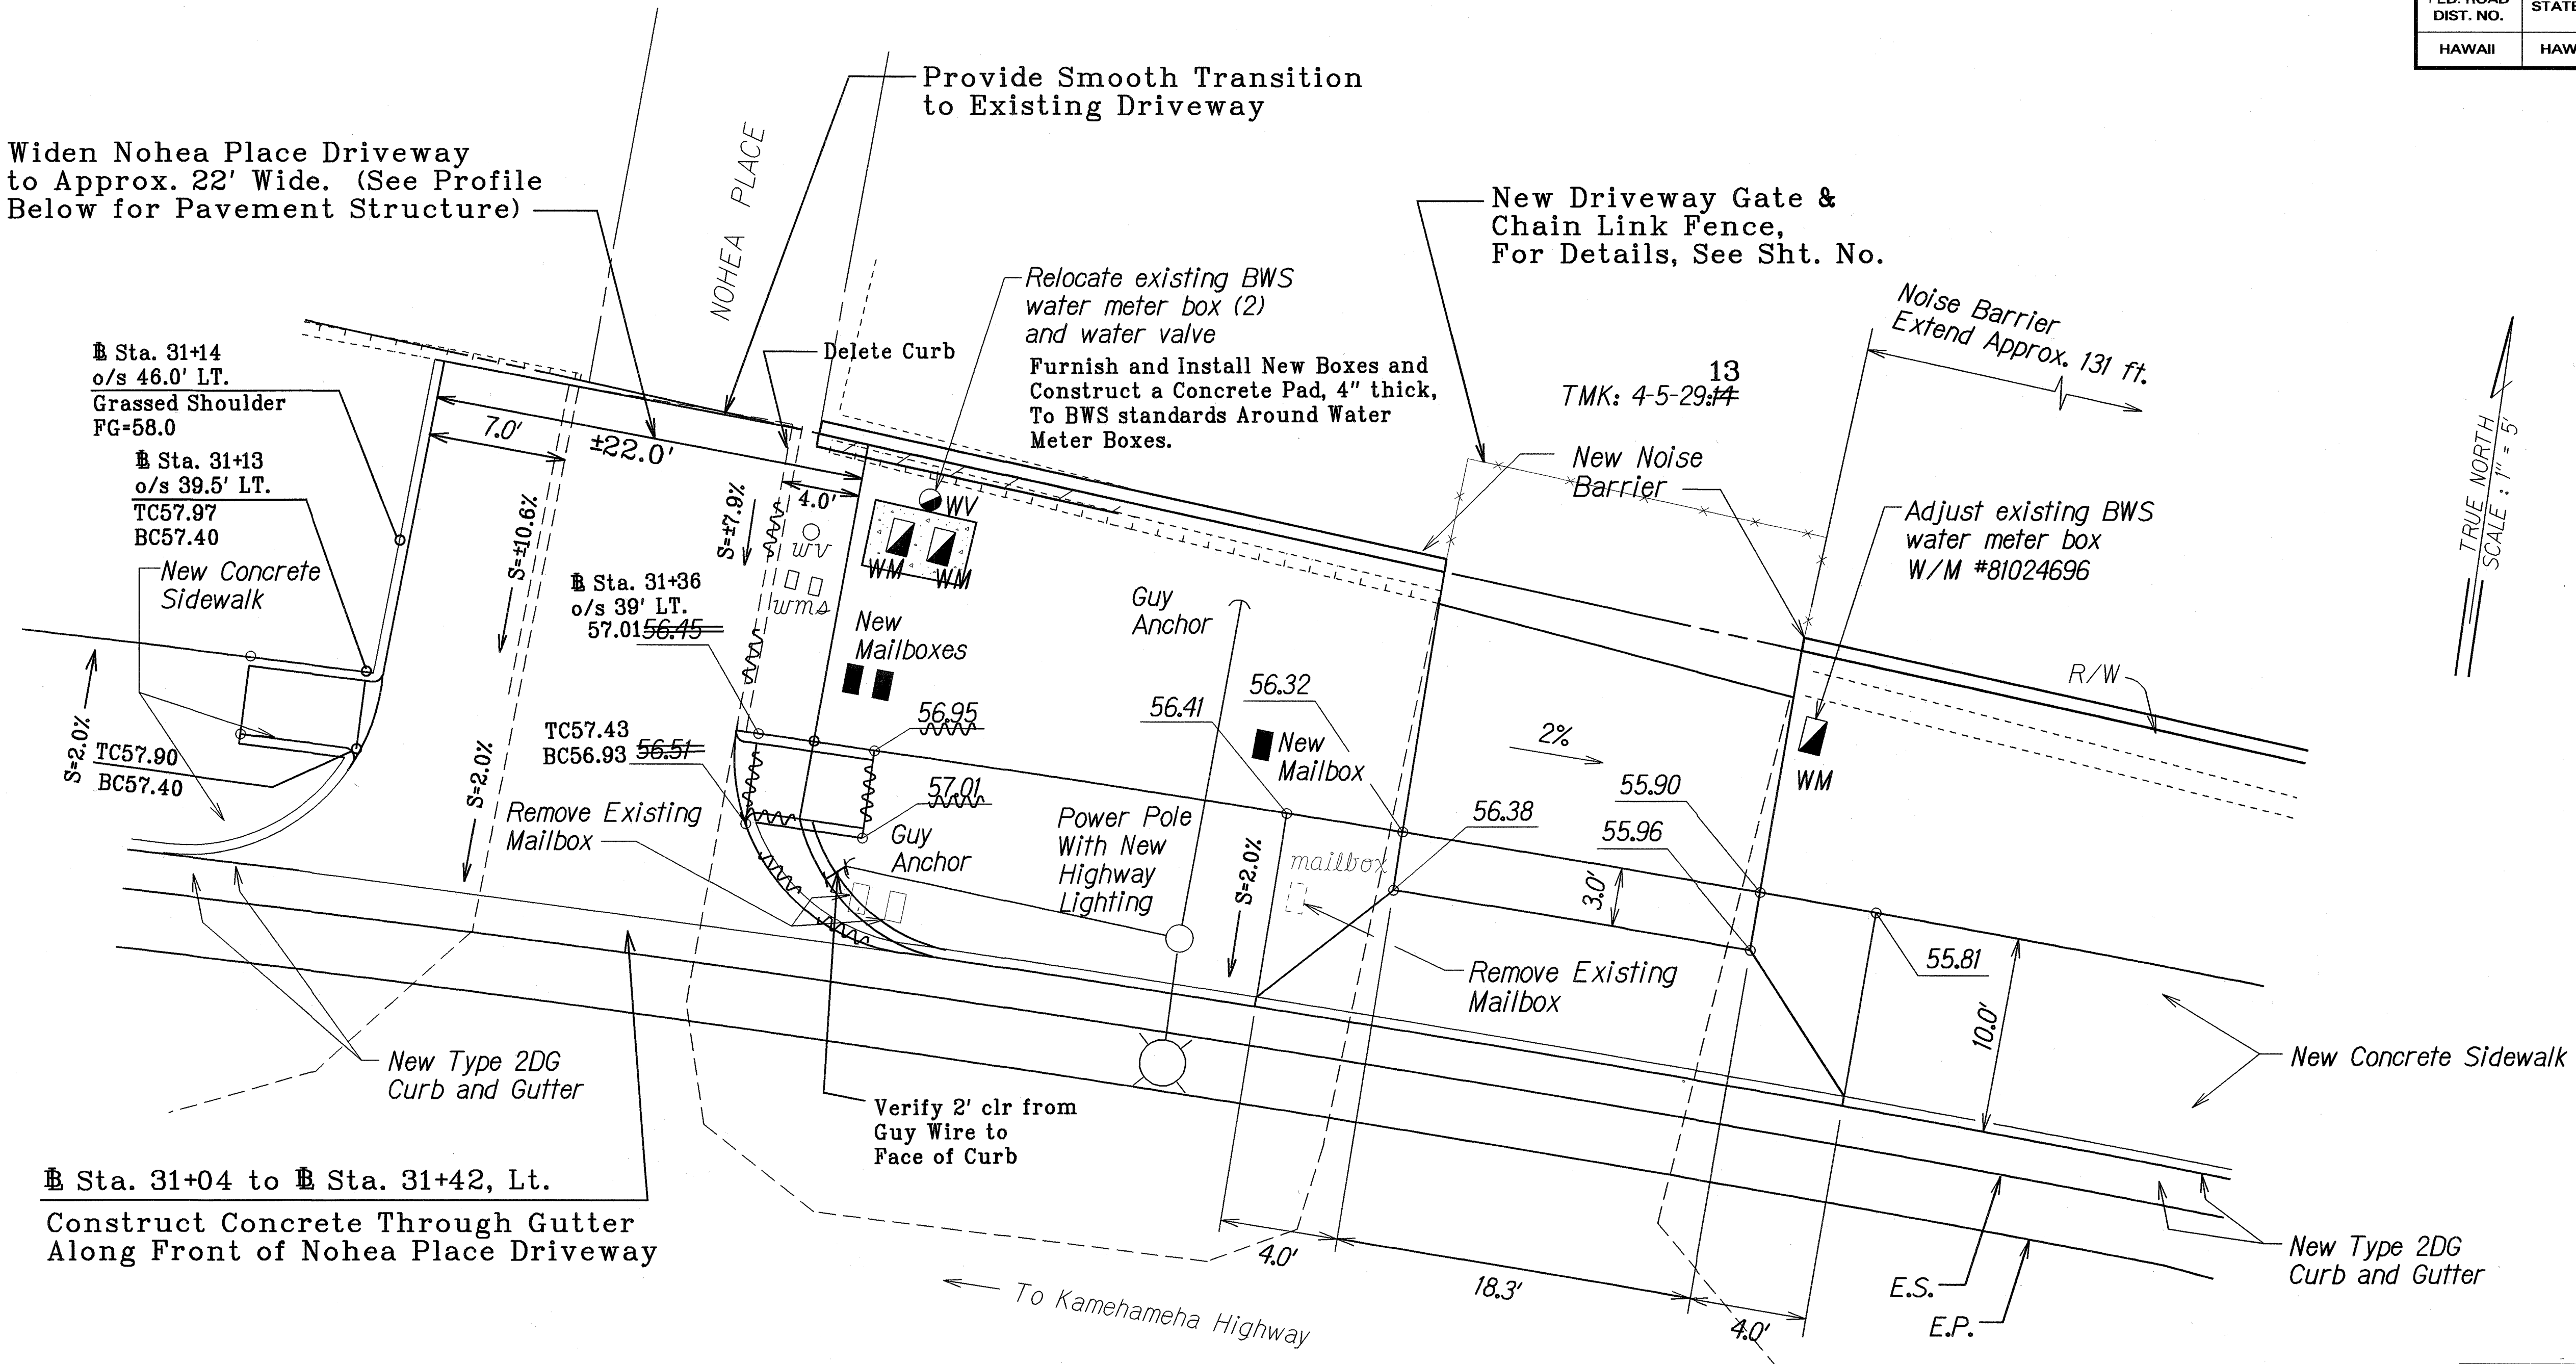

Sta. 31+04 to Sta. 31+42, Lt.
Construct Concrete Through Gutter Along Front of Nohea Place Driveway

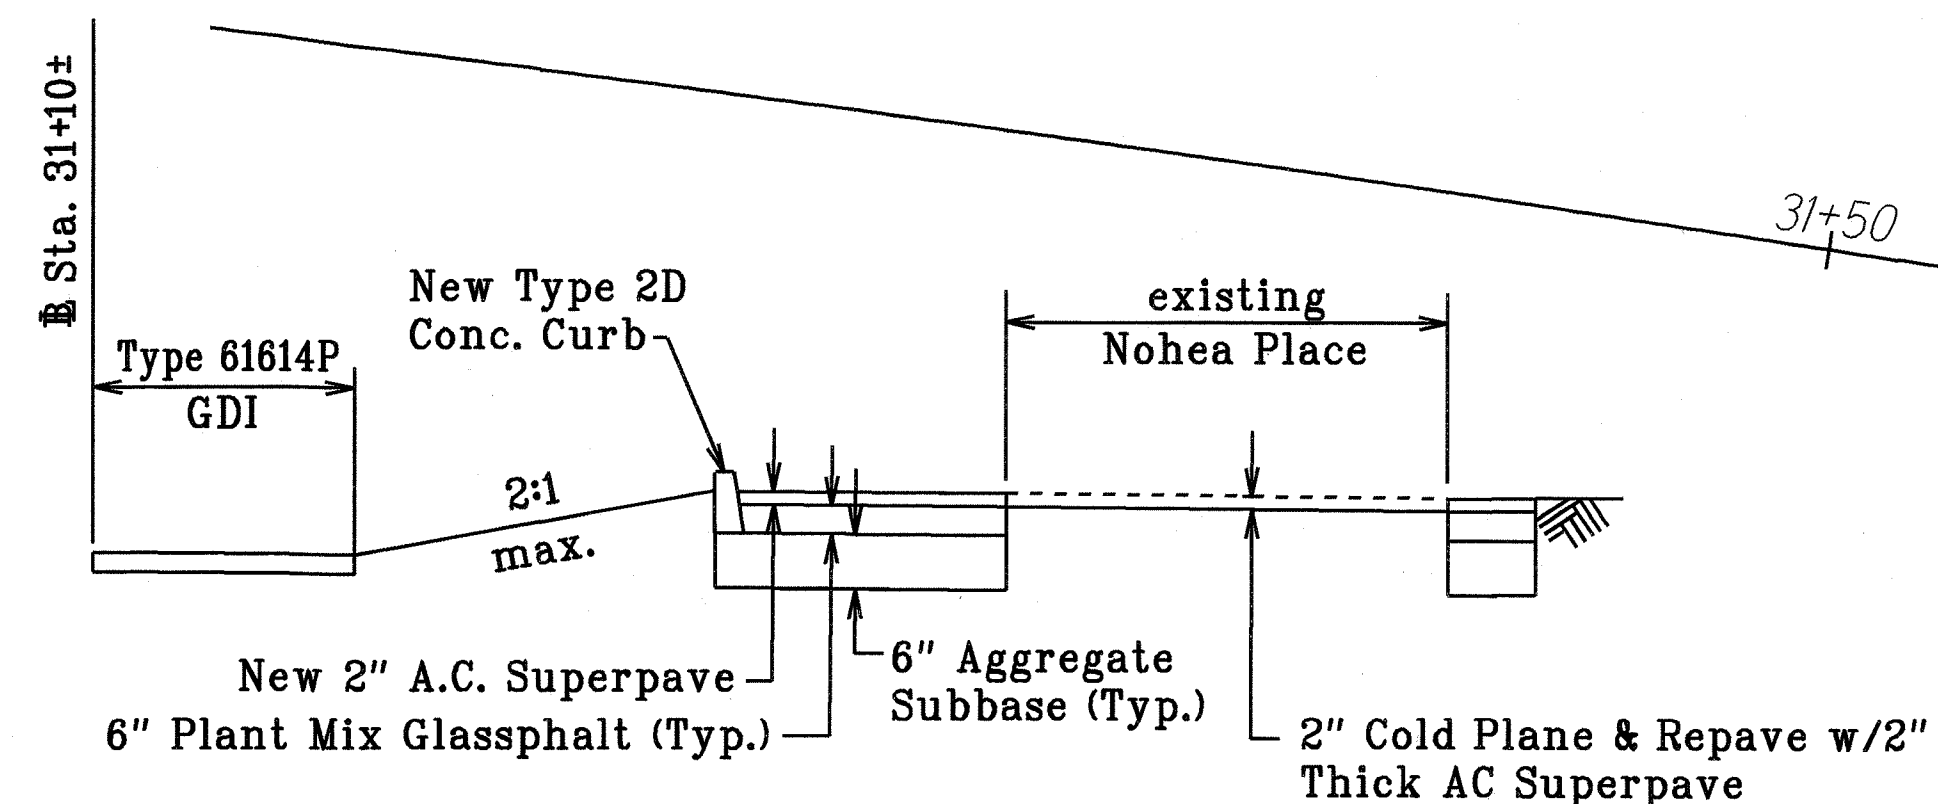

PROFILE at NOHEA PLACE
NTS

LEGEND FOR AS-BUILT POSTINGS	
	Squiggly line for as-built deletion
	Double line for as-built deletion
Roadway	Text for as-built posting


STATE OF HAWAII
DEPARTMENT OF TRANSPORTATION
HIGHWAYS DIVISION

DETAIL ROADWAY PLAN
KANEHOE BAY DRIVE IMPROVEMENTS
Vicinity of Puohala Street to Kawa Bridge
Federal Aid Project No. STP-065-1(9)
Scale: 1"=5' Date: June, 2002
SHEET No. 8 OF 9 SHEETS


APPROVED BY:

PRINCIPAL EXECUTIVE, MAINTENANCE UNIT, DATE 1/21/02
BOARD OF WATER SUPPLY
CITY AND COUNTY OF HONOLULU

FED. ROAD DIST. NO.	STATE	FED. AID PROJ. NO.	FISCAL YEAR	SHEET NO.	TOTAL SHEETS
HAWAII	HAW.	STP-065-1(9)	2003	ADD. 43	114

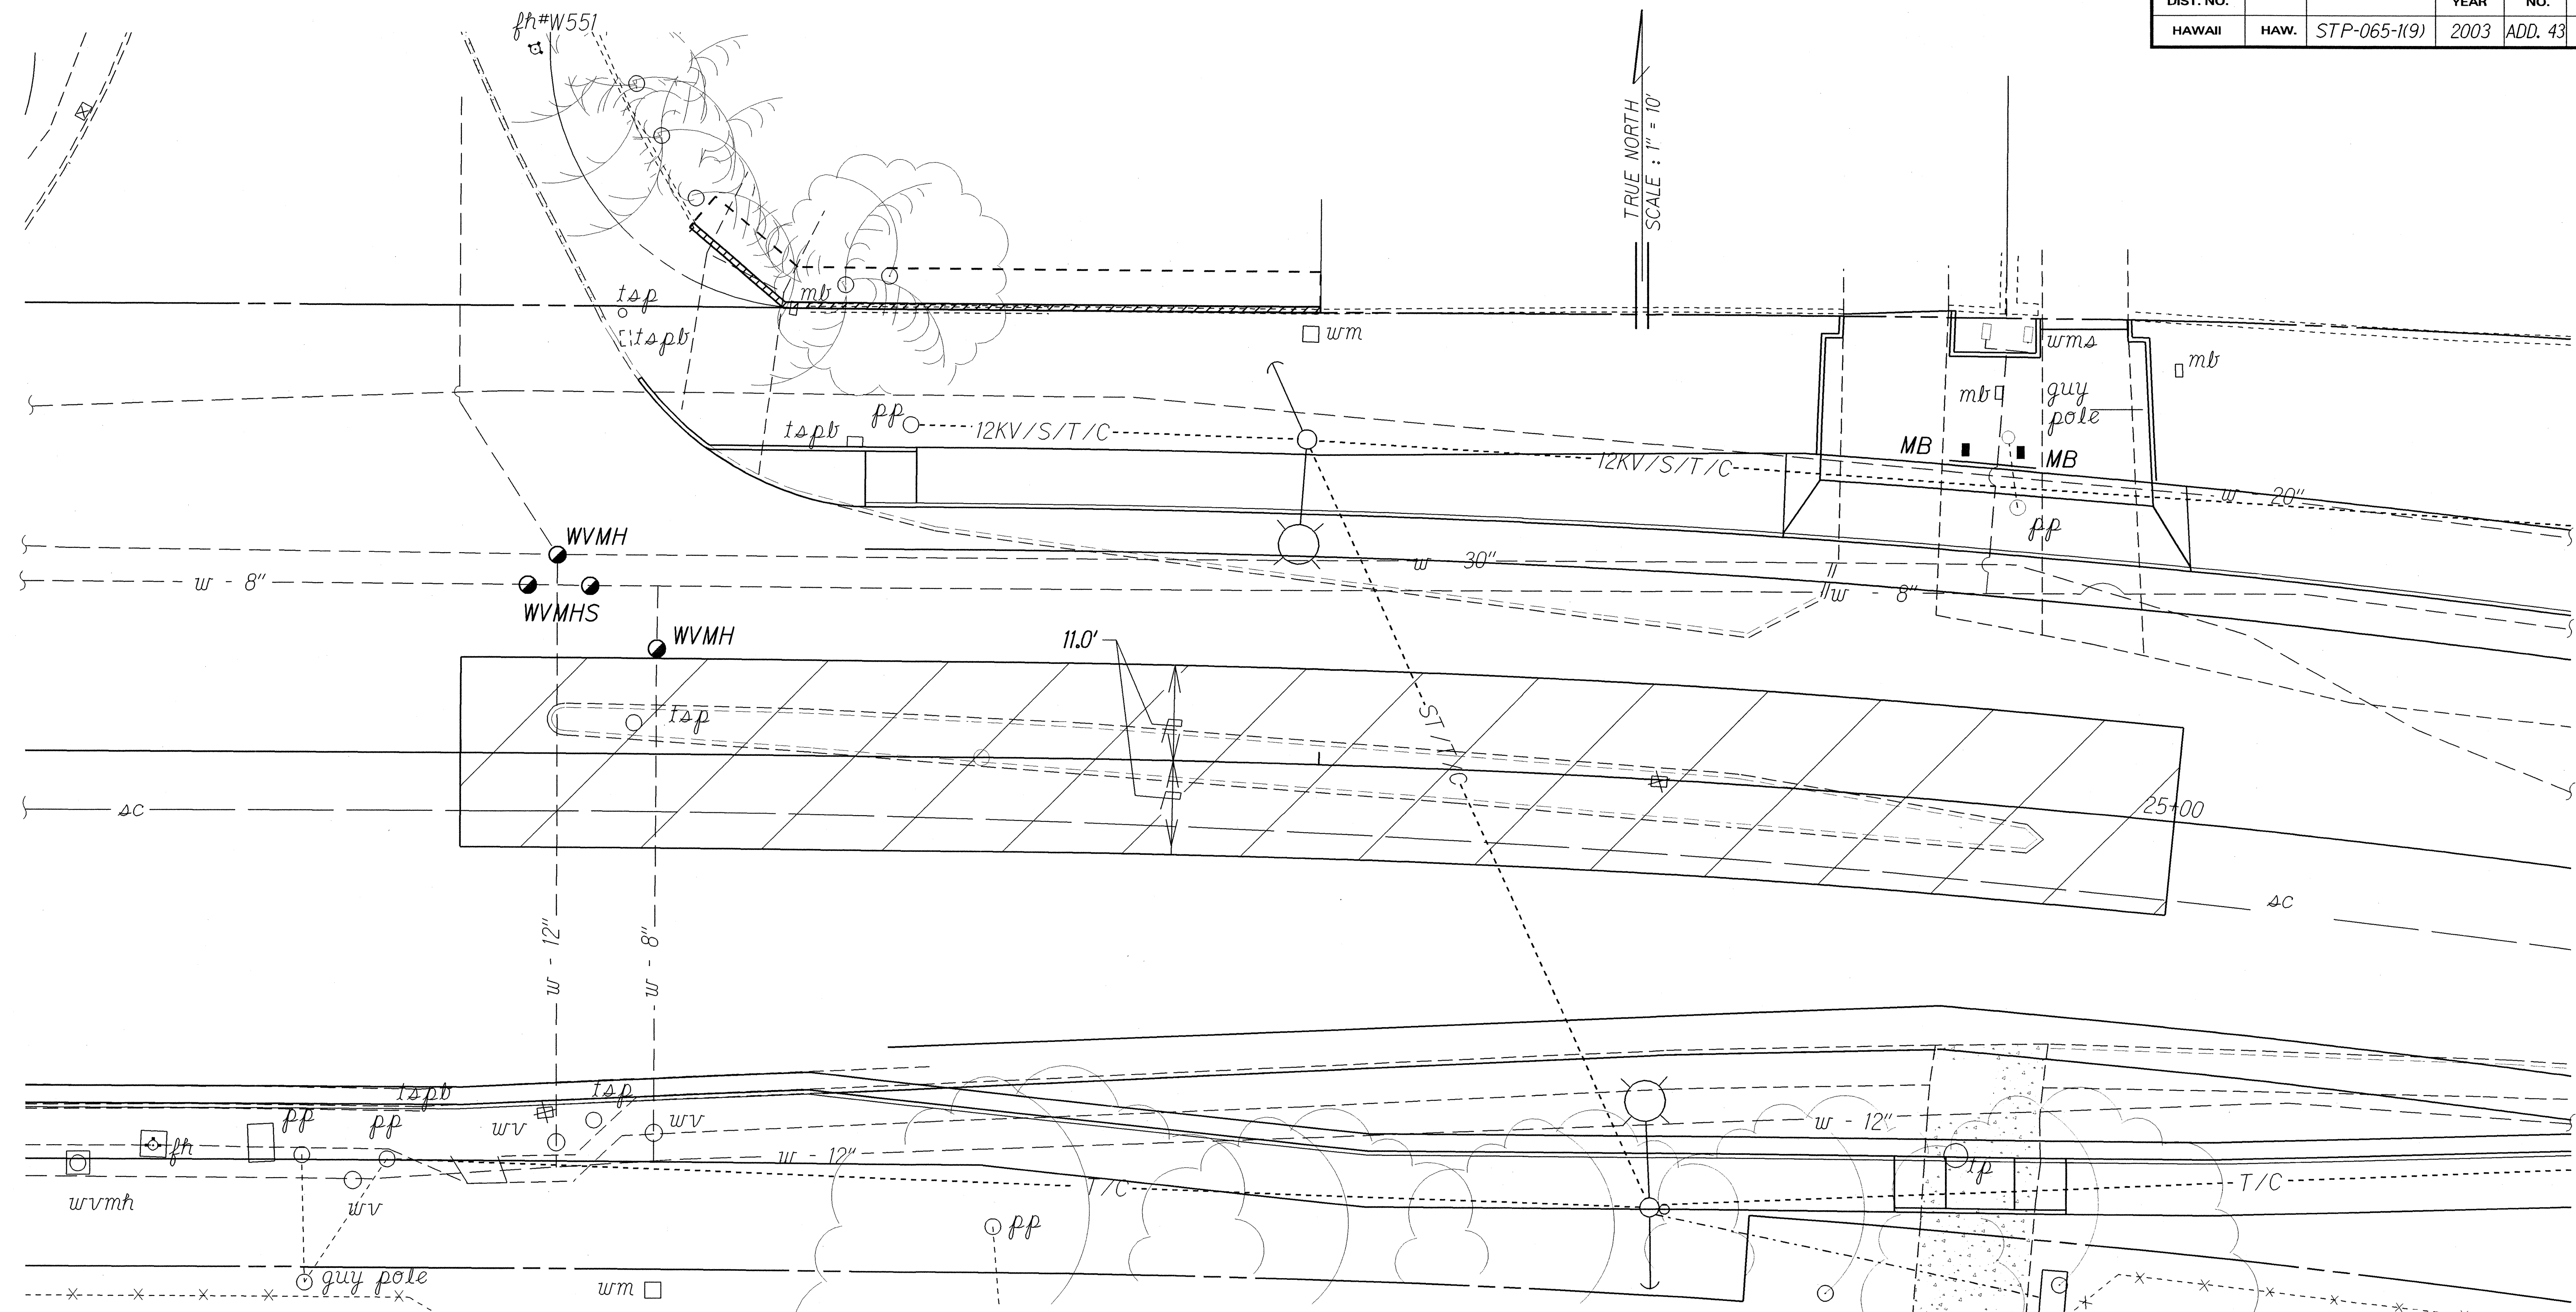

Sta. 23+00 to # Sta. 25+00
 Remove Existing Island (2.5' Below
 New Pavement Grade) and Restore
 with New Pavement Structure. For
 Pavement Structure Detail, See this
 Sheet.

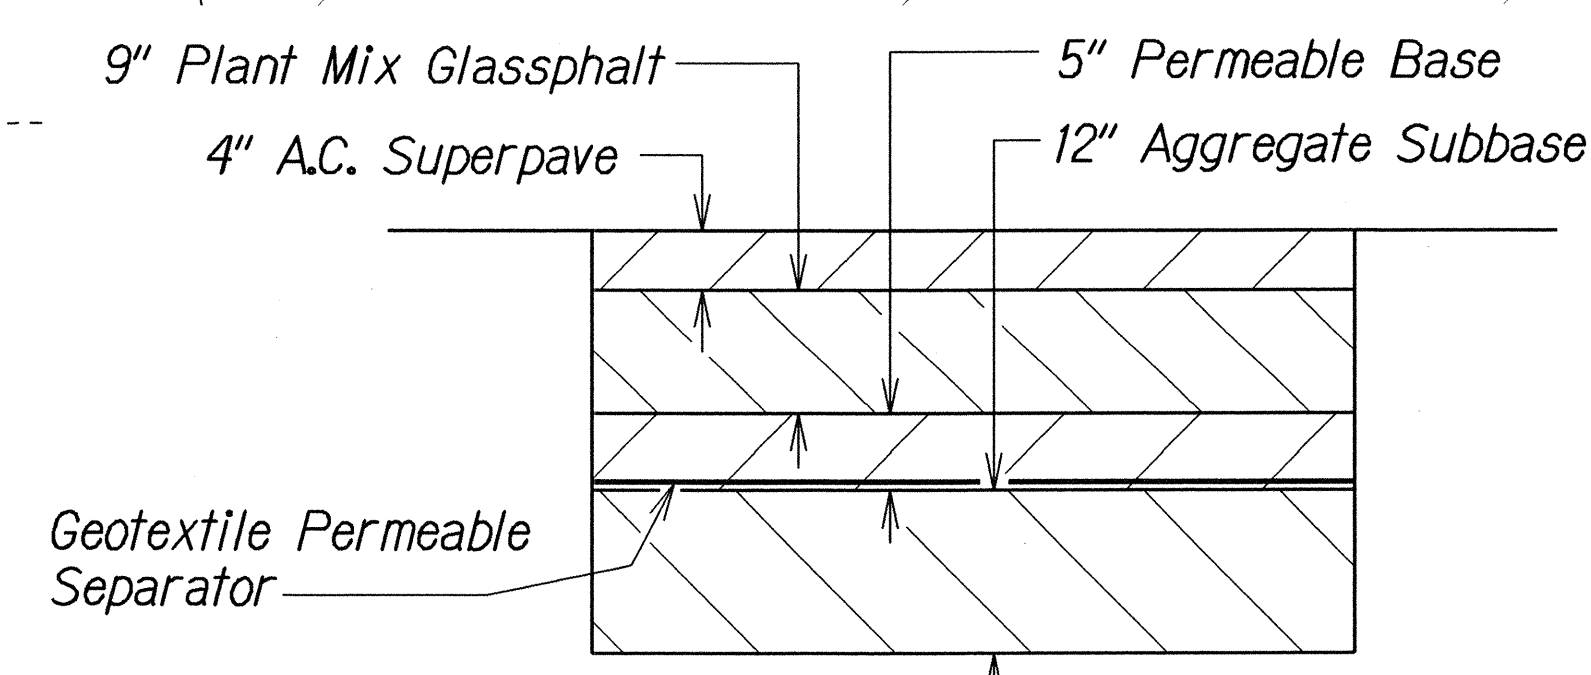

2/3/03 Revised Driveway per Addendum No. 1

DATE	REVISION
------	----------

STATE OF HAWAII
 DEPARTMENT OF TRANSPORTATION
 HIGHWAYS DIVISION

DETAIL ROADWAY PLAN
 KANE OHE BAY DRIVE IMPROVEMENTS
 Vicinity of Puohala Street to Kawa Bridge
 Federal Aid Project No. STP-065-1(9)
 Scale: 1"=10' Date: June, 2002

SHEET No. 9 OF 9 SHEETS

ADD. 43

ORIGINAL PLAN	DATE
DESIGNED BY	19/20/00
TRACED BY	
NOTED BY	
DESIGNED BY	
TRACED BY	
NOTED BY	
DESIGNED BY	
TRACED BY	
NOTED BY	
DESIGNED BY	
TRACED BY	
NOTED BY	