


FED. ROAD DIST. NO.	STATE	FED. AID PROJ. NO.	FISCAL YEAR	SHEET NO.	TOTAL SHEETS
HAWAII	HAW.	A 72-01-66	1966	2	2

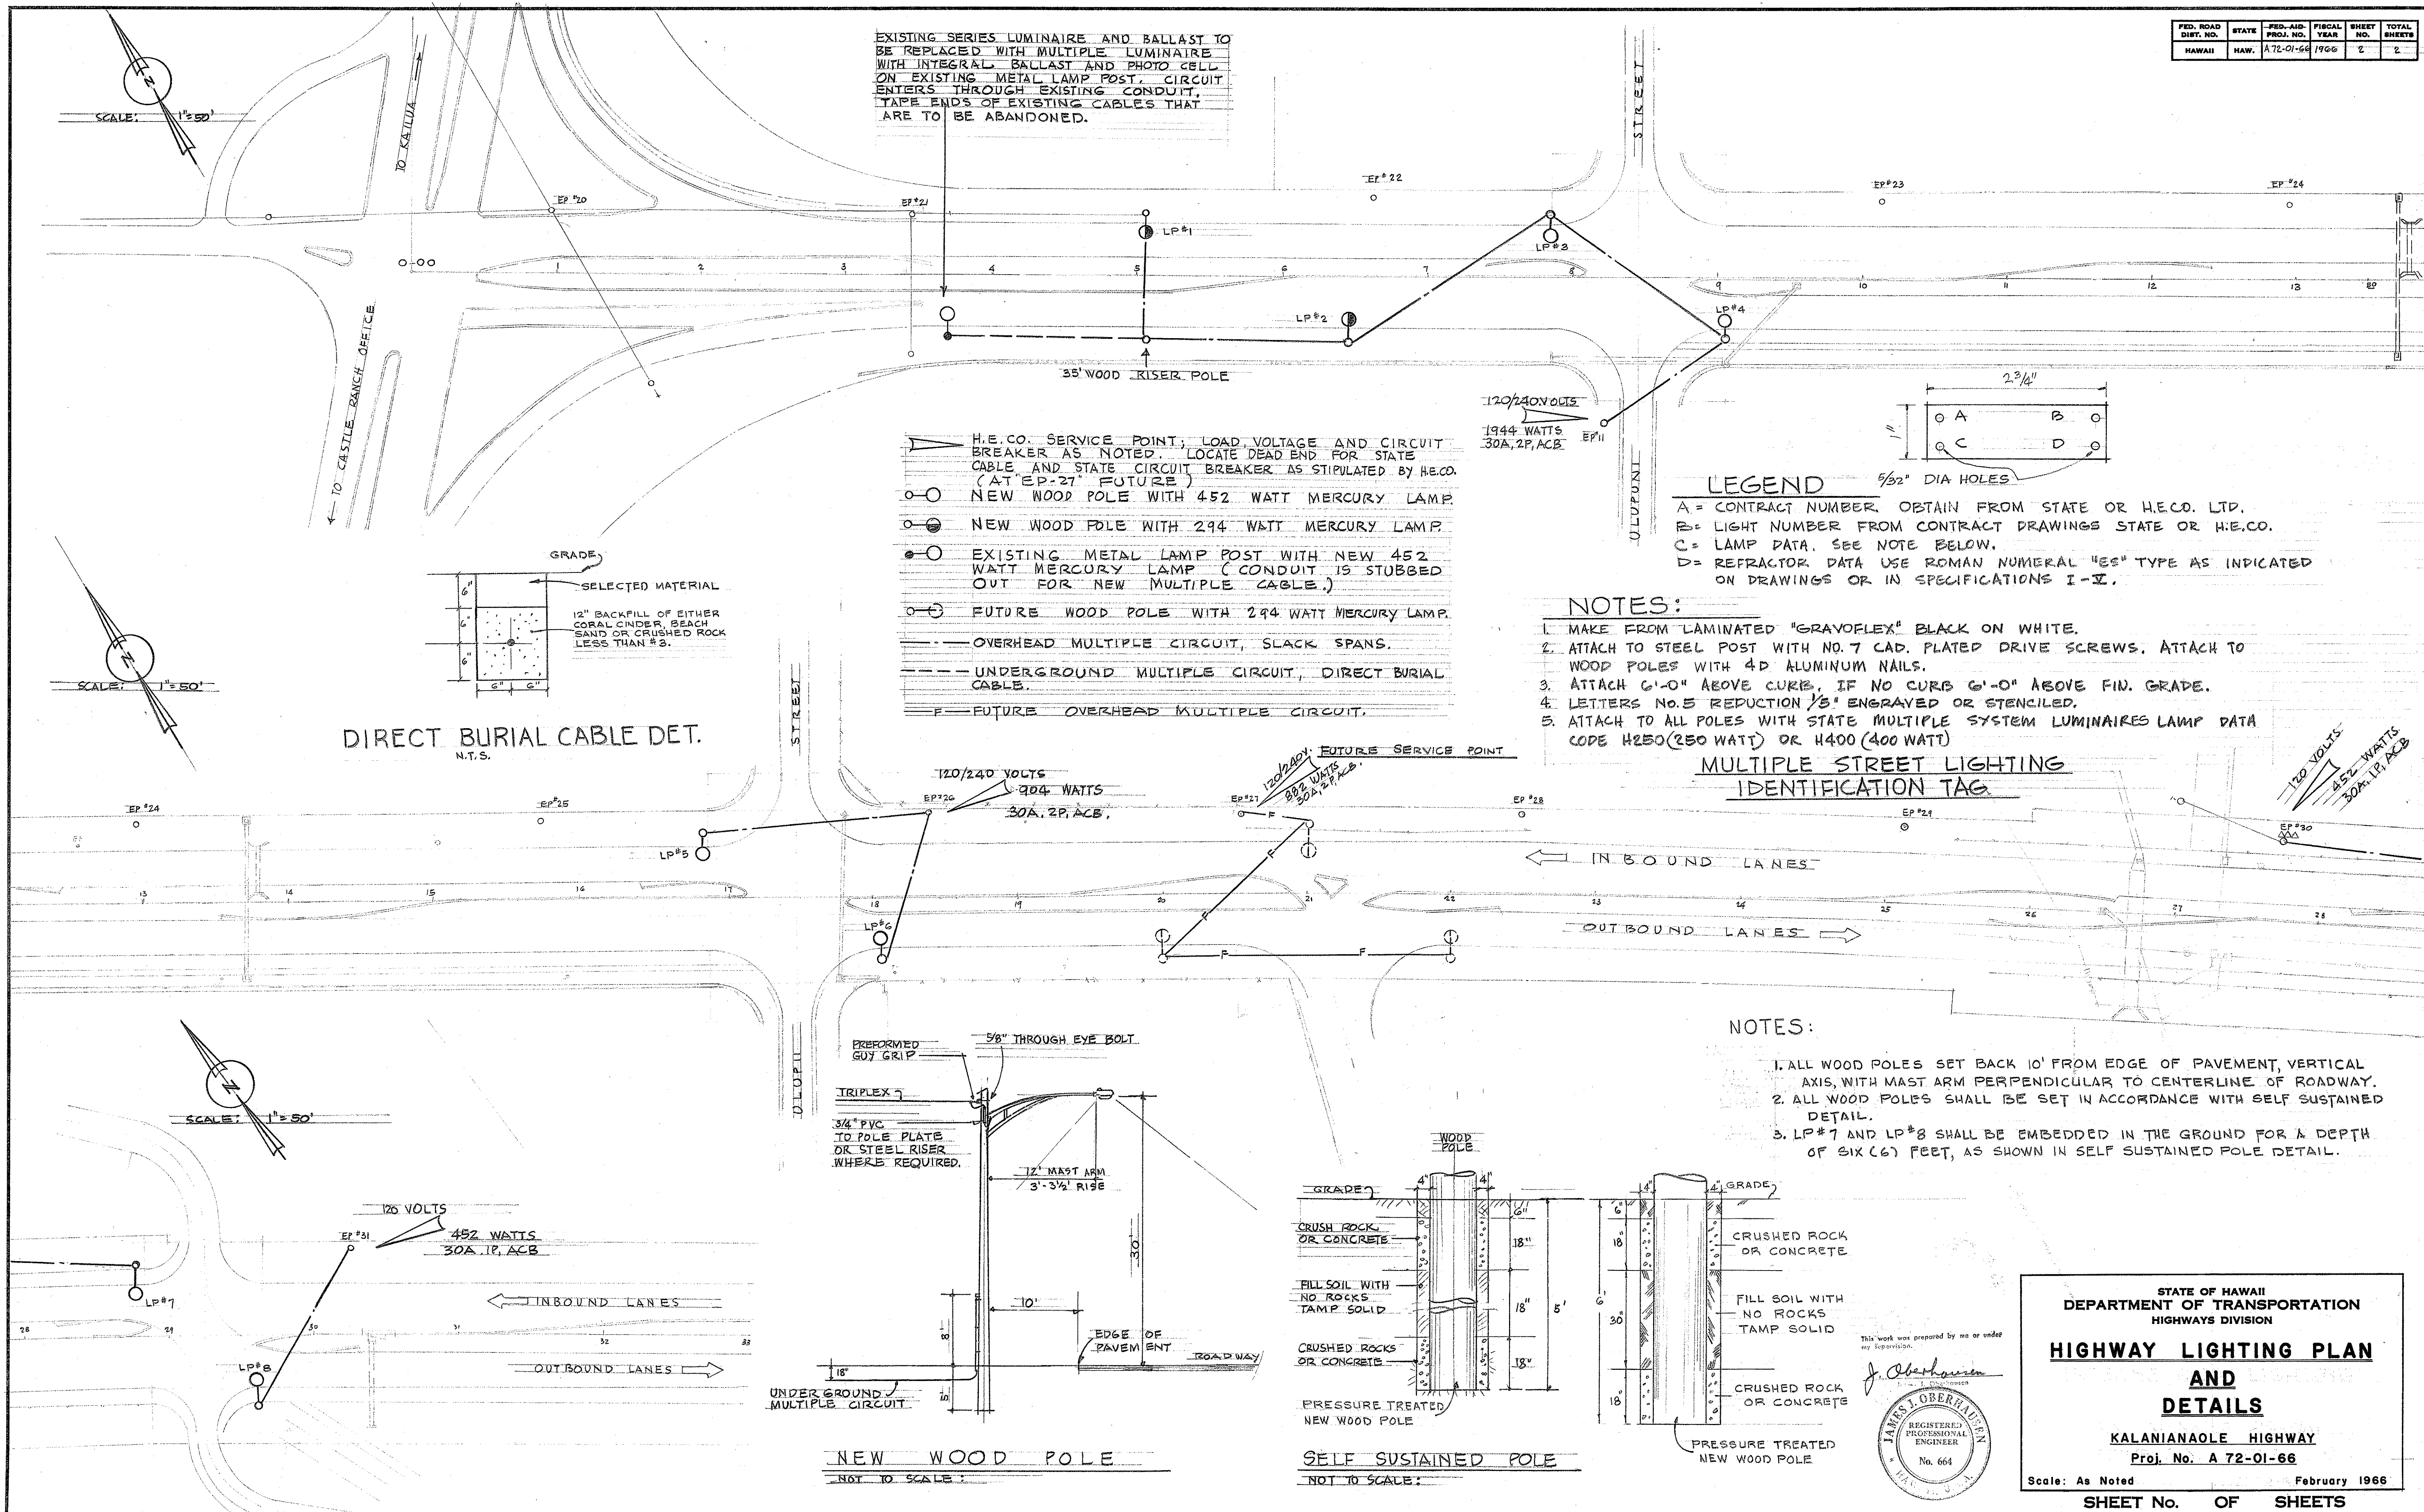

DATE	_____
DESIGNED BY	_____
CHECKED BY	_____
NOTED BY	_____
NO.	_____

STATE OF HAWAII
DEPARTMENT OF TRANSPORTATION
HIGHWAYS DIVISION

**HIGHWAY LIGHTING PLAN
AND
DETAILS**

KALANIANA'OLE HIGHWAY
Proj. No. A 72-01-66

Scale: As Noted February 1966

SHEET No. OF SHEETS