
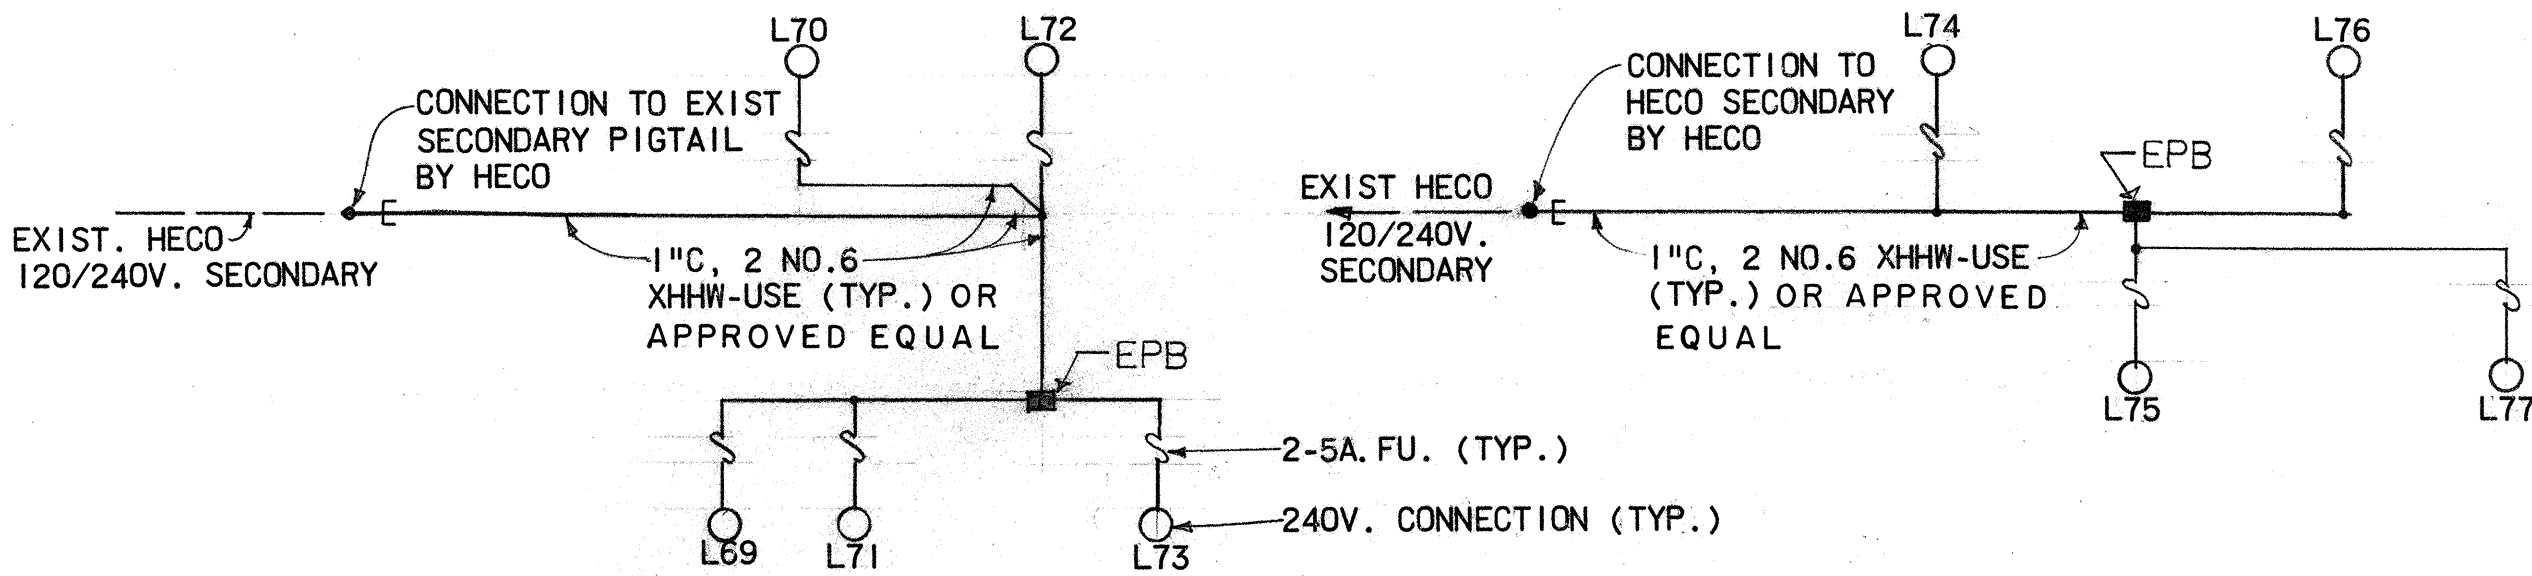



FED. ROAD DIST. NO.	STATE	FED. PROJ. NO.	FISCAL YEAR	SHEET NO.	TOTAL SHEETS
HAWAII	HAW.	72A-01-75	1977	2	4

ELECTRICAL SYMBOLS


- NEW HIGHWAY LIGHTS, SEE SHEET 3 FOR DETAILS
- EXISTING STREET LIGHT
- ELECTRIC PULLBOX, TYPE B, NEW
- STREET LIGHT NO. 1
- NEW UNDERGROUND LINES
- EXISTING PULLBOX
- C.O. EXISTING CLEANOUT
- T.S. EXISTING TRAFFIC SIGNAL
- EHH EXISTING ELECTRIC HANDHOLE
- EPB ELECTRIC PULLBOX
- TPB EXISTING TRAFFIC PULLBOX
- W EXISTING WATER LINE
- D EXISTING DRAIN LINE
- EXISTING UNDERGROUND LINE
- WM. EXISTING WATER METER

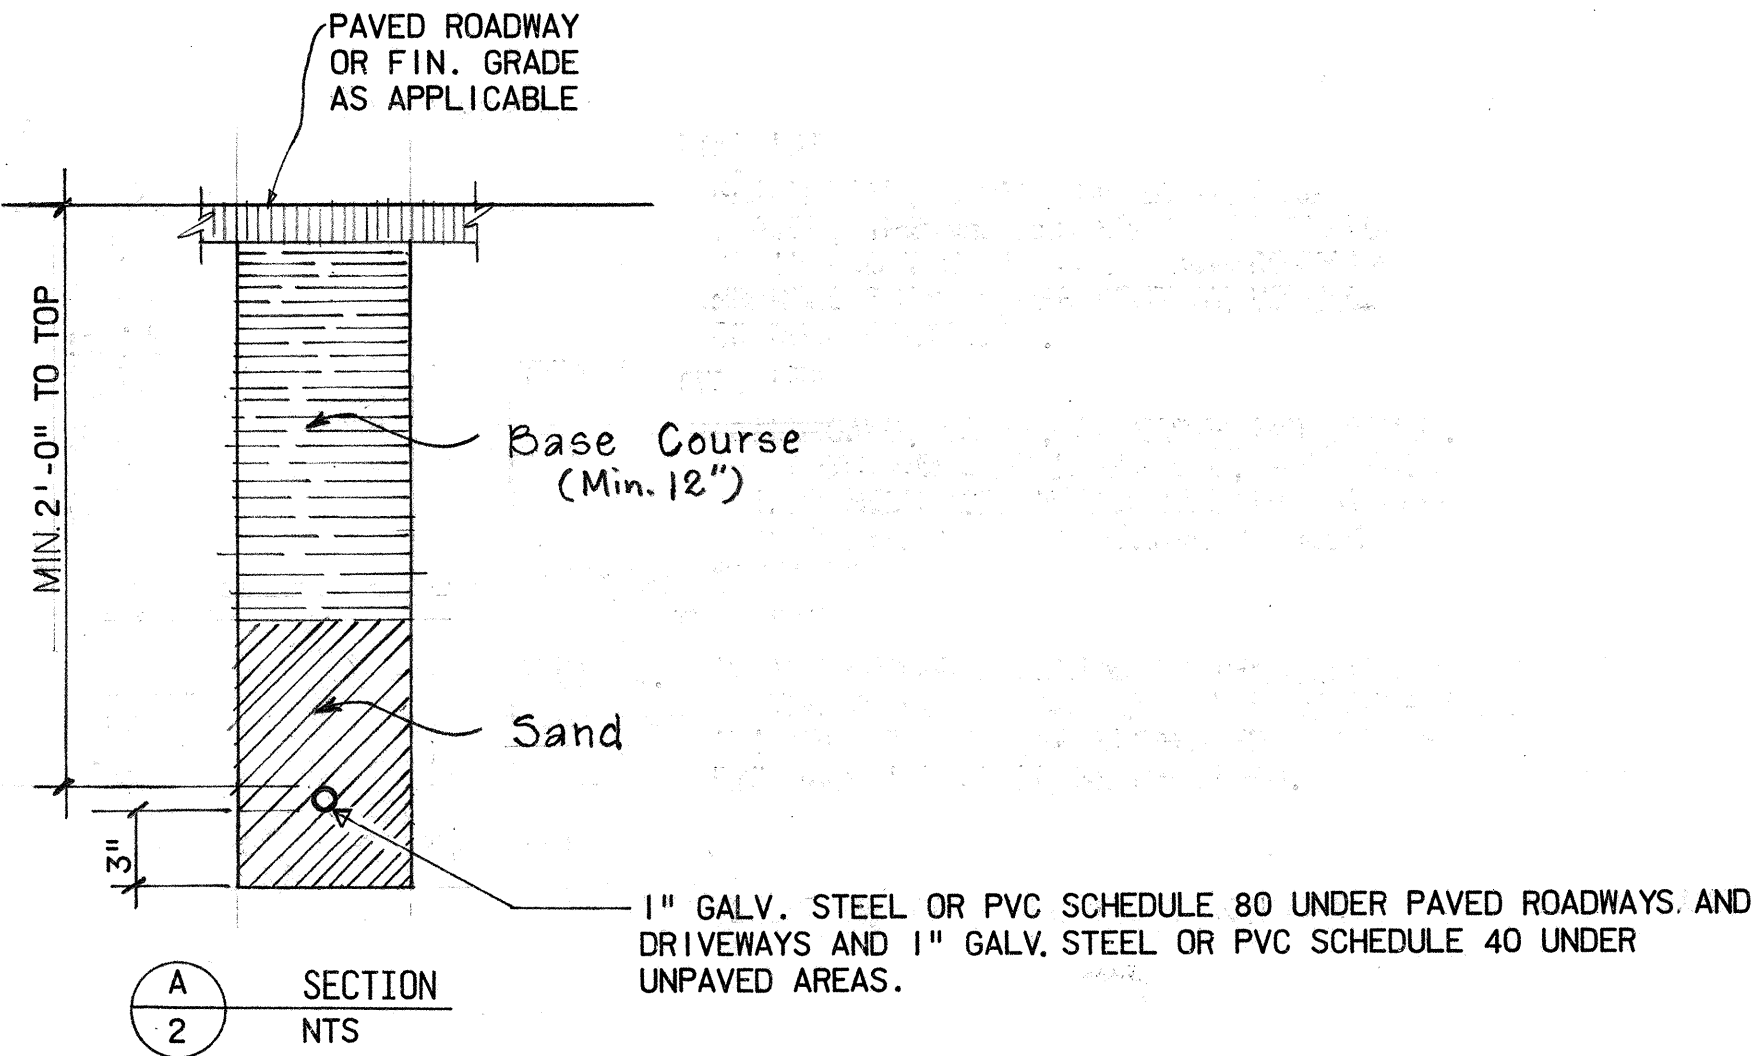

SINGLE LINE DIAGRAM

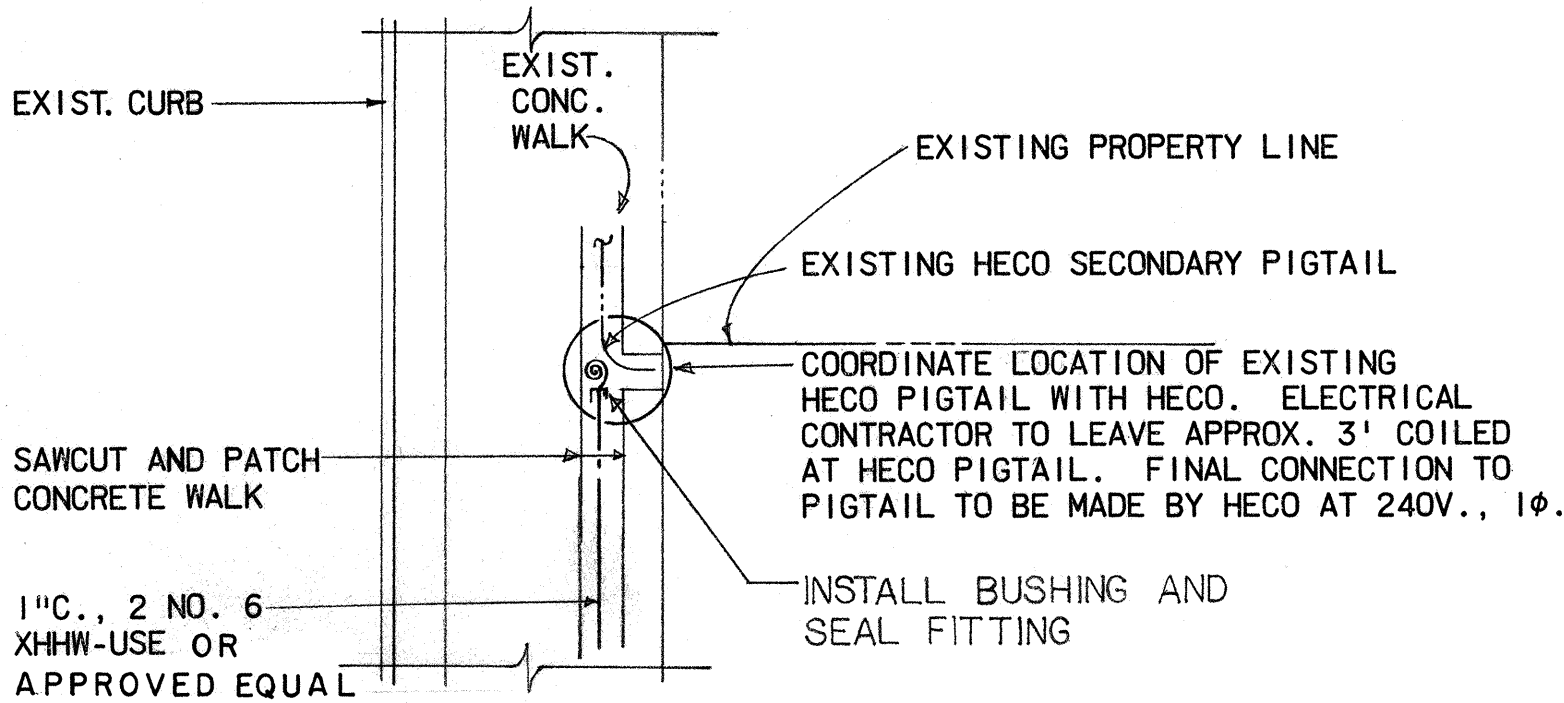

TYPICAL CONNECTION TO EXISTING HECO PIGTAIL

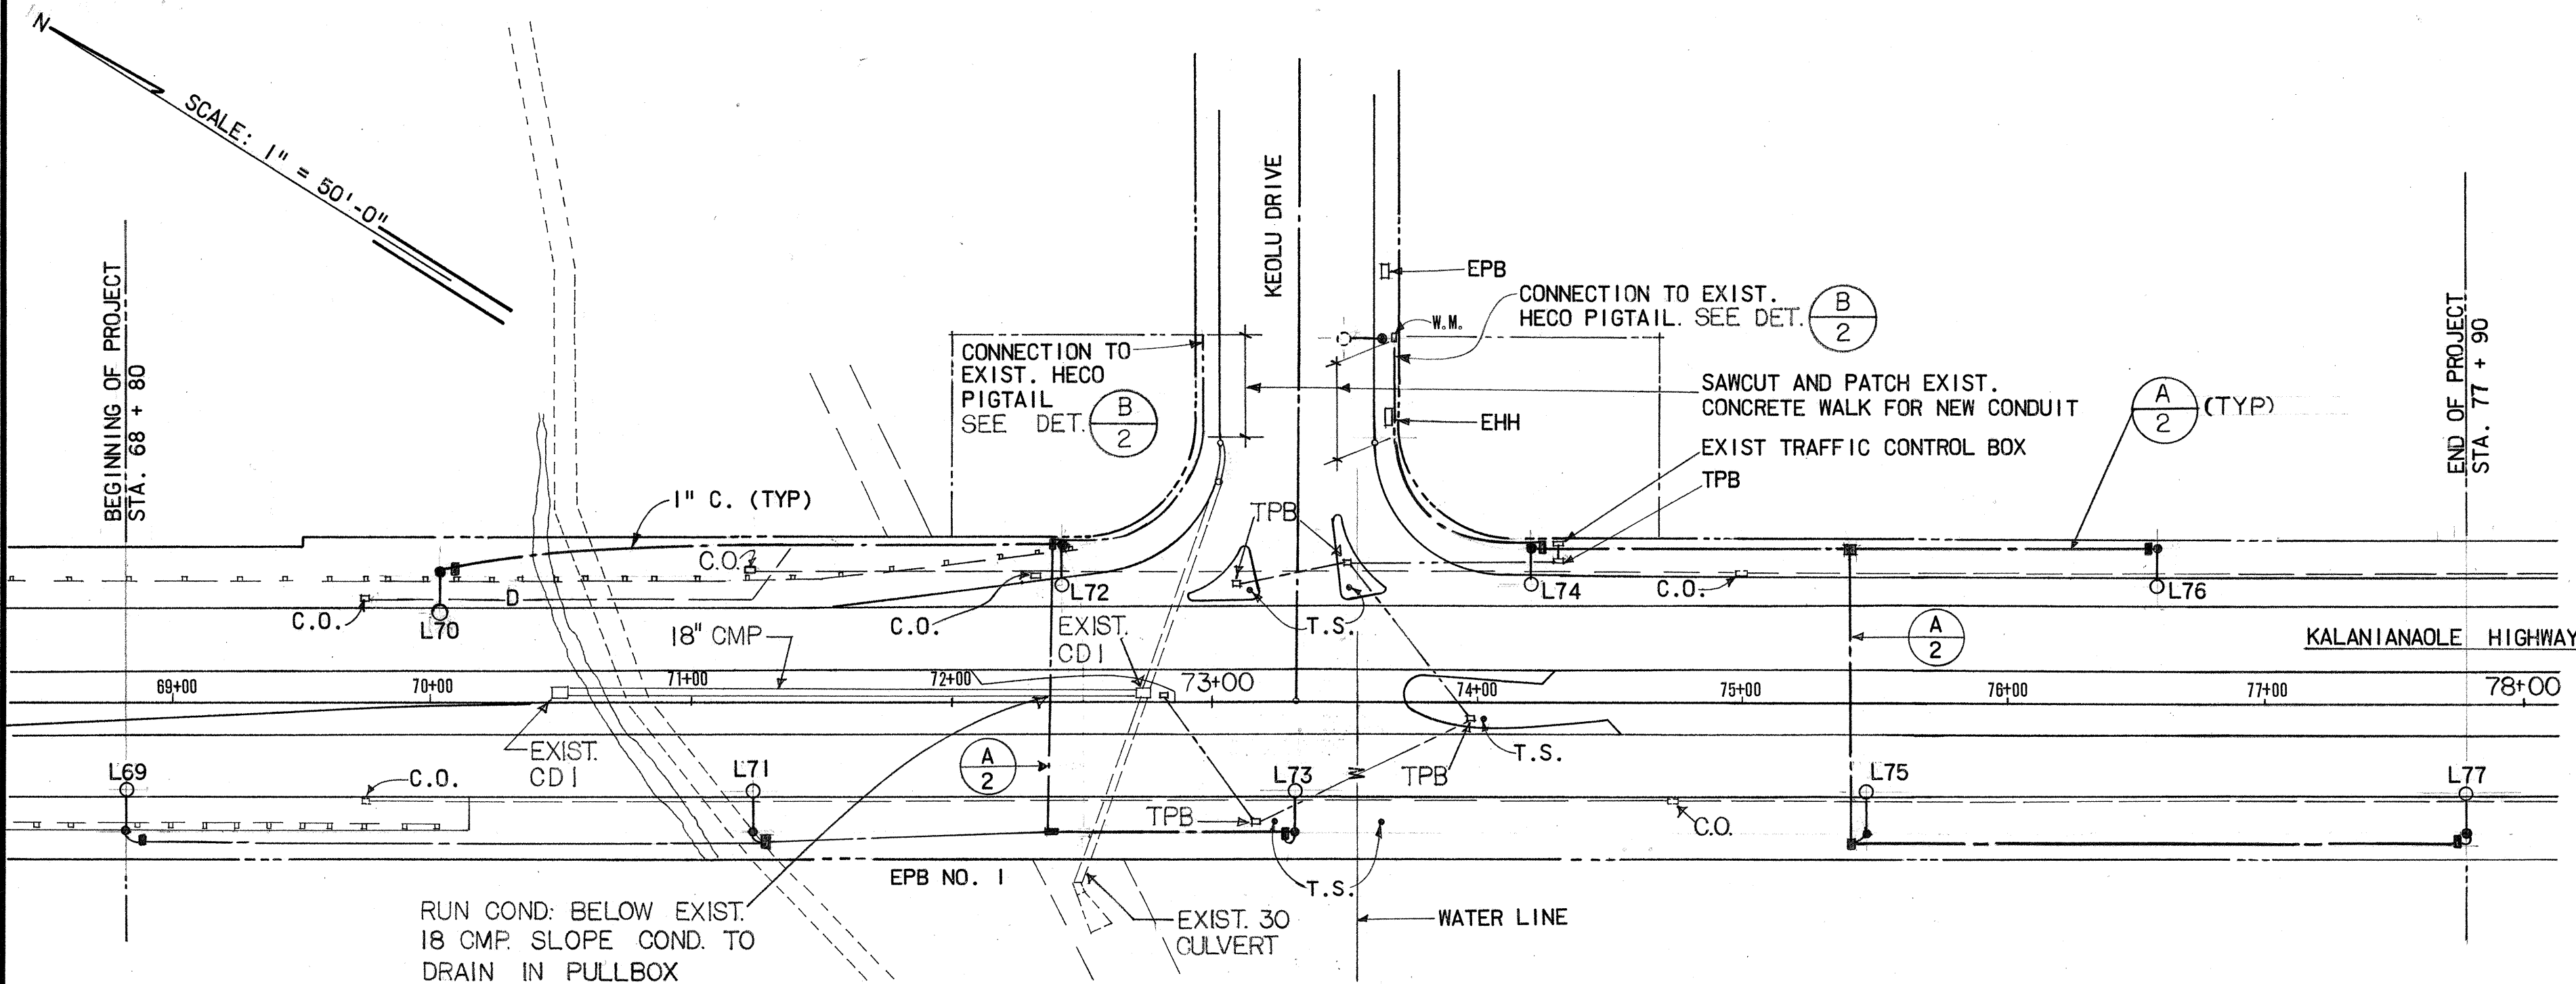

STREET LIGHTING PLAN

DATE	_____
SURVEY PLOTTED BY	_____
DRAWN BY	_____
DESIGNED BY	_____
CHECKED BY	_____
NOTE BOOK	_____
NO.	_____



THIS WORK WAS PREPARED BY ME
OR UNDER MY SUPERVISION
Albert S. C. Chong
Albert S. C. Chong, P.E.

STATE OF HAWAII
DEPARTMENT OF TRANSPORTATION
HIGHWAYS DIVISION

KALANIANA'OLE HIGHWAY
HIGHWAY LIGHTING AT KEOLU DRIVE
PROJECT NO. 72A-01-75