


FED. ROAD DIST. NO.	STATE	PROJ. NO.	FISCAL YEAR	SHEET NO.	TOTAL SHEETS
HAWAII	HAW.	72C-01-19	2019	11	48

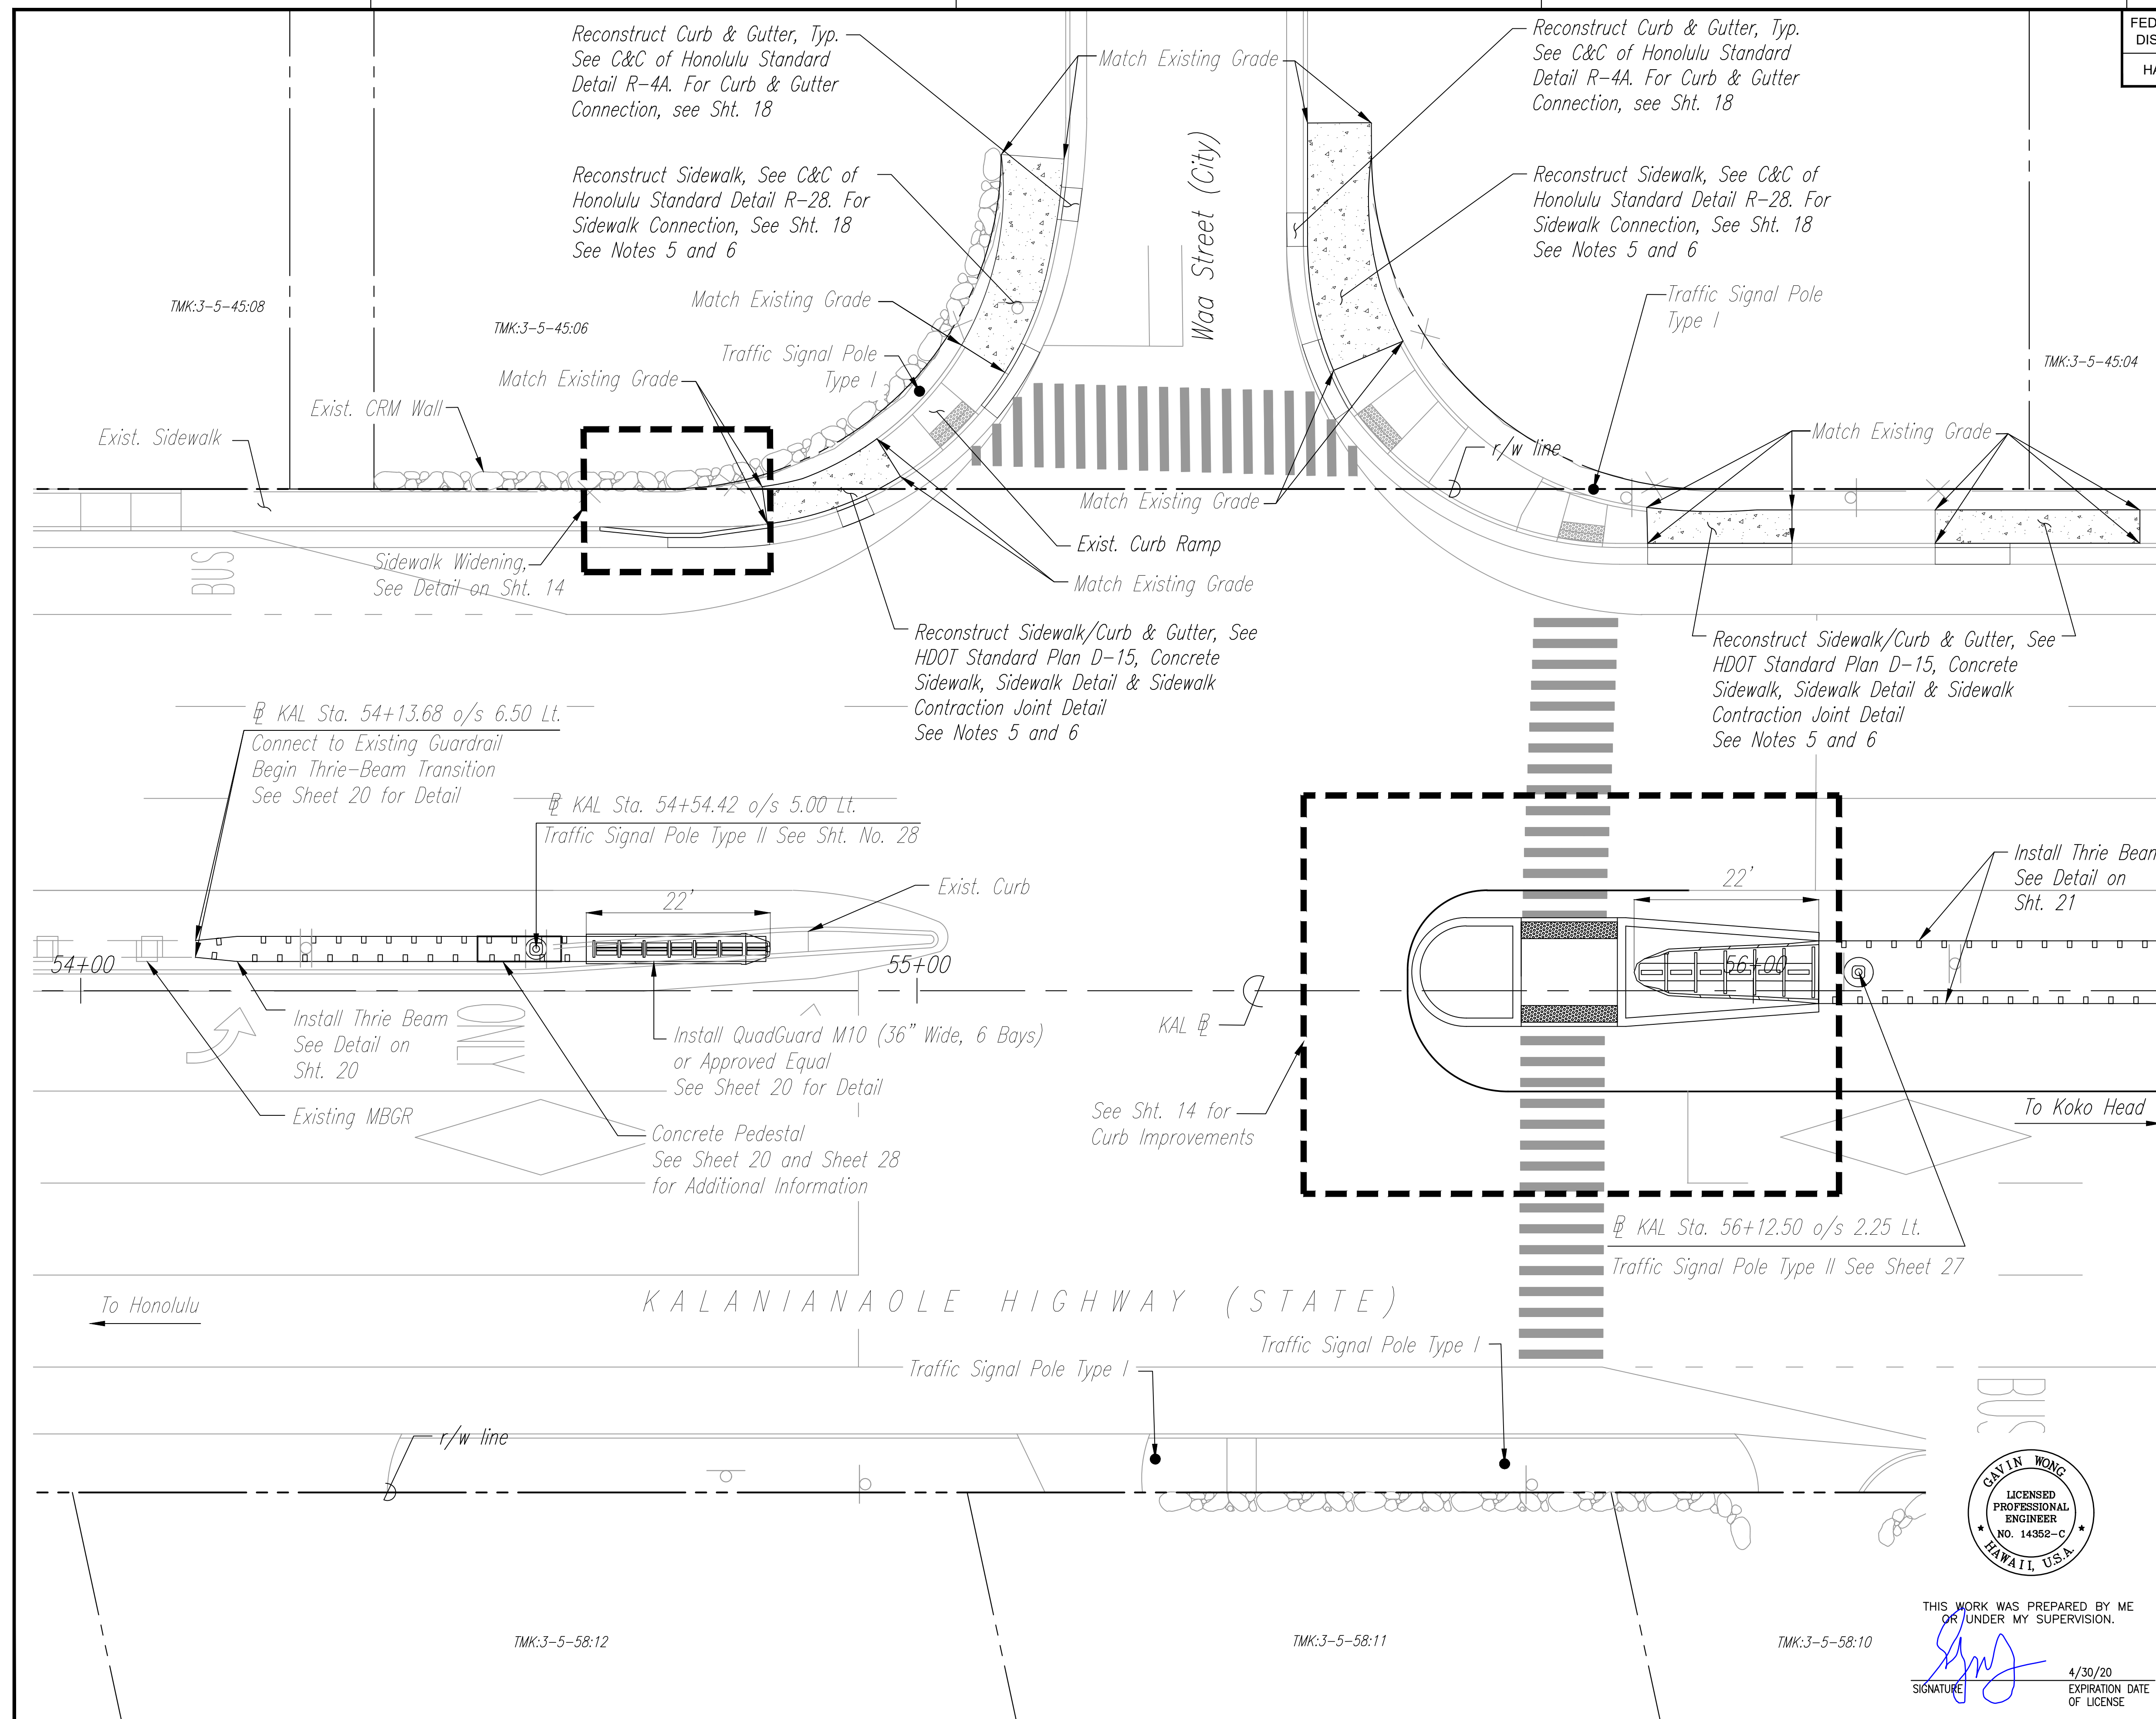


NOTES:

1. See Traffic Signal Foundation Details for Traffic Pole Information on Sheets 27–28.
2. Type II Traffic Signal Poles shown for information only. For additional information, see Electrical Plans.
3. For Additional Guardrail to Concrete Pedestal Details see Sheet 20.
4. See Sheets 20–25 for additional Guardrail Details.
5. Concrete Sidewalk Replacement to end at a joint or scored line.
6. Limits of Sidewalk Reconstruction is based on Electrical Distribution Plan limits. For additional information, see Electrical Plans.

M.L. ~~6~~ STA. 56+50

LEGEND

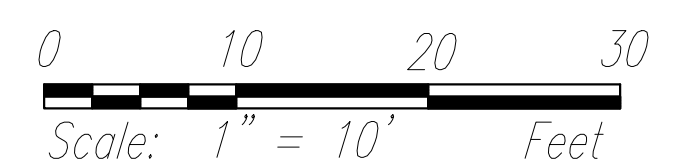


STATE OF HAWAII
DEPARTMENT OF TRANSPORTATION
HIGHWAYS DIVISION

ROADWAY IMPROVEMENT PLANS
KALANIANA'OLE HIGHWAY
TRAFFIC SIGNAL INSTALLATION AT WAA ST.
Project No. 72C-01-19

Scale 1"=10' Date: November 2019
SHEET No. 1 OF 2 SHEETS

ORIGINAL PLAN	SURVEY PLOTTED BY _____ DATE _____
NOTE BOOK	DRAWN BY _____
	TRACED BY _____
	DESIGNED BY _____
	QUANTITIES BY _____
No. _____	CHECKED BY _____




THIS WORK WAS PREPARED BY ME
OR UNDER MY SUPERVISION.

SIGNATURE 4/30/20
EXPIRATION D
OF LICENSE

11

FED. ROAD DIST. NO.	STATE	PROJ. NO.	FISCAL YEAR	SHEET NO.	TOTAL SHEETS
HAWAII	HAW.	72C-01-19	2019	12	48

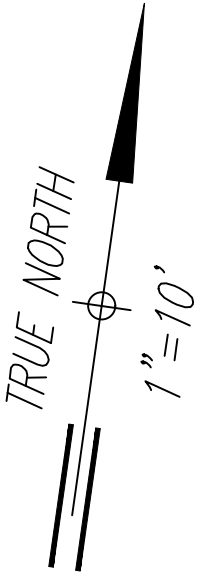

TMK:3-5-45:04

TMK:3-5-45:02

TMK:3-5-45:01

TMK:3-5-46:01

r/w line

To Honolulu

KALANIANA'OLE HIGHWAY (STATE)

To Koko Head

⊕ KAL Sta. 56+72.00 o/s 6.00 Lt.

End Midwest Guardrail System
Begin Transition to Strong Post Guardrail

⊕ KAL Sta. 57+00 o/s 6.00 Lt.

End Transition to Strong Post Guardrail
Connect to Existing MBGR

57+00

58+00

59+00

KAL ⊕

⊕ KAL Sta. 58+06.08 O/S 1.50 Rt.

End Midwest Guardrail System 153± LF
Begin Transition to Strong Post Guardrail

⊕ KAL Sta. 58+34.20 O/S 1.50 Rt.

End Transition to Strong Post Guardrail
Connect to Existing MBGR

Install Guardrail
See Detail on
Sht. 21

Install Guardrail
See Detail on
Sht. 21

ONLY


r/w line

→

TMK:3-5-58:09

TMK:3-5-58:08

TMK:3-5-58:07

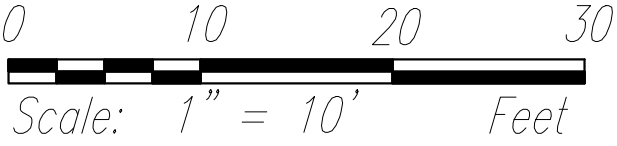

THIS WORK WAS PREPARED BY ME
OR UNDER MY SUPERVISION.

SIGNATURE: *[Signature]*

4/30/20
EXPIRATION DATE
OF LICENSE

STATE OF HAWAII
DEPARTMENT OF TRANSPORTATION
HIGHWAYS DIVISION

ROADWAY IMPROVEMENT PLANS

KALANIANA'OLE HIGHWAY

TRAFFIC SIGNAL INSTALLATION AT WAA ST.

Project No. 72C-01-19

Scale 1"=10'

Date: November 2019

ORIGINAL PLAN	SURVEY PLOTTED BY	DATE
NOTE BOOK	DRAWN BY	
No.	DESIGNED BY	
	QUANTITIES BY	
	CHECKED BY	