


INDEX TO DRAWINGS	
SHEET NO.	DESCRIPTION
1	TITLE SHEET
2	STANDARD PLAN SUMMARY
3-4	GENERAL NOTES, LEGEND, & ABBREVIATIONS
5-6	WATER POLLUTION & EROSION CONTROL NOTES
7	EROSION CONTROL PLAN & DETAILS
8	SURVEY CONTROL PLAN
9-10	DEMOLITION PLANS
11-12	ROADWAY IMPROVEMENT PLANS
13	CURB DETAILS
14-15	SIGNAGE AND STRIPING PLANS
16	PAVING PLAN
17-18	MISCELLANEOUS DETAILS
19-24	GUARDRAIL DETAILS
25	MAINTENANCE OF TRAFFIC PLAN
26-27	DRILLED SHAFT FOUNDATION DETAILS
28	BORING LOG
29-48	ELECTRICAL PLANS

72

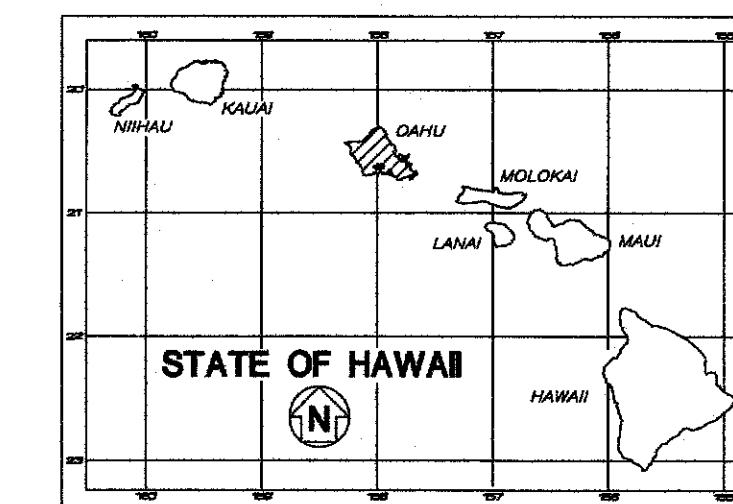

STATE OF HAWAII

DEPARTMENT OF TRANSPORTATION

HIGHWAYS DIVISION

HONOLULU, HAWAII

PLANS FOR

**KALANIANA'OLE HIGHWAY**


**INTERSECTION IMPROVEMENTS AT**

**WAA STREET**

PROJECT NO. 72C-01-19

DISTRICT OF HONOLULU

ISLAND OF OAHU

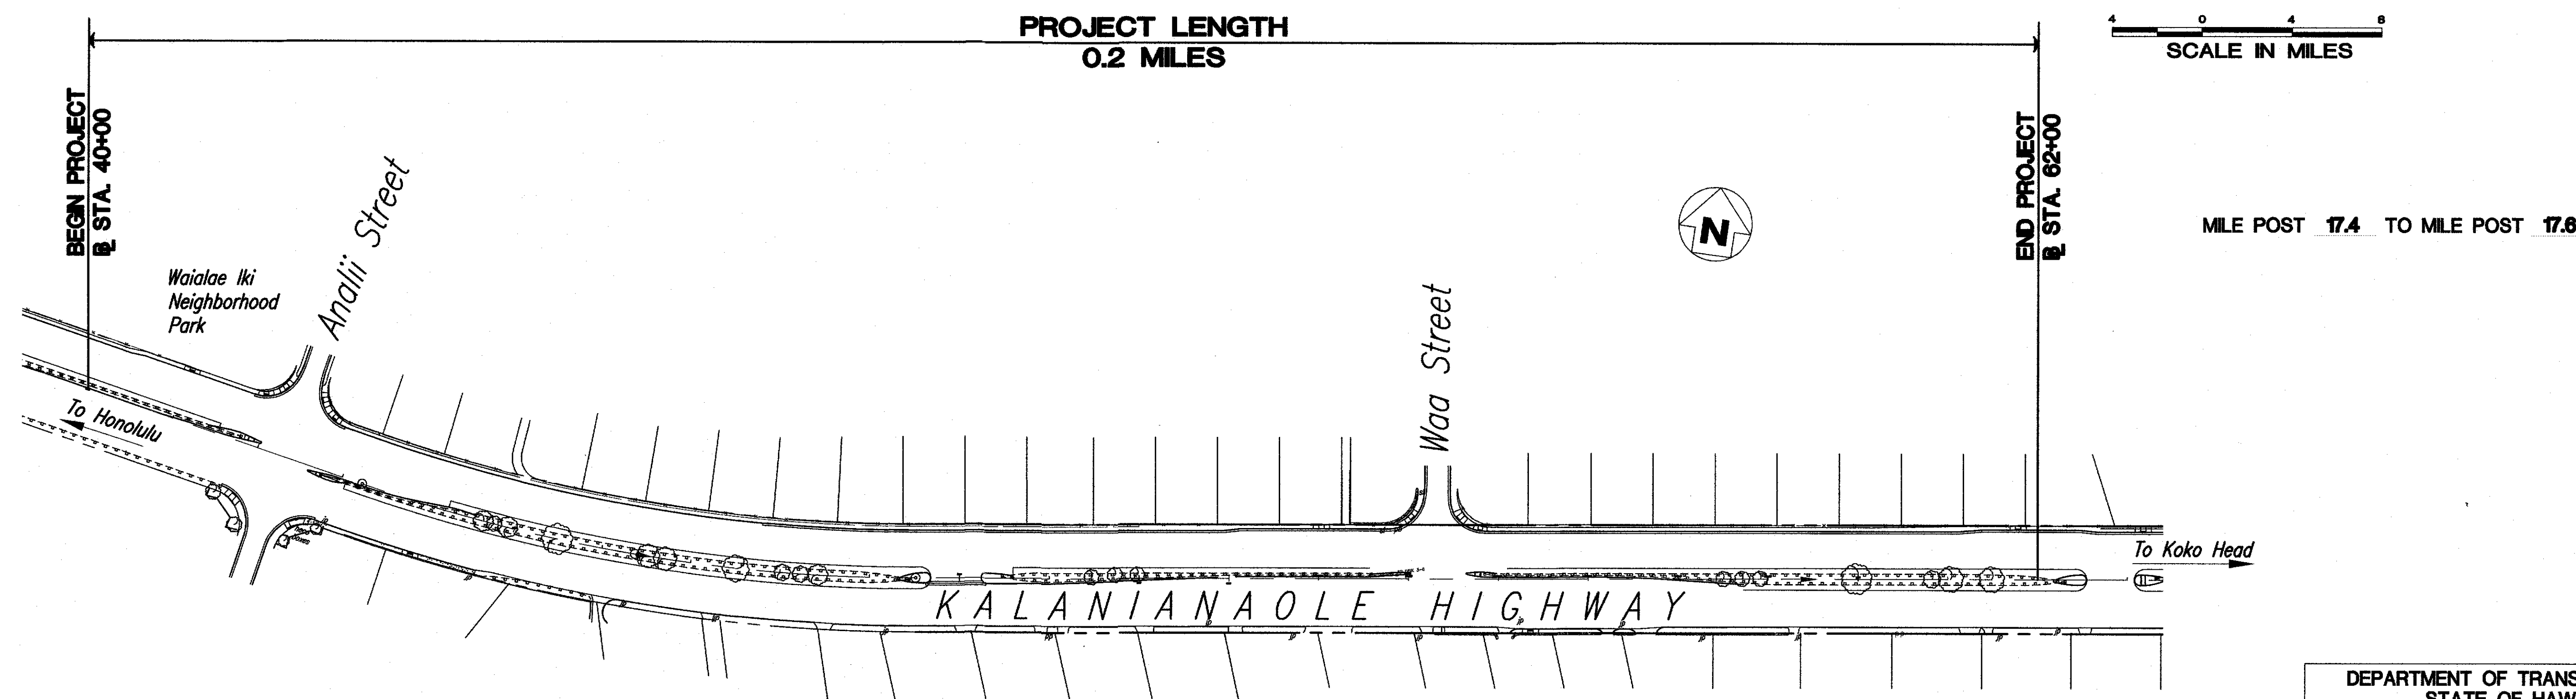

# LAYOUT PLAN

LENGTH OF PROJECT = 0.2 MILES



DEPARTMENT OF TRANSPORTATION  
STATE OF HAWAII

APPROVED: \_\_\_\_\_

*[Signature]* 11/27/11  
\_\_\_\_\_  
DIR. OF TRANSPORTATION DATE