

INDEX TO DRAWINGS	
SHEET NO.	DESCRIPTION
1	TITLE SHEET
2	STANDARD PLAN SUMMARY
3 - 4	PAVEMENT SECTIONS
5	CONSTRUCTION PHASING
6 - 19	EXISTING CONDITION
20	STOCKPILE PLAN
21 - 32	PLAN & PROFILE
33 - 46	DETAIL PLAN
47 - 52	PAIKO DRIVE
53 - 54	GRADE ADJUSTMENT WALL DETAILS
55	DRIVEWAY DETAILS
56	BUS SHELTER DETAIL
57 - 71	DRAINAGE PLAN
72 - 80	DRAIN LINE PROFILES
81 - 84	DRAINAGE DETAILS
85 - 102	DRAINAGE SUMMARY
103 - 144	KULIOUOU & MAUNALUA BRIDGE
145 - 146	UTILITY NOTES
147 - 159	UTILITY PLAN (SEWER, WATER, & GAS)
160 - 161	UTILITY PROFILE (GAS)
162	WATER DETAILS
163 - 164	SEWER DETAILS
165 - 182	NEW 16" WATER MAIN
183 - 184	SIGNING AND PAVEMENT MARKINGS
185	SIGN DETAILS
186 - 189	PERMANENT SIGNING & PAVEMENT MARKINGS
190 - 205	CONSTRUCTION PHASES I, II, III, & IV
206 - 222	CROSS SECTIONS
223 - 258	UTILITY PLANS (HECO, HTO, & CATV)
259 - 276	STREET LIGHTING PLANS
277 - 284	TRAFFIC SIGNAL PLANS
285 - 299	PARTIAL PLANTING PLAN
300 - 316	PARTIAL IRRIGATION SYSTEM
317 - 340	PRIVATE PROPERTY ADJUSTMENT PLAN

STATE OF HAWAII
DEPARTMENT OF TRANSPORTATION
HIGHWAYS DIVISION
HONOLULU, HAWAII

"AS-BUILT"


PLANS FOR
CONSTRUCTION OF A PORTION OF

KALANIANA'OLE HIGHWAY

EAST HALEMAUMAU STREET TO KEAHOLE STREET

FEDERAL AID PROJECT NO. NH-STP-072-1(35)

DISTRICT OF HONOLULU
ISLAND OF OAHU

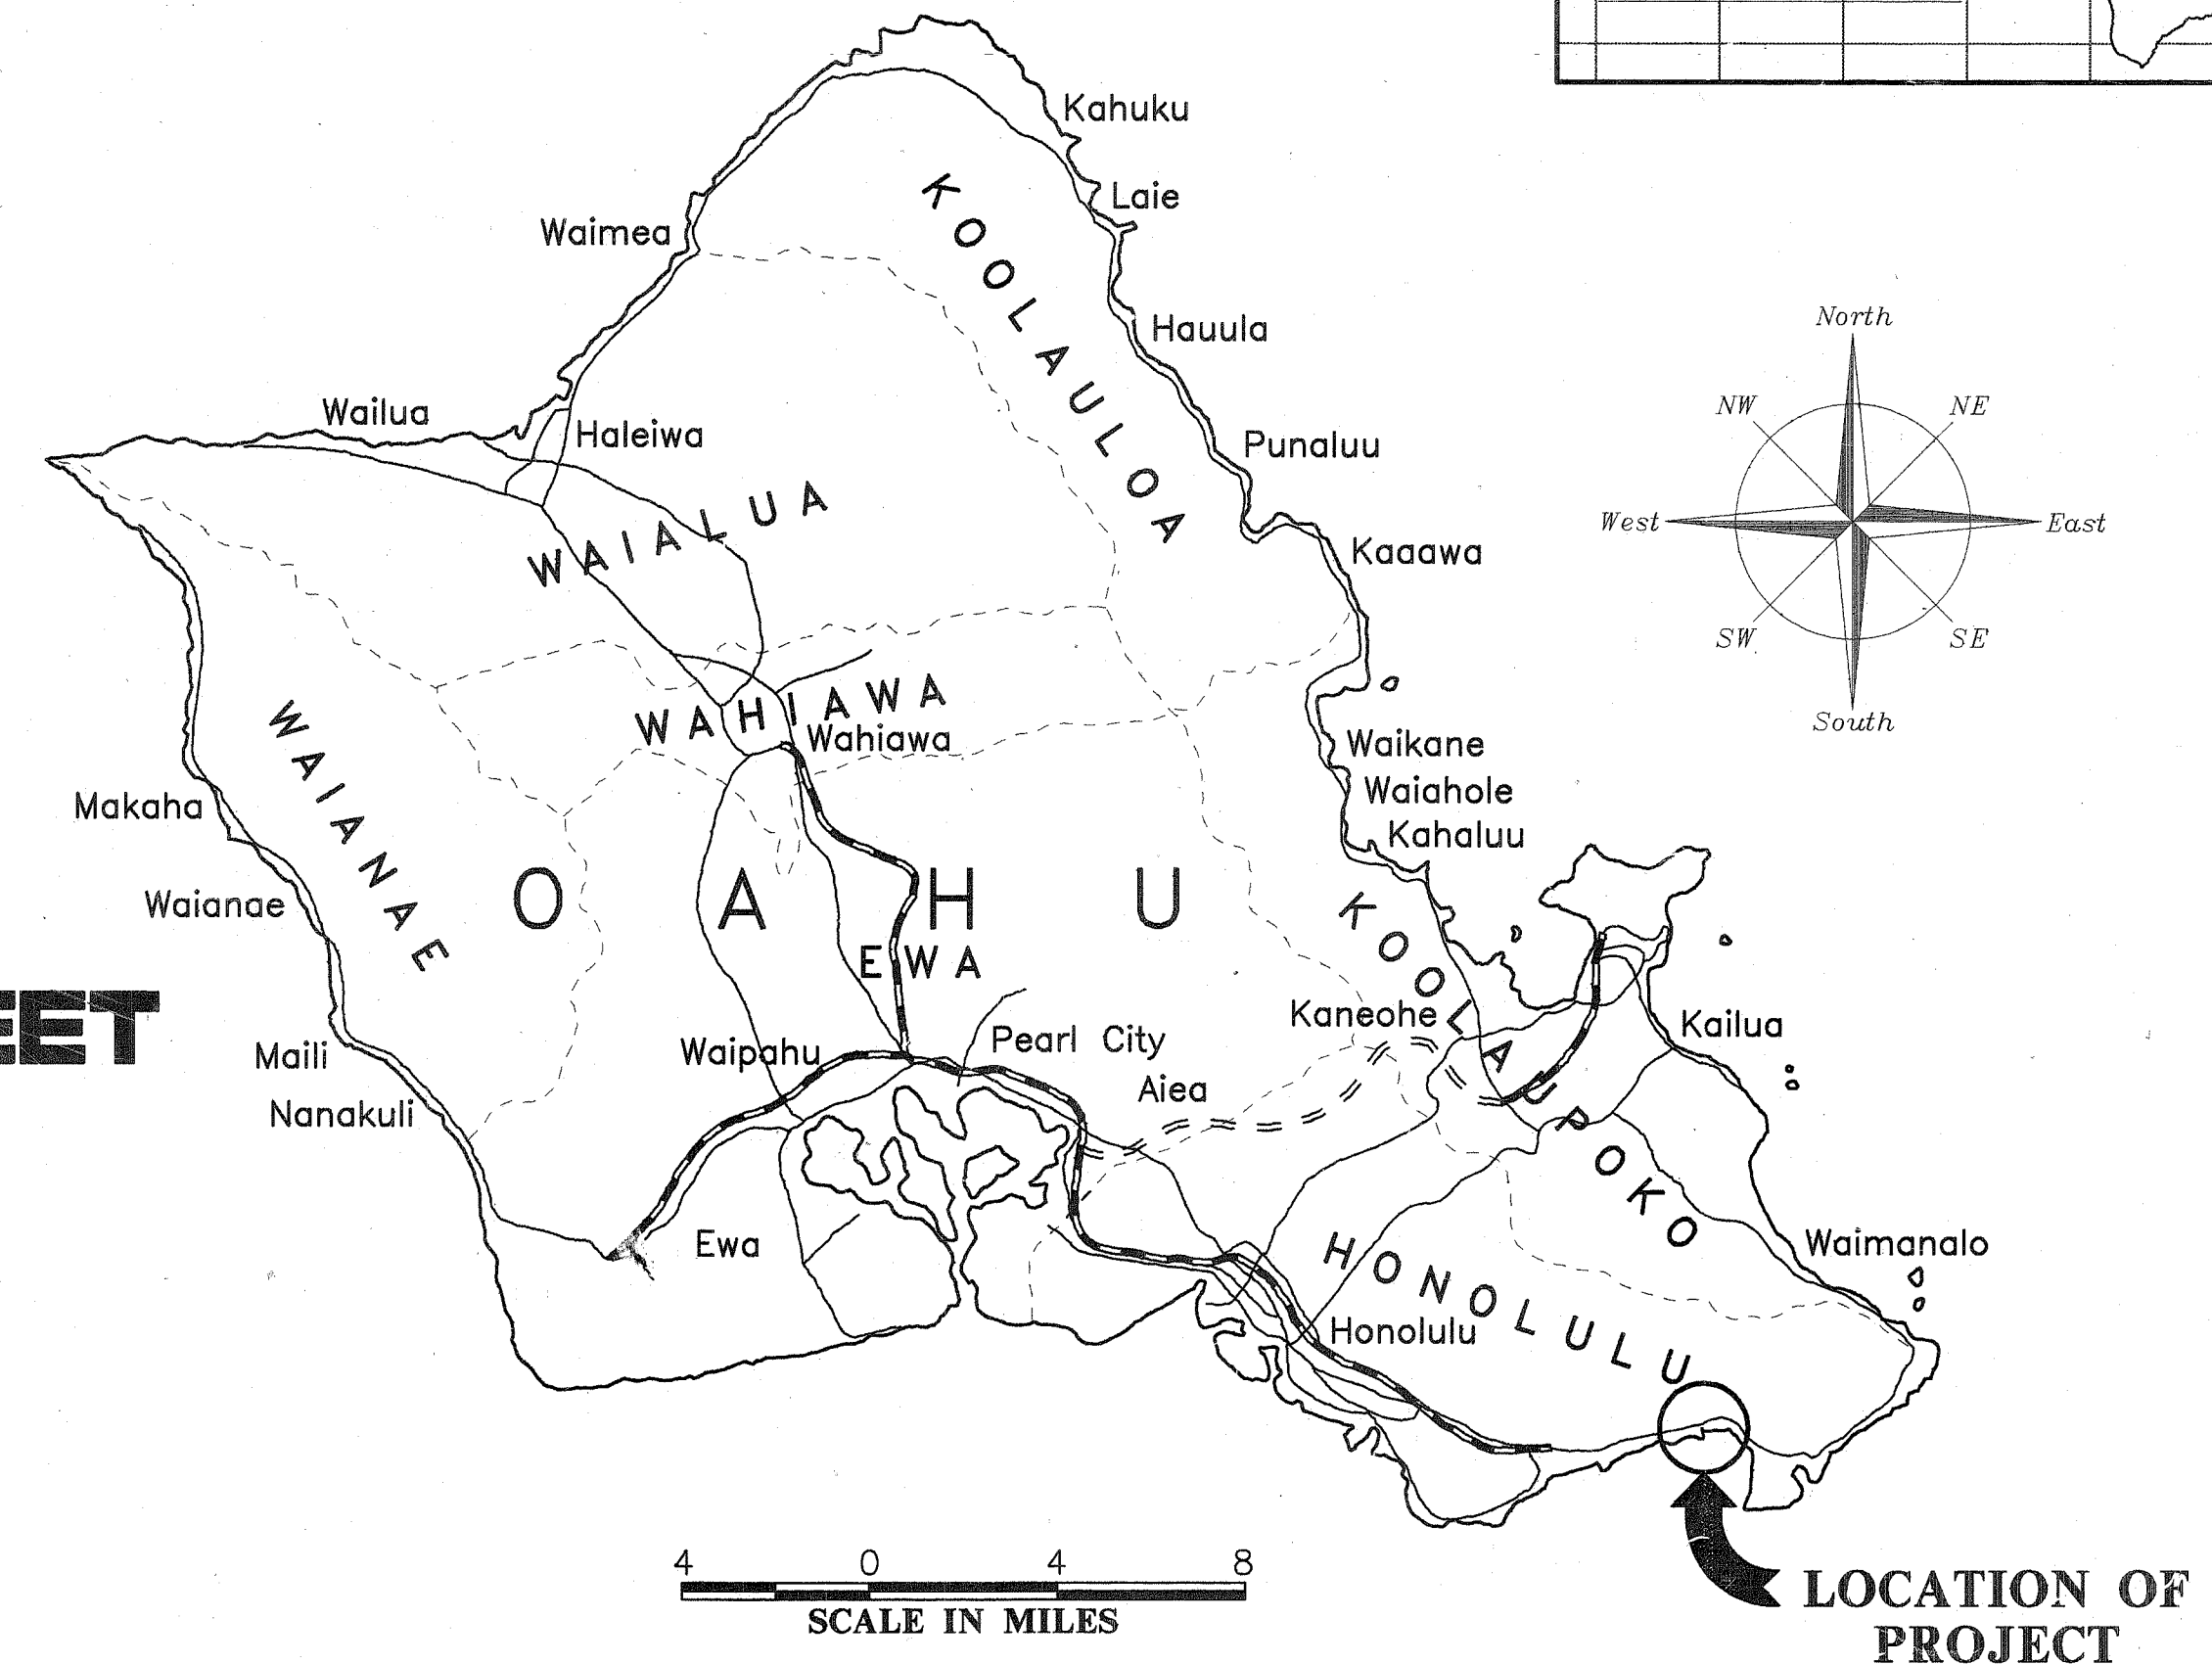

CHANGES MADE DURING CONSTRUCTION HAVE BEEN INCORPORATED ON THESE PLANS EXCEPT CHANGES IN THE ORIGINAL THEORETICAL QUANTITIES. FOR ACTUAL QUANTITIES, REFER TO PROJECT LEDGER AND/OR COMPUTATION BOOK.

Maurice C. H. [Signature] 4-22-2010
RESIDENT ENGINEER DATE

DESIGN CLASSIFICATION

CURRENT ADT (1988)	54,290
DESIGN ADT (2011)	82,730
DHV	6,600
D (Am)	75/25
T	2.5%
V	40MPH
CONTROL OF ACCESS	

BOARD OF WATER SUPPLY
CITY & COUNTY OF HONOLULU

APPROVED: *[Signature]* 4/24/13
MANAGER & CHIEF ENGINEER DATE

DEPARTMENT OF TRANSPORTATION
FEDERAL HIGHWAY ADMINISTRATION

APPROVED: *[Signature]*
DIVISION ADMINISTRATOR DATE


DEPARTMENT OF TRANSPORTATION
STATE OF HAWAII

APPROVED: *[Signature]* 9/22/12
DIR. OF TRANSPORTATION DATE

SHEET No. T-1 OF 1 SHEETS

ORIGINAL PLAN
DATE
DESIGNED BY
CHECKED BY
DATE

M&E Pacific, Inc. Fred Abeshima 587-2123 9/21/92
DESIGNED BY P.S. & E. BY PHONE DATE

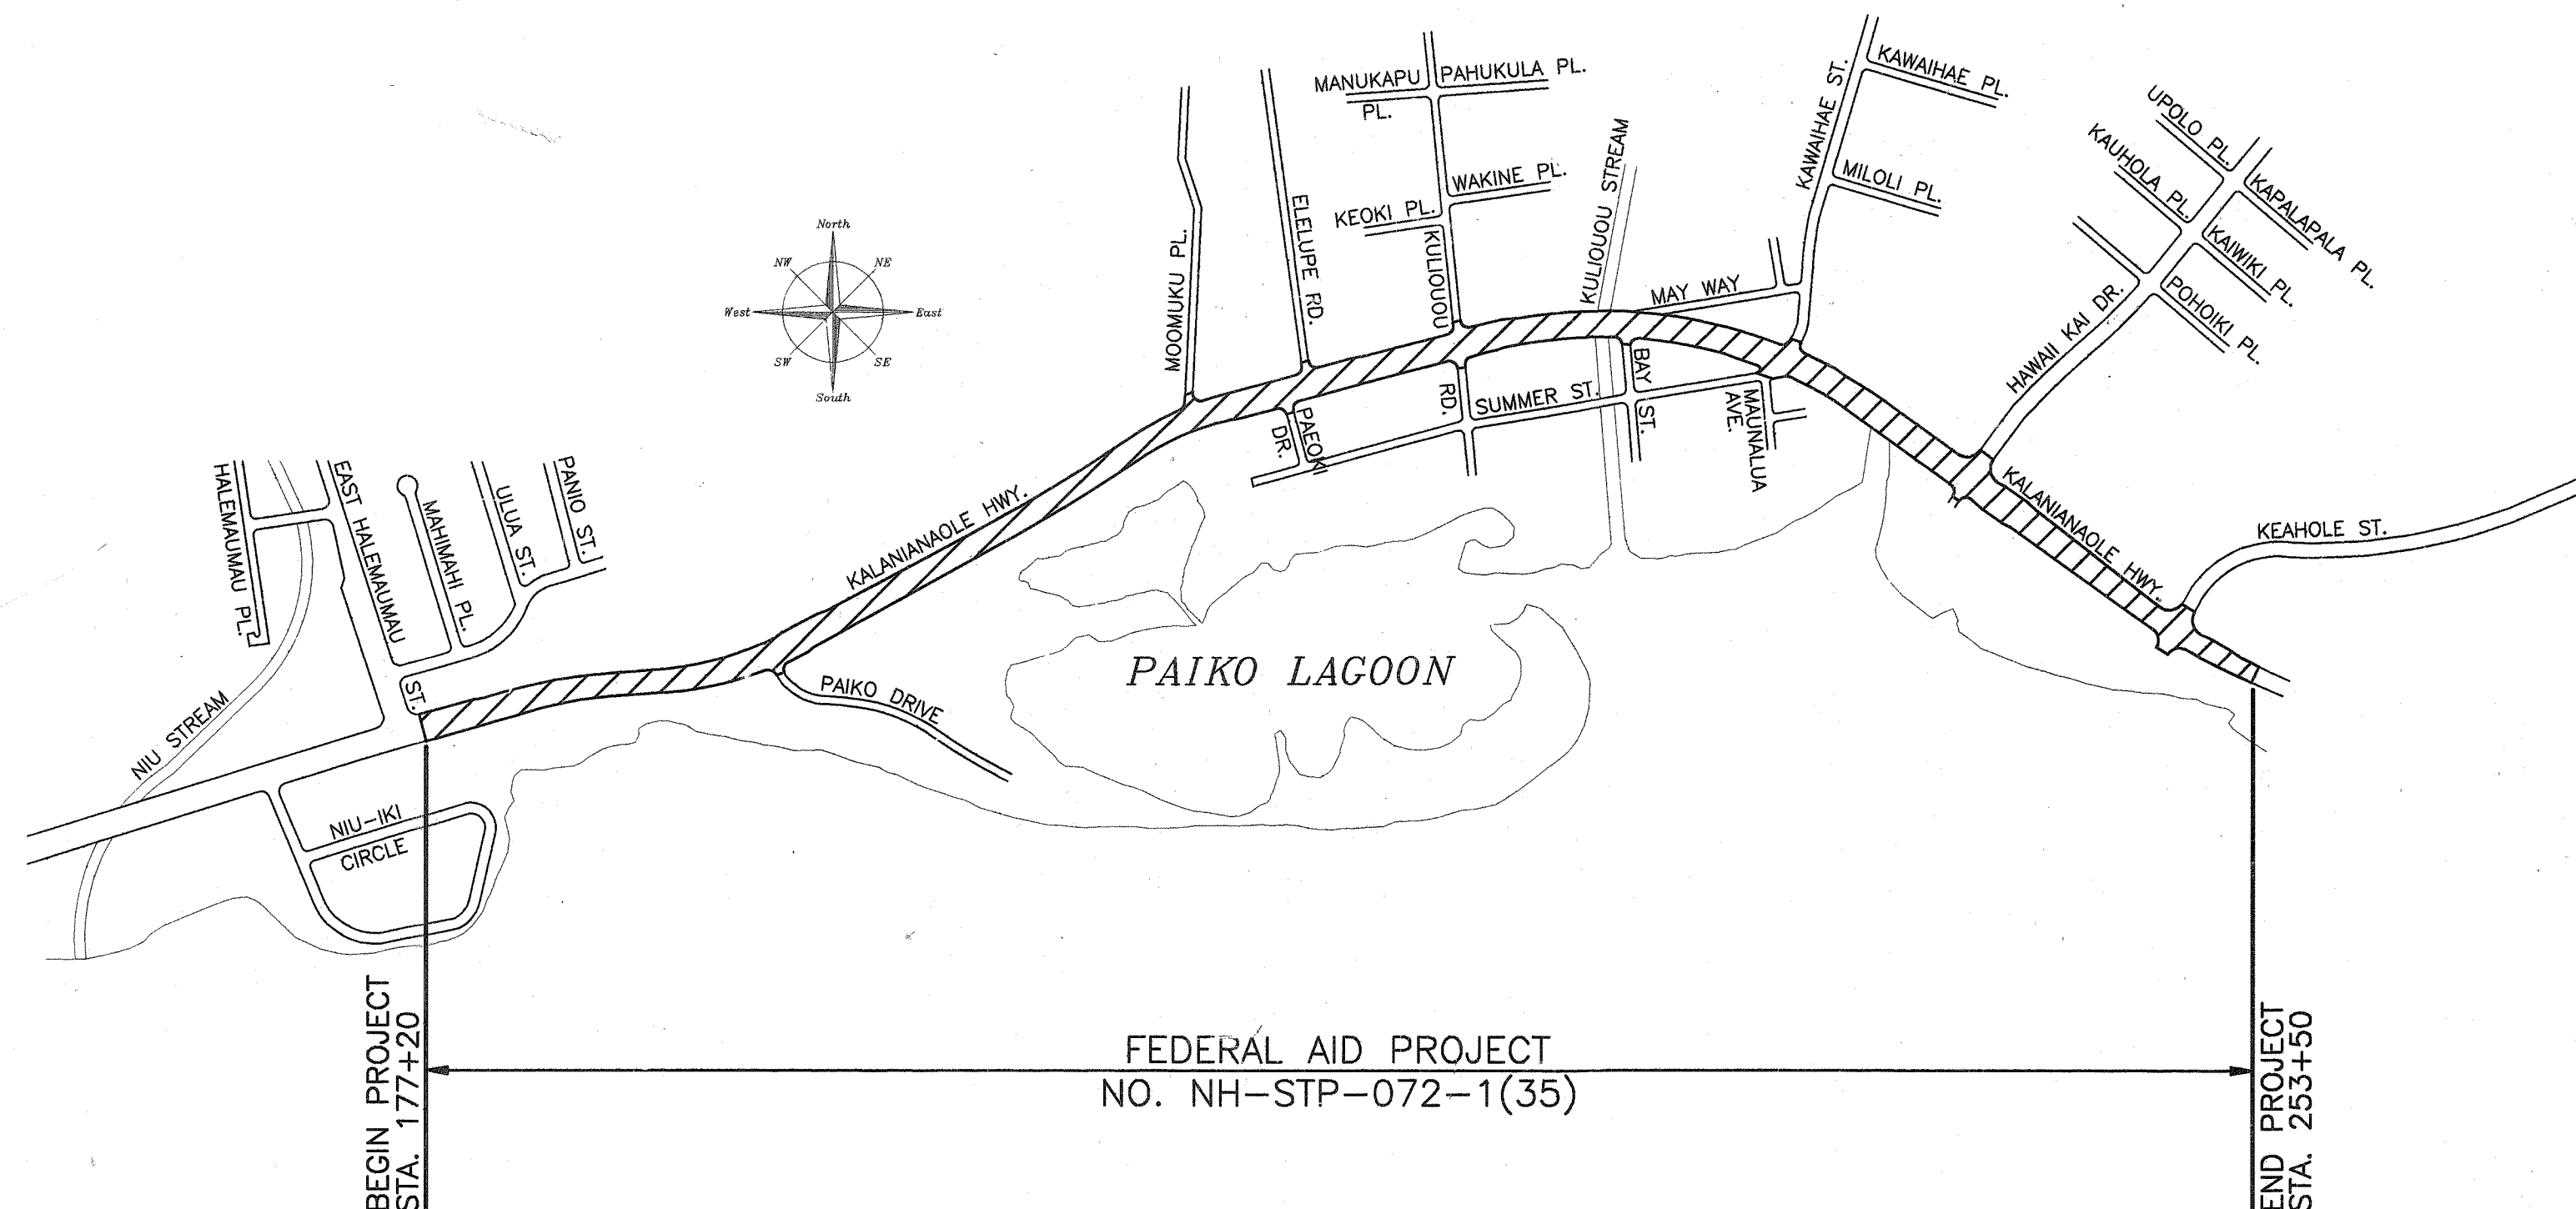

FEDERAL AID PROJECT
NO. NH-STP-072-1(35)

LAYOUT PLAN

GROSS LENGTH OF PROJECT - 1.445 MILES
BRIDGES - 0.069 MILES
NET LENGTH OF ROADWAY - 1.376 MILES

400 200 0 400 800
SCALE IN FEET