

INDEX TO DRAWINGS	
SHEET NO.	DESCRIPTION
1	TITLE SHEET
2 - 3	TYPICAL SECTIONS
4 - 8	PLAN AND PROFILE
9 - 13	ROADWAY DETAILS
(9 - 11)	SPECIAL
(12 - 13)	STANDARD
14 - 22	DRAINAGE DETAILS
(14 - 17)	SPECIAL
(18 - 22)	STANDARD
23 - 25	TRAFFIC SIGNS LAYOUT AND LANDSCAPING PLAN
26	DETOUR PLANS
27 - 31	TRAFFIC SIGN DETAILS
32 - 39	UTILITY PLANS AND DETAILS
40	HIGHWAY LIGHTING PLANS
41 - 53	CROSS SECTIONS
11A	EWA PLANTATION CANE HAUL ROAD
33A	LOWERING OF EXISTING 4" WATER MAIN

STATE OF HAWAII

DEPARTMENT OF TRANSPORTATION

HIGHWAYS DIVISION

HONOLULU, HAWAII

"AS BUILT"

PLANS OF

FARRINGTON HIGHWAY WIDENING

EWA - WAIANAE JUNCTION TO PUPUPUHI STREET

FEDERAL AID PROJECT NO. F-090-1(8)

DISTRICT OF EWA

ISLAND OF OAHU

SCALES:

PLAN & PROFILE

HOR. 1" = 50'

VER. 1" = 10'

GROSS SECTION

HOR. 1" = 10'


VER. 1" = 10'

LAYOUT PLAN

GROSS LENGTH OF PROJECT1.084 MI.

BRIDGES OVER 20'-0" SPAN0.005 MI.

NET LENGTH OF ROADWAY1.079 MI.

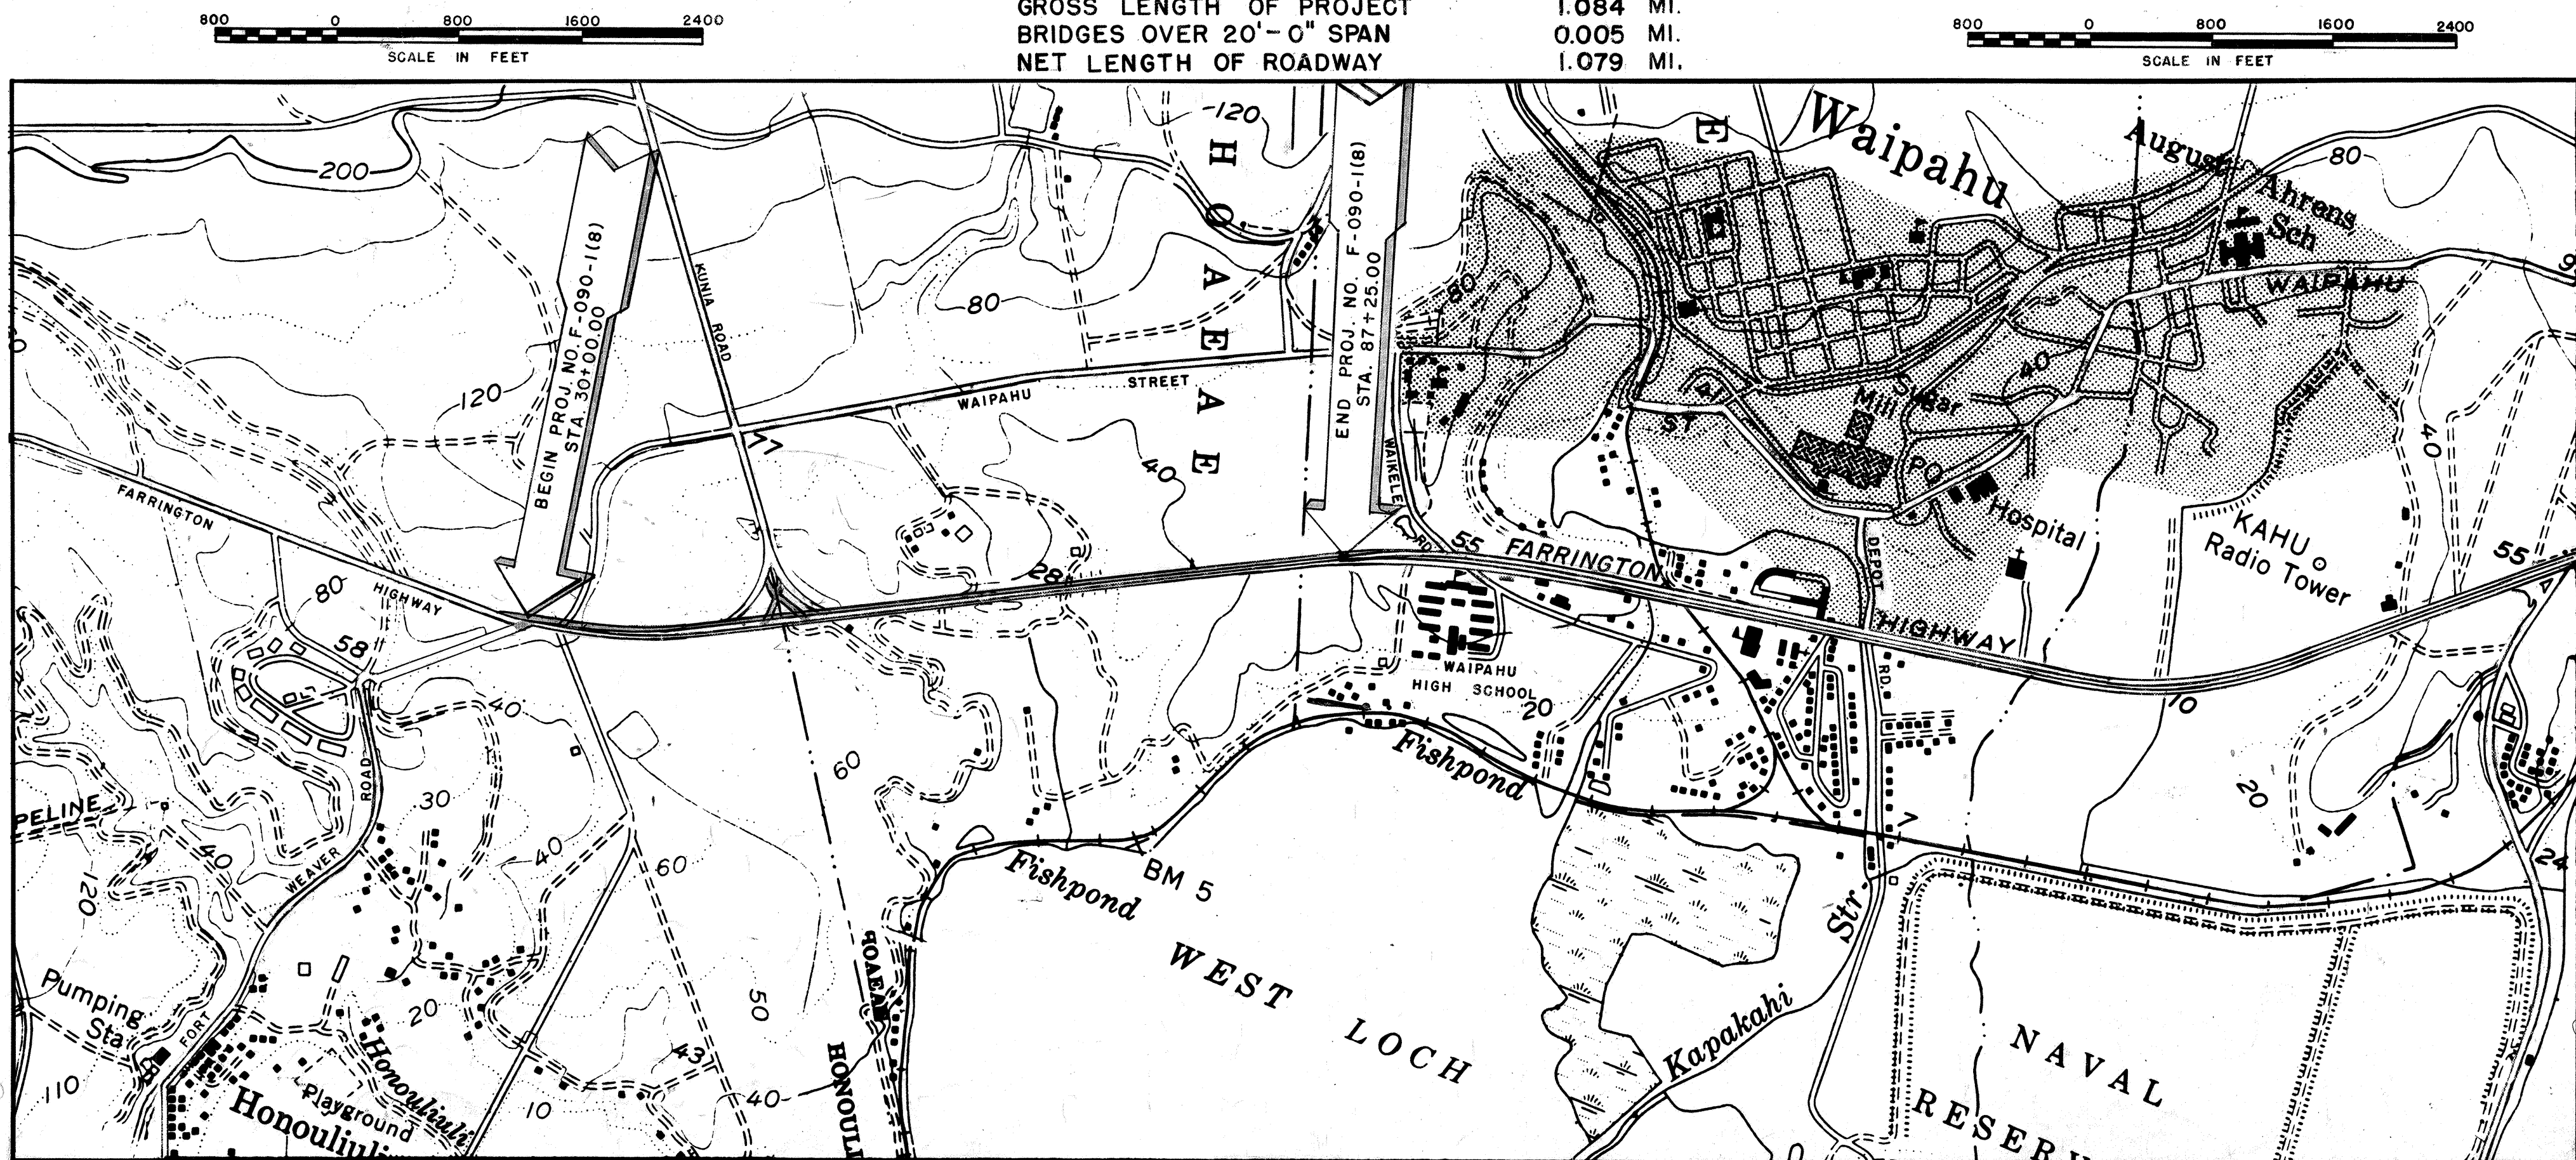

DESIGN CLASSIFICATION

ADT (1963)17,300

DESIGN ADT (1980)14,000

DHV.....12%

D.....52/48

T.....5.5%

V.....50 M.P.H.

NOTE: ALL CHANGES MADE DURING CONSTRUCTION ARE SHOWN IN RED ON THESE TRACINGS AND ARE CHECKED BY

Deery E. Nishida

PROJECT ENGINEER

July 29, 1966

DATE

APPROVED:

DATE 24 Jan 67

Director of Transportation

DIRECTOR OF TRANSPORTATION

DEPARTMENT OF COMMERCE


BUREAU OF PUBLIC ROADS

APPROVED:

DIVISION

ENGINEER

DATE

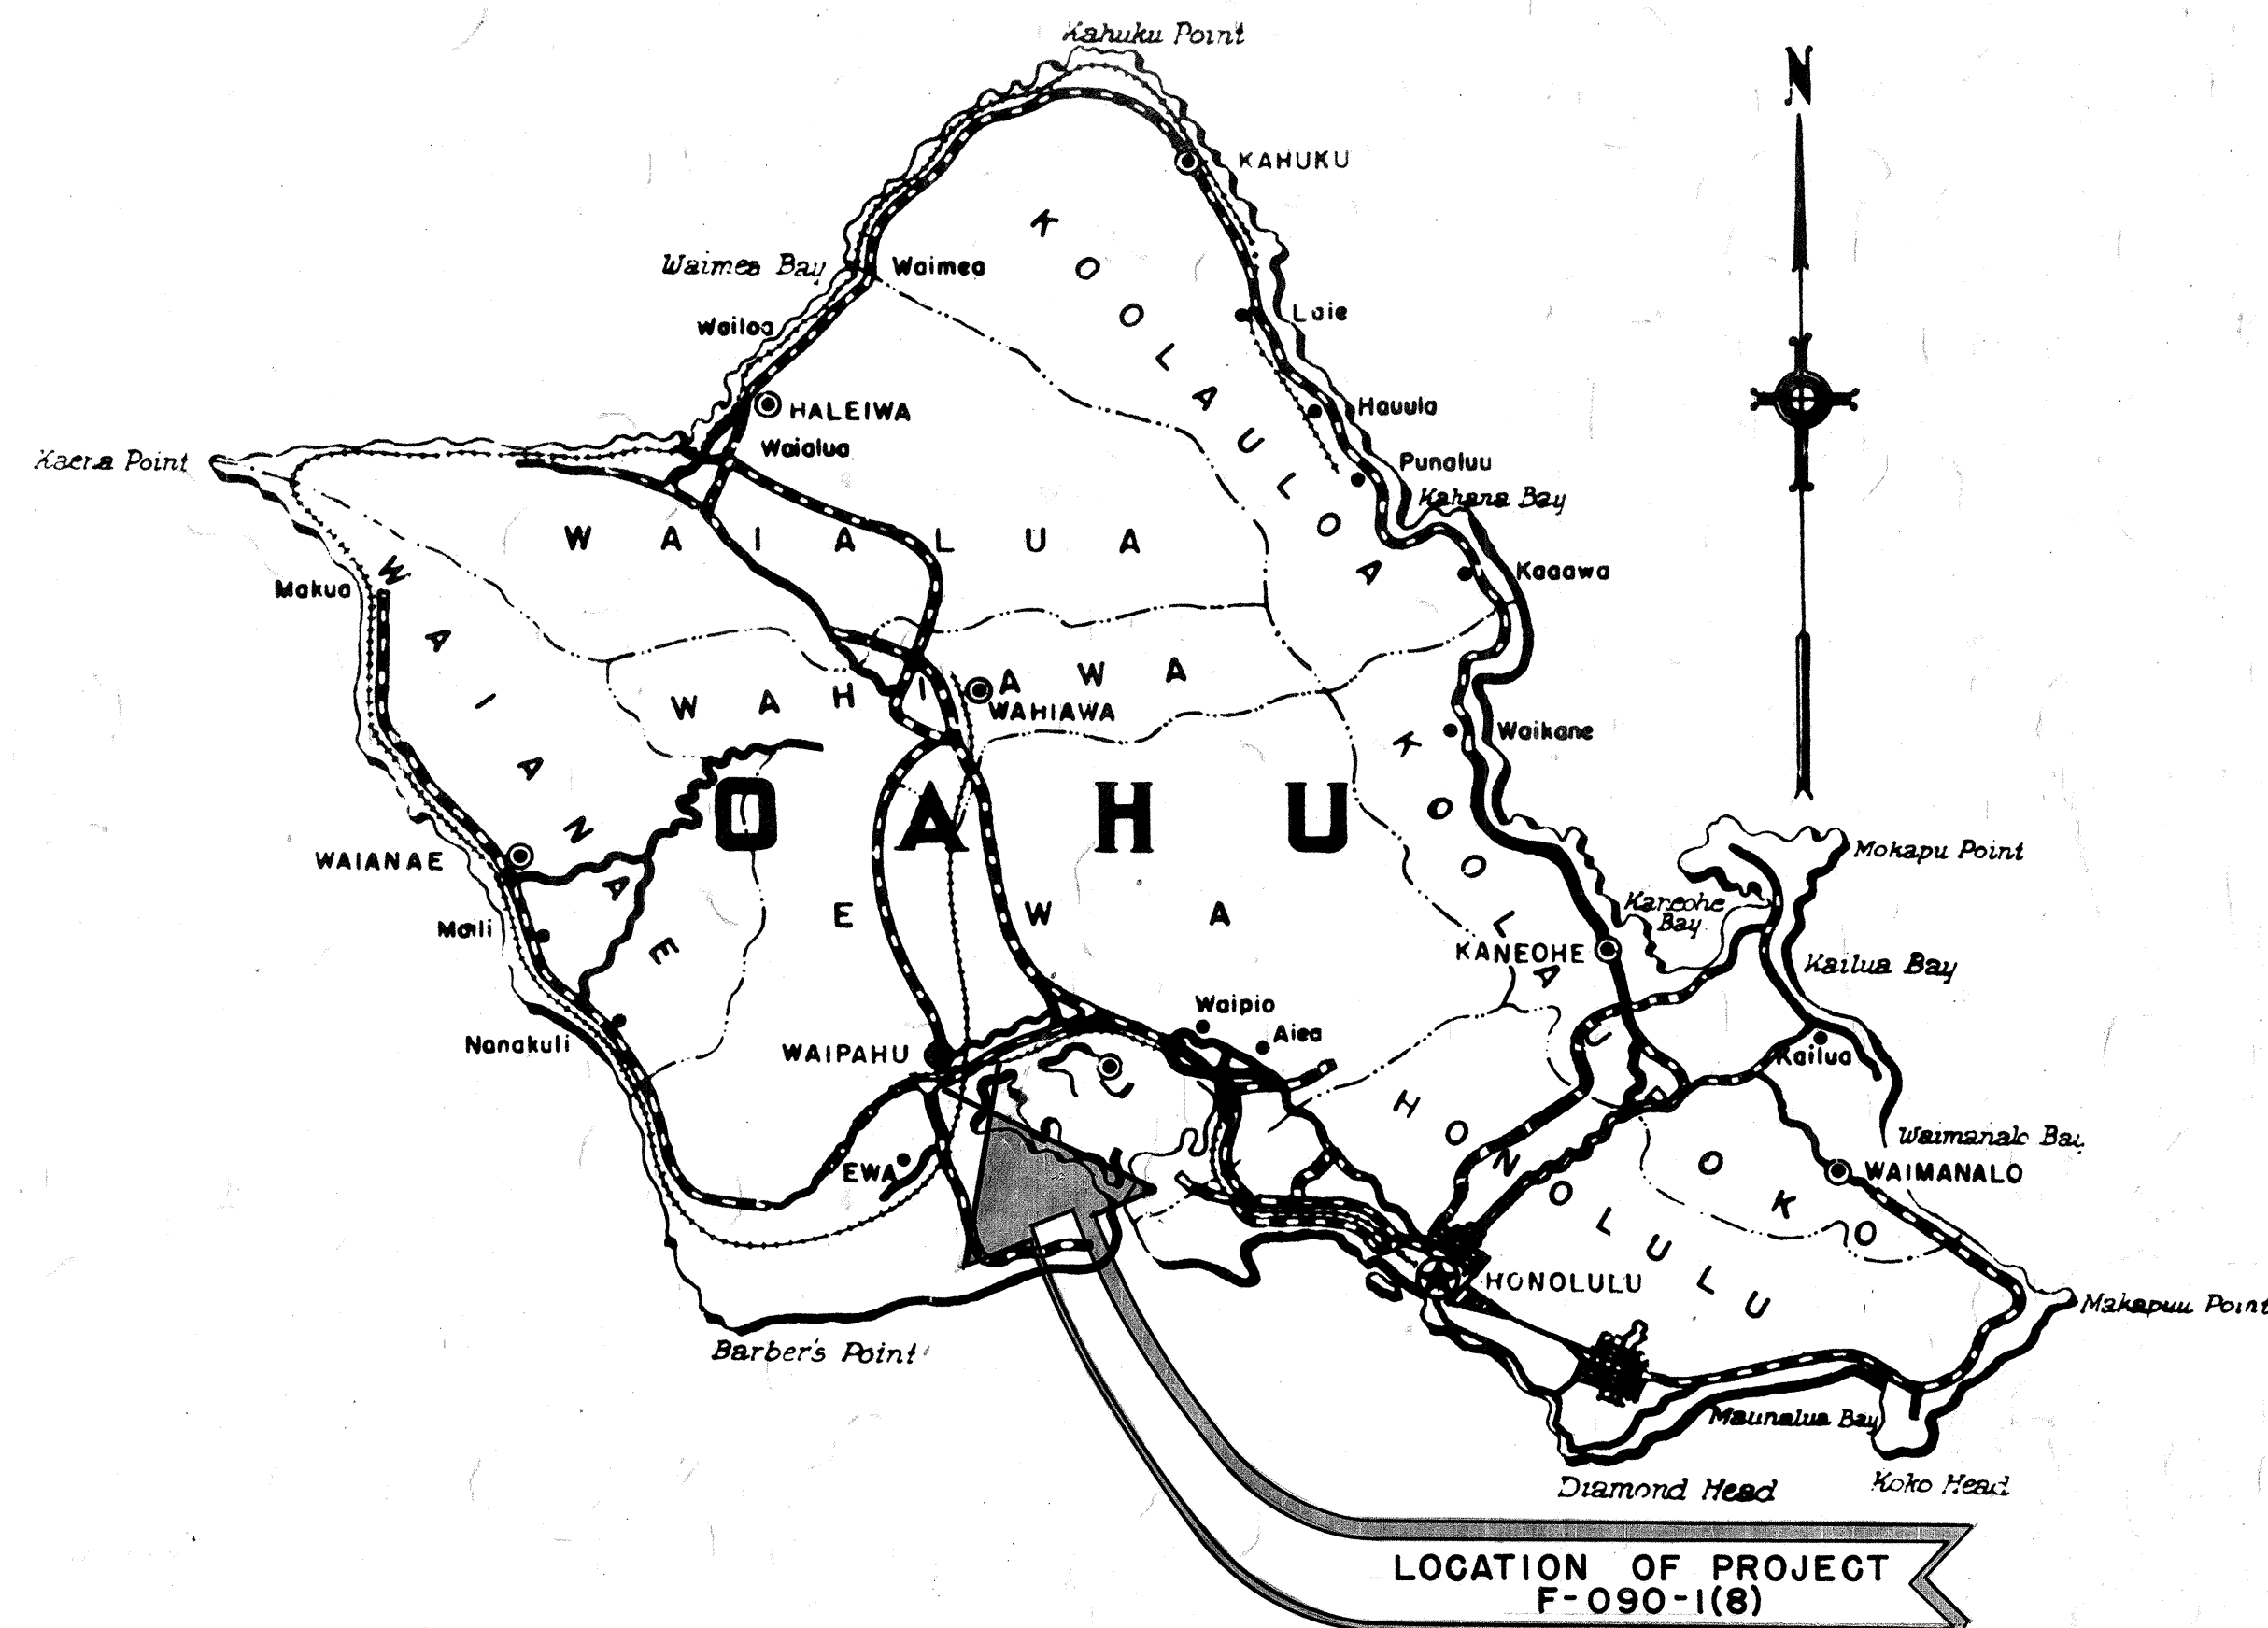

Federal Aid Projects Previously Constructed Or Under Construction

DATE	
SURVEY PLOTTED BY	
DESIGNED BY	
TRACED BY	
NOTED BY	
CHECKED BY	
ORIGINAL PLAN	
NOTE BOOK	
CHECKED BY	

FED. ROAD DIST. NO.	STATE	FED. AID PROJ. NO.	FISCAL YEAR	SHEET NO.	TOTAL SHEETS
HAWAII	HAW	F-090-1(8)	1963	1	53