

INDEX TO DRAWINGS	
SHT. NO.	DESCRIPTION
1	TITLE SHEET
2 - 5	TYPICAL SECTIONS
6 - 7	PLAN AND PROFILE
8 - 11	DETAIL ROADWAY PLANS
12 - 13	RAMP PROFILES
14 - 16	GRADING PLANS
17 - 22	ROADWAY DETAILS
23 - 31	UTILITY PLANS AND DETAILS
32	DETOUR PLAN
33	TRAFFIC SIGNS AND LANDSCAPING
34 - 37	HIGHWAY LIGHTING PLANS
38 - 48	DRAINAGE PLANS AND DETAILS
49 - 50	R/W ADJUSTMENT (HSPA PUMP HOUSE)
51 - 62	KUNIA INTERCHANGE STRUCTURE
63 - 75	CROSS SECTIONS

STATE OF HAWAII
DEPARTMENT OF TRANSPORTATION
HIGHWAYS DIVISION
HONOLULU, HAWAII

"AS BUILT" PLANS FOR
CONSTRUCTION OF A PORTION OF
INTERSTATE ROUTE H-1
BARBERS POINT TO KUNIA ROAD


(KUNIA INTERCHANGE)
FEDERAL AID INTERSTATE PROJECT No. I-HI-1(18), UNIT 2
GRADING AND STRUCTURES

DISTRICT OF EWA
ISLAND OF OAHU

SCALES:

PLAN & PROFILE HOR. 1" = 100'
VER. 1" = 10'
DETAIL ROADWAY PLAN 1" = 50'

CROSS SECTION HOR. 1" = 10'
VER. 1" = 10'
HOR. 1" = 20'
VER. 1" = 20'

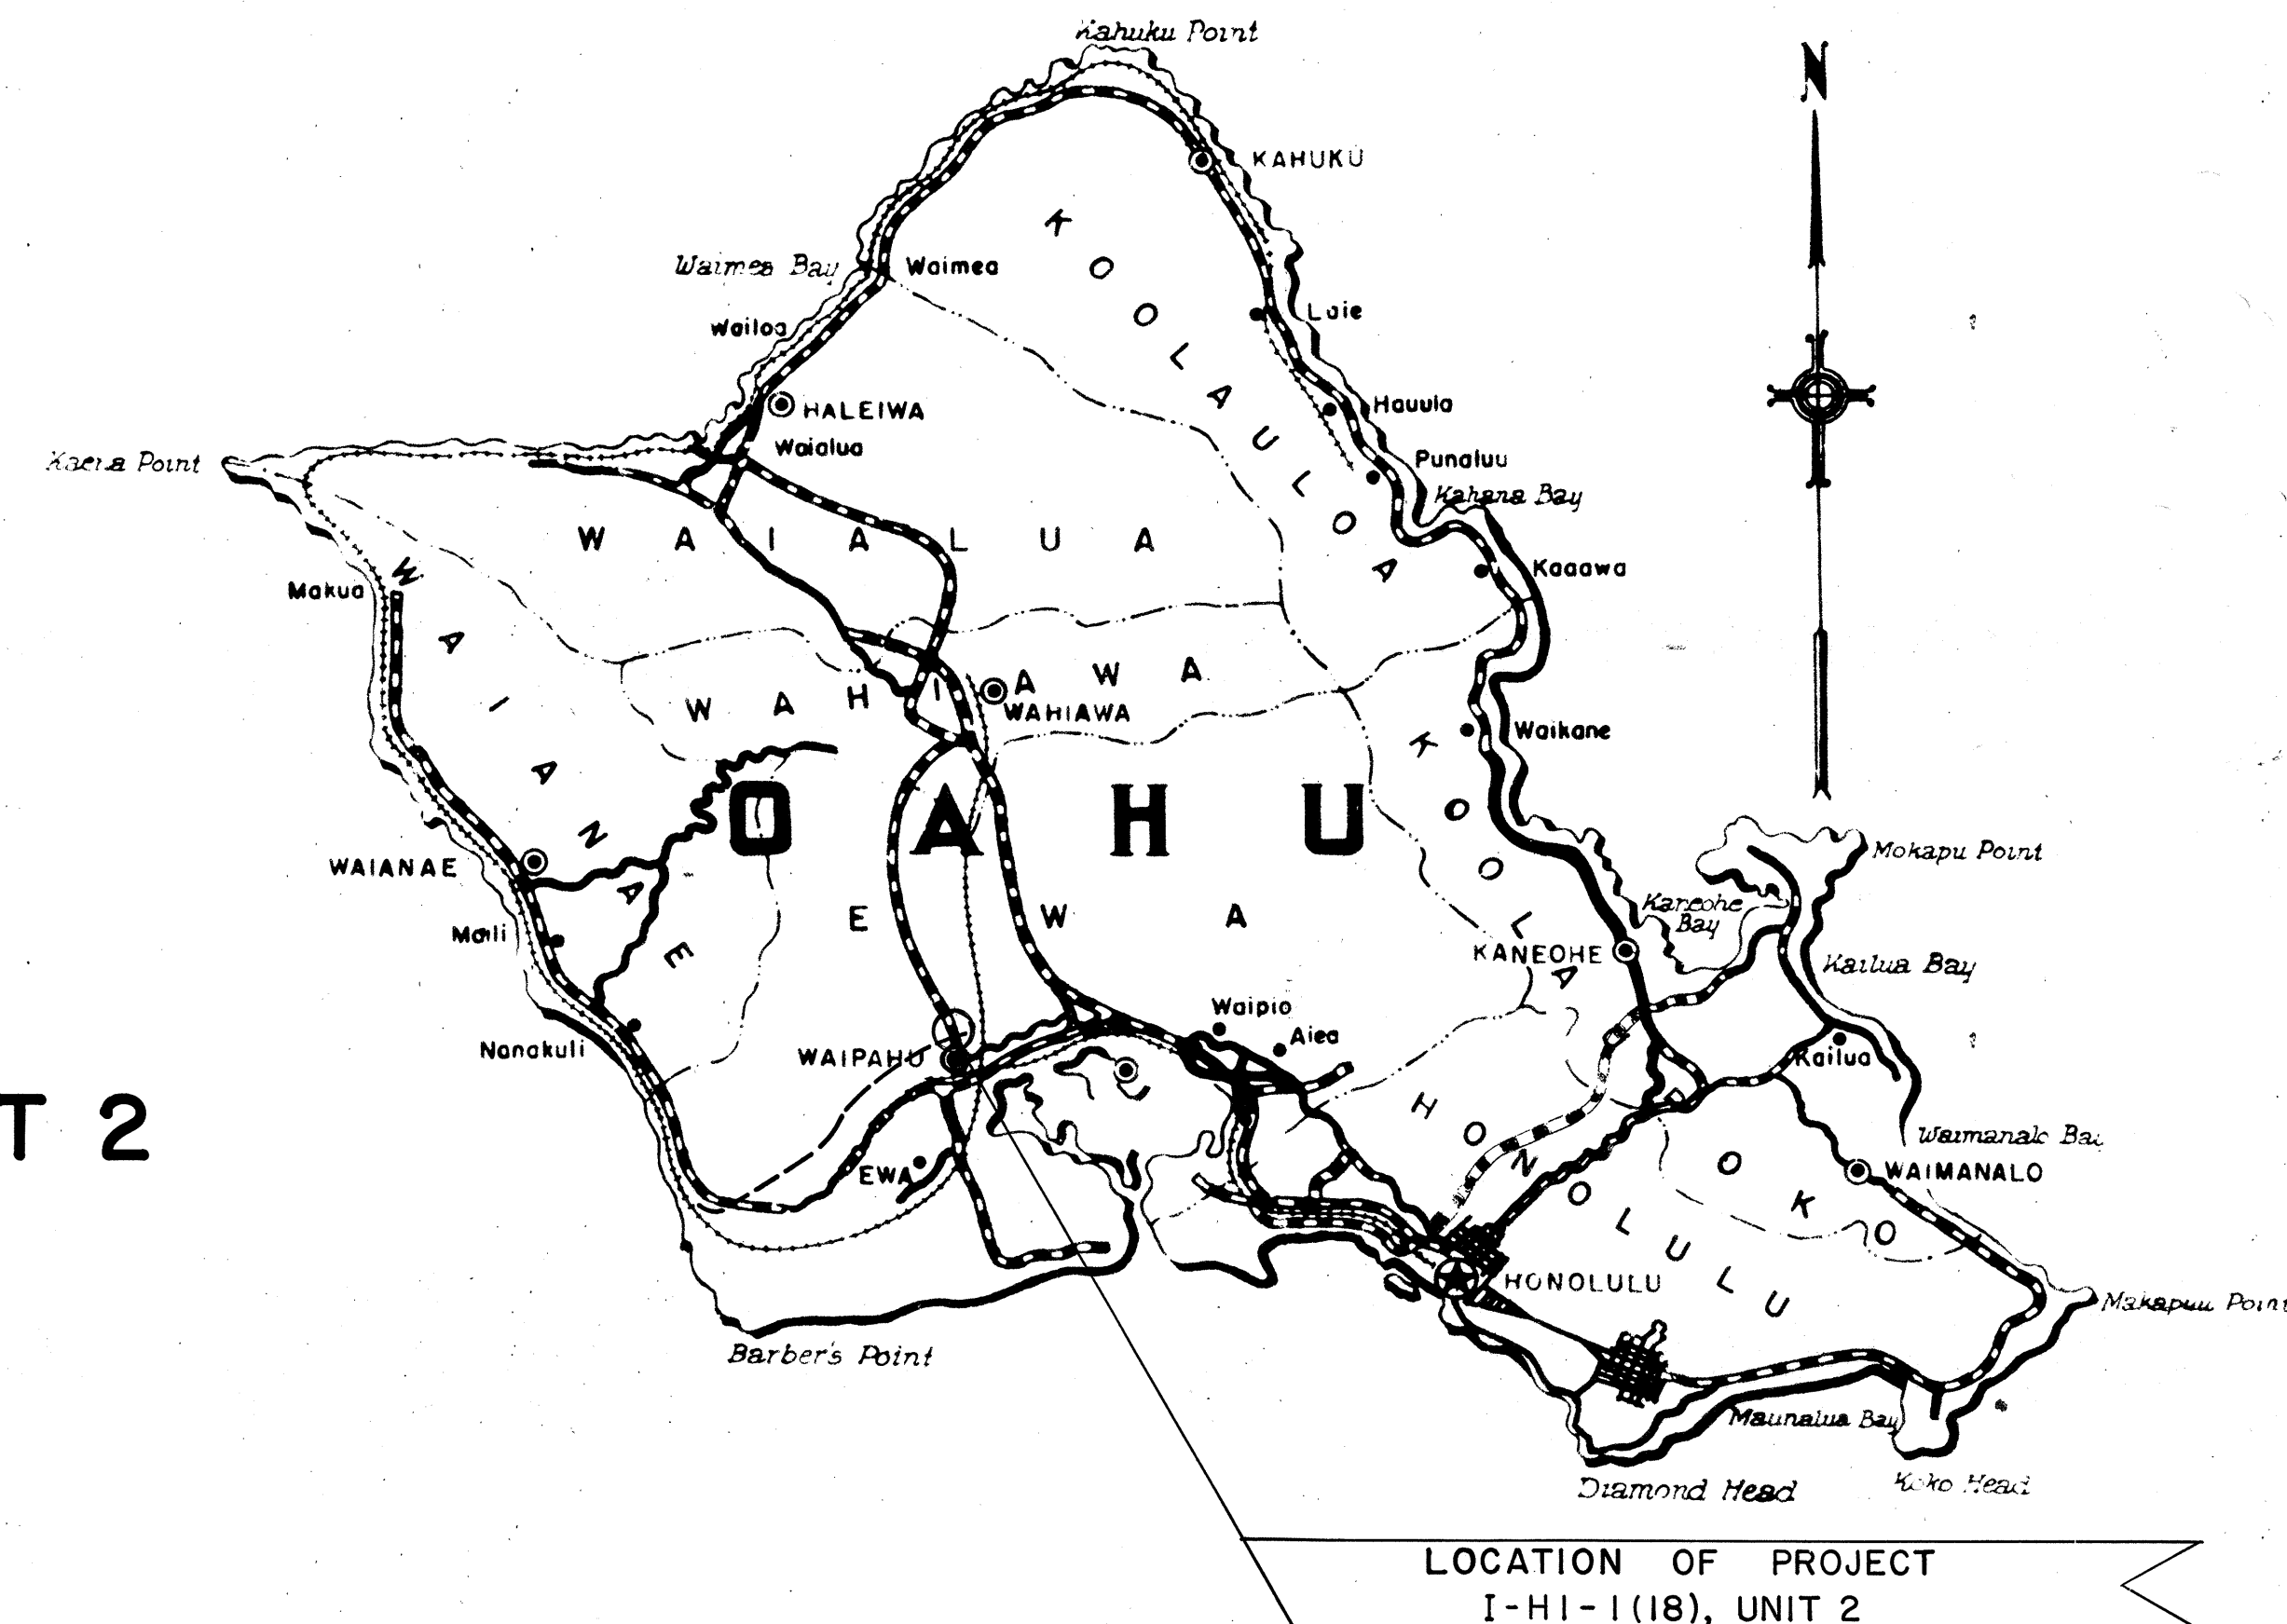

NOTE:
ALL CHANGES MADE DURING CONSTRUCTION HAVE BEEN
NOTED IN RED ON THESE TRACINGS AND CHECKED BY:

[Signature]
PROJECT ENGINEER

SEP 25, 1967
DATE


DESIGN CLASSIFICATION

ADT (1962)..... 0
DESIGN ADT (1985)..... 23,500
DHV..... 2,500
D..... 60/40
T..... 40 %
V..... 70 MPH.

APPROVED: Date 12 Aug 65

[Signature]
DIRECTOR OF TRANSPORTATION

DEPARTMENT OF COMMERCE
BUREAU OF PUBLIC ROADS
APPROVED: *[Signature]* 8-18-65
DIVISION ENGINEER DATE

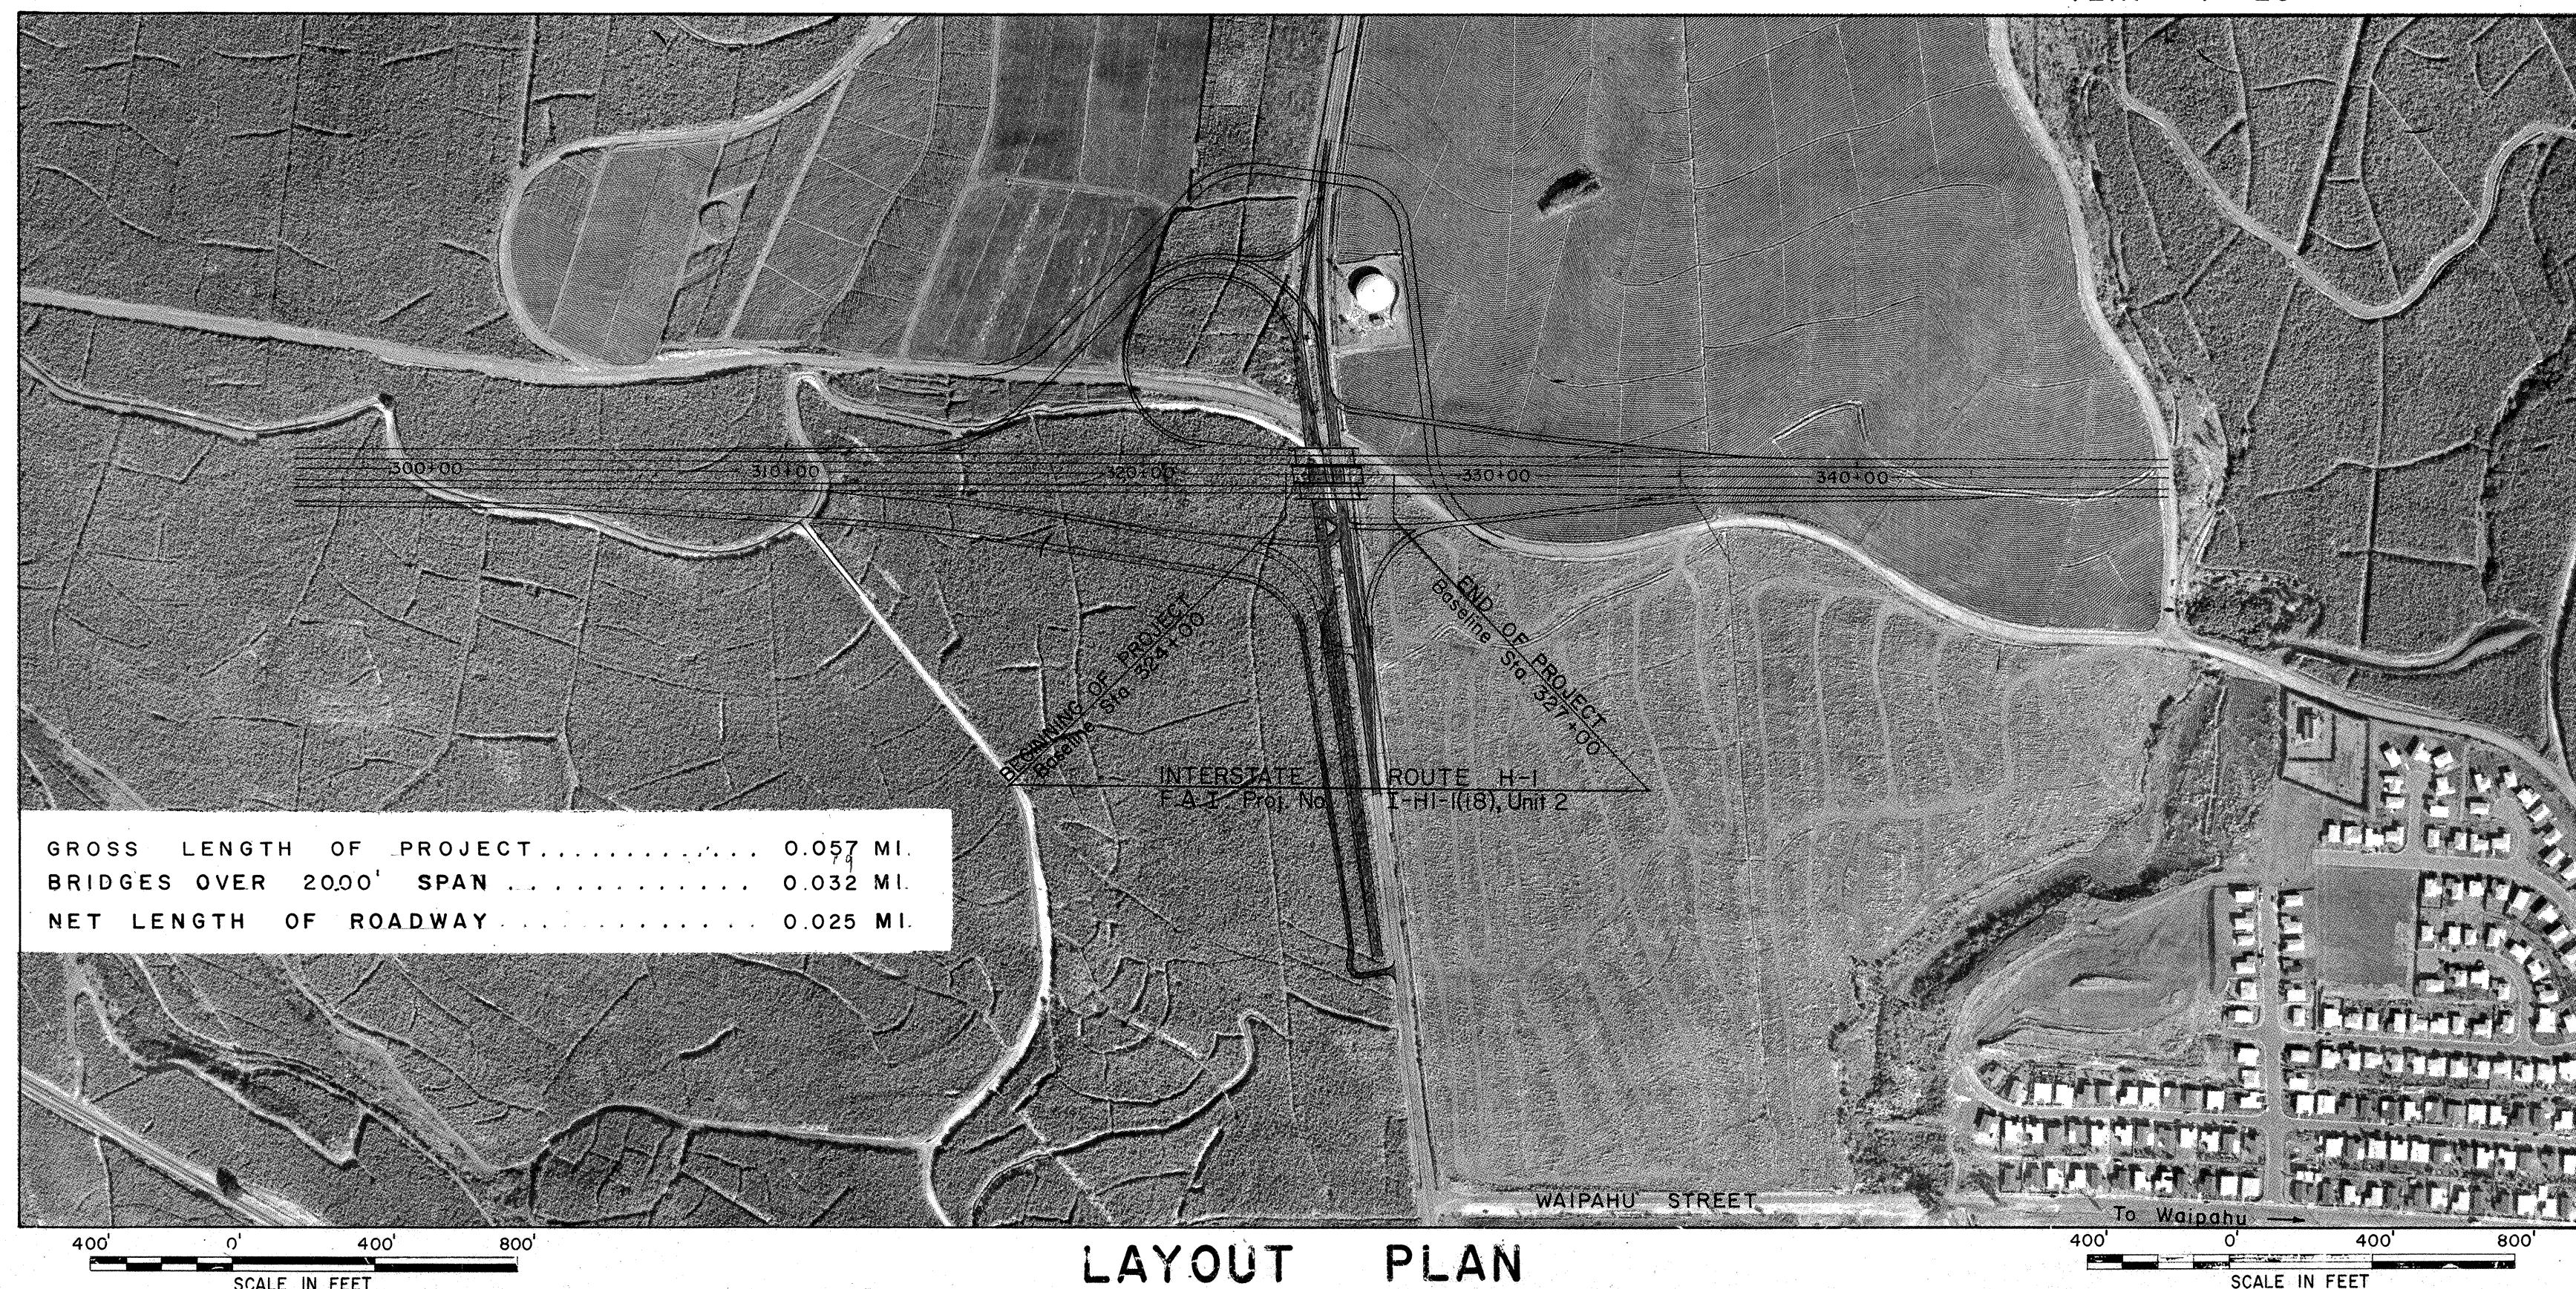

GROSS LENGTH OF PROJECT..... 0.057 MI.
BRIDGES OVER 20.00' SPAN..... 0.032 MI.
NET LENGTH OF ROADWAY..... 0.025 MI.

LAYOUT PLAN

DATE
DESIGNED BY
CHECKED BY
NOTE BOOK
No.