
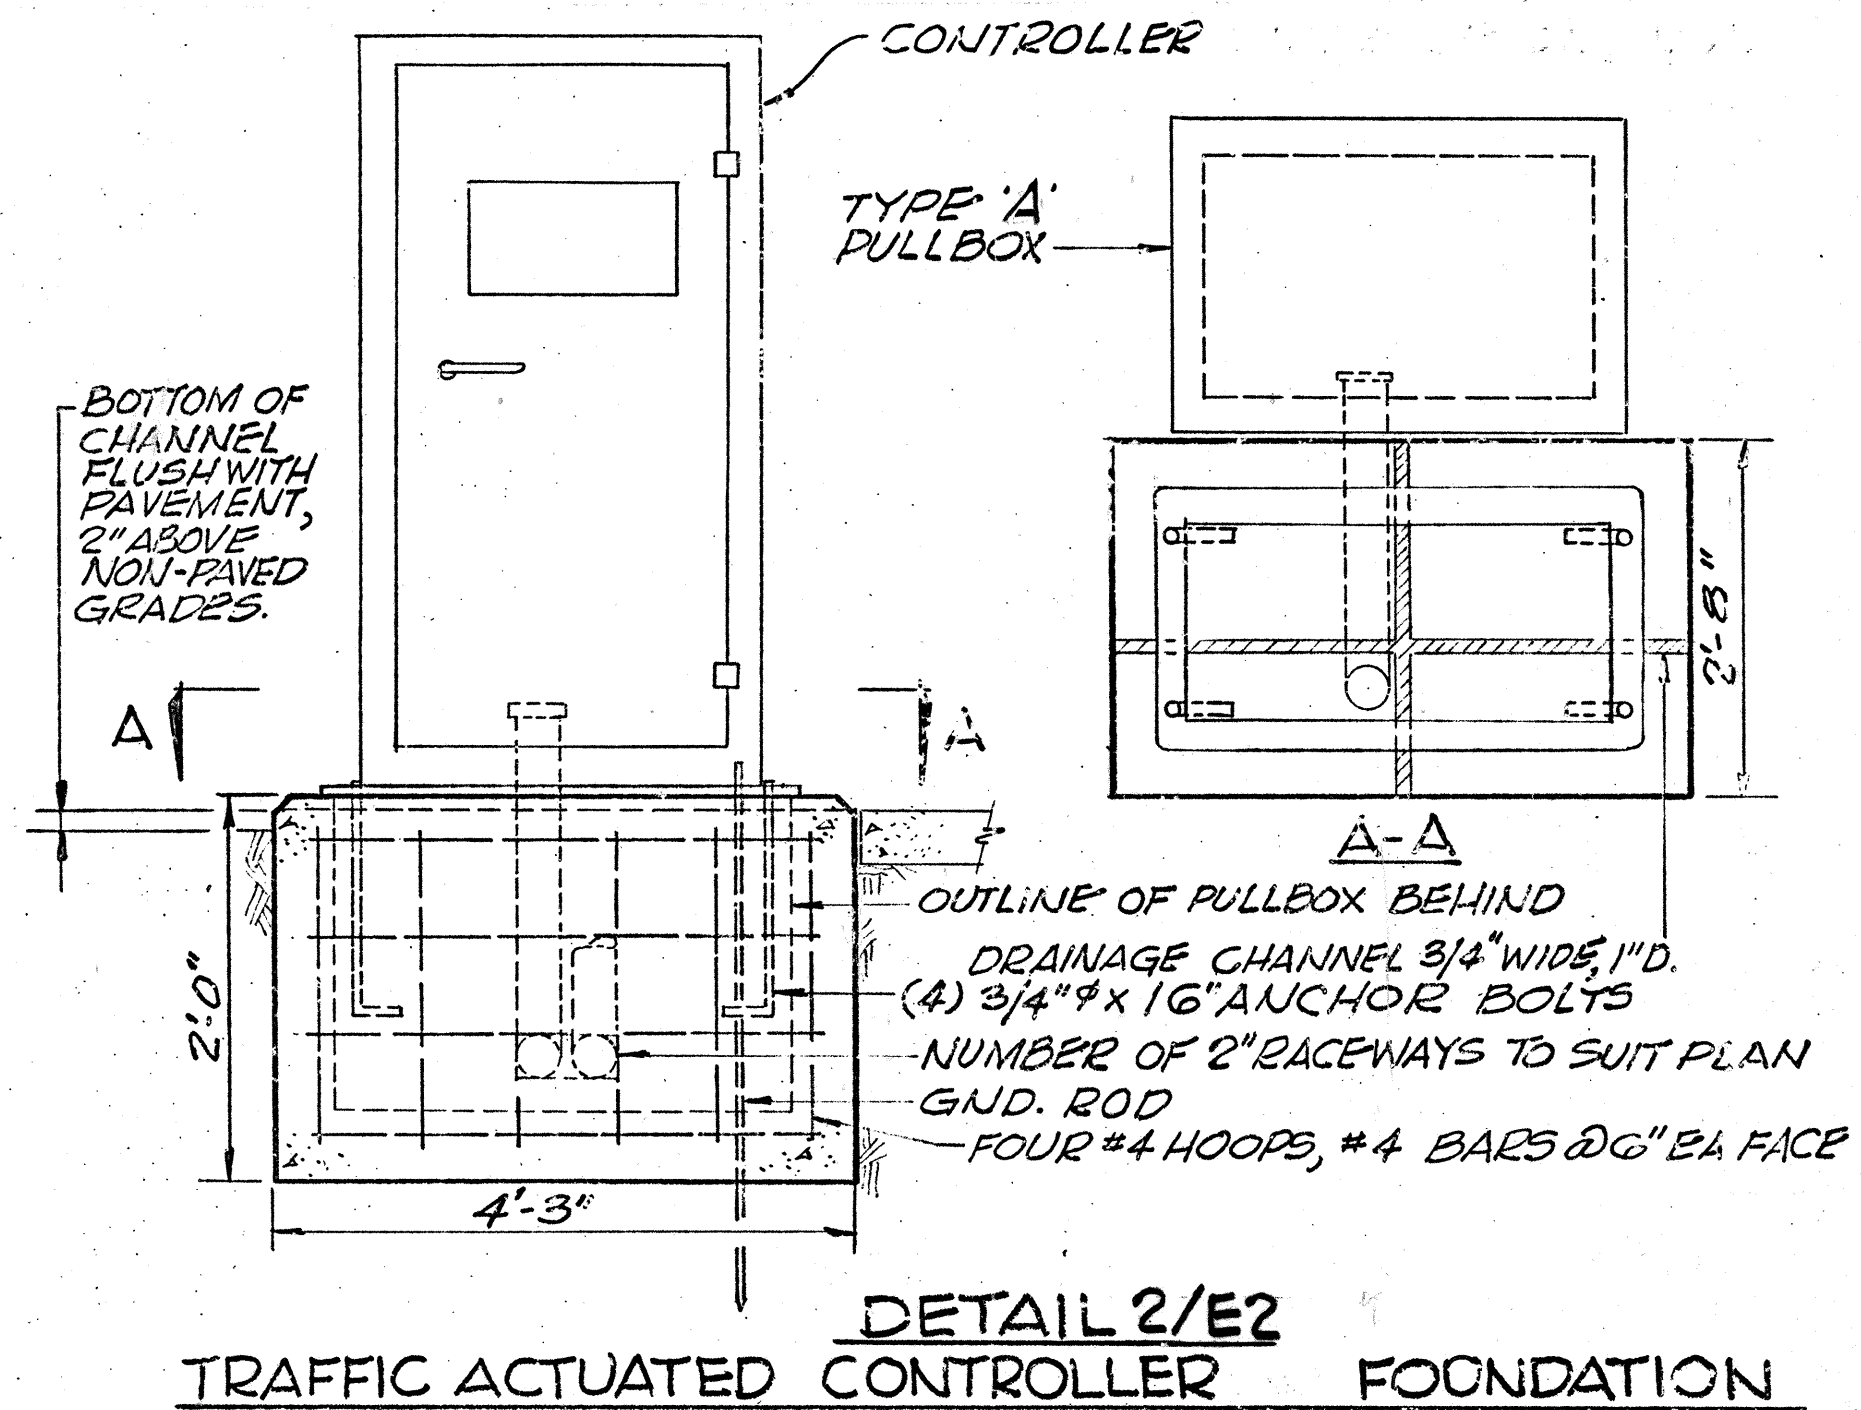
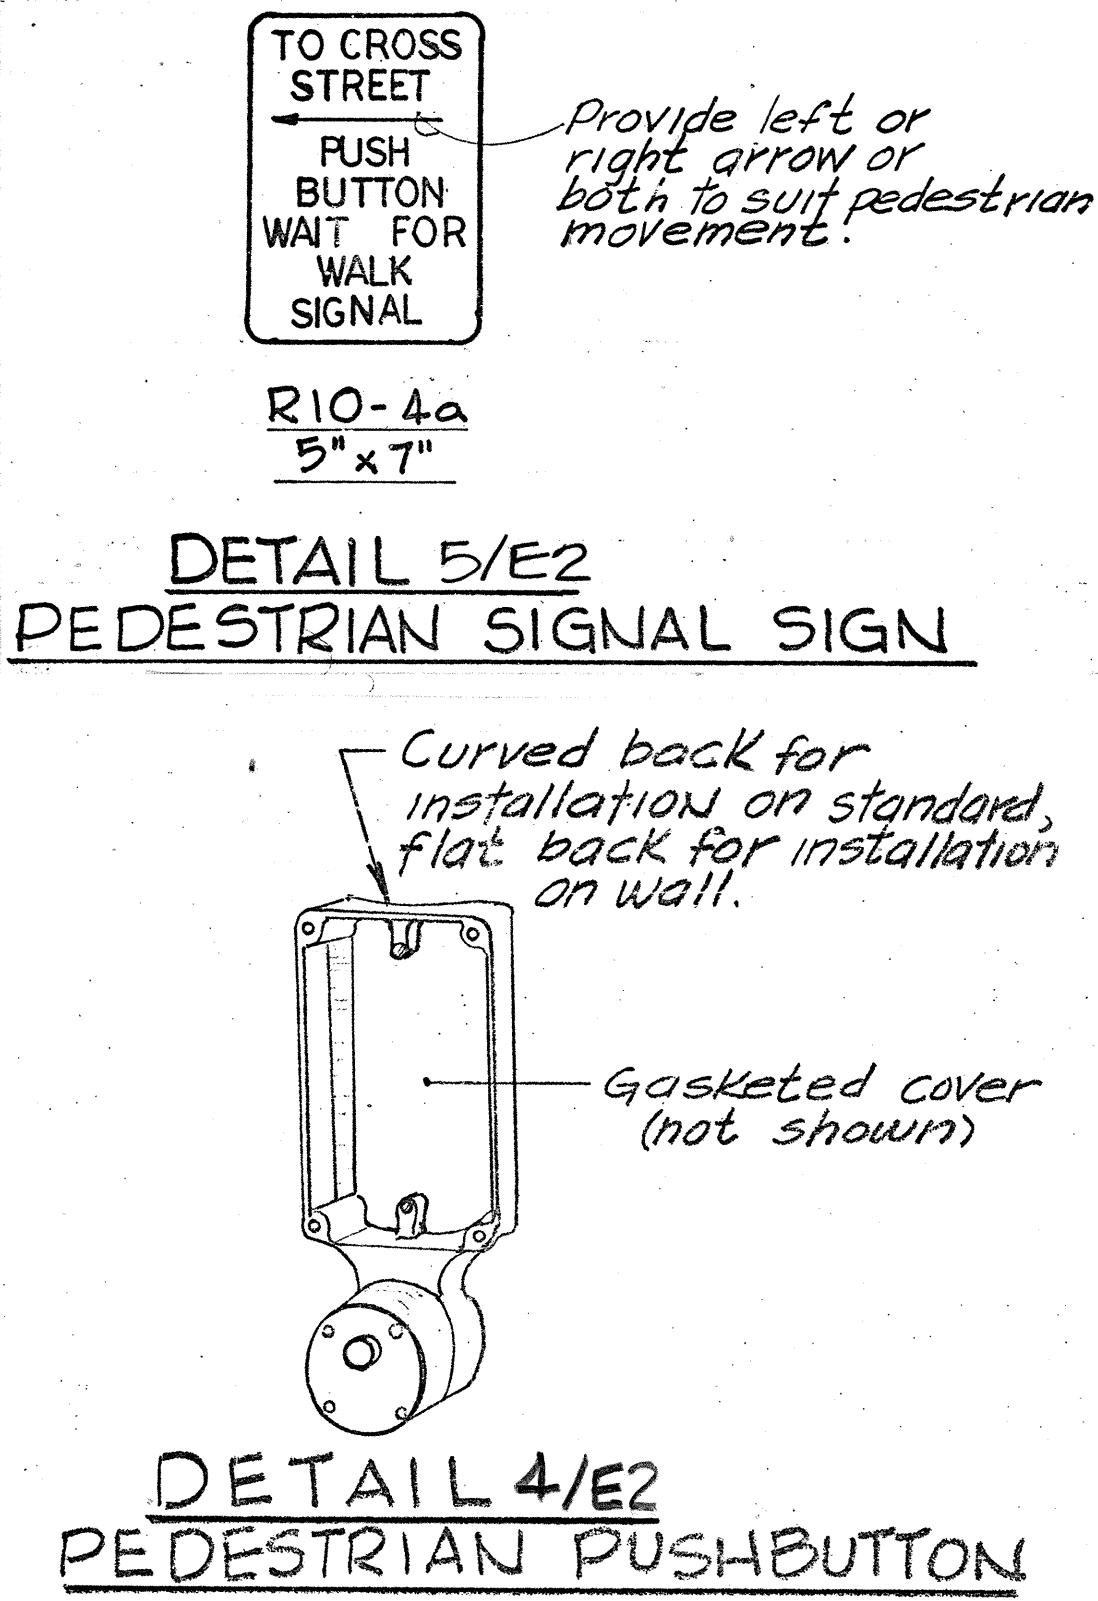
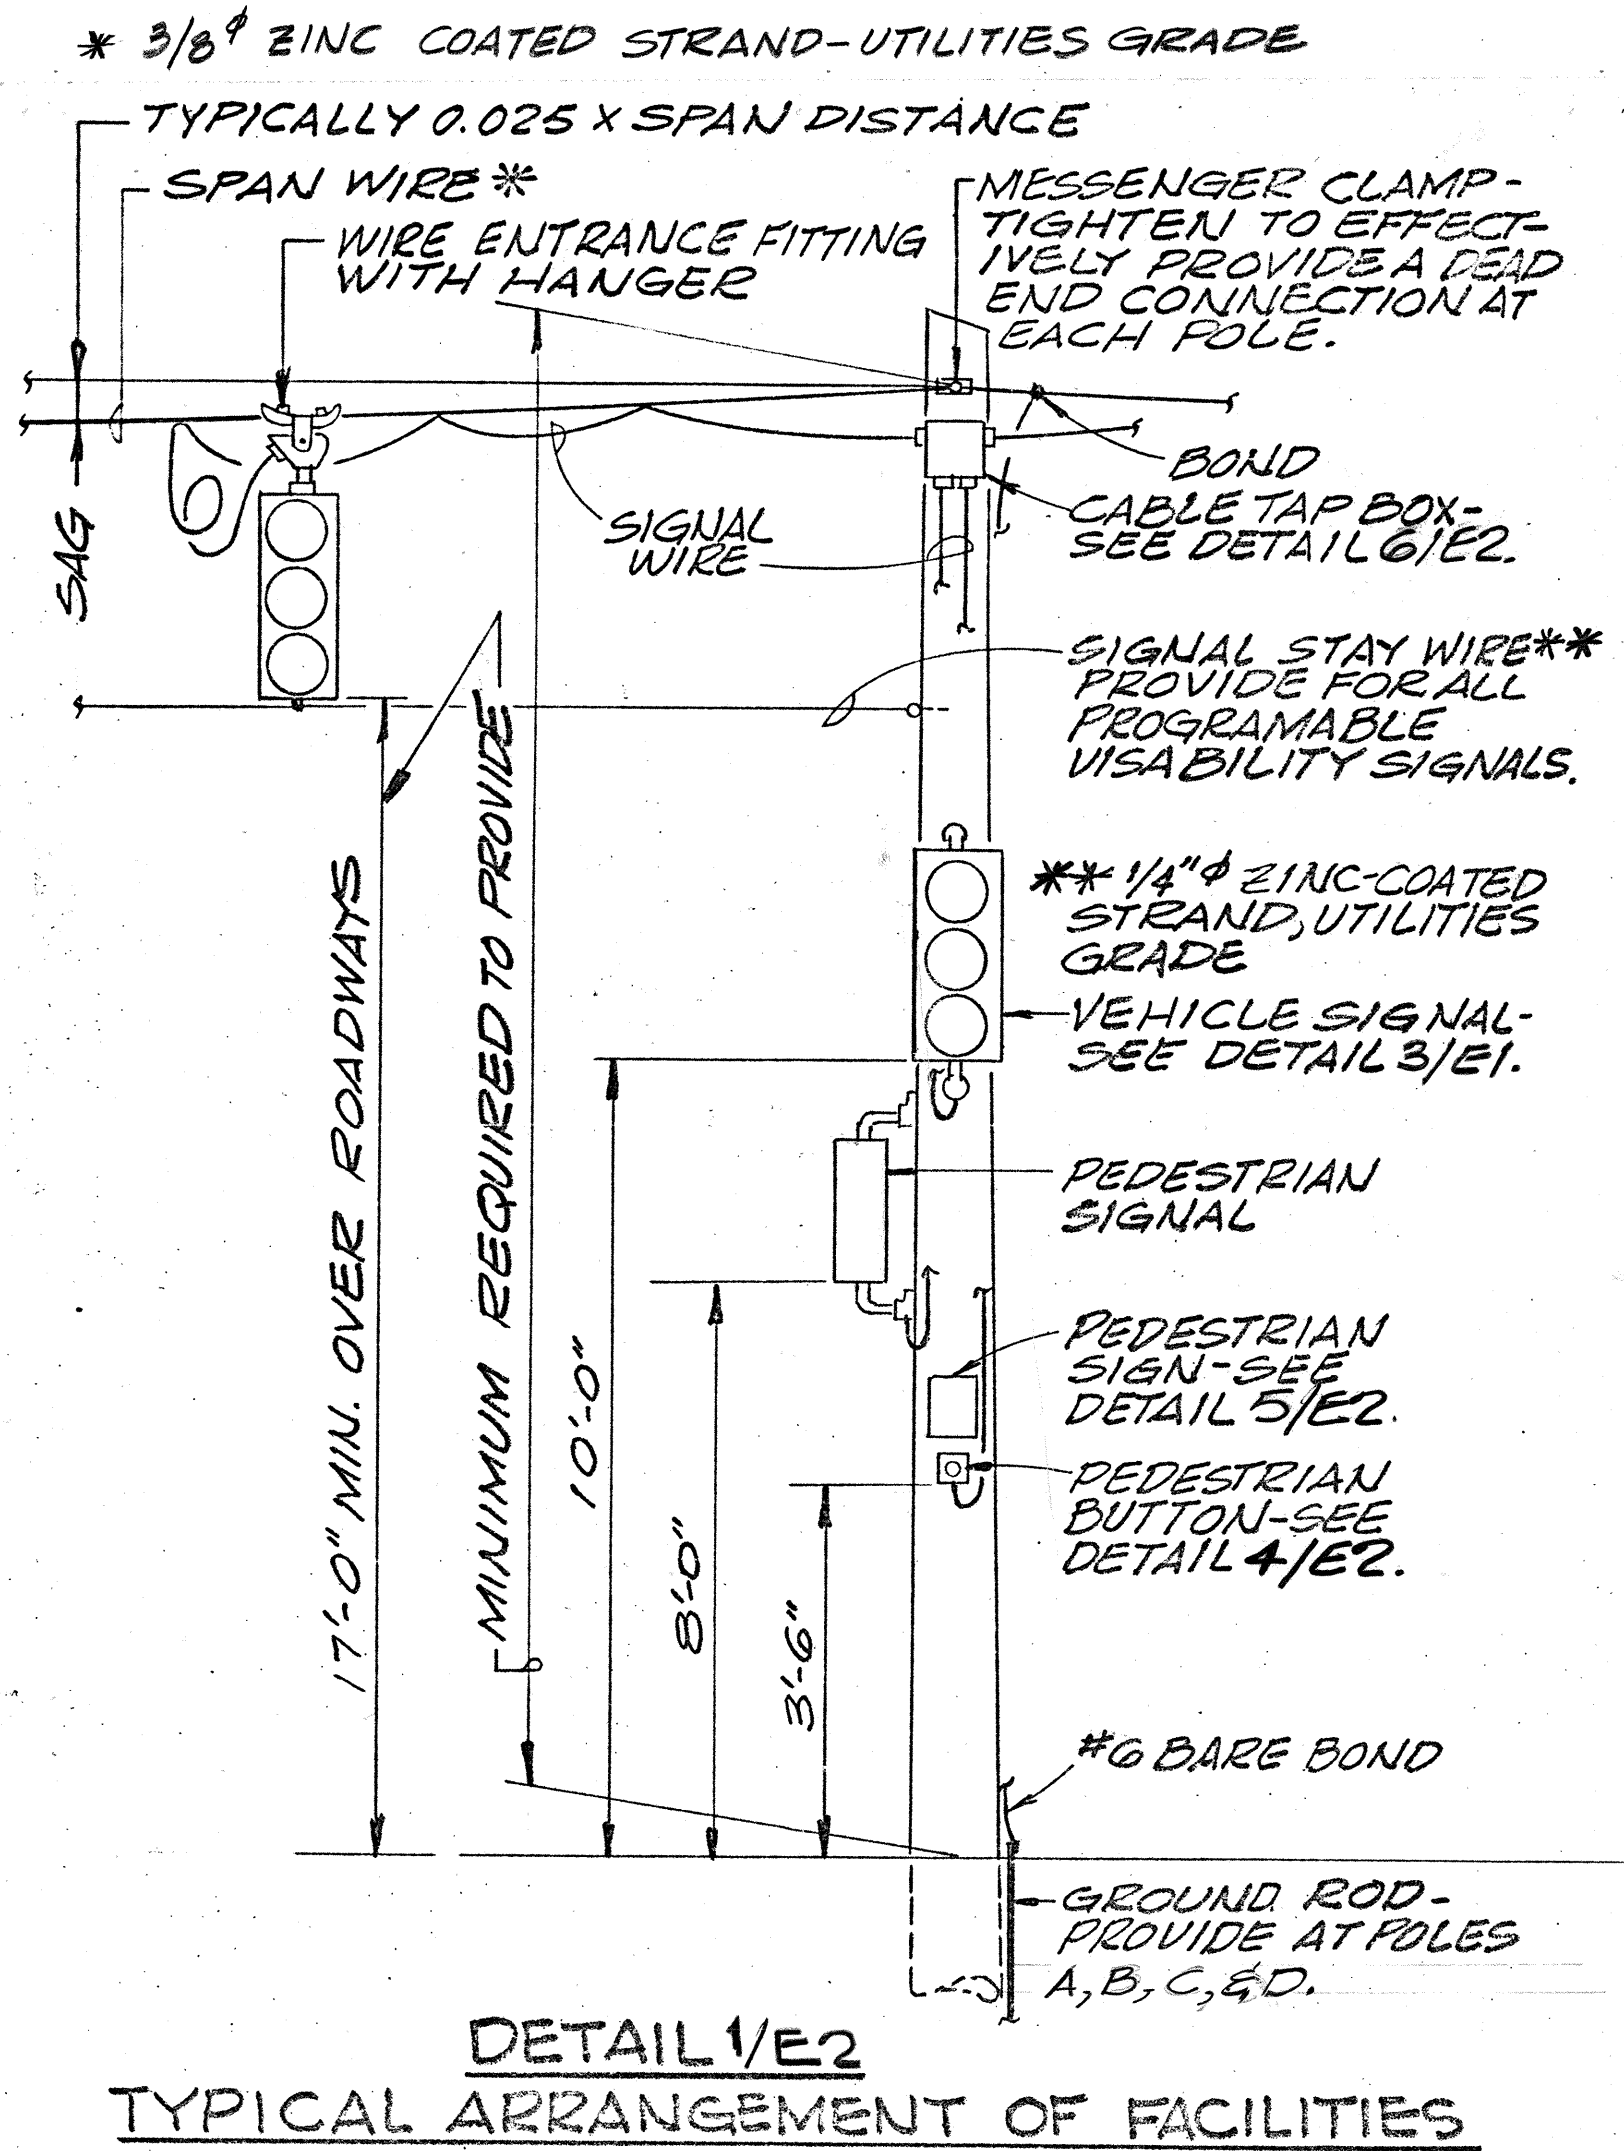
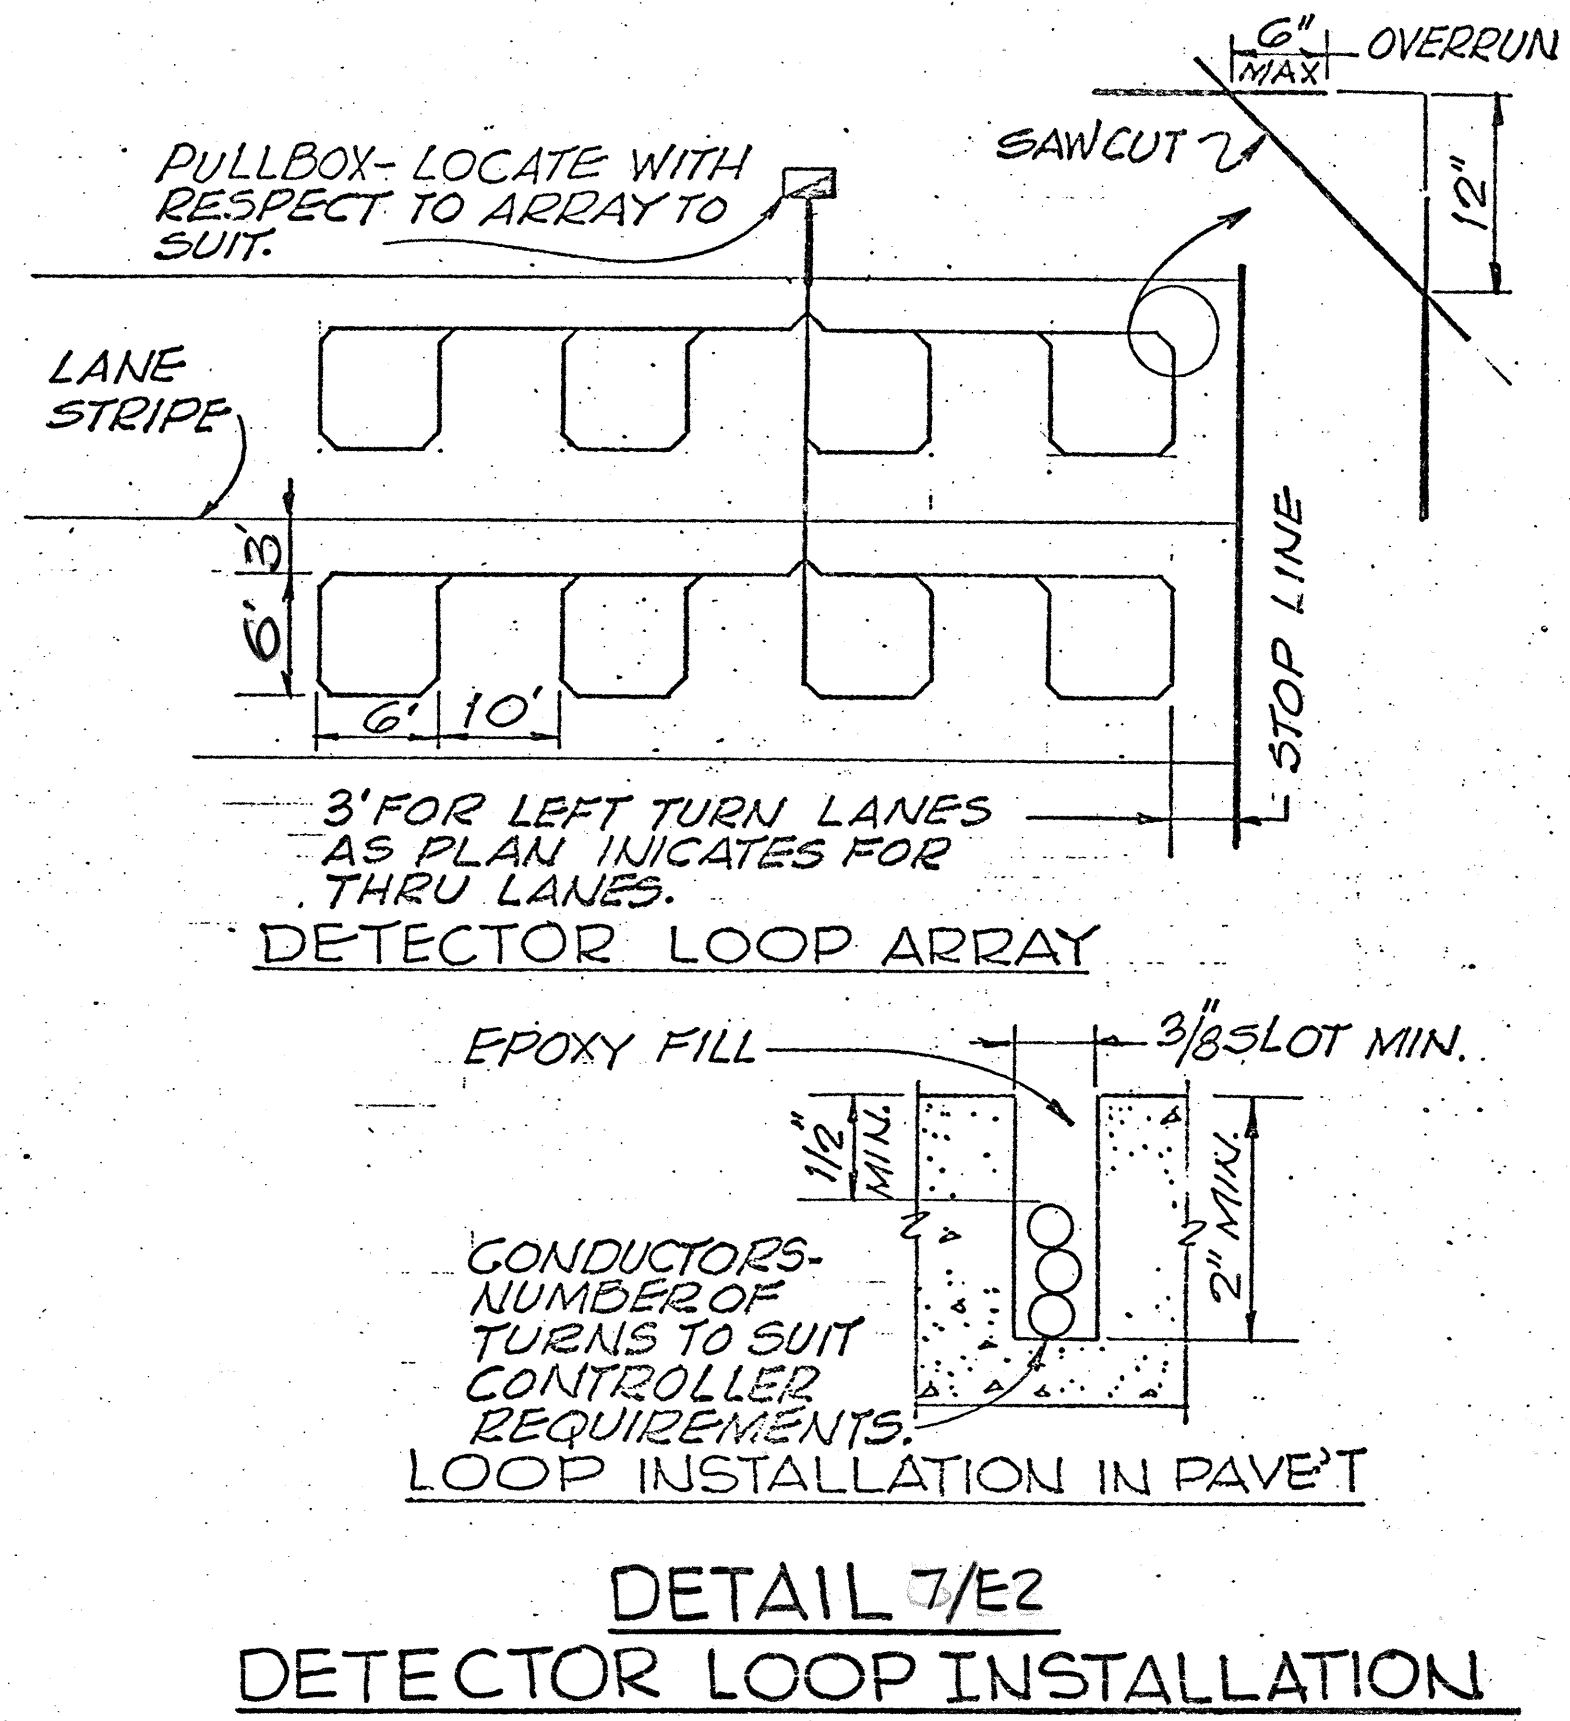


ROAD DIST. NO.	STATE	PROJ. NO.	FISCAL YEAR	SHEET NO.	TOTAL SHEETS
HAWAII	HAW.	760A-0175	1976	4	13

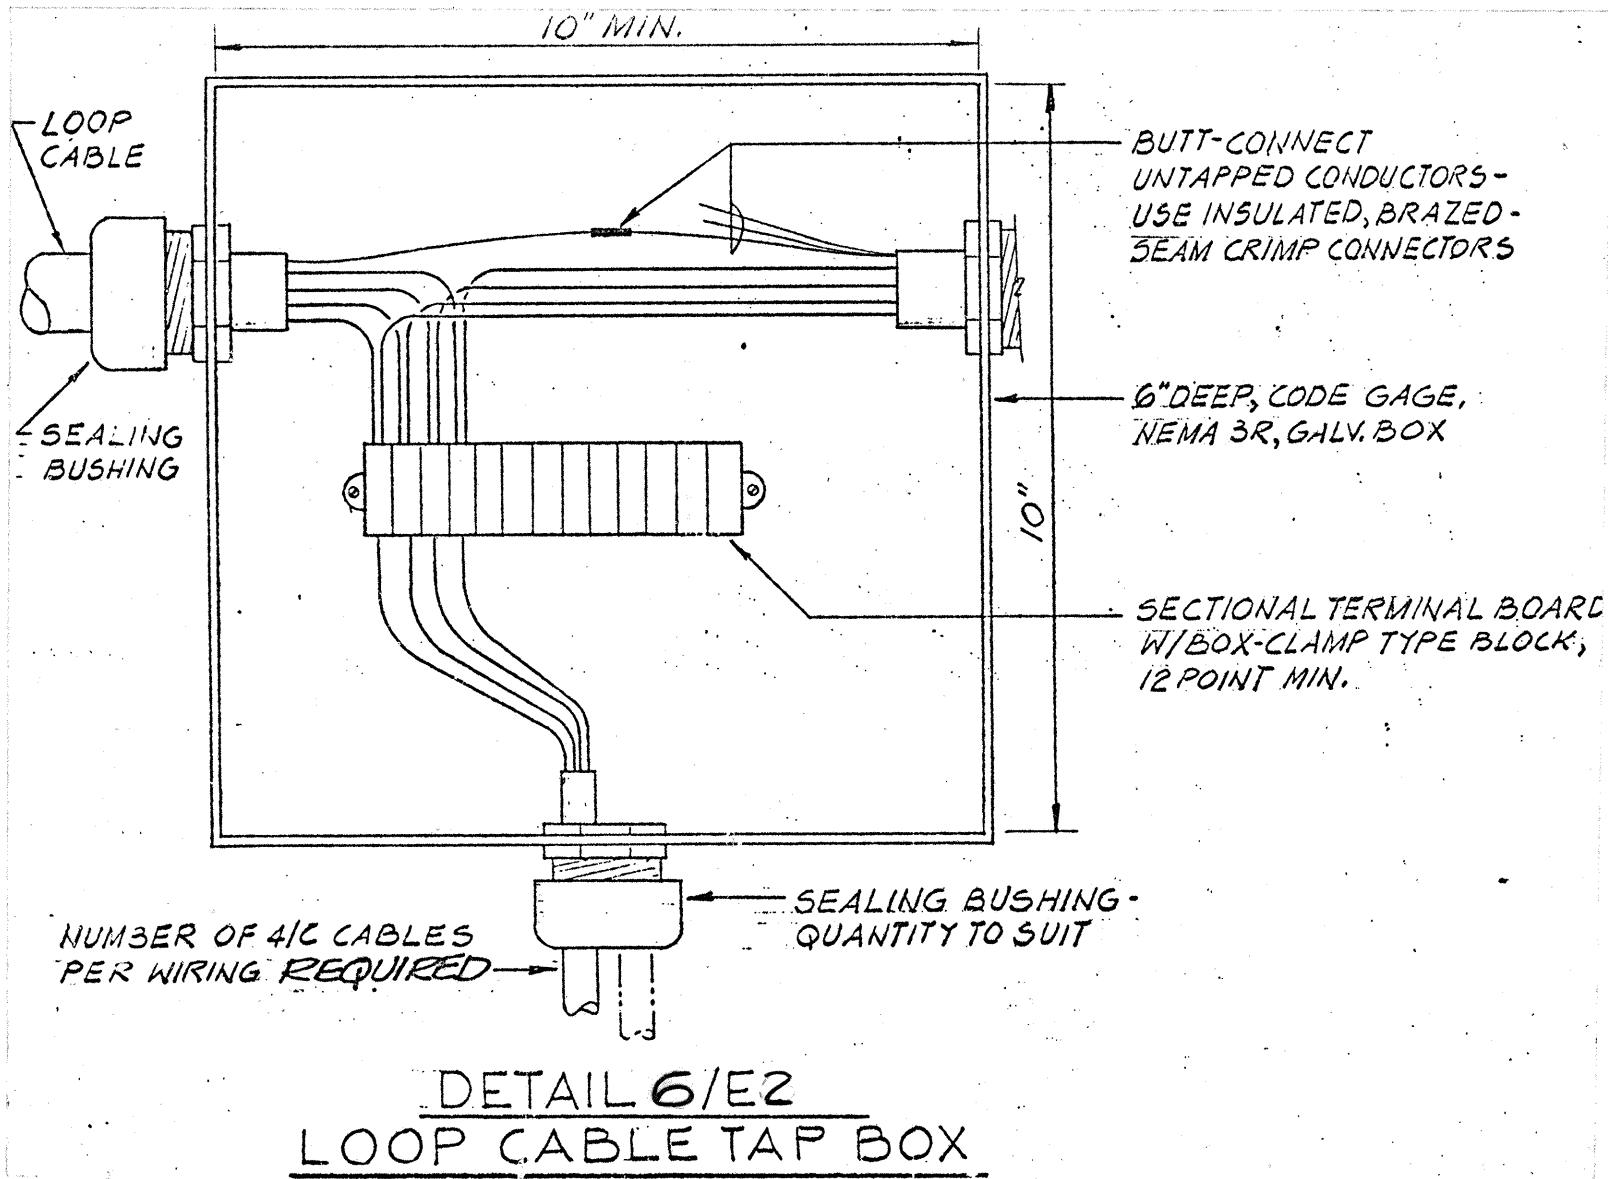

ANTHONY R. DALESIO
REGISTERED PROFESSIONAL ENGINEER
No. 2934
HAWAII, U.S.A.

THIS WORK WAS PREPARED BY
ME OR UNDER MY SUPERVISION.
A.R. Dalesio

ELECTRICAL SHEET E2.

STATE OF HAWAII
DEPARTMENT OF TRANSPORTATION
HIGHWAYS DIVISION

ELECTRICAL PLAN - PART II

FORT WEAVER ROAD
TEMPORARY TRAFFIC SIGNALS AT RENTON RD
PROJECT NO. 760A-01-75

SCALE: N.T.S.

DATE: Oct. 15, 1976

SHEET No. 2 OF 2 SHEETS

SURVEY PLOTTED BY	DATE
DRAWN BY	
TRACED BY	
CHECKED BY	
ORIGINAL PLAN	
NOTE BOOK	
No.	

4