

INDEX TO DRAWINGS	
SHEET NO.	DESCRIPTION
1	TITLE SHEET
2	GENERAL PLAN
3-4	TYPICAL SECTIONS
5-13	ALIGNMENT PLANS
14-25	ROADWAY PROFILES AND SUPERELEVATION DIAGRAMS
26	RAMP TERMINAL DETAILS
27-29	INTERSECTION DETAILS
30-43	GRADING, DRAINAGE AND CONSTRUCTION PLANS
44-56	DRAINAGE DETAILS
57-71	ROADWAY DETAILS
72	SOIL STABILIZATION PLAN
73-74	BORING LOGS
75-82	CONSTRUCTION SEQUENCE AND TEMPORARY SIGNING
83	DETOUR PLAN
84-112	SIGNING PLANS AND DETAILS
113-132	HIGHWAY LIGHTING AND ELECTRICAL PLANS & DETAILS
133-156	UTILITY PLANS AND DETAILS
157-165	OAHU SUGAR CO. FACILITIES
166-167	RAILROAD CROSSING
168-185	STRUCTURE PLAN AND DETAILS
186-187	CROSS SECTION KEY SHEETS
188-244	CROSS SECTIONS

SUPPLEMENTARY SHEETS TO THIS PROJECT ARE SHEET NOS:

- (1) C.O.36S-1, C.O.40S-1, S-2, S-3 & S-4
- (2) ADD.46S-1, C.O.46S-2 & C.O.49S-1
- (3) C.O.59S-1
- (4) C.O.84S-1, S-2, C.O.88S-1, C.O.93S-1, S-2 & S-3
- (5) C.O.129S-1
- (6) C.O.135S-1, C.O.139S-1, S-2 & C.O.140S-1
- (7) C.O.244S-1

TOTAL SHEET COUNT AFTER "AS-BUILT" POSTINGS 265 SHEETS.

PBQ&D DESIGNED BY D. LEE
P. S. & E. BY
548-7532
SEPT., 1979
DATE



STATE OF HAWAII
DEPARTMENT OF TRANSPORTATION

HIGHWAYS DIVISION

HONOLULU, HAWAII



"AS-BUILT"

PLANS FOR

CONSTRUCTION OF A PORTION OF
FORT WEAVER ROAD REALIGNMENT AND WIDENING
SOUTH OF FARRINGTON HIGHWAY TO THE VICINITY OF RENTON ROAD

FEDERAL AID URBAN SYSTEM PROJECT NO. M-7600(2)

DISTRICT OF EWA
ISLAND OF OAHU

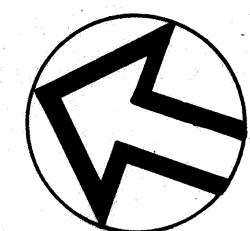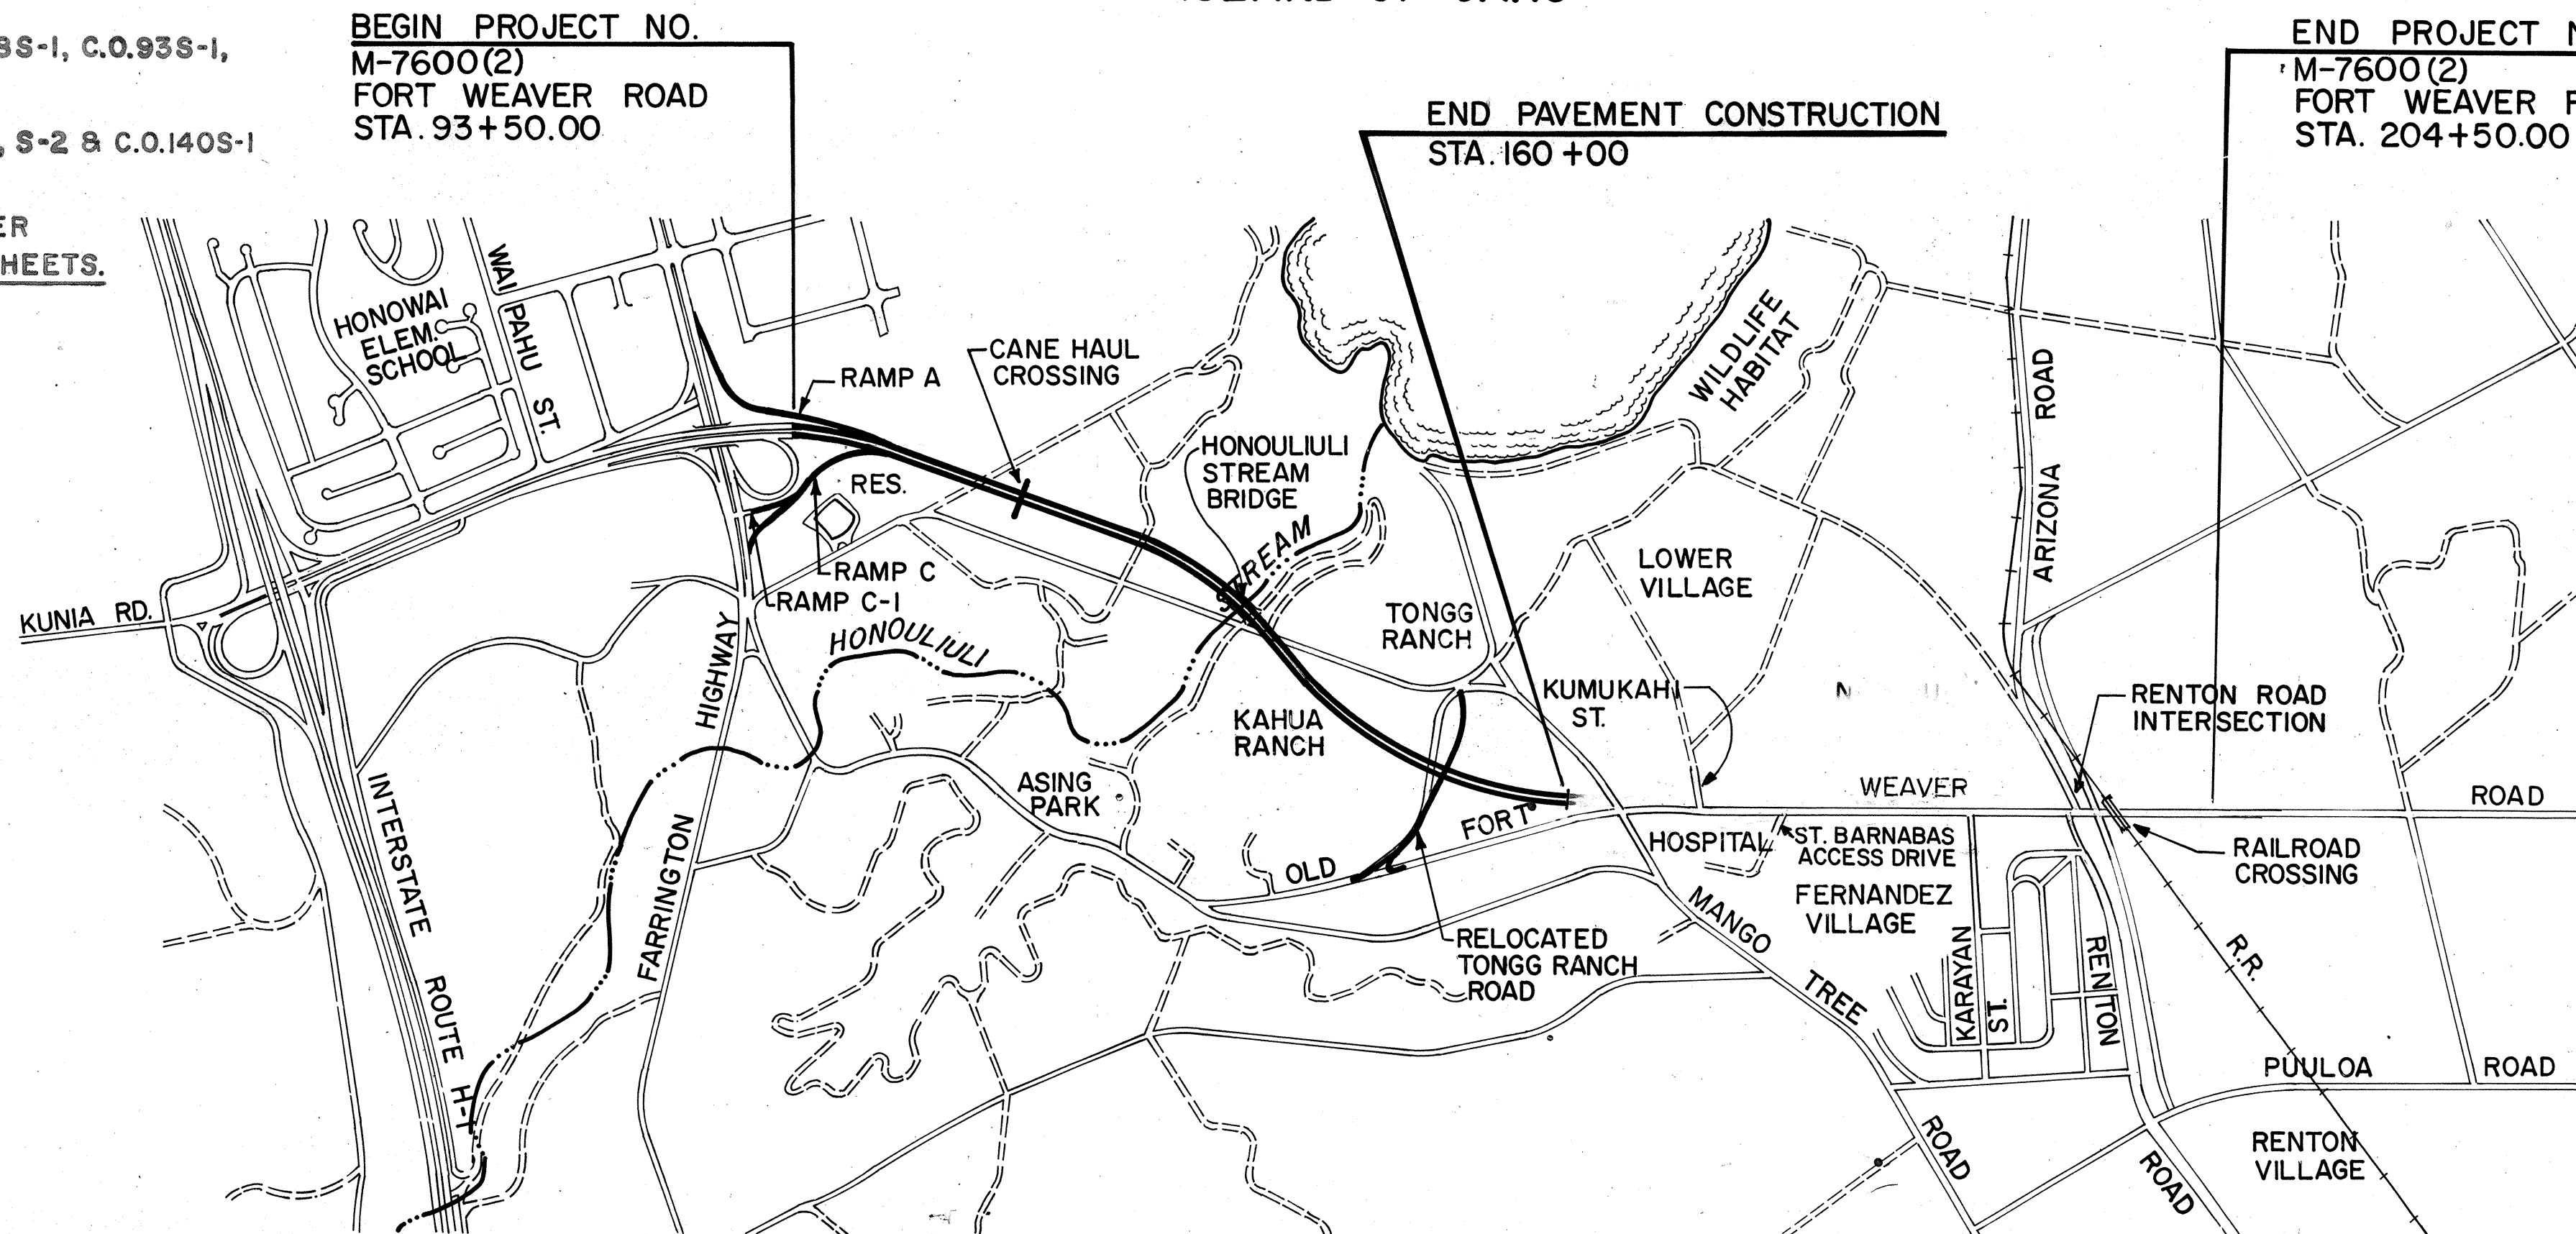

0 1000 2000 3000
GRAPHIC SCALE IN FEET


LAYOUT PLAN

GROSS LENGTH OF PROJECT 2.10 MI.
BRIDGE .05 MI.
NET LENGTH OF ROADWAY 1.21 MI.

CHANGES MADE DURING CONSTRUCTION HAVE BEEN INCORPORATED ON THESE PLANS EXCEPT CHANGES IN THE ORIGINAL THEORETICAL QUANTITIES. FOR ACTUAL QUANTITIES, REFER TO PROJECT LEDGER AND/OR COMPUTATION BOOK.

Robert Y. Omai
RESIDENT ENGINEER

8/9/84
DATE

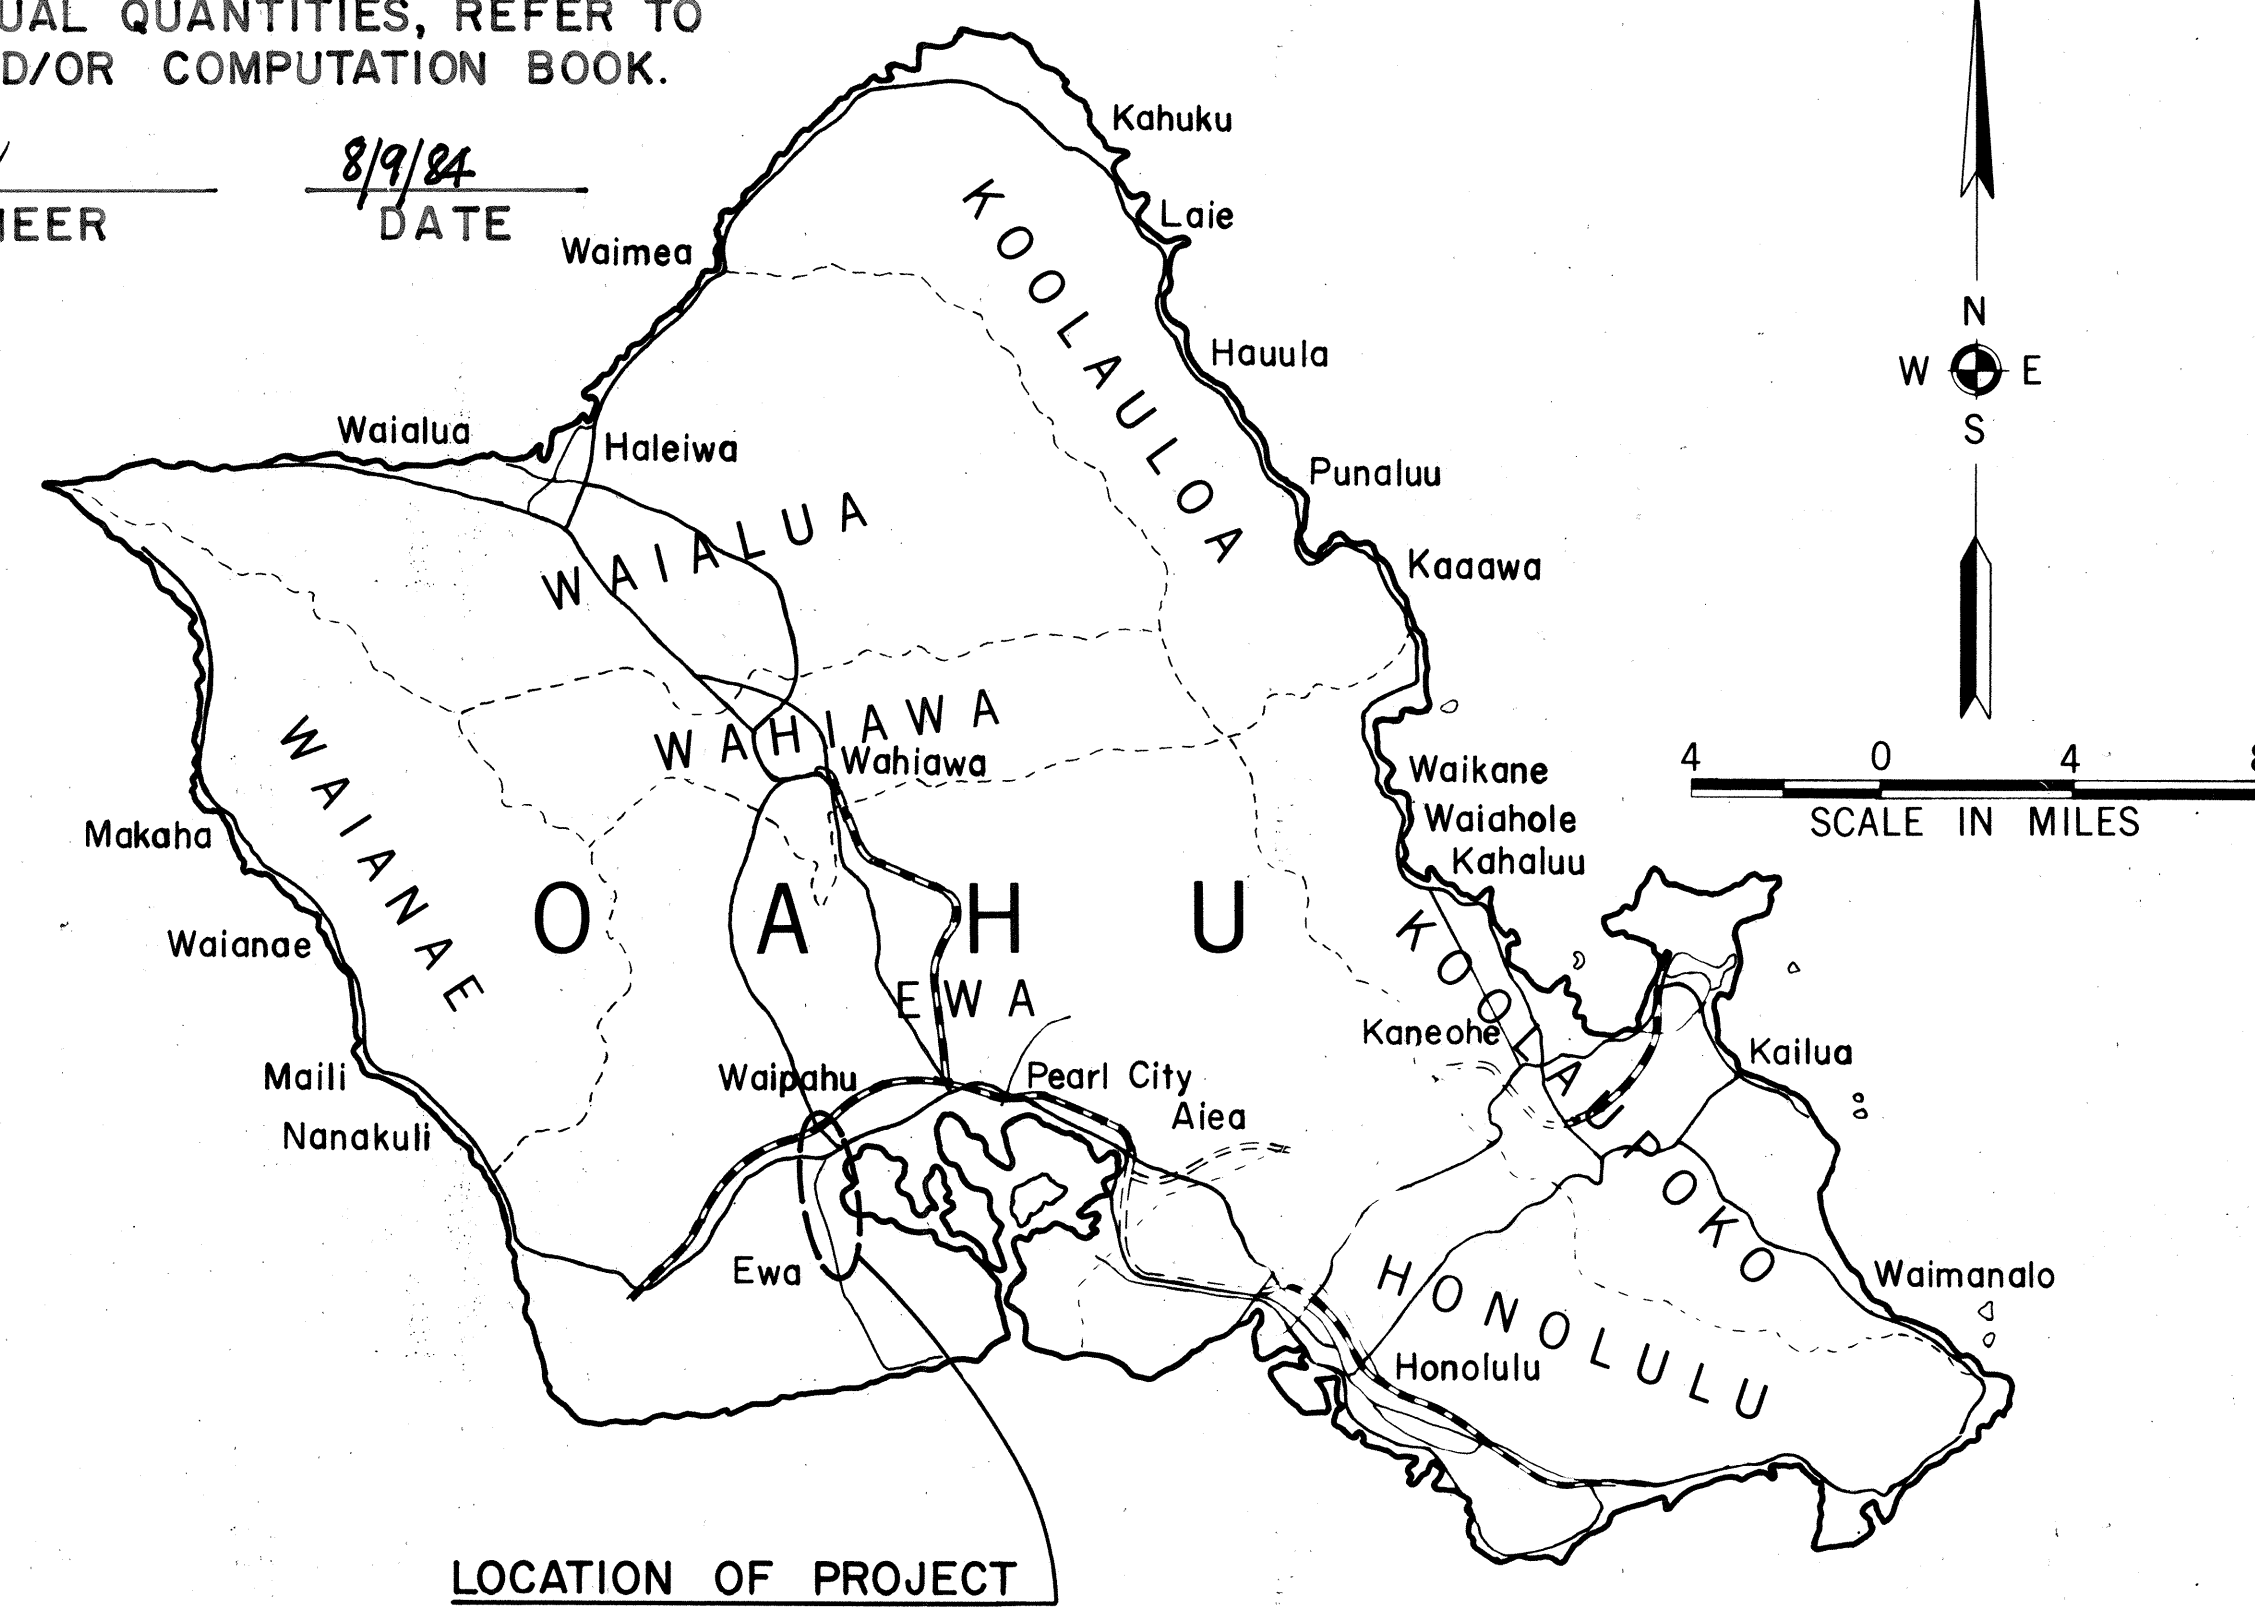

LOCATION OF PROJECT

Federal Aid Interstate Projects Previously Constructed or Under Construction

DESIGN CLASSIFICATION

DESIGN ADT (1998).....31,100
DHV..... 2,700
D..... 55/45
T..... 3 %
V..... 50 MPH

SCALES

PLANS.....Horiz. 1" = 50'
PROFILES.....Horiz. 1" = 50'
Vert. 1" = 10'
DETAIL ROADWAY PLANS...Horiz. 1" = 20'
CROSS SECTIONS.....Horiz. 1" = 10'
Vert. 1" = 10'

DEPARTMENT OF TRANSPORTATION
FEDERAL HIGHWAY ADMINISTRATION
APPROVED: [Signature]
DIVISION ADMINISTRATOR DATE 9/18/79

DEPARTMENT OF TRANSPORTATION
STATE OF HAWAII
APPROVED: [Signature]
DIR. OF TRANSPORTATION DATE 9/18/79