
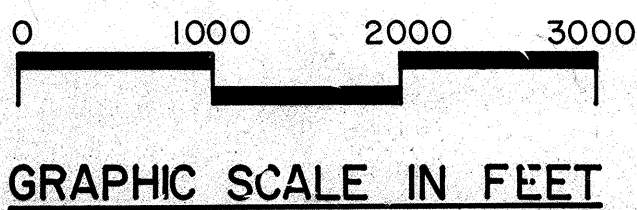
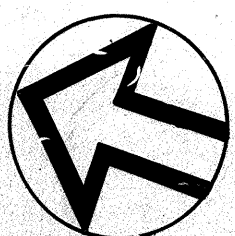


INDEX TO DRAWINGS	
SHEET NO.	DESCRIPTION
1	TITLE SHEET
2-3	GENERAL PLANS
4-6	TYPICAL SECTIONS
7-12	ALIGNMENT PLANS
13-15	ROADWAY PROFILES AND SUPERELEVATION DIAGRAMS
16	INTERSECTION DETAILS
17-23	GRADING, DRAINAGE AND CONSTRUCTION PLANS ①
24-31	DRAINAGE DETAILS ②
32-39,39A	ROADWAY DETAILS ③
40	BORING LOG
41-43	CONSTRUCTION SEQUENCE AND TEMPORARY SIGNING
44-45	DETOUR PLAN
46-66	SIGNING PLANS AND DETAILS ④
67-78	HIGHWAY LIGHTING AND ELECTRICAL PLANS & DETAILS
79-85	UTILITY PLANS AND DETAILS ⑤
86-94	OAHU SUGAR CO. FACILITIES
95-96	RAILROAD CROSSING
97-108	STRUCTURE PLAN AND DETAILS
109-119	LANDSCAPING PLANS
120-122	CROSS SECTION KEY SHEETS
123-162	CROSS SECTIONS ⑥

SUPPLEMENTARY SHEETS TO THIS PROJECT ARE PLAN SHEET NOS:
 ① C.O. 20 S-1 & C.O. 20 S-2, ② C.O. 28 S-1, ③ C.O. 38 S-1 & C.O. 38 S-2, ④ C.O. 49 S-1 & C.O. 49 S-2, ⑤ ADD. 82 S-1 & ADD. 85 S-1, ⑥ C.O. 122 S-1 & C.O. 132 S-1
 TOTAL SHEET COUNT AFTER "AS BUILT" POSTINGS: 174

PBQ&D DESIGNED BY
 D. LEE
 P. S. & E. BY
 548-7532
 APRIL 1982
 DATE
 PHONE

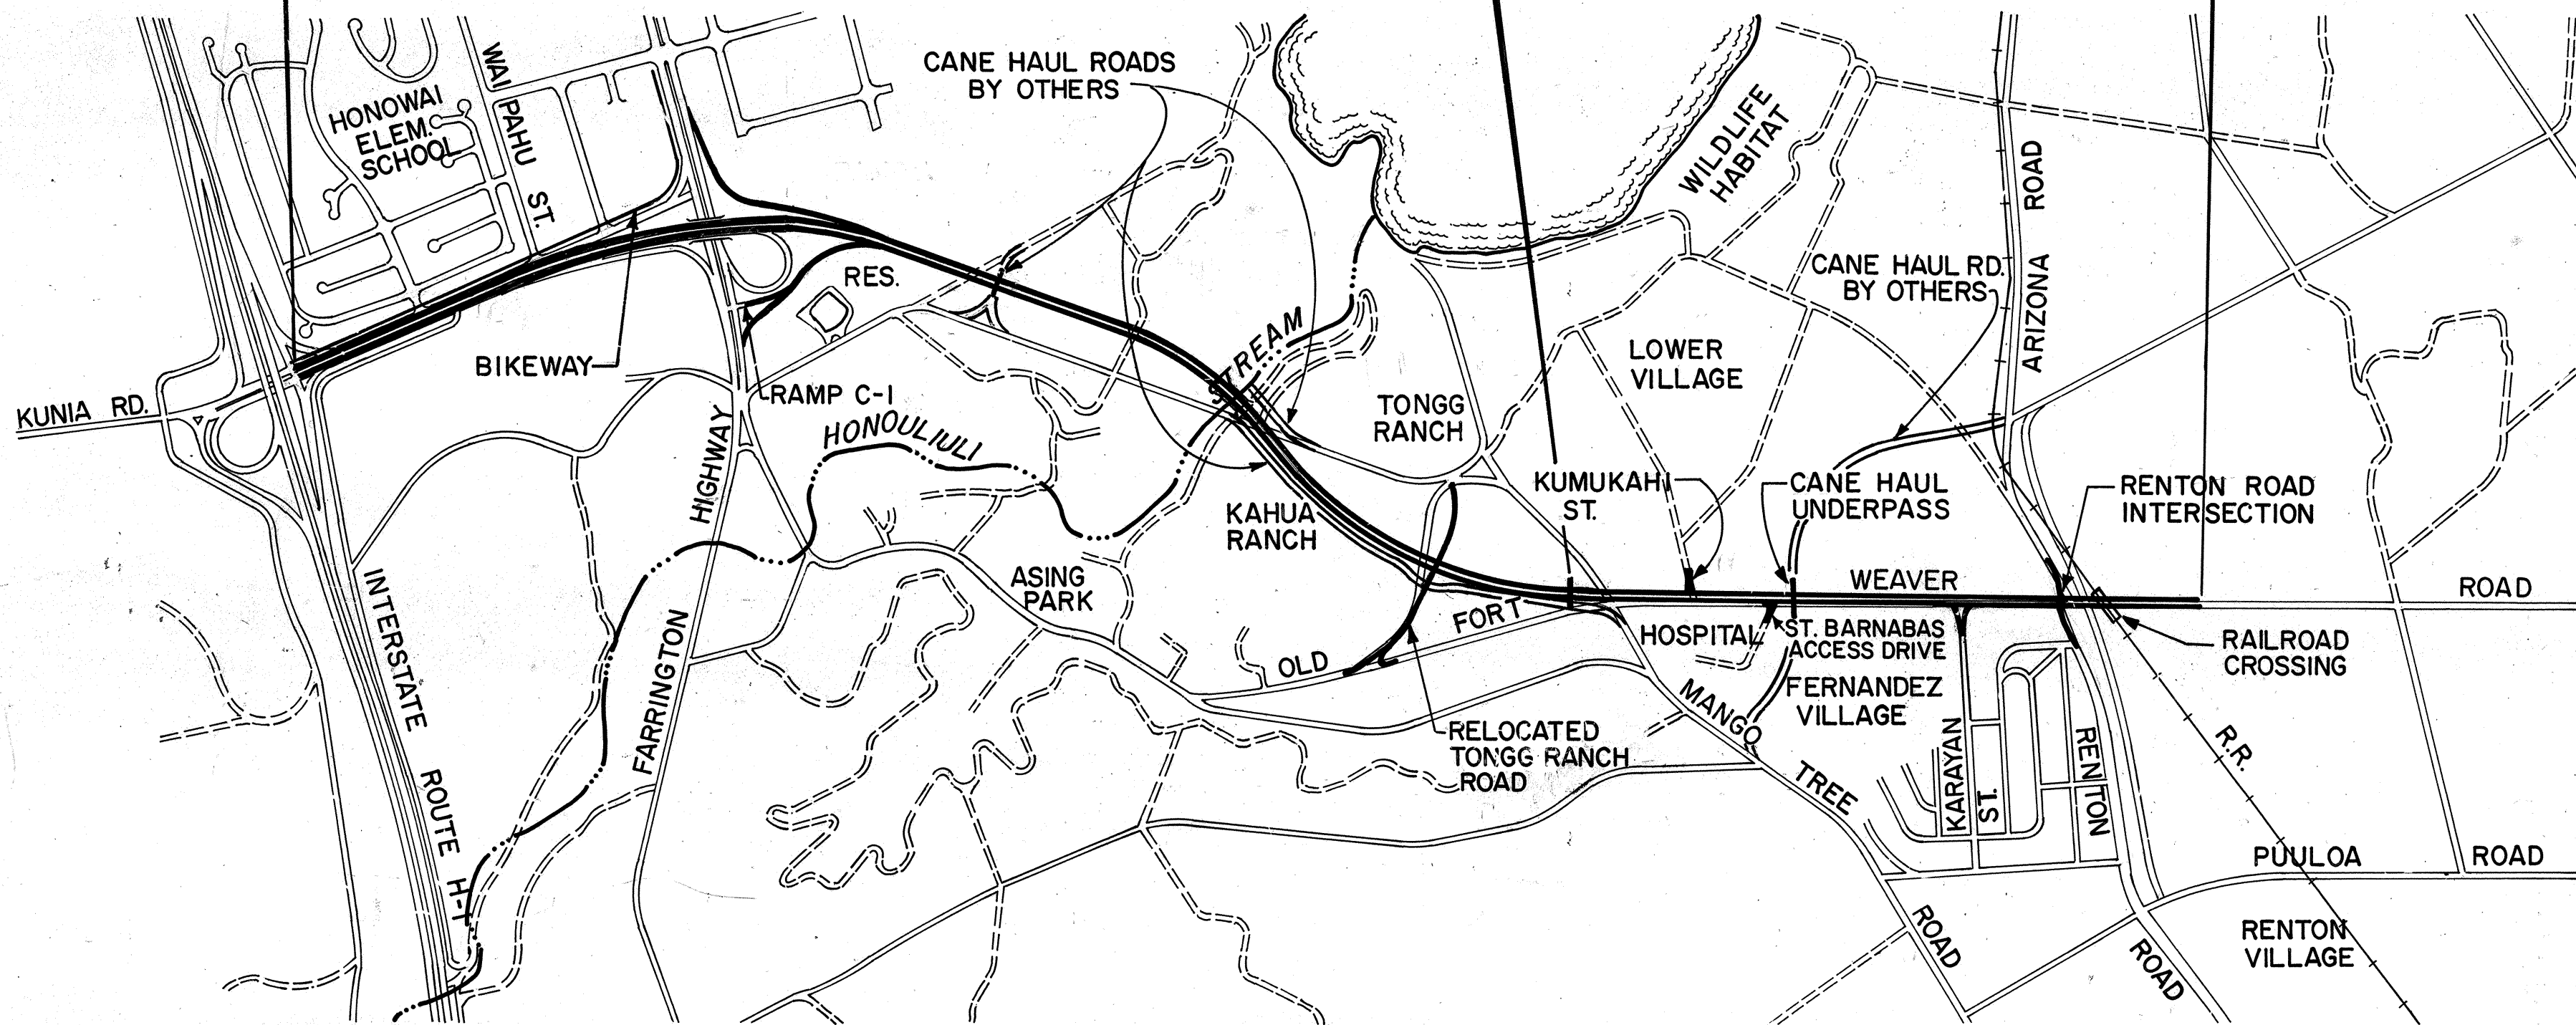


LAYOUT PLAN

GROSS LENGTH OF PROJECT .84 MI.
 BRIDGE .02 MI.
 NET LENGTH OF ROADWAY .82 MI.

STATE OF HAWAII DEPARTMENT OF TRANSPORTATION HIGHWAYS DIVISION HONOLULU, HAWAII **"AS-BUILT"** PLANS FOR CONSTRUCTION OF A PORTION OF **FORT WEAVER ROAD REALIGNMENT AND WIDENING** VICINITY OF MANGO TREE ROAD TO THE VICINITY OF RENTON ROAD STATE PROJECT NO. 7600B-01-82 AND FEDERAL AID PROJECT NO. S-RS-0760(2) R/W

DISTRICT OF EWA
 ISLAND OF OAHU

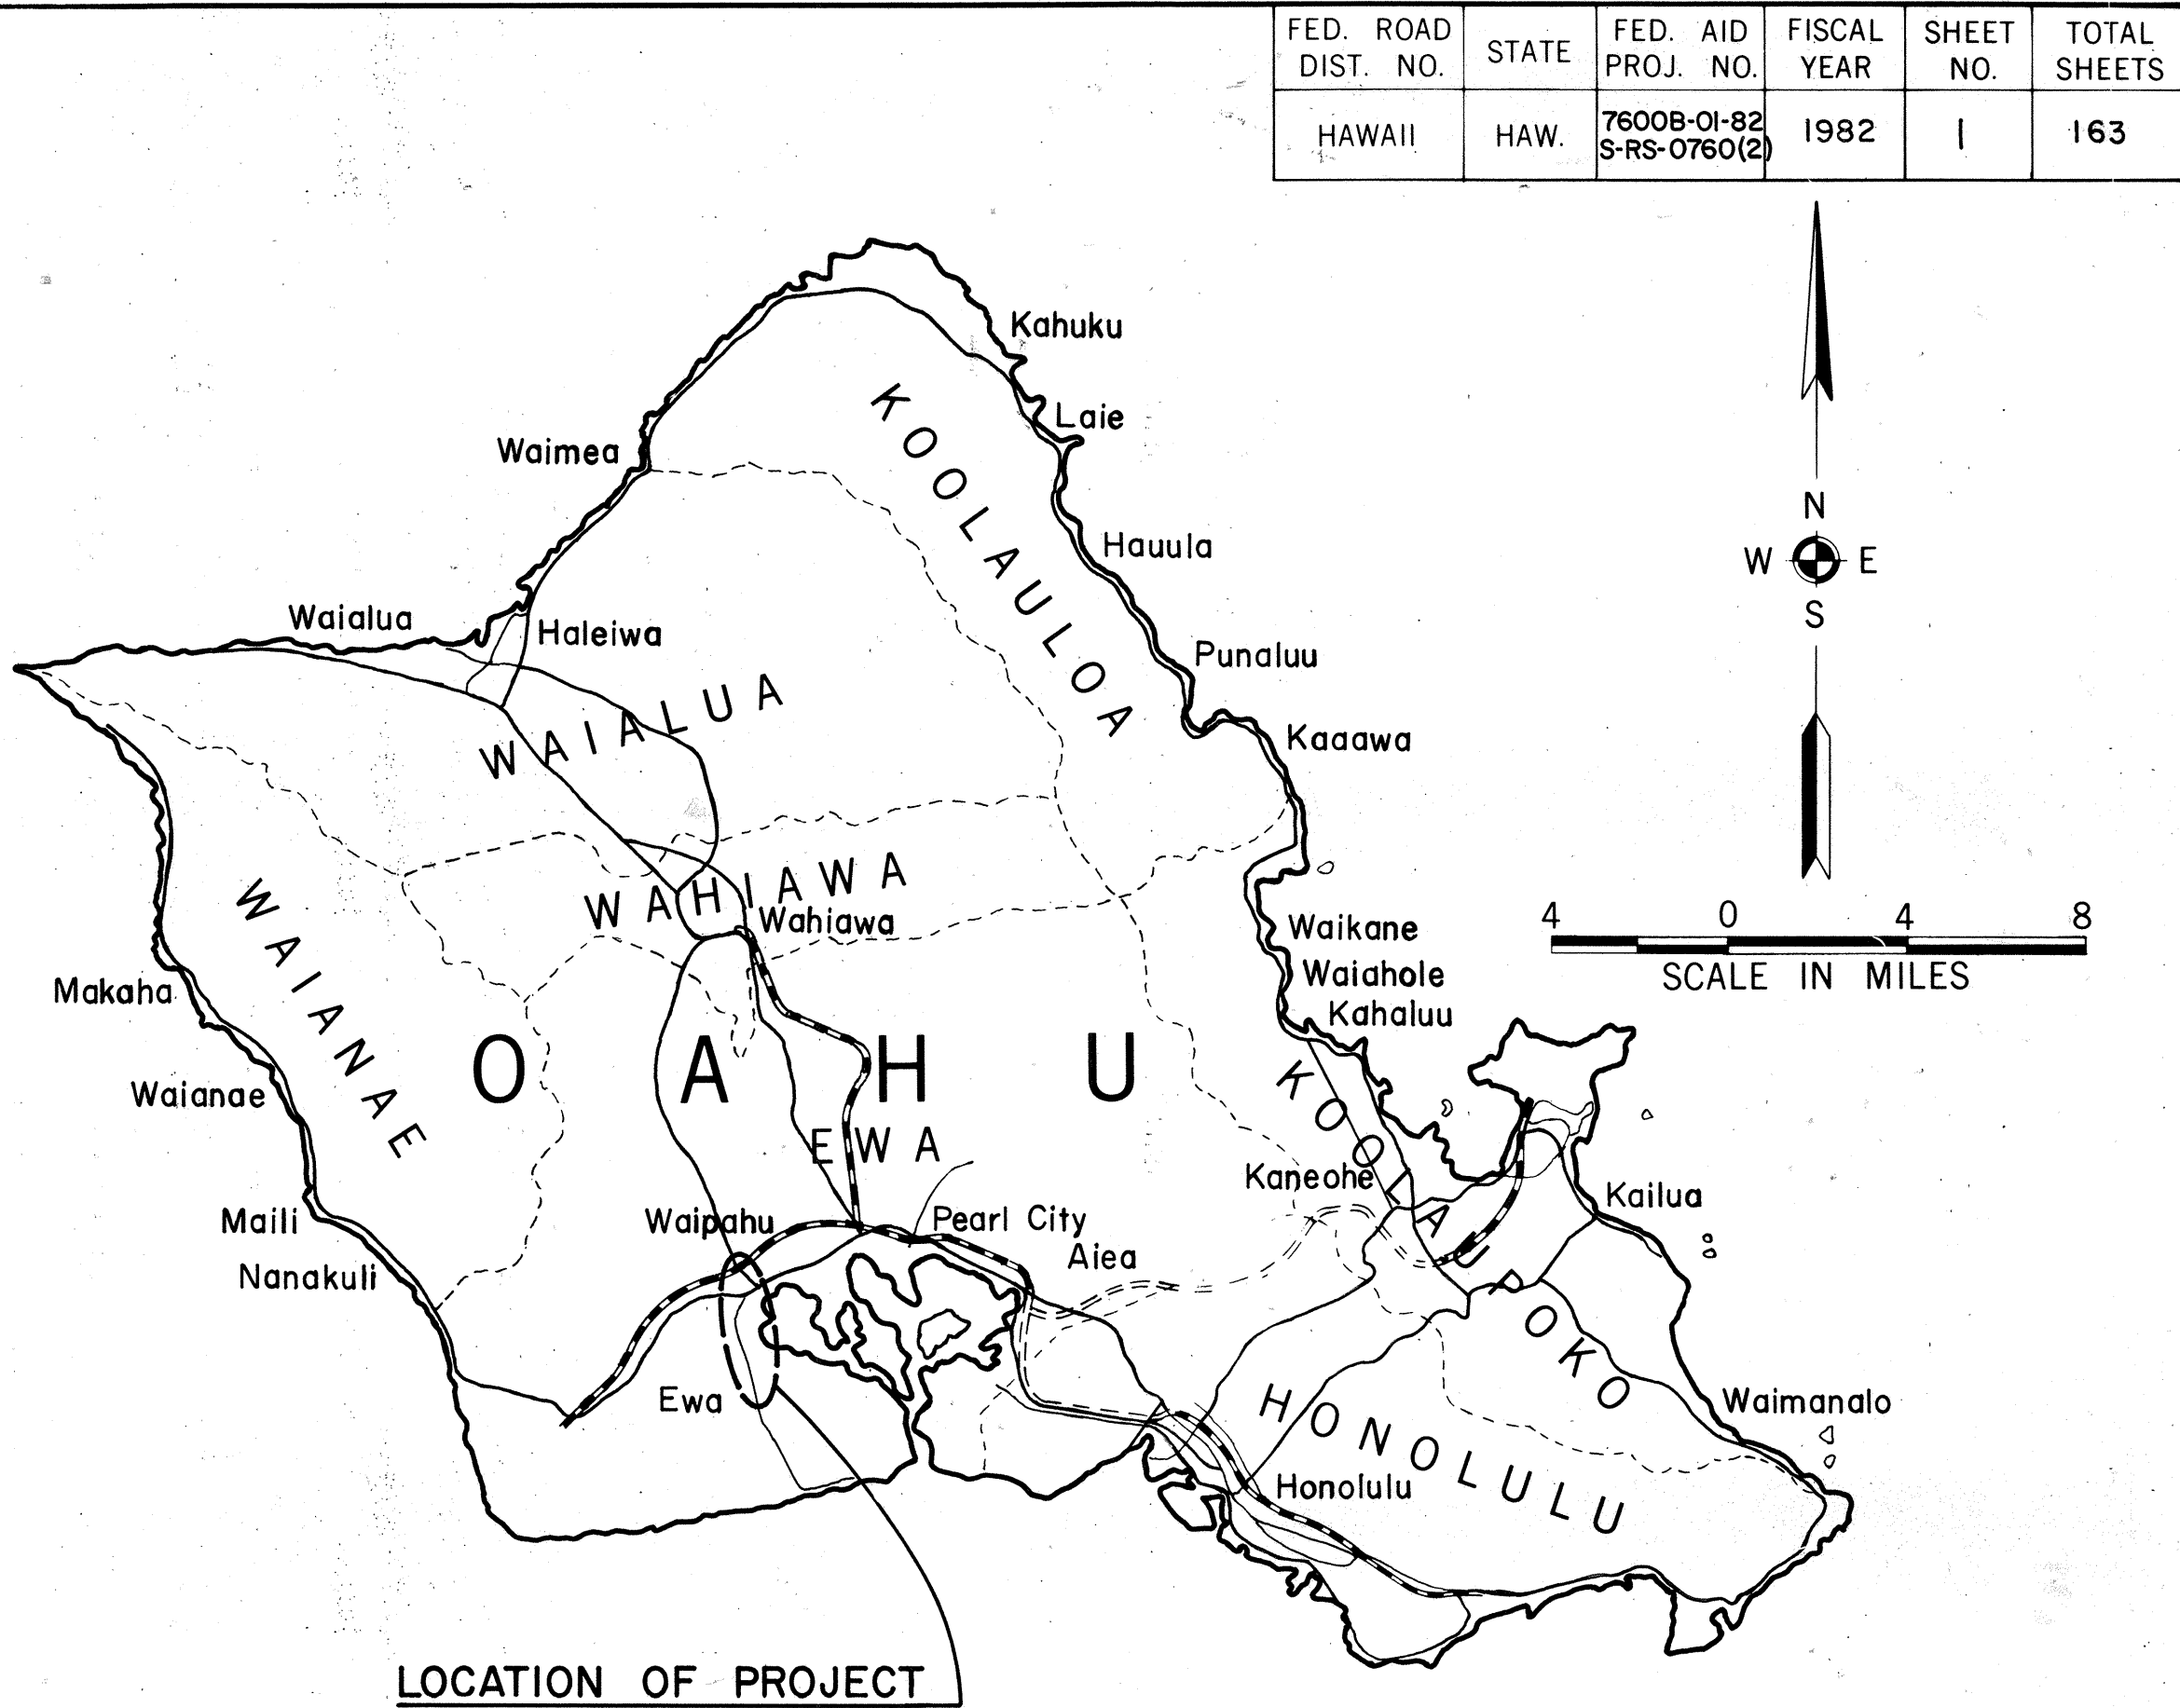

LOCATION OF PROJECT
 Federal Aid Interstate Projects Previously Constructed or Under Construction
 CHANGES MADE DURING CONSTRUCTION HAVE BEEN INCORPORATED ON THESE PLANS EXCEPT CHANGES IN THE ORIGINAL THEORETICAL QUANTITIES. FOR ACTUAL QUANTITIES, REFER TO PROJECT LEDGER AND/OR COMPUTATION BOOK.

RESIDENT ENGINEER
 DATE 10-2-85

DESIGN CLASSIFICATION

DESIGN ADT (2002).....30,600
 DHV..... 2,750
 D..... 55/45
 T..... 2 %
 V..... 50 MPH

SCALES

PLANS.....Horiz. 1" = 50'
 PROFILES.....Horiz. 1" = 50'
 Vert. 1" = 10'
 DETAIL ROADWAY PLANS...Horiz. 1" = 20'
 CROSS SECTIONS.....Horiz. 1" = 10'
 Vert. 1" = 10'

DEPARTMENT OF TRANSPORTATION
 FEDERAL HIGHWAY ADMINISTRATION
 APPROVED:
 DIVISION ADMINISTRATOR
 DATE 5/1/82

DEPARTMENT OF TRANSPORTATION
 STATE OF HAWAII
 APPROVED:
 DIR. OF TRANSPORTATION
 DATE