



FED. ROAD DIST. NO.	STATE	PROJ. NO.	FISCAL YEAR	SHEET NO.	TOTAL SHEETS
HAWAII	HAW.	808-02-68	1968	12	15

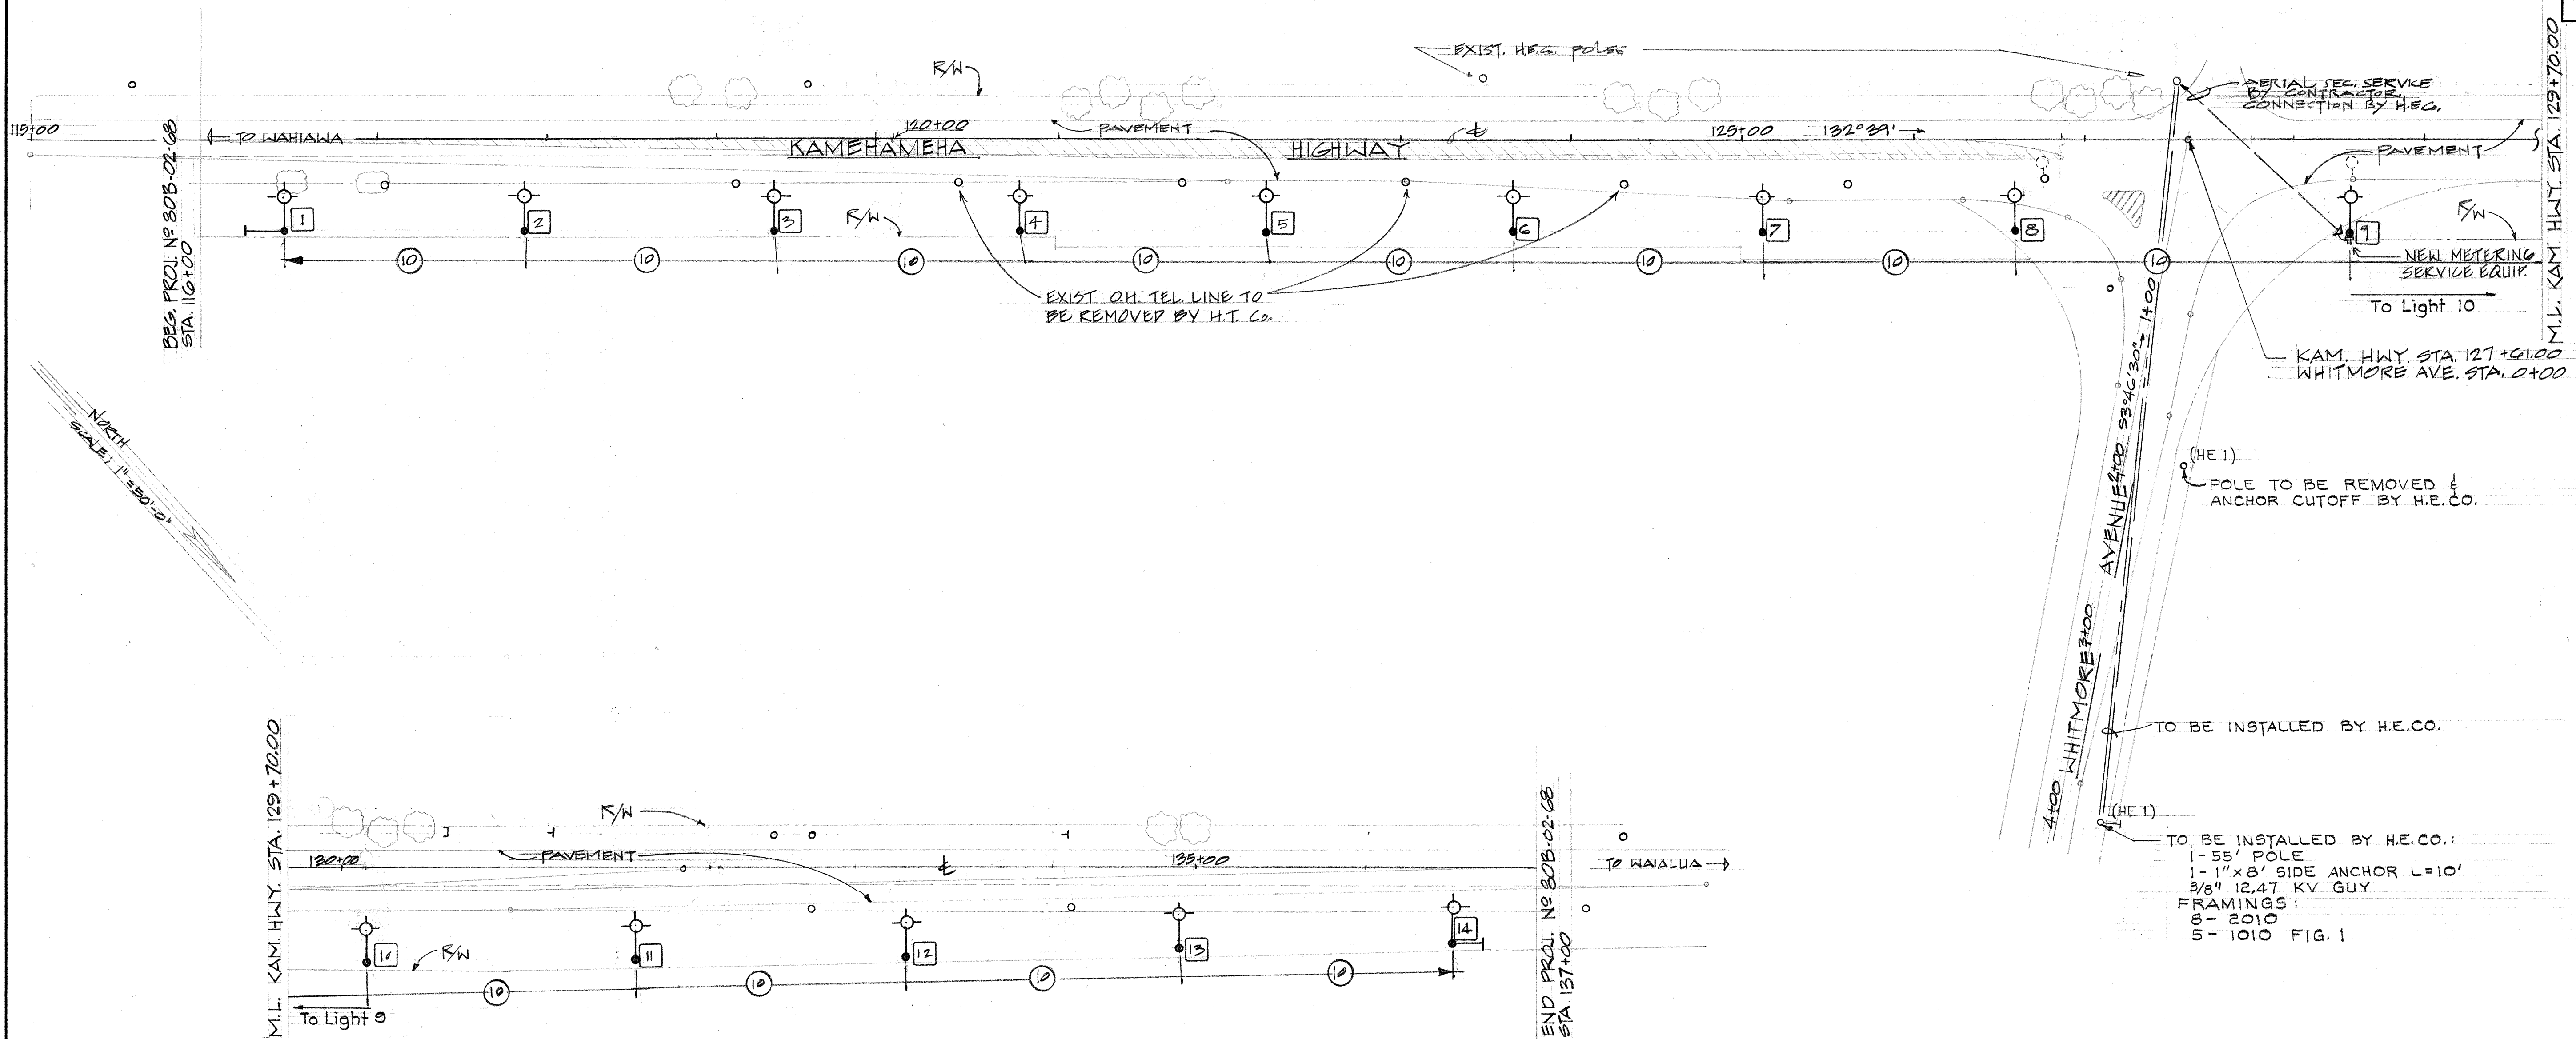

NOTE:

- EXISTING C&C LUMINAIRES SHALL BE REMOVED AND STOCKPILED AS DIRECTED BY THE ENGINEER.
- THE CONTRACTOR SHALL NOTIFY THE C&C STREET LIGHT DIVISION AT LEAST 2 WORKING DAYS BEFORE DOING ANY WORK ON THE CITY'S STREET LIGHT SYSTEM.

ELECTRICAL SYMBOLS	
	LUMINAIRE, TRUSS-TYPE 20' BRACKET (JOINT WOOD POLE BY H.T. Co.) — TYPES II, 400W MERCURY
	MESSENGER WITH 2#4 CU., POLYETHYLENE, 600 VOLTS CABLES
	ANCHOR & DOWN GUY ASSEMBLY
	DEADEND CONSTRUCTION
	POLE LUMINAIRE NUMBER

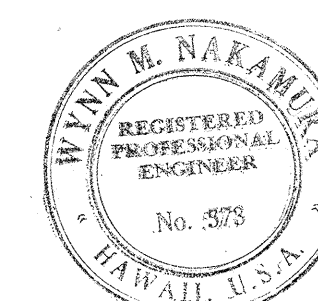

THIS WORK WAS PREPARED BY ME OR UNDER MY SUPERVISION.


Wynn Nakamura

STATE OF HAWAII
DEPARTMENT OF TRANSPORTATION
HIGHWAYS DIVISION
HIGHWAY LIGHTING SYSTEM
INTERSECTION IMPROVEMENT,
KAMEHAMEHA HIGHWAY
AT WHITMORE AVENUE
PROJECT NO. 808-02-68


Scale: As shown Date: May 22, 1968

SHEET No. 1 OF 2 SHEETS


FED. ROAD DIST. NO.	STATE	PROJ. NO.	FISCAL YEAR	SHEET NO.	TOTAL SHEETS
HAWAII	HAW.	80B-02-68	1968	15	15

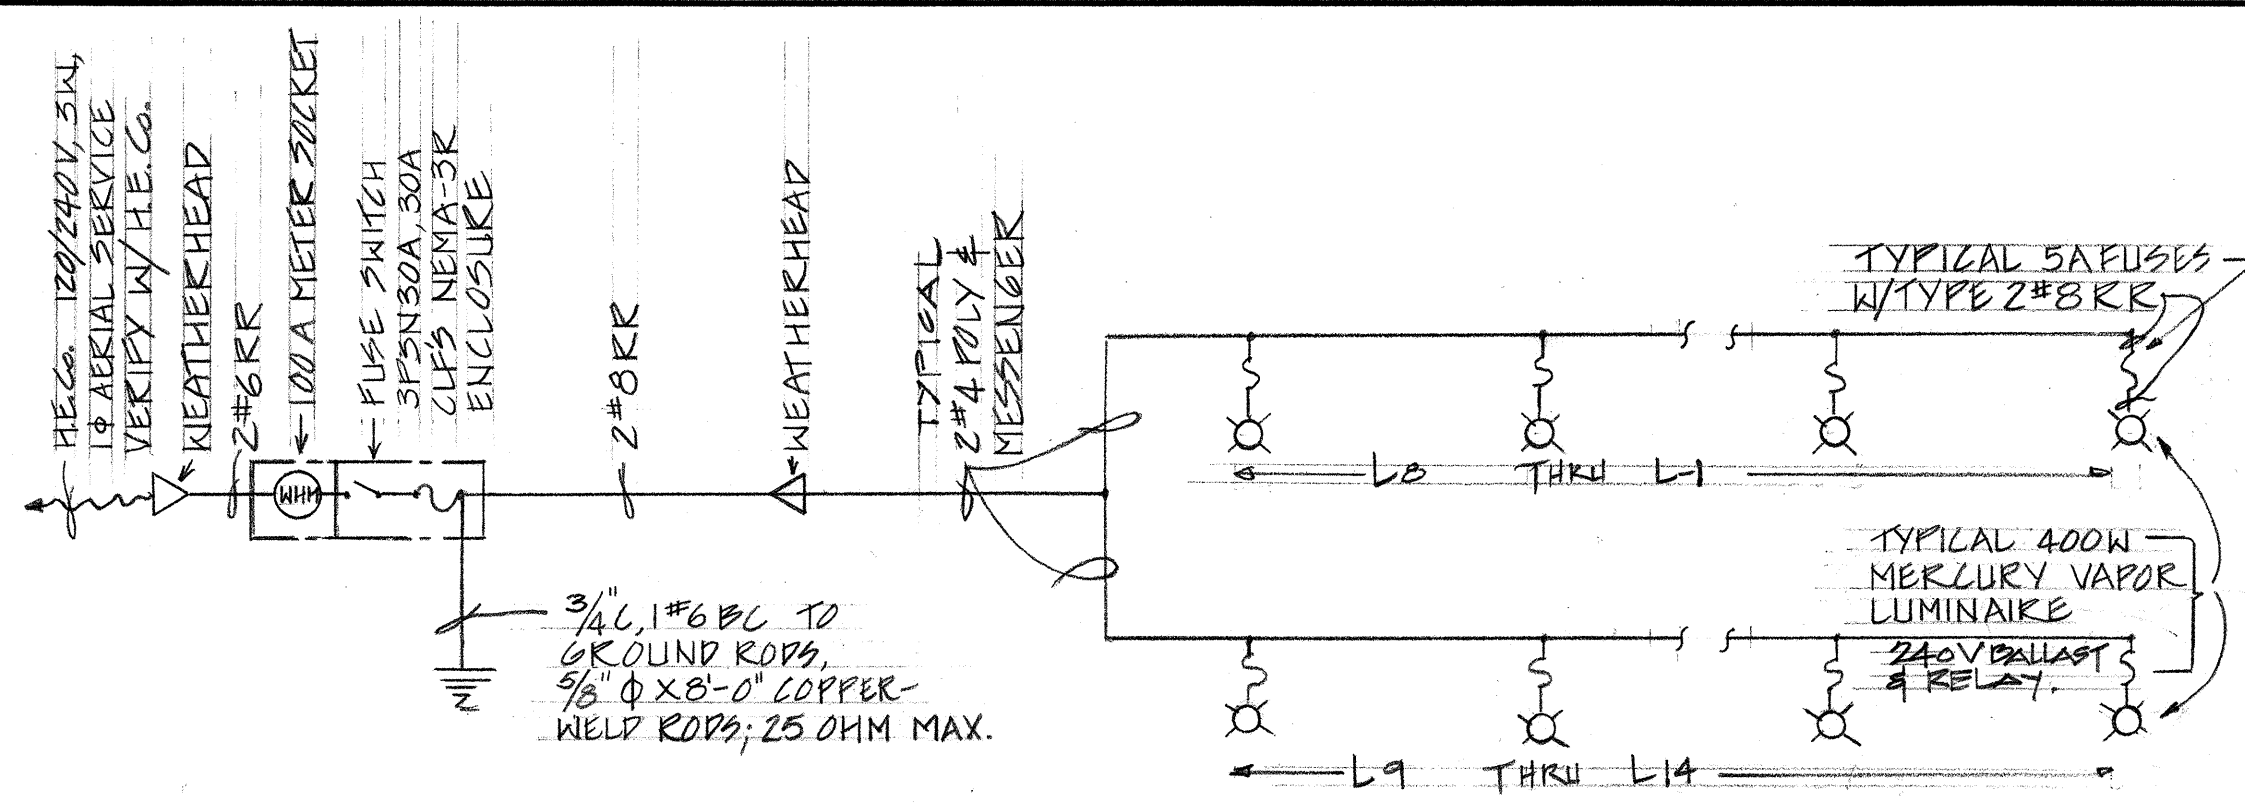

A
E-2 ONE-LINE DIAGRAM KAM HWY AT WHITMORE AVE.

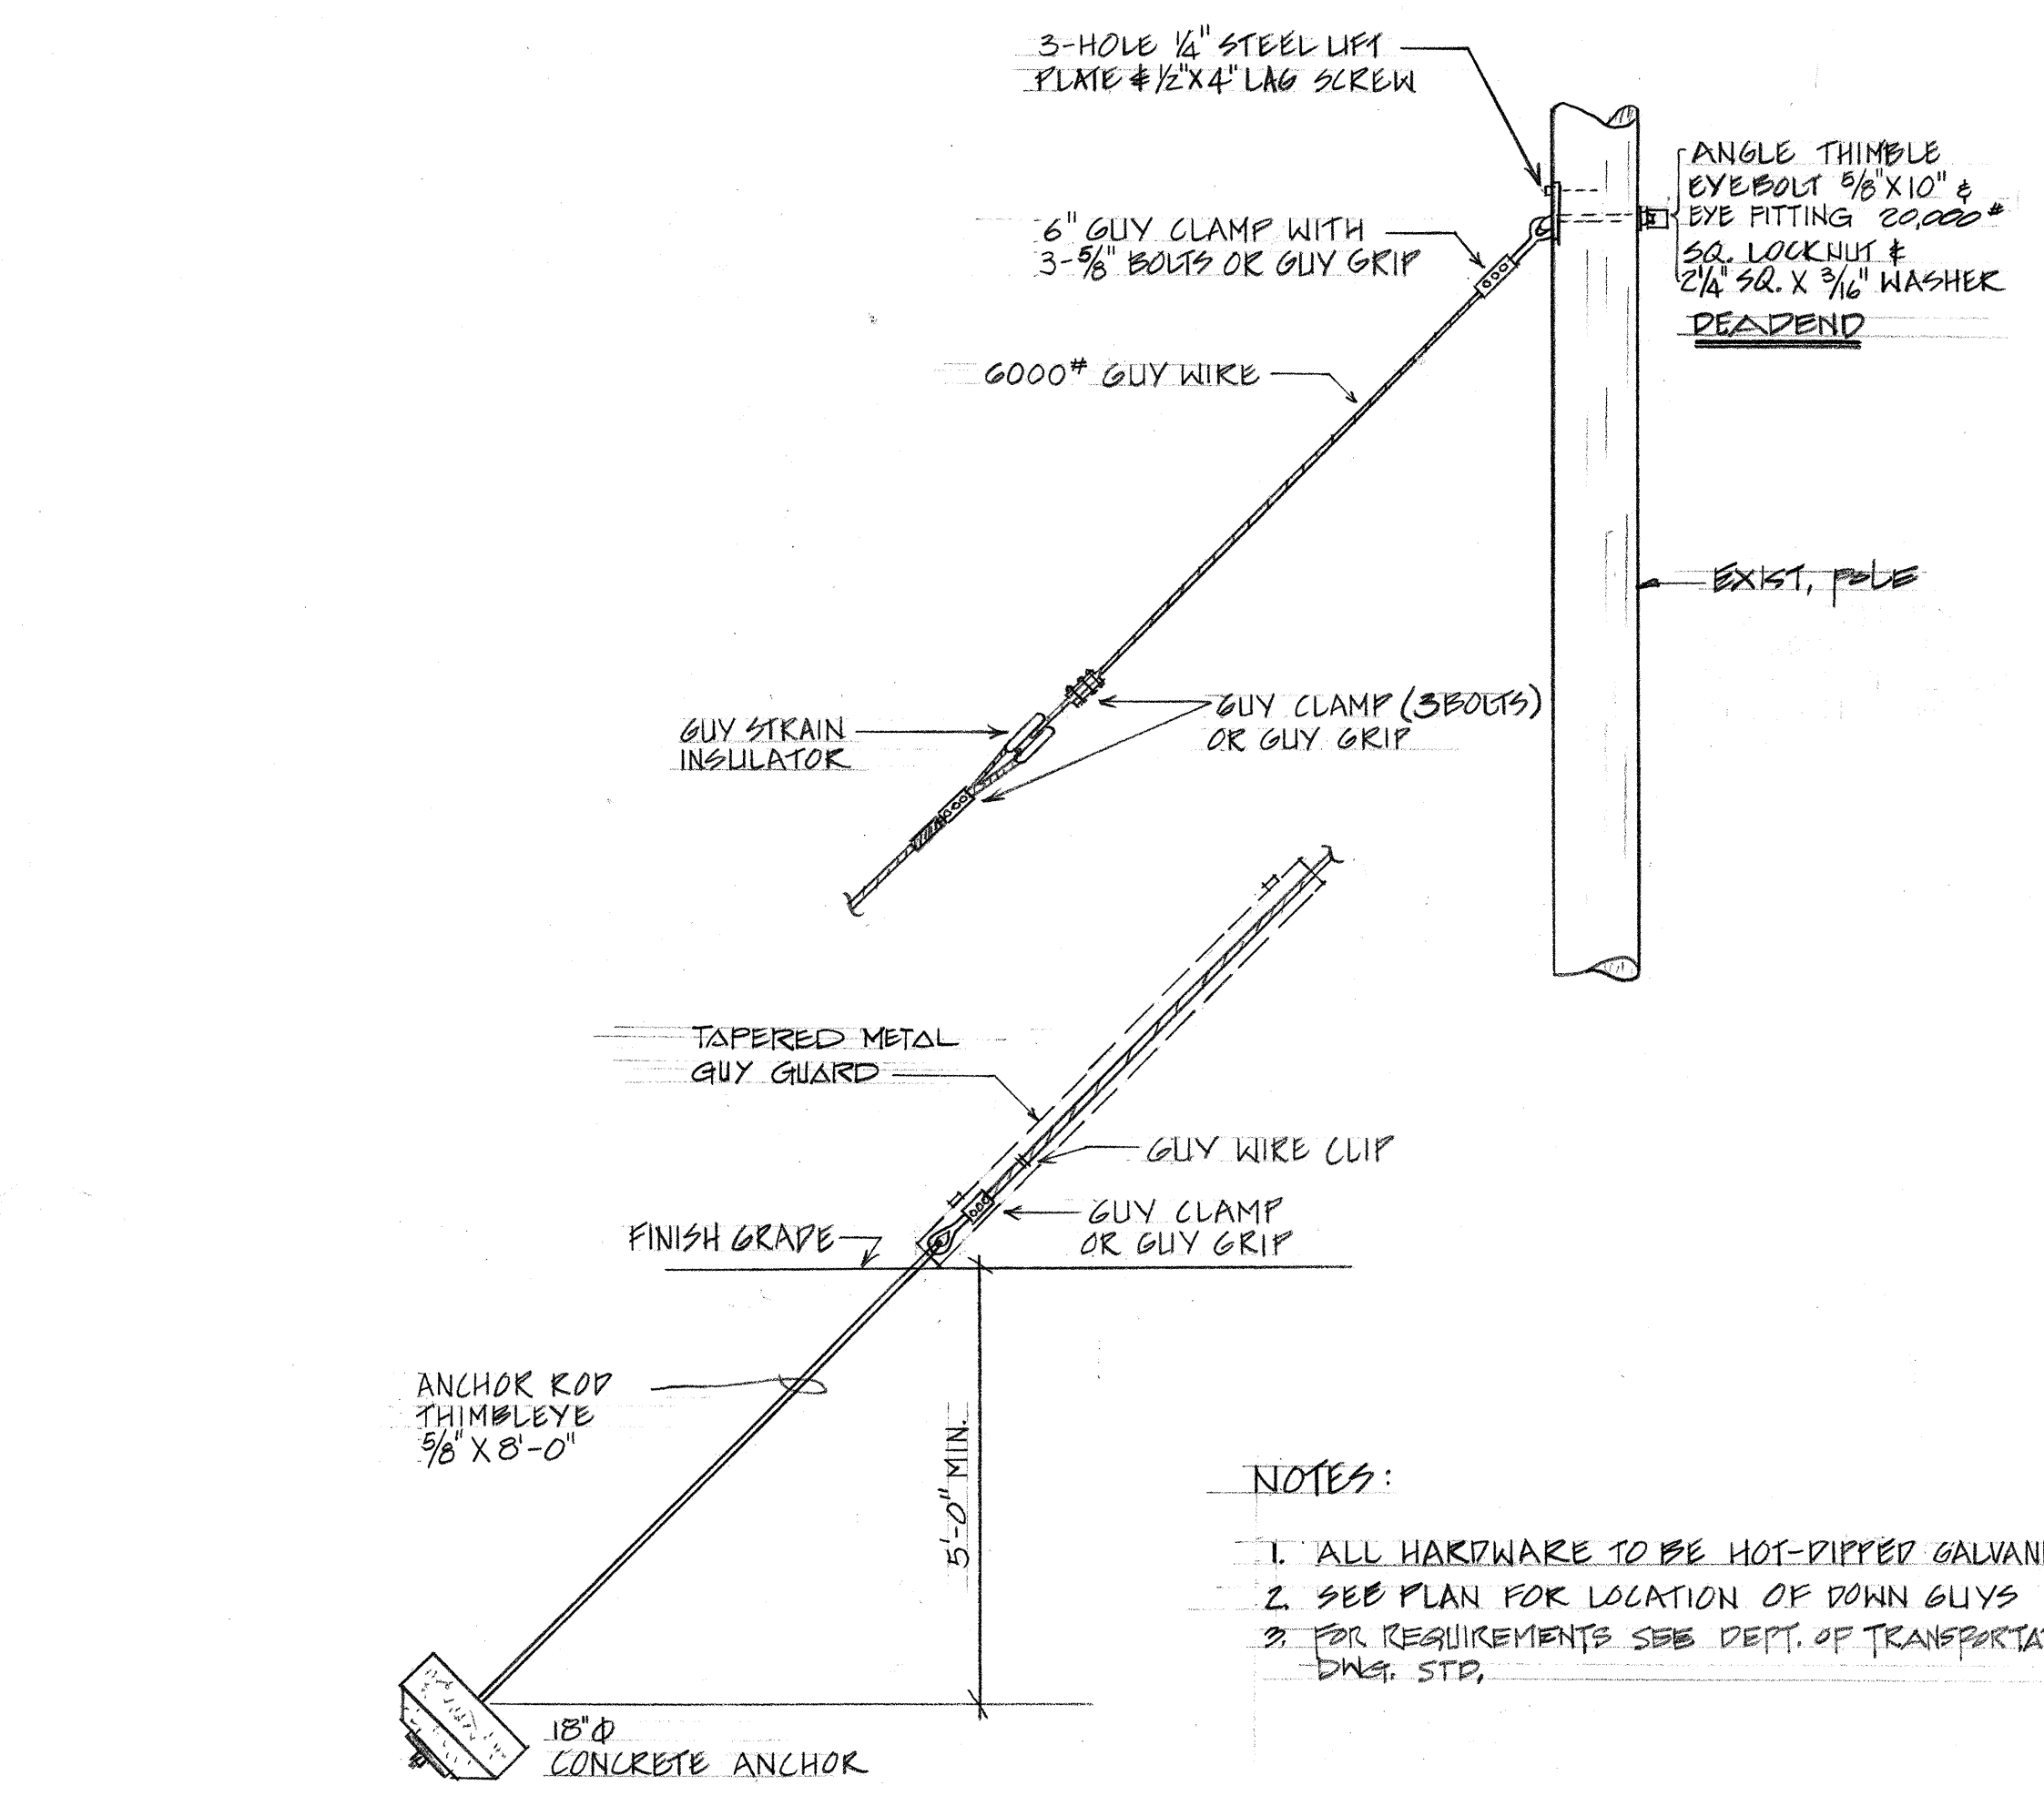


P
E-2 ANCHOR & DOWN GUY DETAILS

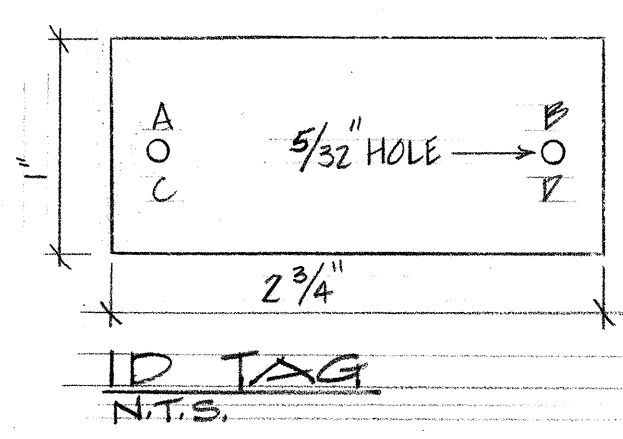


- LEGEND:
- A = CONTRACT NUMBER
 - B = LIGHT NUMBER (NOTE: FOR NUMBER SEE PLAN)
 - C = LAMP DATA: # 400W
 - D = REFRACTOR DATA: TYPE NO III

- NOTES:
1. TAG-MAKE FROM PLASTIC SHEET (GRAVOFLEX/3 PLY) LAMINATED BLACK-WHITE-BLACK
 2. MOUNTING HEIGHT OF TAG = 6'-0" FROM FINISH GRADE
 3. LETTERS - No. 5 REDUCTION, 1/8", STENCILLED
 4. ATTACH TO WOOD POLE WITH NO. 7 4d NAILS


C
E-2 IDENTIFICATION TAG DETAIL

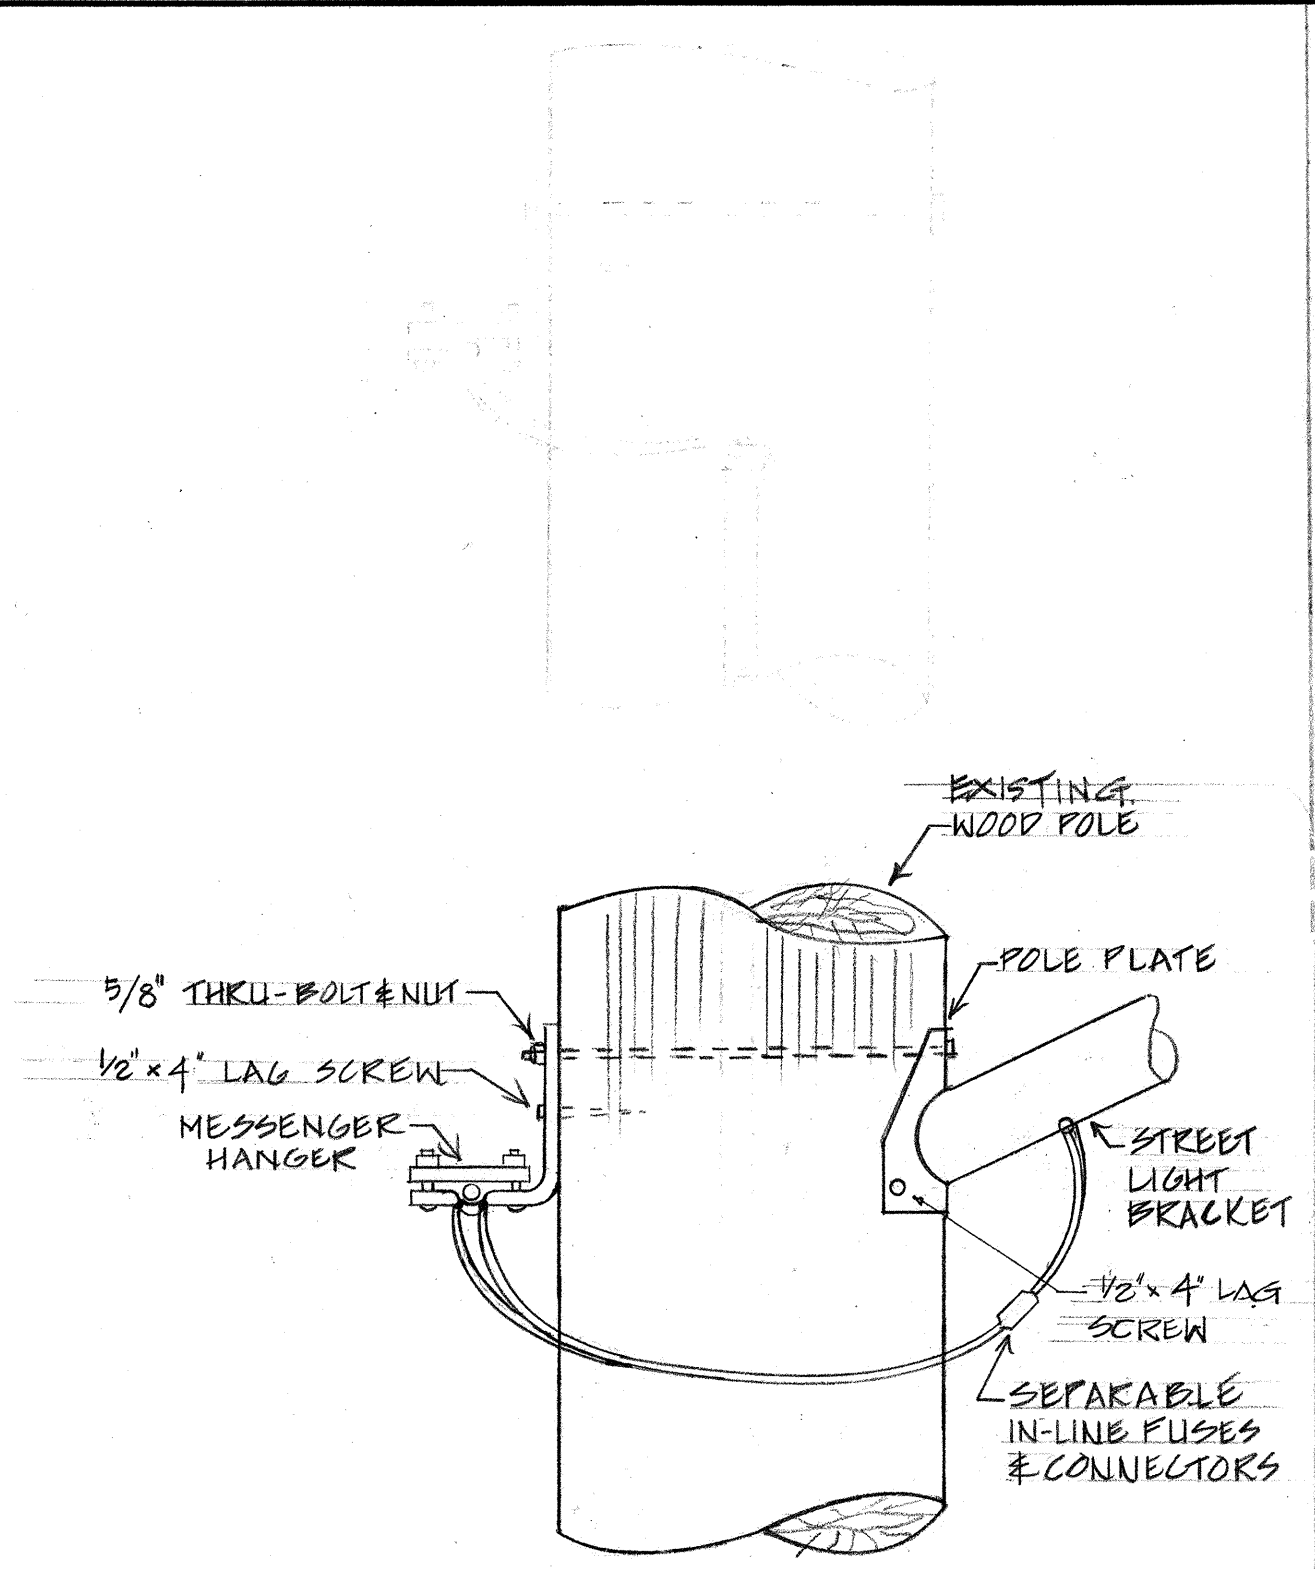


DETAIL AT HANGER

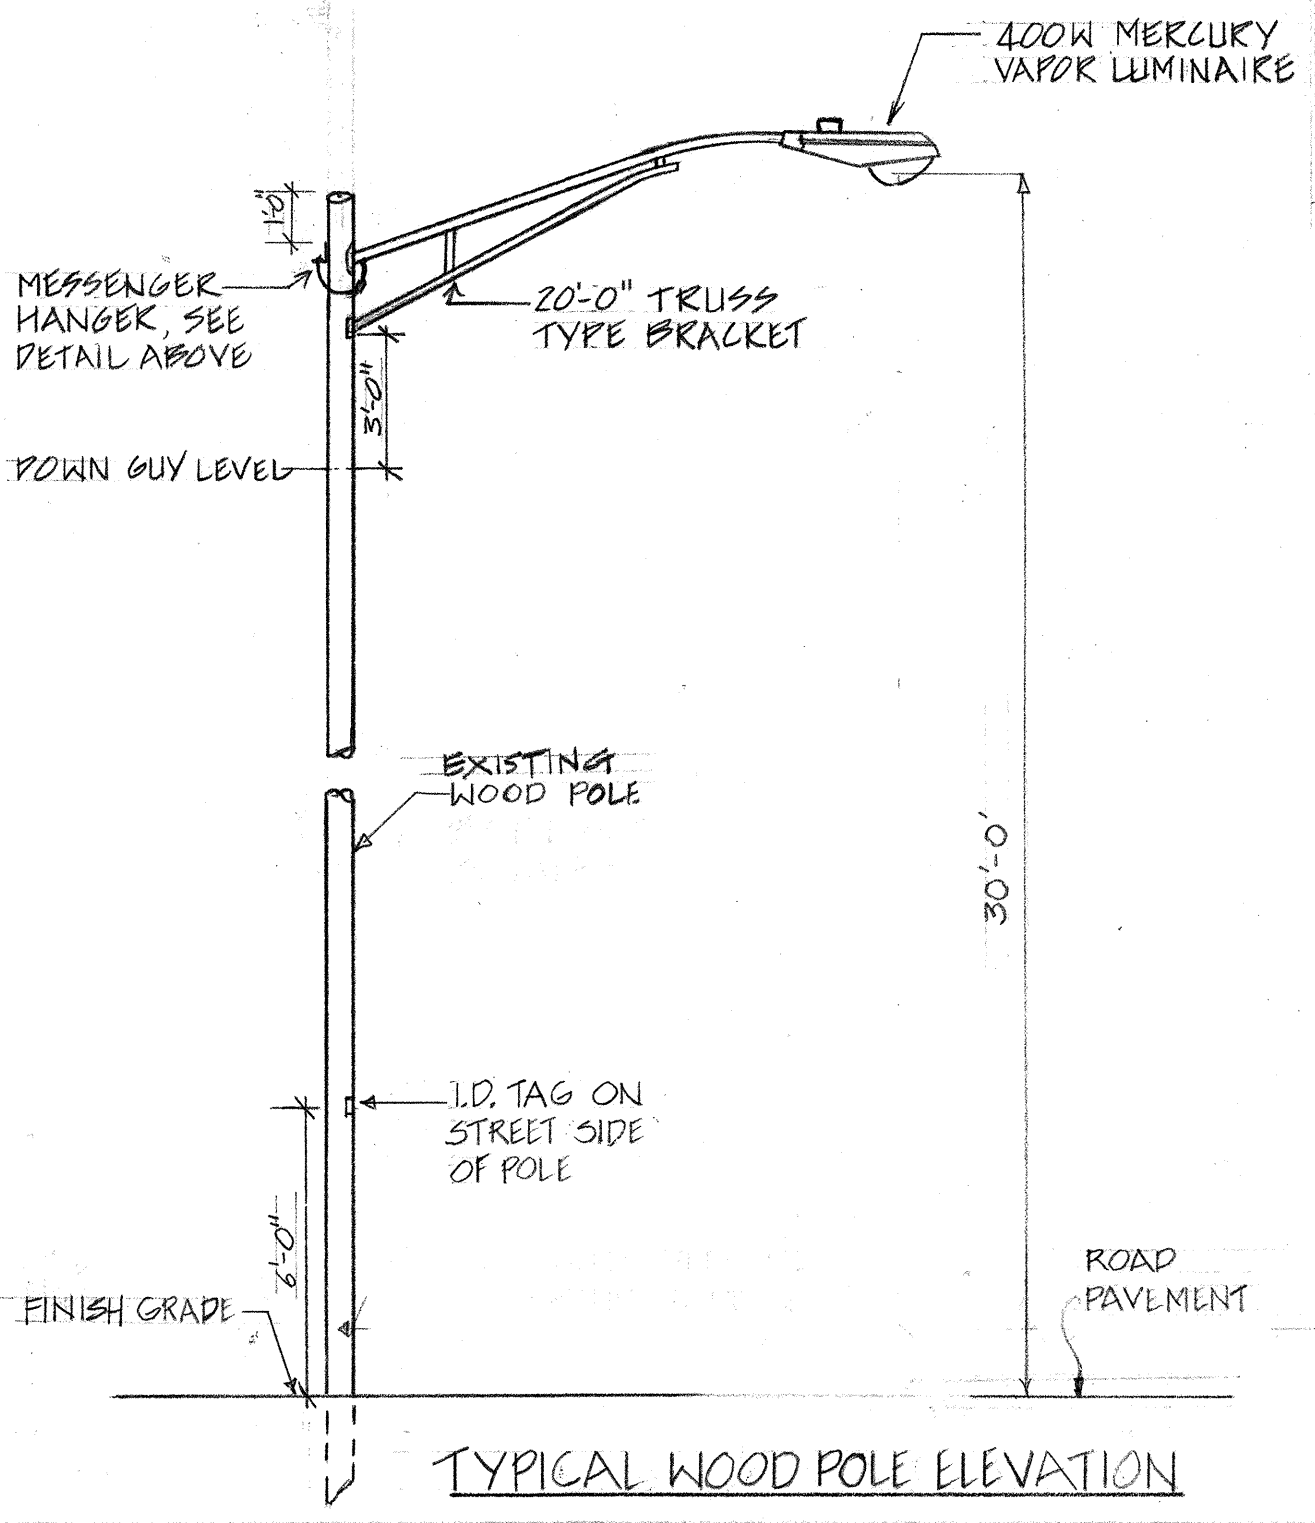

D
E-2 STREET LIGHT DETAILS

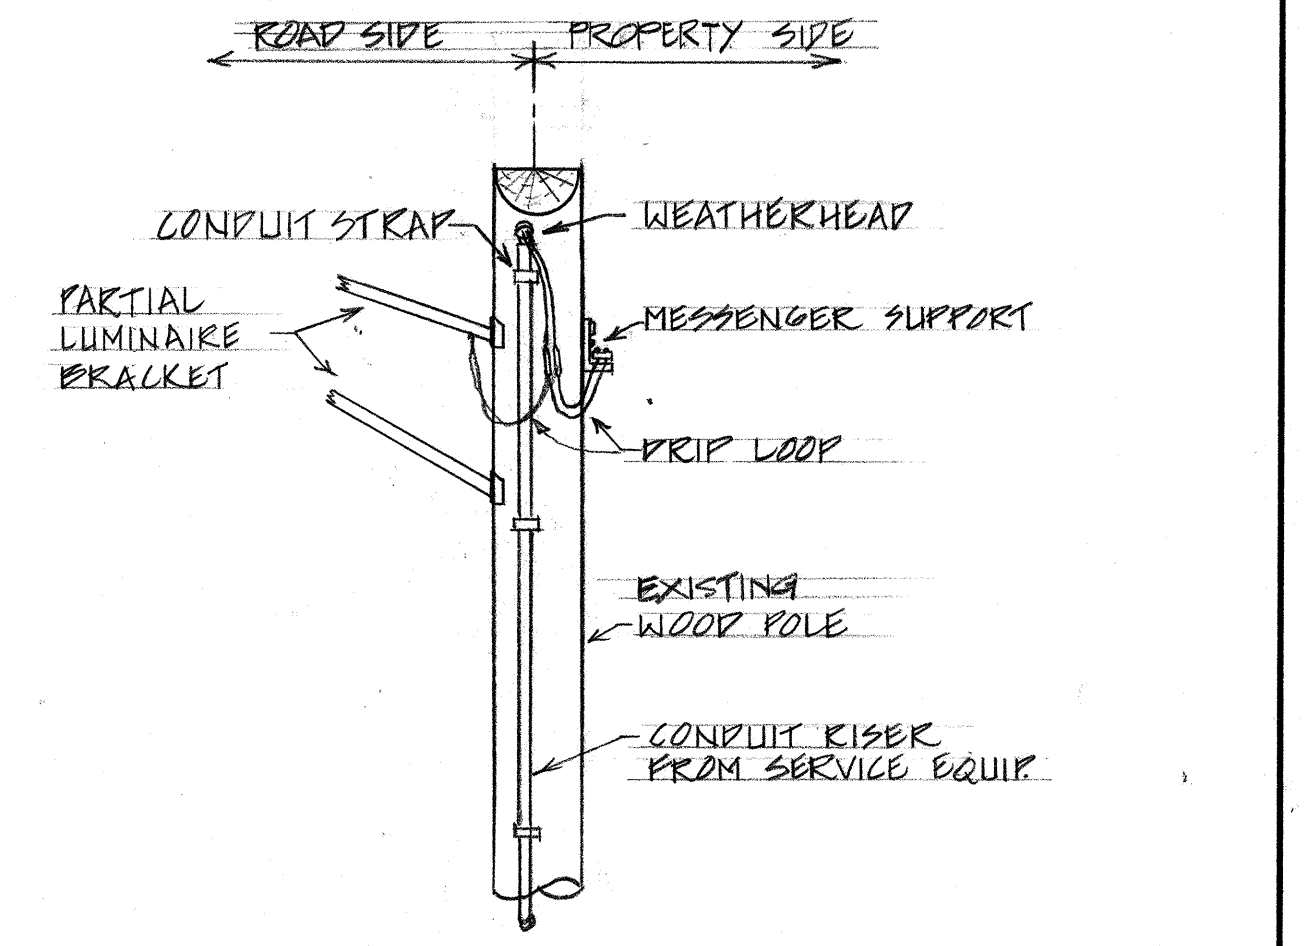


ELEVATION AT WEATHERHEAD

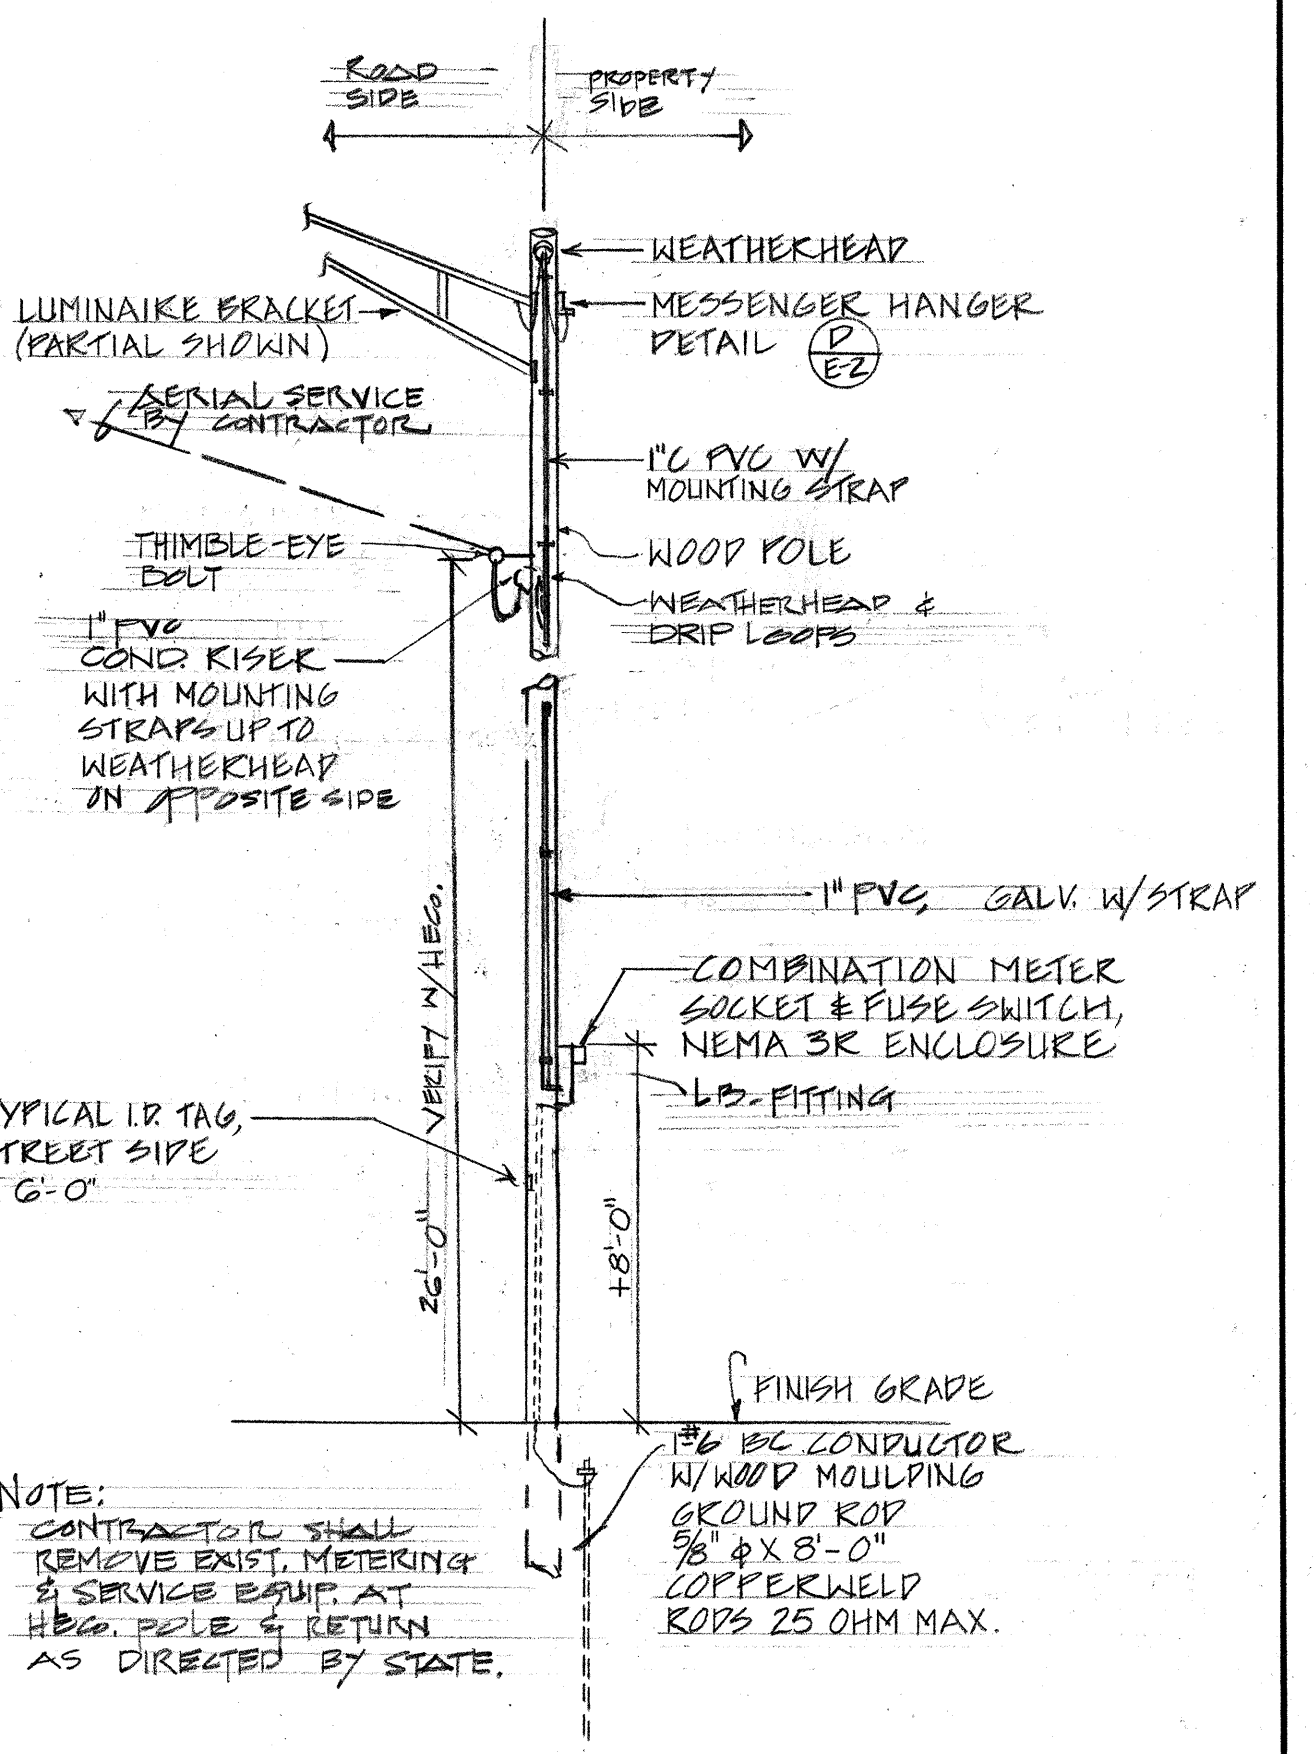

F
E-2 METERING POLE DETAILS

SURVEY PLOTTED BY	DATE
DRAWN BY	
DESIGNED BY	
QUANTITIES BY	
CHECKED BY	
ORIGINAL PLAN	
NOTE BOOK	
No.	

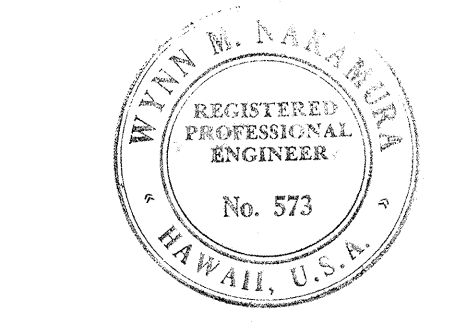

THIS WORK WAS PREPARED BY ME OR UNDER MY SUPERVISION.
Wynn Nakanuma

STATE OF HAWAII
DEPARTMENT OF TRANSPORTATION
HIGHWAYS DIVISION

HIGHWAY LIGHTING SYSTEM
INTERSECTION IMPROVEMENT
KAMEHAMEHA HIGHWAY
AT WHITMORE AVENUE
PROJECT NO. 80B-02-68

Scale: As shown Date: May 22, 1968

SHEET No. 2 OF 2 SHEETS