


FED. ROAD DIST. NO.	STATE	PROJ. NO.	FISCAL YEAR	SHEET NO.	TOTAL SHEETS
HAWAII	HAW.	80B-01-87	1988	2	3

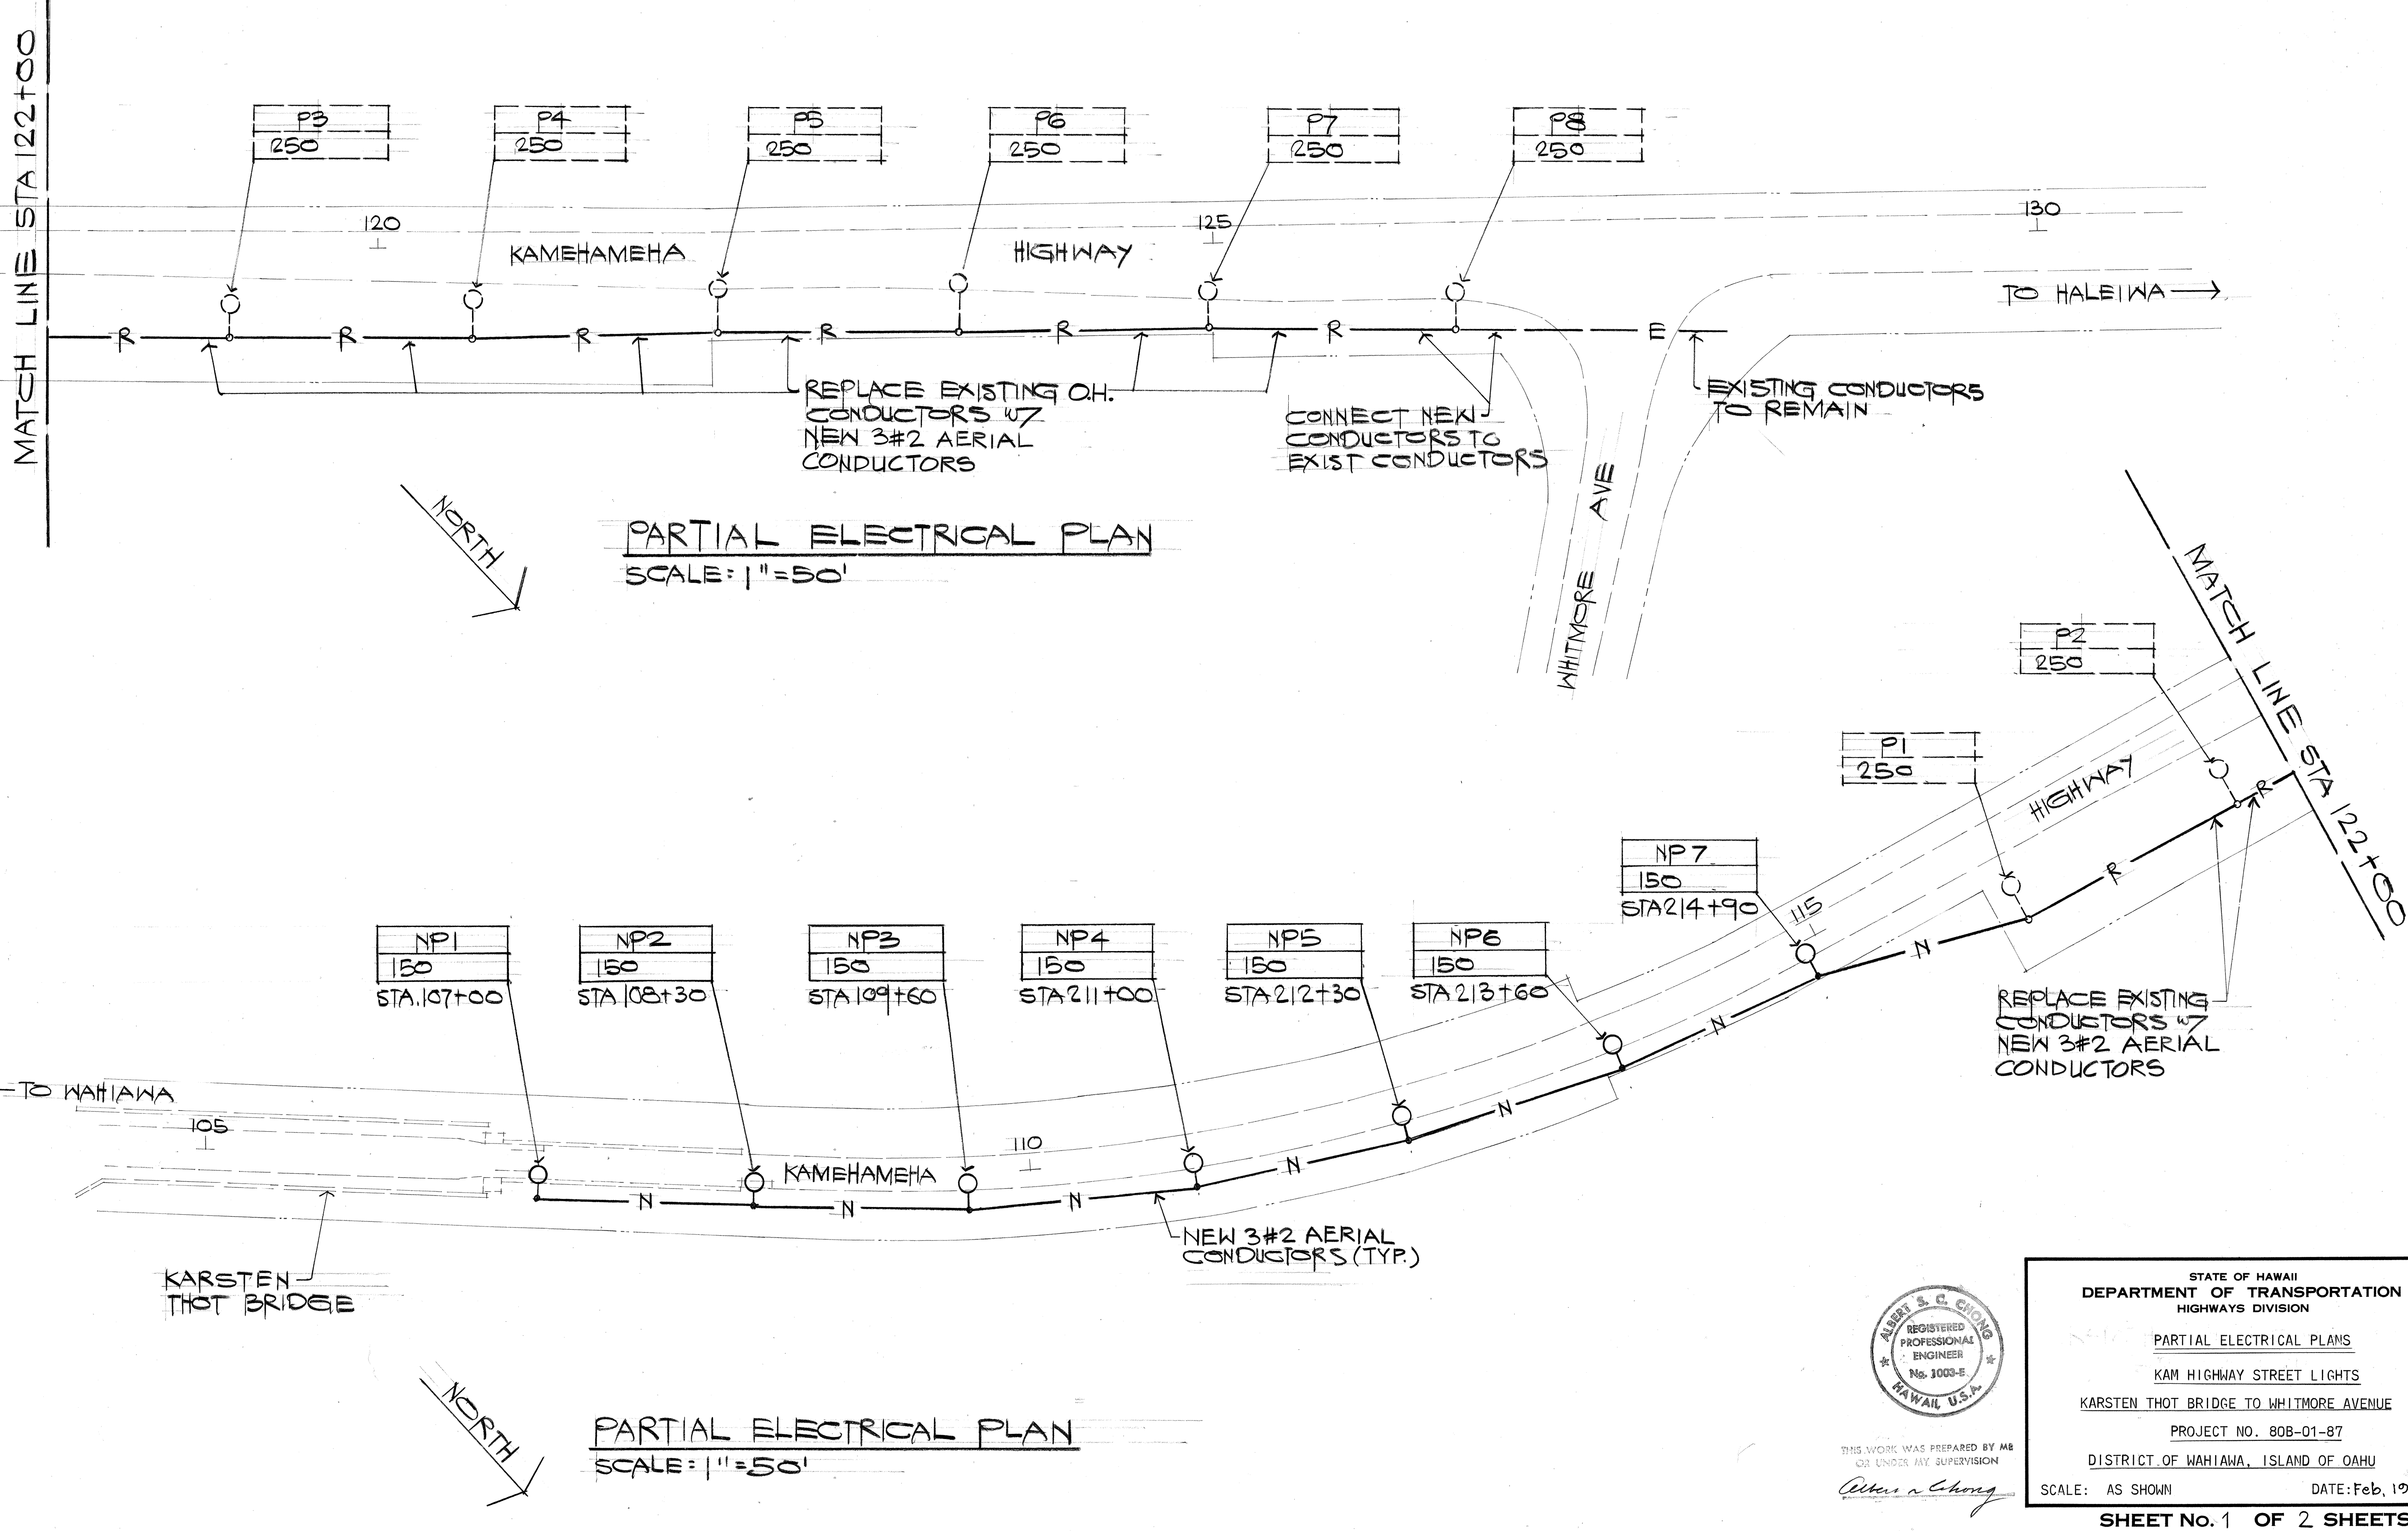

SURVEY PLOTTED BY	DATE
DRAWN BY	
DESIGNED BY	
QUANTITIES BY	
CHECKED BY	
ORIGINAL PLAN	No.

THIS WORK WAS PREPARED BY ME  
OR UNDER MY SUPERVISION

*Albert S. C. Chong*

STATE OF HAWAII  
DEPARTMENT OF TRANSPORTATION  
HIGHWAYS DIVISION

PARTIAL ELECTRICAL PLANS

KAM HIGHWAY STREET LIGHTS

KARSTEN HOT BRIDGE TO WHITMORE AVENUE

PROJECT NO. 80B-01-87

DISTRICT OF WAHIAWA, ISLAND OF OAHU

SCALE: AS SHOWN      DATE: Feb. 1988

SHEET No. 1 OF 2 SHEETS

DD-B-7-4