



FED. ROAD DIST. NO.	STATE	PROJ. NO.	FISCAL YEAR	SHEET NO.	TOTAL SHEETS
HAWAII	HAW.	83D-03-71	1972	2	3

SYMBOL LIST

- NEW MULTIPLE 400 WATT MERCURY VAPOR STREET LIGHT LUMINAIRES, CROSS ARM BRACKET MOUNTED
- EXISTING LUMINAIRES TO BE REMOVED
- EXISTING SERIES INCANDESCENT STREET LIGHT LUMINAIRES, CROSS ARM MOUNTED, TO REMAIN
- NEW MULTIPLE 400 WATT MERCURY VAPOR STREET LT. LUMINAIRES POLE BRACKET MOUNTED
- EXISTING SERIES REGULATOR CIRCUIT ON CROSS ARMS TO REMAIN
- EXISTING SERIES ISOLATING TRANSFORMER STREET LIGHT CIRCUIT ON CROSS ARMS TO REMAIN
- * SERIES ISOLATING TRANSFORMER ST. LT. CIRCUIT TO BE REMOVED
- △ EXISTING SERIES ISOLATING TRANSFORMERS
- NEW SECONDARY, AERIAL LINES (BY H.E.CO.)

NOTES:

- SEE NOTES ON SHEET 3
- REMOVED EXISTING SERIES LIGHT SIX (6) EA. BY C.C.O. #1 P-83, 87, 98, 99, 101 & 128.
- REMOVED EXISTING TWO-WIRE O.H. SERIES CIRCUIT FROM P-80 TO P-87 BY C.C.O. #1.

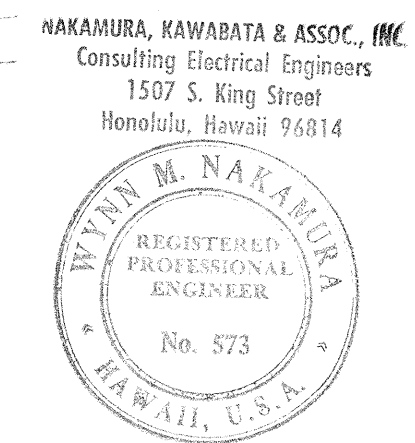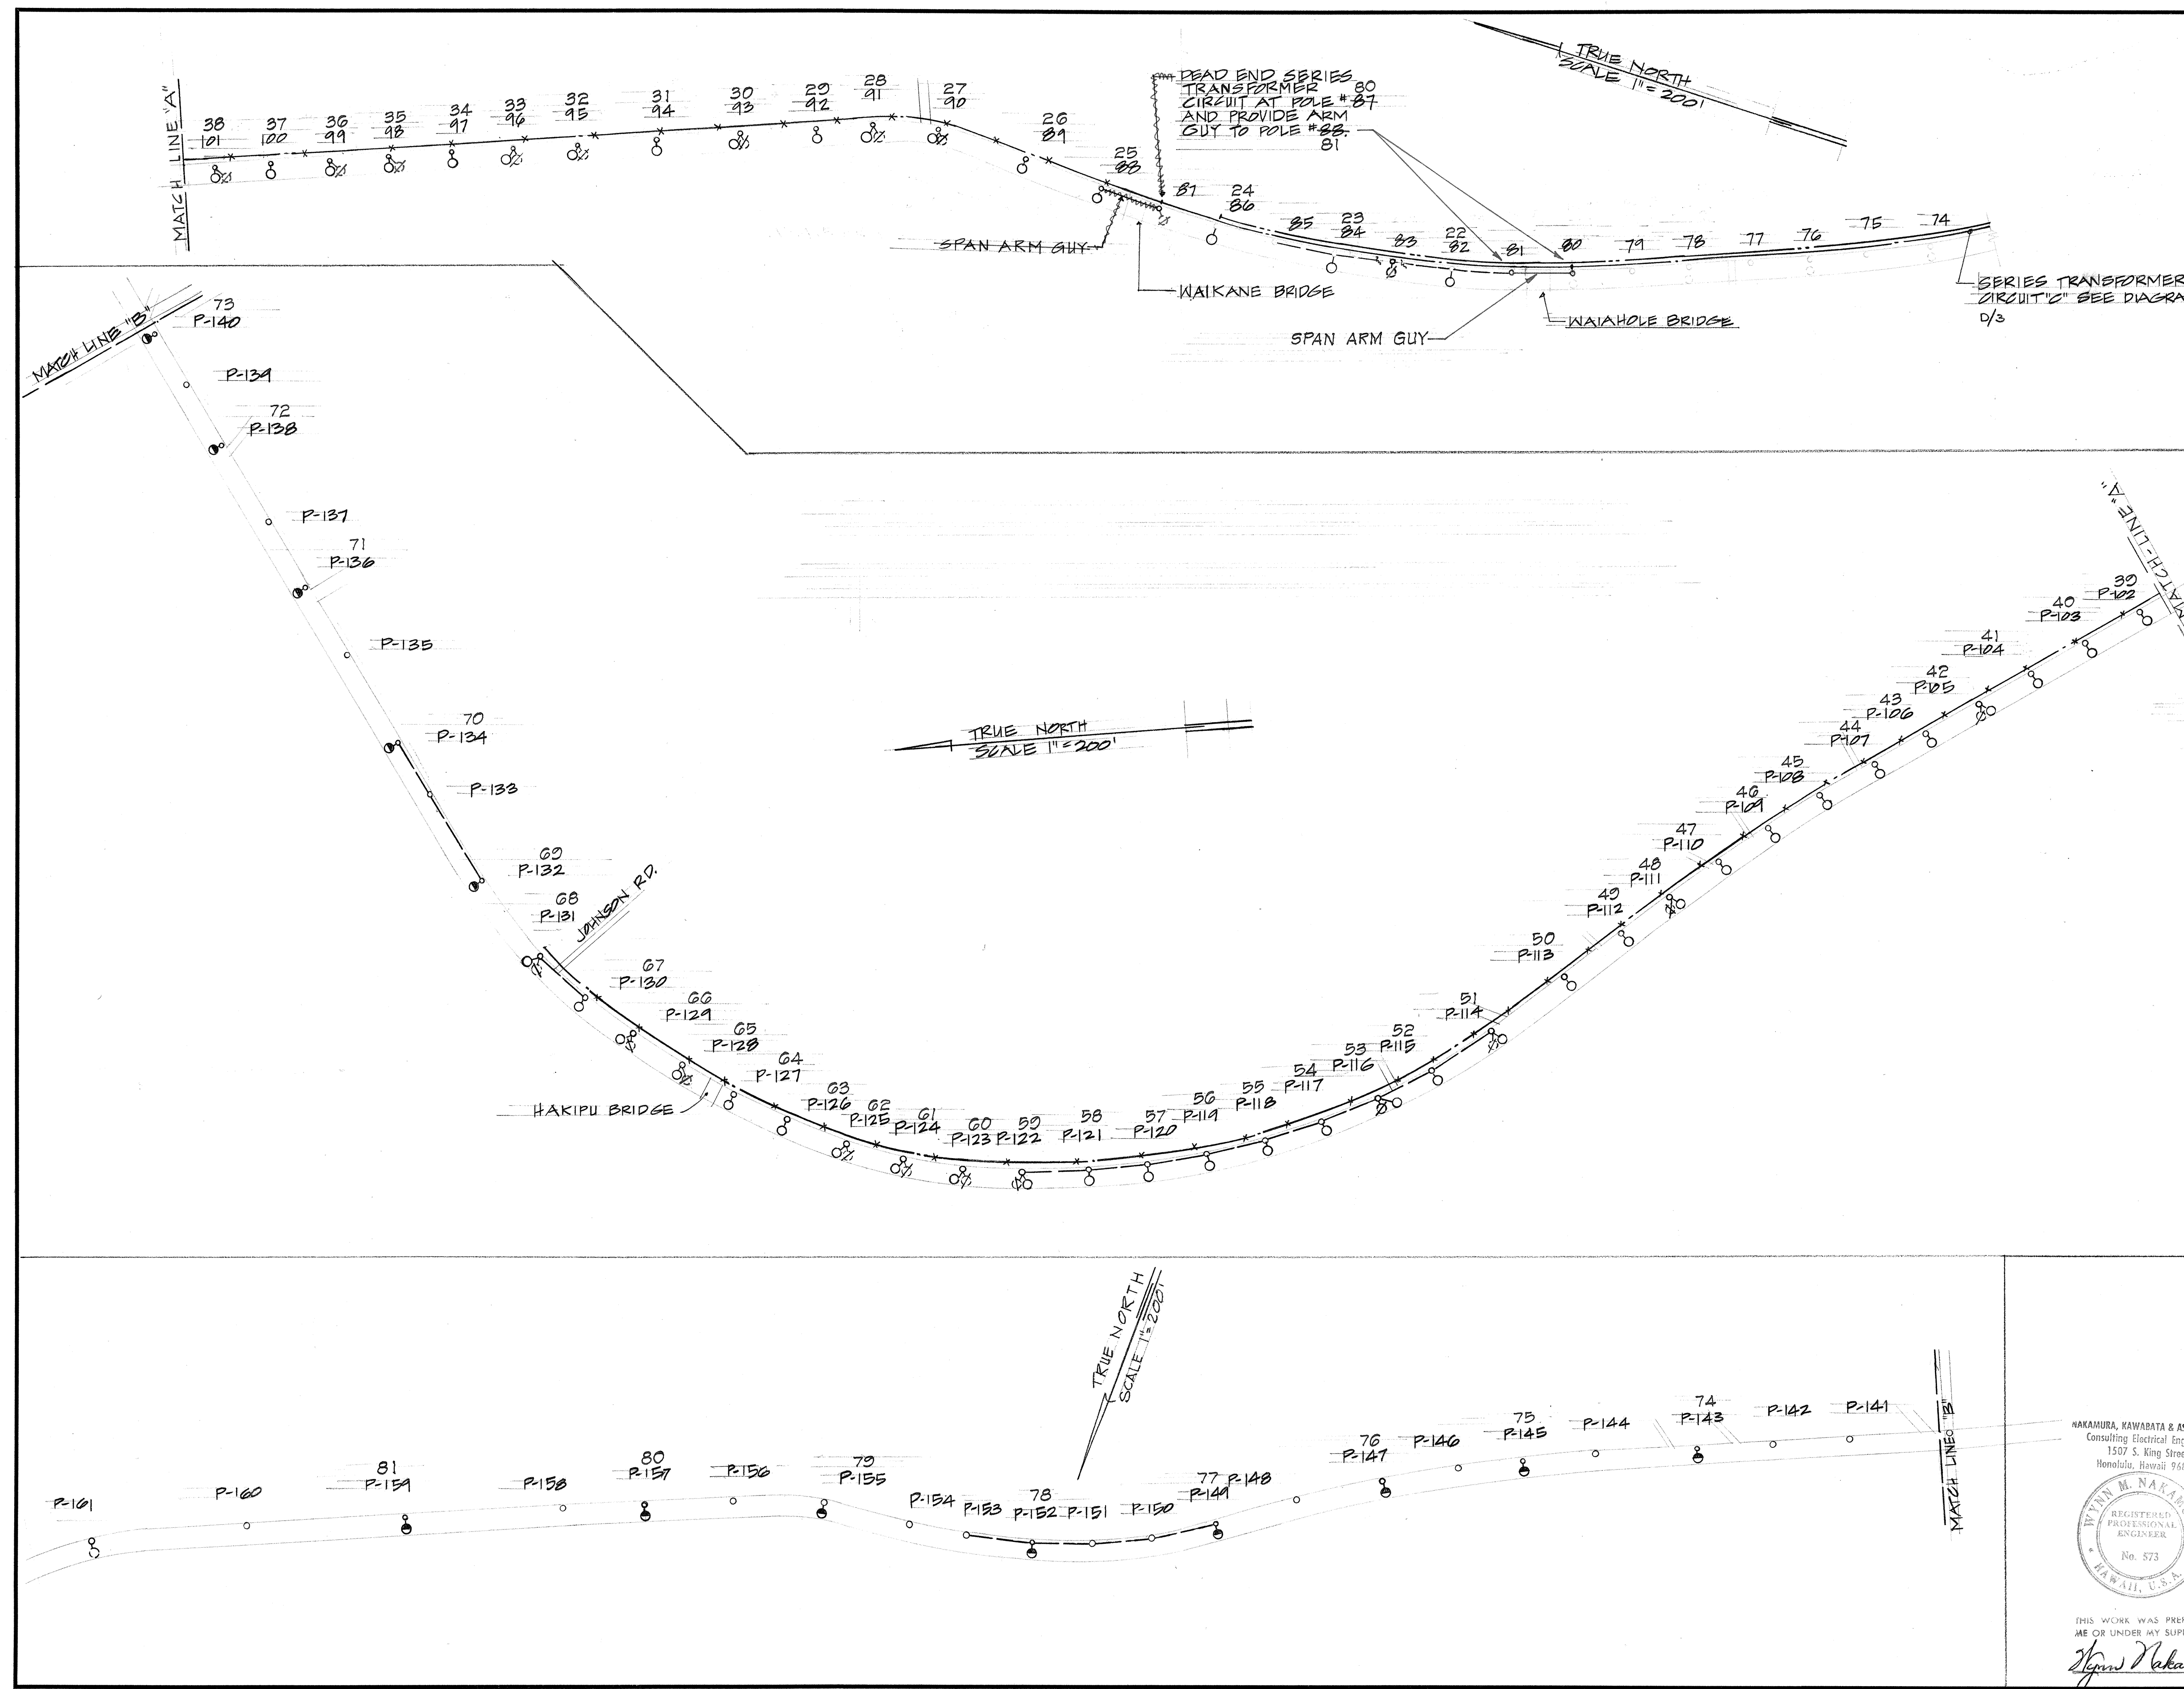

THIS WORK WAS PREPARED BY ME OR UNDER MY SUPERVISION.
Wynn Nakamura

STATE OF HAWAII
DEPARTMENT OF TRANSPORTATION
HIGHWAYS DIVISION

ROADWAY LIGHTING PLAN FOR
KAMEHAMEHA HIGHWAY, STREET LIGHTS BETWEEN
WAIKANE AND KUALOA POINT
PROJECT NO. 83D-03-71

SCALE: 1" = 200' DATE: FEB. 1972

SHEET NO. 1 OF 2 SHEETS

NAKAMURA, KAWABATA & ASSOC., INC.
Consulting Electrical Engineers
1507 S. King Street
Honolulu, Hawaii 96814

SURVEY PLANNED BY	DATE
DRAWN BY	
CHECKED BY	
QUANTITIES BY	
NOTES BY	
CHECKED BY	