


INDEX TO DRAWINGS	
SHEET NO.	DESCRIPTION
1	TITLE SHEET
2	STANDARD PLAN SUMMARY
3-5	GENERAL NOTES, LEGEND AND ABBREVIATIONS
6-11	UTILITY NOTES
12-15	WATER POLLUTION AND EROSION CONTROL NOTES AND DETAILS
16	EROSION AND SEDIMENT CONTROL PLAN
17-22	BORING LOCATION PLAN, LEGEND, AND BORING LOGS
23	DEMOLITION PLAN
24	TEMPORARY FENCING PLAN
25-28	TYPICAL SECTIONS
29	SURVEY CONTROL PLAN
30-33	ALIGNMENT PLANS
34-35	ROADWAY PLAN AND PROFILE
36	SUPERELEVATION DIAGRAM
37-40	ROADWAY CONSTRUCTION PLANS
41	ELEVATION WINGWALL NO. 1, 2, 3 & 4
42	PLAN AND PROFILE FH LATERAL A,B & C
43	PLAN AND PROFILE TEMPORARY 12" WATERLINE
44-49	GRADING NOTES, GRADING AND DRAINAGE PLANS AND PROFILES
50	DUMPED RIPRAP PLAN AND DETAILS
51-55	MISCELLANEOUS DETAILS
56-58	MISCELLANEOUS DETAILS
59-62	SPOT ELEVATION PLANS
63-65	GUARDRAIL DETAILS
66	PAVEMENT MARKINGS NOTES AND LEGEND
67-73	SIGNING AND PAVEMENT MARKINGS PLANS & DETAILS
74	CONSTRUCTION PHASING PLAN
73-88	TRAFFIC CONTROL NOTES AND PLANS
89-111	ELECTRICAL PLANS
112-191	STRUCTURAL PLANS
192-201	LANDSCAPING PLANS
202-231	CROSS SECTIONS


FED. ROAD DIST. NO.	STATE	PROJ. NO.	FISCAL YEAR	SHEET NO.	TOTAL SHEETS
HAWAII	HAW.	83B-01-09	2023	1	231

STATE OF HAWAII
DEPARTMENT OF TRANSPORTATION
HIGHWAYS DIVISION
HONOLULU, HAWAII

PLANS FOR
KAMEHAMEHA HIGHWAY DRAINAGE
AND SAFETY IMPROVEMENTS
VICINITY OF LANIAKEA BEACH (MP 3.06 TO MP 3.54)
PROJECT NO. 83B-01-09
DISTRICT OF WAIALUA
ISLAND OF OAHU

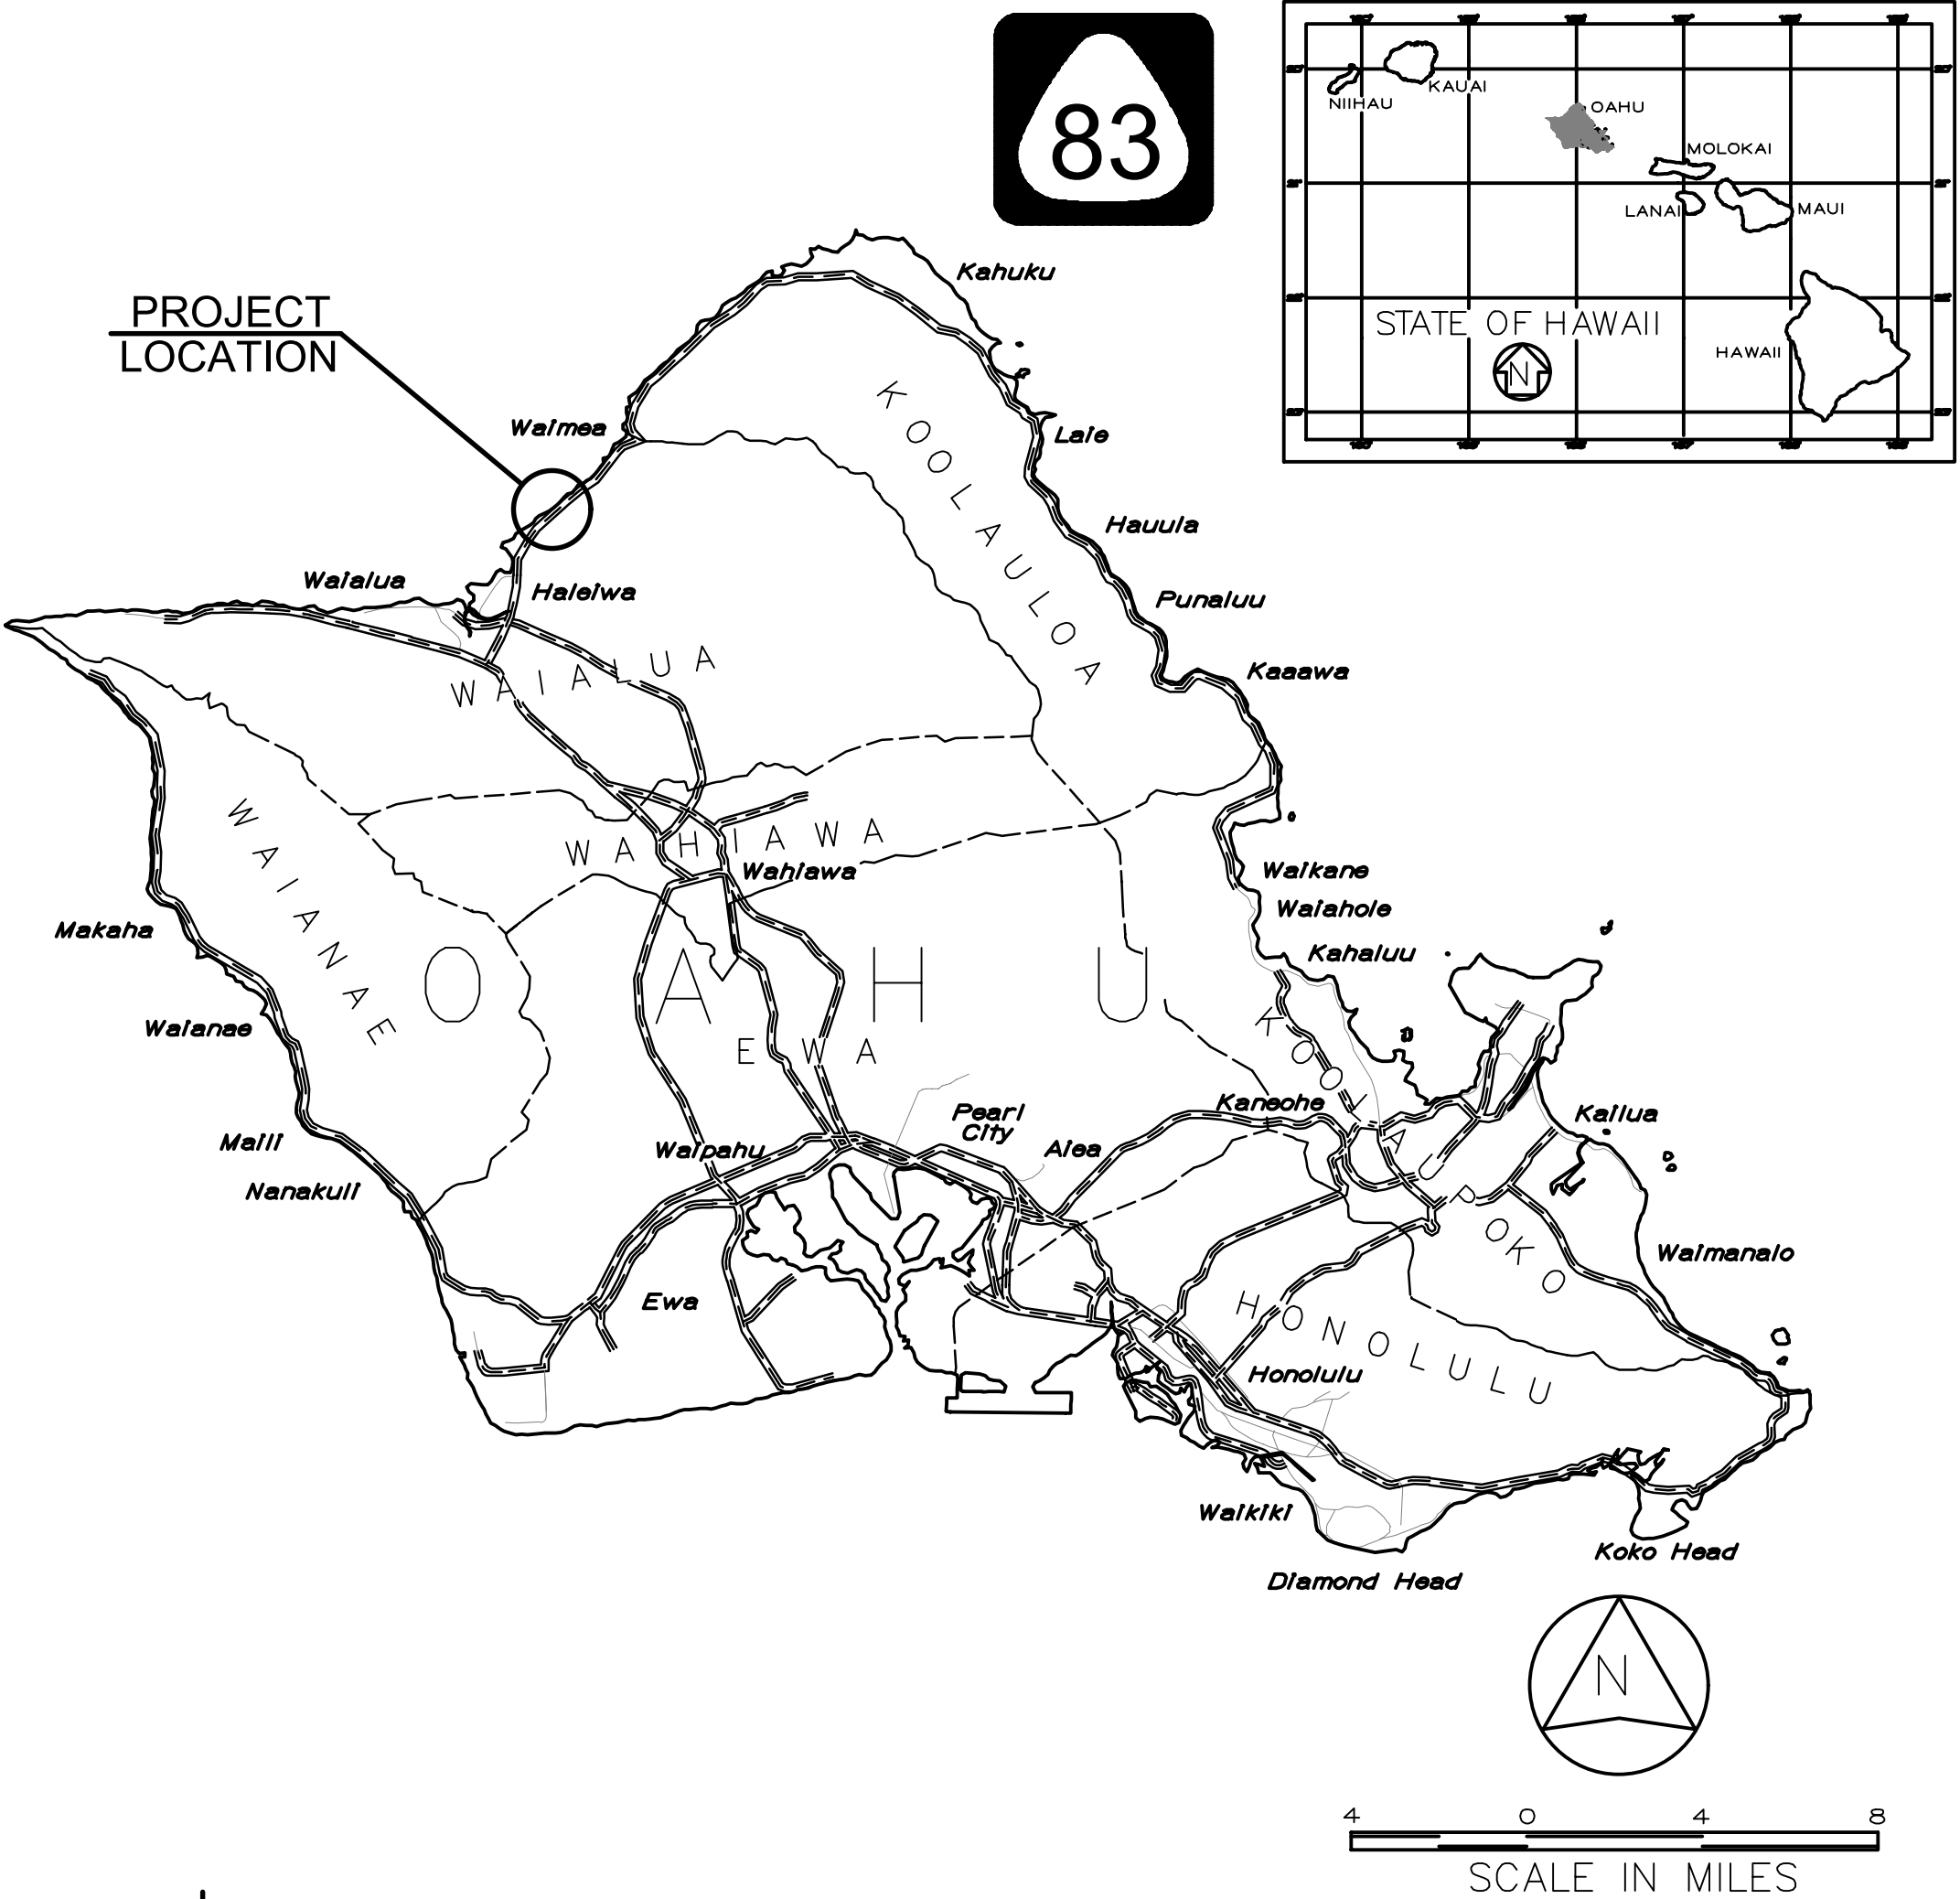

WSP USA DESIGNED BY
HWY-DD MANAGED BY
692-7578 PHONE
DEC 2022 DATE

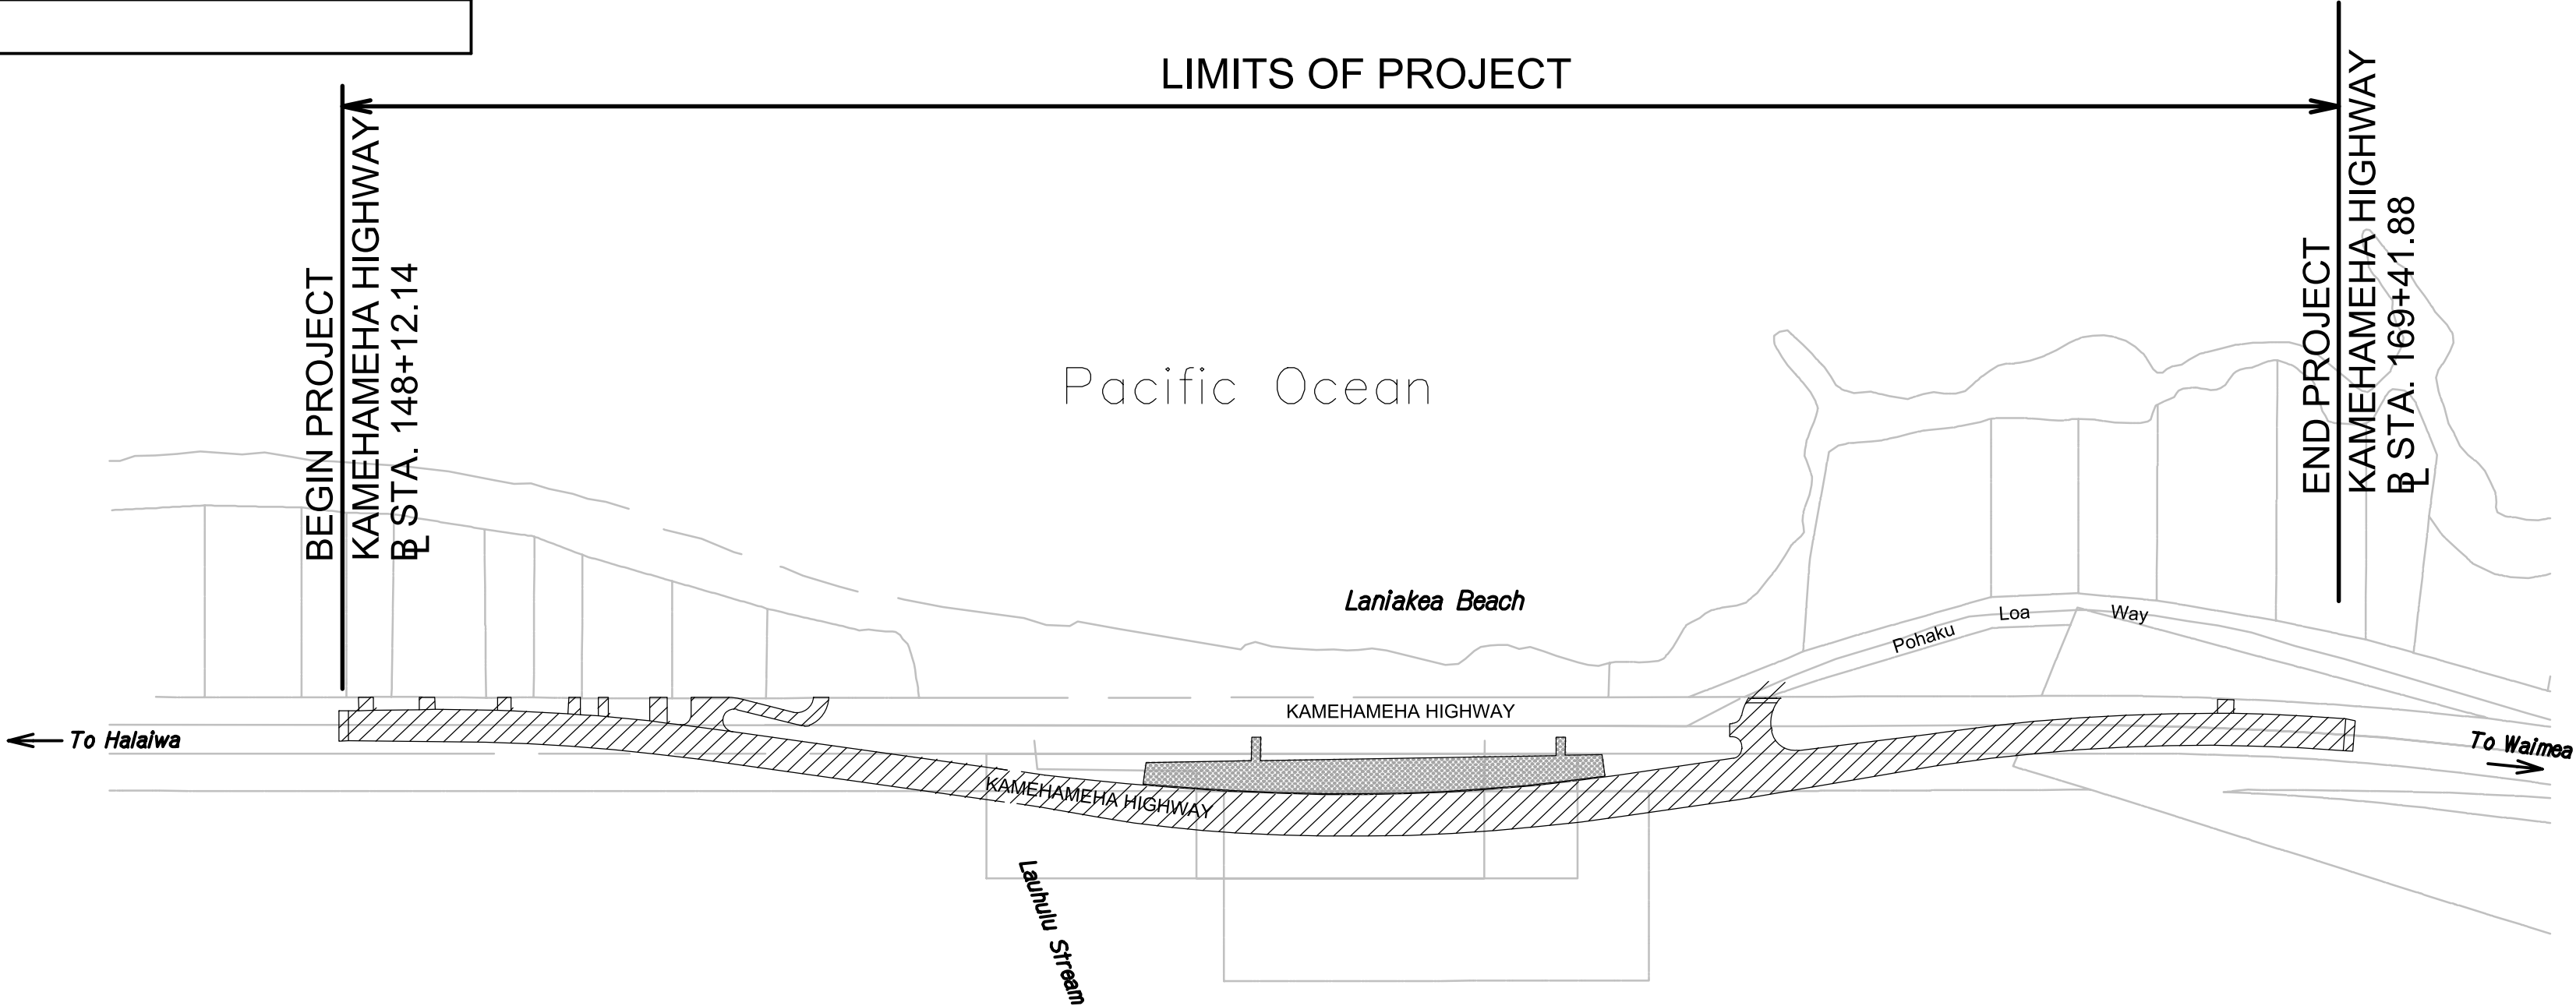

KAMEHAMEHA HIGHWAY
LOCATION PLAN - SITE
Scale: NTS

DEPARTMENT OF TRANSPORTATION
STATE OF HAWAII
APPROVED: Jun 14, 2023
DIR. OF TRANSPORTATION DATE

ORIGINAL PLAN	DATE
NOTE BOOK	
DESIGNED BY	
TRACED BY	
QUANTITIES BY	
CHECKED BY	