


FED. ROAD DIST. NO.	STATE	FED. AID PROJ. NO.	FISCAL YEAR	SHEET NO.	TOTAL SHEETS
HAWAII	HAW.	FR-083-1(21)	1984	4	7

ORIGINAL PLAN	DATE
DESIGNED BY	
TRACED BY	
NOTED BY	
CHECKED BY	

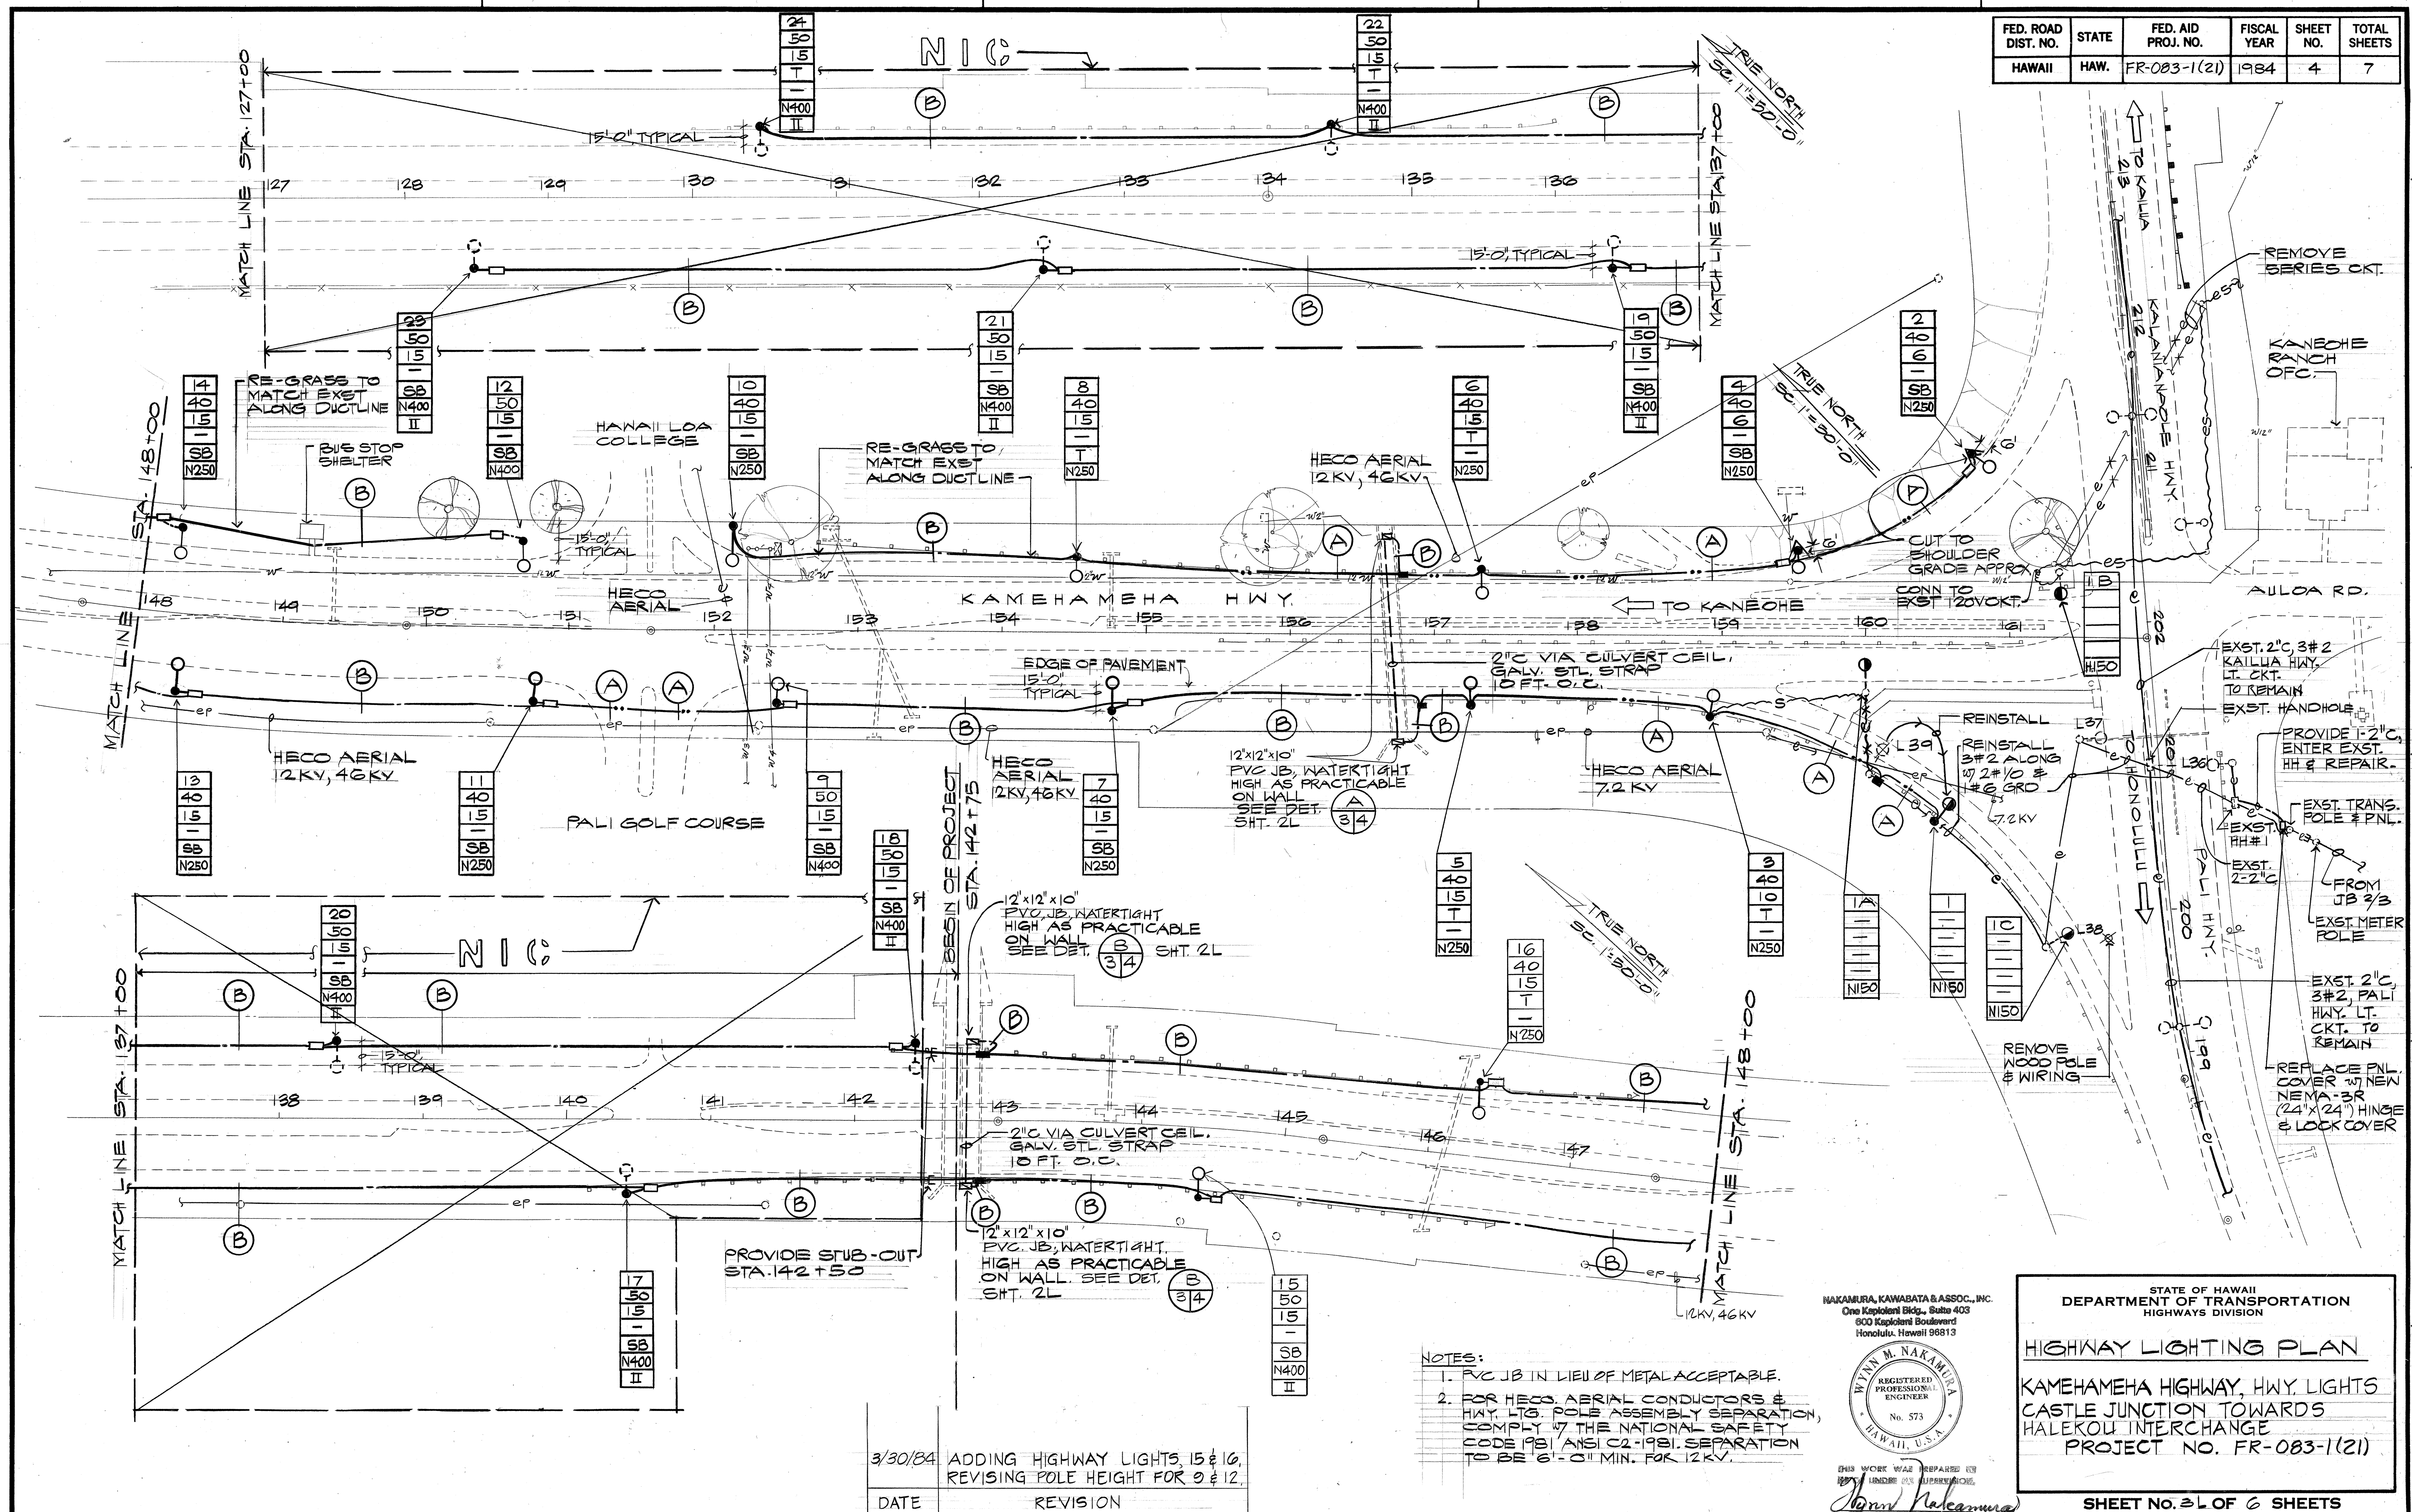

NAKAMURA, KAWABATA & ASSOC., INC.
One Kapiolani Bldg., Suite 403
800 Kapiolani Boulevard
Honolulu, Hawaii 96813

WYNN M. NAKAMURA
REGISTERED PROFESSIONAL ENGINEER
No. 573
HAWAII, U.S.A.

THIS WORK WAS PREPARED BY
UNDER AN AGREEMENT
J. Nakamura

STATE OF HAWAII
DEPARTMENT OF TRANSPORTATION
HIGHWAYS DIVISION

HIGHWAY LIGHTING PLAN
KAMEHAMEHA HIGHWAY, HWY. LIGHTS
CASTLE JUNCTION TOWARDS
HALEKOU INTERCHANGE
PROJECT NO. FR-083-1(21)

SHEET NO. 3L OF 6 SHEETS

ADD. 4