



FED. ROAD DIST. NO.	STATE	PROJ. NO.	FISCAL YEAR	SHEET NO.	TOTAL SHEETS
HAWAII	HAW.	83F-01-90	1990	3	0

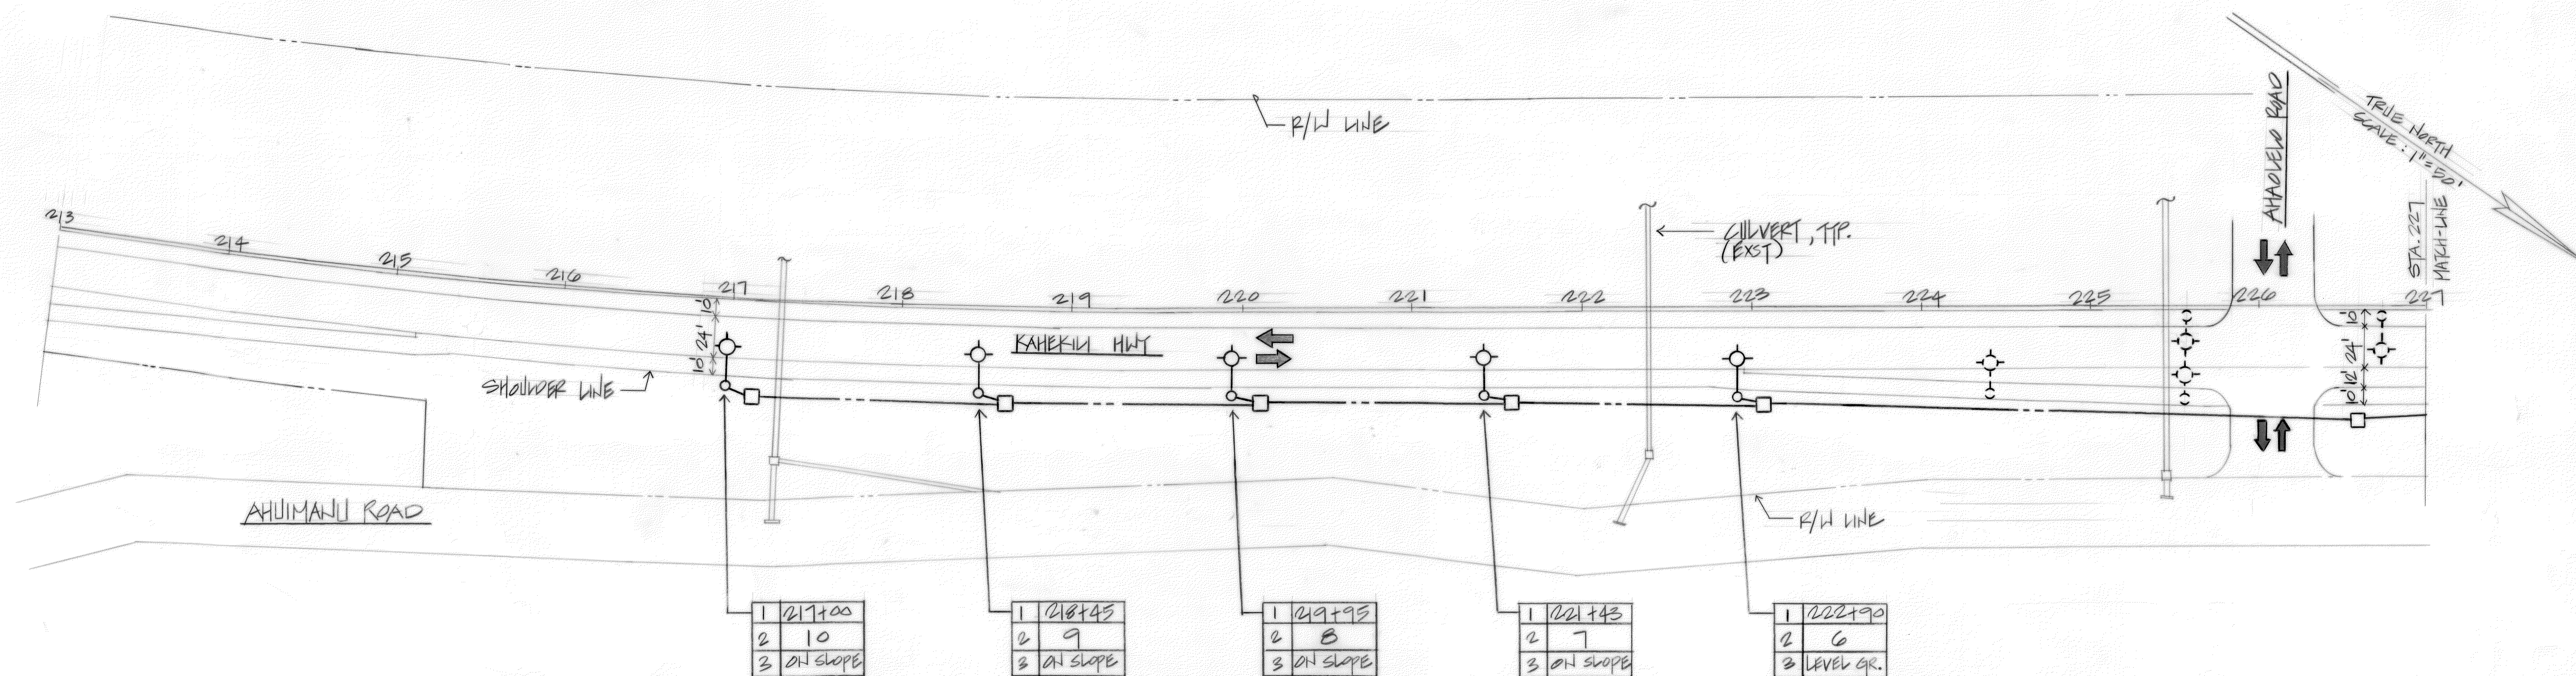

ELECTRICAL PLAN SCALE: 1"=50'

ORIGINAL PLAN	DATE
SURVEY PLOTTED BY	
DRAWN BY	
TRACED BY	
NOTED BY	
QUANTITIES BY	
CHECKED BY	
NO.	

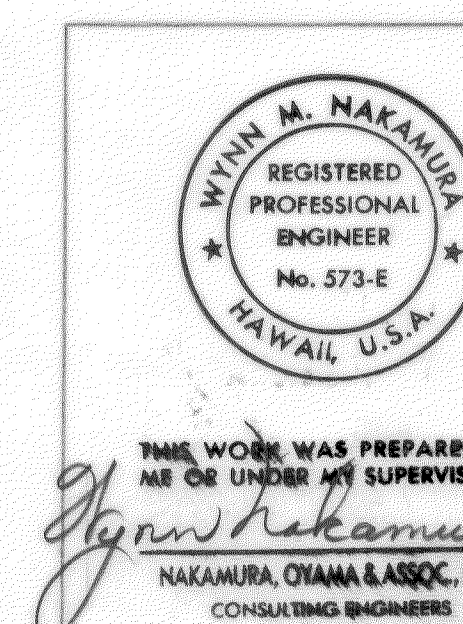

STATE OF HAWAII DEPARTMENT OF TRANSPORTATION HIGHWAYS DIVISION	
<u>ELECTRICAL PLAN</u>	
<u>KAHEKILI HIGHWAY</u>	
<u>HIGHWAY LIGHTING</u>	
<u>AHUIMANU ROAD TO KAHEKILI HWY</u>	
<u>PROJECT NO. 83F-01-90</u>	
SCALE: AS NOTED	DATE: MAY 14, 1990
SHEET No. 02 OF 0 SHEETS	

