


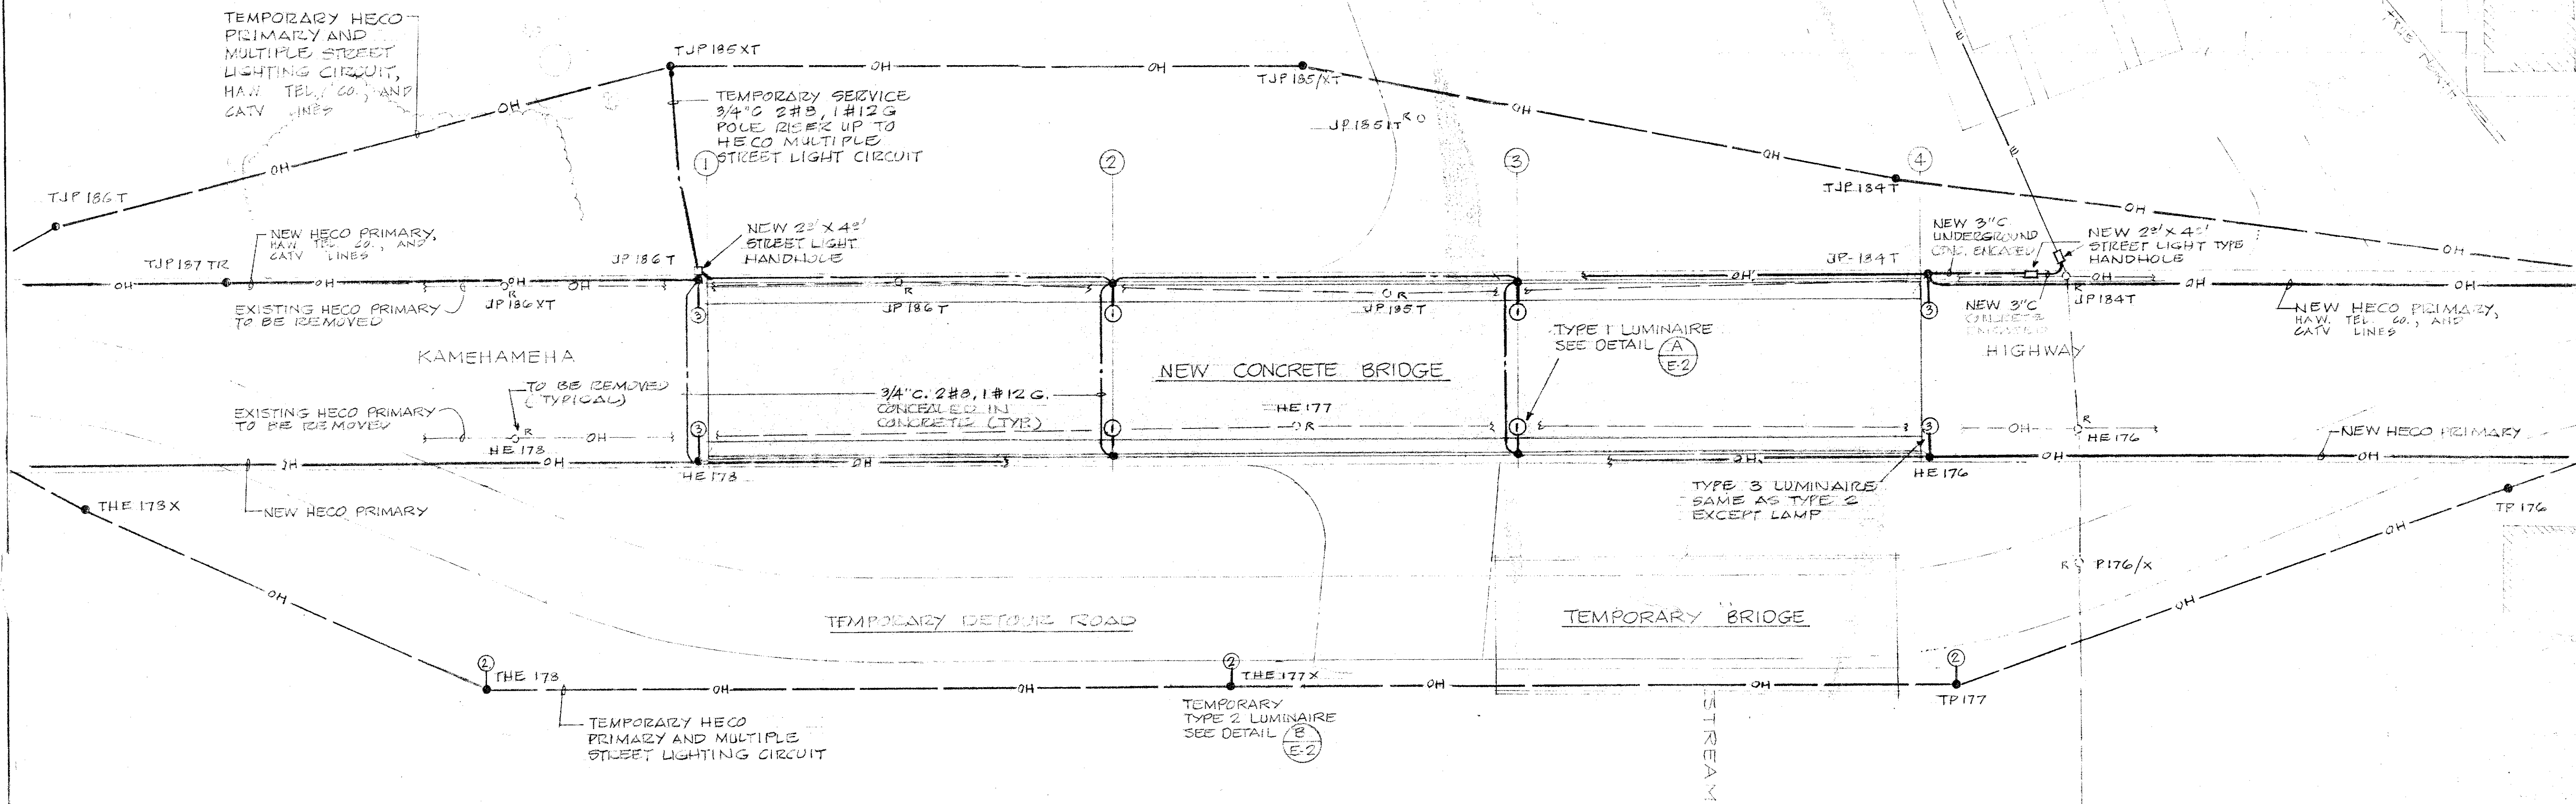

ELECTRICAL SITE PLAN SCALE: 1" = 20'-0"

ELECTRICAL SYMBOLS

- ① TYPE 1 LUMINAIRE (ON STREETLIGHT STD.)
- ② TYPE 2 LUMINAIRE (ON TEMPORARY POLE)
- ③ TYPE 3 LUMINAIRE (ON HECO POLE)
- NEW HECO POLE
- EXISTING HECO POLE TO BE REMOVED
- NEW HECO PRIMARY OVERHEAD LINE
- NEW HECO TEMPORARY OVERHEAD LINE
- EXISTING OVERHEAD LINE TO BE REMOVED
- NEW UNDERGROUND LINE IN CONDUIT
- EXISTING OVERHEAD LINE
- NEW 2" X 4" HANDHOLE (SLID-4 STREET LIGHT PULLBOX) PER STREET LIGHT STANDARD DRAWING NO. A-111

NOTES:

1. REMOVAL OF ALL EXISTING POLES, PRIMARY, SECONDARY AND COMMUNICATION CABLES ARE BY THEIR RESPECTIVE UTILITY COMPANIES.
2. INSTALLATION OF NEW AND TEMPORARY POLES, PRIMARY, SECONDARY AND MULTIPLE STREET LIGHTING CIRCUITS SHALL BE BY OTHERS.
3. INSTALL EXPANSION COUPLINGS ON ALL EXPANSION JOINTS.

U. S. DEPARTMENT OF AGRICULTURE SOIL CONSERVATION SERVICE

NO.	DATE	DESCRIPTION	ENGR.	DEPT. OR DIV.
REVISIONS				APPR'D

DEPARTMENT OF PUBLIC WORKS CITY AND COUNTY OF HONOLULU	
DIVISION OF ENGINEERING	
KAMEHAMEHA HIGHWAY BRIDGE OVER KAHALUU STREAM KAHALUU, OAHU, HAWAII	
ELECTRICAL SITE PLAN	
ENGINEER: J.R.	DATE: JUNE 17, 1977
DRAFTSMAN: K.M.I.	CHECKED BY: G.M.O.
APPROVED: <i>[Signature]</i>	
CHIEF, DIVISION OF ENGINEERING	

JOB NO. 38-77 DWG. NO. 7 E-39014