

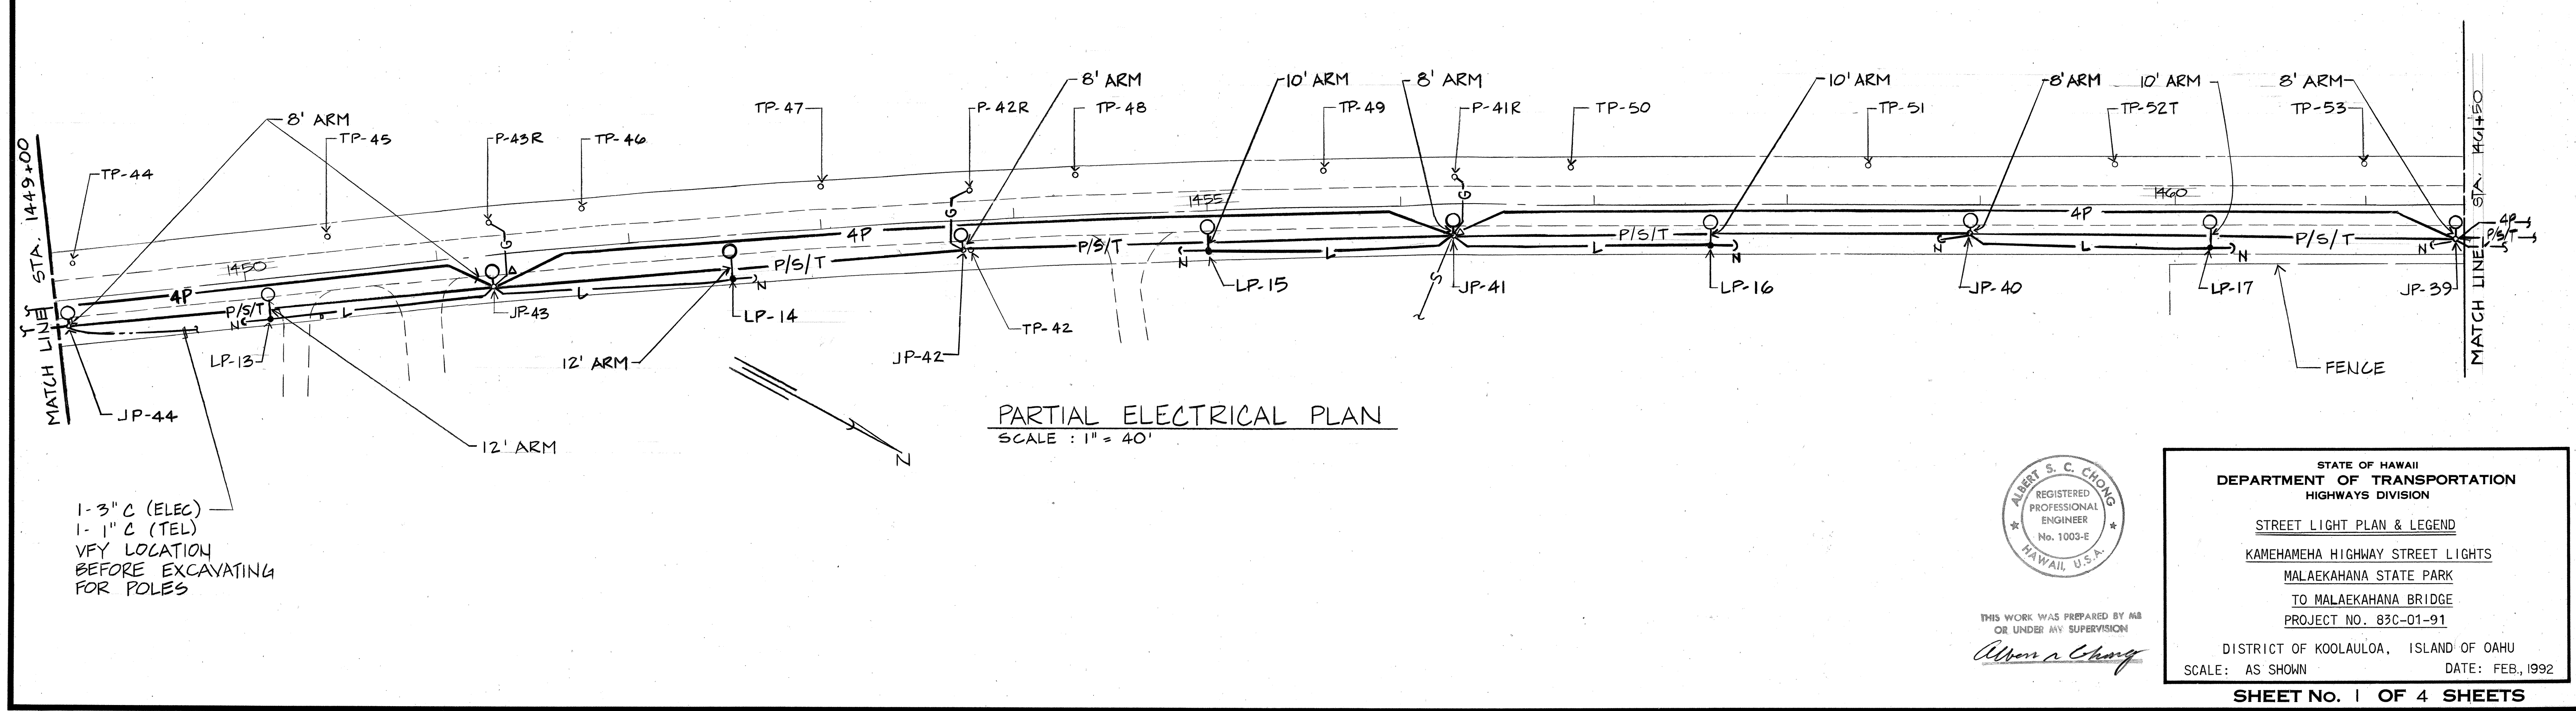


00788

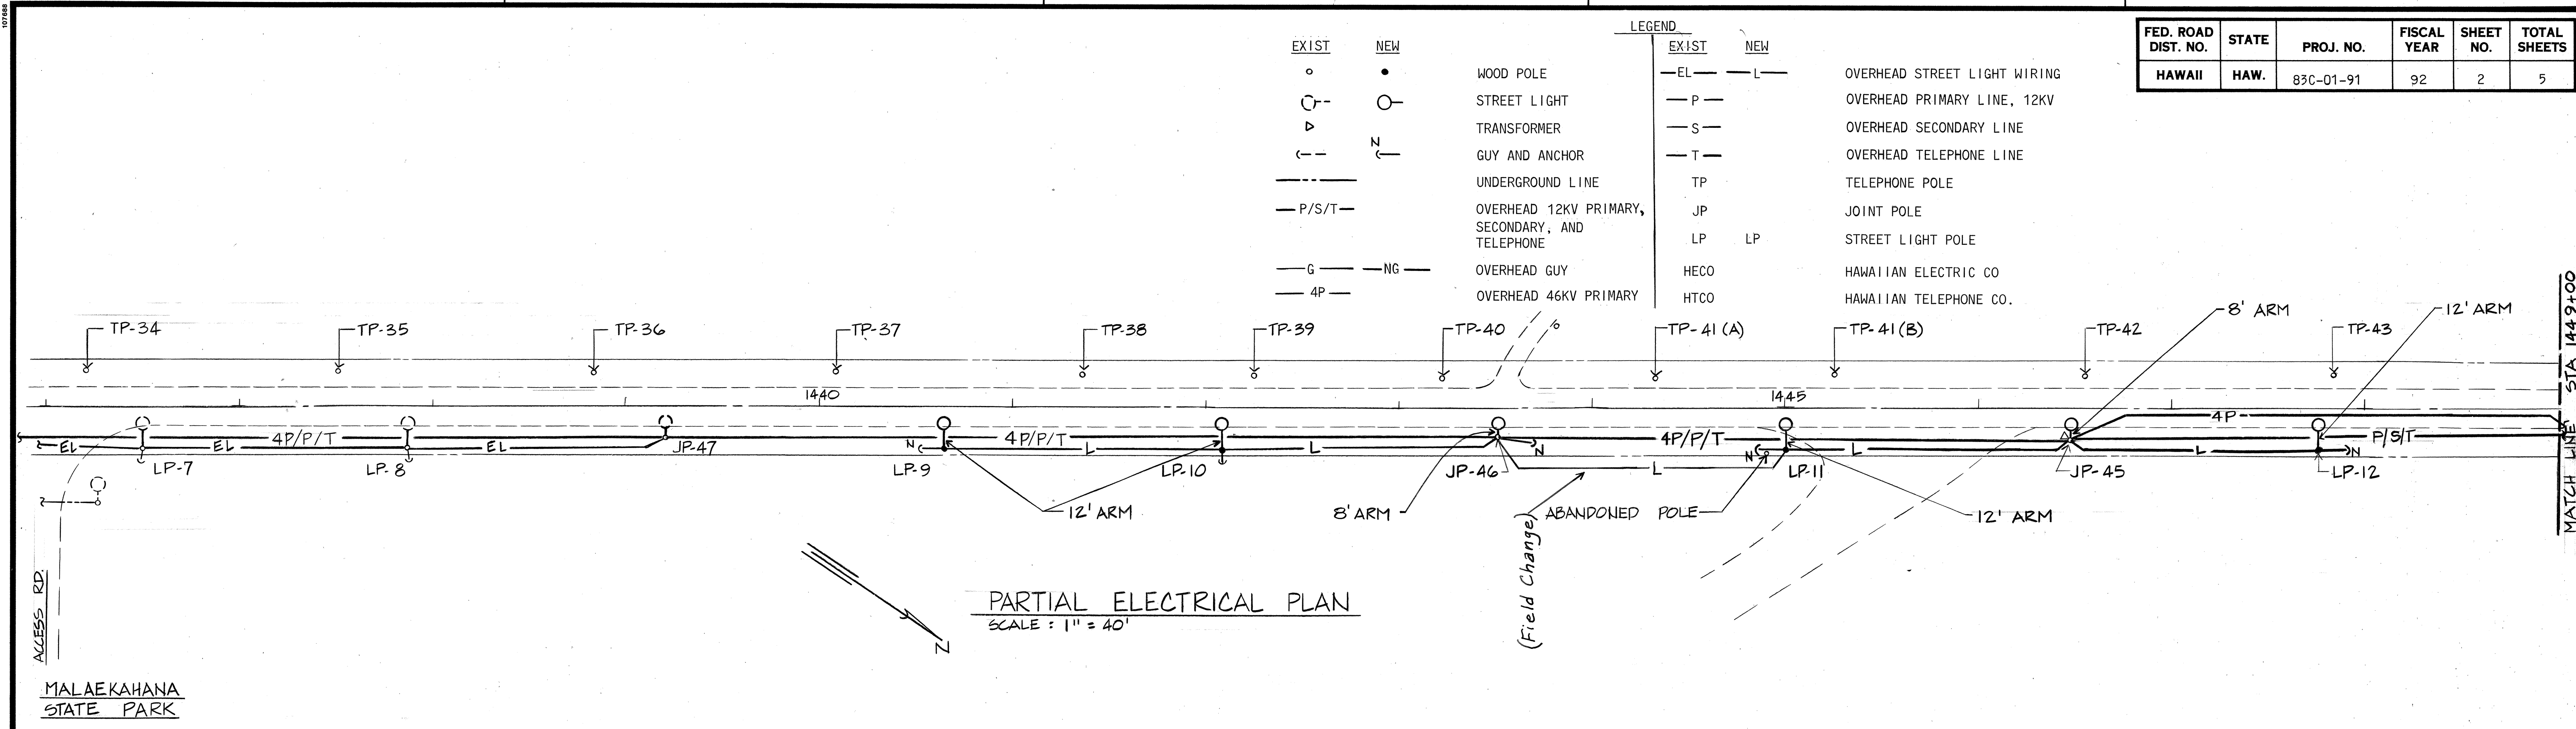

DATE	
SURVEY PLOTTED BY	
DRAWN BY	
DESIGNED BY	
QUANTITIES BY	
CHECKED BY	
ORIGINAL PLAN	
NOTE BOOK	
No.	

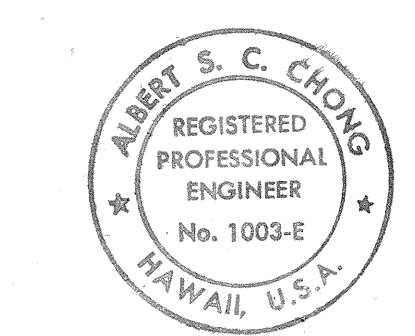

THIS WORK WAS PREPARED BY ME
OR UNDER MY SUPERVISION

Albert S. C. Chong

STATE OF HAWAII
DEPARTMENT OF TRANSPORTATION
HIGHWAYS DIVISION


STREET LIGHT PLAN & LEGEND

KAMEHAMEHA HIGHWAY STREET LIGHTS
MALAEKAHANA STATE PARK
TO MALAEKAHANA BRIDGE
PROJECT NO. 83C-01-91


DISTRICT OF KOOLAULOAA, ISLAND OF OAHU
SCALE: AS SHOWN DATE: FEB, 1992

SHEET NO. 1 OF 4 SHEETS

FED. ROAD DIST. NO.	STATE	PROJ. NO.	FISCAL YEAR	SHEET NO.	TOTAL SHEETS
HAWAII	HAW.	83C-01-91	92	3	5

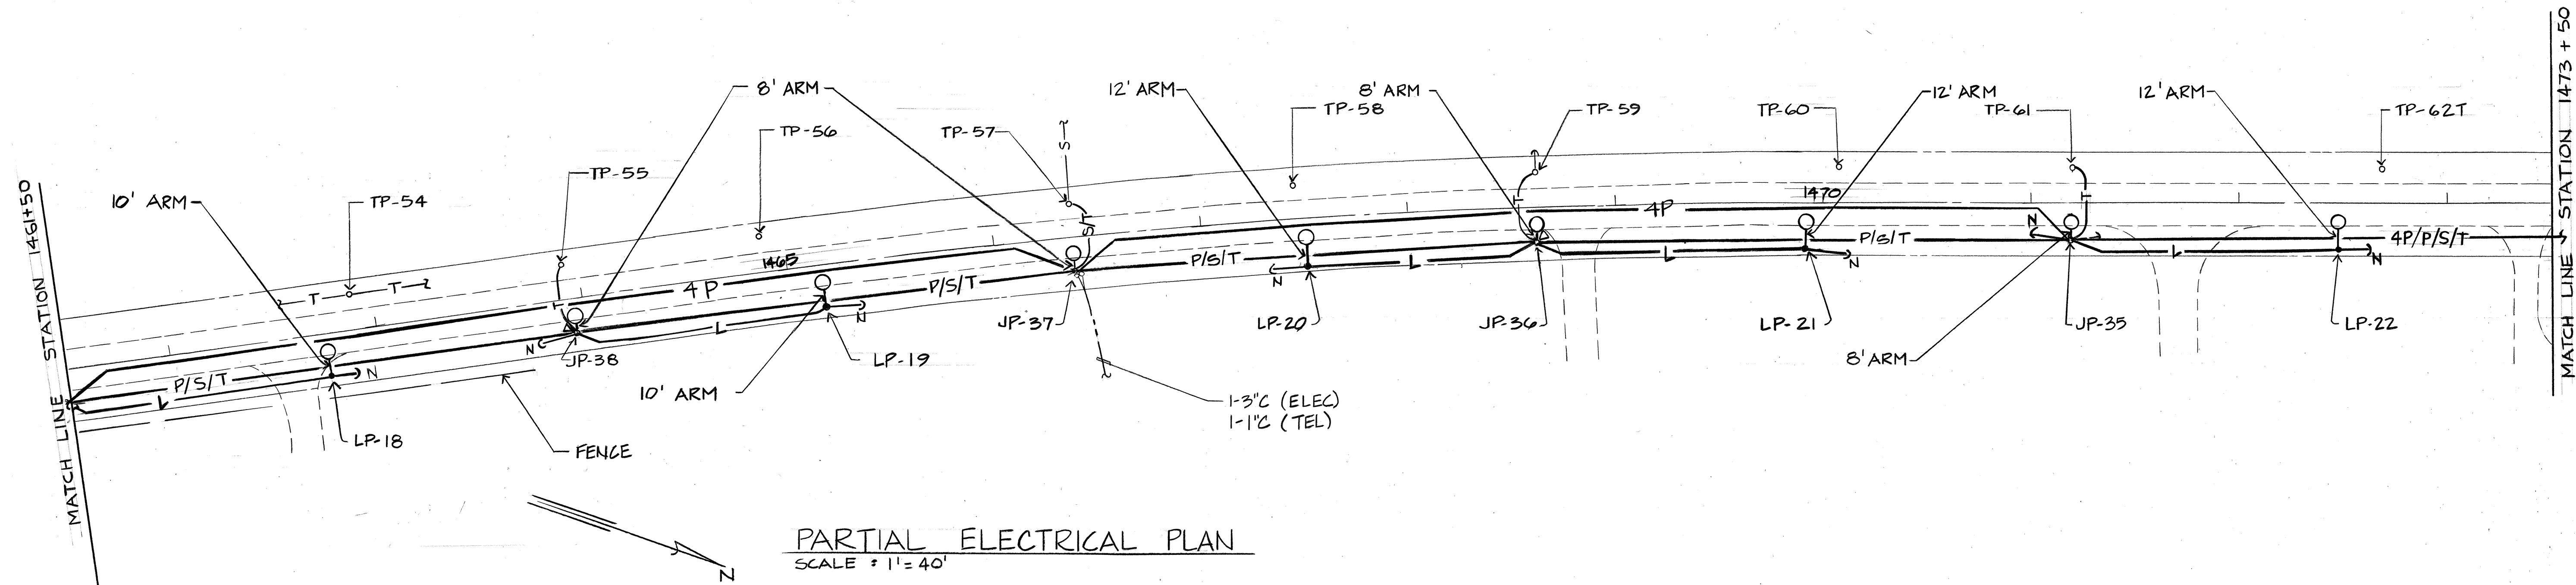

PARTIAL ELECTRICAL PLAN
SCALE : 1" = 40'

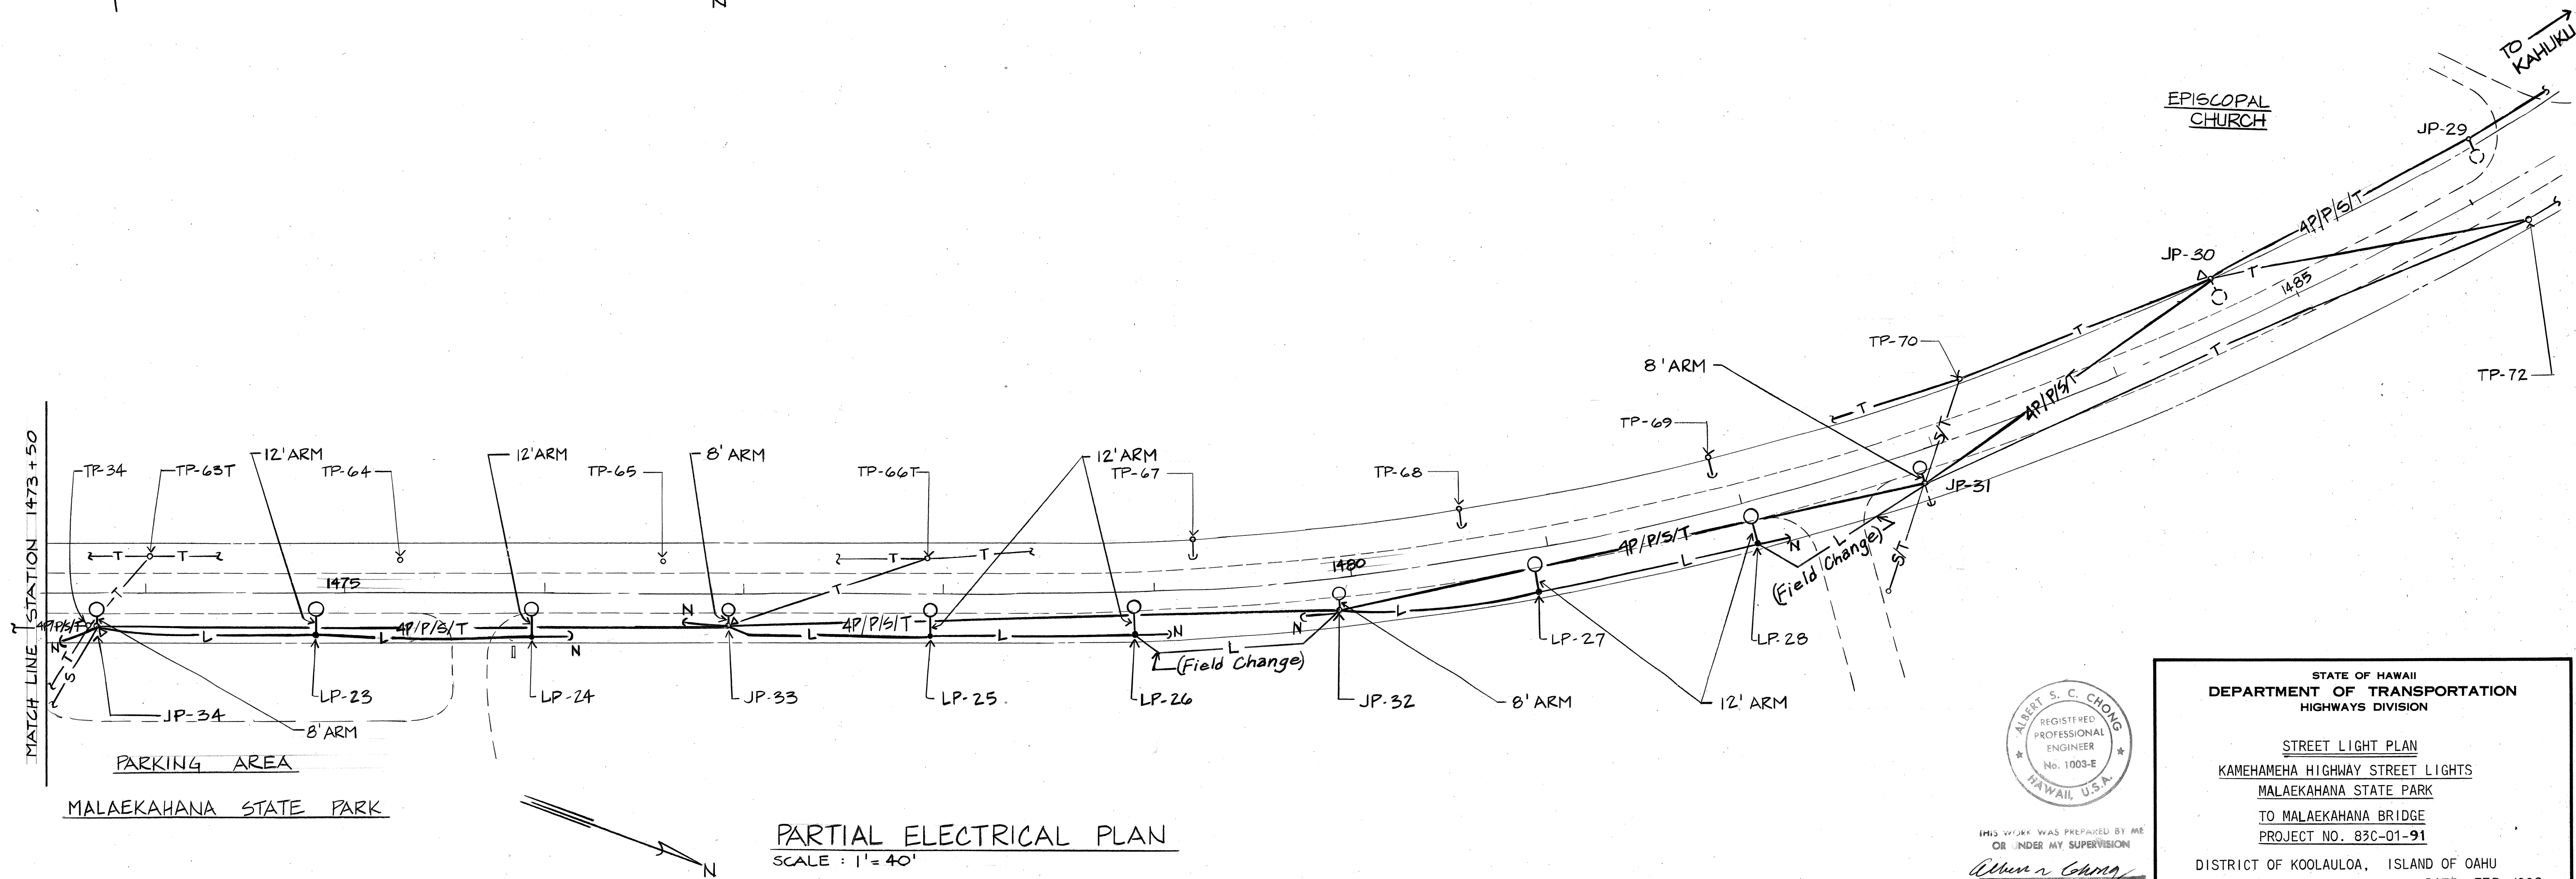

PARTIAL ELECTRICAL PLAN
SCALE : 1" = 40'

SURVEY PLOTTED BY	DATE
DESIGNED BY	
TRACED BY	
QUANTITIES BY	
CHECKED BY	
ORIGINAL PLAN	
NOTE BOOK	
No.	

ALBERT S. C. CHONG
REGISTERED PROFESSIONAL ENGINEER
No. 1003-E
HAWAII, U.S.A.
THIS WORK WAS PREPARED BY ME
OR UNDER MY SUPERVISION
Albert S. C. Chong

STATE OF HAWAII
DEPARTMENT OF TRANSPORTATION
HIGHWAYS DIVISION

STREET LIGHT PLAN
KAMEHAMEHA HIGHWAY STREET LIGHTS
MALAEKAHANA STATE PARK
TO MALAEKAHANA BRIDGE
PROJECT NO. 83C-01-91



DISTRICT OF KOOLAULOA, ISLAND OF OAHU
SCALE: AS SHOWN DATE: FEB, 1992

SHEET NO. 2 OF 4 SHEETS


ORIGINAL PLAN	SURVEY PLOTTED BY _____ DATE _____	
NOTE BOOK	DRAWN BY _____	* _____
	TRACED BY _____	* _____
	DESIGNED BY _____	* _____
	QUANTITIES BY _____	* _____
No. _____	CHECKED BY _____	* _____

4


FED. ROAD DIST. NO.	STATE	PROJ. NO.	FISCAL YEAR	SHEET NO.	TOTAL SHEETS
HAWAII	HAW.	83C-01-91	92	5	5

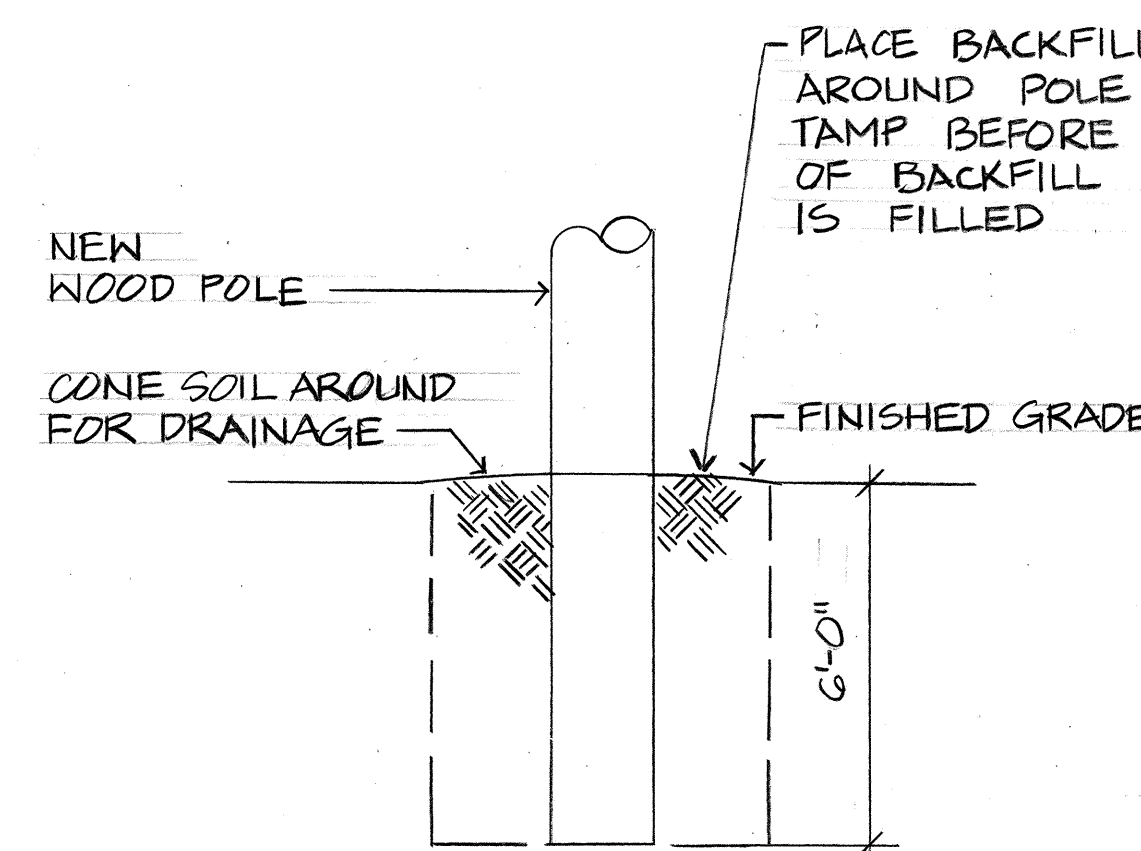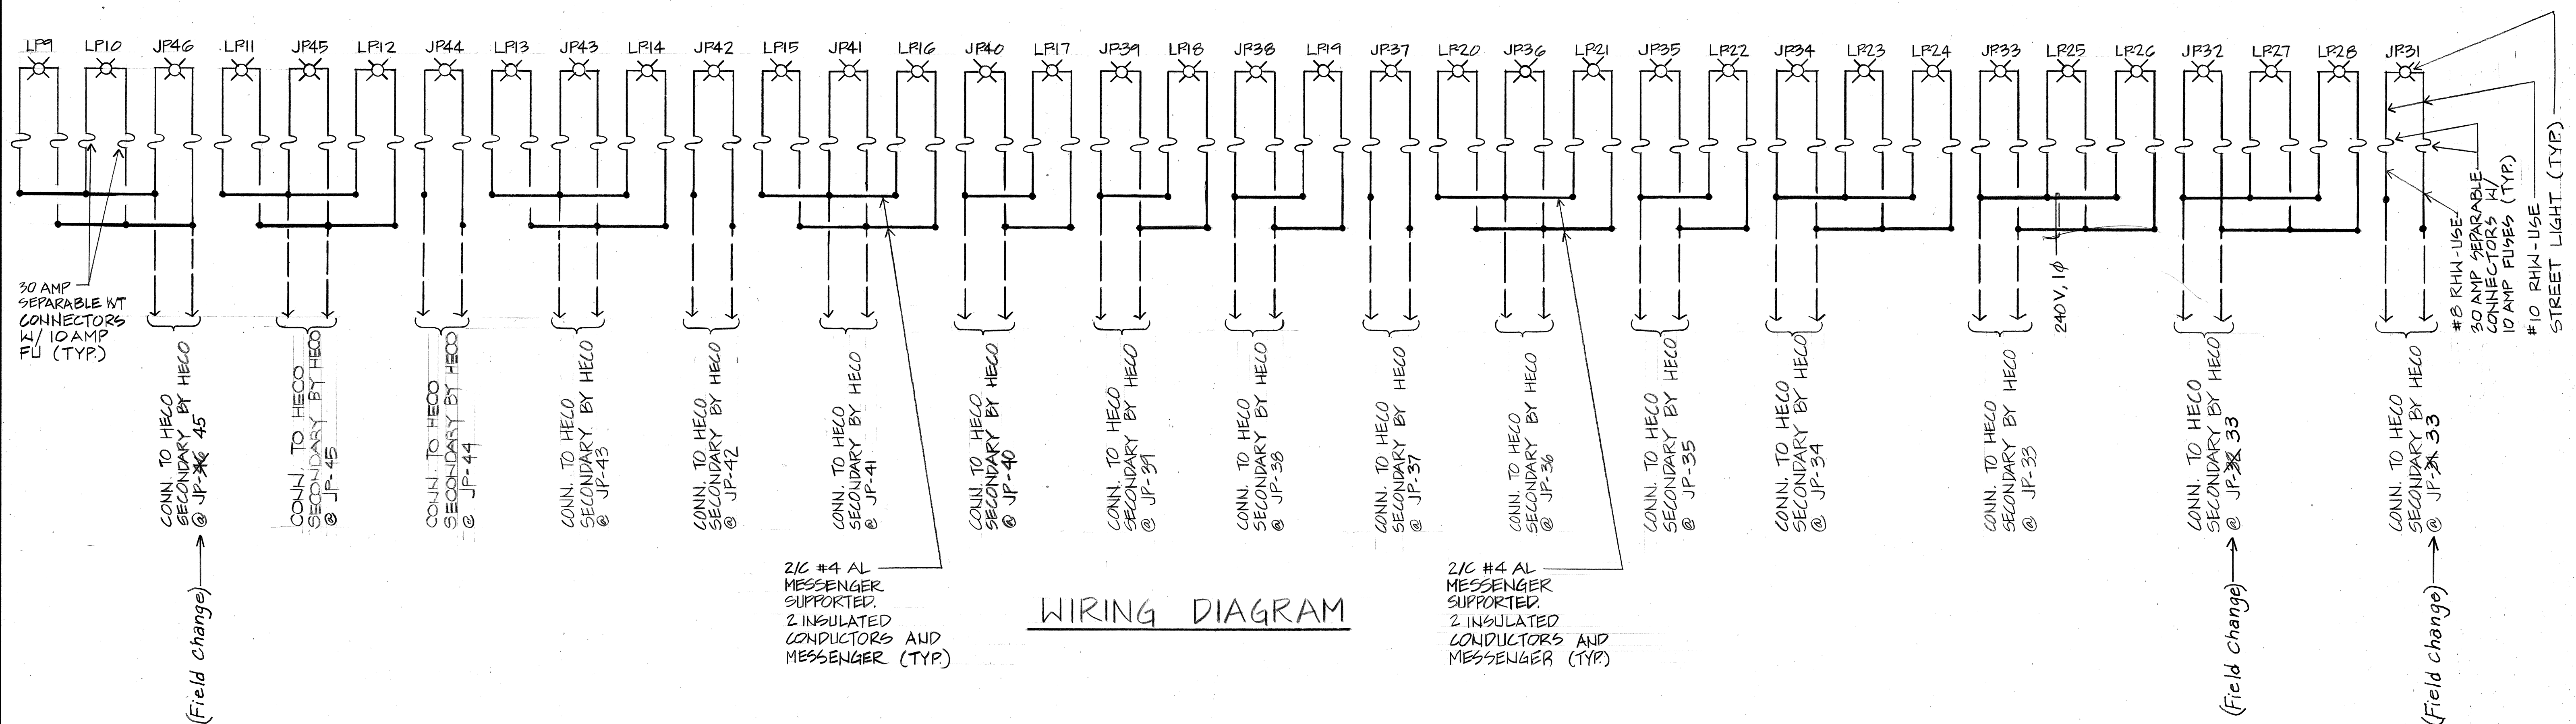


1 POLE SETTING DETAIL
4 N.T.S.

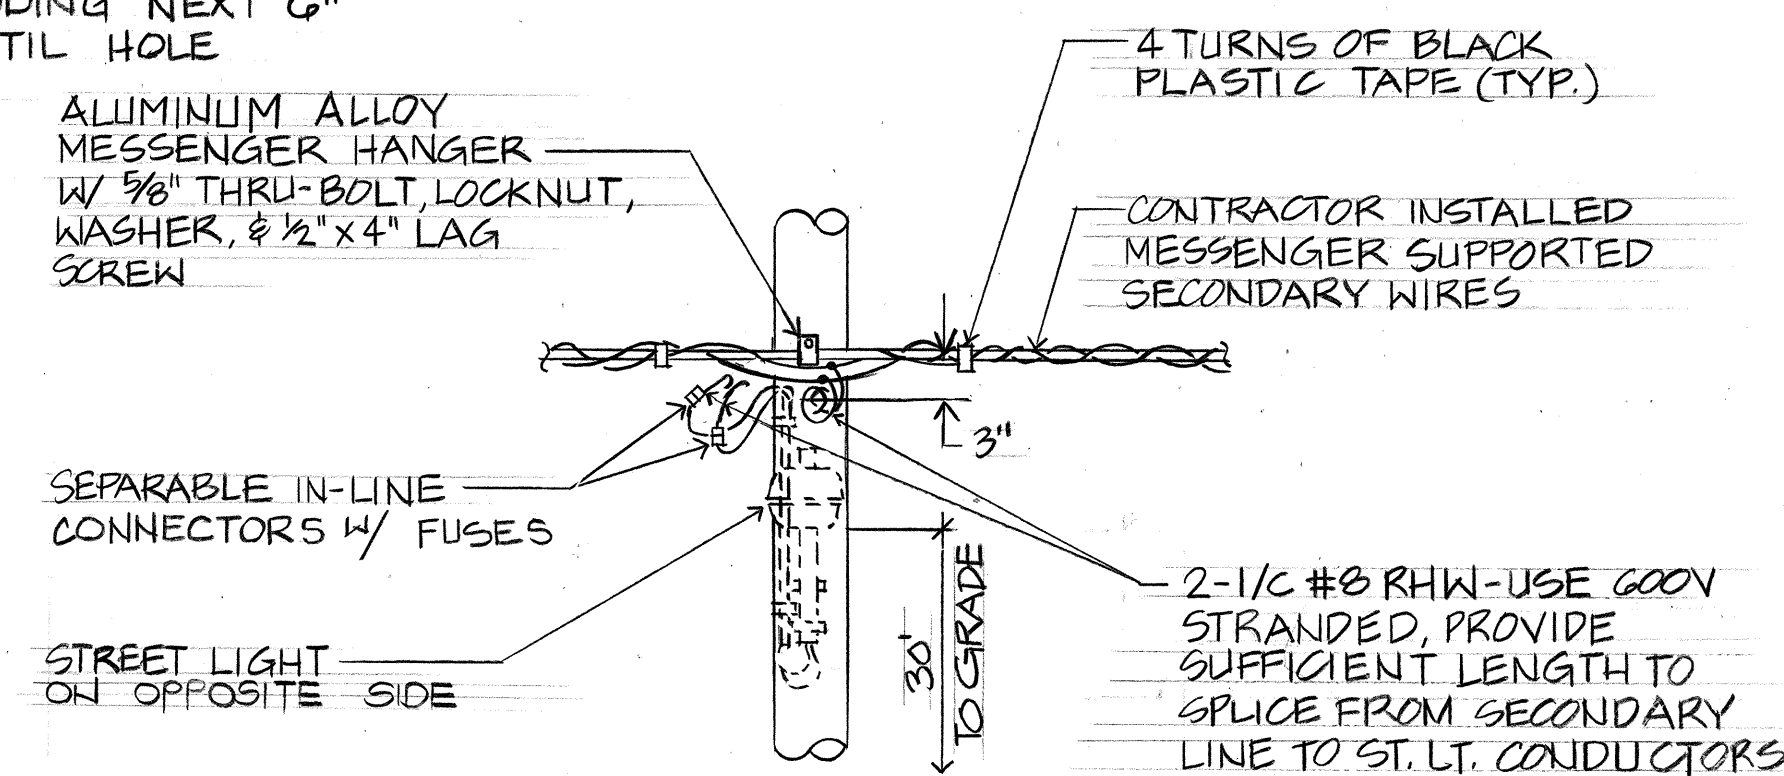

2 STREET LIGHT CIRCUIT TANGENT DETAIL
4 N.T.S.

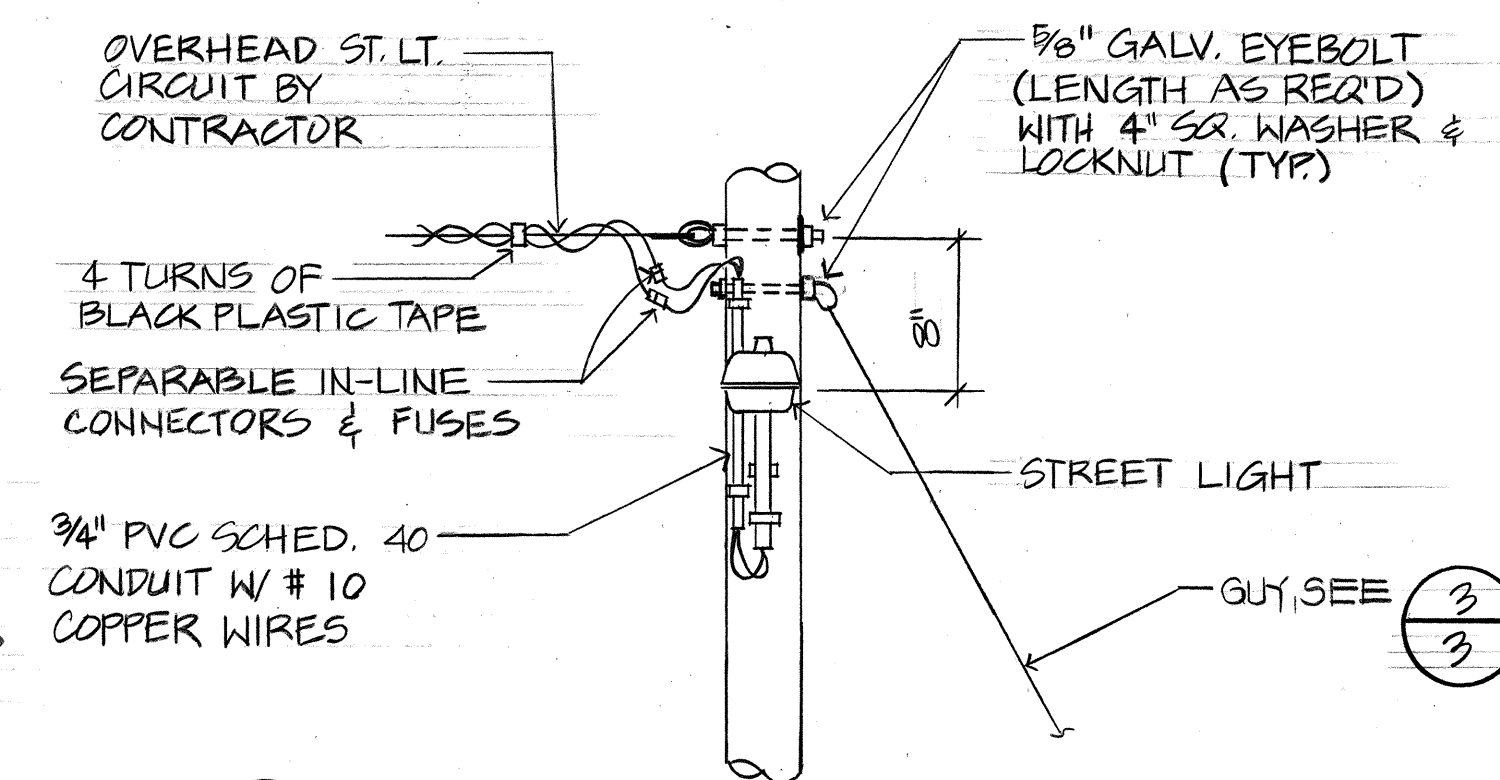

3 STREET LIGHT CIRCUIT DEAD END DETAIL
4 N.T.S.

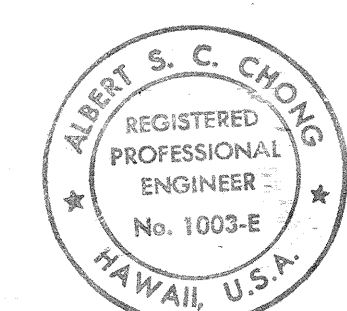

THIS WORK WAS PREPARED BY ME OR UNDER MY SUPERVISION

Albert S. C. Chong

STATE OF HAWAII
DEPARTMENT OF TRANSPORTATION
HIGHWAYS DIVISION

STREET LIGHT CIRCUIT DETAILS AND WIRING DIAGRAM
KAMEHAMEHA HIGHWAY STREET LIGHTS
MALAEKAHANA STATE PARK
TO MALAEKAHANA BRIDGE
PROJECT NO. 83C-01 91
DISTRICT OF KOOLAULOA, ISLAND OF OAHU
SCALE: AS SHOWN DATE: FEB., 1992

SHEET NO. 4 OF 4 SHEETS