

INDEX TO DRAWINGS	
SHEET NO.	DESCRIPTION
1	TITLE SHEET
2	GENERAL PLAN
3	NOTES
4	BASELINE DATA SHEET
5	STANDARD PLANS SUMMARY
6-7	TYPICAL ROAD SECTIONS
8-10	MAJOR INTERSECTIONS GEOMETRIC LAYOUT
11-23	PLAN & PROFILE-BY PASS ROAD
24	PLAN & PROFILE-WAIALUA CONNECTOR ROAD
25	PLAN & PROFILE-HALEIWA CONNECTOR ROAD
26	PLAN & PROFILE-EMERSON ROAD
27-30	PLAN & PROFILE-CANEHAUL ROAD "A"
31-32	PLAN & PROFILE-CANEHAUL ROAD "B"
33	PLAN & PROFILE-CANEHAUL ROAD "C"
34-35	SUPERELEVATION DIAGRAMS
36-44	GRADING PLANS
45-48	DRAIN LINE PROFILES
49-56	MISCELLANEOUS DETAILS
57-62	DRAINAGE SUMMARY
63-70	BORING LOGS
71-82	SIGNING & STRIPING PLAN
83	SPECIAL SIGN DETAIL
84-85	DETOUR PLANS
86-123	CROSS SECTIONS
124-161	HIGHWAY LIGHTING & ELECTRICAL PLANS


Plan Sht. Nos. ① C.O.19S-1, ② C.O.35S-1, ③ 38S-1, 44S-1, 44S-2 and ④ C.O.146S-1, C.O.161S1, C.O.161S-1A and C.O.161S-2 through C.O.161S-16 are supplementary sheets to this project. TOTAL SHEET COUNT after "AS-BUILT" postings 185 sheets.

STATE OF HAWAII
DEPARTMENT OF TRANSPORTATION
HIGHWAYS DIVISION
HONOLULU, HAWAII
"AS-BUILT"
PLANS FOR
CONSTRUCTION OF
KAMEHAMEHA HIGHWAY
HELEMANO/WAIALUA JUNCTION
TO HALEIWA BEACH PARK
(ROADWAY)

PROJECT NO. 83A-01-92

DISTRICT OF WAIALUA
ISLAND OF OAHU

FED. ROAD DIST. NO.	STATE	PROJ. NO.	FISCAL YEAR	SHEET NO.	TOTAL SHEETS
HAWAII	HAW.	83A-01-92	1992	1	167

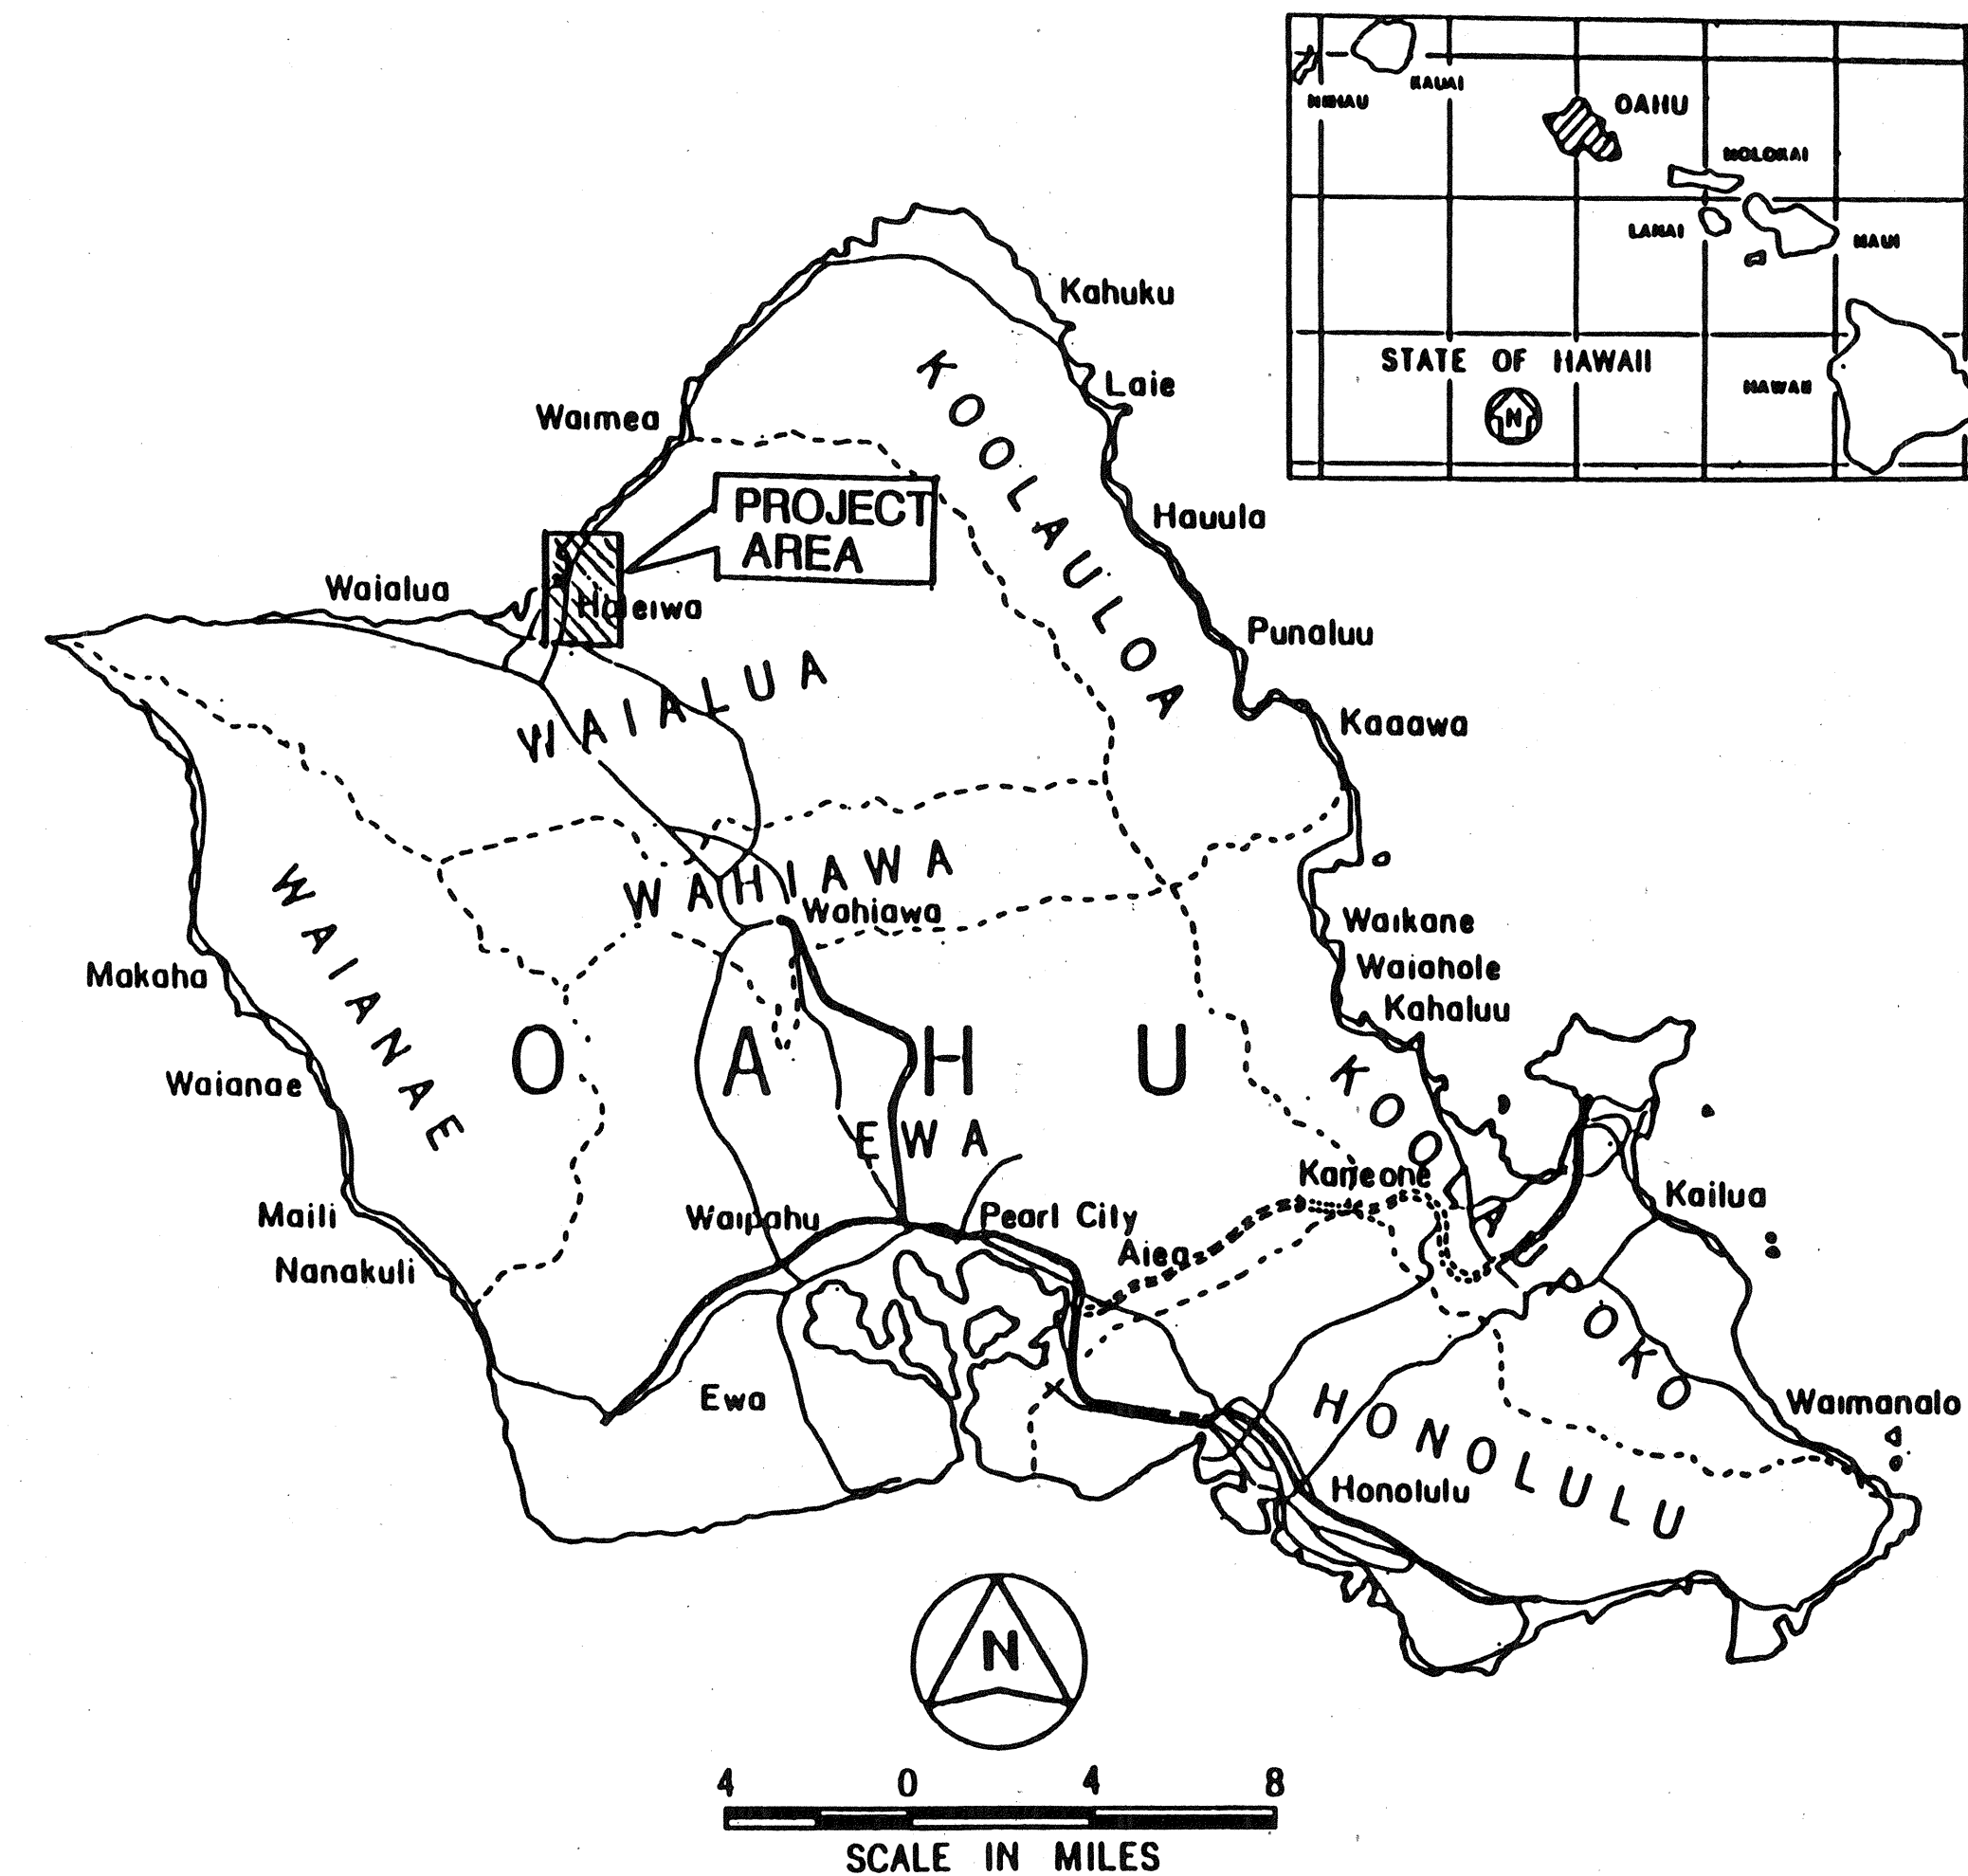

VICINITY MAP
TMK'S: 6-2-01 THRU 07, 12 AND 6-4-01

DESIGN DESIGNATION	
DESIGN ADT (2001)	23,000
DHV	1,780
D	55/40
T	3%
T ₂₄	5%
V	60 MPH

CHANGES MADE DURING CONSTRUCTION HAVE BEEN INCORPORATED ON THESE PLANS EXCEPT CHANGES IN THE ORIGINAL THEORETICAL QUANTITIES. FOR ACTUAL QUANTITIES, REFER TO PROJECT LEDGER AND/OR COMPUTATION BOOK.

RESIDENT ENGINEER
DATE 8/31/99

DEPARTMENT OF TRANSPORTATION STATE OF HAWAII	
APPROVED: <i>H. Pang</i>	10/18/91
DIR. OF TRANSPORTATION	DATE

DESIGNED BY: H. TAO
P.S. & E BY: H. TAO
PHONE: 587-2124
DATE: OCT 1991

