
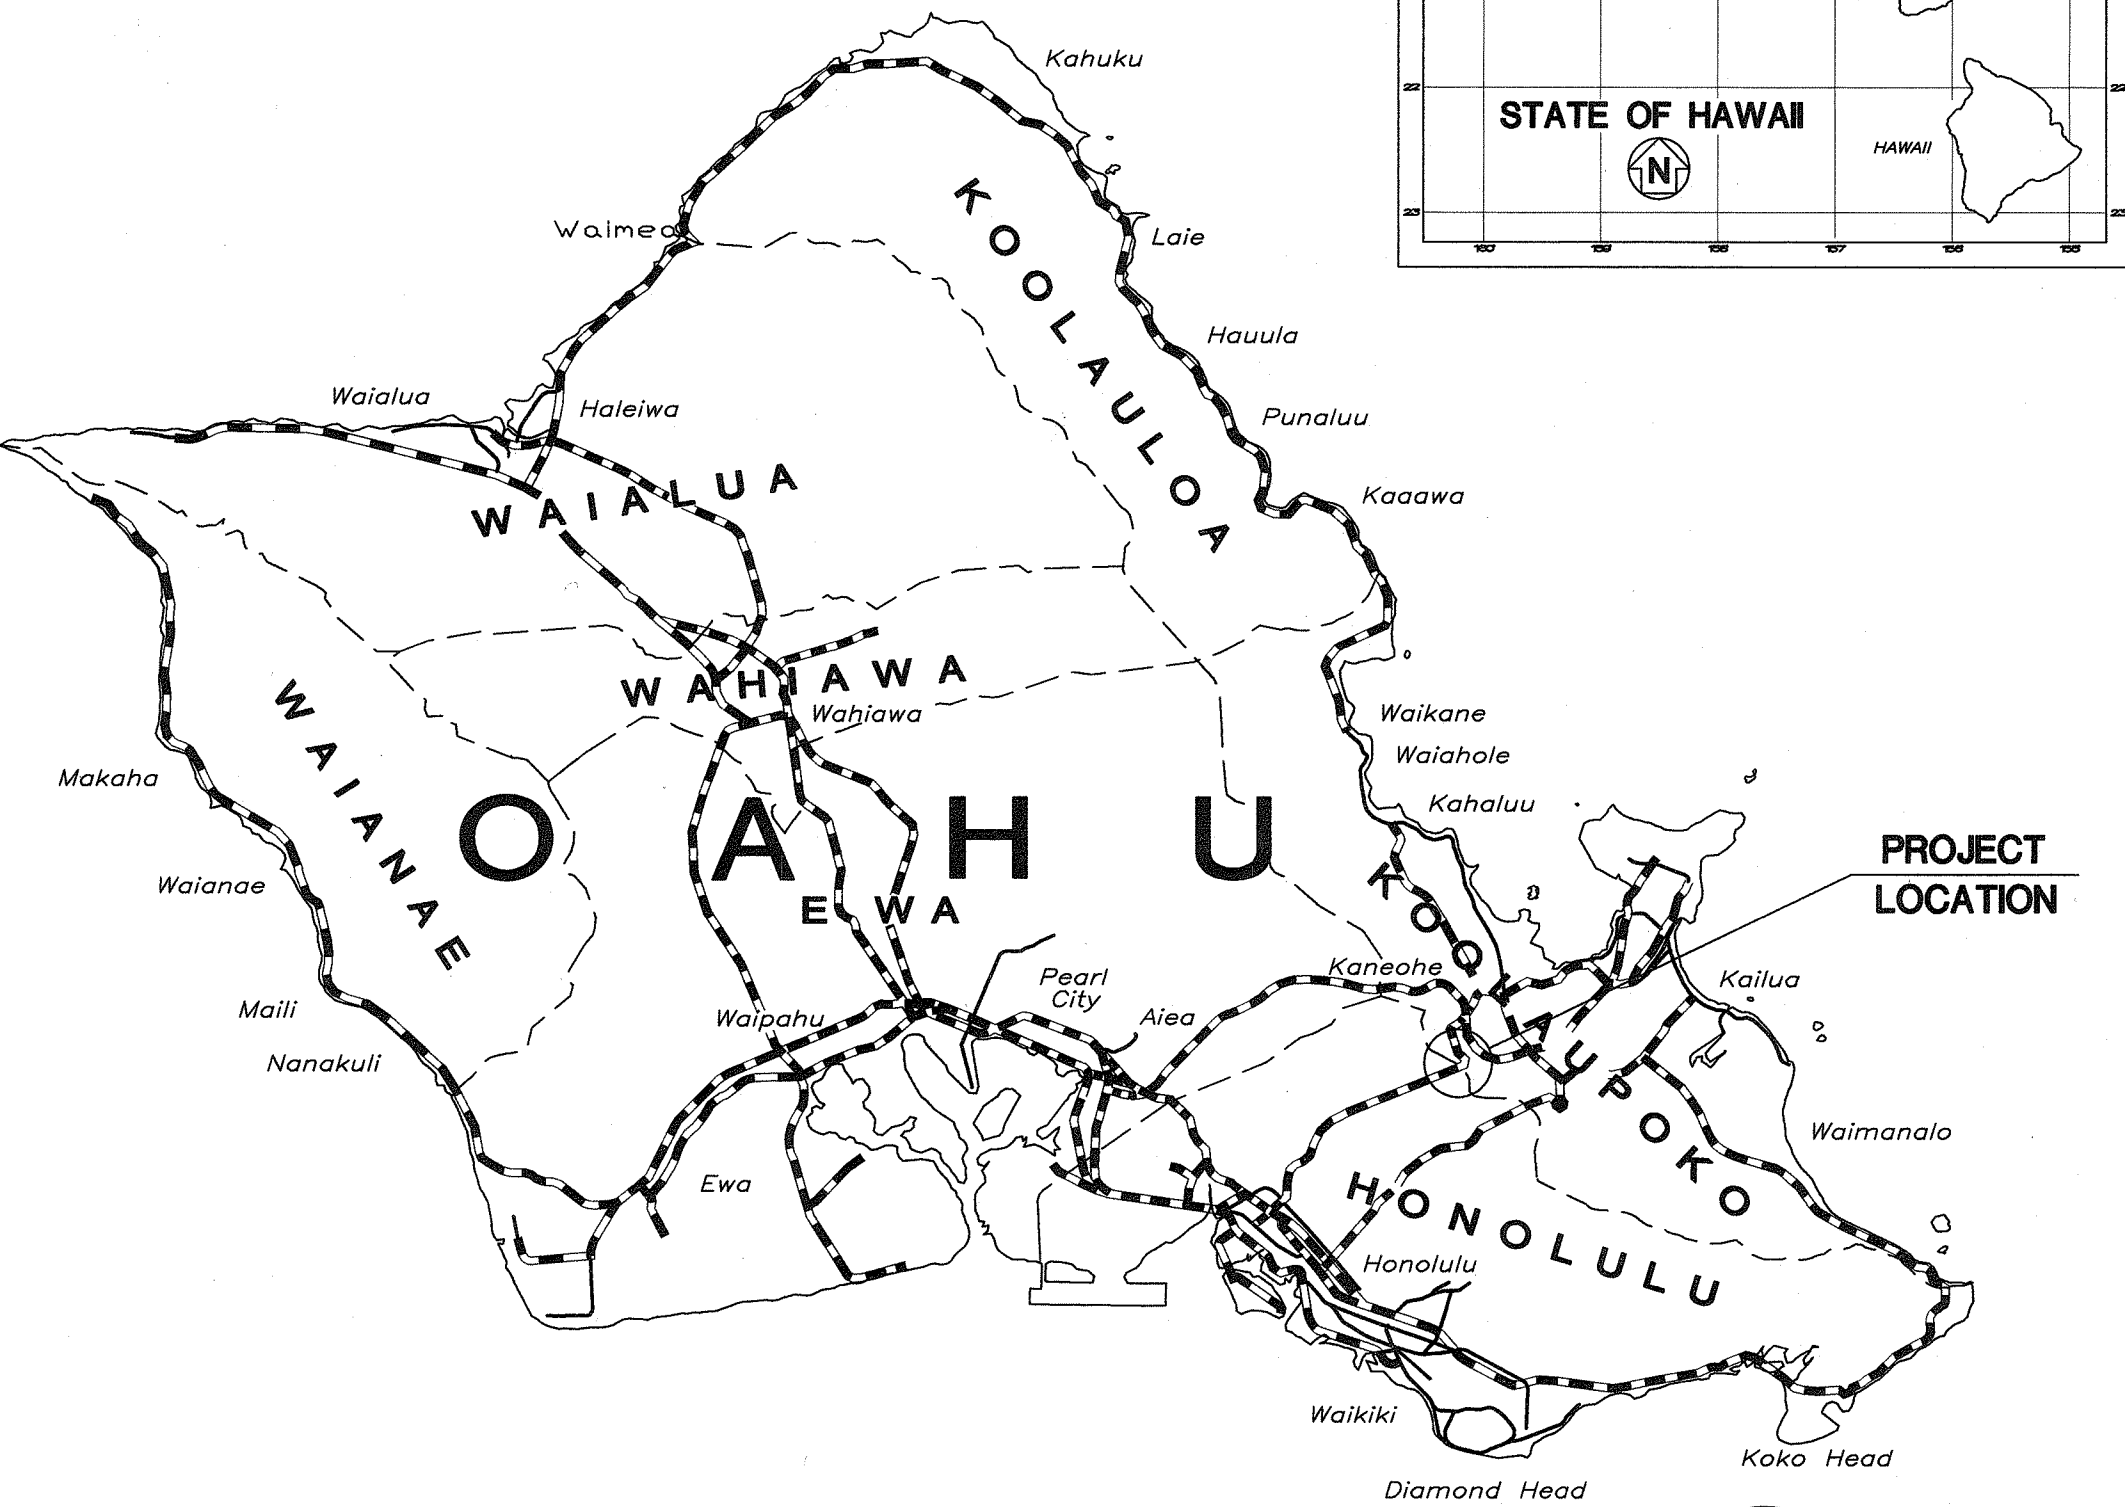



INDEX TO DRAWINGS	
SHEET NO.	DESCRIPTION
1	TITLE SHEET
2	STANDARD PLANS SUMMARY
3 - 7	GENERAL NOTES AND LEGEND
8 - 9	TYPICAL SECTIONS & DETAILS
10 - 12	ROADWAY PLANS
13	IMPROVEMENTS TO ISLANDS/MEDIANS - INTERSECTION #1
14 - 23	DETAILED INTERSECTION PLANS
24 - 27	CURB RAMP DETAILS
28 - 32	MISCELLANEOUS GUARDRAIL DETAILS
33	FLEAT-350 FLARED ENERGY ABSORBING TERMINAL
34 - 36	TYPE "A" FLARE
37	MISCELLANEOUS DETAILS
38 - 43	UTILITY ADJUSTMENT SCHEDULES
44 - 54	SIGNAGE & PAVEMENT MARKING LEGEND, NOTES, SUMMARY, PLANS & DETAILS
55 - 59	TRAFFIC CONTROL NOTES, LEGEND, & PLANS
60 - 71	HIGHWAY LIGHTING NOTES, PLANS & DETAILS
72 - 83	TRAFFIC SIGNAL SYSTEM NOTES, PLANS, PROFILES & DETAILS
84 - 86	ELECTRICAL PLAN & DETAILS
87 - 90	DRAINAGE PLANS

STATE OF HAWAII
DEPARTMENT OF TRANSPORTATION
HIGHWAYS DIVISION
HONOLULU, HAWAII
"AS-BUILT"
PLANS FOR
**KAMEHAMEHA HIGHWAY
RESURFACING**
KANEHOE BAY DRIVE TO
KAHIKO STREET
FEDERAL AID PROJECT NO. NH-083-1(41)
DISTRICT OF KOOLAUPOKO
ISLAND OF OAHU

FED. ROAD DIST. NO.	STATE	FED. AID PROJ. NO.	FISCAL YEAR	SHEET NO.	TOTAL SHEETS
HAWAII	HAW.	NH-083-1(41)	2000	1	90

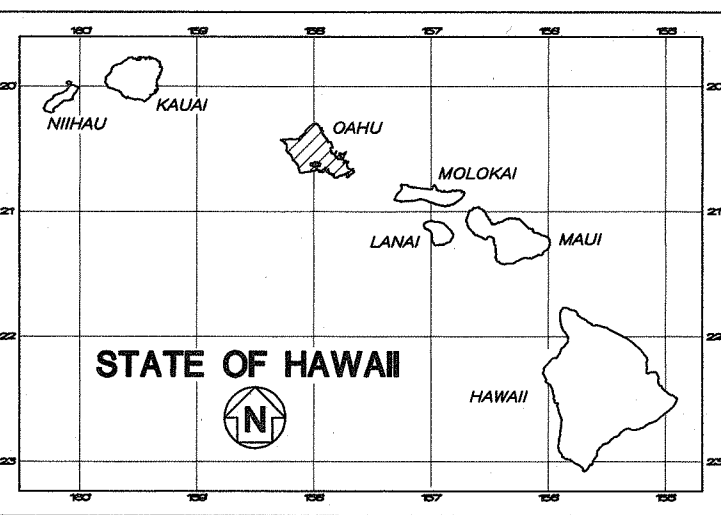

CHANGES MADE DURING CONSTRUCTION HAVE BEEN INCORPORATED ON THESE PLANS EXCEPT CHANGES IN THE ORIGINAL THEORETICAL QUANTITIES. FOR ACTUAL QUANTITIES, REFER TO PROJECT LOGBOOK AND/OR COMPUTATION BOOK.
[Signature] 5/17/2011
RESIDENT ENGINEER DATE

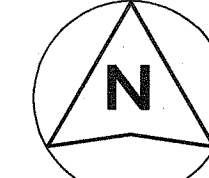

SCALE IN MILES

FEDERAL AID PROJECTS PREVIOUSLY CONSTRUCTED OR UNDER CONSTRUCTION

MILE POST 41.38 TO MILE POST 42.52

1 - DESIGN DESIGNATION

Southbound

ADT (1998)	40,400
ADT (2008)	46,900
ADT (2028)	N/A
DHV	3,800
K	8.0
D	55/45
T	2.5
T24	3.5
V	35

2 - DESIGN DESIGNATION


Northbound

ADT (1998)	40,400
ADT (2008)	N/A
ADT (2028)	51,100
DHV	3,800
K	8.0
D	55/45
T	2.5
T24	3.5
V	35

TMK: 4-5-34,36,38,39,43,44,54,60,76,77&103.



SCALE IN THOUSAND FEET

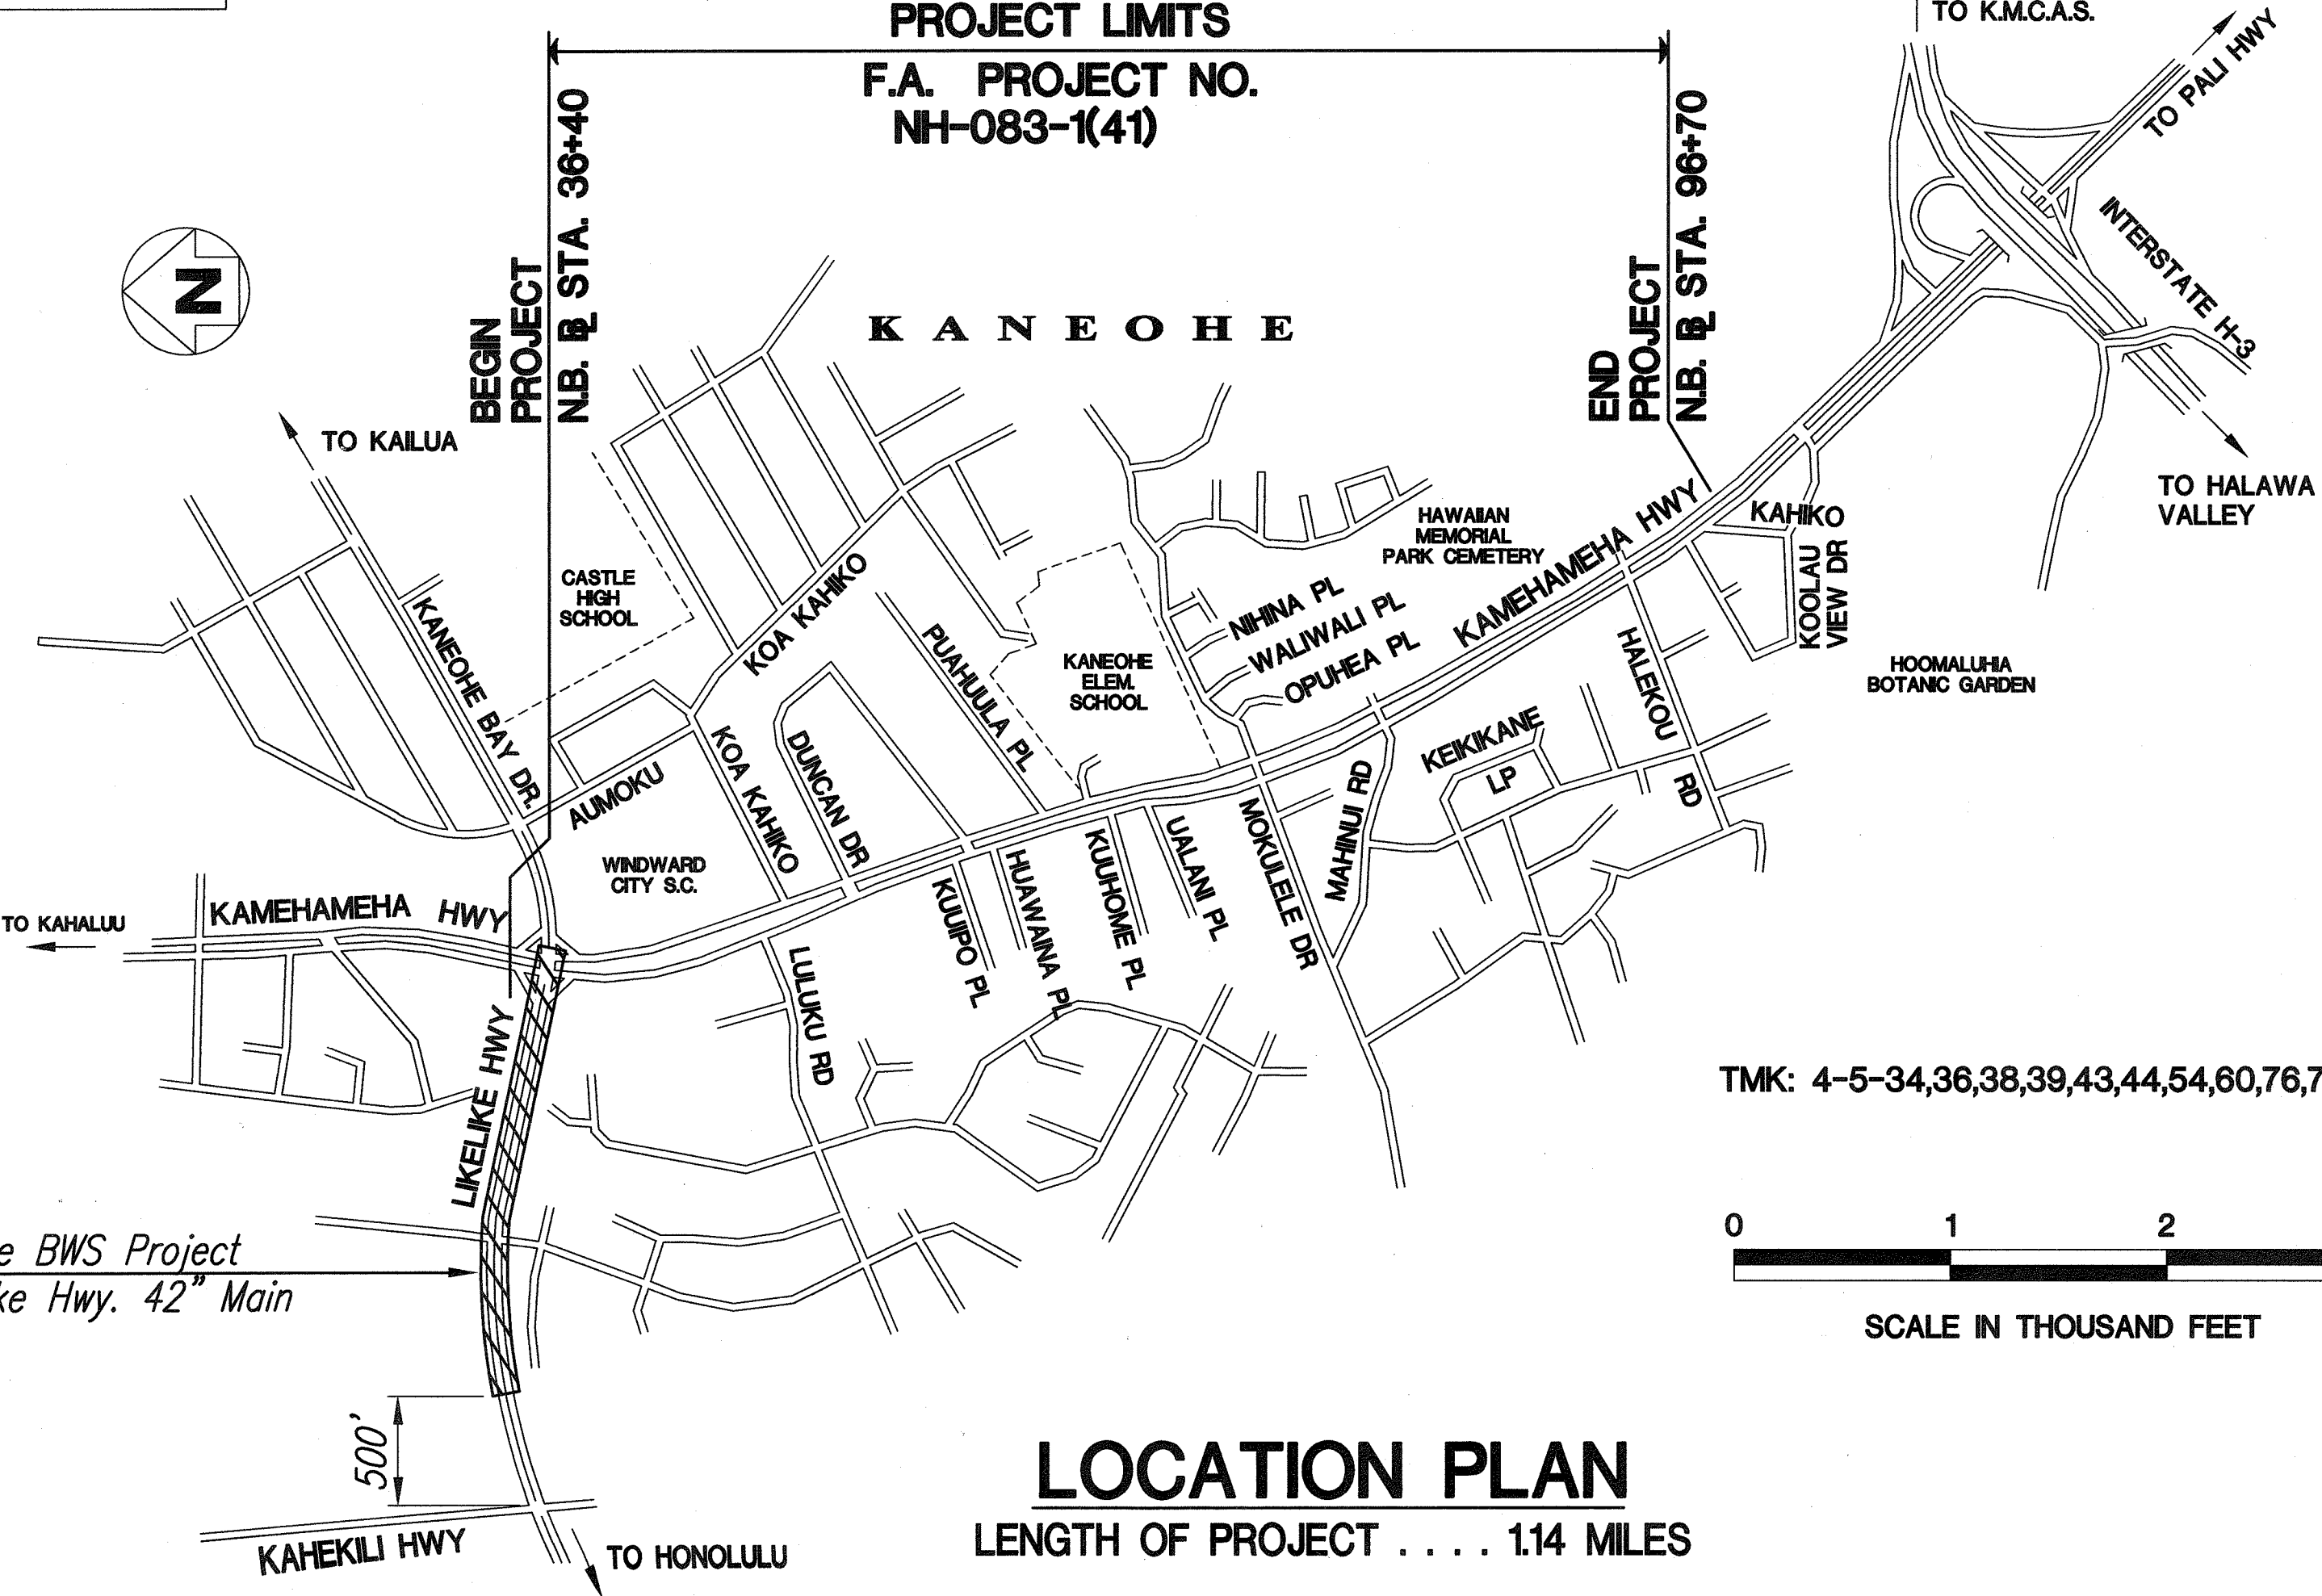

LOCATION PLAN

LENGTH OF PROJECT . . . 1.14 MILES

M&E Pacific, Inc. Jantine Urasaki 587-2630 7/23/99
DESIGNED BY P. S. & E. BY PHONE DATE

Future BWS Project
Likelike Hwy. 42" Main