




FED. ROAD DIST. NO.	STATE	PROJ. NO.	FISCAL YEAR	SHEET NO.	TOTAL SHEETS
HAWAII	HAW.	NH-083-1(46)	2002	86	89

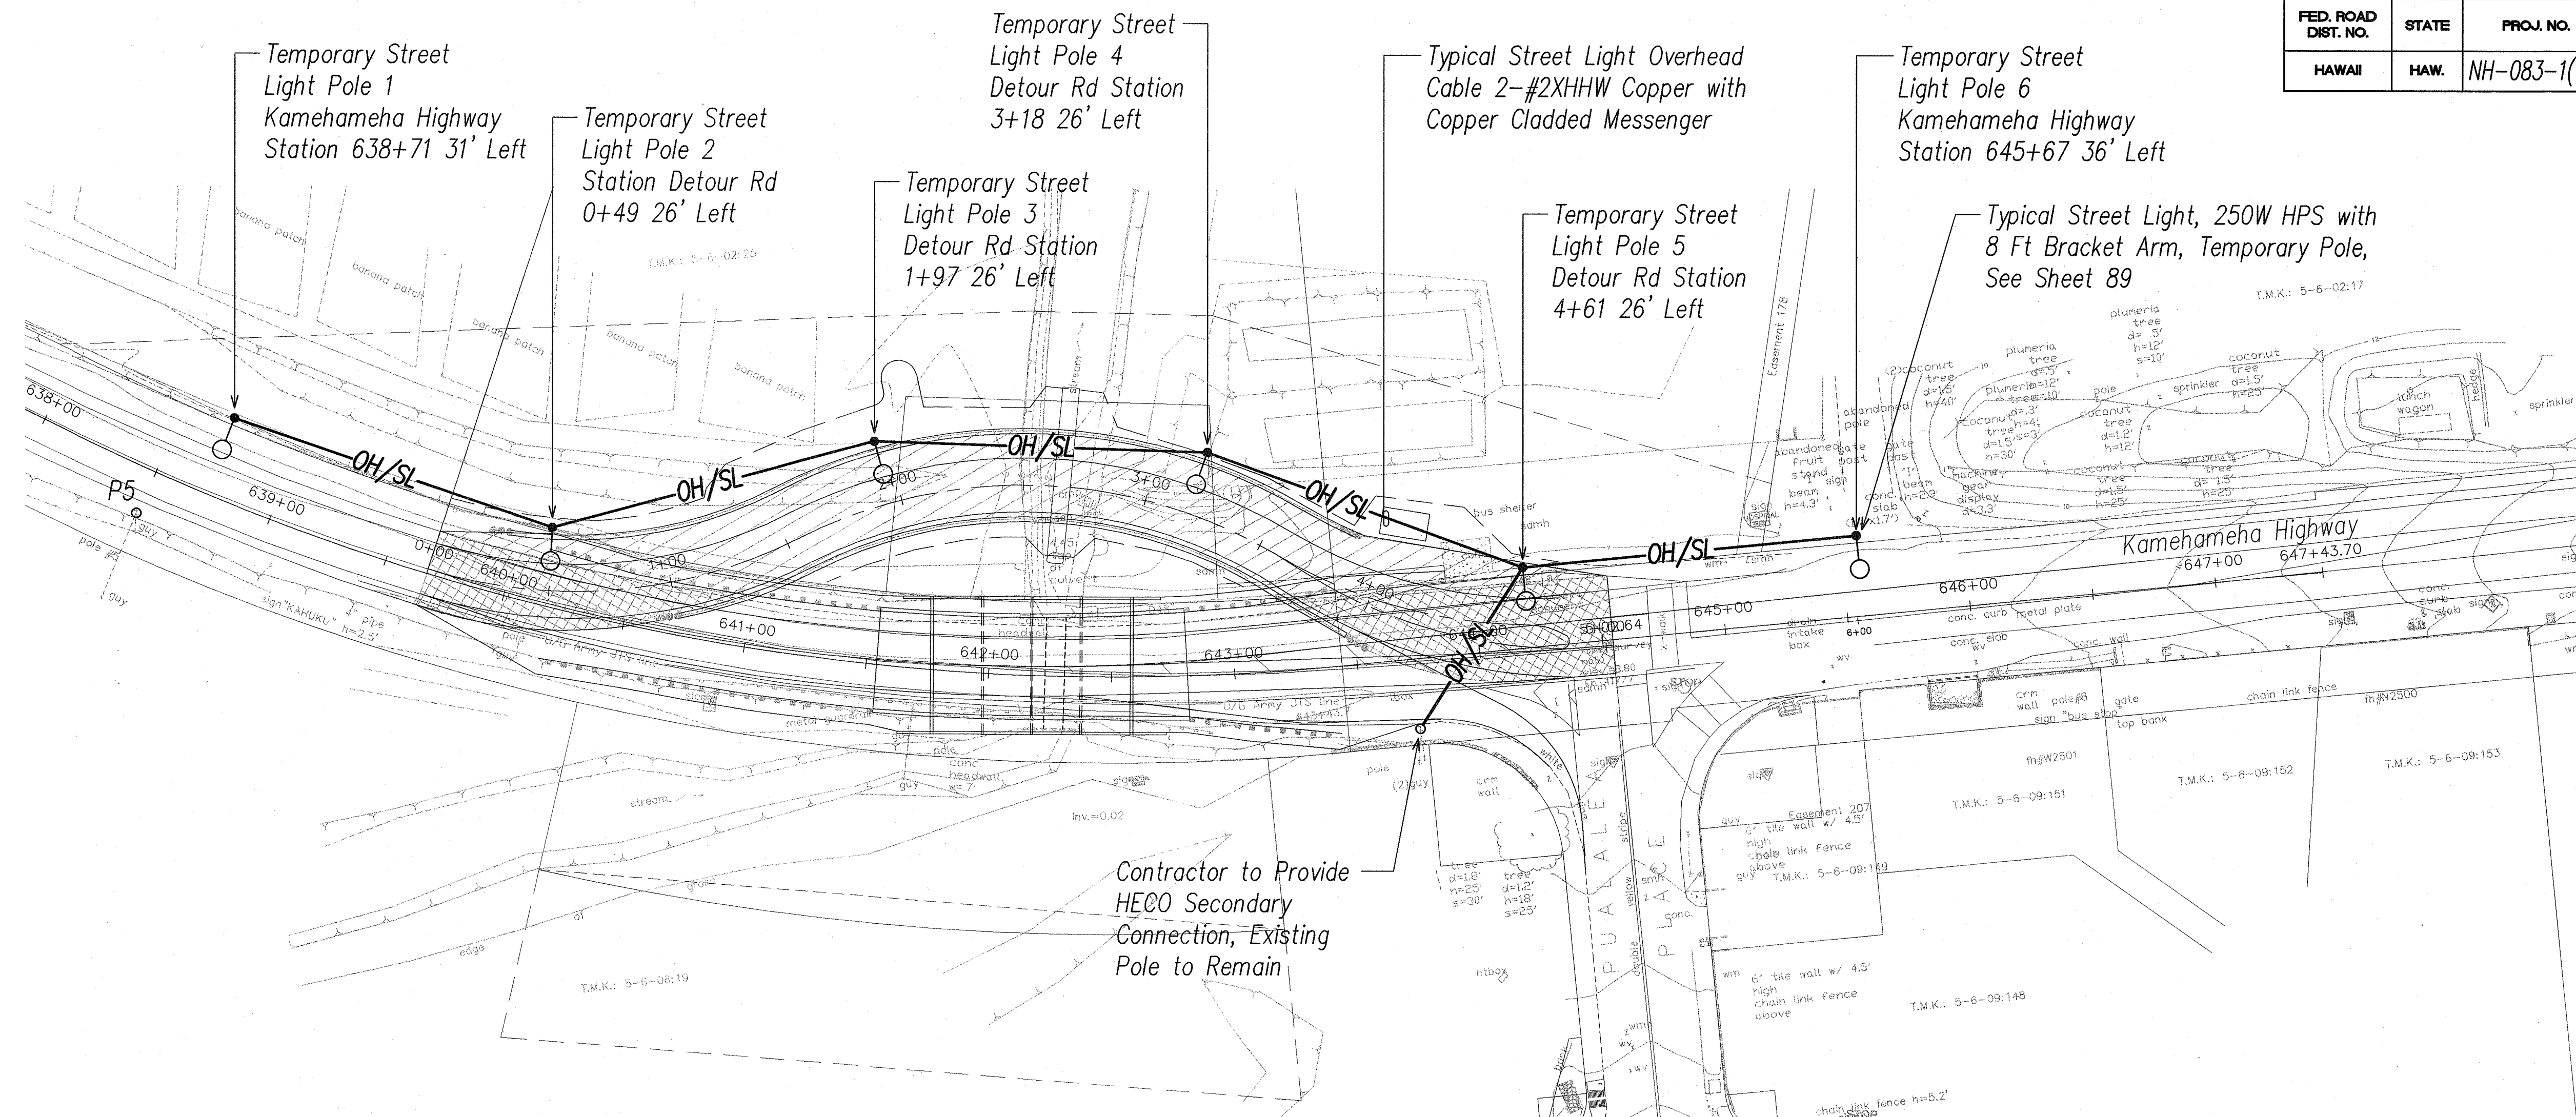

DETOUR ROAD TEMPORARY STREET LIGHTING PLAN @ KAHUKU HOSPITAL
SCALE: 1"=40'

ORIGINAL PLAN	SURVEY PLOTTED BY	DATE
TRACED BY		
NOTED BY		
CHECKED BY		
NO.		

LAST SAVE: 11/17/03 @ 16:17:15 BY: TE PLAT SC: 1=40
Z:\VADO\PROJECTS\23090\601_23090.dwg 2/26/03 2:02 PM

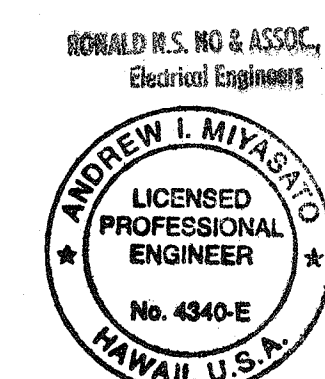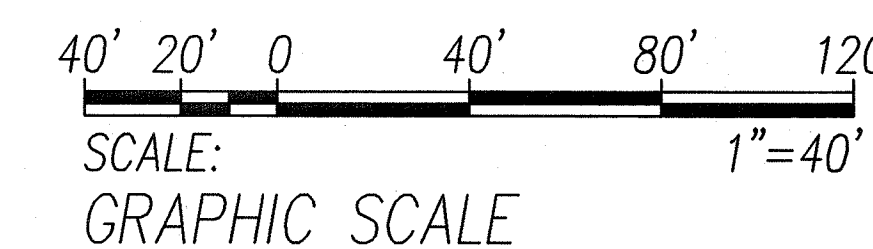

THIS WORK WAS PREPARED BY ME
OR UNDER MY SUPERVISION.
Andrew I. Miyasato
01.28.08

STATE OF HAWAII
DEPARTMENT OF TRANSPORTATION
HIGHWAYS DIVISION



**DETOUR ROAD TEMPORARY STREET
LIGHTING PLAN @ KAHUKU HOSPITAL**

KAMEHAMEHA HIGHWAY DRAINAGE IMPROVEMENTS
VICINITY OF KAHUKU HOSPITAL AND REPLACEMENT OF KII BRIDGE
Federal Aid Project No. NH-083-1(46)


Scale: AS NOTED Date: NOVEMBER 2003

SHEET No. E-1 OF 3 SHEETS

FED. ROAD DIST. NO.	STATE	PROJ. NO.	FISCAL YEAR	SHEET NO.	TOTAL SHEETS
HAWAII	HAW.	NH-083-1(46)	2002	87	89

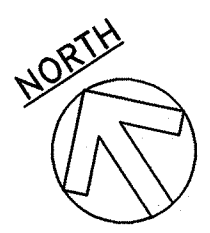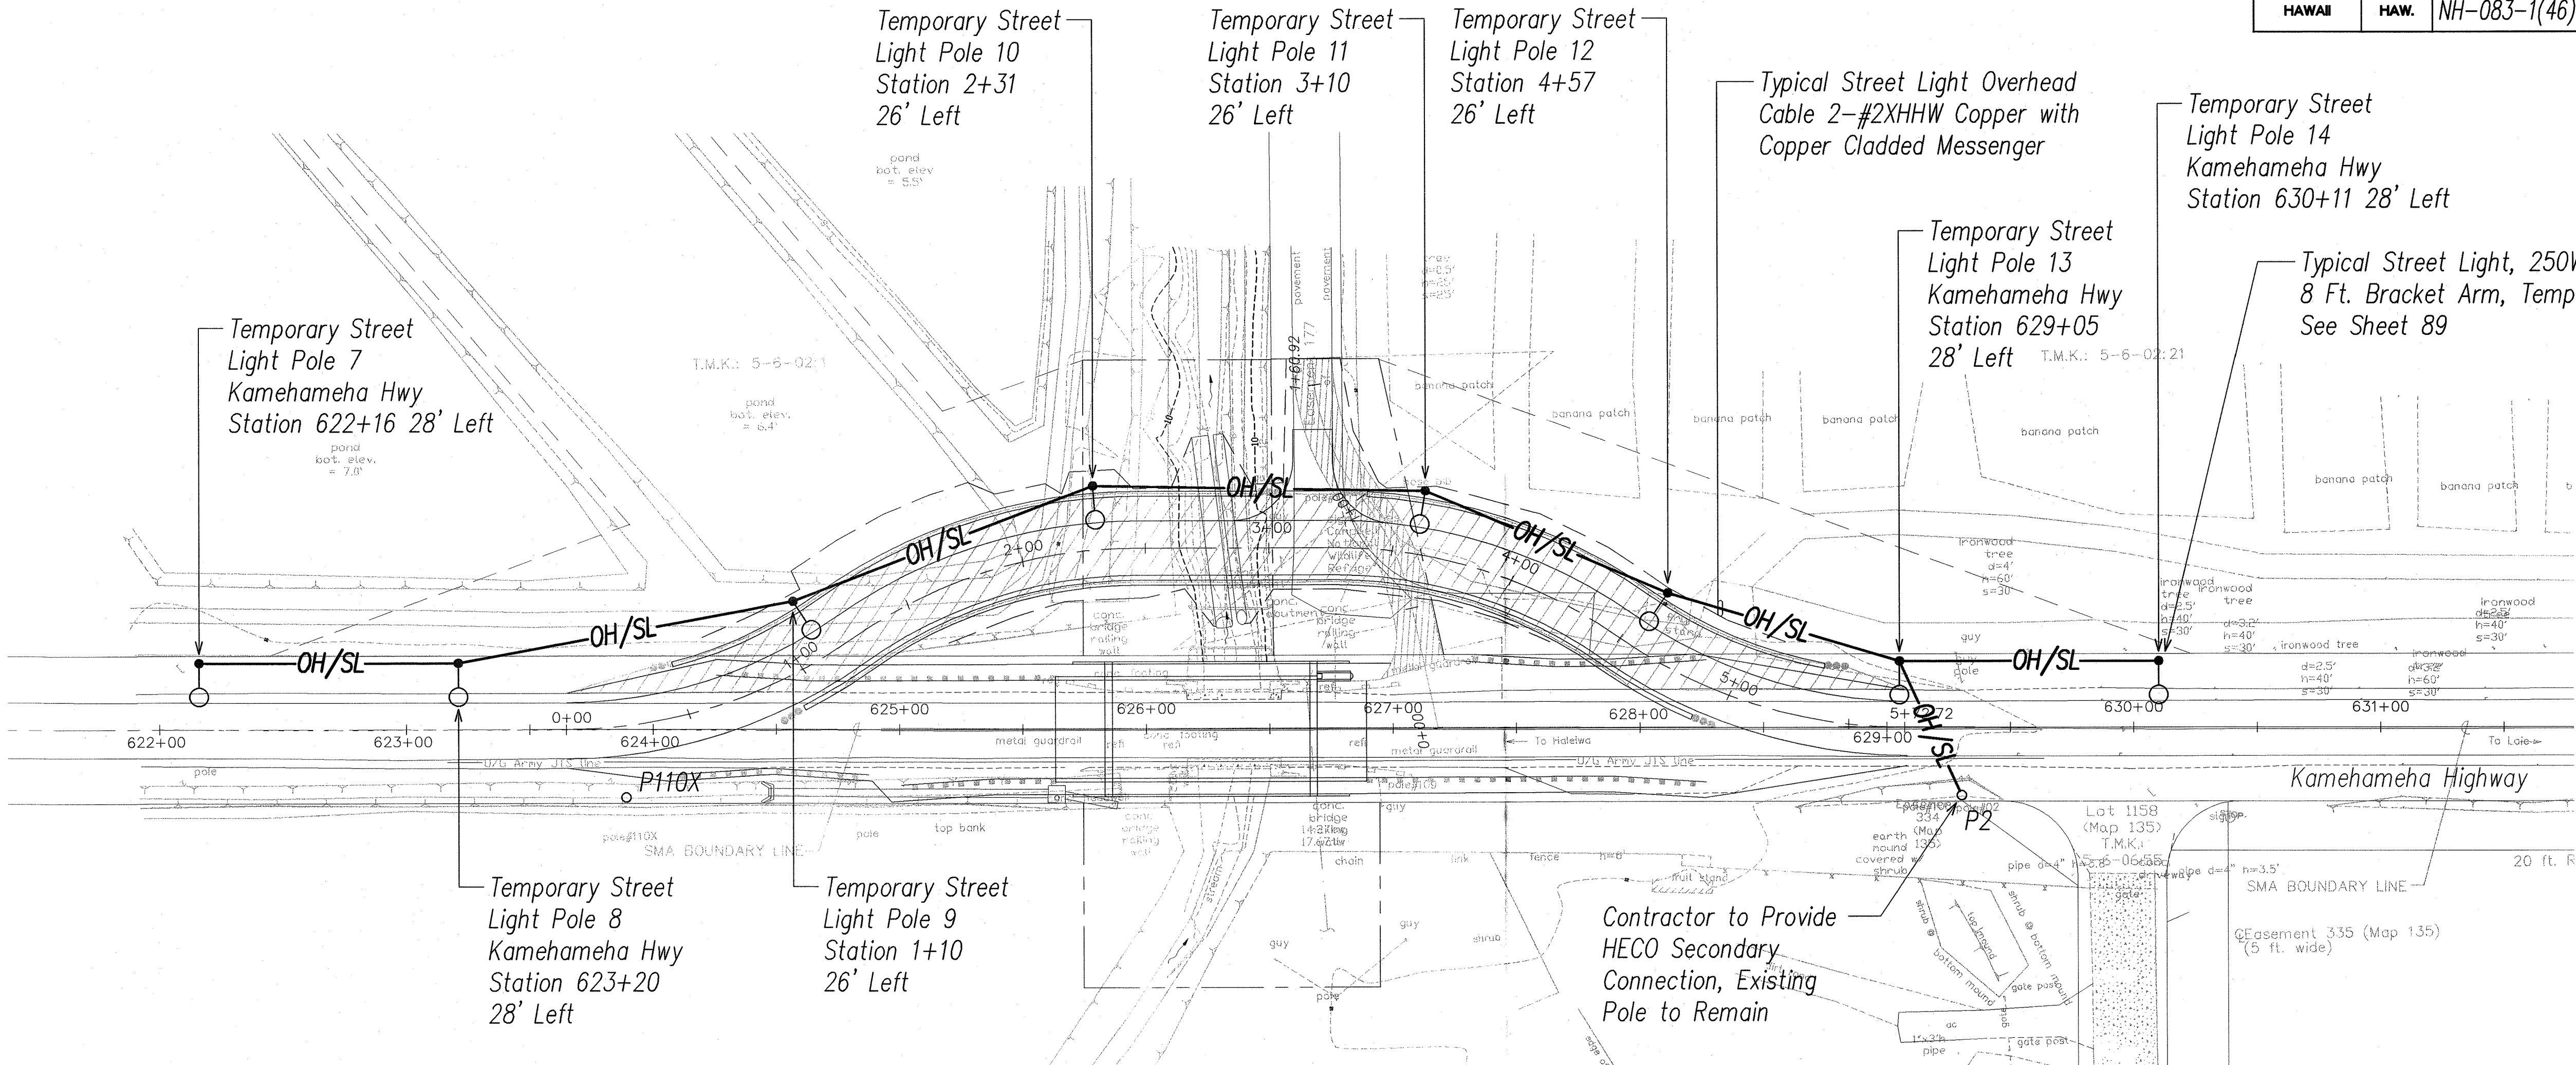

DETOUR ROAD TEMPORARY STREET LIGHTING PLAN @ KII BRIDGE
 SCALE: 1"=40'

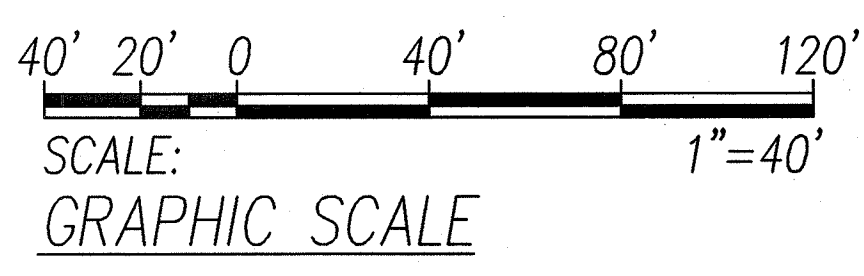

RONALD H.S. HO & ASSOC., INC.
 Electrical Engineers



THIS WORK WAS PREPARED BY ME
 OR UNDER MY SUPERVISION
Andrew I. Miyasato
 11-28-03

STATE OF HAWAII
 DEPARTMENT OF TRANSPORTATION
 HIGHWAYS DIVISION

**DETOUR ROAD TEMPORARY STREET
 LIGHTING PLAN @ KII BRIDGE**

KAMEHAMEHA HIGHWAY DRAINAGE IMPROVEMENTS
 VICINITY OF KAHUKU HOSPITAL AND REPLACEMENT OF KII BRIDGE
 Federal Aid Project No. NH-083-1(46)


Scale: AS NOTED Date: NOVEMBER 2003

SHEET No. E-2 OF 3 SHEETS

SURVEY PLOTTED BY	DATE
DRAWN BY	
TRACED BY	
CHECKED BY	
NOTE BOOK	
NO.	

LAST SAVE: 11/17/03 @ 16:01:35 BY: TE PLAT SC: 14-40
 Z:\ROAD PROJECTS\23090\02_23090.dwg XREFS: XSITE

FED. ROAD DIST. NO.	STATE	PROJ. NO.	FISCAL YEAR	SHEET NO.	TOTAL SHEETS
HAWAII	HAW.	NH-083-1(46)	2002	88	89

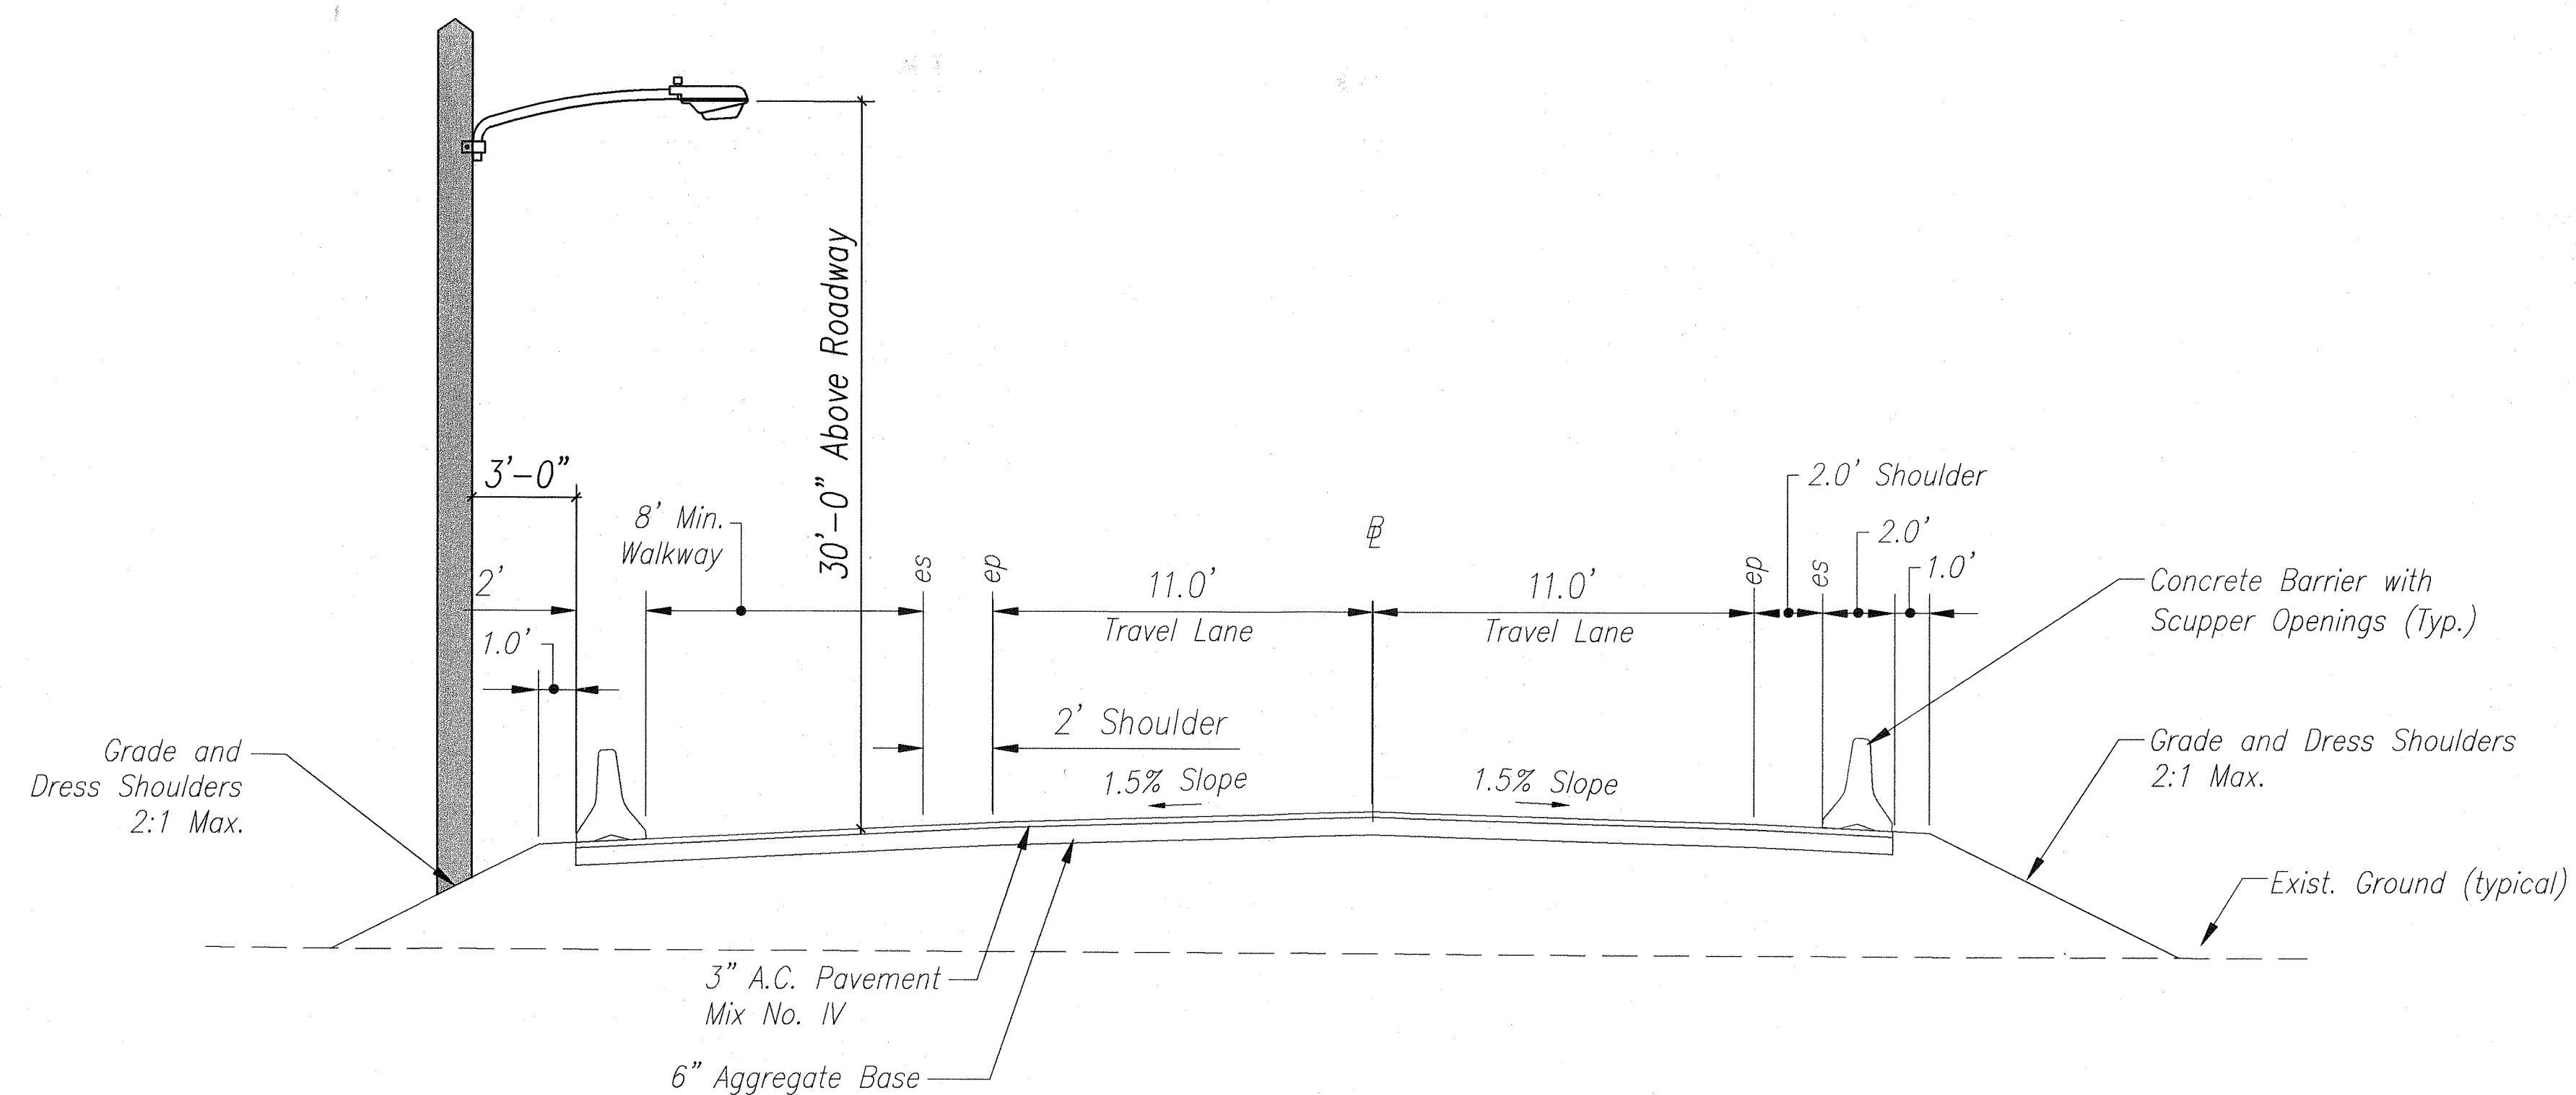

DETOUR ROAD SECTION STREET LIGHT TYPICAL LOCATION
NOT TO SCALE

ORIGINAL PLAN	DATE
DRAWN BY	
TRACED BY	
NOTED BY	
CHECKED BY	
DATE	

LAST SAVE: 11/17/03 @ 15:50:17 BY: TE PLOT SC 1/4"=1'
Z:\ACAD\PROJECTS\239901\03_239901.dwg 239901.dwg

RONALD H.S. PRO & ASSOC., INC.
Electrical Engineers



THIS WORK WAS PREPARED BY ME
OR UNDER MY SUPERVISION.
Andrew L. Miyahara
101.28.08

STATE OF HAWAII
DEPARTMENT OF TRANSPORTATION
HIGHWAYS DIVISION

DETOUR ROAD SECTION STREET
LIGHT TYPICAL LOCATION

KAMEHAMEHA HIGHWAY DRAINAGE IMPROVEMENTS
VICINITY OF KAHUKU HOSPITAL AND REPLACEMENT OF KII BRIDGE

Federal Aid Project No. NH-083-1(16)

Scale: AS NOTED Date: NOVEMBER 2003

SHEET No. E-3 OF 3 SHEETS