

INDEX TO DRAWINGS	
SHEET NO.	DESCRIPTION
1	TITLE SHEET
2	STANDARD PLANS SUMMARY
3 - 4	GENERAL NOTES AND CONSTRUCTION NOTES
5 - 6	UTILITY NOTES
7 - 8	WATER POLLUTION & EROSION CONTROL NOTES
9	TYPICAL SECTIONS AND LEGEND
10	KII BRIDGE PLAN & PROFILE
11	KII BRIDGE DETOUR ROAD PLAN & PROFILE
12	KII STREAM IMPROVEMENTS PLAN
13	KII BRIDGE DRAINAGE & SUBDRAIN PLAN
14	WWTP ACCESS ROAD PLAN, PROFILE & SECTION
15	HOSPITAL CULVERT PLAN & PROFILE
16	HOSPITAL CULVERT DETOUR ROAD PLAN & PROFILE
17	HOSPITAL CULVERT SUPERELEVATION PLAN
18	HOSPITAL CULVERT DETOUR ROAD SUPERELEVATION PLAN
19	HOSPITAL CULVERT STREAM IMPROVEMENTS PLAN
20	HOSPITAL CULVERT DRAINAGE & SUBDRAIN PLAN
21	KII BRIDGE CONSTRUCTION SEQUENCE PLAN
22	HOSPITAL CULVERT CONSTRUCTION SEQUENCE PLAN
23	BUS SHELTER DETAILS
24 - 26	DRAIN MANHOLE PLANS
27 - 67	STRUCTURAL PLANS
68 - 72	GEOTECHNICAL PLANS
73	GUARDRAIL DETAILS & NOTES
74	THREE BEAM AND APPURTENANCE DETAILS
75	STRONG POST W-BEAM GUARDRAIL
76	GUARDRAIL TERMINAL CONNECTORS AND END SECTIONS
77 - 78	PORTABLE CONCRETE BARRIER
79	FLEAT-350
80	PAVEMENT MARKERS LEGEND & NOTES
81	KII BRIDGE SIGNING & STRIPING PLAN
82	KII BRIDGE DETOUR SIGNING & STRIPING PLAN
83	HOSPITAL CULVERT SIGNING & STRIPING PLAN
84	HOSPITAL CULVERT DETOUR SIGNING & STRIPING PLAN
85	TRAFFIC & PAVEMENT MARKING SUMMARIES
86 - 88	ELECTRICAL PLANS
89	TEMPORARY STREET LIGHT DETAIL

WESLEY R. SEGAWA  
& ASSOCIATES, INC.  
DESIGNED BY

S. URADA  
P. S. & E. BY


692-7553  
PHONE

JULY 2004  
DATE


STATE OF HAWAII  
DEPARTMENT OF TRANSPORTATION  
HIGHWAYS DIVISION  
HONOLULU, HAWAII

PLANS FOR  
KAMEHAMEHA HIGHWAY DRAINAGE IMPROVEMENTS  
VICINITY OF KAHUKU HOSPITAL AND REPLACEMENT OF KII BRIDGE  
FEDERAL AID PROJECT NO. NH-083-1(46)

DISTRICT OF KOOLAULOA  
ISLAND OF OAHU

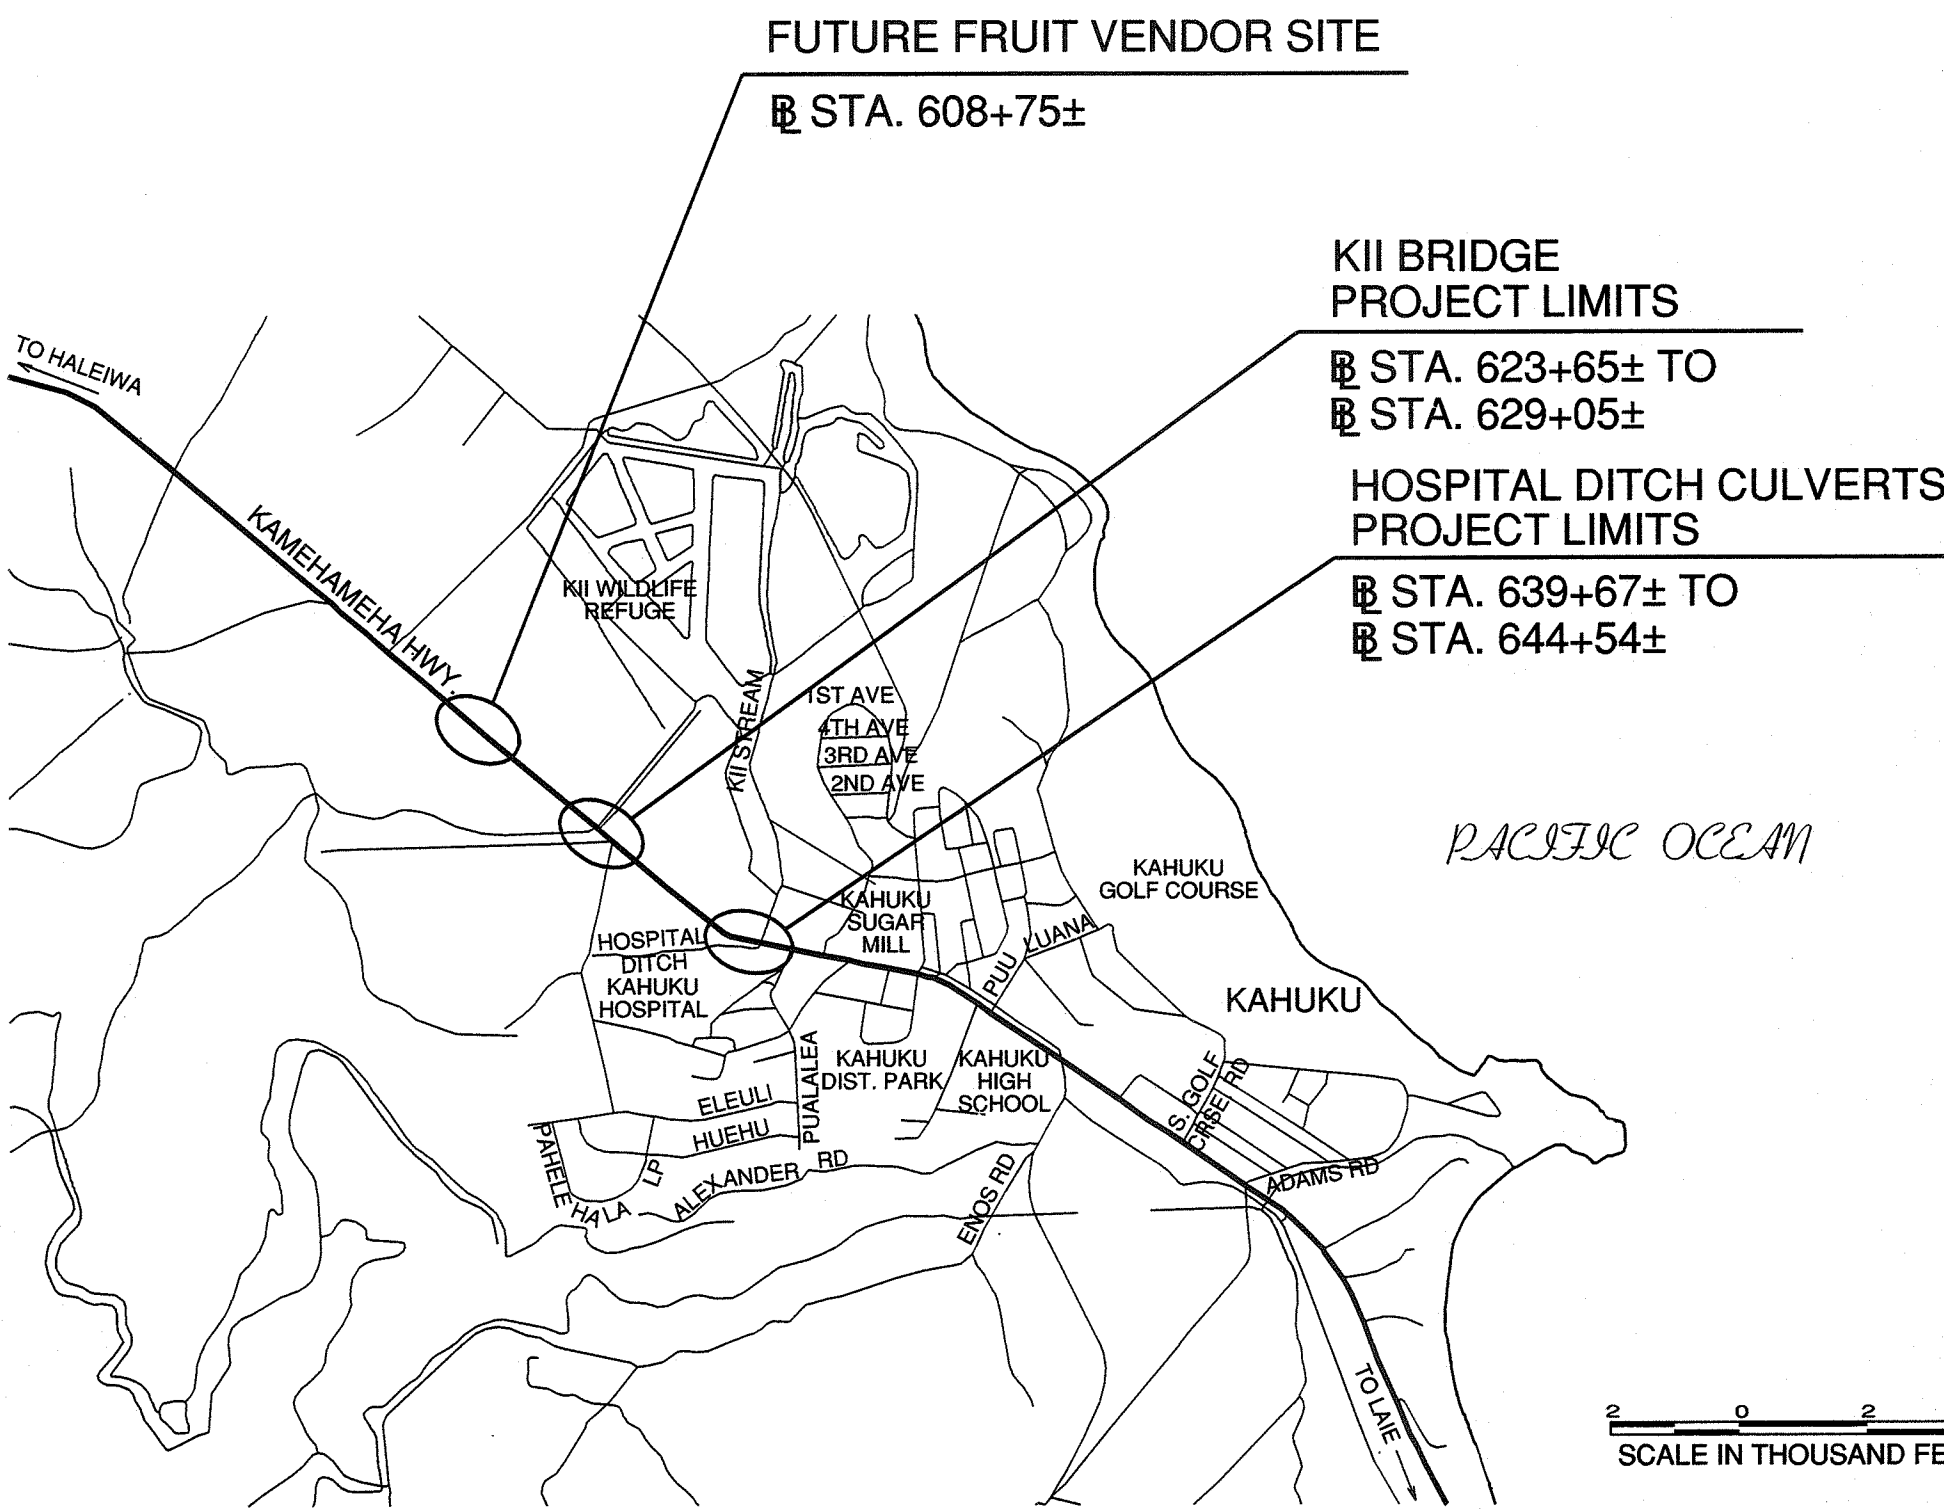

LAYOUT PLAN  
GROSS LENGTH OF PROJECT..... 0.31 MILES  
NET LENGTH OF PROJECT..... 0.31 MILES

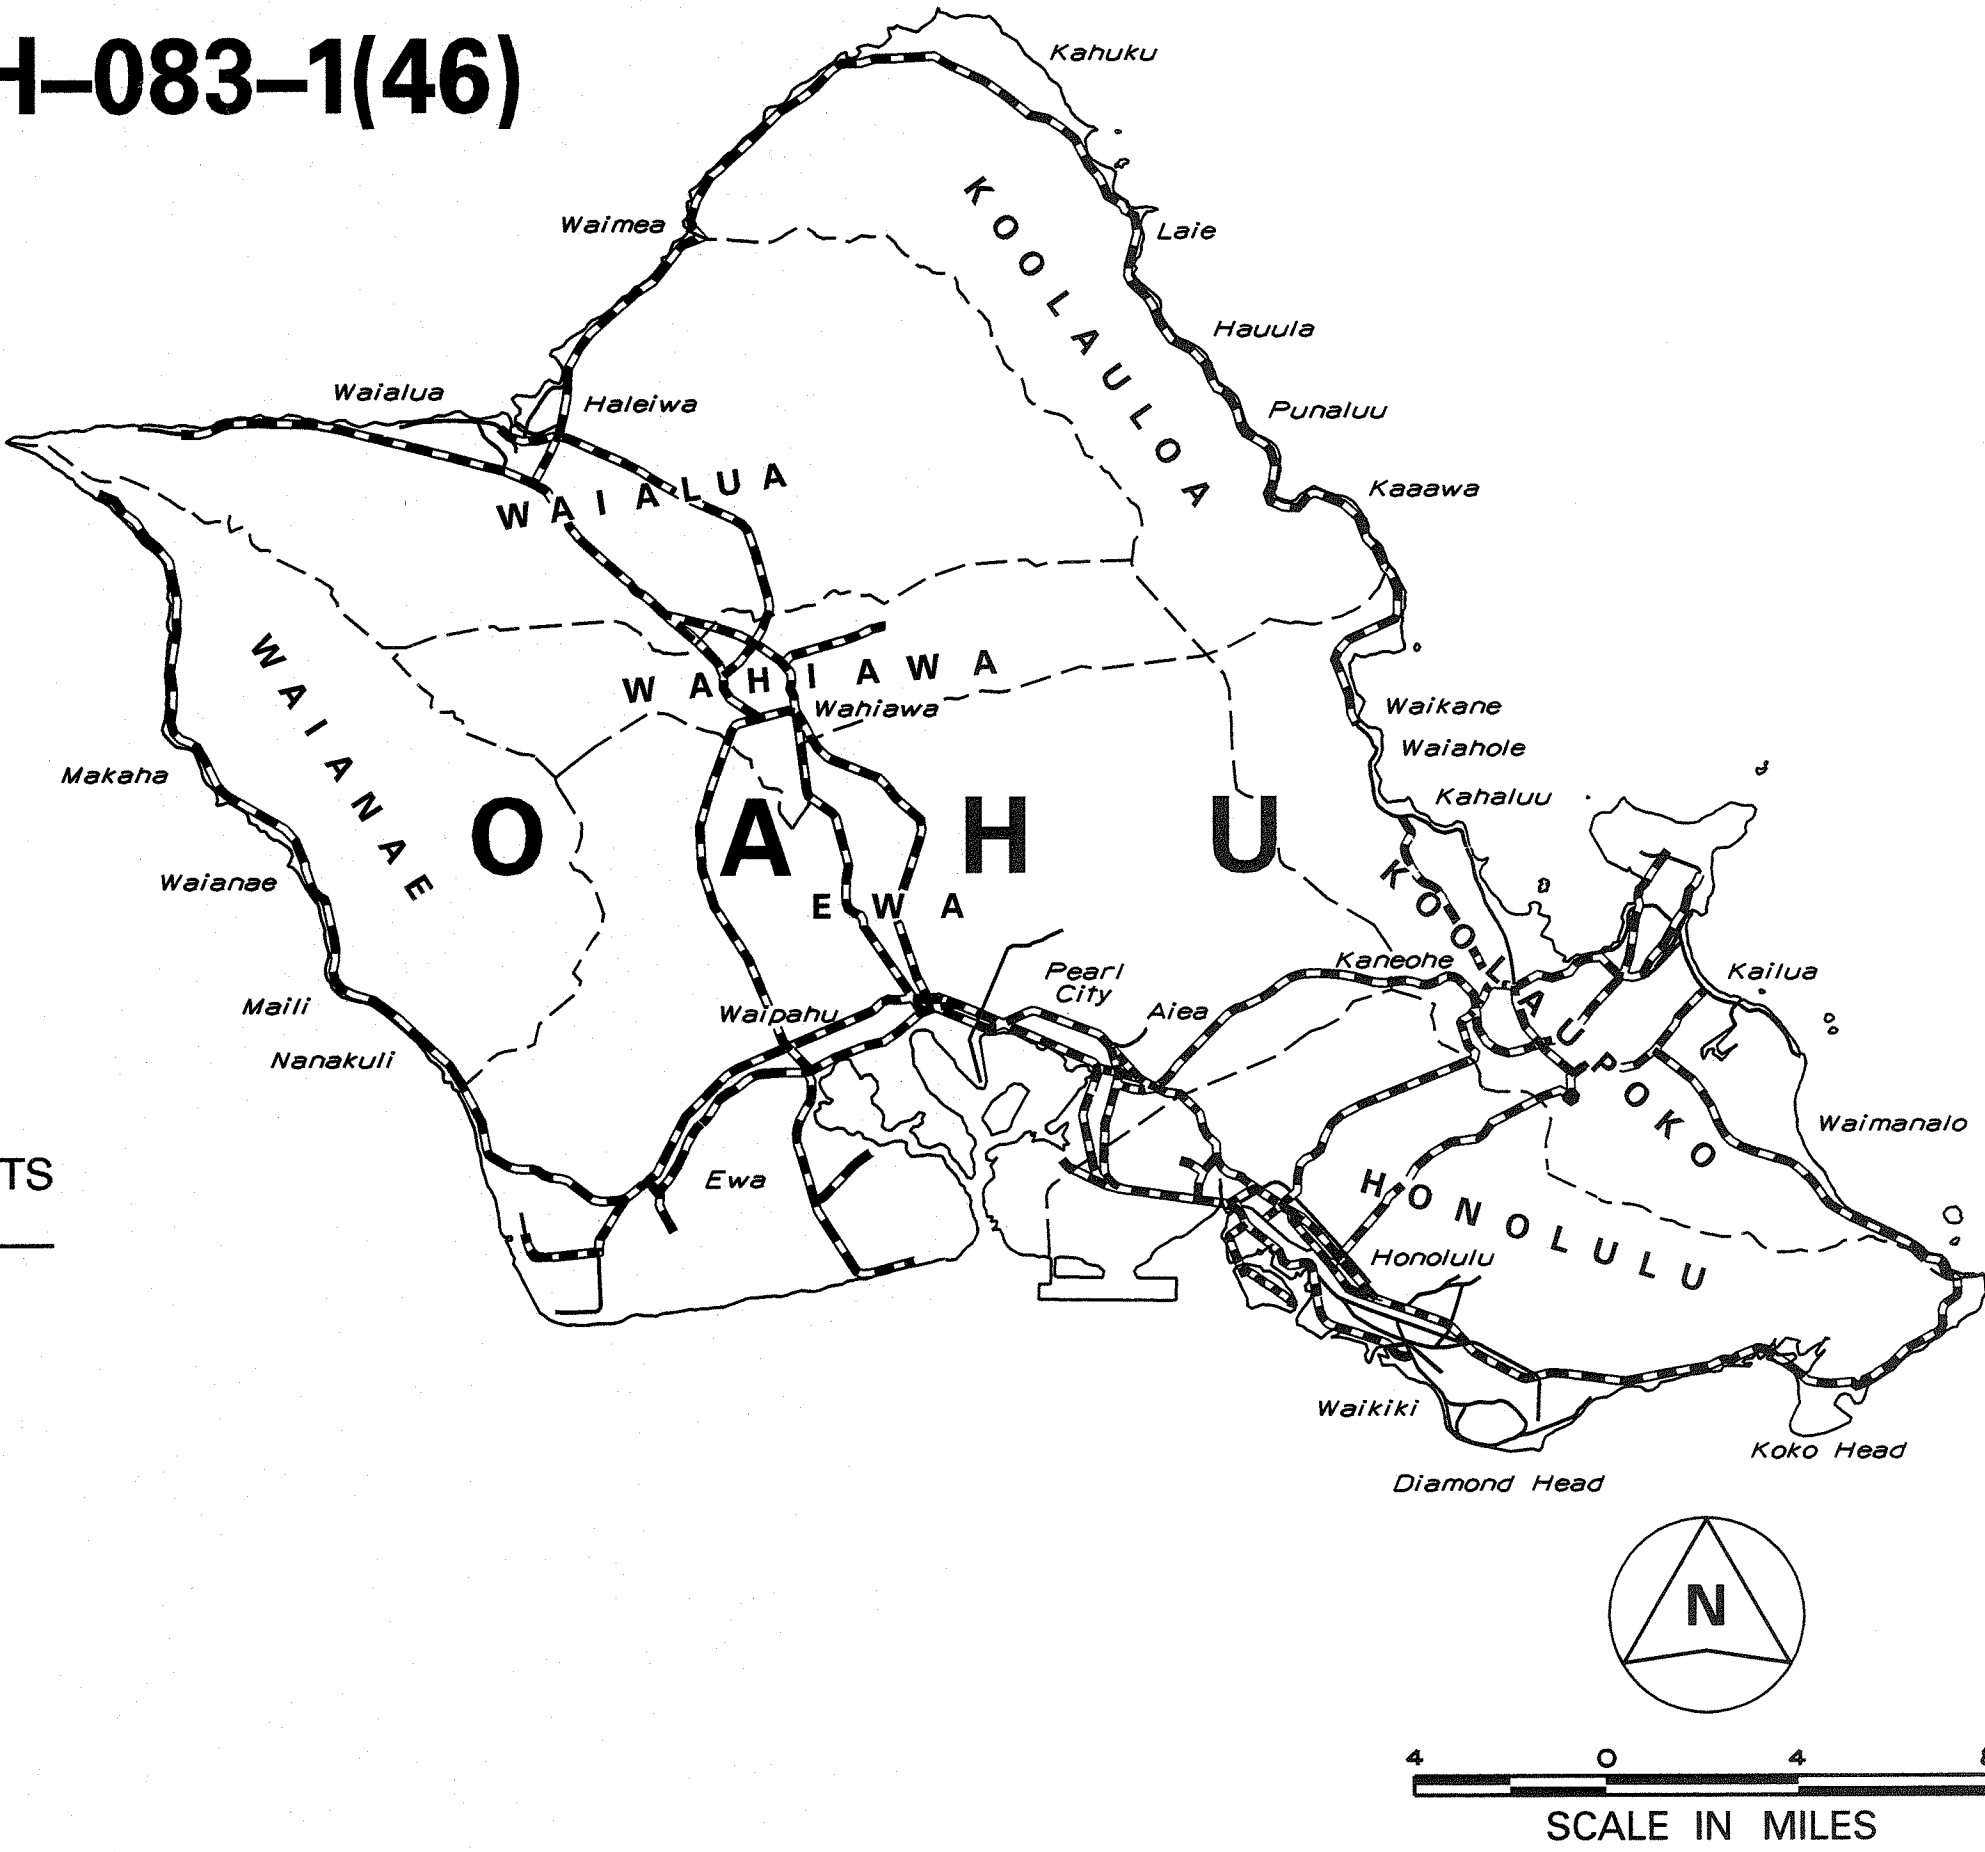

DESIGN DESIGNATION

ADT (2002)..... 6,600  
ADT (2022)..... 7,600  
DHV..... 700  
D..... 55/45  
T..... 4.0 %  
T<sub>24</sub>..... 4.5 %  
K..... 9.0  
V..... 45 M.P.H.

FEDERAL AID INTERSTATE PROJECTS PREVIOUSLY  
CONSTRUCTED OR UNDER CONSTRUCTION

MILE POST 15.04 TO MILE POST 15.35

DEPARTMENT OF TRANSPORTATION  
STATE OF HAWAII  
APPROVED:  
DIR. OF TRANSPORTATION DATE