





INDEX TO DRAWINGS	
SHEET NO.	DESCRIPTION
1	TITLE SHEET
2	STANDARD PLANS SUMMARY
3-7	CONSTRUCTION NOTES
8-9	TYPICAL ROADWAY SECTIONS
10-13	SITE PLANS
14	DRAINAGE PROFILE
15-20	DRAINAGE DETAILS
21-22	MISCELLANEOUS DETAILS
23-27	TRAFFIC CONTROL PLANS
28-29	HIGHWAY LIGHTING PLANS
30-37	LANDSCAPE IRRIGATION
38-47	LANDSCAPE PLANTING
48-71	STRUCTURAL PLANS AND DETAILS
72-78	ARCHITECTURAL WALL TREATMENT

STATE OF HAWAII
DEPARTMENT OF TRANSPORTATION
HIGHWAYS DIVISION


HONOLULU, HAWAII

PLANS FOR
KAHEKILI HIGHWAY LANDSCAPING
VICINITY OF KULUKEOE STREET TO HAIKU ROAD
FEDERAL AID PROJ. NO. NH-083-1(49)
DISTRICT OF KOOLAUPOKO
ISLAND OF OAHU

FED. ROAD DIST. NO.	STATE	PROJ. NO.	FISCAL YEAR	SHEET NO.	TOTAL SHEETS
HAWAII	HAW.	NH-083-1(49)	2003	1	78

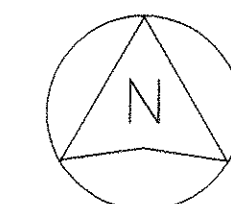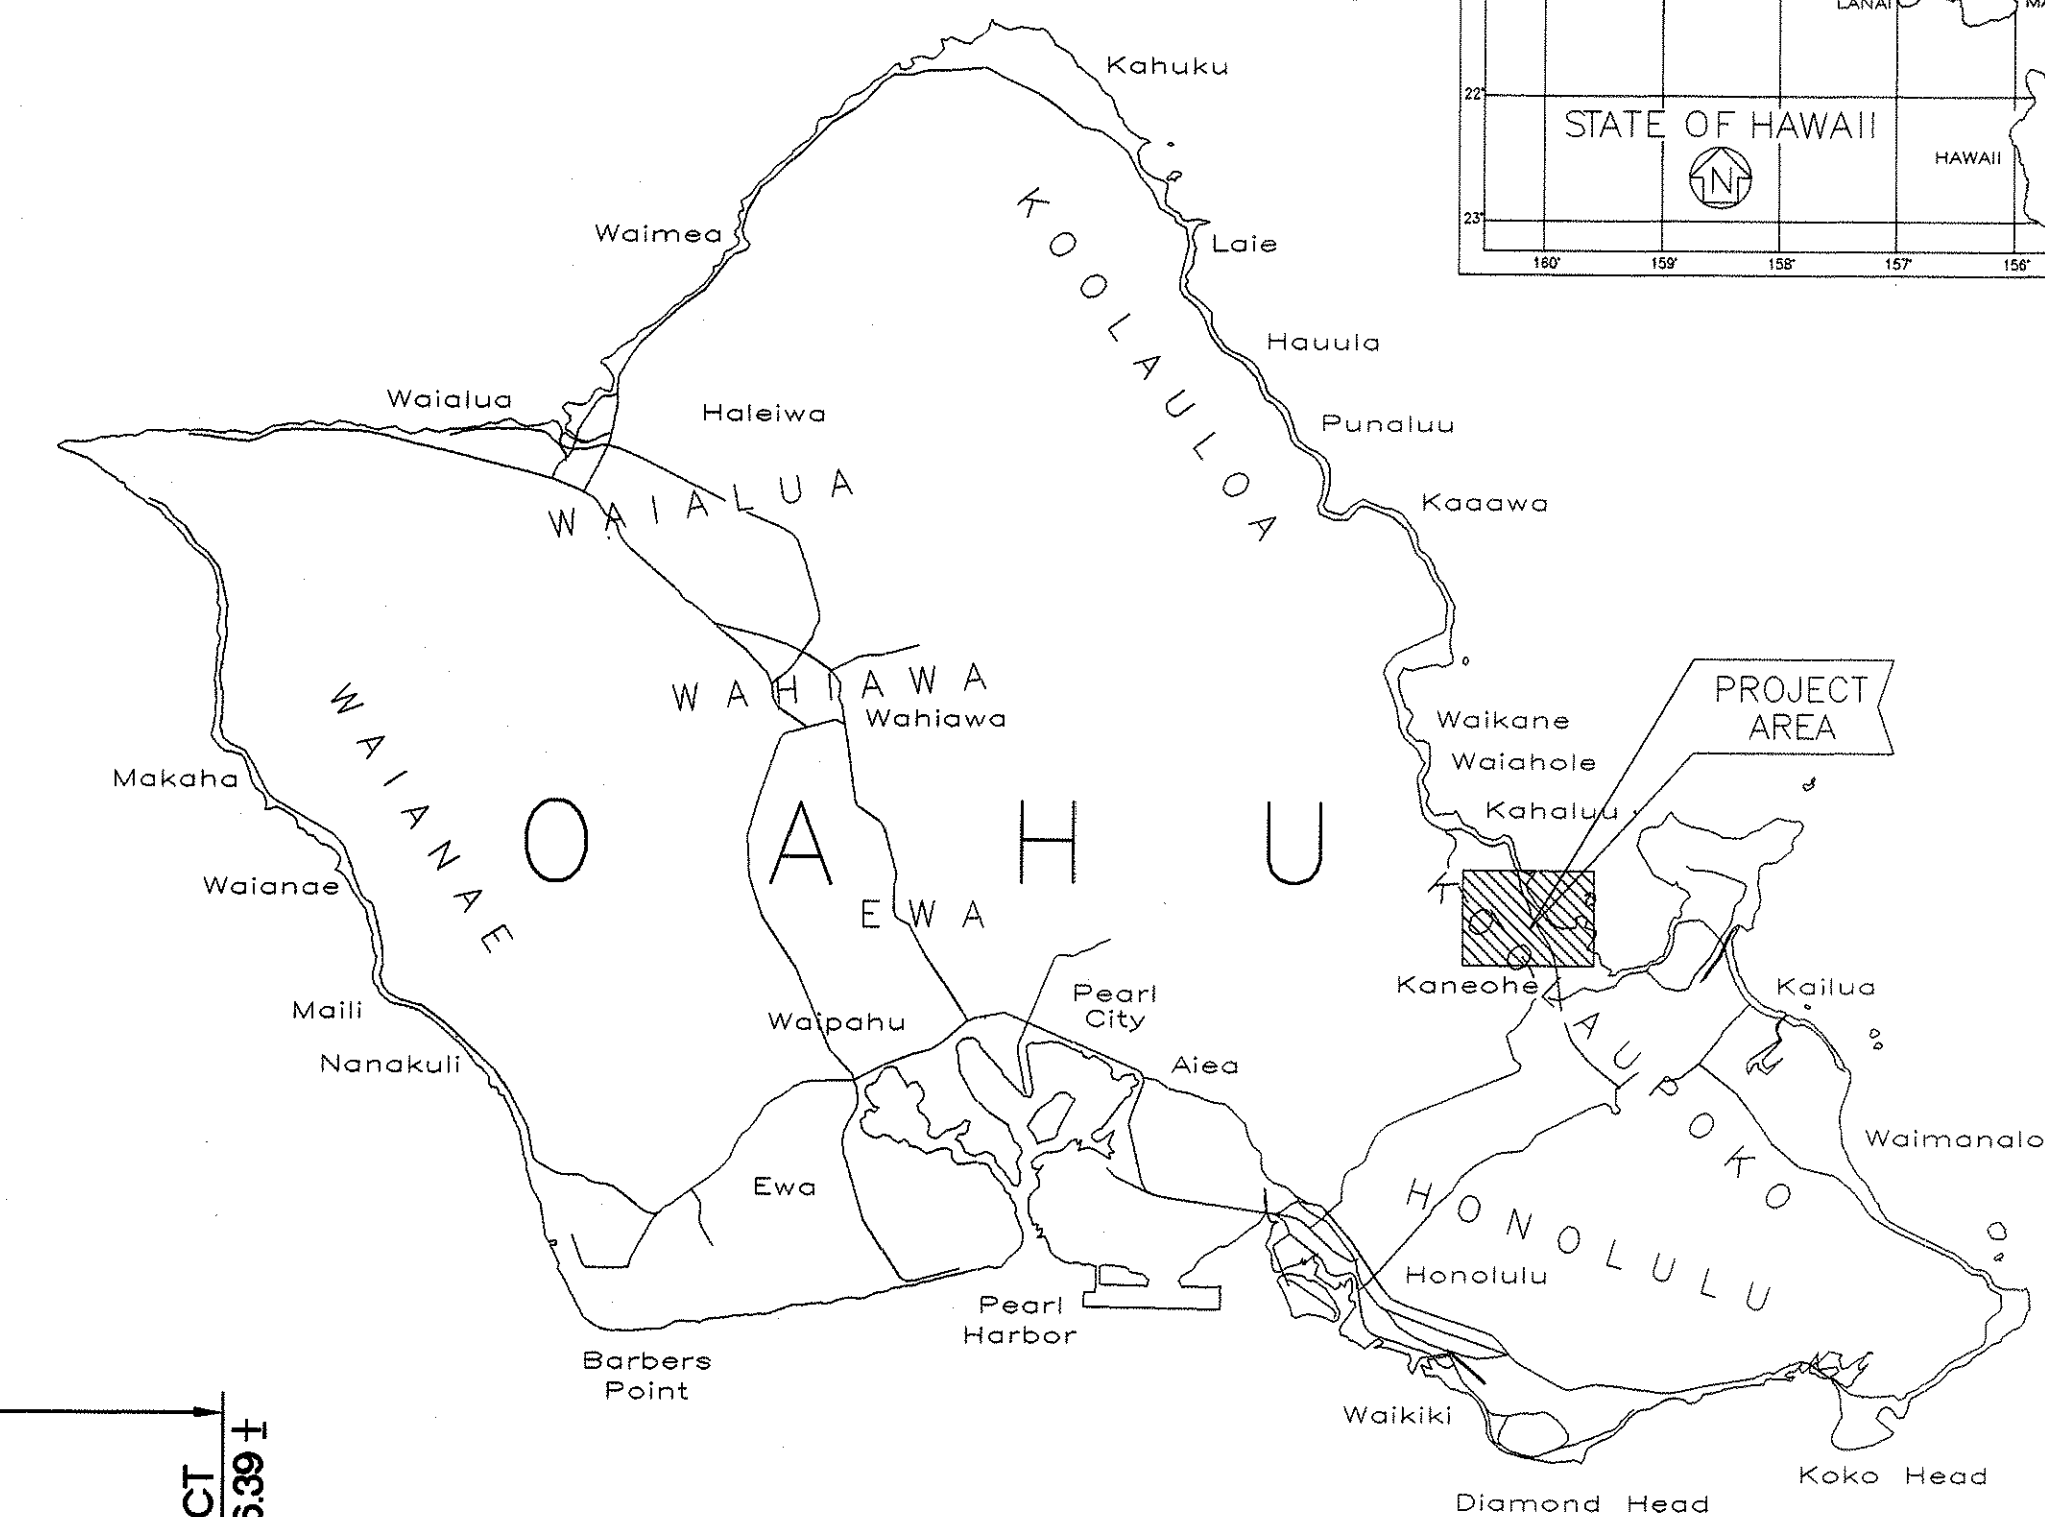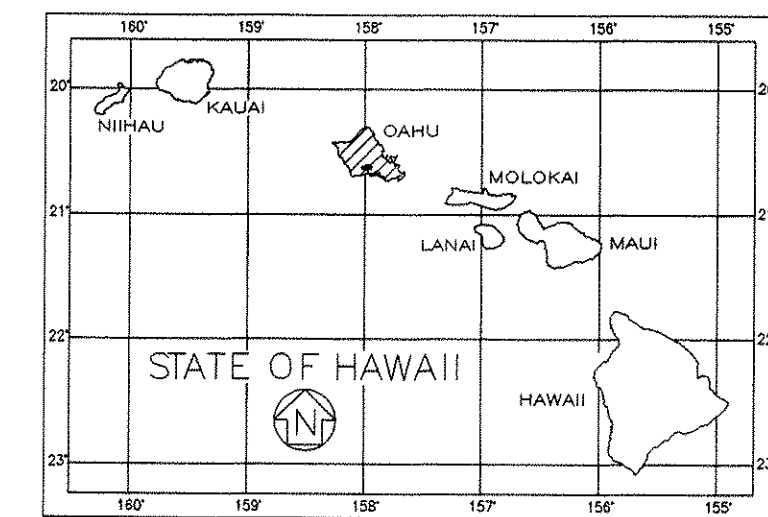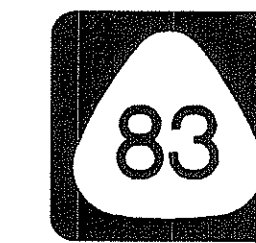

SCALE IN MILES
MILE POST 40.46 TO MILE POST 39.59

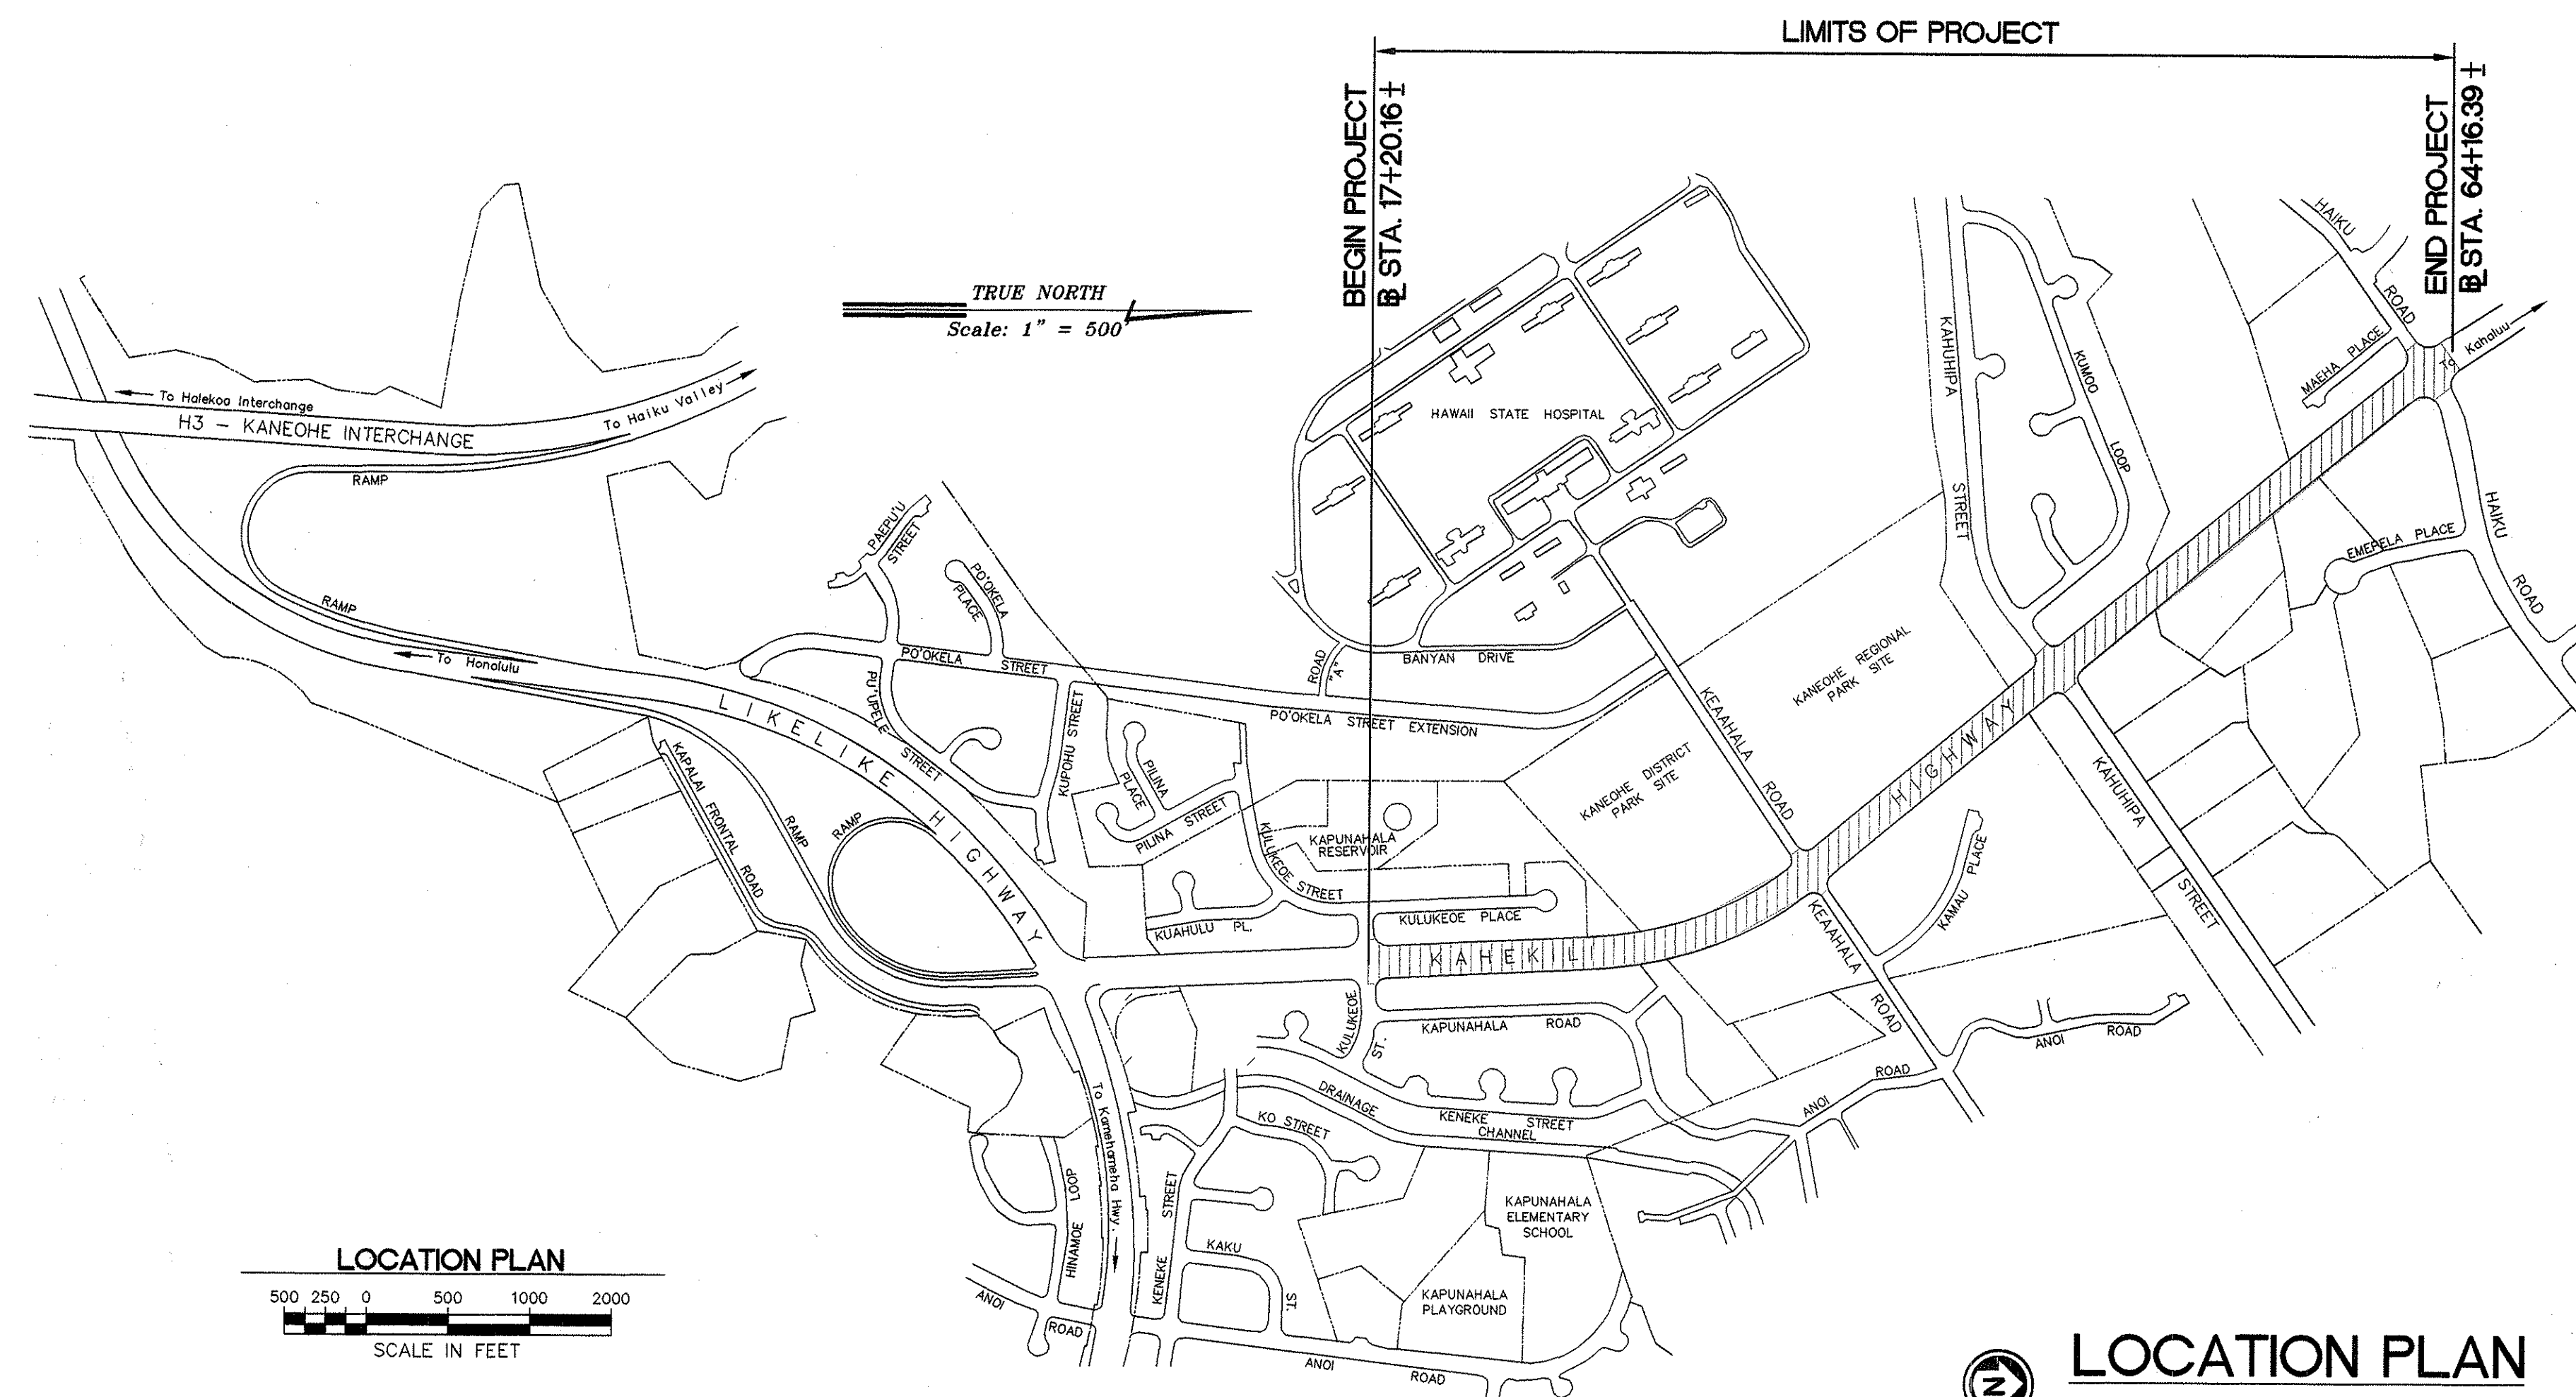

LOCATION PLAN

GROSS LENGTH OF PROJECT..... 0.894 MILES

DEPARTMENT OF TRANSPORTATION STATE OF HAWAII	
APPROVED:	
<i>Deane M. Jaramila</i>	8/9/02
DIR. OF TRANSPORTATION	DATE

SURVEY PLOTTED BY	DATE
DRAWN BY	
CHECKED BY	
NOTED BY	
QUANTITIES BY	
CHECKED BY	

HAWAII DESIGN ASSOCIATES, INC.
DESIGNED BY: H. KENNEDY
P.S. & E BY: P.S. & E BY
692-7550
APRIL 2002
DATE