

SURVEY PLOTTED BY	DATE
DRAWN BY	
INCHES BY	
NOTES BY	
CHECKED BY	
NO.	


FILE: DOT95101  
 SCALE: 1"=1  
 BEG: 03/06/97

PM: STY  
 OPER: CKY,STY,RCQ,RMK,MNN,MSM,\*CKM  
 REVISED: 3/24/00

AKINAKA & ASSOCIATES, LTD. DESIGNED BY  
 CRAIG WATANABE  
 P.S. & E. BY  
 APRIL 2000  
 DATE

692-7551  
 PHONE

INDEX TO DRAWINGS	
SHEET NO.	DESCRIPTION
1	TITLE SHEET
2	STATE STANDARD PLANS SUMMARY
3	COUNTY STANDARD DETAILS LIST
4	GENERAL NOTES AND LEGEND
5	CONSTRUCTION NOTES
6	BWS WATER NOTES
7 - 8	GENERAL PLAN
9 - 10	BORING LOGS & GEOTECHNICAL ENGINEER'S NOTES
11 - 12	TYPICAL ROAD SECTIONS
13 - 15	ROAD PLAN & PROFILE
16	CURB RETURN GRADES
17	CURB RAMP DETAILS
18 - 19	DRIVEWAY DETAILS
20	MISCELLANEOUS DETAILS
21 - 24	DRAINAGE PLAN & PROFILE AND DETAILS
25 - 33	BWS - REPLACEMENT OF 16 INCH MAIN, PHASE 1 PLANS
34 - 35	EROSION CONTROL PLAN, NOTES AND DETAILS
36 - 37	SIGNING & PAVEMENT MARKING NOTES & DETAILS
38 - 40	SIGNING & STRIPING PLAN
41 - 45	CROSS SECTIONS
46	CONSTRUCTION PHASING NOTES, DETAIL, LEGEND
47 - 55	CONSTRUCTION PHASING PLANS
56 - 64	STRUCTURAL PLANS
65 - 106	ELECTRICAL PLANS
107 - 110	LANDSCAPE PLANS

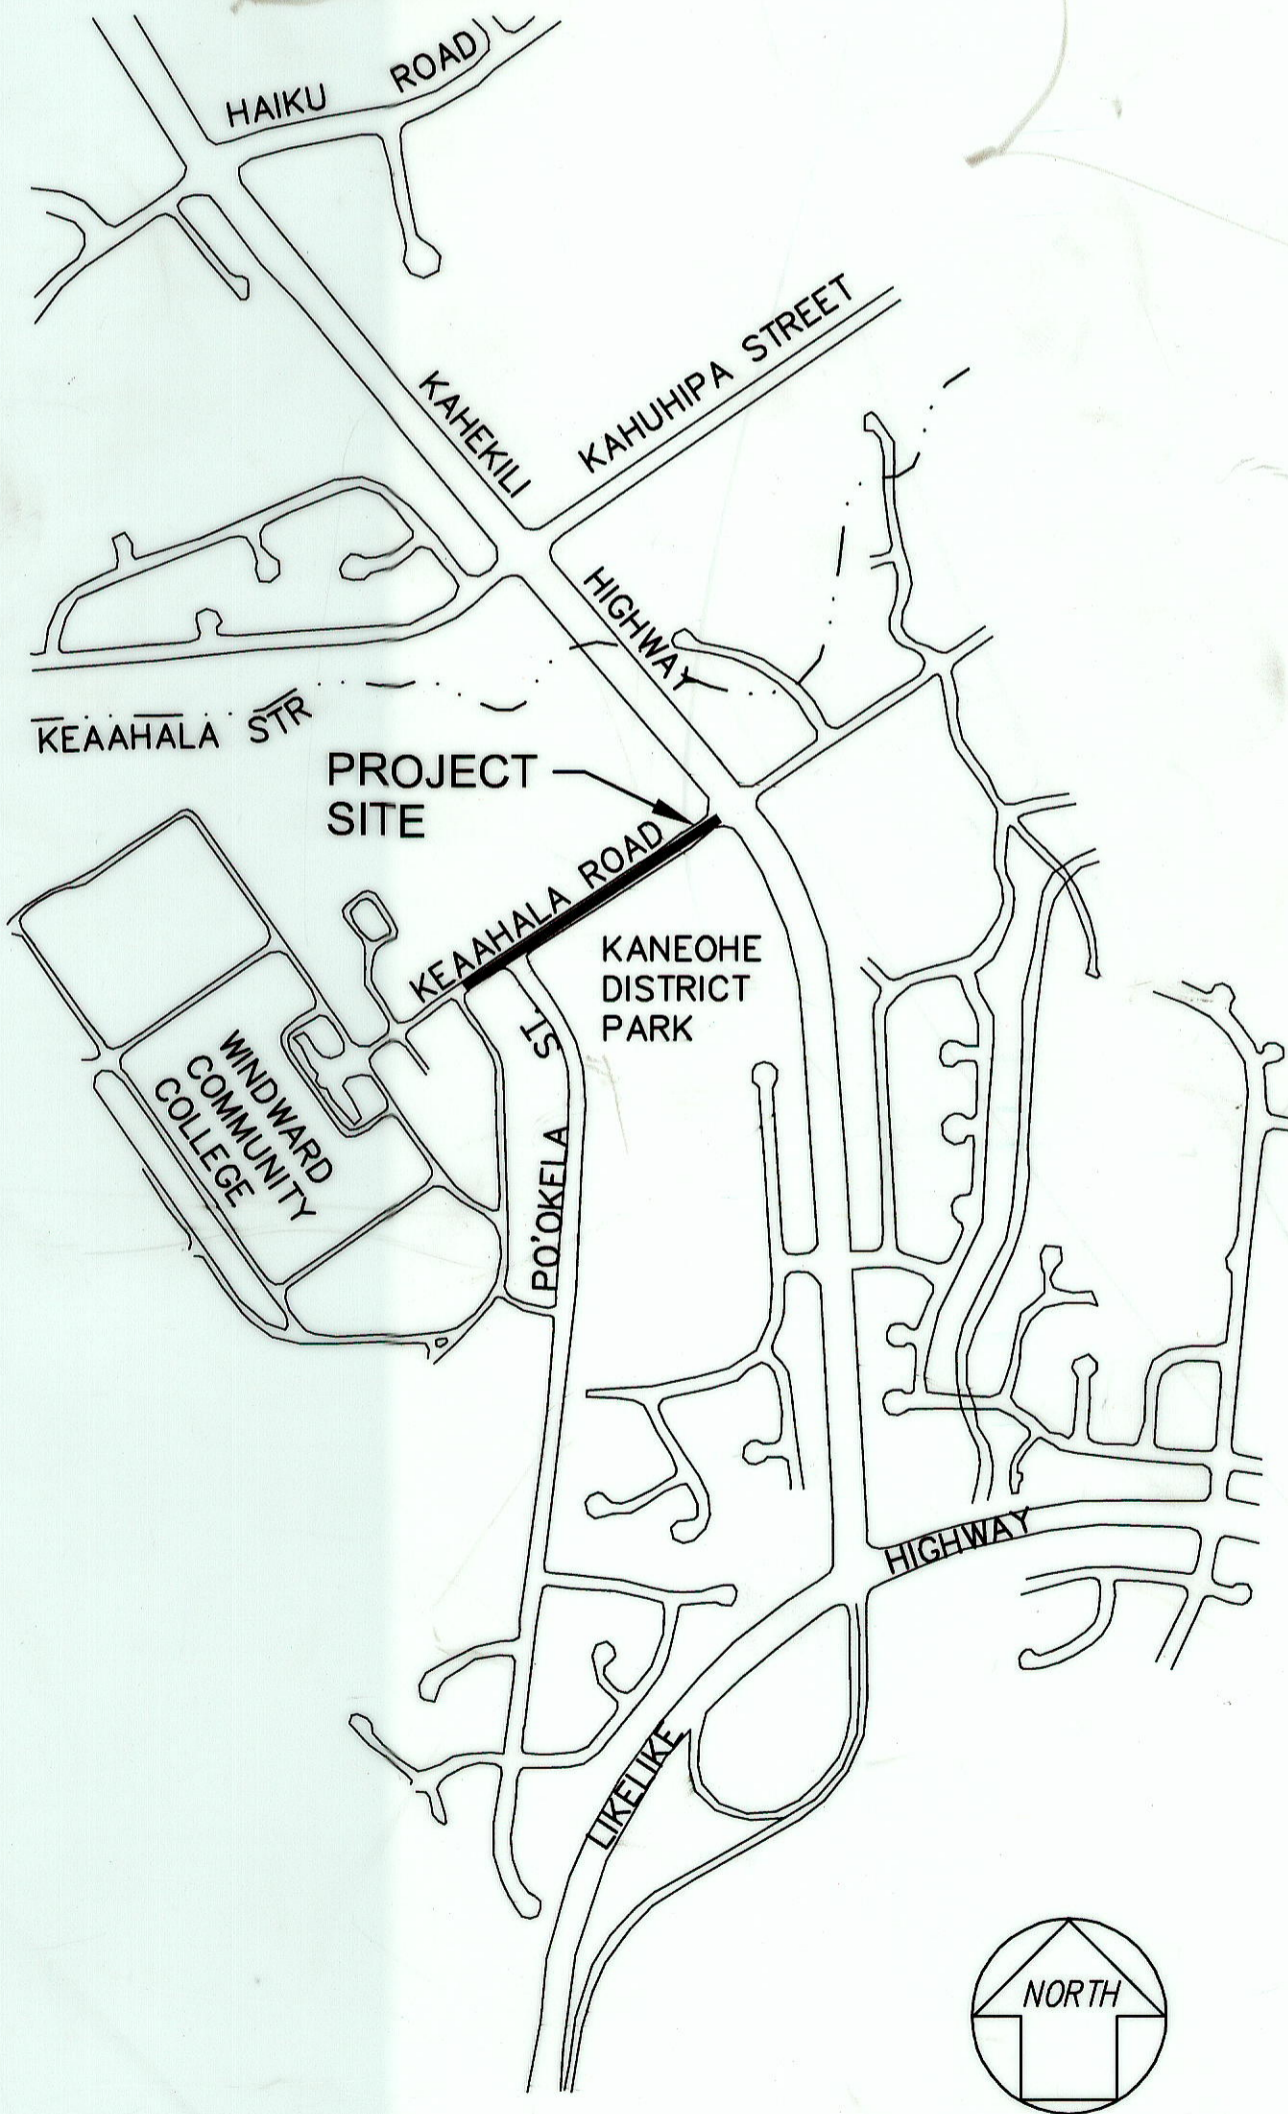

TAX MAP KEY: 4-5-23: 2, 9, 10 AND 15


**PROJECT LOCATION**  
 NOT TO SCALE

STATE OF HAWAII  
 DEPARTMENT OF TRANSPORTATION  
 HIGHWAYS DIVISION  
 HONOLULU, HAWAII  
**"AS-BUILT"**  
 PLANS FOR

**KEAAHALA ROAD WIDENING**  
**KAHEKILI HIGHWAY TO PO'OKELA STREET**

**STATE PROJECT NO. HWY-O-03-97**

DISTRICT OF KOOLAUPOKO  
 ISLAND OF OAHU

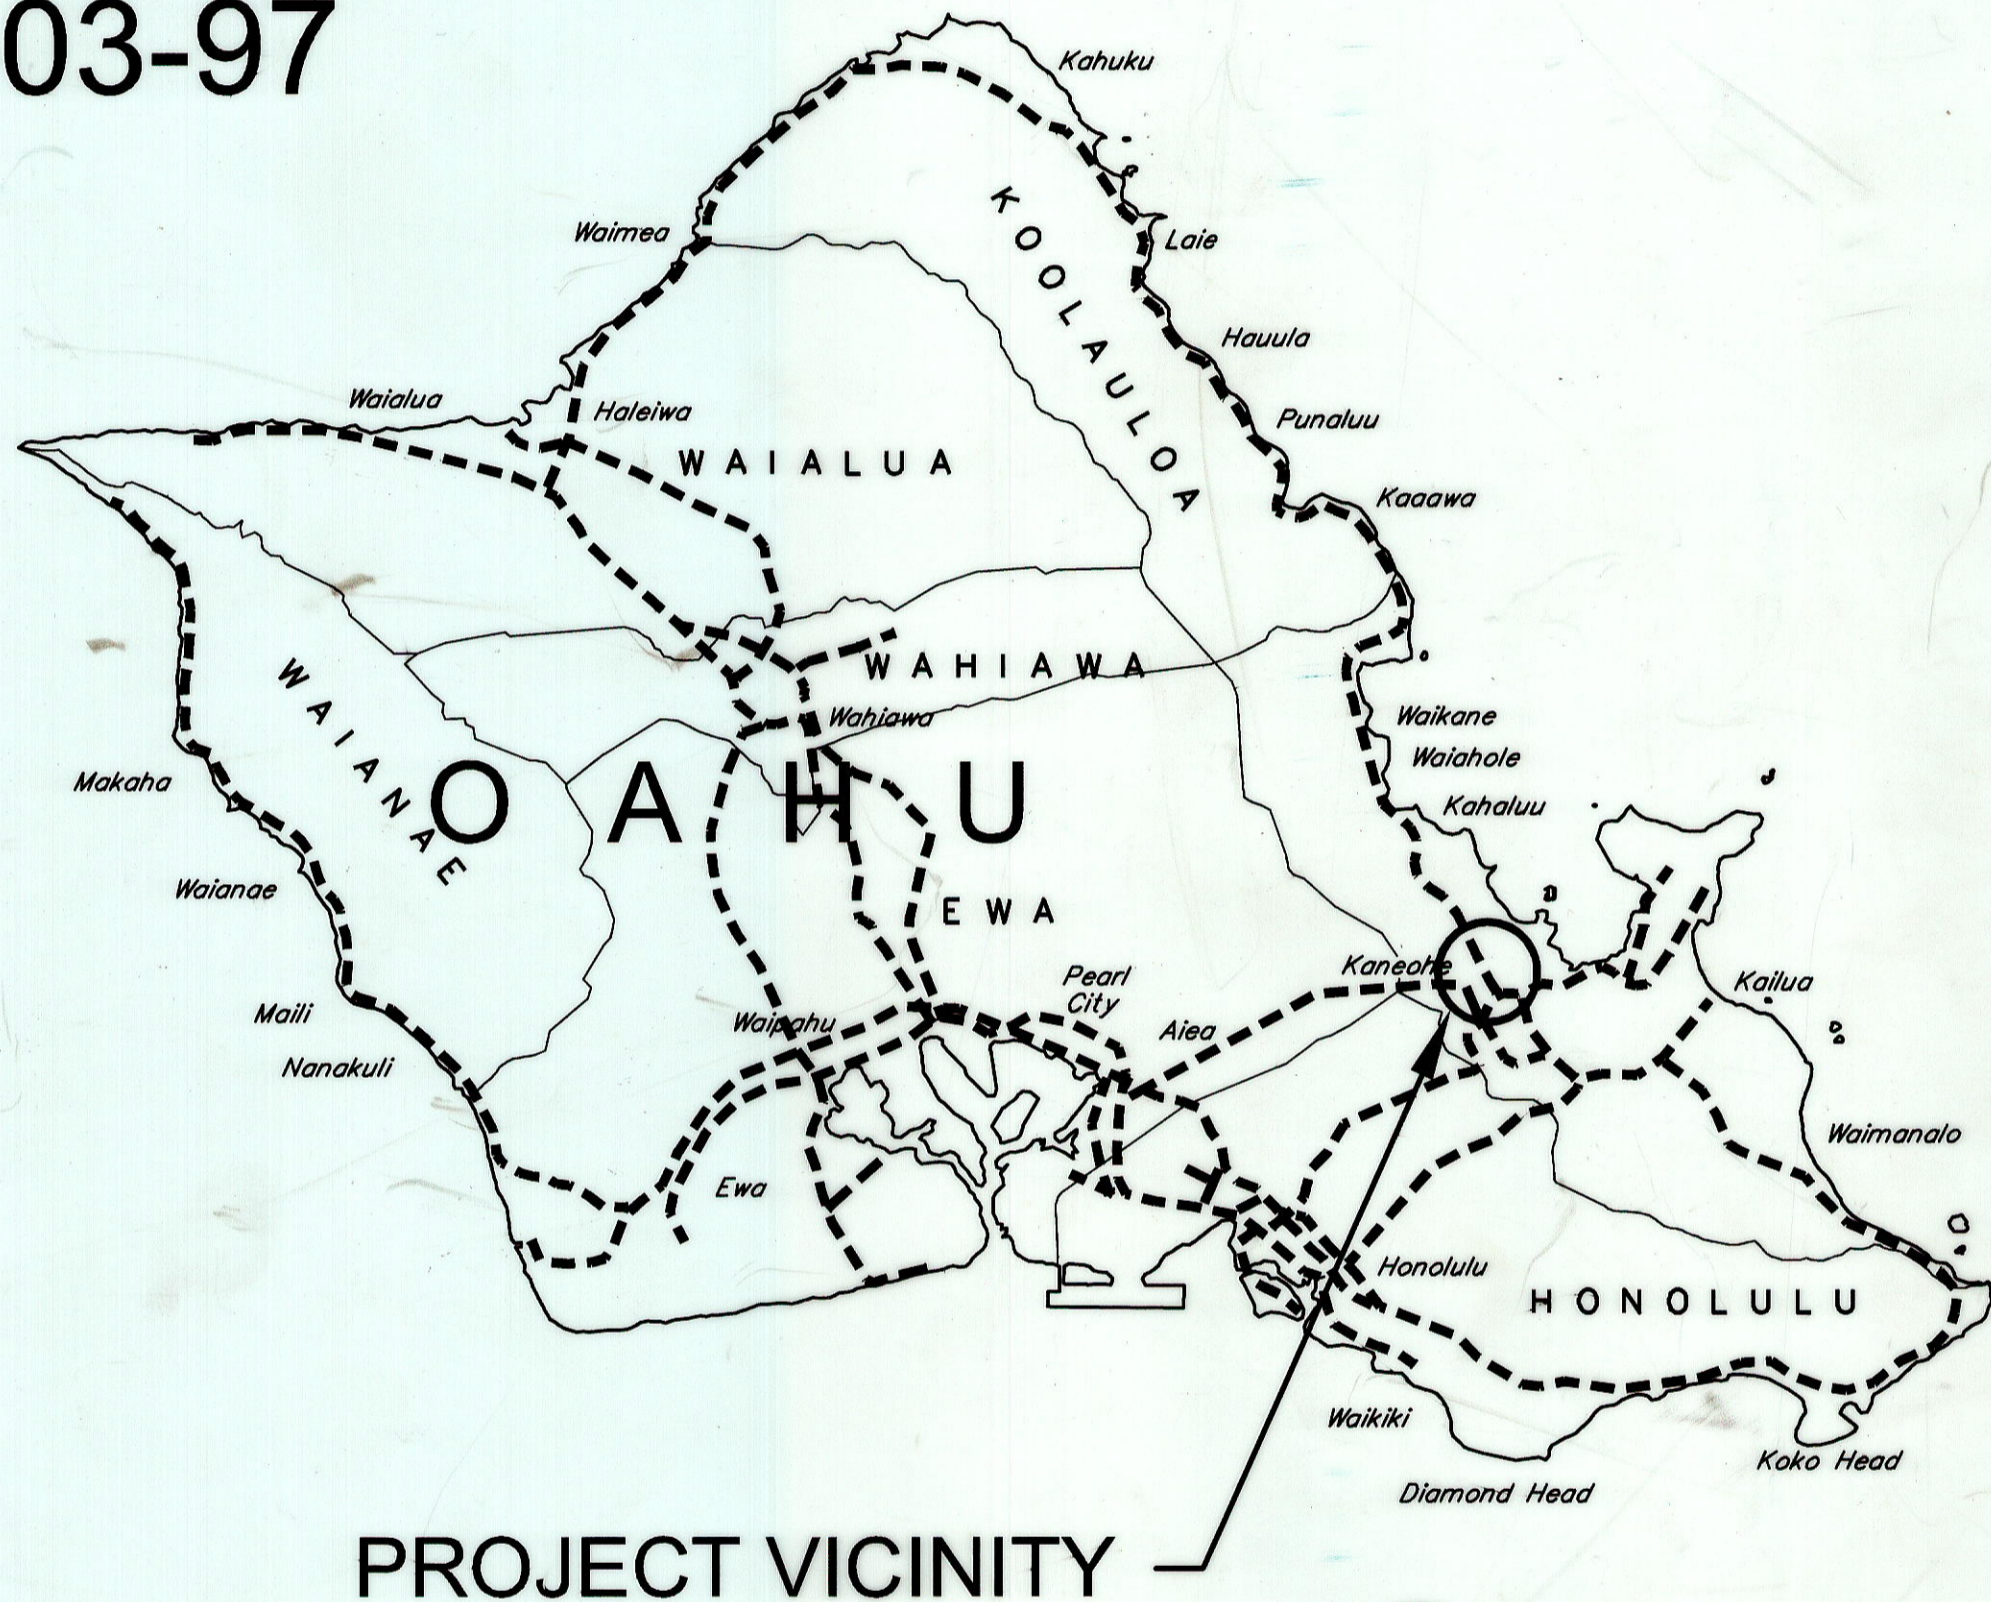

APPROVED:


*M. Ferguson*  
 DIRECTOR, DEPT. OF PLANNING AND PERMITTING  
 CITY & COUNTY OF HONOLULU

5/7/00  
 DATE

*Chapman Smith*  
 MANAGER AND CHIEF ENGINEER, BOARD OF WATER SUPPLY  
 CITY & COUNTY OF HONOLULU

4.76.00  
 DATE

FED. ROAD DIST. NO.	STATE	FED. AID PROJ. NO.	FISCAL YEAR	SHEET NO.	TOTAL SHEETS
HAWAII	HAW.	HWY-O-03-97	2000	1	110

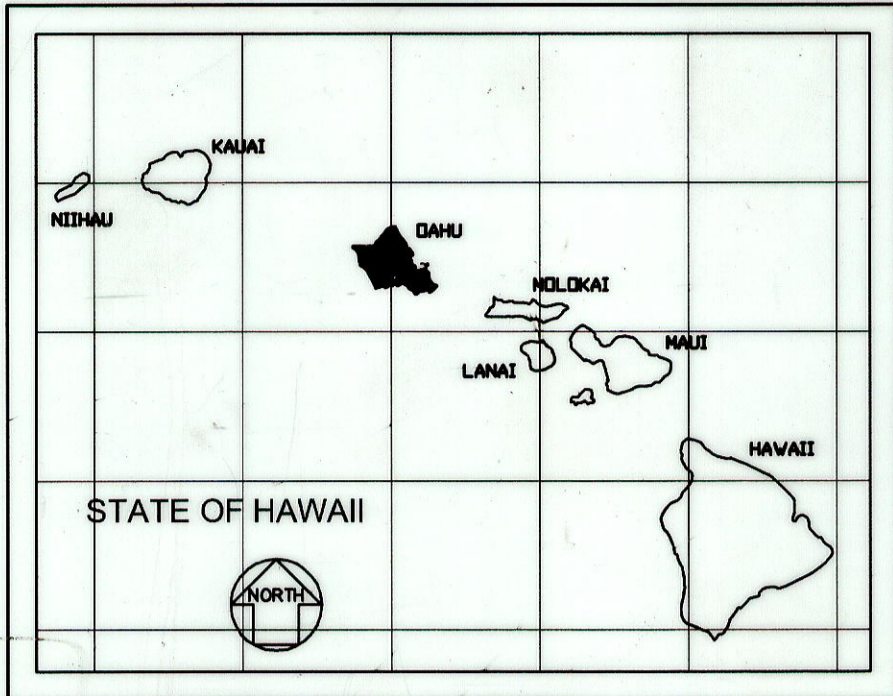

CHANGES MADE DURING CONSTRUCTION HAVE BEEN INCORPORATED ON THESE PLANS EXCEPT CHANGES IN THE ORIGINAL THEORETICAL QUANTITIES. FOR ACTUAL QUANTITIES, REFER TO PROJECT LEDGER AND/OR COMPUTATION BOOK.  
*M. Ferguson*  
 RESIDENT ENGINEER  
 3/25/14  
 DATE

DEPARTMENT OF TRANSPORTATION STATE OF HAWAII	
APPROVED:	
<i>Raymond H. H. H.</i> DIR. OF TRANSPORTATION	5/8/00 DATE