

FED. ROAD DIST. NO.	STATE	FED. AID PROJ. NO.	FISCAL YEAR	SHEET NO.	TOTAL SHEETS
HAWAII	HAW.	STP-0001 (30)	2007	2	89


INDEX OF DRAWINGS

SHT. NO.	DESCRIPTION	SHT. NO.	DESCRIPTION	SHT. NO.	DESCRIPTION
T-1	TITLE SHEET	E-36	KAMEHAMEHA HWY/HAIKU ROAD INTERSECTION CCTV PLAN	C-21	TRAFFIC CONTROL PLAN-KAHEKILI-LIKELIKE INTERSECTION 1
T-2	INDEX OF DRAWINGS	E-37	WINDWARD CCTV TRAFFIC CAMERA SYSTEM DIAGRAM AND DETAILS	C-22	TRAFFIC CONTROL PLAN-KAHEKILI-LIKELIKE INTERSECTION 2
E-1	ELECTRICAL SYMBOLS	E-38	CCTV SYSTEM BLOCK DIAGRAM	C-23	TRAFFIC CONTROL PLAN-LIKELIKE-ANOI INTERSECTION
E-2	ELECTRICAL SITE PLAN I	E-39	DUCT SECTIONS AND DETAILS	C-24	TRAFFIC CONTROL PLAN-KAMEHAMEHA/KANEOHE BAY-LIKELIKE
E-3	ELECTRICAL SITE PLAN II	E-40	MISCELLANEOUS DETAILS		INTERSECTION 1
E-4	CONSTRUCTION NOTES	E-41	MISCELLANEOUS DETAILS	C-25	TRAFFIC CONTROL PLAN-KAMEHAMEHA/KANEOHE BAY-LIKELIKE
E-5	CONSTRUCTION NOTES	E-42	MISCELLANEOUS DETAILS		INTERSECTION 2
E-6	CONSTRUCTION NOTES	E-43	MISCELLANEOUS DETAILS	C-26	TRAFFIC CONTROL PLAN-KAMEHAMEHA/KANEOHE BAY-LIKELIKE
E-7	ELECTRICAL PLAN 1	E-44	RECONSTRUCTION DETAILS		INTERSECTION 3
E-8	ELECTRICAL PLAN 2	E-45	HECO JOINT POLE OCCUPANCY DATA	C-27	TRAFFIC CONTROL PLAN-KAMEHAMEHA/KANEOHE BAY-LIKELIKE
E-9	ELECTRICAL PLANS 3 AND 3X	E-46	HECO JOINT POLE OCCUPANCY DATA AND GUY DETAILS		INTERSECTION 4
E-10	ELECTRICAL PLAN 4	C-1	TRAFFIC CONTROL NOTES	C-28	TRAFFIC CONTROL PLAN-KAMEHAMEHA/KANEOHE BAY-LIKELIKE
E-11	ELECTRICAL PLAN 5	C-2	TRAFFIC CONTROL PLAN-KAMEHAMEHA HWY-HAULANANI & HEEIA		INTERSECTION 5
E-12	ELECTRICAL PLAN 6		INTERSECTIONS	C-29	TRAFFIC CONTROL PLAN-KAMEHAMEHA/KANEOHE BAY-LIKELIKE
E-13	ELECTRICAL PLAN 7	C-3	TRAFFIC CONTROL PLAN-KAMEHAMEHA HWY-HEEIA TO		INTERSECTION 6
E-14	ELECTRICAL PLAN 8		LILIPUNA/HAIKU 1	C-30	TRAFFIC CONTROL PLAN-KAMEHAMEHA/KANEOHE BAY-LIKELIKE
E-15	ELECTRICAL PLAN 9	C-4	TRAFFIC CONTROL PLAN-KAMEHAMEHA HWY-HEEIA TO		INTERSECTION 7
E-16	ELECTRICAL PLAN 10		LILIPUNA/HAIKU 2	C-31	TRAFFIC CONTROL PLAN-KAMEHAMEHA-LULUKU INTERSECTION
E-17	ELECTRICAL PLAN 11	C-5	TRAFFIC CONTROL PLAN-KAMEHAMEHA HWY-LILIPUNA/HAIKU	C-32	TRAFFIC CONTROL PLAN-KAMEHAMEHA-KUU HOME INTERSECTION
E-18	ELECTRICAL PLAN 12		INTERSECTION	C-33	TRAFFIC CONTROL PLAN-KAMEHAMEHA-MOKULELE INTERSECTION
E-19	ELECTRICAL PLAN 13	C-6	TRAFFIC CONTROL PLAN-KAMEHAMEHA HWY-LILIPUNA/HAIKU TO	C-34	TRAFFIC CONTROL PLAN-HALEKOU INTERCHANGE 1
E-20	ELECTRICAL PLAN 14		LILIPUNA/KAHUIPA	C-35	TRAFFIC CONTROL PLAN-HALEKOU INTERCHANGE 2
E-21	ELECTRICAL PLAN 15	C-7	TRAFFIC CONTROL PLAN-KAMEHAMEHA HWY-LILIPUNA/KAHUIPA	C-36	TRAFFIC CONTROL PLAN-HALEKOU INTERCHANGE 3
E-22	ELECTRICAL PLAN 16		INTERSECTION	C-37	TRAFFIC CONTROL PLAN-HALEKOU INTERCHANGE 4
E-23	ELECTRICAL PLAN 17	C-8	TRAFFIC CONTROL PLAN-KAMEHAMEHA HWY-LILIPUNA/KAHUIPA TO	C-38	TRAFFIC CONTROL PLAN-HALEKOU INTERCHANGE 5
E-24	ELECTRICAL PLAN 18		WM HENRY/KEAAHALA	C-39	TRAFFIC CONTROL PLAN-KAMEHAMEHA-PALI INTERSECTION 1
E-25	KAMEHAMEHA HWY/PALI HWY INTERSECTION CCTV PLAN	C-9	TRAFFIC CONTROL PLAN-KAMEHAMEHA HWY-WM HENRY/KEAAHALA	C-40	TRAFFIC CONTROL PLAN-KAMEHAMEHA-PALI INTERSECTION 2
E-26	HALEKOU INTERCHANGE CCTV PLAN - PART I		TO WAIKALUA/PAKELA	C-41	TRAFFIC CONTROL PLAN-KAMEHAMEHA-PALI INTERSECTION 3
E-27	HALEKOU INTERCHANGE CCTV PLAN - PART II	C-10	TRAFFIC CONTROL PLAN-KAMEHAMEHA HWY-WM HENRY/KEAAHALA		
E-28	KAMEHAMEHA HWY/LULUKU ROAD AND KAMEHAMEHA HWY/ MOKULELE		INTERSECTION		
	STREET INTERSECTION CCTV PLANS	C-11	TRAFFIC CONTROL PLAN-KAMEHAMEHA HWY-WAIKALUA/PAKELA		
E-29	KAMEHAMEHA HWY/KANEOHE BAY DR/LIKELIKE HIGHWAY		INTERSECTION		
	INTERSECTION CCTV PLAN	C-12	TRAFFIC CONTROL PLAN-KAMEHAMEHA HWY-WAIKALUA/PAKELA TO		
E-30	KAMEHAMEHA HWY/WILLIAM HENRY ROAD/KEAALAH ROAD AND		LIKELIKE		
	KAMEHAMEHA HWY/KEOLE STREET INTERSECTION CCTV PLANS	C-13	TRAFFIC CONTROL PLAN-HAIKU-KAMEHAMEHA HWY & OHALA		
E-31	KAMEHAMEHA HWY/LILIPUNA STREET AND KAMEHAMEHA HWY/		INTERSECTION		
	HAULALANI STREET INTERSECTION CCTV PLANS	C-14	TRAFFIC CONTROL PLAN-HAIKU-OHALA INTERSECTION		
E-32	KAHEKILI HWY/HAIKU ROAD AND KAHEKILI HWY/KAHUIPA STREET	C-15	TRAFFIC CONTROL PLAN-HAIKU-OHALA TO ALALOA		
	INTERSECTION CCTV PLANS	C-16	TRAFFIC CONTROL PLAN-HAIKU-ALALOA INTERSECTION		
E-33	KAHEKILI HWY/KEAHALA STREET AND KAHEKILI HWY/KULUKEOE	C-17	TRAFFIC CONTROL PLAN-HAIKU-HEEIA TO KAHEKILI		
	STREET INTERSECTION CCTV PLANS	C-18	TRAFFIC CONTROL PLAN-HAIKU-KAHEKILI INTERSECTION		
E-34	KAHEKILI HWY/LIKELIKE HWY INTERSECTION CCTV PLAN	C-19	TRAFFIC CONTROL PLAN-KAHEKILI-KAHUIPA & KEEAHALA		
E-35	HAIKU RD/ALALOA ST AND LIKELIKE HWY/ANOI ROAD INTERSECTION		INTERSECTIONS		
	CCTV PLANS	C-20	TRAFFIC CONTROL PLAN-KAHEKILI-KULUKEOE INTERSECTION		

LIST OF ABBREVIATIONS

AC	ASPHALT CONCRETE
ASTM	AMERICAN SOCIETY FOR TESTING AND MATERIALS
C	CONDUIT
C	CONDUCTOR
CAB	CABINET
CCTV	CLOSED CIRCUIT TELEVISION
CONC	CONCRETE
CONT	CONTINUED
CTRL	CONTROL
DET	DETAIL
DIST	DISTRIBUTION
DOT	DEPARTMENT OF TRANSPORTATION
DR	DRIVE
DTS	DEPARTMENT OF TRANSPORTATION SERVICES
ENCL	ENCLOSURE
EQUIPT	EQUIPMENT
EXST	EXISTING
GRS	GALVANIZED RIGID STEEL
HECO	HAWAIIAN ELECTRIC COMPANY
HWY	HIGHWAY
MPH	MILES PER HOUR
PAVT	PAVEMENT
RD	ROAD
ROW	RIGHT OF WAY
SHT	SHEET
SIG	SIGNAL
ST	STREET
SM	SINGLE MODE
TS	TRAFFIC SIGNAL
TYP	TYPICAL
W/	WITH

REVISION	DATE	BRIEF	BY	APPROVED
----------	------	-------	----	----------

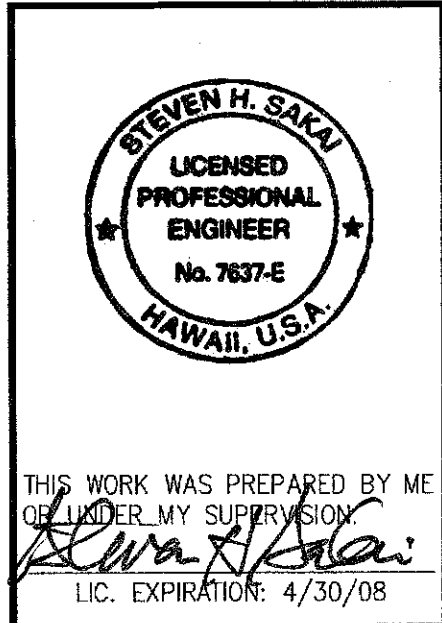

DEPARTMENT OF TRANSPORTATION SERVICES
CITY AND COUNTY OF HONOLULU
FEDERAL AID NO. STP-0001(30)
COMPUTERIZED TRAFFIC CONTROL SYSTEM
PHASE 9

INDEX OF DRAWINGS

ENGINEER: GTN DATE: MARCH 2007
DRAFTSMAN: SS SCALE: AS NOTED
CHK. BY: REF:
APPROVED: APPROVED:
DIRECTOR: DIVISION ENGINEER: